

WKE

AUGUST 2019

PROJECT ID:

4867-03-70

COUNTY:

WASHINGTON

ORDER OF SHEETS

|             |   |                              |
|-------------|---|------------------------------|
| Section No. | 1 | Title                        |
| Section No. | 2 | Typical Sections and Details |
| Section No. | 3 | Estimate of Quantities       |
| Section No. | 3 | Miscellaneous Quantities     |
| Section No. | 4 | Right of Way Plat            |
| Section No. | 5 | Plan and Profile             |
| Section No. | 6 | Standard Detail Drawings     |
| Section No. | 7 | Sign Plates                  |
| Section No. | 8 | Structure Plans              |
| Section No. | 9 | Computer Earthwork Data      |
| Section No. | 9 | Cross Sections               |

TOTAL SHEETS = 48



06

DESIGN DESIGNATION

|                 |   |        |
|-----------------|---|--------|
| A.A.D.T. (2019) | = | 4,000  |
| A.A.D.T. (2039) | = | 5,950  |
| D.H.V.          | = |        |
| D.D.            | = |        |
| T.              | = | 10%    |
| DESIGN SPEED    | = | 60 MPH |
| ESALS           | = | N.A.   |

CONVENTIONAL SYMBOLS

| PLAN                              | PROFILE                                        |
|-----------------------------------|------------------------------------------------|
| CORPORATE LIMITS                  | GRADE LINE                                     |
| PROPERTY LINE                     | ORIGINAL GROUND                                |
| LOT LINE                          | MARSH OR ROCK PROFILE<br>(To be noted as such) |
| LIMITED HIGHWAY EASEMENT          | SPECIAL DITCH                                  |
| EXISTING RIGHT OF WAY             | GRADE ELEVATION                                |
| PROPOSED OR NEW R/W LINE          | CULVERT (Profile View)                         |
| STOPE INTERCEPT                   | UTILITIES                                      |
| REFERENCE LINE                    | ELECTRIC                                       |
| EXISTING CULVERT                  | FIBER OPTIC                                    |
| PROPOSED CULVERT<br>(Box or Pipe) | GAS                                            |
| COMBUSTIBLE FLUIDS                | SANITARY SEWER                                 |
|                                   | STORM SEWER                                    |
|                                   | TELEPHONE                                      |
|                                   | WATER                                          |
|                                   | UTILITY PEDESTAL                               |
|                                   | POWER POLE                                     |
|                                   | TELEPHONE POLE                                 |
| MARSH AREA                        |                                                |
| WOODED OR SHRUB AREA              |                                                |

STATE OF WISCONSIN  
DEPARTMENT OF TRANSPORTATION

PLAN OF PROPOSED IMPROVEMENT


CTH H  
OAK DRIVE TO KETTLE MORaine DRIVE  
CTH H  
WASHINGTON COUNTY

STATE PROJECT NUMBER

4867-03-70

BEGIN PROJECT  
STA. 13+00  
X = 359,488.24  
Y = 211,376.81

END PROJECT  
STA. 33+55

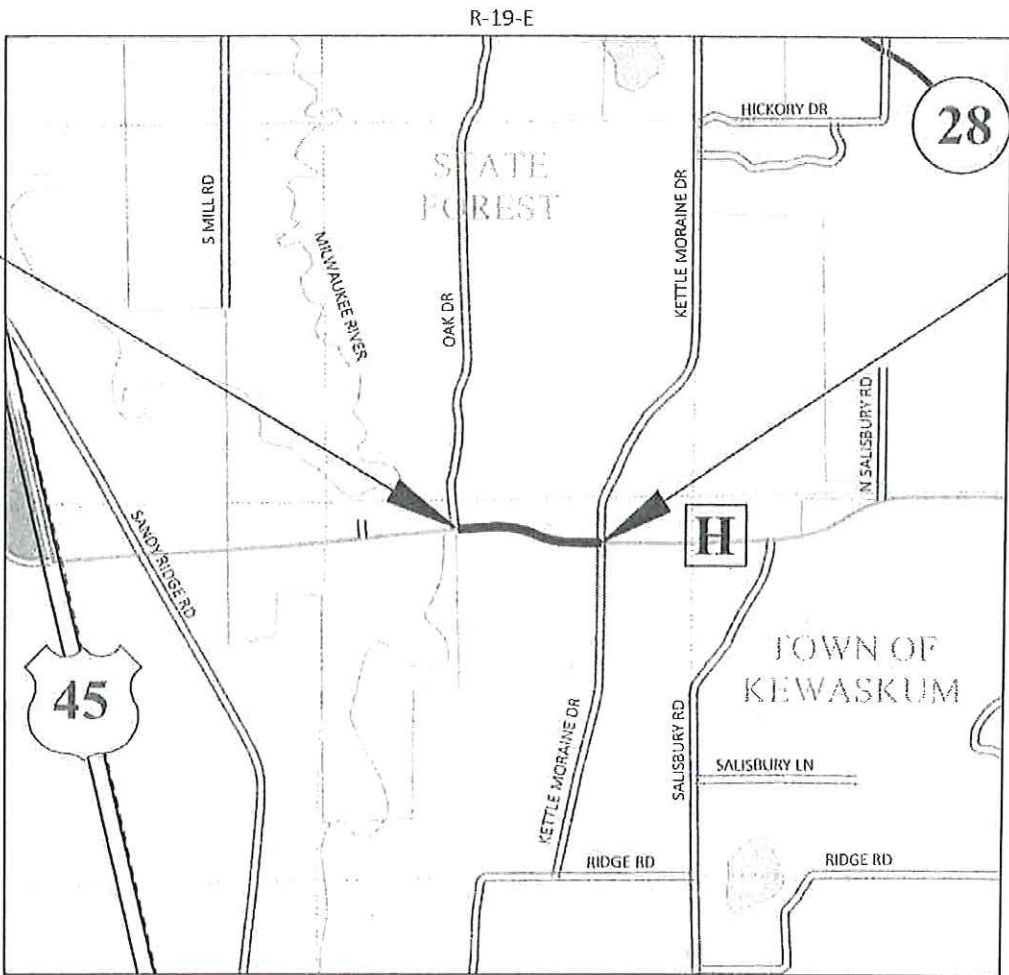

LAYOUT

SCALE 0 0.5 MI

TOTAL NET LENGTH OF CENTERLINE = 0.389 MI

COORDINATES ON THIS PLAN ARE REFERENCED TO THE WISCONSIN  
COUNTY COORDINATE SYSTEM, WASHINGTON COUNTY, NAD83 (2011).

STATE PROJECT

4867-03-70

FEDERAL PROJECT

PROJECT

WISC 2019581

CONTRACT

1

ACCEPTED FOR  
WASHINGTON COUNTY

SIGNATURE:

*WASH CO. HWY COM.*

TITLE:

WASH CO. HWY COM.

DATE:

4/25/19

ORIGINAL PLANS PREPARED BY:

**SA**  
**STRAND**  
ASSOCIATES®  
126 N. JEFFERSON STREET, SUITE 350  
MILWAUKEE, WISCONSIN 53202  
(414) 271-0771



*Ashley Pridemore*  
4/25/19

STATE OF WISCONSIN  
DEPARTMENT OF TRANSPORTATION

PREPARED BY

|                     |                         |
|---------------------|-------------------------|
| Surveyor            | N/A                     |
| Designer            | STRAND ASSOCIATES, INC. |
| Project Manager     | KATHLEEN KRAMER, P.E.   |
| Regional Examiner   | WISDOT MI REGION        |
| Regional Supervisor | ADELOVE ADENIYI, P.E.   |

APPROVED FOR THE DEPARTMENT

DATE: 4/25/19 *KKramer*  
(Signature)

E

GENERAL NOTES

THE CENTERLINE OF CTH H IS APPROXIMATELY THE MAINLINE REFERENCE LINE.

DISTURBED AREAS WITHIN THE RIGHT OF WAY SHALL BE RESTORED AS DIRECTED BY THE ENGINEER.

THERE ARE UTILITY FACILITIES WITHIN THE PROJECT AREA WHICH ARE NOT SHOWN ON THE PLANS. COORDINATE CONSTRUCTION ACTIVITIES WITH A CALL TO DIGGERS HOTLINE AND/OR A DIRECT CALL TO THE UTILITIES THAT HAVE FACILITIES IN THAT AREA.

ADJUST THE LOCATIONS OF CONTRACT ITEMS UNDER THIS CONTRACT TO AVOID CONFLICT WITH THE EXISTING UTILITY FACILITIES, UNLESS OTHERWISE SPECIFIED IN THE CONTRACT SPECIAL PROVISIONS.

ALL EXISTING SIGNS SHALL REMAIN IN PLACE UNTIL CONSTRUCTION OPERATIONS REQUIRE THEIR REMOVAL OR UNLESS THE ENGINEER APPROVES THEIR REMOVAL.

THE CONTRACTOR'S RESTORATION OPERATIONS SHALL BE CONSISTENT WITH THE PLAN TYPICAL SECTIONS.

ALIGNMENT AND PLAN INFORMATION ARE BASED ON AVAILABLE AERIAL MAPPING. A TOPOGRAPHICAL SURVEY WAS NOT COMPLETED FOR THIS PROJECT.

UTILITY CONTACTS

- \* AT&T - COMMUNICATION LINES  
JEFF OLDENBURG  
MANAGER, OSP PLANNING & ENGINEERING DESIGN  
2005 PEWAUKEE ROAD  
WAUKESHA, WI 53188  
(262) 896-7522  
JO2376@ATT.COM
- \* WE ENERGIES - ELECTRIC  
GREGORY BOERNER  
500 SOUTH 116TH STREET  
WEST ALLIS, WI 53214  
(618) 409-5861  
GREGORY.BOERNER@WE-ENERGIES.COM

SECTION 2 ORDER OF SHEETS

- GENERAL NOTES
- PROJECT OVERVIEW
- TYPICAL SECTIONS
- CONSTRUCTION DETAILS
- PAVEMENT MARKING
- TRAFFIC CONTROL - ADVANCED WARNING SIGNING
- TRAFFIC CONTROL - DETOUR ROUTE



Dial  or (800)242-8511  
www.DiggersHotline.com

\* DENOTES DIGGERS HOTLINE MEMBERS

WASHINGTON COUNTY

SCOTT M. SCHMIDT, P.E., R.L.S.  
900 LANG STREET  
WEST BEND, WI 53090  
(262) 335-6881  
SCOTT.SCHMIDT@CO.WASHINGTON.WI.US

DNR LIAISON


KRISTINA BETZOLD  
DNR SOUTHEAST REGION HEADQUARTERS  
2300 N DR. MARTIN LUTHER KING JR. DRIVE  
MILWAUKEE, WI 53212  
(414) 263-8517  
KRISTINA.BETZOLD@WISCONSIN.GOV

WISDOT REGION CONTACT


KATHLEEN KRAMER, P.E.  
WISDOT SOUTHEAST REGION  
WAUKESHA OFFICE  
141 NW BARSTOW STREET  
WAUKESHA, WI 53187  
(262) 548-8772  
KATHLEEN1.KRAMER@DOT.WI.GOV

DESIGN CONSULTANT


ASHLEY PRIDEMORE, P.E.  
STRAND ASSOCIATES, INC.  
126 NORTH JEFFERSON STREET  
SUITE 350  
MILWAUKEE, WI 53202  
(414) 271-0771  
ASHLEY.PRIDEMORE@STRAND.COM

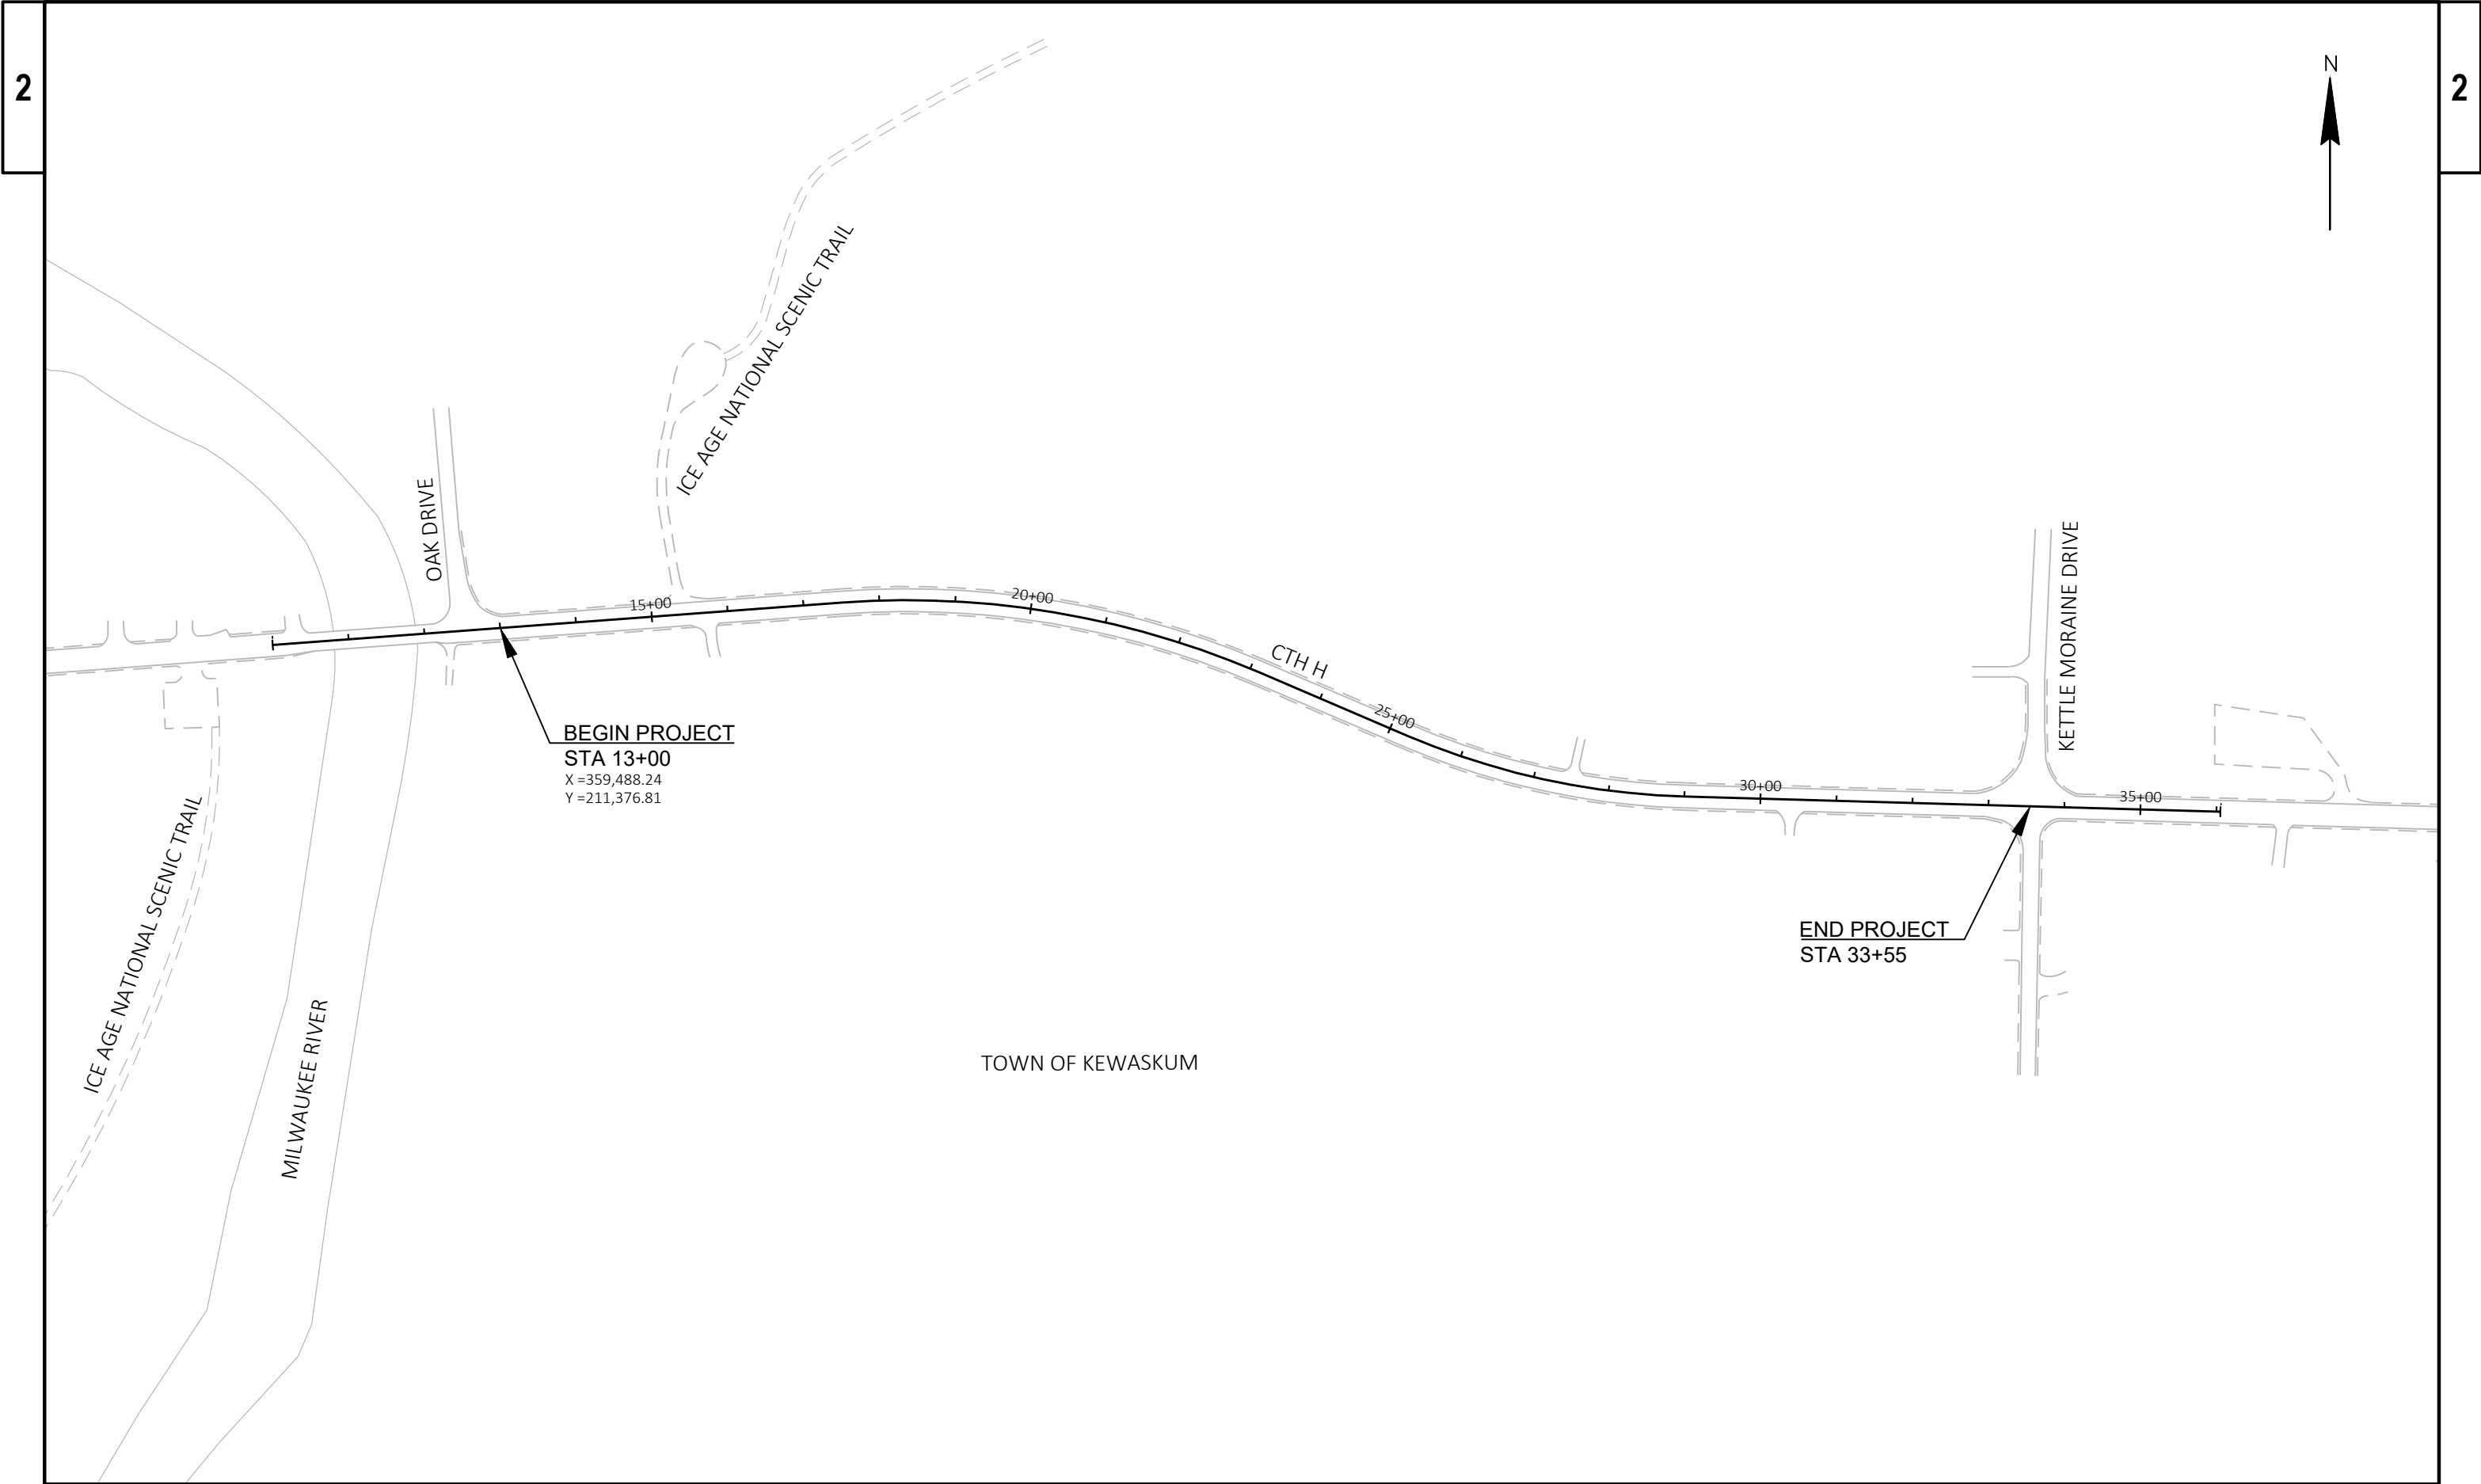


|                        |            |                    |                  |       |   |
|------------------------|------------|--------------------|------------------|-------|---|
| PROJECT NO: 4867-03-70 | HWY: CTH H | COUNTY: WASHINGTON | PROJECT OVERVIEW | SHEET | E |
|------------------------|------------|--------------------|------------------|-------|---|

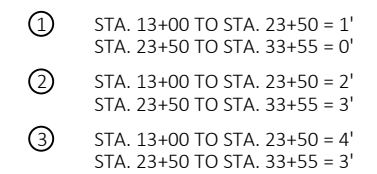

STA. 13+00 - STA. 33+55

 

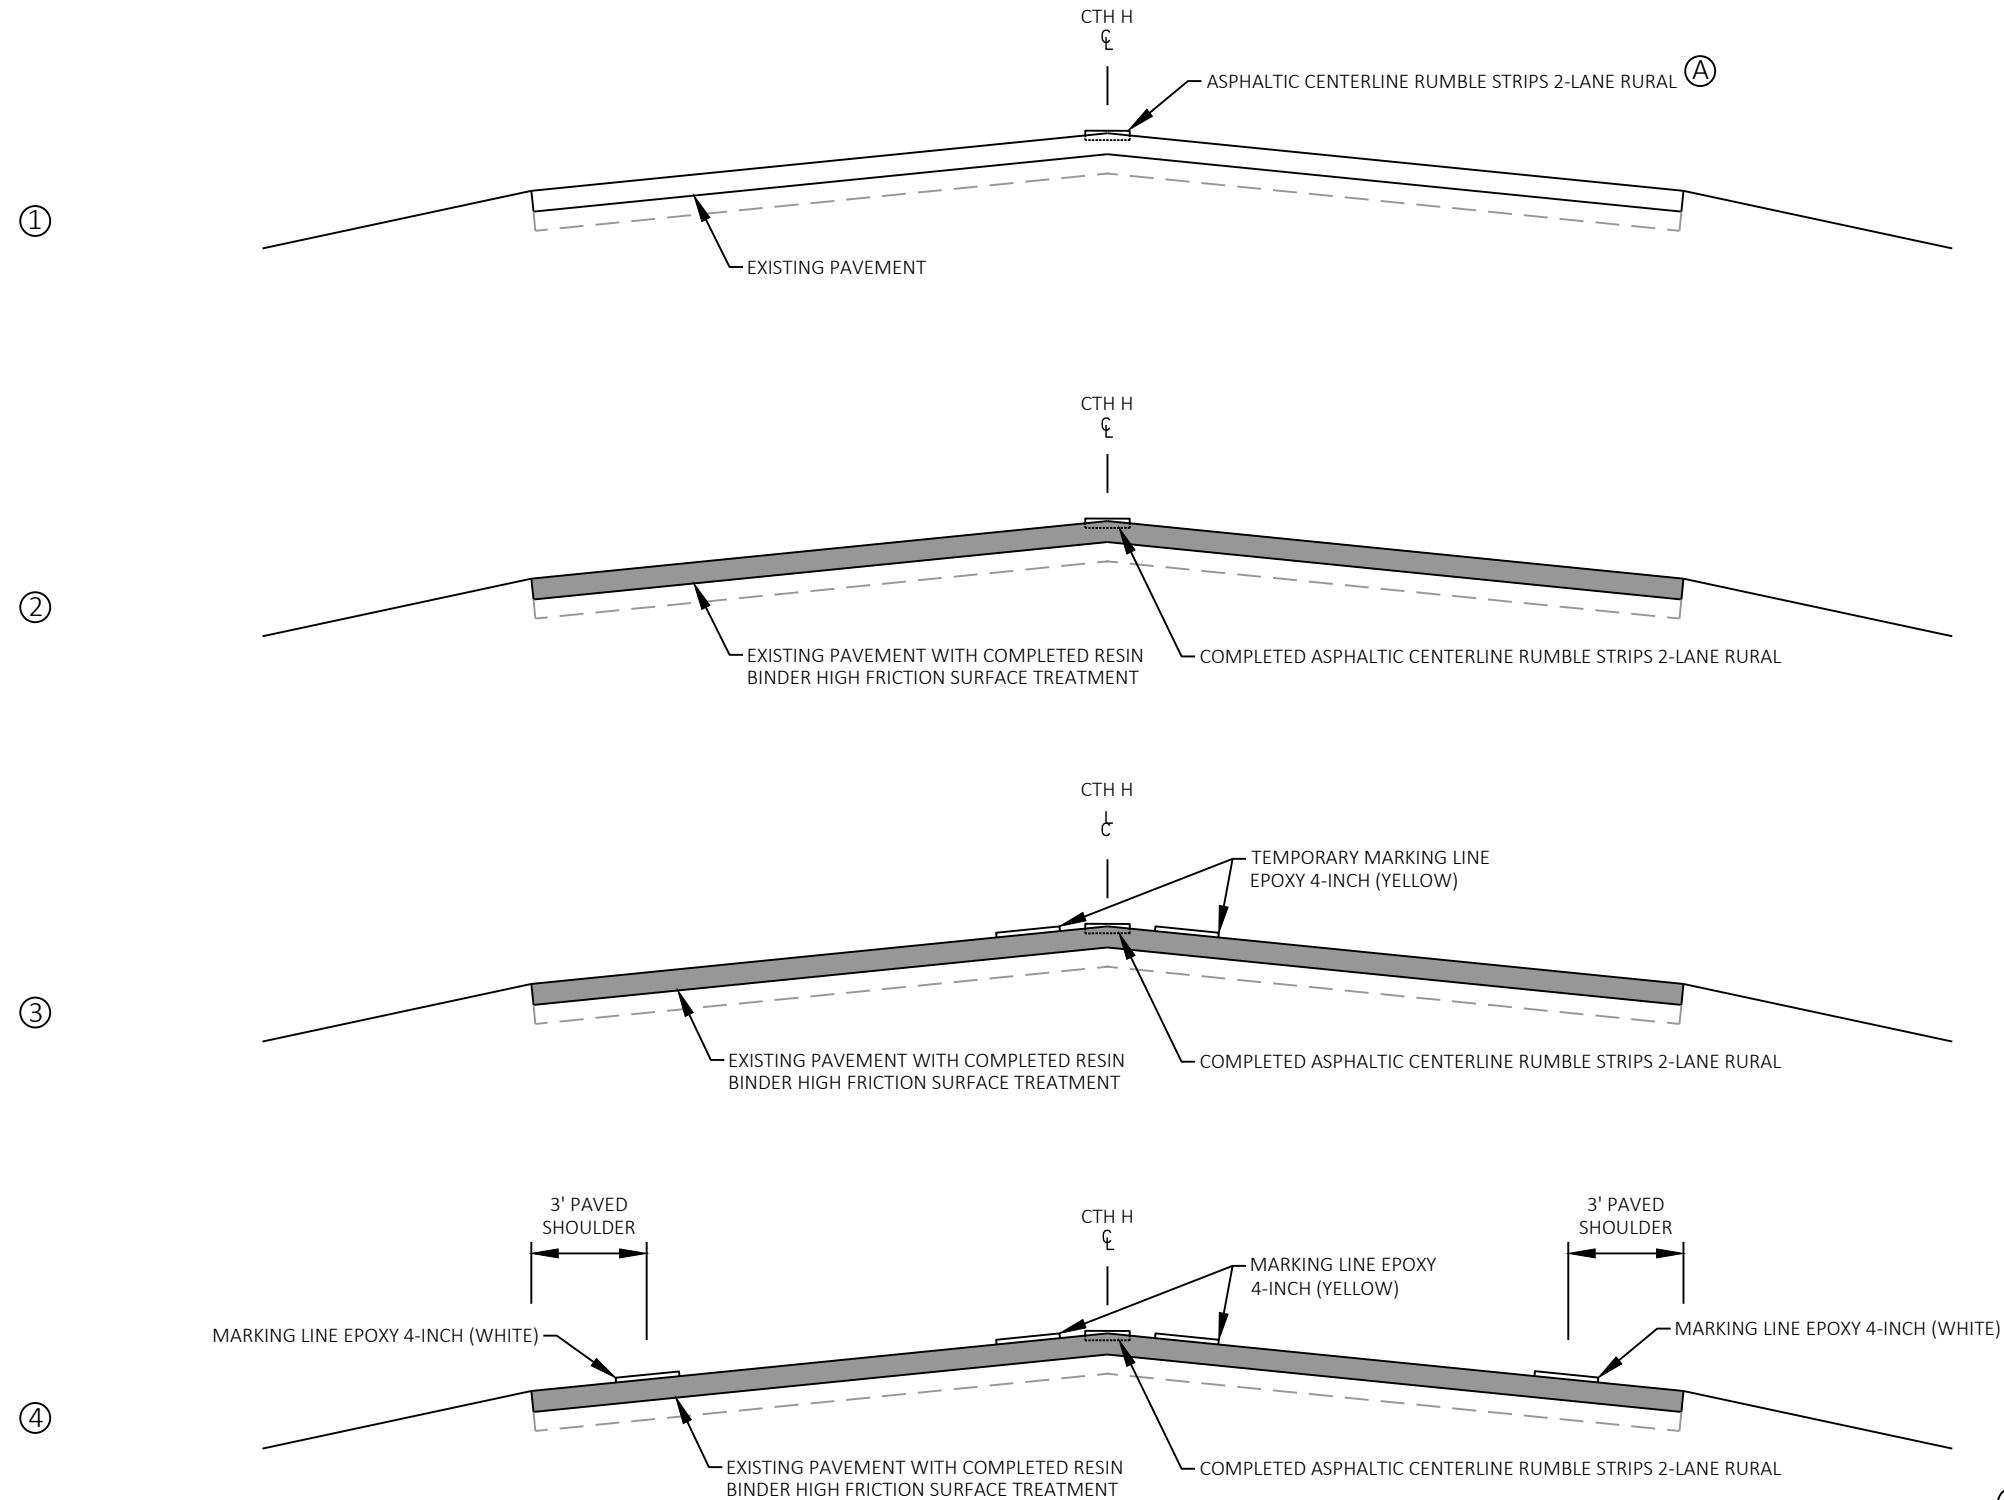

RUMBLE STRIP AND PAVEMENT MARKING APPLICATION SEQUENCE DETAIL


NOTES:

(A) REFER TO CONSTRUCTION DETAIL ASPHALTIC CENTERLINE RUMBLE STRIPS 2-LANE RURAL FOR ADDITIONAL INFORMATION.


ALL NEW CENTERLINE PASSING/NO PASSING PAVEMENT MARKING (BEGIN/END) LOCATIONS TO MATCH EXISTING PASSING/NO PASSING MARKING (BEGIN/END) LOCATIONS.

1, 2, AND 3 ARE COMPLETED UNDER THE CTH H DETOUR CONDITION.


SEE SPECIAL PROVISIONS FOR ADDITIONAL INFORMATION.

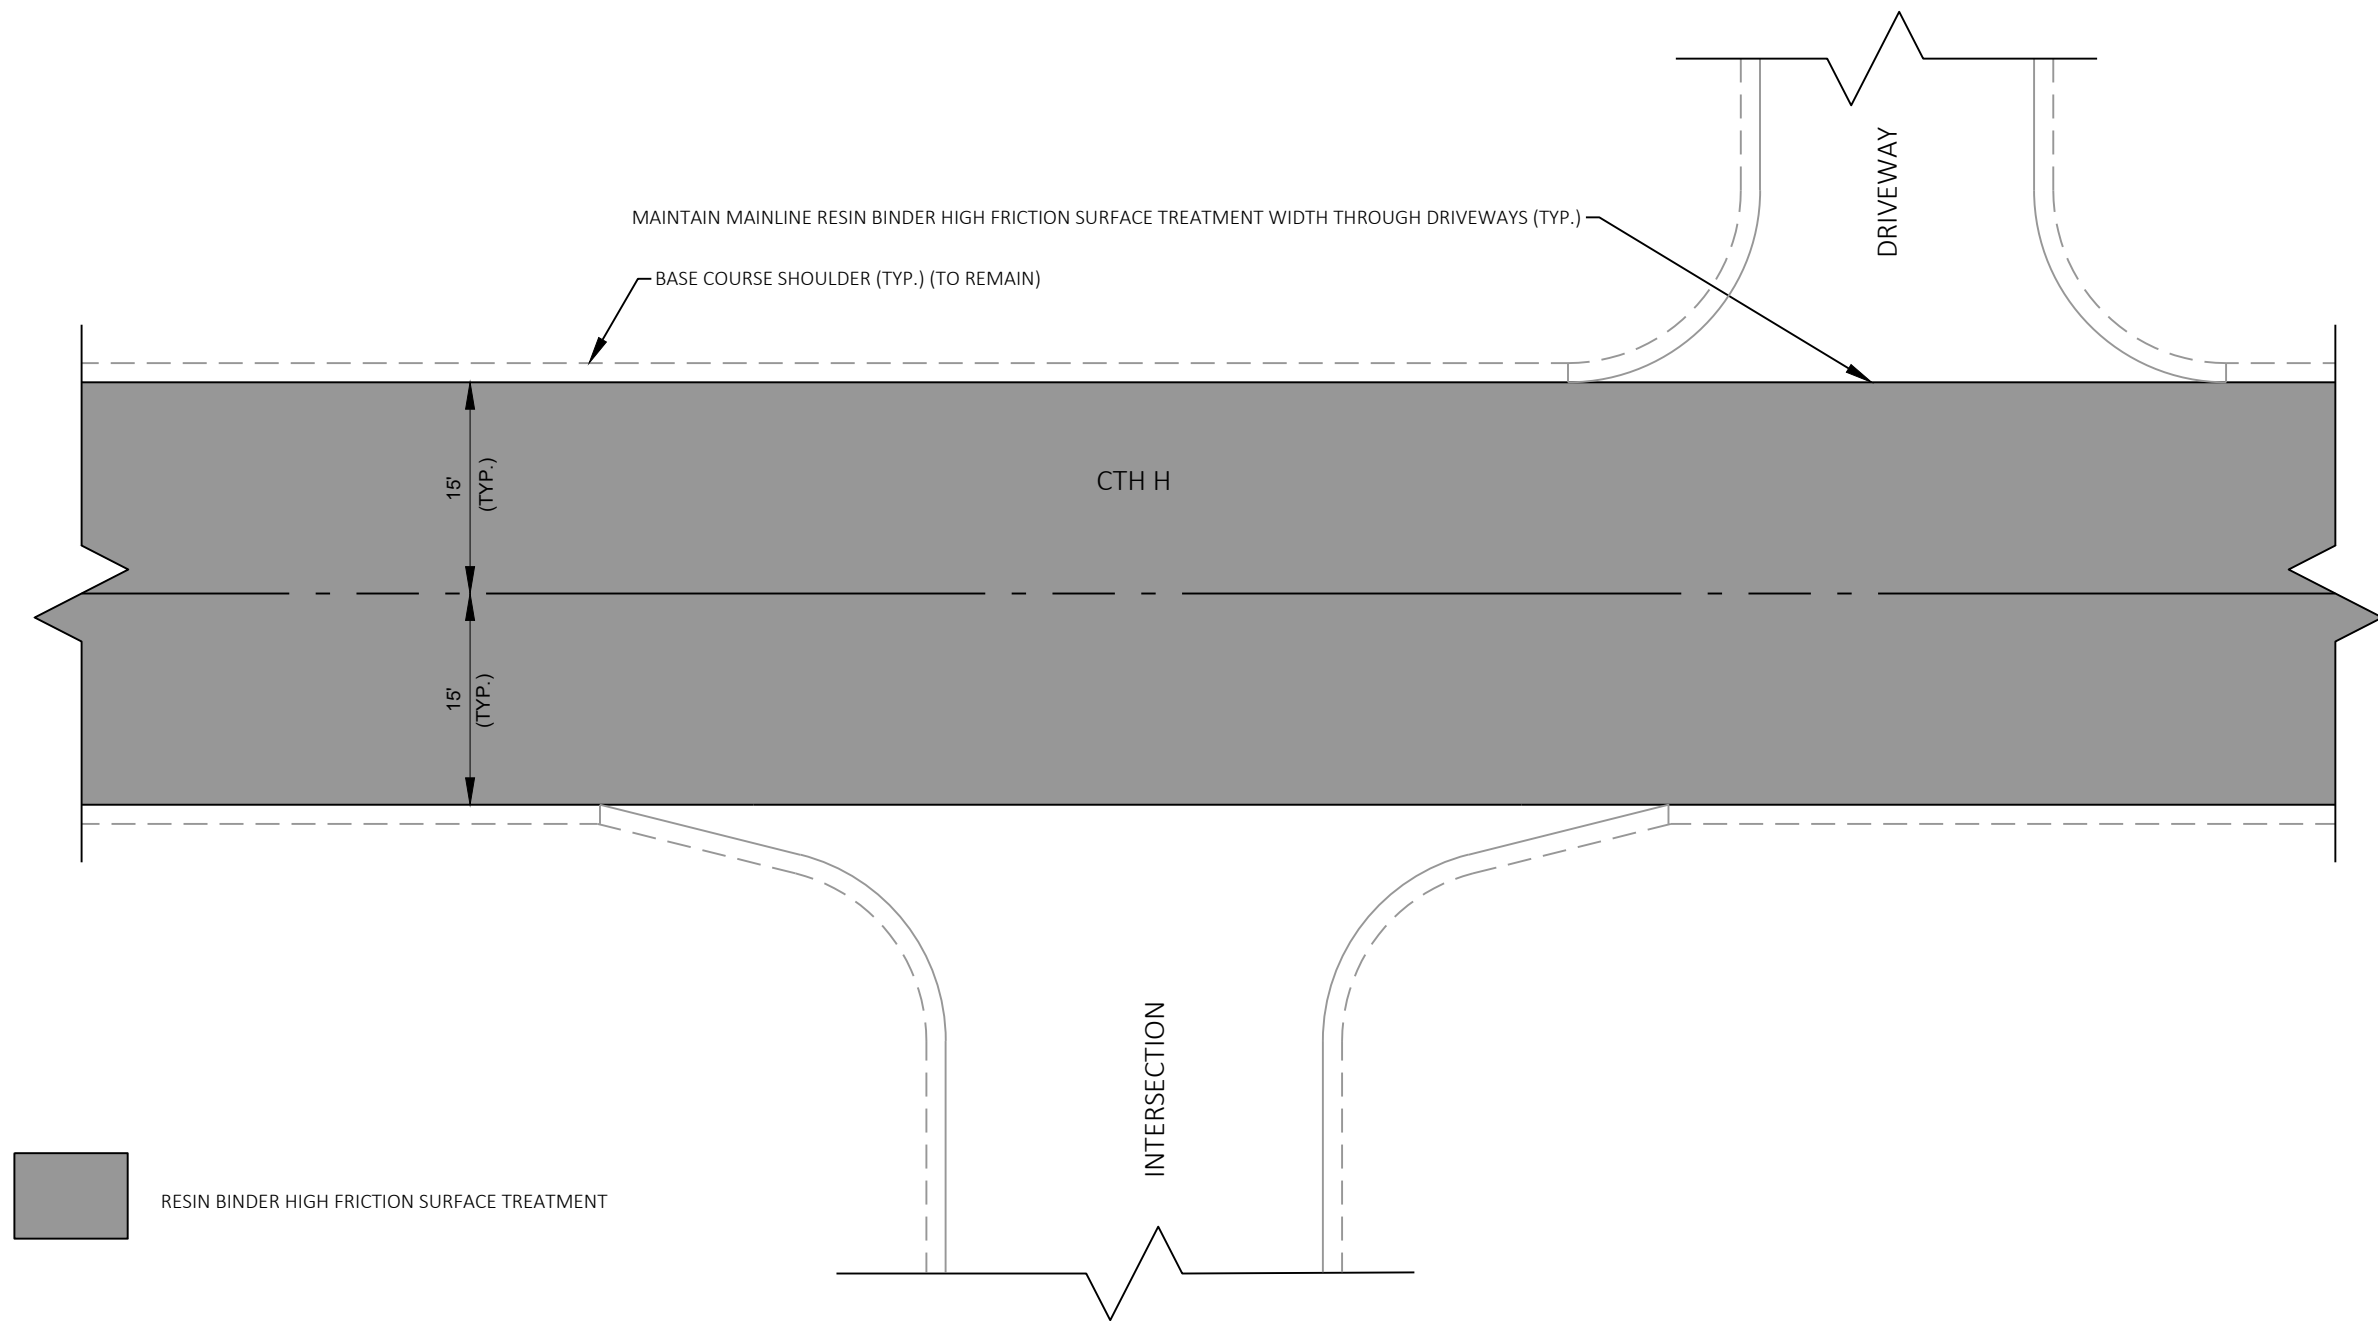

DETAIL OF RESIN BINDER HIGH FRICTION SURFACE TREATMENT AT DRIVEWAYS AND INTERSECTIONS

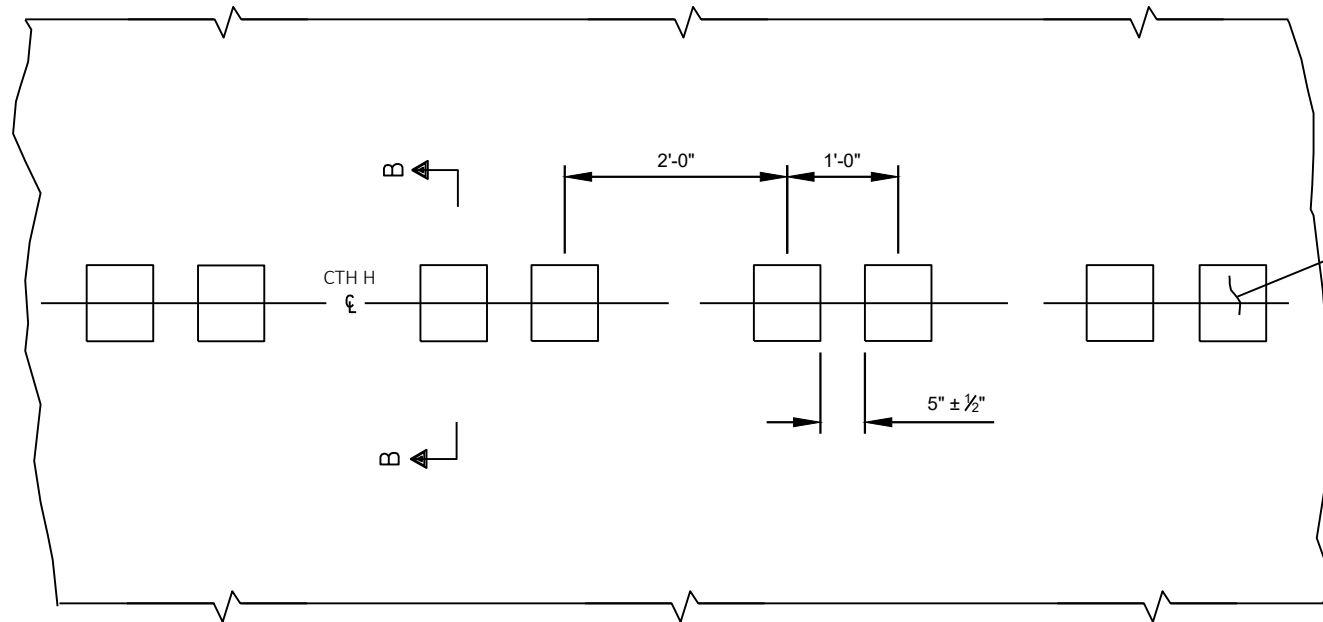

PLAN VIEW  
(GROOVE SPACING)

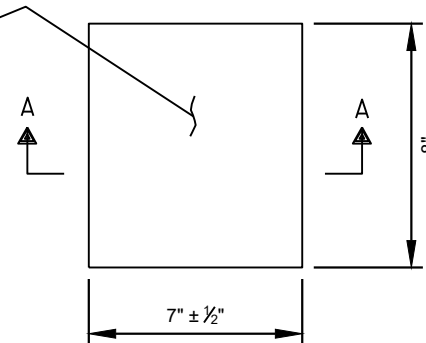


PLAN VIEW  
(SINGLE GROOVE)

NOTES:


INSTALL ASPHALTIC CENTERLINE RUMBLE STRIPS 2-LANE RURAL PRIOR TO APPLYING RESIN BINDER HIGH FRICTION SURFACE TREATMENT AND PLACING TEMPORARY MARKING LINE EPOXY 4-INCH (CENTERLINE MARKINGS). REFER TO THE SPECIAL PROVISIONS FOR ADDITIONAL ASPHALTIC CENTERLINE RUMBLE STRIPS 2-LANE RURAL SEQUENCING INFORMATION.

REFER TO STANDARD DETAIL DRAWING "2-LANE RURAL CENTERLINE RUMBLE STRIP, MILLING" FOR LIMITS OF RUMBLE STRIPS AT INTERSECTION AND DRIVEWAYS.


- ① DEPTHS SHOWN ALLOW FOR A RESULTING DEPTH OF 3/8" MIN., 1/2" MAX. ONCE THE RESIN BINDER HIGH FRICTION SURFACE TREATMENT IS APPLIED OVER THE ASPHALTIC CENTERLINE RUMBLE STRIPS 2-LANE RURAL AREAS BASED ON A FRICTION SURFACE TREATMENT THICKNESS OF 1/8" MIN., 1/4" MAX.

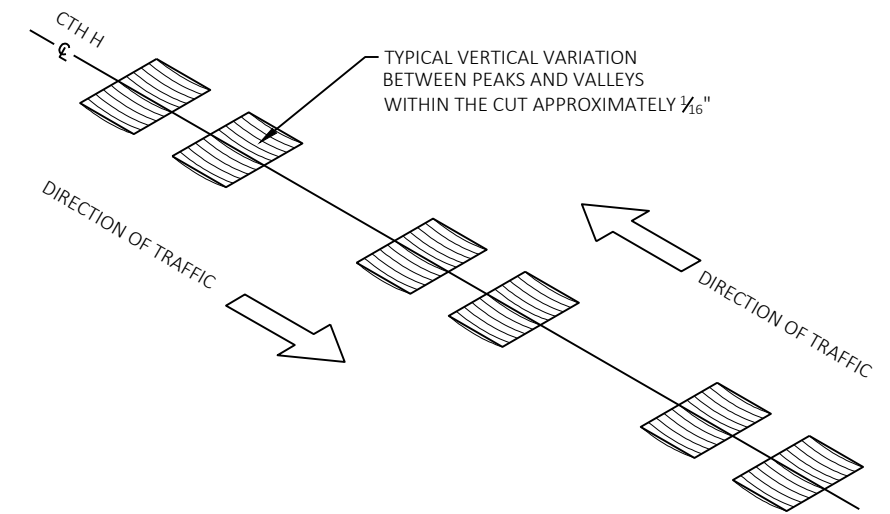


ISOMETRIC

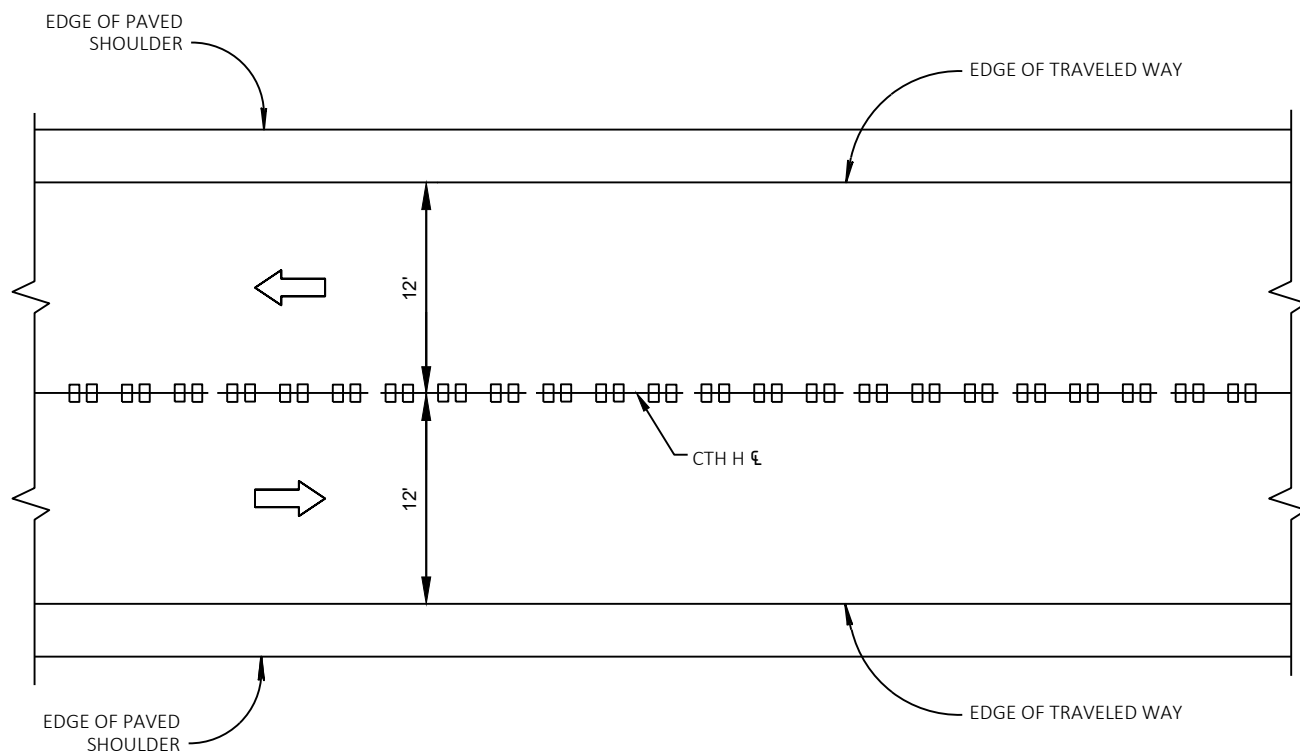


PLAN VIEW

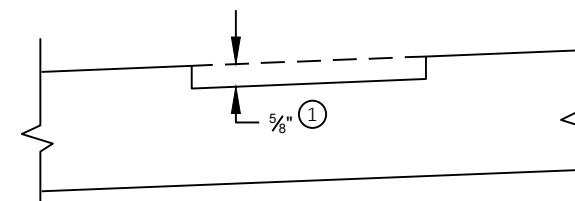

SECTION B-B  
SUPERELEVATED ROADWAY

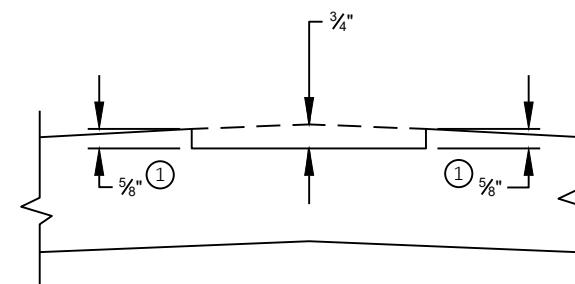

SECTION B-B  
CROWNED ROADWAY

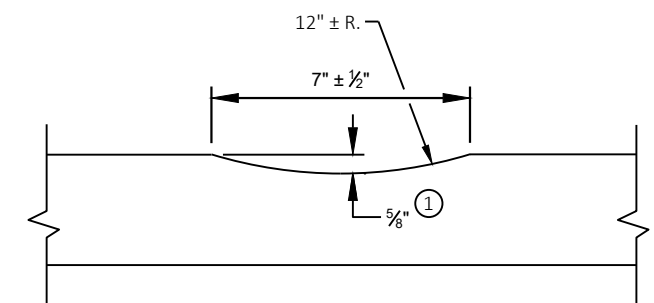

SECTION A-A

ASPHALTIC CENTERLINE RUMBLE STRIPS 2-LANE RURAL  
(PRIOR TO APPLYING RESIN BINDER HIGH FRICTION SURFACE TREATMENT)



|                        |            |                    |                  |       |   |
|------------------------|------------|--------------------|------------------|-------|---|
| PROJECT NO: 4867-03-70 | HWY: CTH H | COUNTY: WASHINGTON | PAVEMENT MARKING | SHEET | E |
|------------------------|------------|--------------------|------------------|-------|---|

## GENERAL NOTES FOR TRAFFIC CONTROL

ALL SIGN LOCATIONS ARE APPROXIMATE. THE ACTUAL LOCATION WILL BE DETERMINED IN THE FIELD BY THE ENGINEER.

DRAWINGS SHOW TRAFFIC CONTROL FOR A TYPICAL SITUATION. ADDITIONAL TRAFFIC CONTROL DEVICES MAY BE REQUIRED AND/OR LAYOUT DETAILS MODIFIED DEPENDING ON CONTRACTOR'S METHODS OR SEQUENCES OF OPERATION.

ROAD MACHINERY, TRUCK ENTRANCE, FLAGMEN AHEAD, ETC., SIGNS SHALL BE USED AS NEEDED AND SHALL BE REMOVED WHEN THE ACTIVITY OR CONDITION DOES NOT EXIST.






"WO" SERIES SIGNS ARE "W" SERIES EXCEPT THE BACKGROUND IS ORANGE.

ALL SIGNS ARE 48" X 48" UNLESS OTHERWISE NOTED.

DETAILS OF TRAFFIC CONTROL NOT SHOWN ON THIS DRAWING SHALL CONFORM TO THE PERTINENT REQUIREMENTS OF THE STANDARD SPECIFICATIONS, APPLICABLE SPECIAL PROVISIONS, AND THE MANUAL ON UNIFORM TRAFFIC CONTROL DEVICES (MUTCD).

FOR ADDITIONAL INFORMATION SEE STANDARD DETAIL DRAWINGS:

"BARRICADES AND SIGNS FOR MAINLINE, DETOUR, ON RAMP, OFF RAMP CLOSURES AND ADVANCED WIDTH RESTRICTION" - SHEET A  
"BARRICADES AND SIGNS FOR MAINLINE CLOSURES" AND "TRAFFIC CONTROL FOR LANE CLOSURE WITH FLAGGING OPERATION".

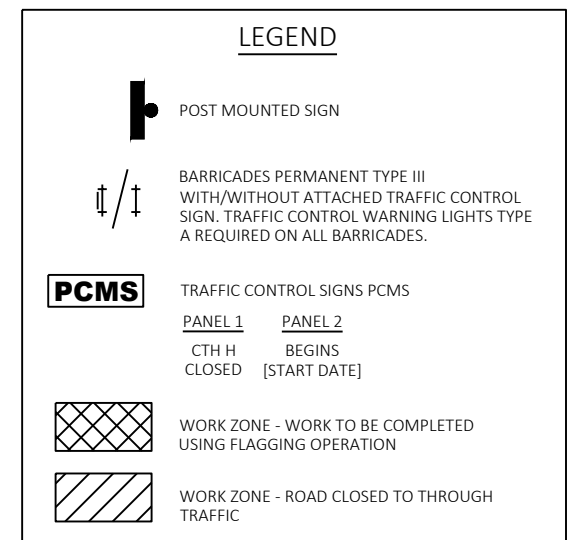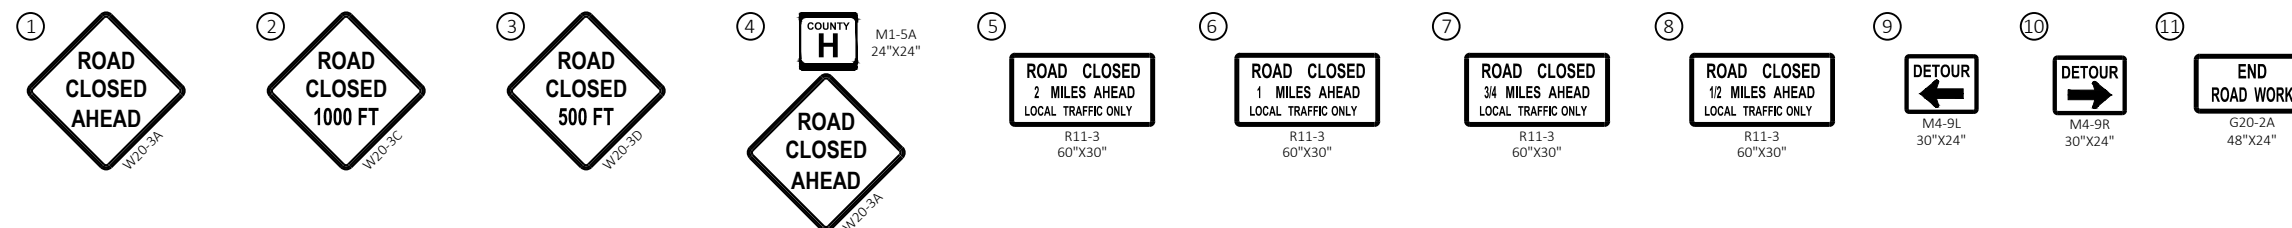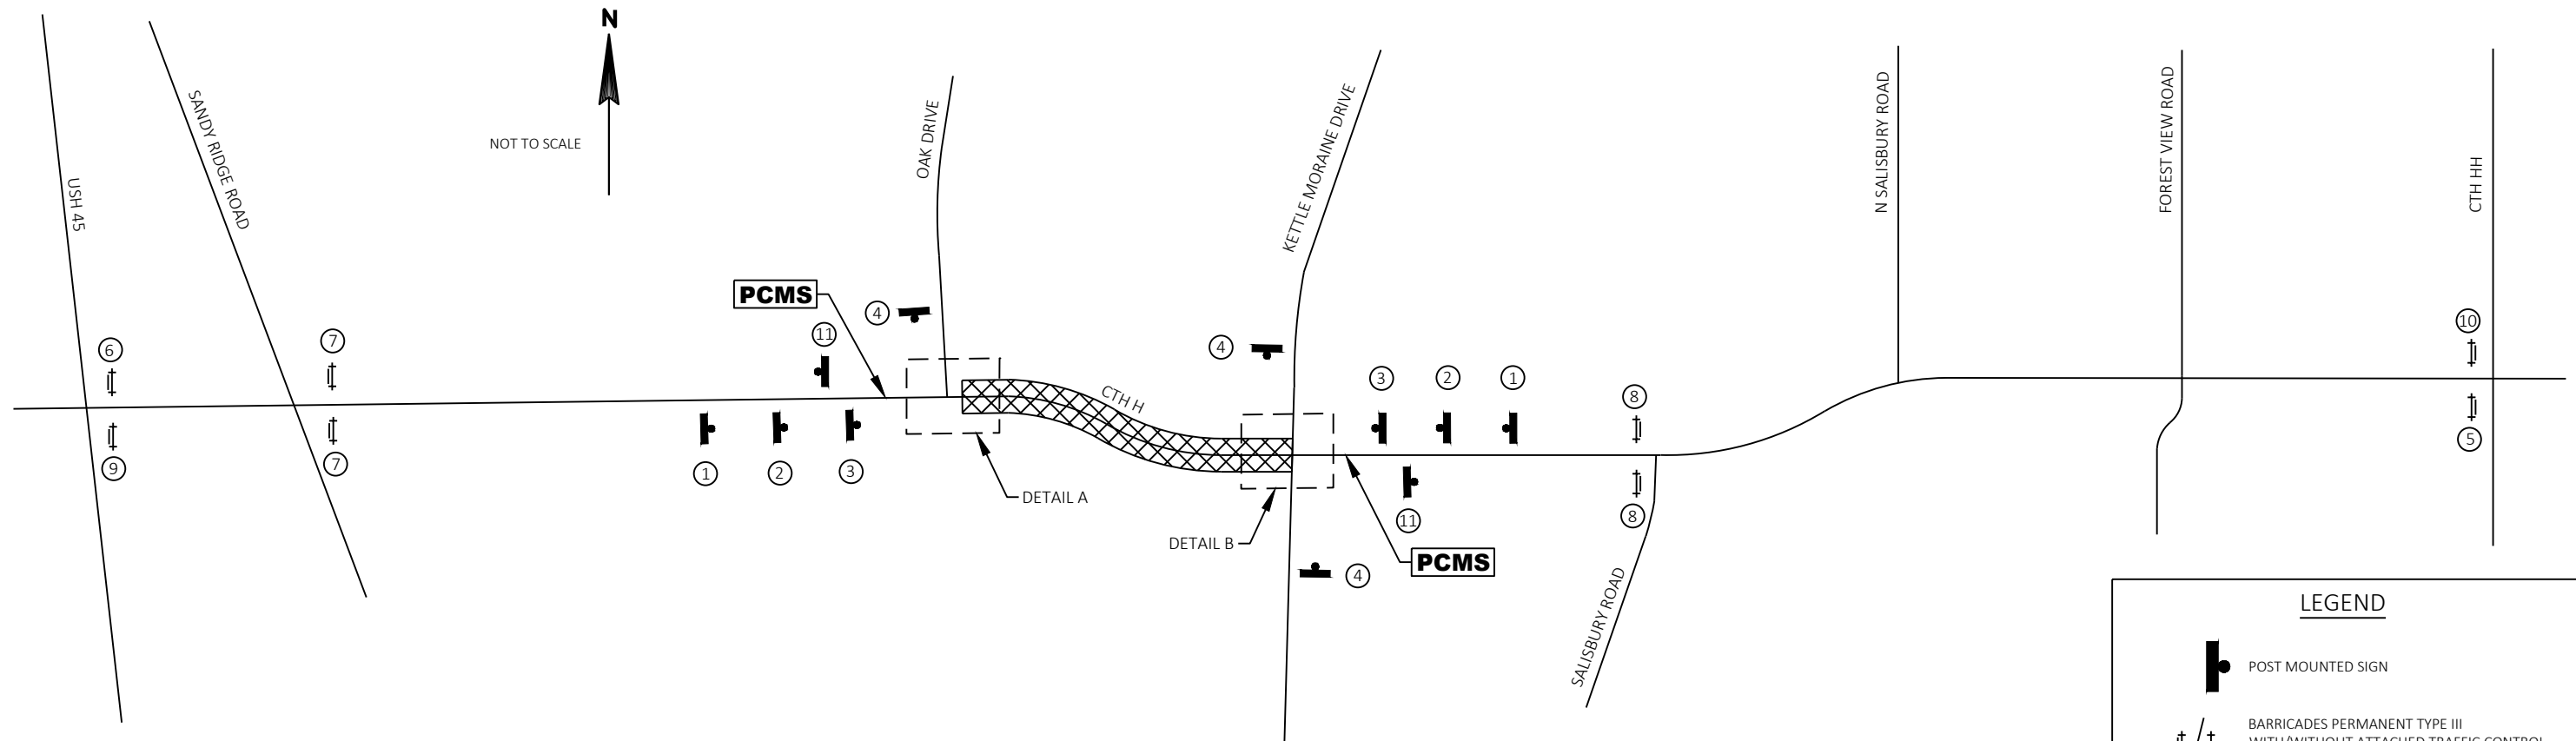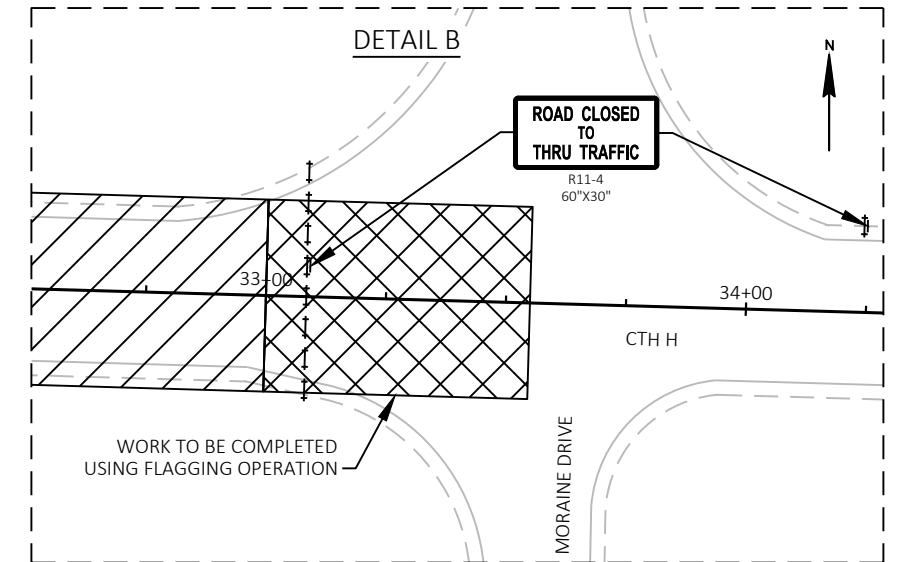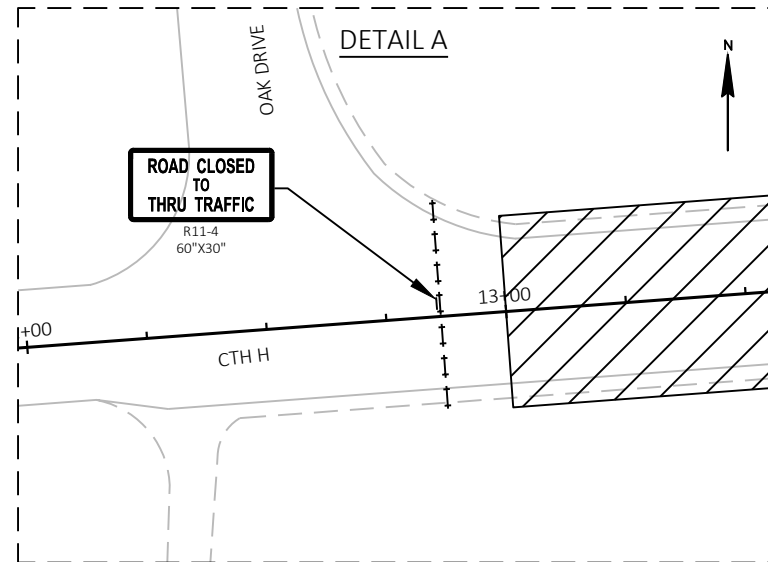

PROJECT NO: 4867-03-70

HWY: CTH H

COUNTY: WASHINGTON

TRAFFIC CONTROL - ADVANCED WARNING SIGNING (DURING DETOUR)

SHEET

E

GENERAL NOTES FOR TRAFFIC CONTROL

ALL SIGN LOCATIONS ARE APPROXIMATE. THE ACTUAL LOCATION WILL BE DETERMINED IN THE FIELD BY THE ENGINEER.

DRAWINGS SHOW TRAFFIC CONTROL FOR A TYPICAL SITUATION. ADDITIONAL TRAFFIC CONTROL DEVICES MAY BE REQUIRED AND/OR LAYOUT DETAILS MODIFIED DEPENDING ON CONTRACTOR'S METHODS OR SEQUENCES OF OPERATION.


ROAD MACHINERY, TRUCK ENTRANCE, FLAGMEN AHEAD, ETC., SIGNS SHALL BE USED AS NEEDED AND SHALL BE REMOVED WHEN THE ACTIVITY OR CONDITION DOES NOT EXIST.

"WO" SERIES SIGNS ARE "W" SERIES EXCEPT THE BACKGROUND IS ORANGE.

ALL SIGNS ARE 48" X 48" UNLESS OTHERWISE NOTED.

DETAILS OF TRAFFIC CONTROL NOT SHOWN ON THIS DRAWING SHALL CONFORM TO THE PERTINENT REQUIREMENTS OF THE STANDARD SPECIFICATIONS, APPLICABLE SPECIAL PROVISIONS, AND THE MANUAL ON UNIFORM TRAFFIC CONTROL DEVICES (MUTCD).

FOR ADDITIONAL INFORMATION SEE STANDARD DETAIL DRAWINGS:  
"TRAFFIC CONTROL FOR LANE CLOSURE WITH FLAGGING OPERATION", "TRAFFIC CONTROL, ADVANCED WARNING SIGNS 45 M.P.H. OR GREATER, TWO WAY UNDIVIDED ROAD OPEN TO TRAFFIC", AND "MOVING PAVEMENT MARKING OPERATION - TWO-LANE TWO-WAY ROADWAY".

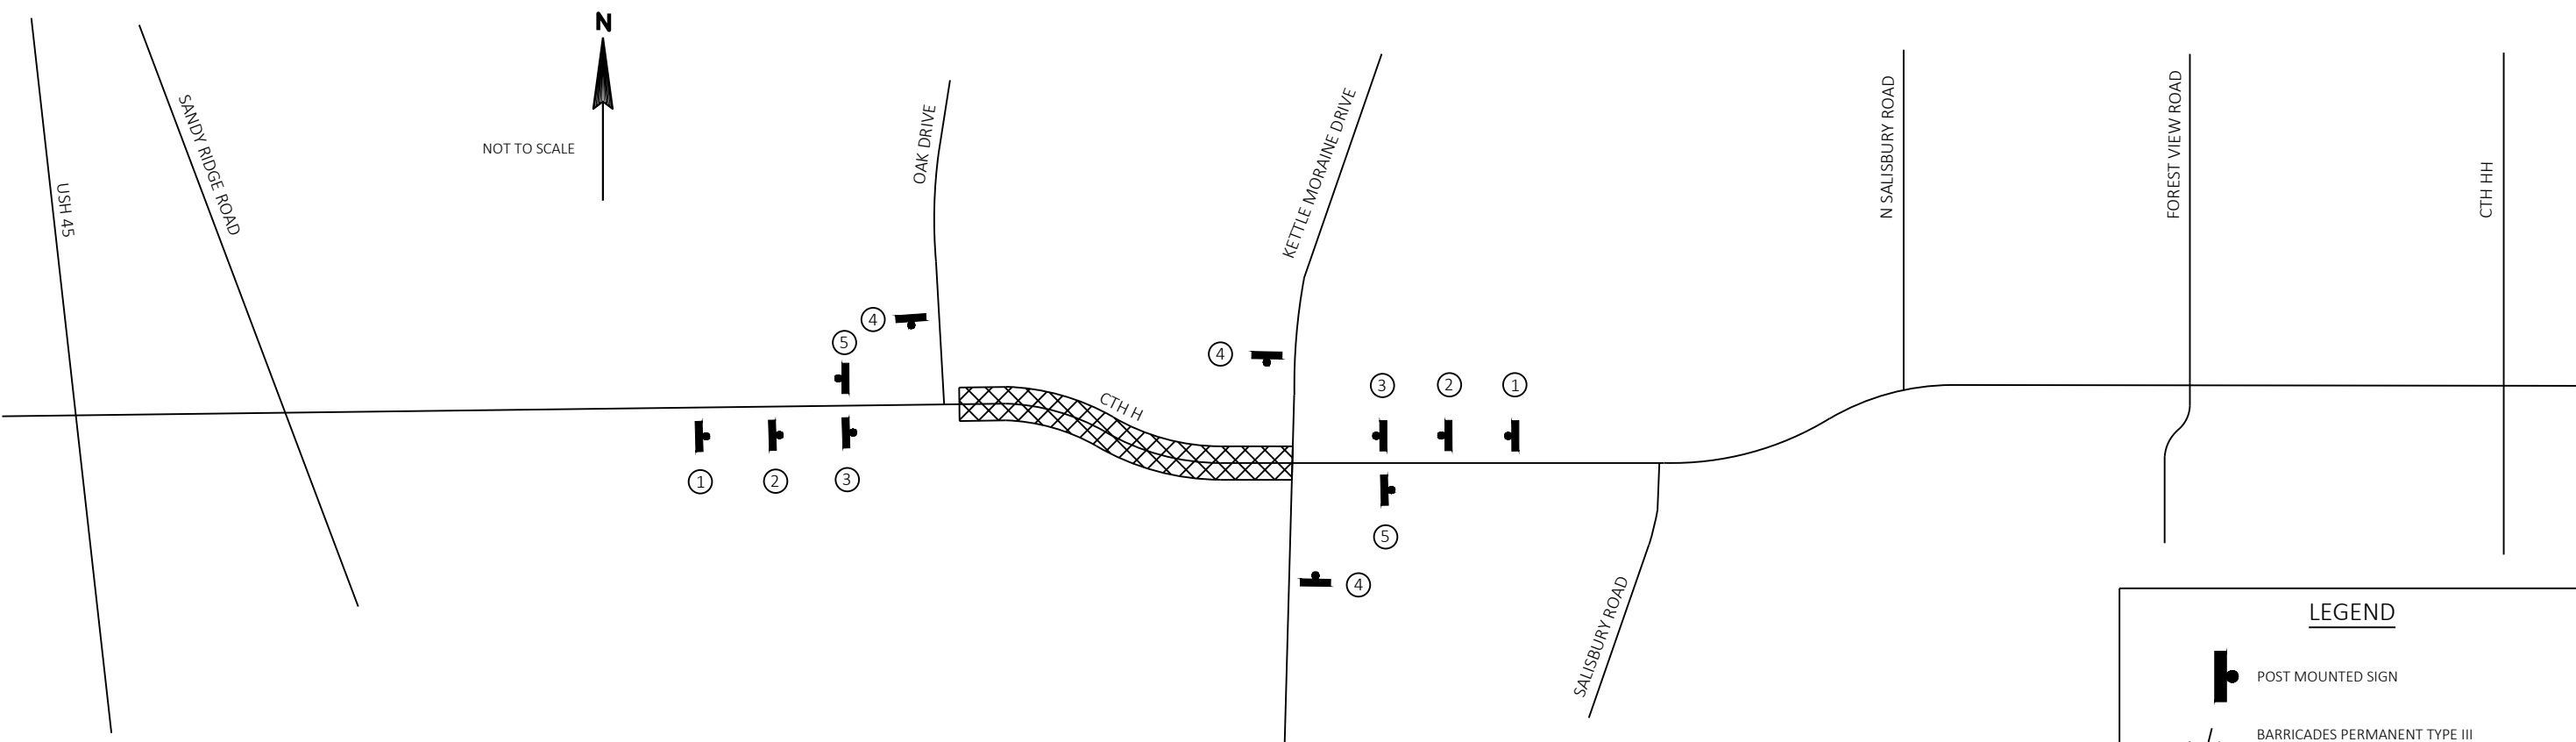

LEGEND

POST MOUNTED SIGN

BARRICADES PERMANENT TYPE III WITH/WITHOUT ATTACHED TRAFFIC CONTROL SIGN. TRAFFIC CONTROL WARNING LIGHTS TYPE A REQUIRED ON ALL BARRICADES.

PCMS

PANEL 1  
CTH H  
CLOSED

PANEL 2  
BEGINS  
[START DATE]

TRAFFIC CONTROL SIGNS PCMS

WORK ZONE - WORK TO BE COMPLETED USING FLAGGING OPERATION

WORK ZONE - ROAD CLOSED TO THROUGH TRAFFIC

ALL MO5 AND MO6 ARROW SIGNS SHALL BE THE SAME AS "M" SIGNS EXCEPT THAT THE BACKGROUND IS ORANGE.



Estimate Of Quantities

4867-03-70

| Line | Item     | Item Description                                              | Unit | Total     | Qty       |
|------|----------|---------------------------------------------------------------|------|-----------|-----------|
| 0002 | 213.0100 | Finishing Roadway (project) 01. 4867-03-70                    | EACH | 1.000     | 1.000     |
| 0004 | 465.0475 | Asphalt Centerline Rumble Strips 2-Lane Rural                 | LF   | 1,650.000 | 1,650.000 |
| 0006 | 618.0100 | Maintenance And Repair of Haul Roads (project) 01. 4867-03-70 | EACH | 1.000     | 1.000     |
| 0008 | 619.1000 | Mobilization                                                  | EACH | 1.000     | 1.000     |
| 0010 | 643.0300 | Traffic Control Drums                                         | DAY  | 42.000    | 42.000    |
| 0012 | 643.0420 | Traffic Control Barricades Type III                           | DAY  | 336.000   | 336.000   |
| 0014 | 643.0705 | Traffic Control Warning Lights Type A                         | DAY  | 616.000   | 616.000   |
| 0016 | 643.0900 | Traffic Control Signs                                         | DAY  | 3,420.000 | 3,420.000 |
| 0018 | 643.1050 | Traffic Control Signs PCMS                                    | DAY  | 14.000    | 14.000    |
| 0020 | 643.5000 | Traffic Control                                               | EACH | 1.000     | 1.000     |
| 0022 | 646.1020 | Marking Line Epoxy 4-Inch                                     | LF   | 8,080.000 | 8,080.000 |
| 0024 | 649.0120 | Temporary Marking Line Epoxy 4-Inch                           | LF   | 4,110.000 | 4,110.000 |
| 0026 | ASP.1T0A | On-the-Job Training Apprentice at \$5.00/HR                   | HRS  | 100.000   | 100.000   |
| 0028 | ASP.1T0G | On-the-Job Training Graduate at \$5.00/HR                     | HRS  | 100.000   | 100.000   |
| 0030 | SPV.0180 | Special 01. Resin Binder High Friction Surface Treatment      | SY   | 7,535.000 | 7,535.000 |

| FINISHING ROADWAY |                |                  |
|-------------------|----------------|------------------|
| CATEGORY          | PROJECT        | 213.0100<br>EACH |
| 0010              | 01. 4867-03-70 | 1                |

| ASPHALT CENTERLINE RUMBLE STRIPS 2-LANE RURAL |                   |         |                |
|-----------------------------------------------|-------------------|---------|----------------|
| CATEGORY                                      | STATION - STATION |         | 465.0475<br>LF |
| 0010                                          | 16+50             | - 33+00 | 1,650          |

| MAINTENANCE AND REPAIR OF HAUL ROADS |            |                  |
|--------------------------------------|------------|------------------|
| CATEGORY                             | PROJECT    | 618.0100<br>EACH |
| 0020                                 | 4867-03-70 | 1                |



| MOBILIZATION |            |                  |
|--------------|------------|------------------|
| CATEGORY     | PROJECT    | 619.1000<br>EACH |
| 0010         | 4867-03-70 | 1                |

| TRAFFIC CONTROL AND ADVANCED WARNING ITEMS |                                  |                    |                                     |                                                |                                                      |                                                                 |                                                           |                                                                      |                                     |                                                |                                          |                                                     |
|--------------------------------------------|----------------------------------|--------------------|-------------------------------------|------------------------------------------------|------------------------------------------------------|-----------------------------------------------------------------|-----------------------------------------------------------|----------------------------------------------------------------------|-------------------------------------|------------------------------------------------|------------------------------------------|-----------------------------------------------------|
| CATEGORY                                   | LOCATION                         | DURATION<br>(DAYS) | TRAFFIC<br>CONTROL<br>DRUMS<br>EACH | 643.0300<br>TRAFFIC<br>CONTROL<br>DRUMS<br>DAY | TRAFFIC<br>CONTROL<br>BARRICADES<br>TYPE III<br>EACH | 643.0420<br>TRAFFIC<br>CONTROL<br>BARRICADES<br>TYPE III<br>DAY | TRAFFIC<br>CONTROL<br>WARNING<br>LIGHTS<br>TYPE A<br>EACH | 643.0705<br>TRAFFIC<br>CONTROL<br>WARNING<br>LIGHTS<br>TYPE A<br>DAY | TRAFFIC<br>CONTROL<br>SIGNS<br>EACH | 643.0900<br>TRAFFIC<br>CONTROL<br>SIGNS<br>DAY | TRAFFIC<br>CONTROL<br>SIGNS PCMS<br>EACH | 643.1050<br>TRAFFIC<br>CONTROL<br>SIGNS PCMS<br>DAY |
|                                            |                                  |                    |                                     |                                                |                                                      |                                                                 |                                                           |                                                                      |                                     |                                                |                                          |                                                     |
| 0010                                       | PRE-CONSTRUCTION                 | 7                  | 6                                   | 42                                             | ---                                                  | ---                                                             | ---                                                       | ---                                                                  | ---                                 | ---                                            | 2                                        | 14                                                  |
|                                            | ADVANCED WARNING (DURING DETOUR) | 14                 | ---                                 | ---                                            | 24                                                   | 336                                                             | 44                                                        | 616                                                                  | 29                                  | 406                                            | ---                                      | ---                                                 |
|                                            | ADVANCED WARNING                 | 7                  | ---                                 | ---                                            | ---                                                  | ---                                                             | ---                                                       | ---                                                                  | 18                                  | 126                                            | ---                                      | ---                                                 |
|                                            | DETOUR                           | 19                 | ---                                 | ---                                            | ---                                                  | ---                                                             | ---                                                       | ---                                                                  | 152                                 | 2,888                                          | ---                                      | ---                                                 |
| TOTALS                                     |                                  |                    |                                     | 42                                             |                                                      | 336                                                             |                                                           | 616                                                                  |                                     | 3,420                                          |                                          | 14                                                  |

| TRAFFIC CONTROL |                |                  |
|-----------------|----------------|------------------|
| CATEGORY        | PROJECT        | 643.5000<br>EACH |
| 0010            | 01. 4867-03-70 | 1                |

| MARKING LINE ITEMS |                   |                                                                       |                                       |              |
|--------------------|-------------------|-----------------------------------------------------------------------|---------------------------------------|--------------|
| CATEGORY           | STATION - STATION | 649.0120<br>TEMPORARY<br>MARKING LINE<br>EPOXY 4-INCH<br>YELLOW<br>LF | 646.1020<br>MARKING LINE EPOXY 4-INCH |              |
|                    |                   |                                                                       | WHITE<br>LF                           | YELLOW<br>LF |
| 0010               | 13+00 - 33+55     | 4,110                                                                 | 3,970                                 | 4,110        |
| TOTALS             |                   | 4,110                                                                 | 8,080                                 |              |


| RESIN BINDER HIGH FRICTION SURFACE TREATMENT |                                |                   |
|----------------------------------------------|--------------------------------|-------------------|
| CATEGORY                                     | STATION - STATION              | SPV.0180.01<br>SY |
| 0010                                         | 13+00 - 33+55<br>UNDISTRIBUTED | 6,850<br>685      |
| TOTAL                                        |                                | 7,535             |

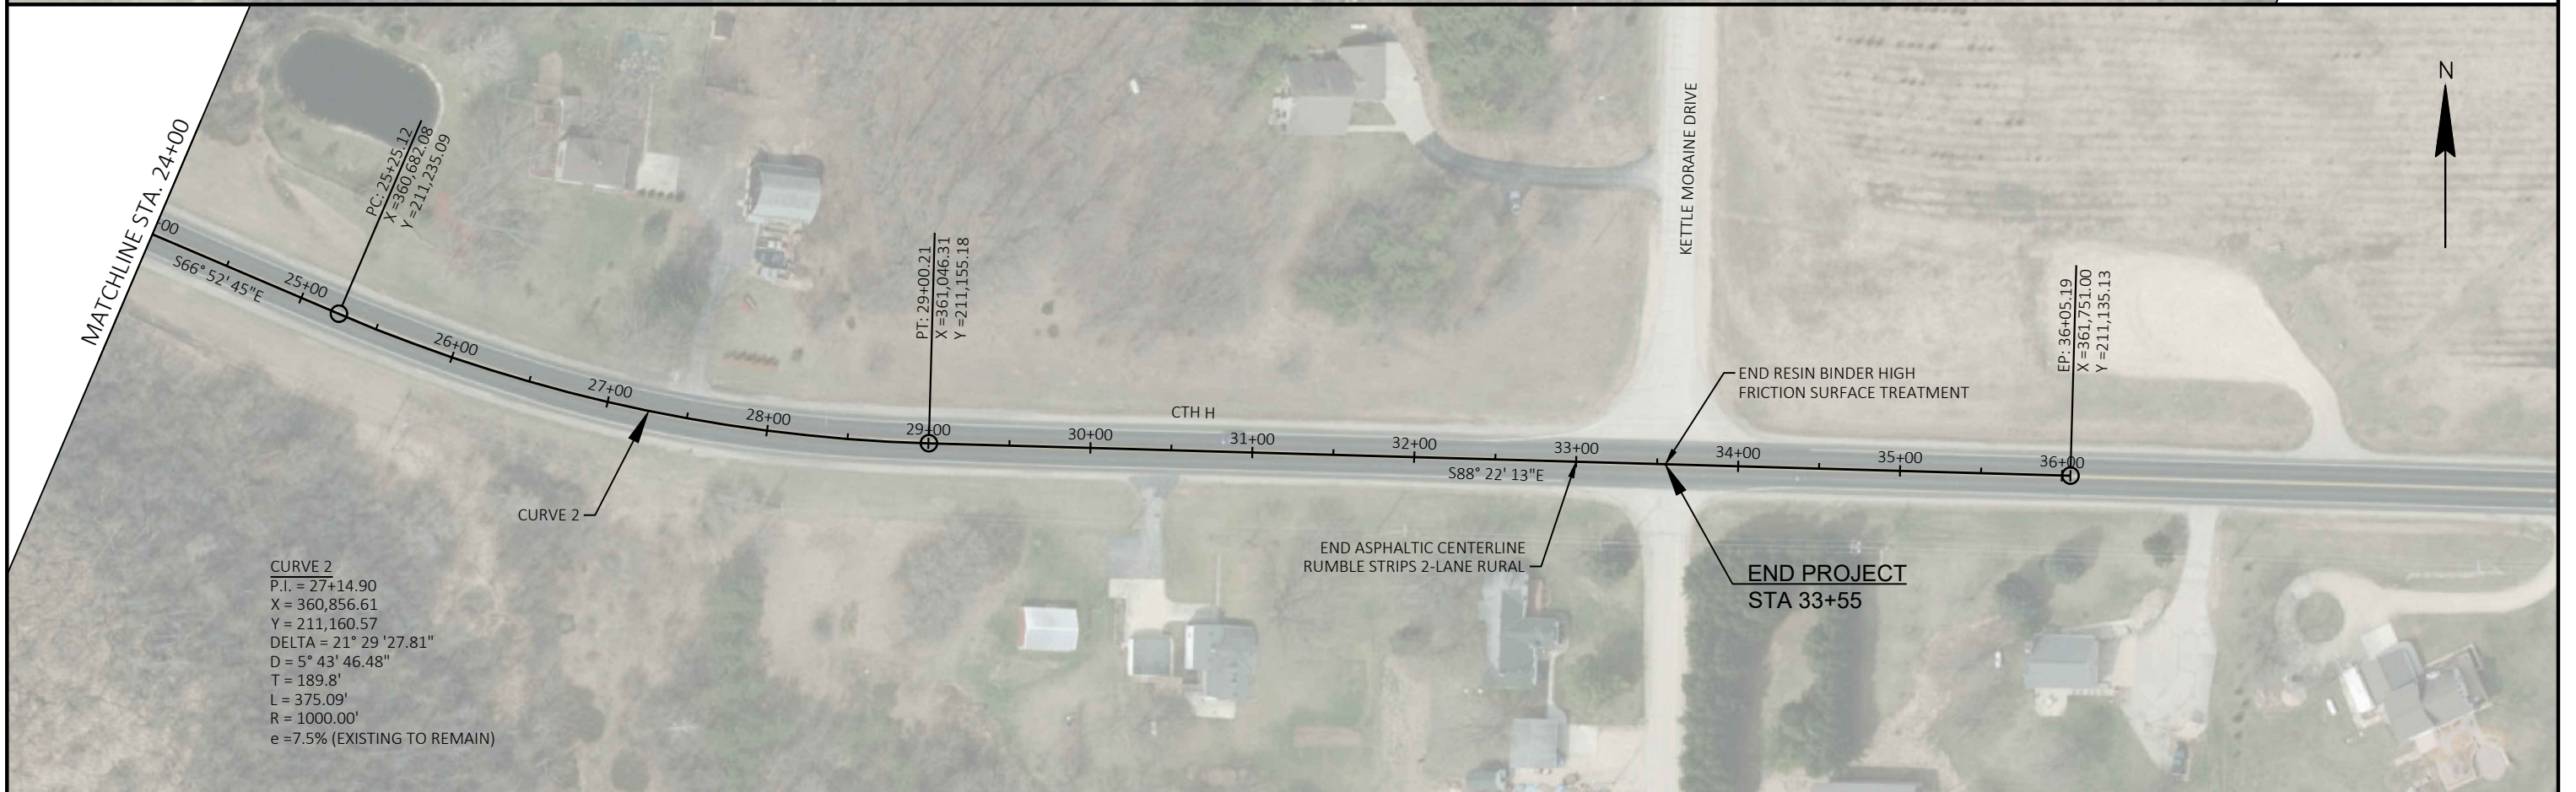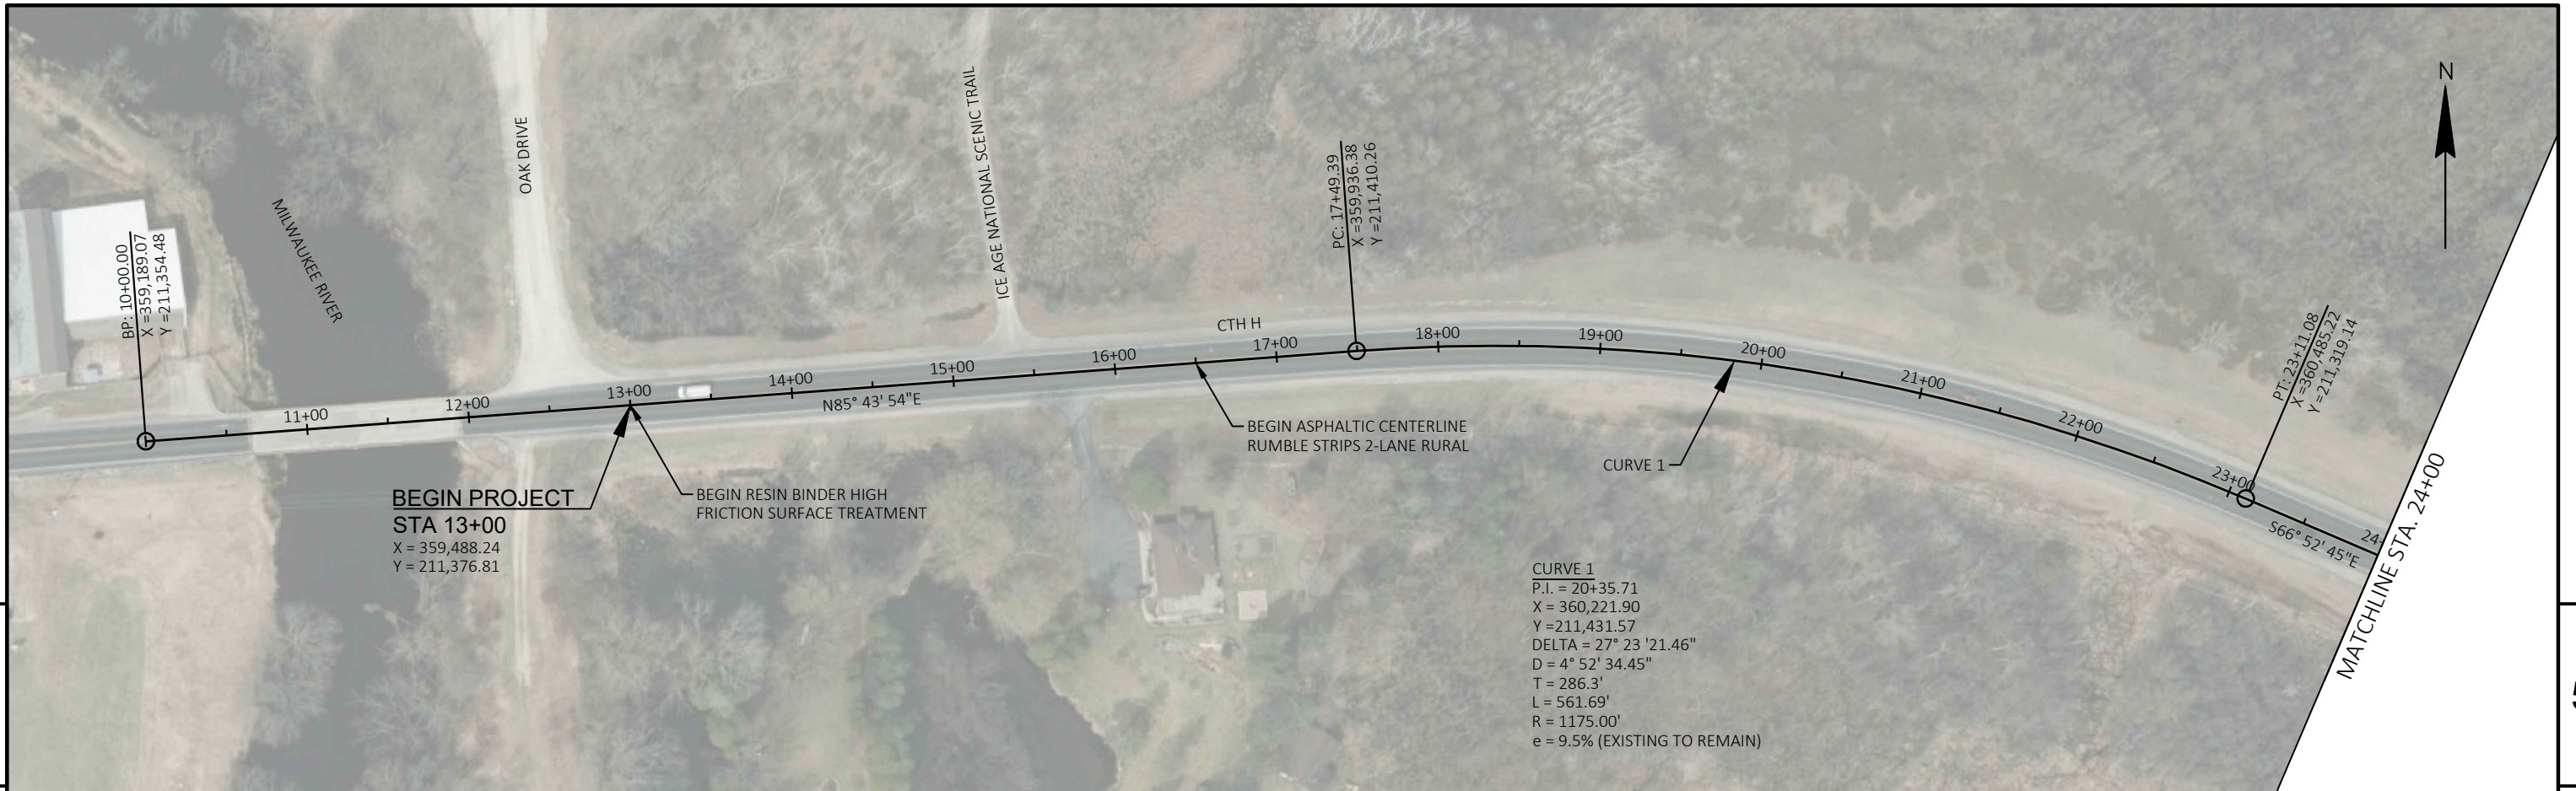


|                        |            |                    |      |       |   |
|------------------------|------------|--------------------|------|-------|---|
| PROJECT NO: 4867-03-70 | HWY: CTH H | COUNTY: WASHINGTON | PLAN | SHEET | E |
|------------------------|------------|--------------------|------|-------|---|

Standard Detail Drawing List


|           |                                                                                                    |
|-----------|----------------------------------------------------------------------------------------------------|
| 13A11-03B | 2-LANE RURAL CENTER LINE RUMBLE STRIP, MILLING                                                     |
| 15C02-07A | BARRICADES AND SIGNS FOR MAINLINE CLOSURES                                                         |
| 15C02-07B | BARRICADES AND SIGNS FOR VARIOUS CLOSURES                                                          |
| 15C02-07C | DETOUR SIGNING FOR MAINLINE CLOSURES                                                               |
| 15C03-05  | BARRICADES AND SIGNS FOR SIDEROAD CLOSURES                                                         |
| 15C04-05  | TRAFFIC CONTROL, ADVANCE WARNING SIGNS 45 M.P.H. OR GREATER TWO-WAY UNDIVIDED ROAD OPEN TO TRAFFIC |
| 15C08-19A | LONGITUDINAL MARKING (MAINLINE)                                                                    |
| 15C11-07B | CHANNELIZING DEVICES DRUMS, CONES, BARRICADES AND VERTICAL PANELS                                  |
| 15C12-06  | TRAFFIC CONTROL FOR LANE CLOSURE WITH FLAGGING OPERATION                                           |
| 15C19-05A | MOVING PAVEMENT MARKING OPERATION TWO-LANE TWO-WAY ROADWAY                                         |
| 15D38-02A | TEMPORARY TRAFFIC CONTROL SIGN MOUNTING                                                            |
| 15D38-02B | ATTACHMENT OF SIGNS TO POSTS                                                                       |

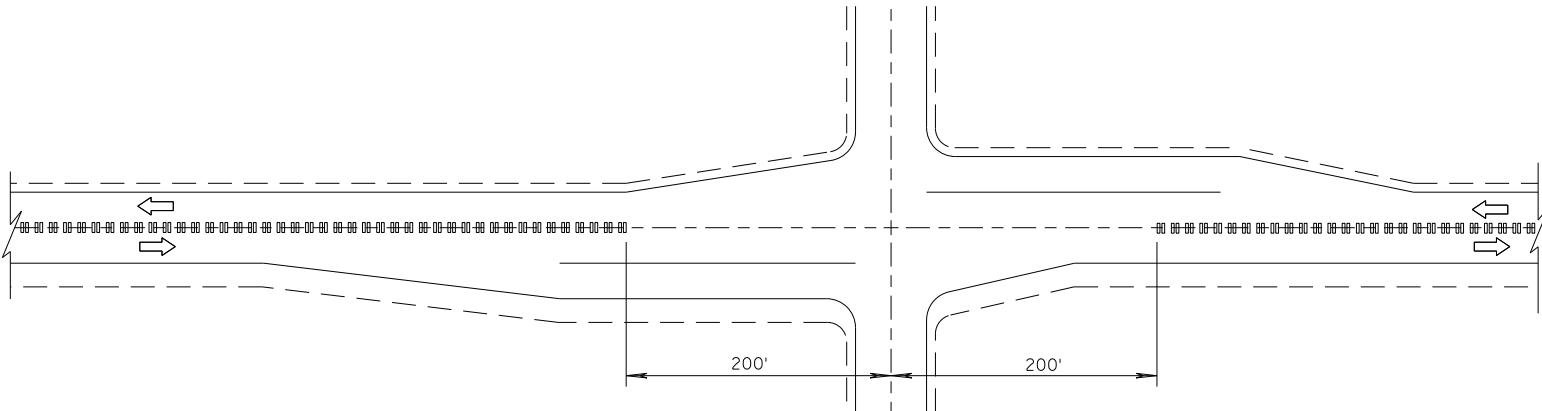

CENTER LINE GROOVES AT INTERSECTIONS

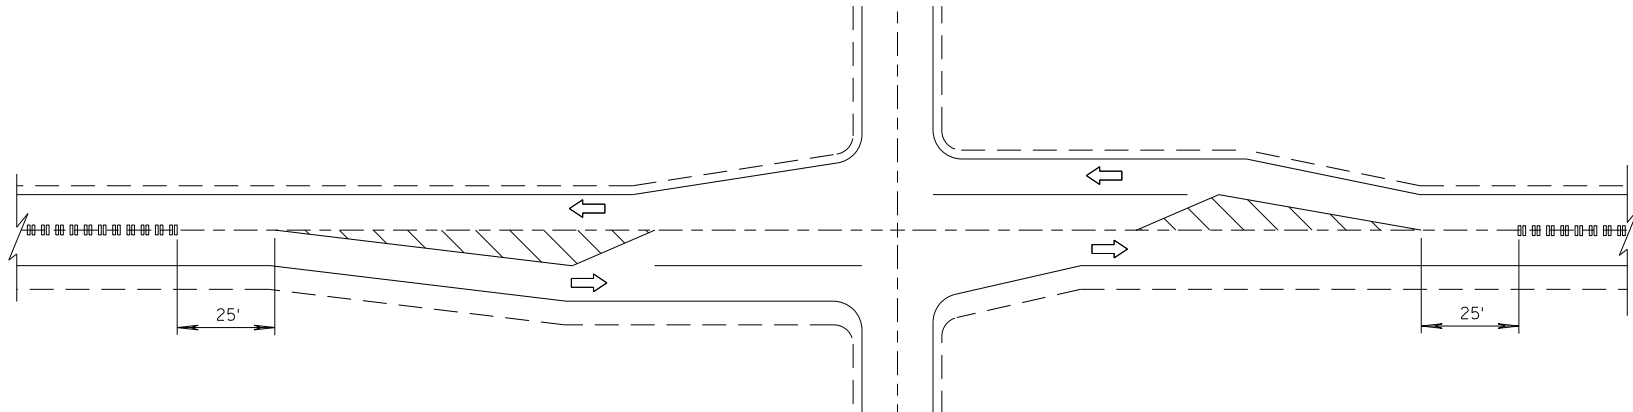


CENTER LINE GROOVES AT INTERSECTIONS  
(WITH LEFT TURN LANES)

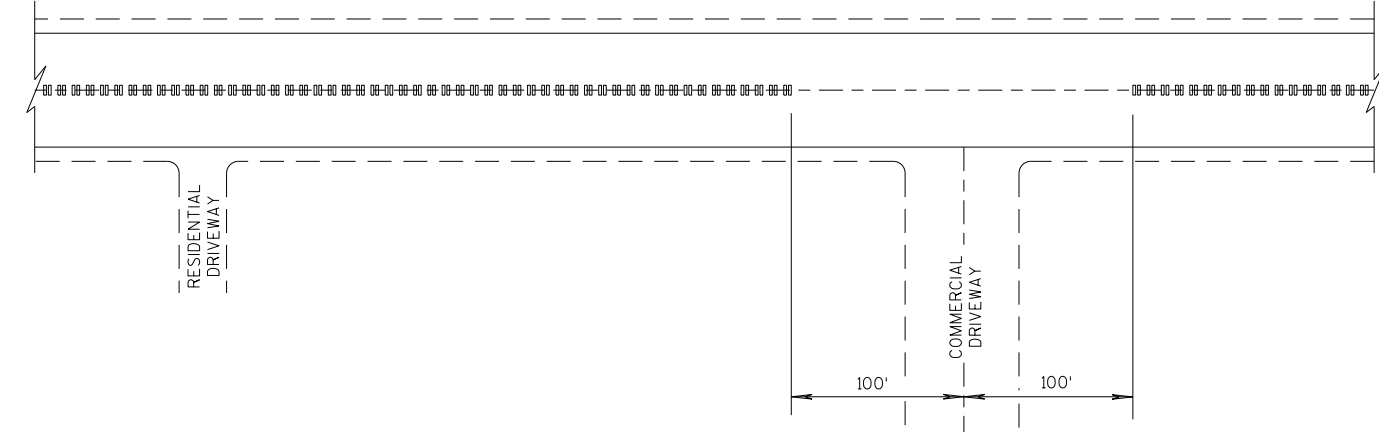


CENTER LINE GROOVES AT DRIVEWAYS

1

1 CENTERLINE GROOVES MAY BE OMITTED IN AREAS WITH HIGH CONCENTRATIONS OF DRIVEWAYS, WHEN DIRECTED BY THE ENGINEER.

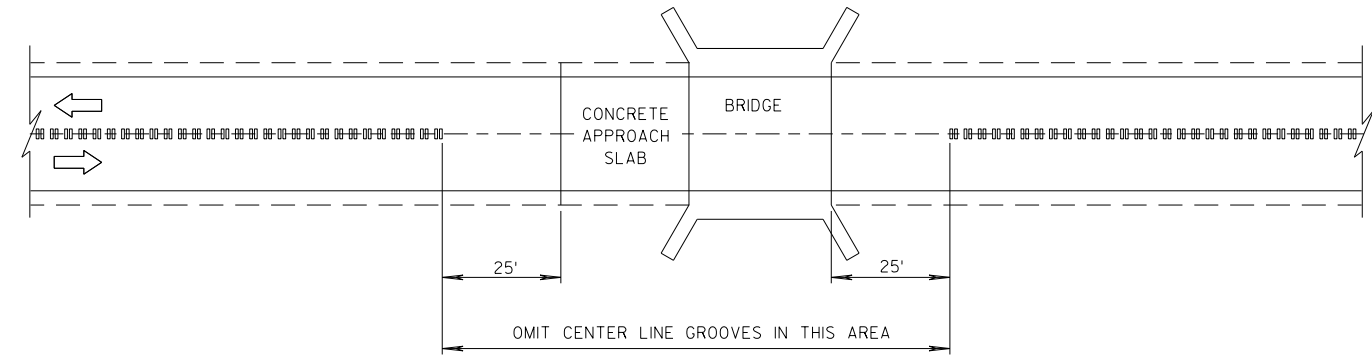


CENTER LINE GROOVES AT BRIDGES

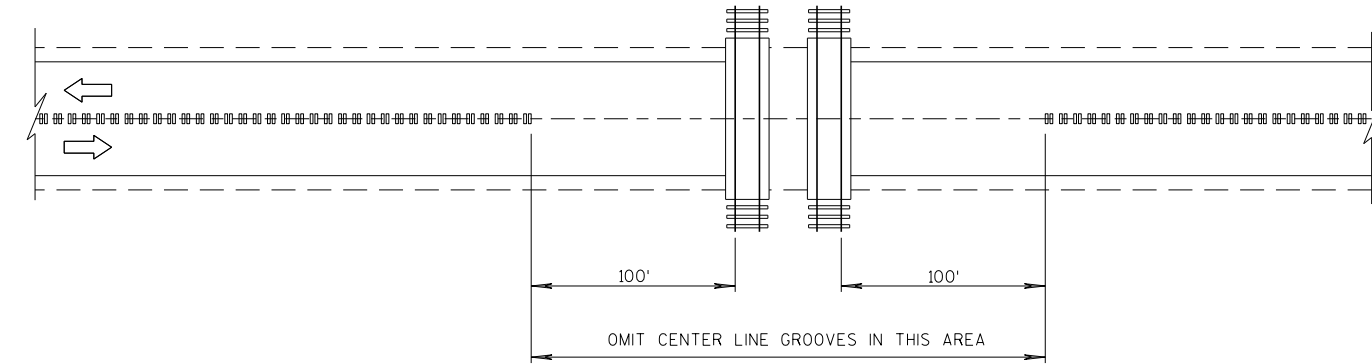

CENTER LINE GROOVES AT RAILROADS

|                                                      |                                                                       |
|------------------------------------------------------|-----------------------------------------------------------------------|
| 2-LANE RURAL<br>CENTER LINE RUMBLE STRIP,<br>MILLING |                                                                       |
| STATE OF WISCONSIN<br>DEPARTMENT OF TRANSPORTATION   |                                                                       |
| APPROVED<br>7/2018<br>DATE                           | /S/ Rodney Taylor<br>ROADWAY STANDARDS DEVELOPMENT<br>UNIT SUPERVISOR |
| FHWA                                                 |                                                                       |

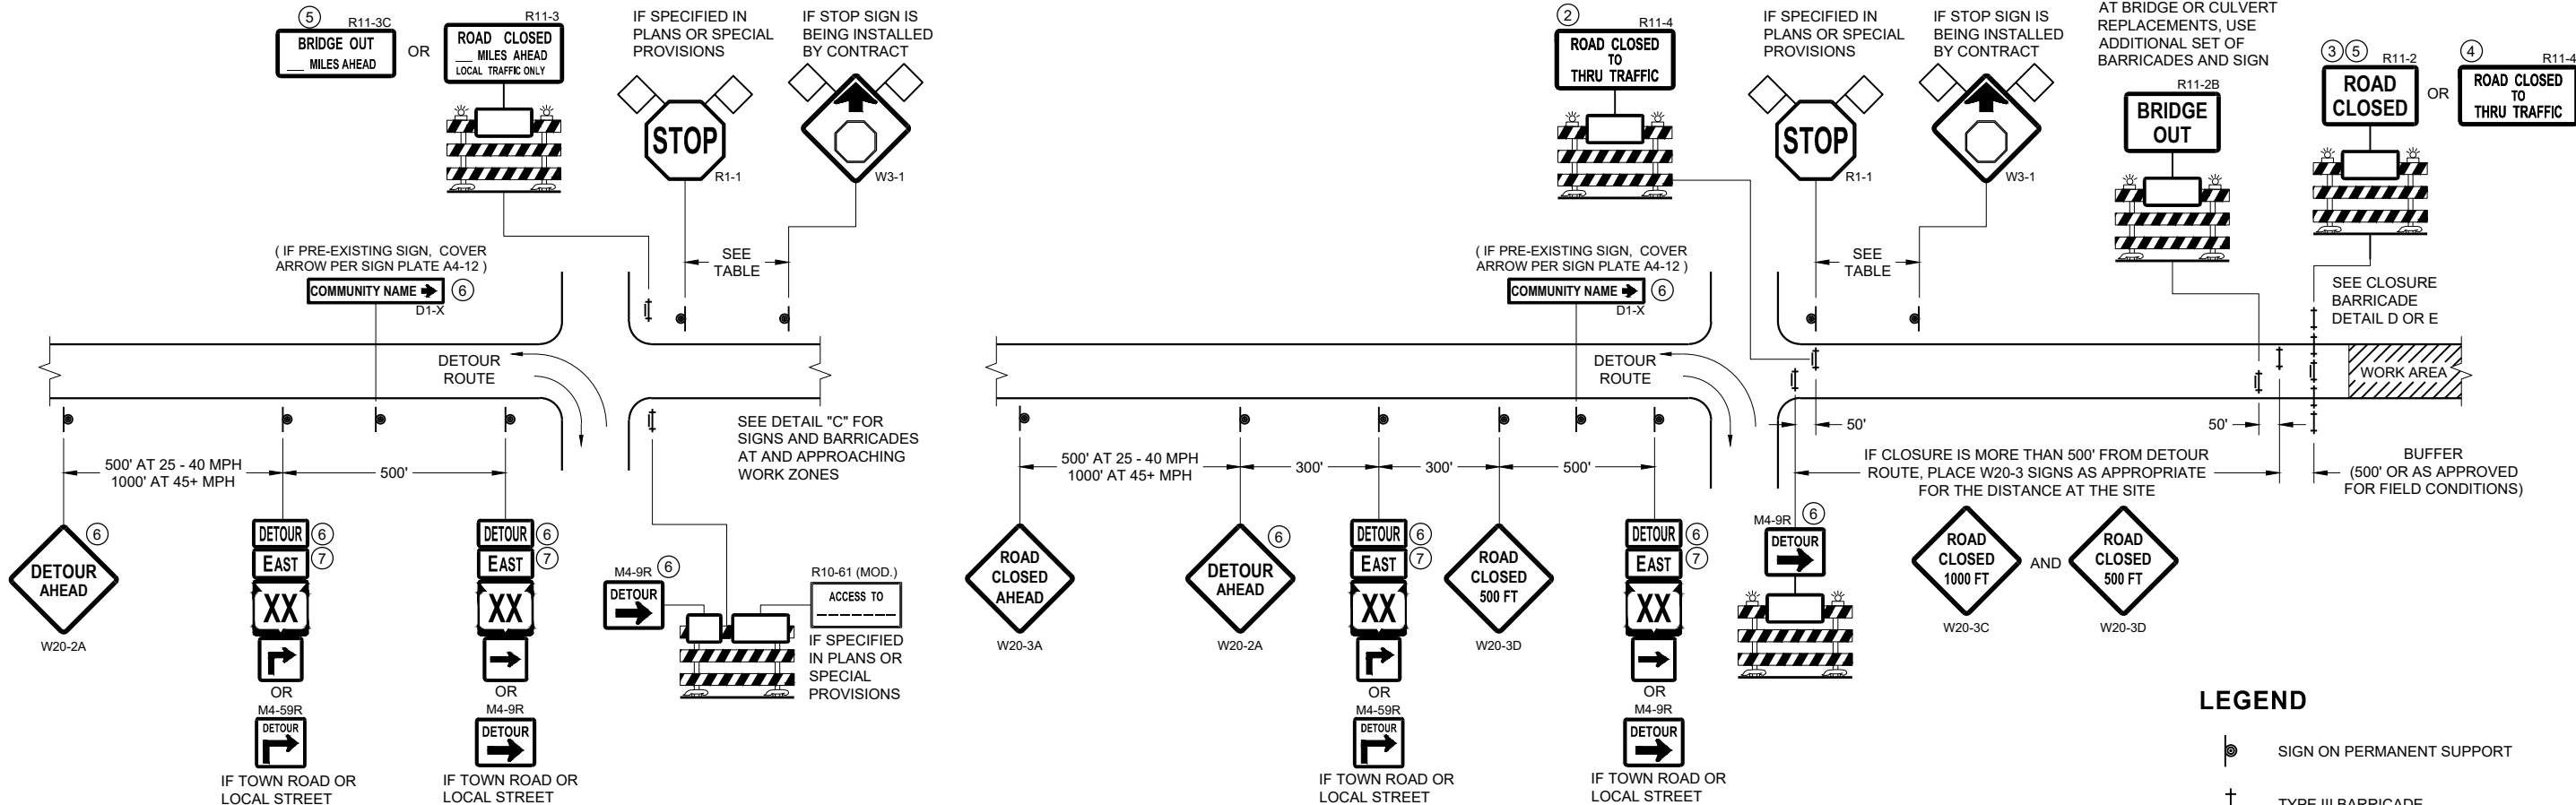

**LEGEND**

- SIGN ON PERMANENT SUPPORT
- TYPE III BARRICADE
- TYPE III BARRICADE WITH ATTACHED SIGN
- TYPE "A" WARNING LIGHT (FLASHING)
- WORK AREA
- FLAGS, 16" X 16" MIN. (ORANGE)

| SPEED LIMIT (MPH) | "STOP AHEAD" ADVANCE WARNING DISTANCE (FT) |
|-------------------|--------------------------------------------|
| 25                | 200                                        |
| 30                | 200                                        |
| 35                | 350                                        |
| 40                | 350                                        |
| 45                | 500                                        |
| 50                | 550                                        |
| 55                | 750                                        |


SEE SDD 15C2-SHEET "b" FOR GENERAL NOTES AND FOOTNOTES ① THROUGH ⑦

**BARRICADES AND SIGNS FOR MAINLINE CLOSURES**


STATE OF WISCONSIN  
DEPARTMENT OF TRANSPORTATION

APPROVED  
November 2018 /S/ Andrew Heidtke  
DATE WORK ZONE ENGINEER

FHWA

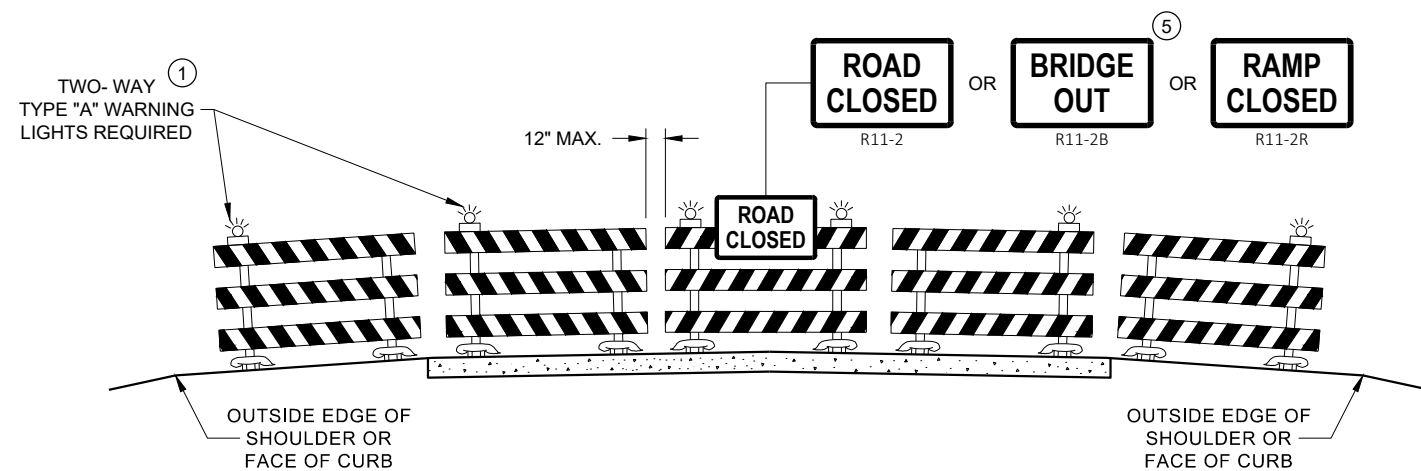

DETAIL D  
ROAD CLOSURE BARRICADE DETAIL  
APPROACH VIEW

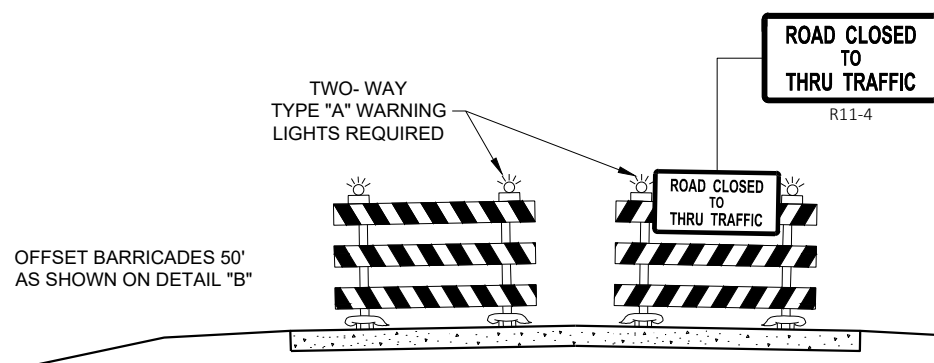

DETAIL E  
LANE CLOSURE BARRICADE DETAIL  
APPROACH VIEW

SEE SDD 15C2 - SHEET "a" FOR LEGEND

## GENERAL NOTES

THE EXACT NUMBER, LOCATION, AND SPACING OF ALL SIGNS AND BARRICADES SHALL BE ADJUSTED TO FIT FIELD CONDITIONS AS APPROVED BY THE ENGINEER.

ANY SIGNS TEMPORARY OR EXISTING, WHICH CONFLICT WITH TRAFFIC CONTROL "IN USE", SHALL BE REMOVED OR COVERED AS NEEDED AND AS APPROVED BY THE ENGINEER.

THE SPACING BETWEEN TRAFFIC CONTROL SIGNS SHOULD BE ADJUSTED TO NOT CONFLICT WITH AND SHOULD PROVIDE A DESIRABLE MINIMUM OF 200 FEET CLEARANCE TO EXISTING SIGNS THAT WILL REMAIN IN PLACE.

BARRICADES THAT MUST BE MOVED FOR A WORK OPERATION SHALL BE IMMEDIATELY RE-ESTABLISHED UPON COMPLETION OF THE OPERATION, OR FOR CONTINUING OPERATIONS, AT THE END OF EACH WORKING DAY.

SIGNS THAT WILL BE IN PLACE LESS THAN 7 CONTINUOUS DAYS AND NIGHTS MAY BE MOUNTED ON PORTABLE SUPPORTS.

ALL TYPE III BARRICADES SHALL HAVE RAILS REFLECTORIZED ON BOTH FACES. STRIPES SHALL BE PROPERLY SLOPED DOWN TOWARD THE TRAFFIC SIDE OR AS SHOWN IN THE ROAD CLOSURE BARRICADE DETAIL "D" FOR FULL ROAD CLOSURES.

TYPE "A" LOW - INTENSITY FLASHING WARNING LIGHTS SHALL BE VISIBLE ON BOTH SIDES OF THE BARRICADE.

THE R11 - 2, R11 - 3, M4 - 9, R11 - 4, AND R10 - 61 SIGNS PLACED ON THE BARRICADES SHALL COVER NO MORE THAN THE TOP RAIL. THE SIGNS SHALL NOT COVER ANY PORTION OF THE MIDDLE RAIL OR BOTTOM RAILS.

"WO" AND "MO" SIGNS ARE THE SAME AS "W" AND "M" SIGNS EXCEPT THE BACKGROUND IS ORANGE.

ALL SIGNS SHALL BE 48" X 48" UNLESS OTHERWISE NOTED BELOW:

- R11 - 2 SHALL BE 48" X 30"
- R11 - 3 SHALL, R11 - 4 AND R10 - 61 SHALL BE 60 " X 30"
- M4 - 9 SHALL BE 30" X 24"
- M3 - X SHALL BE 24" X 12" (36" X 18" IF NEEDED TO MATCH EXISTING SIGNS)
- M4 - 8 SHALL BE 24" X 12" (36" X 18" IF NEEDED TO MATCH EXISTING SIGNS)
- M1 - 4, M1 - 5A AND M1 - 6 SHALL BE 24" X 24" (36" X 36" IF NEEDED TO MATCH EXISTING SIGNS)
- MO5 - 1 AND MO6 - 1 SHALL BE 21" X 21" (30" X 30" IF NEEDED TO MATCH EXISTING SIGNS)
- D1 - X SHALL BE AS SHOWN ON SPECIFIC PROJECT SIGNING DETAIL SHEETS.
- R1 - 1 SHALL BE 36" X 36"


- 1 TWO WARNING LIGHTS SHALL BE PROVIDED ON THE CENTER BARRICADE AND A MINIMUM OF ONE WARNING LIGHT SHALL BE PROVIDED ON EACH OF THE OTHER BARRICADES WITHIN THE ROADWAY LIMITS. SPACING OF THE WARNING LIGHTS SHALL BE UNIFORM TO THE EDGE OF ROADWAY AS SHOWN (APPROX. 8 FOOT LIGHT SPACING).
- 2 THESE SIGNS AND BARRICADES ARE NOT REQUIRED IF ROAD CLOSURE BEGINS AT AN INTERSECTION.
- 3 FOR ROAD CLOSURE WITHOUT LOCAL ACCESS TO PROJECT, SEE ROAD CLOSURE BARRICADE DETAIL "D".
- 4 FOR ROAD CLOSURE WITH LOCAL ACCESS TO PROJECT, SEE ROAD CLOSURE BARRICADE DETAIL "E".
- 5 FOR BRIDGE OR CULVERT REPLACEMENTS, SUBSTITUTE "BRIDGE OUT" INSTEAD OF "ROAD CLOSED" ON R11 - 2 AND R11 - 3 SIGNS.
- 6 INSTALL DETOUR AND COMMUNITY GUIDE SIGNS AND ARROWS ONLY IF SPECIFIED IN THE CONTRACT. IF THERE ARE EXISTING ROUTE MARKER ASSEMBLIES THAT WILL REMAIN IN PLACE, ADJUST THE LOCATION OF THE DETOUR ROUTE SIGNS TO CORRESPOND WITH THE EXISTING ASSEMBLIES. MODIFY EXISTING SIGNS WHERE POSSIBLE. SEE SPECIFIC PROJECT DETOUR SIGNING DETAIL SHEETS. IF DETOUR SIGNS ARE BEING INSTALLED BY OTHERS, PLACE THE CONTRACTED TRAFFIC CONTROL SIGNS TO ALLOW FOR PLACEMENT OF ALL WARNING, DETOUR AND GUIDE SIGNS AS SHOWN.
- 7 "EAST" CARDINAL DIRECTION MARKERS AND RIGHT TURN ARROWS ARE SHOWN. USE OTHER CARDINAL DIRECTIONS AND ARROWS AS APPROPRIATE.

## BARRICADES AND SIGNS FOR VARIOUS CLOSURES

STATE OF WISCONSIN  
DEPARTMENT OF TRANSPORTATION

APPROVED  
November 2018 /S/ Andrew Heidtke  
DATE WORK ZONE ENGINEER


FHWA

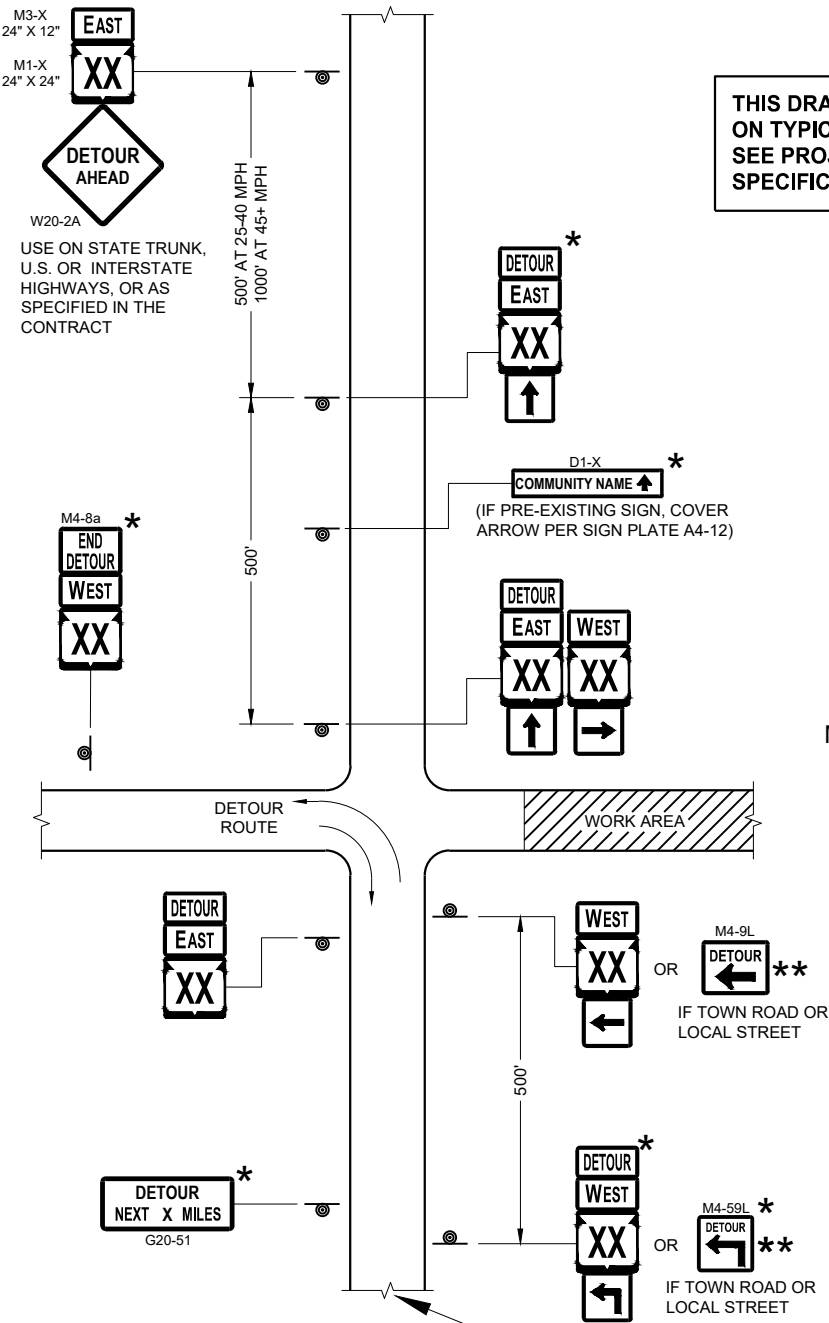

SEE SPECIFIC PROJECT DETOUR  
SIGNING DETAIL SHEETS AND  
DETAIL A OR B ON SDD SHEET 15C02 - SHEET "a"


THIS DRAWING PROVIDES GENERAL GUIDANCE  
ON TYPICAL DETOUR SIGN LAYOUT AND SPACING.  
SEE PROJECT DETOUR SIGNING SHEETS FOR  
SPECIFIC DETAILS FOR EACH PROJECT.

MATCH POINT

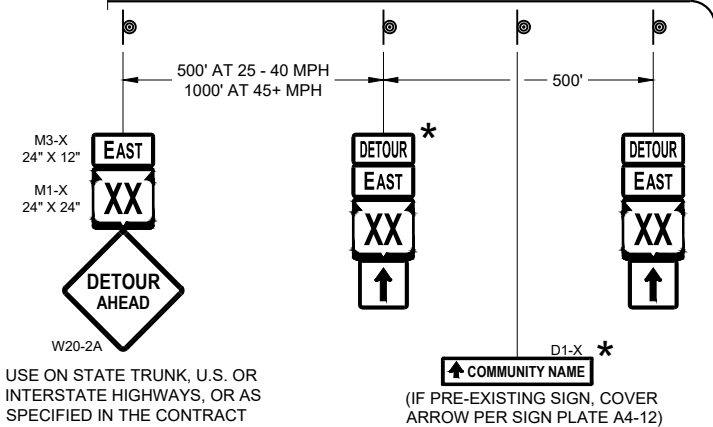

DETAIL F  
DETOUR SIGNING

LEGEND

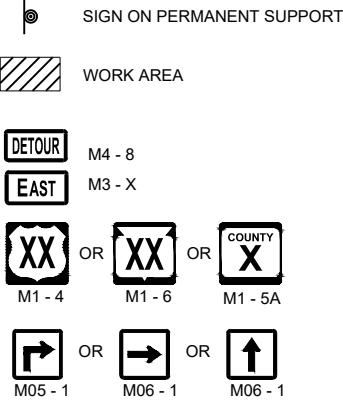

GENERAL NOTES

THE EXACT NUMBER, LOCATION AND SPACING OF ALL SIGNS SHALL BE ADJUSTED TO FIT FIELD CONDITIONS AS APPROVED BY THE ENGINEER.

IF THERE ARE EXISTING ROUTE MARKER ASSEMBLIES THAT WILL REMAIN IN PLACE, ADJUST THE LOCATION OF THE DETOUR ROUTE SIGNS TO CORRESPOND WITH THE EXISTING ASSEMBLIES. SEE SPECIFIC PROJECT DETOUR SIGNING DETAIL SHEETS. MODIFY EXISTING SIGNS WHERE POSSIBLE.

THE SPACING BETWEEN TRAFFIC CONTROL AND DETOUR SIGNS SHOULD BE ADJUSTED TO NOT CONFLICT WITH AND TO PROVIDE A DESIRABLE MINIMUM OF 200 FEET CLEARANCE TO EXISTING SIGNS THAT WILL REMAIN IN PLACE.

ANY SIGNS TEMPORARY OR EXISTING, WHICH CONFLICT WITH TRAFFIC CONTROL "IN USE" SHALL BE REMOVED OR COVERED AS NEEDED AND AS APPROVED BY THE ENGINEER.


SIGNS THAT WILL BE IN PLACE LESS THAN 7 CONTINUOUS DAYS AND NIGHTS MAY BE MOUNTED ON PORTABLE SUPPORTS.

"MO" SIGNS ARE THE SAME AS "M" SIGNS EXCEPT THE BACKGROUND IS ORANGE.

SIGN SIZES SHALL BE AS FOLLOWS:

- M3-X SHALL BE 24" X 12" (36" X 18" IF NEEDED TO MATCH EXISTING SIGNS)
- M4-8 SHALL BE 24" X 12" (30" X 15" IF NEEDED TO MATCH EXISTING SIGNS)
- M1-4, M1-5A AND M1-6 SHALL BE 24" X 24" (30" X 30" IF NEEDED TO MATCH EXISTING SIGNS)
- M05-1 AND M06-1 SHALL BE 21" X 21" (30" X 30" IF NEEDED TO MATCH EXISTING SIGNS)
- M4-9 AND M4-59 SHALL BE 30" X 24"
- M4-8a SHALL BE 24" X 18"
- G20-51 SHALL BE 60" X 24"
- W20-2 SHALL BE 48" X 48"
- D1-X SHALL BE AS SHOWN ON SPECIFIC PROJECT SIGNING DETAIL SHEETS.

- \* OPTIONAL SIGNS. SEE SPECIFIC PROJECT DETOUR SIGNING DETAIL SHEETS.
- \*\* FOR A TOWN ROAD OR LOCAL STREET DETOURED ONTO A STATE TRUNK HIGHWAY, PLACE A ROAD NAME PLAQUE ABOVE THE M4-9 SIGN AS SPECIFIED IN THE CONTRACT.

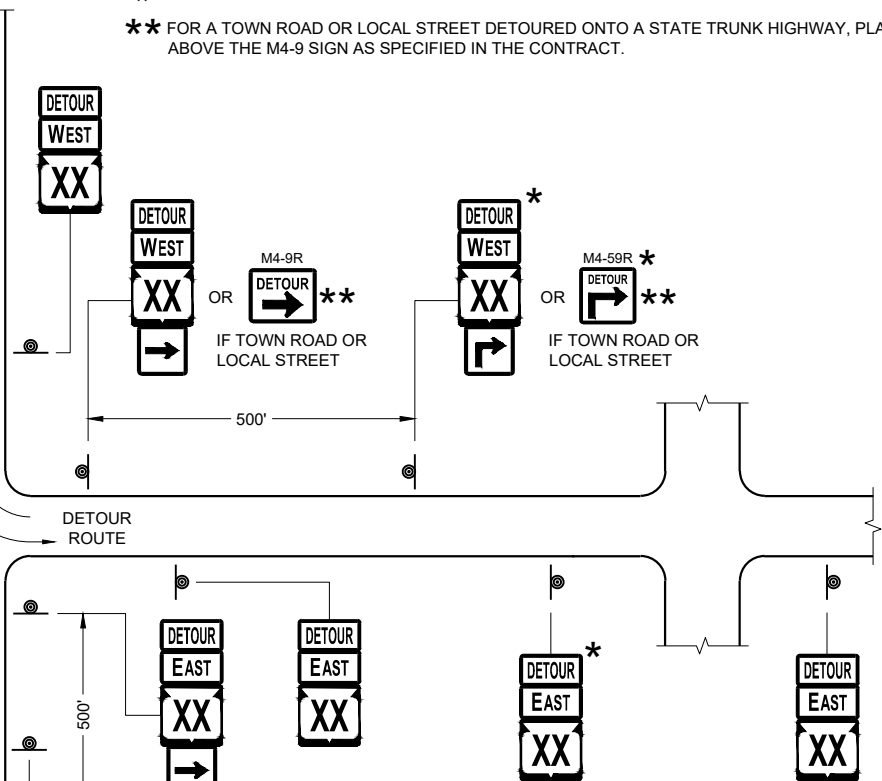


PLACE SIGNS BEYOND INTERSECTIONS  
WITH STATE OR COUNTY TRUNK  
HIGHWAYS OR AT 4 MILE MAXIMUM  
SPACING (4 BLOCKS IF URBAN AREA)


DETOUR SIGNING  
FOR MAINLINE CLOSURES

STATE OF WISCONSIN  
DEPARTMENT OF TRANSPORTATION


APPROVED  
November 2018 /S/ Andrew Heidtke  
DATE WORK ZONE ENGINEER  
FHWA

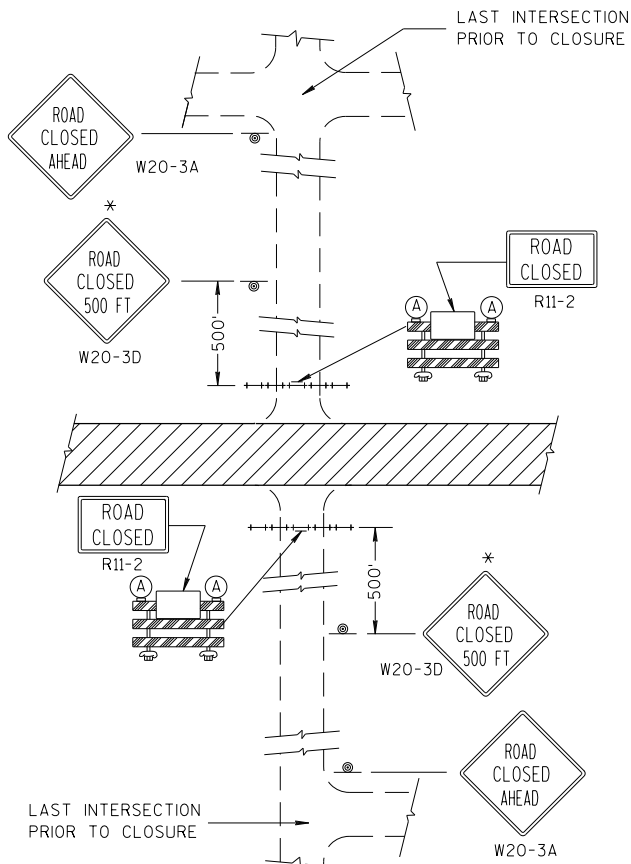


**DETAIL 1**  
(NO ACCESS TO PROJECT)

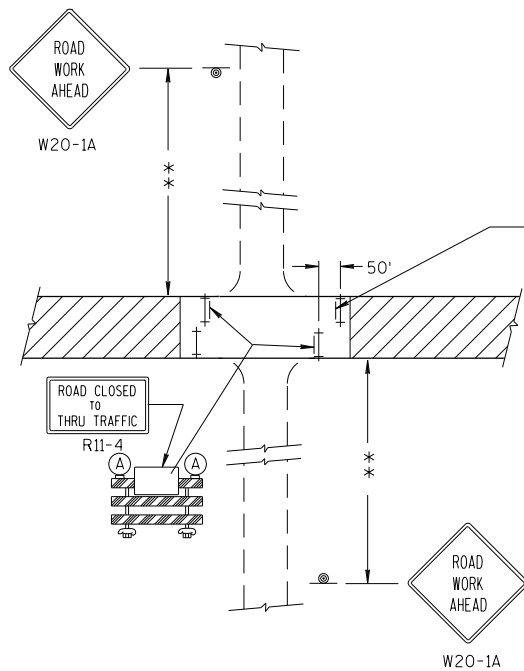

**DETAIL 3**  
(PUBLIC CROSS-TRAFFIC MAINTAINED. CONTRACTOR, LOCAL BUSINESS AND RESIDENT ACCESS).

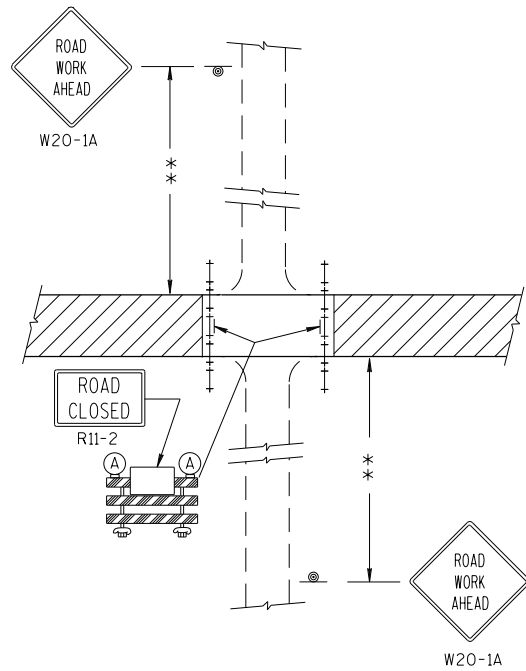

**DETAIL 2**  
(PUBLIC CROSS-TRAFFIC MAINTAINED. NO ACCESS TO PROJECT).

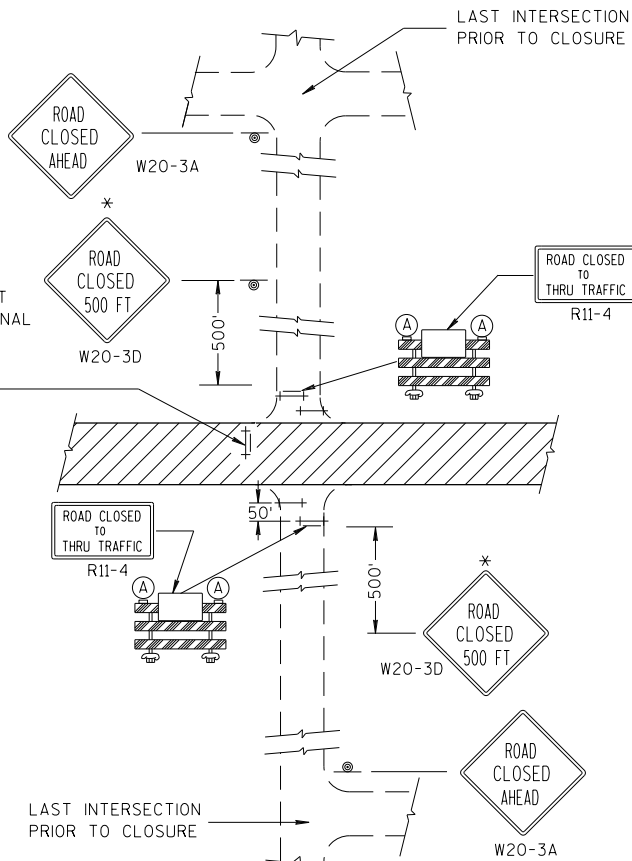

**DETAIL 4**  
(CONTRACTOR, LOCAL BUSINESS AND RESIDENT ACCESS TO PROJECT)

**GENERAL NOTES**

THE EXACT NUMBER, LOCATION, AND SPACING OF ALL SIGNS AND BARRICADES SHALL BE ADJUSTED TO FIT FIELD CONDITIONS AS APPROVED BY THE ENGINEER.

ANY SIGNS TEMPORARY OR EXISTING, WHICH CONFLICT WITH TRAFFIC CONTROL "IN USE" SHALL BE REMOVED OR COVERED AS NEEDED AND AS APPROVED BY THE ENGINEER.

THE SPACING BETWEEN TRAFFIC CONTROL SIGNS SHOULD BE ADJUSTED TO NOT CONFLICT WITH AND SHOULD PROVIDE A DESIRABLE MINIMUM OF 200 FEET CLEARANCE TO EXISTING SIGNS THAT WILL REMAIN IN PLACE.

IF A "STOP" SIGN MUST BE REMOVED FOR A WORK OPERATION, A TEMPORARY "STOP" SIGN SHALL BE PLACED PRIOR TO THE SIGN REMOVAL, OR A FLAGGER SHALL BE PROVIDED UNTIL THE SIGN IS RE-ESTABLISHED.

BARRICADES THAT MUST BE MOVED FOR A WORK OPERATION SHALL BE IMMEDIATELY RE-ESTABLISHED UPON COMPLETION OF THE OPERATION OR, FOR CONTINUING OPERATIONS, AT THE END OF EACH WORKING DAY.

SIGNS THAT WILL BE IN PLACE LESS THAN 7 CONTINUOUS DAYS AND NIGHTS MAY BE MOUNTED ON PORTABLE SUPPORTS.

ALL TYPE III BARRICADES SHALL HAVE RAILS REFLECTORIZED ON BOTH FACES. STRIPES SHALL BE PROPERLY SLOPED DOWN TOWARD THE TRAFFIC SIDE OR AS SHOWN IN THE ROAD CLOSURE BARRICADE DETAIL D FOR FULL ROAD CLOSURES.

TYPE "A" LOW-INTENSITY FLASHING WARNING LIGHTS SHALL BE VISIBLE ON BOTH SIDES OF THE BARRICADE.

THE R11-2, R11-3 AND R11-4 SIGNS PLACED ON BARRICADES SHALL COVER NO MORE THAN THE TOP RAIL. THE SIGNS SHALL NOT COVER ANY PORTION OF THE MIDDLE OR BOTTOM RAILS.

ALL SIGNS SHALL BE 48" X 48" UNLESS OTHERWISE NOTED BELOW:

R11-2 SHALL BE 48" X 30".

R11-4 AND R11-3 SHALL BE 60" X 30".

\*OMIT THE "ROAD CLOSED 500 FT." SIGN IF THE LAST INTERSECTION IS 500 FT. OR LESS FROM THE WORK ZONE.

\*\*500' MAX. OR AT LAST INTERSECTION WHICHEVER IS CLOSER.


**LEGEND**

- ⊙ SIGN ON PERMANENT SUPPORT
- TYPE III BARRICADE
- TYPE III BARRICADE WITH ATTACHED SIGN
- (A) TYPE "A" WARNING LIGHT (FLASHING)
- ▨ WORK AREA

**BARRICADES AND SIGNS  
FOR  
SIDEROAD CLOSURES**

STATE OF WISCONSIN  
DEPARTMENT OF TRANSPORTATION

APPROVED  
7/2018 /S/ Andrew Heidtke  
DATE WORK ZONE ENGINEER  
FHWA

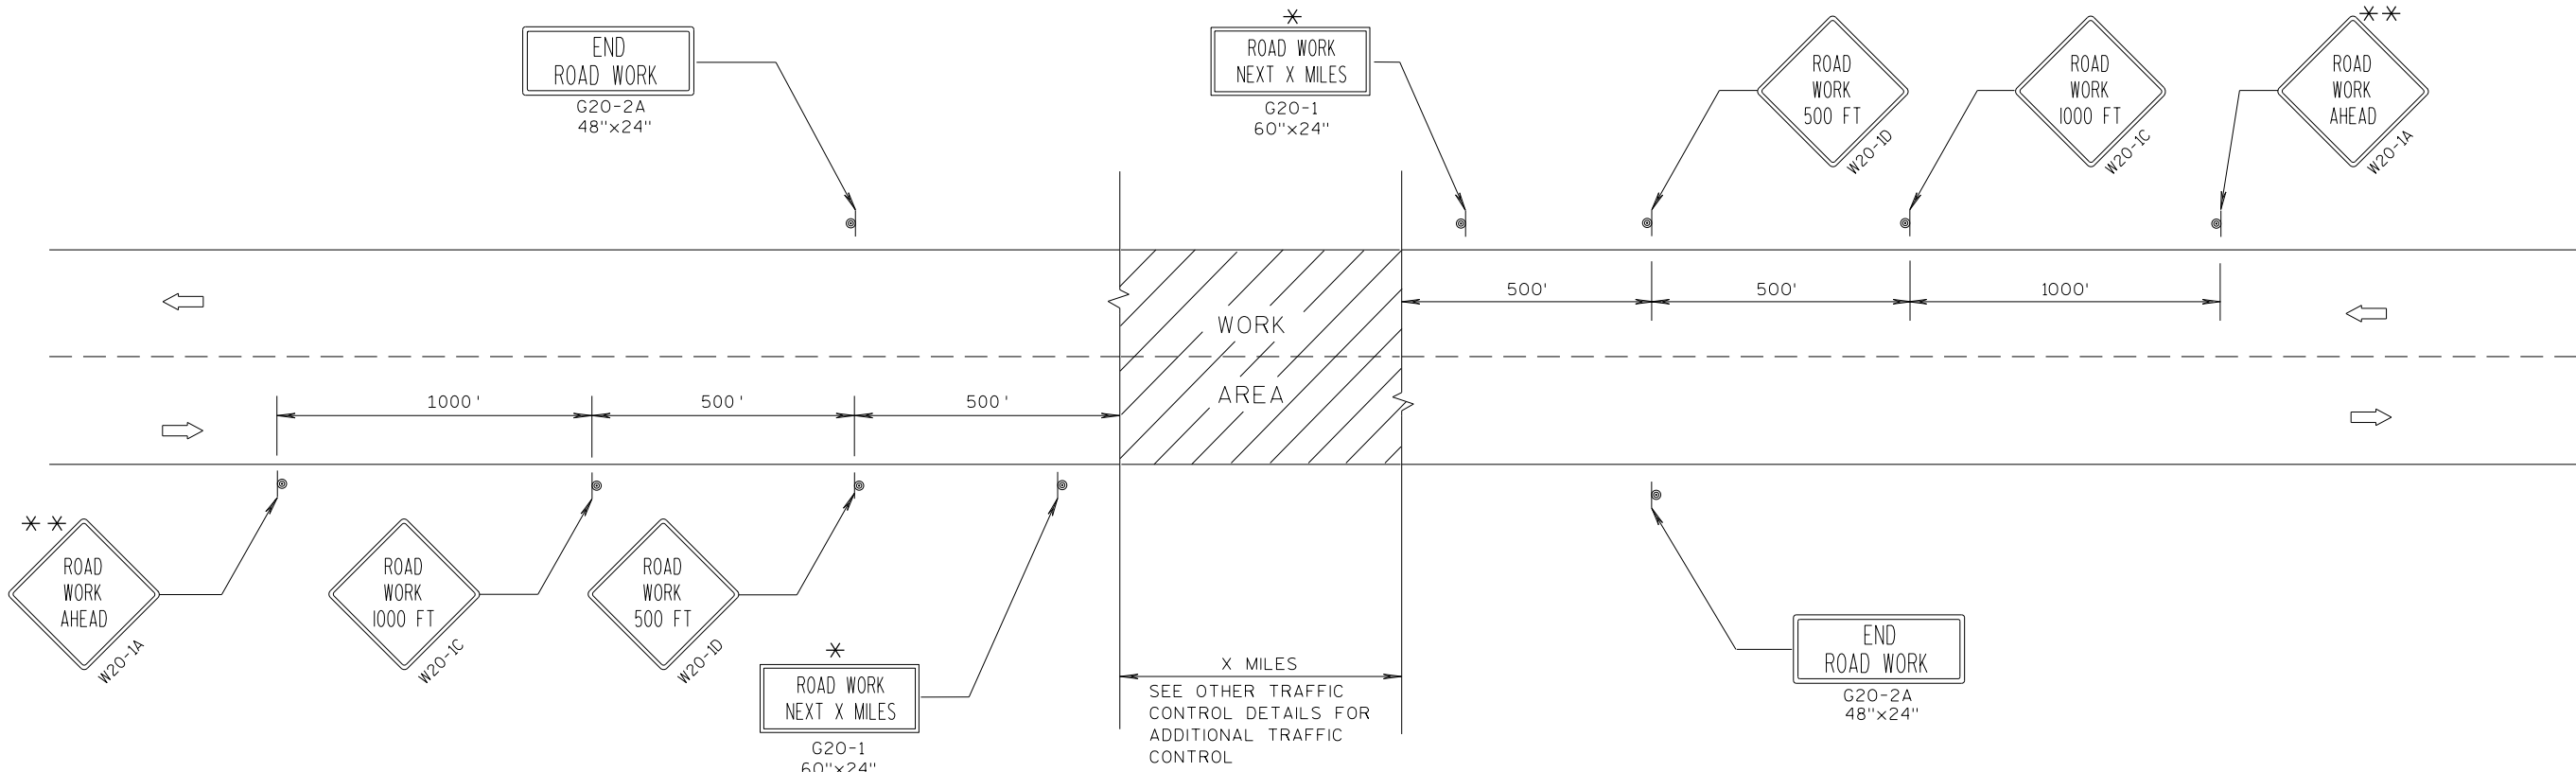

TYPICAL SIDEROAD APPROACH WARNING SIGN DETAIL

GENERAL NOTES

THE EXACT NUMBER, LOCATION, AND SPACING OF ALL SIGNS AND DEVICES SHALL BE ADJUSTED TO FIT FIELD CONDITIONS.

THE SPACING BETWEEN TRAFFIC CONTROL SIGNS SHOULD BE ADJUSTED TO NOT CONFLICT WITH AND SHOULD PROVIDE A MINIMUM OF 200 FEET (500 FEET DESIRABLE) CLEARANCE TO EXISTING SIGNS THAT WILL REMAIN IN PLACE.


ALL SIGNS ARE 48"x48" UNLESS OTHERWISE NOTED.

SIGNS THAT WILL BE IN PLACE LESS THAN 7 CONTINUOUS DAYS AND NIGHTS MAY BE MOUNTED ON PORTABLE SUPPORTS.

IF A "STOP" SIGN MUST BE REMOVED FOR A WORK OPERATION, A TEMPORARY "STOP" SIGN SHALL BE PLACED PRIOR TO THE SIGN REMOVAL, OR A FLAGGER SHALL BE PROVIDED UNTIL THE SIGN IS RE-ESTABLISHED.

\* OMIT G20-1 SIGNS IF LENGTH OF WORK AREA IS 2 MILES OR LESS.


\* \* PLACE ADDITIONAL W20-1A "ROAD WORK AHEAD" SIGN IF WORK AREA WITHIN THE PROJECT IS SEPARATED BY MORE THAN 2 MILES FROM PREVIOUS WORK AREA.

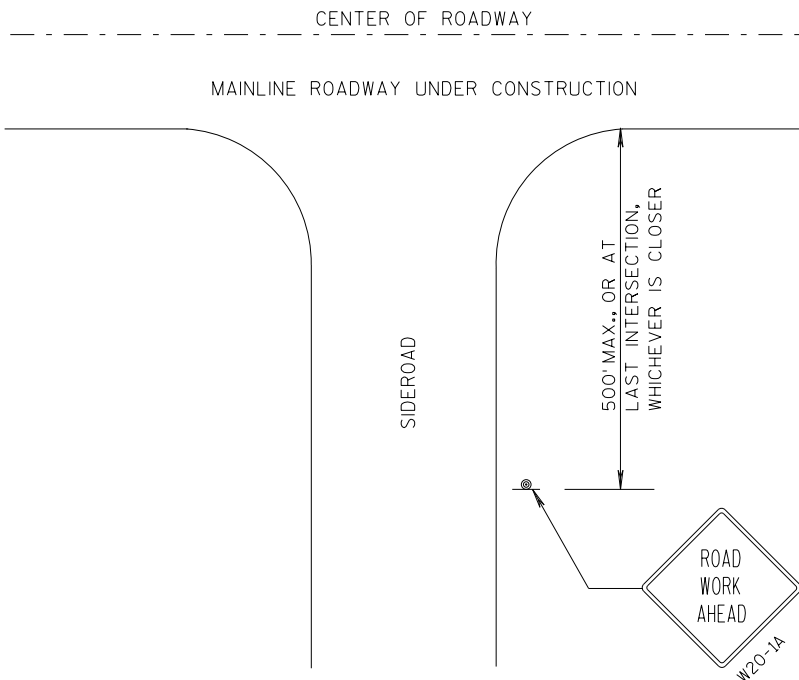


LEGEND

- ⊙ SIGN ON PERMANENT SUPPORT
- ➡ DIRECTION OF TRAFFIC
- ▨ WORK AREA

| TRAFFIC CONTROL, ADVANCE WARNING SIGNS 45 M.P.H. OR GREATER TWO-WAY UNDIVIDED ROAD OPEN TO TRAFFIC |                                          |
|----------------------------------------------------------------------------------------------------|------------------------------------------|
| STATE OF WISCONSIN<br>DEPARTMENT OF TRANSPORTATION                                                 |                                          |
| APPROVED<br>7/2018<br>DATE                                                                         | /S/ Andrew Heidtke<br>WORK ZONE ENGINEER |
| FHWA                                                                                               |                                          |

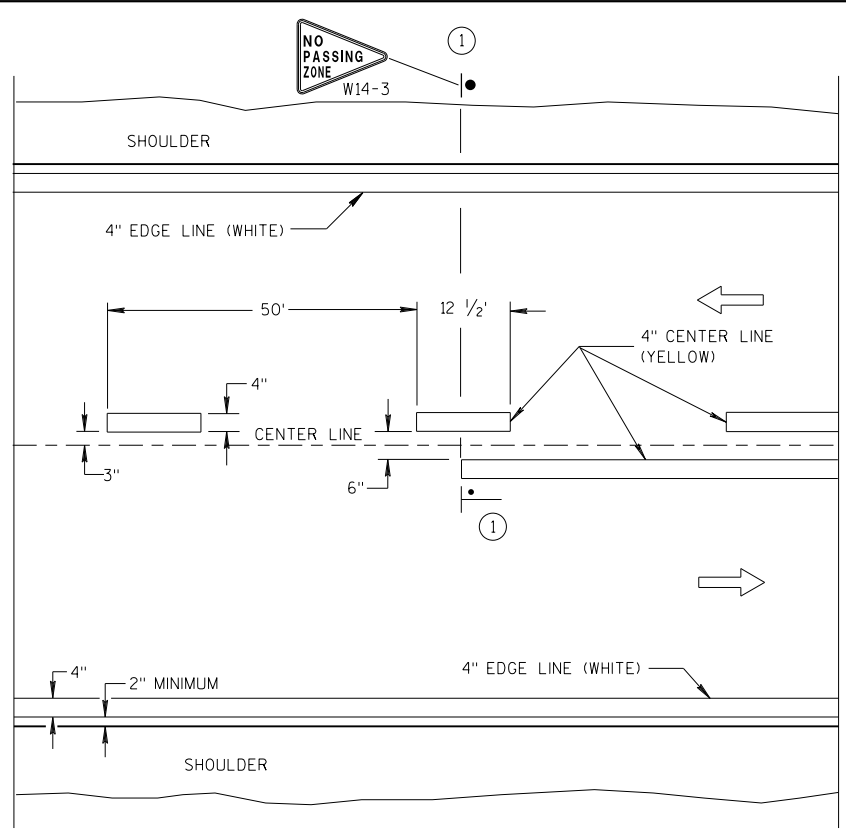


TWO WAY TRAFFIC

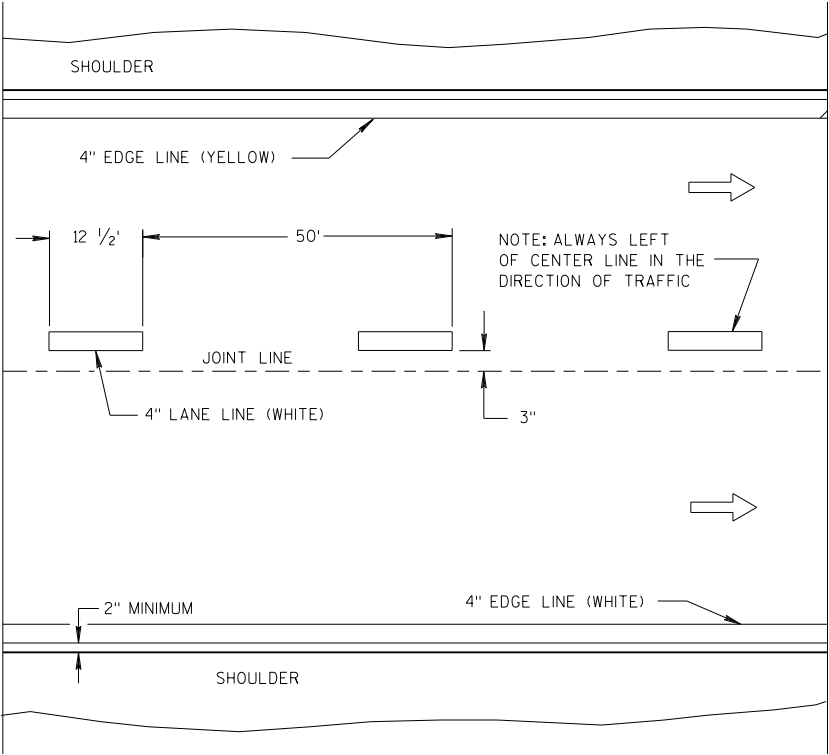


ONE WAY TRAFFIC

PERMANENT PAVEMENT MARKING

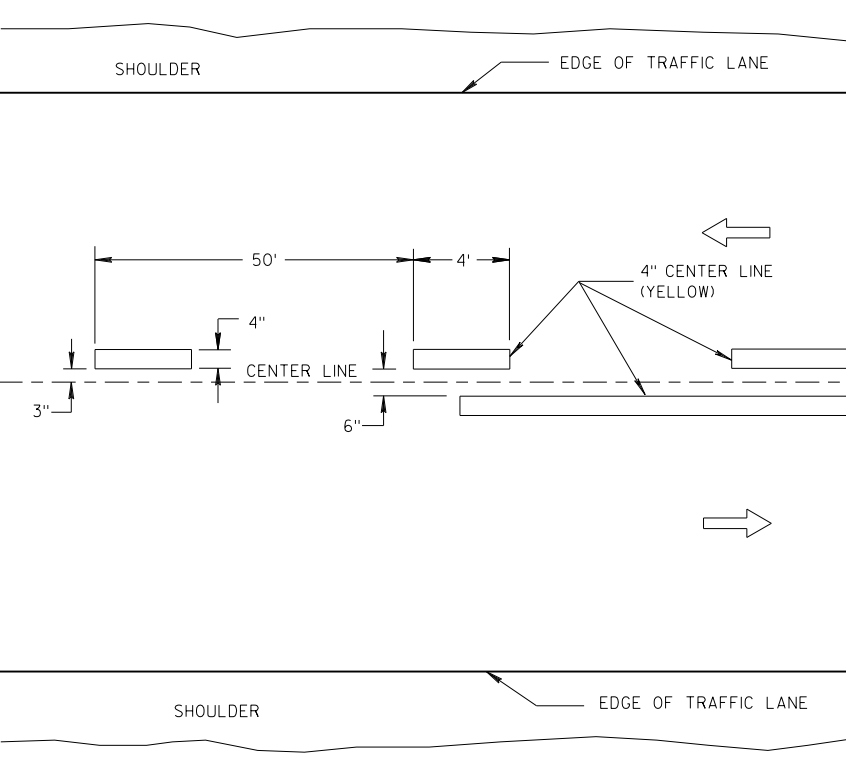

TWO WAY TRAFFIC

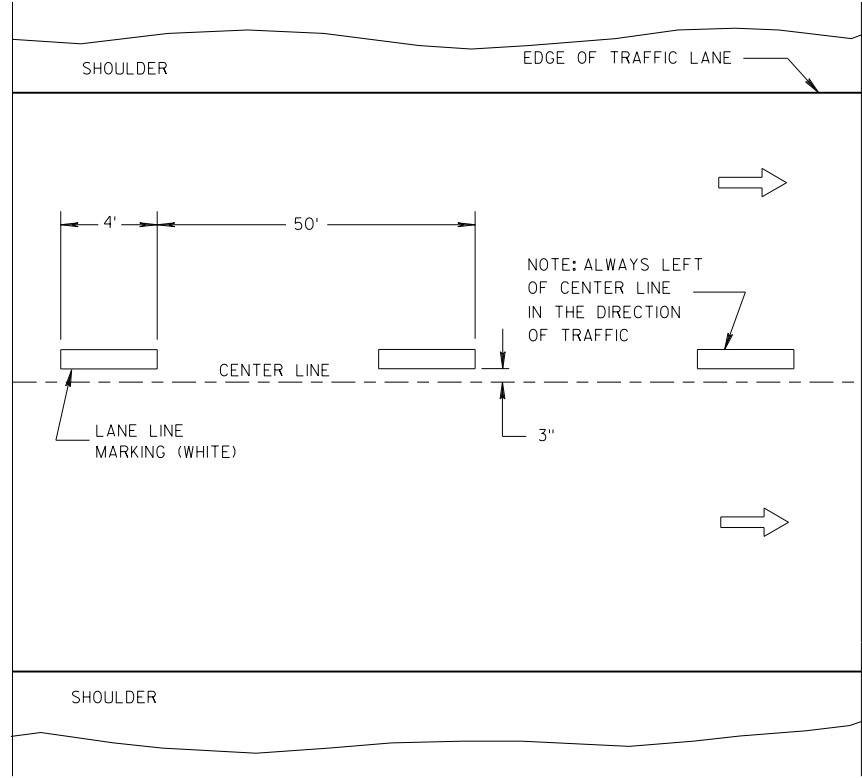

ONE WAY TRAFFIC

TEMPORARY PAVEMENT MARKING

GENERAL NOTES

DETAILS OF CONSTRUCTION NOT SHOWN ON THIS DRAWING SHALL CONFORM TO STANDARD SPECIFICATIONS AND SPECIAL PROVISIONS.

① LOCATE THE NO PASSING ZONE W14-3 SIGN WITHIN 50 FEET OF THE "T" MARKING.

NOTE

ARROW SYMBOL (➡) SHOWS DIRECTION OF TRAVEL


LEGEND

- "T" MARKING
- POST MOUNTED SIGN


LONGITUDINAL MARKING (MAINLINE)

STATE OF WISCONSIN  
DEPARTMENT OF TRANSPORTATION

APPROVED  
7/2018 /S/ Matthew R. Rauch  
DATE STATE SIGNING AND MARKING ENGINEER  
FHWA

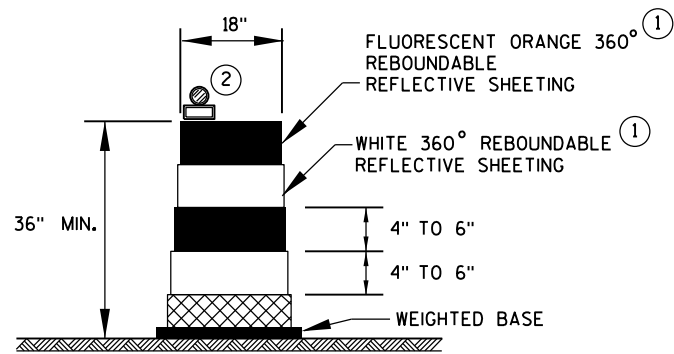

**DRUM**

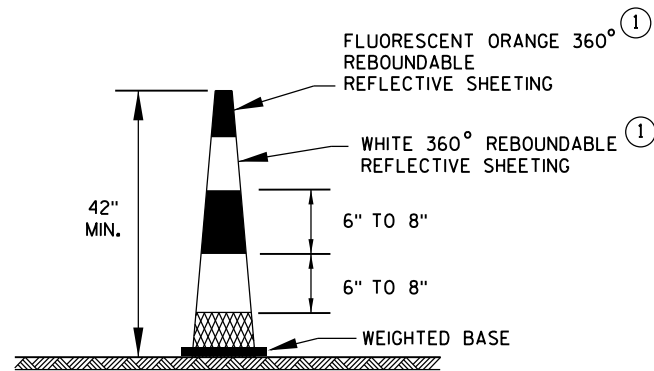


**42" CONE**

DO NOT USE IN TAPERS  
1/2 SPACING OF DRUMS


**GENERAL NOTES**

- ① REFLECTIVE SHEETING SHALL FOLLOW THE REQUIREMENTS IN THE APPROVED PRODUCTS LISTING FOR SIGN SHEETING.
- ② LOCATION OF WARNING LIGHTS WHEN SHOWN ON THE PLAN.

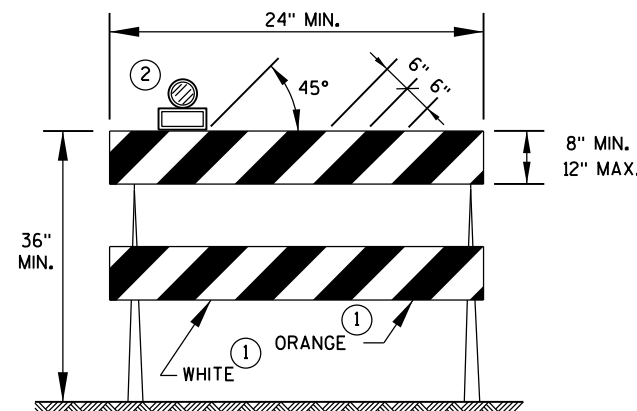


**TYPE 2 BARRICADE**

FOR RAILS LESS THAN 36" LONG, 4" WIDE STRIPES MAY BE USED.  
ALL STRIPES SHALL SLOPE DOWNWARD TO THE TRAFFIC SIDE FOR CHANNELIZATION.

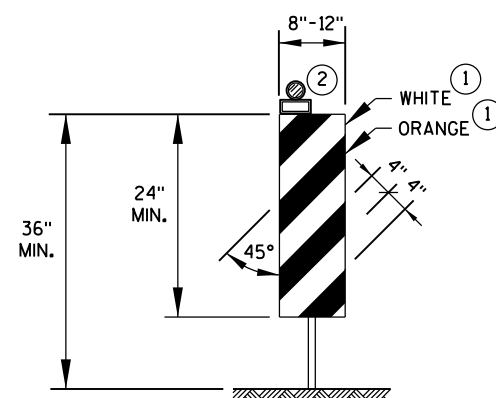

**VERTICAL PANEL**

THE STRIPES SHALL SLOPE DOWNWARD TO THE TRAFFIC SIDE FOR CHANNELIZATION.

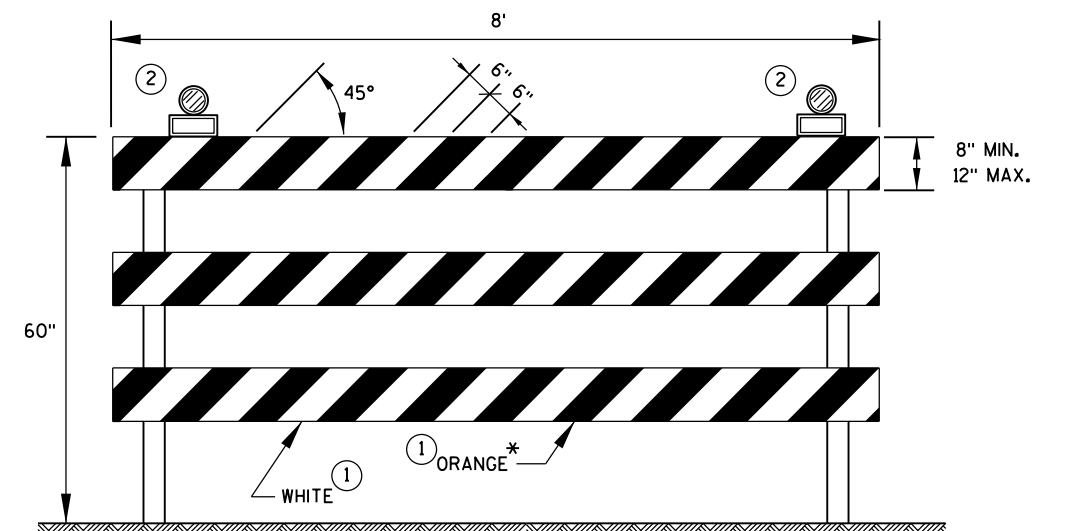

**TYPE 3 BARRICADE**

IF SIGN MOUNTED, DO NOT COVER MORE THAN 50% OF THE TOP TWO RAILS OR 33% OF THE TOTAL AREA OF THE THREE RAILS.

\* IF USED FOR A PERMANENT APPLICATION, USE RED SHEETING.

CHANNELIZING DEVICES  
DRUMS, CONES, BARRICADES  
AND VERTICAL PANELS

STATE OF WISCONSIN  
DEPARTMENT OF TRANSPORTATION

APPROVED  
June 2017 /S/ Andrew Heidtke  
DATE WORK ZONE ENGINEER  
FHWA

LEGEND



- SIGN ON PORTABLE OR PERMANENT SUPPORT
- DIRECTION OF TRAFFIC
- WORK AREA
- FLAGGER, EQUIPPED WITH STOP/SLOW PADDLE FASTENED ON SUPPORT STAFF

SIGN AND TEMPORARY RUMBLE STRIP ARRAY SPACING TABLE

| SPEED LIMIT | SPACING A |
|-------------|-----------|
| 25-35 MPH   | 200'      |
| 35-40 MPH   | 350'      |
| 45-55 MPH   | 500'      |



USE OF THE "BE PREPARED TO STOP" SIGN IS OPTIONAL. WHEN USED, THIS SIGN SHALL BE LOCATED BETWEEN THE W20-7A AND W20-4A SIGNS, USING SPACING A.

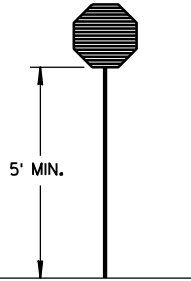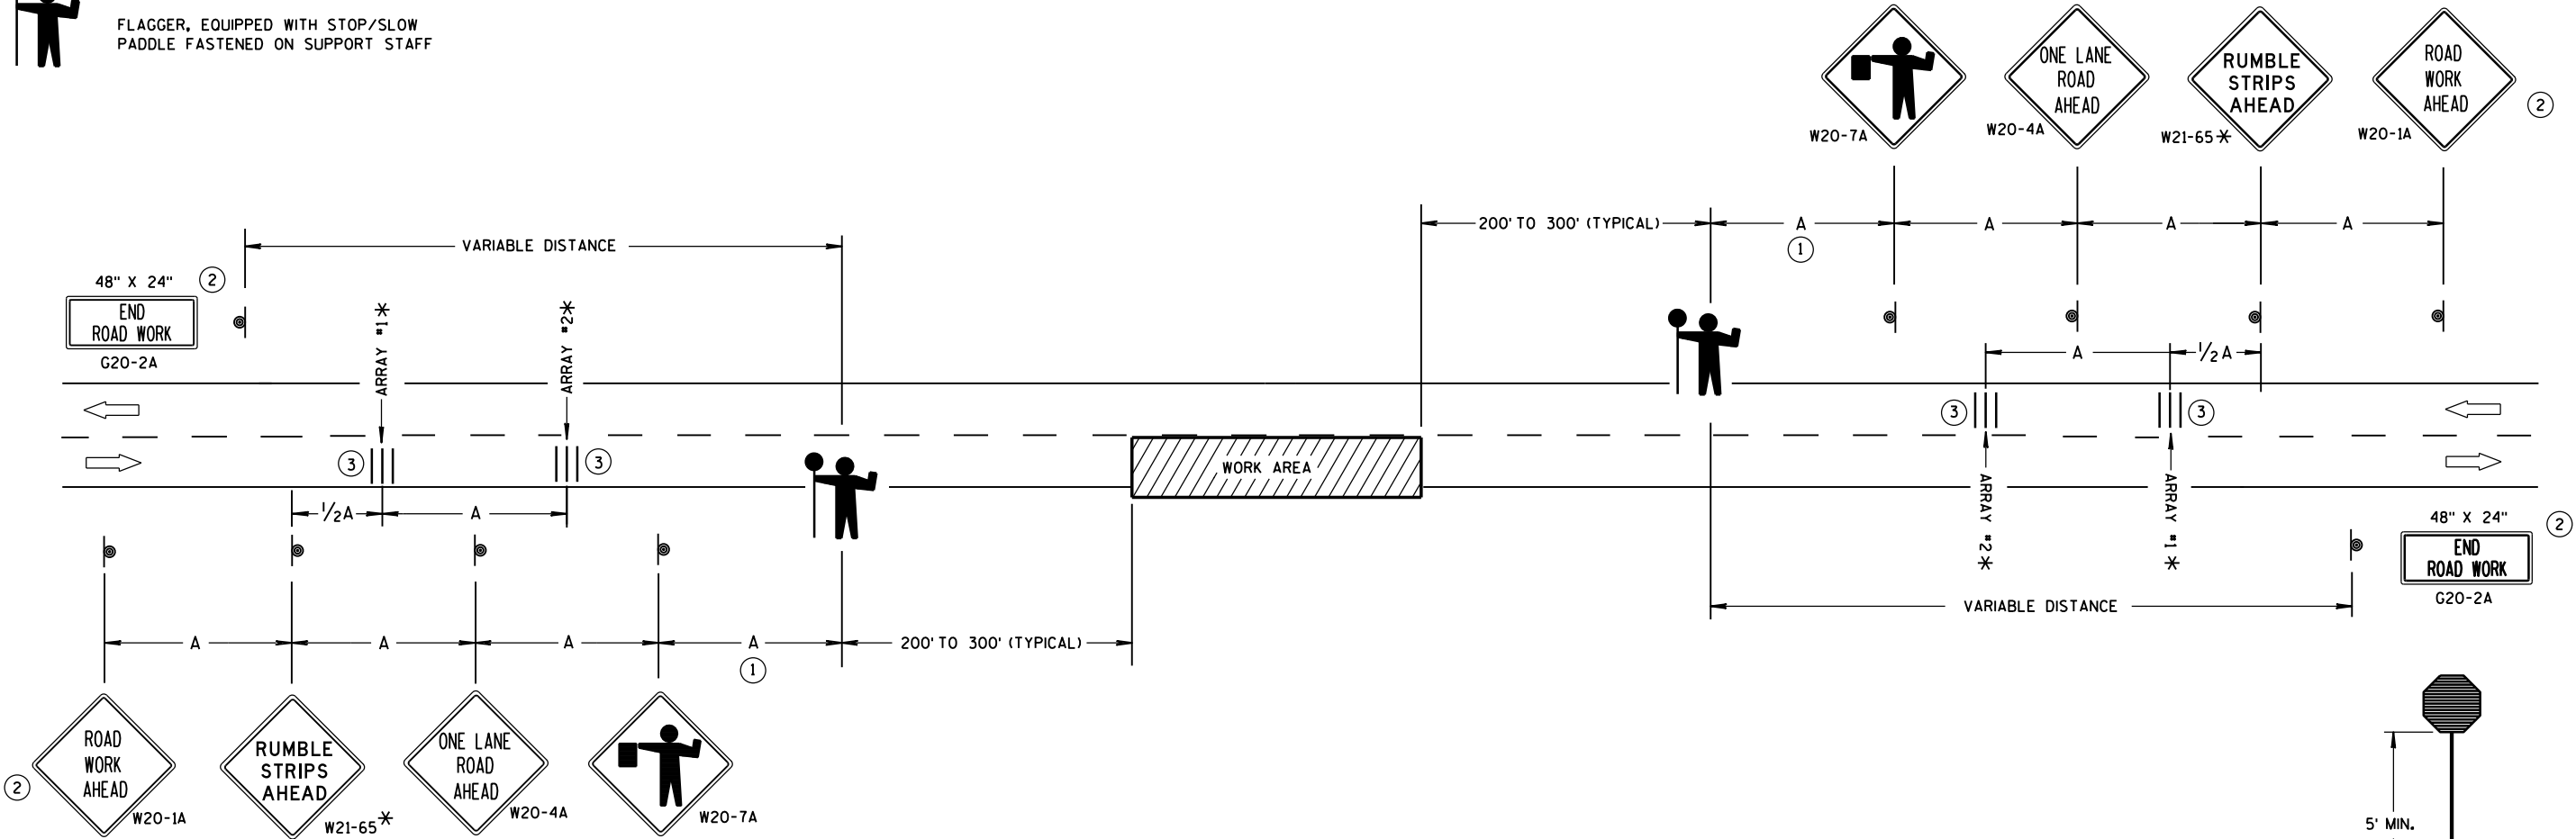

STOP/SLOW PADDLE ON SUPPORT STAFF

TRAFFIC CONTROL FOR LANE CLOSURE WITH FLAGGING OPERATION

GENERAL NOTES

DETAILS OF TRAFFIC CONTROL DEVICES AND INSTALLATION NOT SHOWN ON THIS DRAWING SHALL CONFORM TO THE PERTINENT REQUIREMENTS OF THE STANDARD SPECIFICATIONS, THE SPECIAL PROVISIONS, AND THE MANUAL ON UNIFORM TRAFFIC CONTROL DEVICES.

THE EXACT NUMBER, LOCATION AND SPACING OF ALL SIGNS AND DEVICES (AND THE LOCATION OF ALL FLAGGERS) SHALL BE ADJUSTED TO FIT FIELD CONDITIONS AS APPROVED BY THE ENGINEER.

THE FIRST ADVANCE WARNING SIGN SHOULD TYPICALLY BE LOCATED IN ADVANCE OF THE ANTICIPATED TRAFFIC BACKUP OR QUEUE.

"W0" SIGNS ARE THE SAME AS "W" SIGNS EXCEPT THE BACKGROUND IS ORANGE.

WHEN A SIDE ROAD OR RAMP INTERSECTS THE FACILITY ON WHICH THE WORK IS BEING PERFORMED, ADDITIONAL TRAFFIC CONTROLS SHALL BE PROVIDED AS SPECIFIED IN THE PLANS AND/OR THE SPECIAL PROVISIONS OR AS APPROVED BY THE ENGINEER.

INSTALL TEMPORARY RUMBLE STRIPS PER MANUFACTURER'S RECOMMENDATIONS. PLACE ADVANCE SIGNING PRIOR TO INSTALLING TEMPORARY RUMBLE STRIPS.

ALL SIGNS ARE 48" X 48" UNLESS OTHERWISE NOTED.


FLAGGERS SHALL BE IN SIGHT OF EACH OTHER OR IN DIRECT COMMUNICATION AT ALL TIMES. THEY SHALL BE EQUIPPED WITH STOP/SLOW PADDLES FASTENED ON SUPPORT STAFFS. WHEN THE FLAGGING OPERATION IS NOT IN EFFECT, REMOVE TEMPORARY RUMBLE STRIPS PRIOR TO COVERING OR REMOVING ALL ADVANCE SIGNING.

- \* UTILIZE TEMPORARY RUMBLE STRIPS WHEN FLAGGING OPERATION IS ANTICIPATED TO BE STATIONARY IN EXCESS OF TWO HOURS.
- ① FOR A MOVING WORK OPERATION, SIGNING AND TEMPORARY RUMBLE STRIPS (IF USED) SHALL BE REESTABLISHED (AS SIMULTANEOUSLY AS PRACTICAL) AT APPROXIMATELY 3,500 FOOT INTERVALS IN THE MOVING WORK OPERATION OR AS APPROVED BY THE ENGINEER.
- ② SIGN NOT REQUIRED IF FLAGGING OPERATION OCCURS WITHIN A SIGNED ROAD WORK ZONE AREA.
- ③ EACH TEMPORARY RUMBLE STRIP ARRAY CONSISTS OF THREE RUMBLE STRIPS SPACED ACCORDING TO MANUFACTURER'S RECOMMENDATION, PLACED TRANSVERSE ACROSS THE LANE AT LOCATIONS SHOWN.

TRAFFIC CONTROL FOR LANE CLOSURE WITH FLAGGING OPERATION

STATE OF WISCONSIN  
DEPARTMENT OF TRANSPORTATION


APPROVED  
June 2017 /S/ Andrew Heldtke  
DATE WORK ZONE ENGINEER  
FHWA

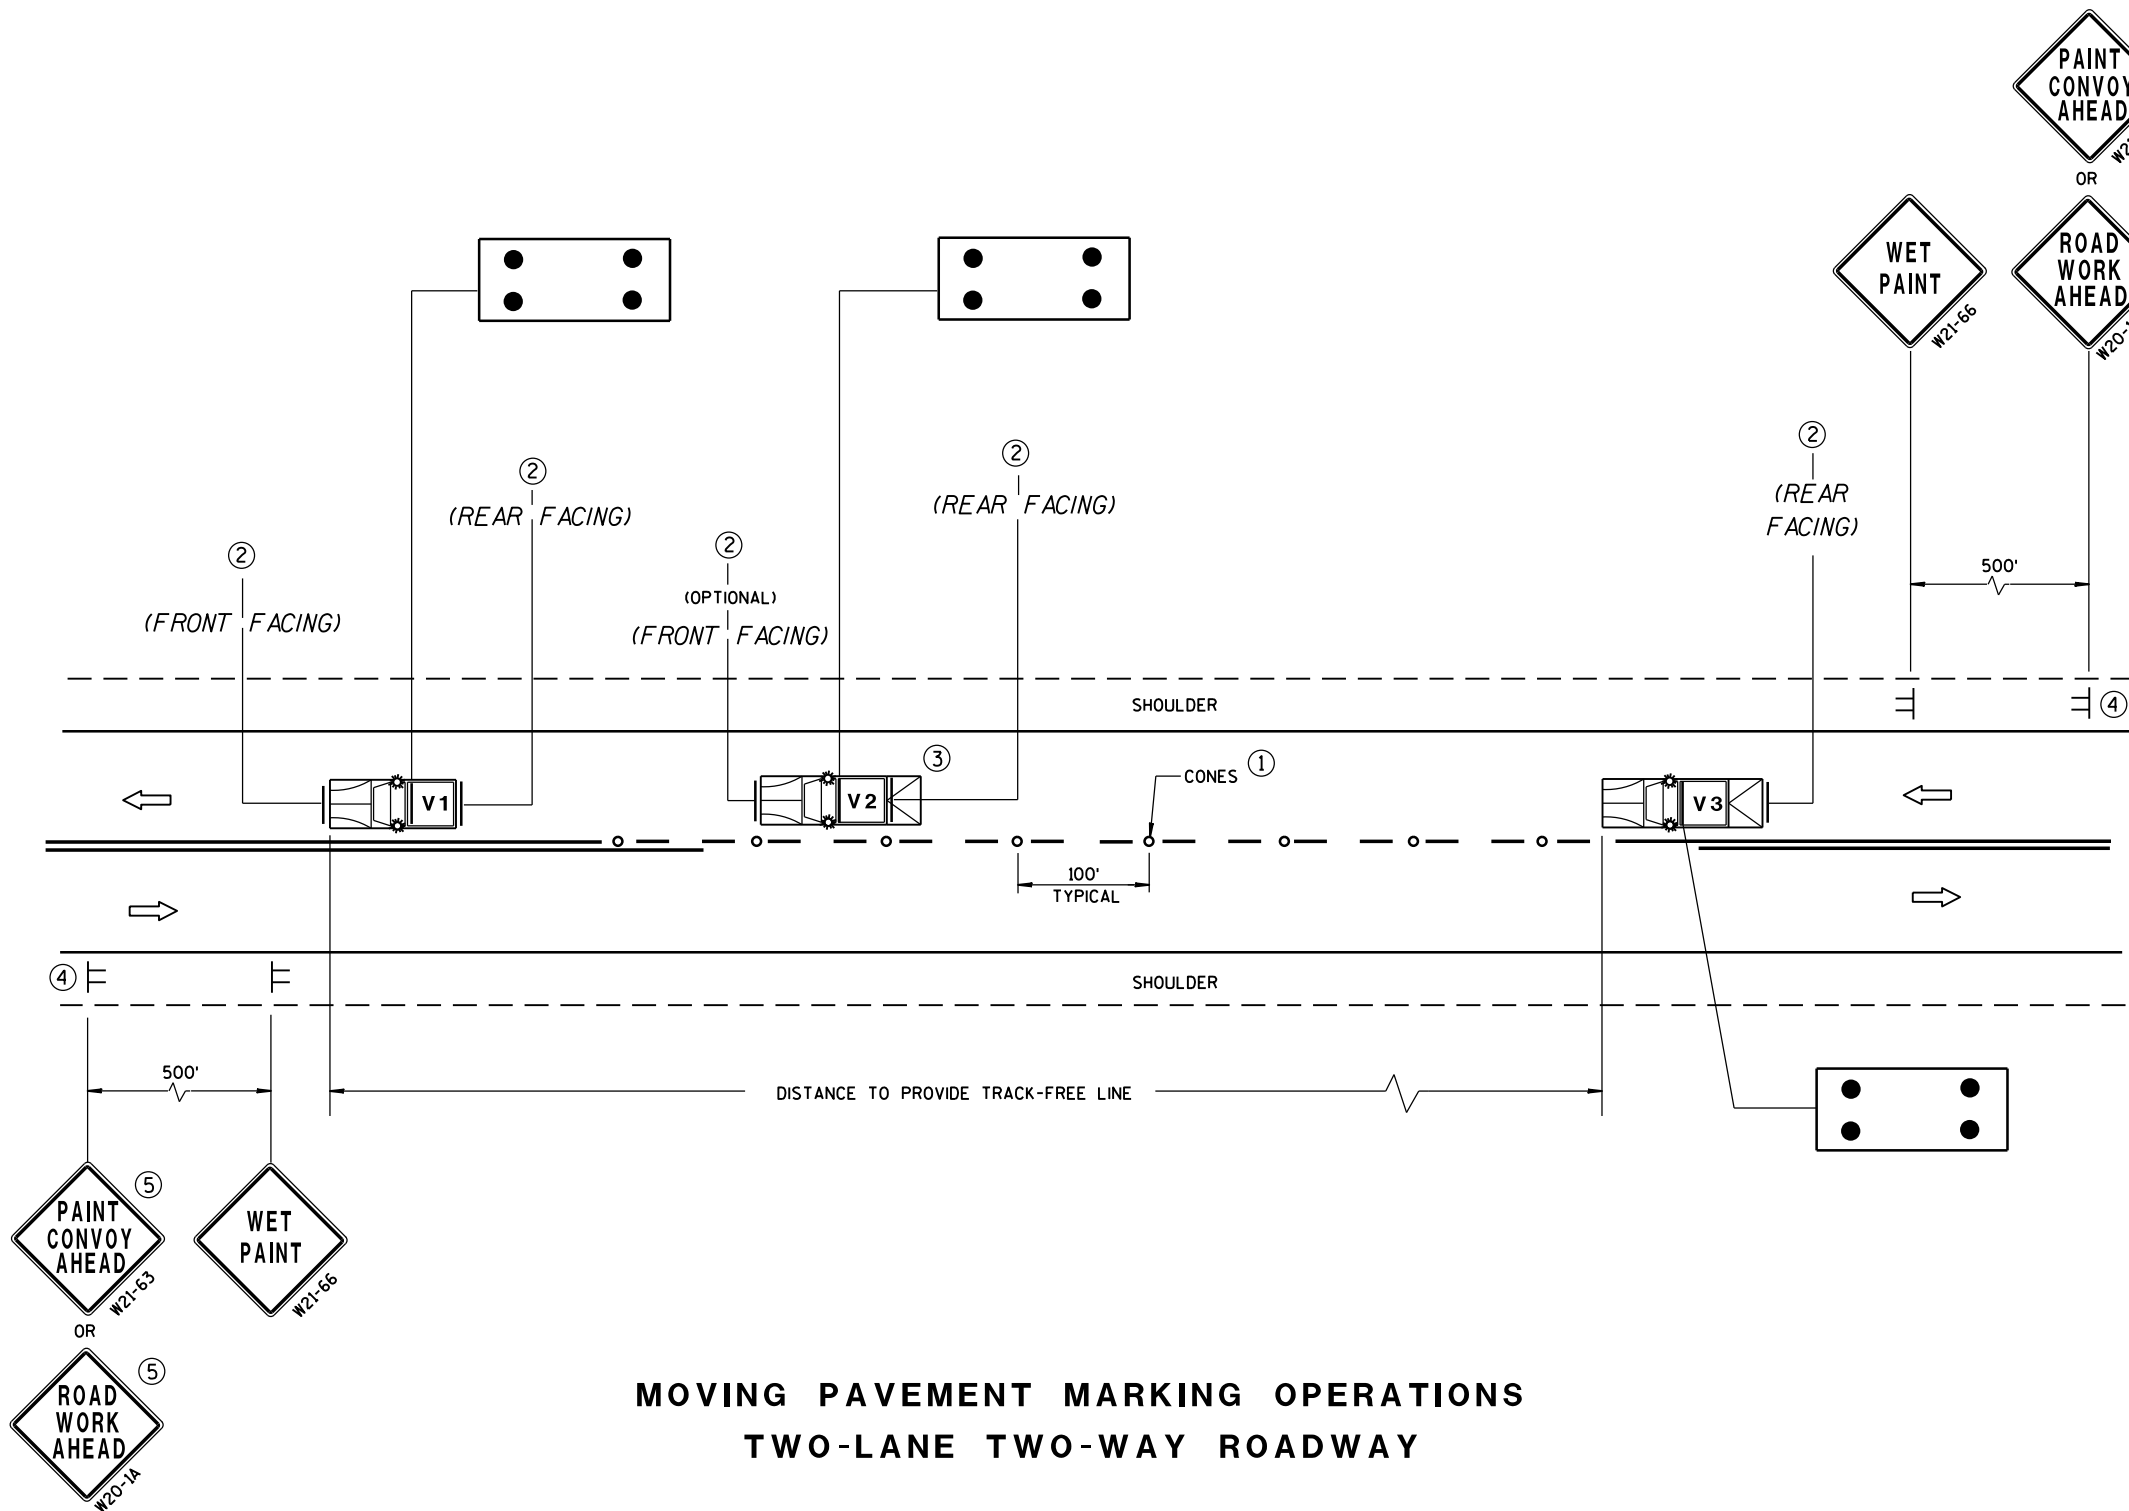

MOVING PAVEMENT MARKING OPERATIONS  
TWO-LANE TWO-WAY ROADWAY

GENERAL NOTES

 - ALL VEHICLES SHALL BE EQUIPPED WITH TWO 360 DEGREE HIGH INTENSITY YELLOW FLASHING LIGHTS OR STROBE LIGHTS AND OPERATED WITH HEADLIGHTS TURNED ON.
- VEHICLES SHALL BE EQUIPPED WITH REAR FACING TYPE B OR C FLASHING ARROW PANEL OPERATING IN CAUTION MODE. SIGNS PLACED ON VEHICLES MUST NOT OBSCURE THE ARROW PANEL.
- ALL SIGNS ARE 48" X 48" UNLESS OTHERWISE SPECIFIED.
- IF SPEED LIMIT IS 40 MPH OR LESS STATIONARY SIGNS MAY BE OMITTED IF CONES ARE USED.
- ALTERNATE SIGN MESSAGES, SUCH AS "PAINT CREW AHEAD" OR "ROAD PAINTING AHEAD" MAY BE USED.
- DISTANCE BETWEEN VEHICLES MAY VARY ACCORDING TO TERRAIN, SIGHT DISTANCE, PAINT DRYING TIME, AND OTHER FACTORS. WHENEVER ADEQUATE STOPPING SIGHT DISTANCE EXISTS TO THE REAR, SHADOW VEHICLES SHOULD MAINTAIN THE MINIMUM DISTANCE FROM THE WORK VEHICLE AND PROCEED AT THE SAME SPEED AS THE WORK VEHICLE. SHADOW VEHICLES SHOULD SLOW DOWN IN ADVANCE OF VERTICAL OR HORIZONTAL CURVES THAT RESTRICT SIGHT DISTANCE.
- THE WORK AND SHADOW VEHICLES SHOULD PULL OVER PERIODICALLY TO ALLOW TRAFFIC TO PASS.
- THIS DRAWING SHALL BE USED FOR CENTERLINE OR EDGELINE MARKING.
- WHEN NO WORK ACTIVITY IS TAKING PLACE, REMOVE OR TURN THE STATIONARY WARNING SIGNS AWAY FROM TRAFFIC.
- ① CONES MAY BE OMITTED ON PAINTED LINE IF APPROVED BY THE ENGINEER. CONSIDER PAVEMENT MARKING DRY OR CURE TIMES AND TRAFFIC VOLUME.
- ② USE STANDARD SIGN W21-64 WITH APPROPRIATE ARROW.
- ③ OPTIONAL TRUCK-MOUNTED ATTENUATOR.
- ④ SIGNS SHALL BE REPEATED APPROXIMATELY EVERY THREE MILES.
- ⑤ IF CONSTRUCTION WORK ZONE SIGNS ARE IN PLACE, W20-1 OR W21-63 ARE NOT REQUIRED.




LEGEND

- V1** LEAD VEHICLE
- V2** SHADOW VEHICLE
- V3** TRAIL VEHICLE WITH TMA
- TMA** TRUCK-MOUNTED ATTENUATOR
- SIGN ON TEMPORARY SUPPORT
- DIRECTION OF TRAFFIC
- CONES
- FLASHING ARROW PANEL (CAUTION)

MOVING PAVEMENT MARKING  
OPERATION  
TWO-LANE TWO-WAY ROADWAY

STATE OF WISCONSIN  
DEPARTMENT OF TRANSPORTATION

APPROVED  
Sept., 2017 /S/ Andrew Heidtke  
DATE WORK ZONE ENGINEER  
FHWA


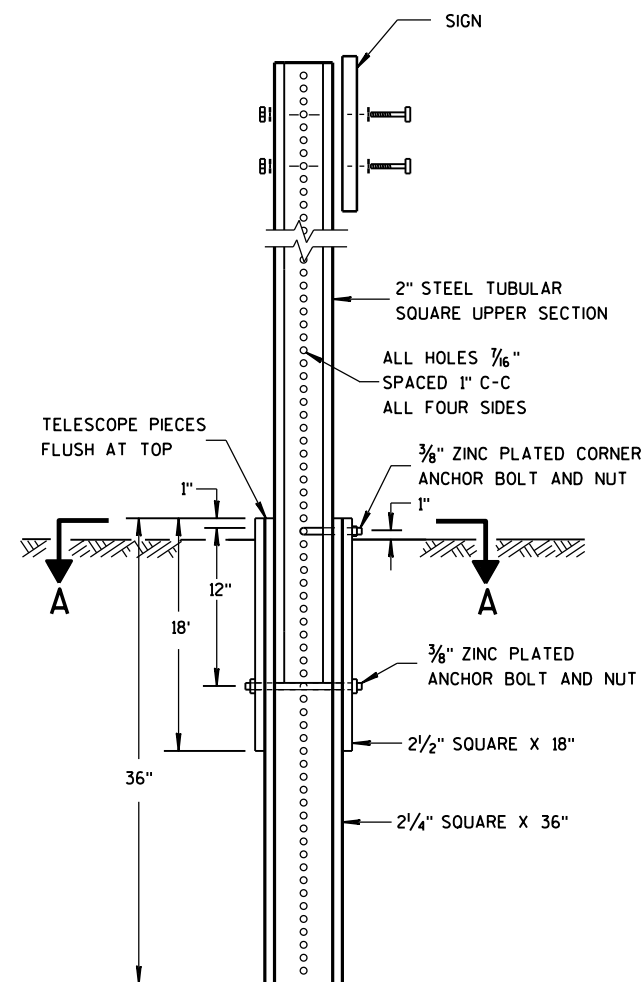


DETAIL OF TUBULAR  
STEEL SIGN POST

TUBULAR STEEL POSTS

| AREA OF SIGN<br>INSTALLATION<br>(SQ. FT.)      | NUMBER OF<br>REQUIRED TUBULAR<br>STEEL POSTS |
|------------------------------------------------|----------------------------------------------|
| 9 OR LESS                                      | 1                                            |
| GREATER THAN 9<br>LESS THAN OR EQUAL<br>TO 18  | 2                                            |
| GREATER THAN 18<br>LESS THAN OR EQUAL<br>TO 27 | 3                                            |



SIGNS WIDER THAN 3 FEET OR LARGER THAN 9 SQ. FT. SHALL  
BE MOUNTED ON MULTIPLE POSTS (SEE ABOVE TABLE).  
SIGNS LARGER THAN 27 SQ. FT. SHALL NOT BE MOUNTED  
ON TUBULAR STEEL POSTS.

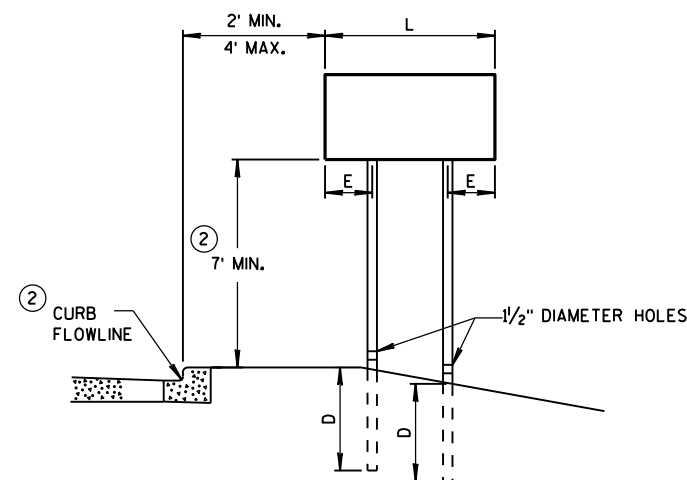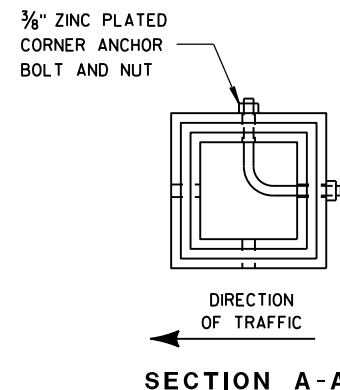

URBAN AREA

POST MOUNTING DETAIL FOR TEMPORARY TRAFFIC CONTROL FIXED MESSAGE SIGNS

| WOOD POST<br>EMBEDMENT DEPTH              |            |
|-------------------------------------------|------------|
| AREA OF SIGN<br>INSTALLATION<br>(SQ. FT.) | D<br>(MIN) |
| 20 OR LESS                                | 4'         |
| GREATER THAN 20                           | 5'         |

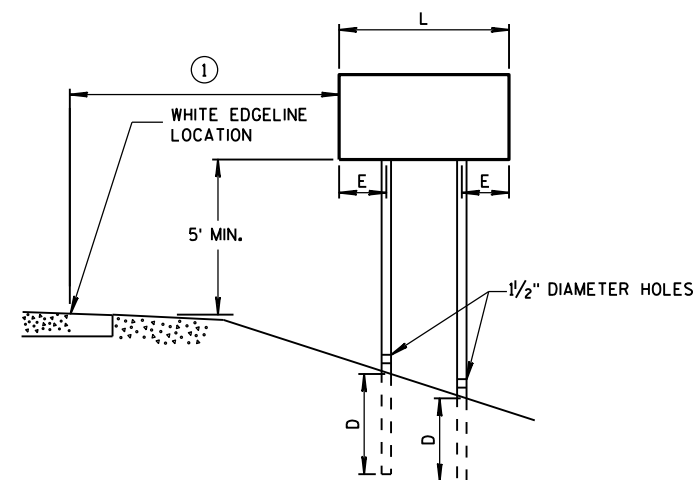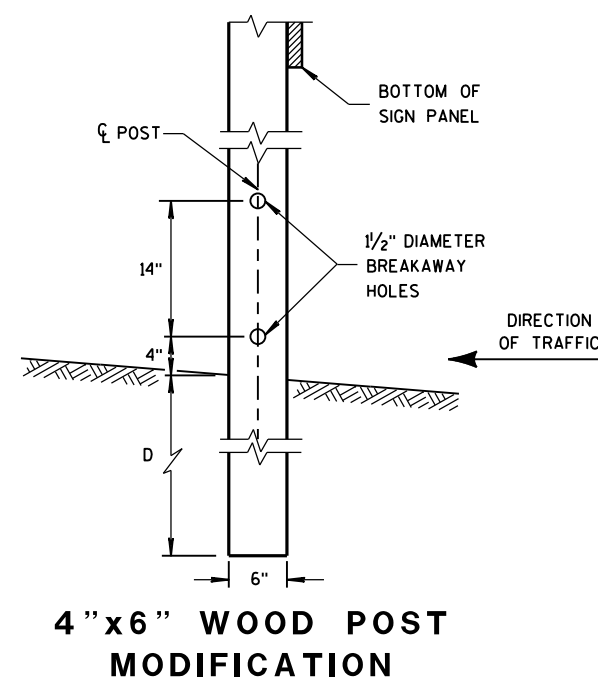

RURAL AREA

| POST SPACING REQUIREMENTS               |     | NUMBER OF<br>WOOD POSTS<br>REQUIRED |
|-----------------------------------------|-----|-------------------------------------|
| L                                       | E   |                                     |
| 48" OR LESS AND<br>LESS THAN 20 SQ. FT. | -   | 1                                   |
| LESS THAN 60"                           | 12" | 2                                   |
| 60" TO 120"                             | L/5 | 2                                   |
| GREATER THAN 120"<br>LESS THAN 168"     | 12" | 3                                   |
| 168" AND GREATER                        | 12" | 4                                   |


SEE NOTE ③

GENERAL NOTES

- ① 6 FEET FROM THE EDGE OF PAVEMENT (EDGE LINE LOCATION) UNLESS OTHERWISE DIRECTED BY THE PROJECT ENGINEER. LATERAL OFFSET SHOULD BE ADJUSTED TO AVOID THE DITCH FLOWLINE.
- ② THE EXISTENCE OF CURB AND GUTTER DOES NOT IN ITSELF MANDATE THE VERTICAL CLEARANCE ILLUSTRATED. THAT HEIGHT IS TYPICALLY MEASURED WHERE THERE IS SIDEWALK ADJACENT TO THE ROADWAY OR PARKING IS PERMITTED. IN THE ABSENCE OF SIDEWALK, VERTICAL CLEARANCE IS MEASURED FROM THE TOP OF THE CURB. IF NO SIDEWALK AND NO PARKING, VERTICAL CLEARANCE MAY BE REDUCED TO 5 FOOT MINIMUM. OFFSET OF SIGNS IS MEASURED FROM THE CURB FLOWLINE.
- ③ FOR SIGNS REQUIRING 4 POSTS, SPACE INTERMEDIATE POSTS EVENLY.

TEMPORARY TRAFFIC CONTROL  
SIGN MOUNTING

STATE OF WISCONSIN  
DEPARTMENT OF TRANSPORTATION

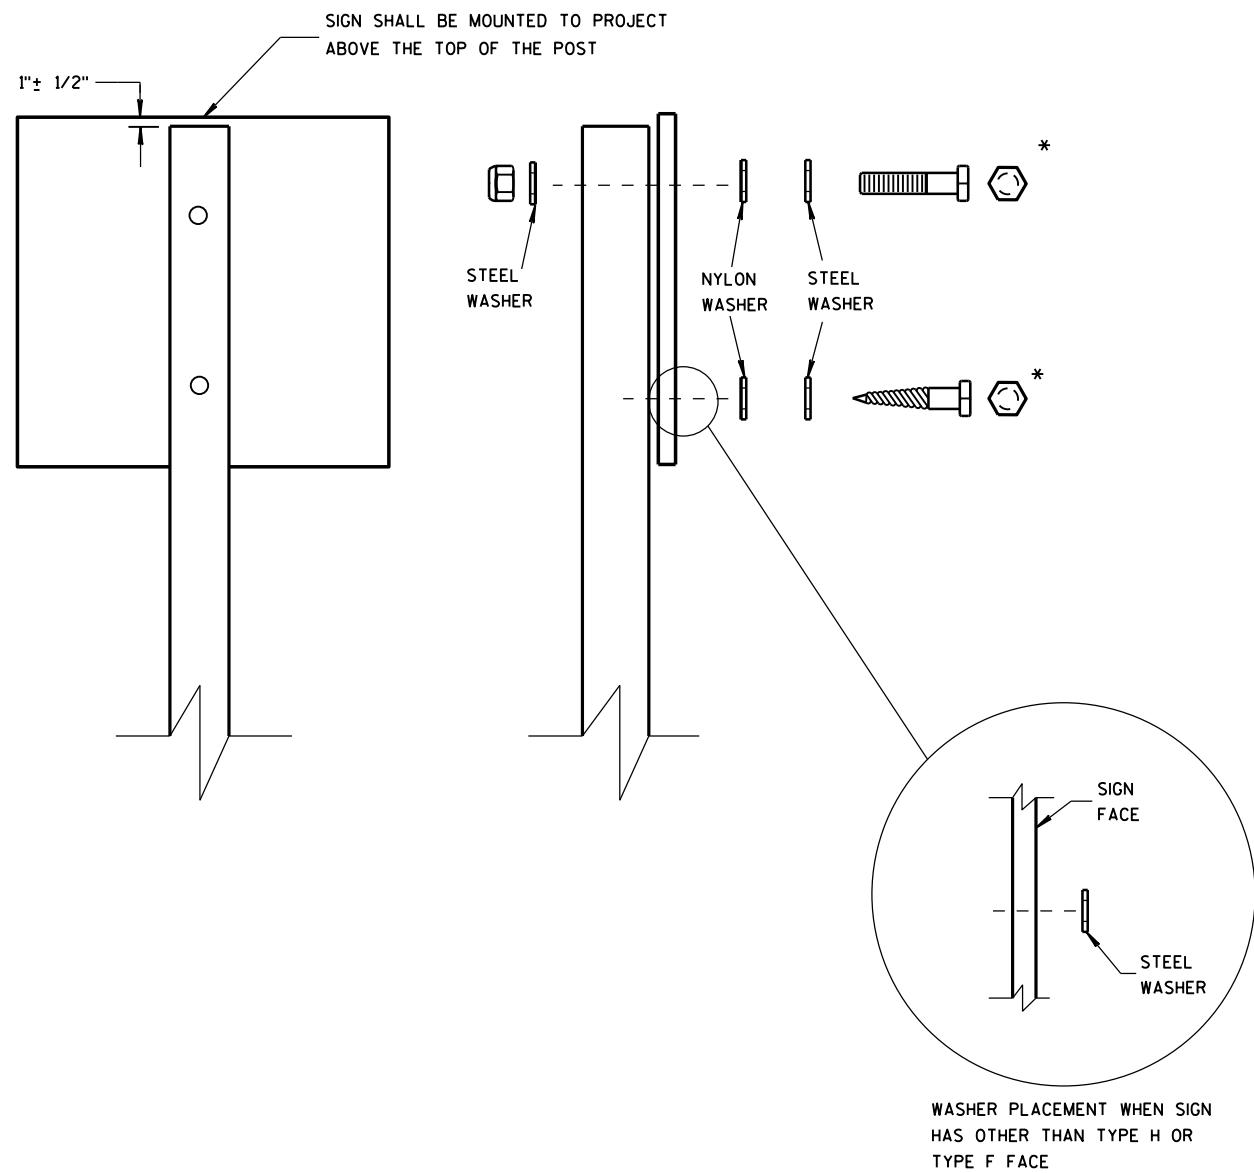

NUTS, BOLTS AND LAGS USED FOR MOUNTING SIGNS SHALL HAVE HEXAGONAL HEADS AND SHALL BE EITHER:

- A. HOT DIP GALVANIZED IN ACCORDANCE WITH ASTM DESIGNATION: A 153, CLASS D, OR SC 3
- B. ELECTRO-GALVANIZED IN ACCORDANCE WITH ASTM DESIGNATION: B 633, TYPE III, SC 3

THREADS ON BOLTS AND NUTS SHALL BE MANUFACTURED WITH SUFFICIENT ALLOWANCE FOR THE CADMIUM PLATE OR GALVANIZED COATING TO PERMIT THE NUTS TO RUN FREELY ON THE BOLTS.

- WOOD POSTS (4" x 4" or 4" x 6")
- LAG SCREWS - 3/8" X 3"
  - MACHINE BOLTS - 5/16" X 6-1/2" OR 7" LENGTH W/ NUTS


- SQUARE STEEL POSTS (2" x 2")
- MACHINE BOLTS - 3/8" X 3-1/4" LENGTH W/ NUTS
  - RIVETS - 9/32" (6605-9-6) BULB-TITE, TRI-FOLD, ALUMINUM BODY/MANDREL O.D. FLANGE .720-.765 INCH, GRIP RANGE .042-.375 INCH

- WASHERS (ALL POSTS) -
- 1-1/4" O.D. X 3/8" I.D. X 1/16" STEEL
  - 1-1/4" O.D. X 3/8" I.D. X .080 NYLON FOR ALL TYPE H SIGNS


\* TWO DIFFERENT FASTENING SYSTEMS ARE SHOWN FOR ILLUSTRATION PURPOSES. ON ANY INDIVIDUAL SIGN, EITHER ONE OR THE OTHER SYSTEM SHALL BE USED. ACTUAL NUMBER OF FASTENERS PER SIGN VARIES WITH THE SIGN AREA. FOR A SINGLE POST INSTALLATION, ALL SIGNS GREATER THAN 9 SQ. FT. REQUIRE THE USE OF 3 FASTENERS.

|                                                    |                                          |
|----------------------------------------------------|------------------------------------------|
| ATTACHMENT OF SIGNS<br>TO POSTS                    |                                          |
| STATE OF WISCONSIN<br>DEPARTMENT OF TRANSPORTATION |                                          |
| APPROVED<br>June 2017<br>DATE                      | /S/ Andrew Heldtke<br>WORK ZONE ENGINEER |
| FHWA                                               |                                          |

TYPICAL ASSEMBLIES

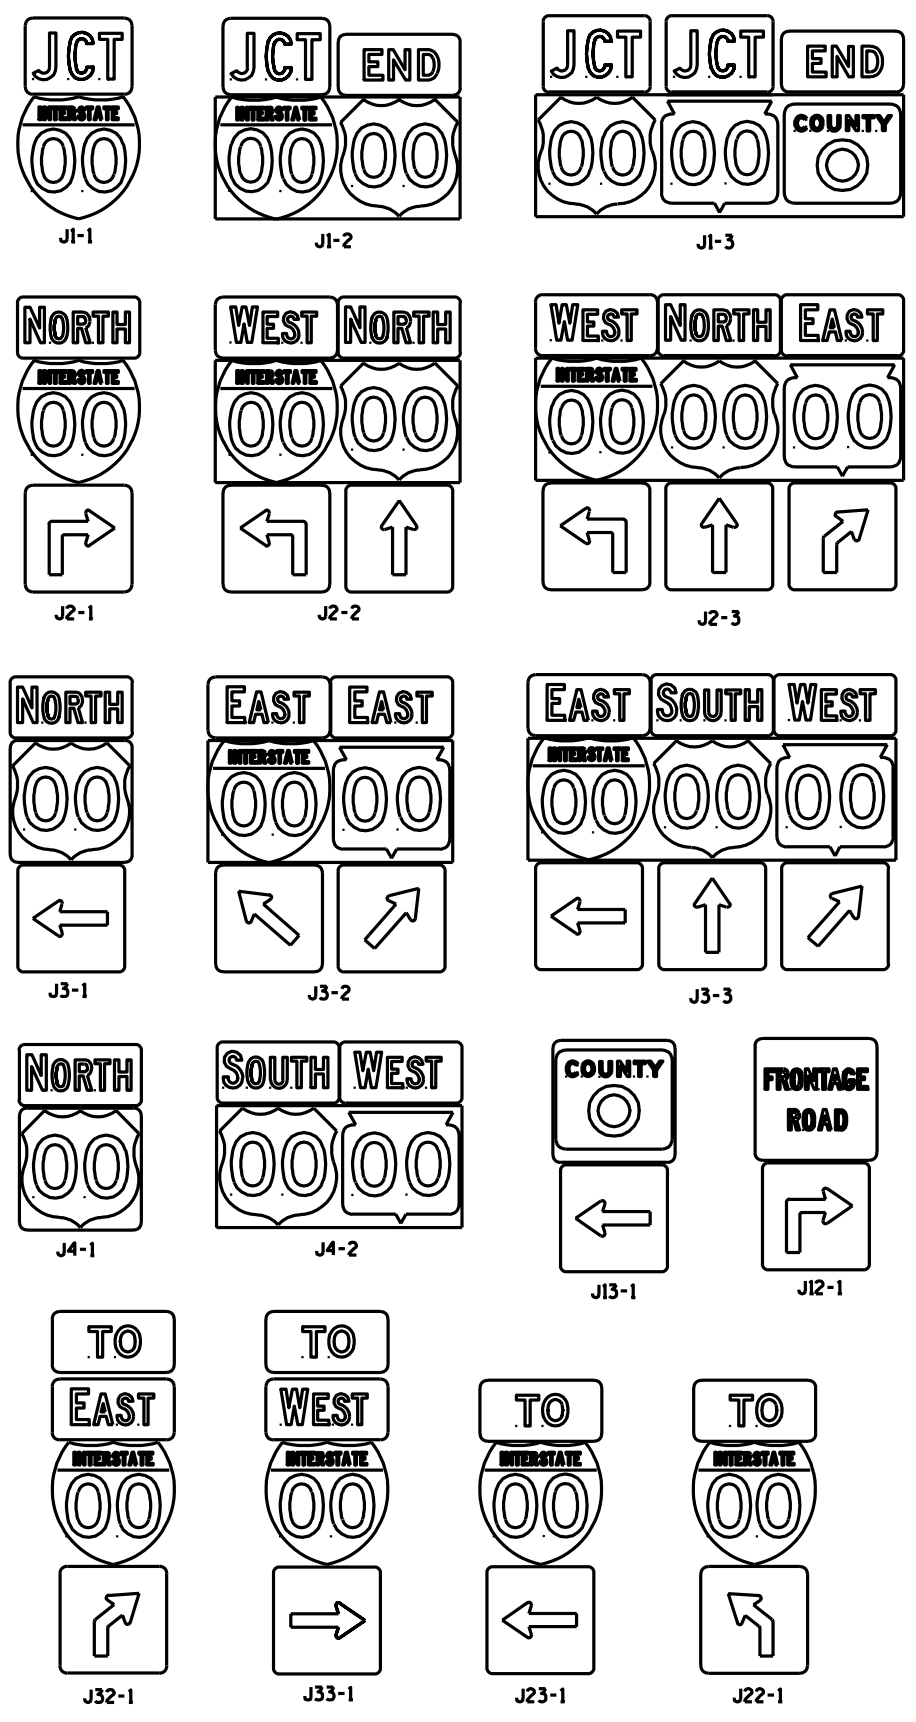



INDIVIDUAL COMPONENTS OF ASSEMBLIES

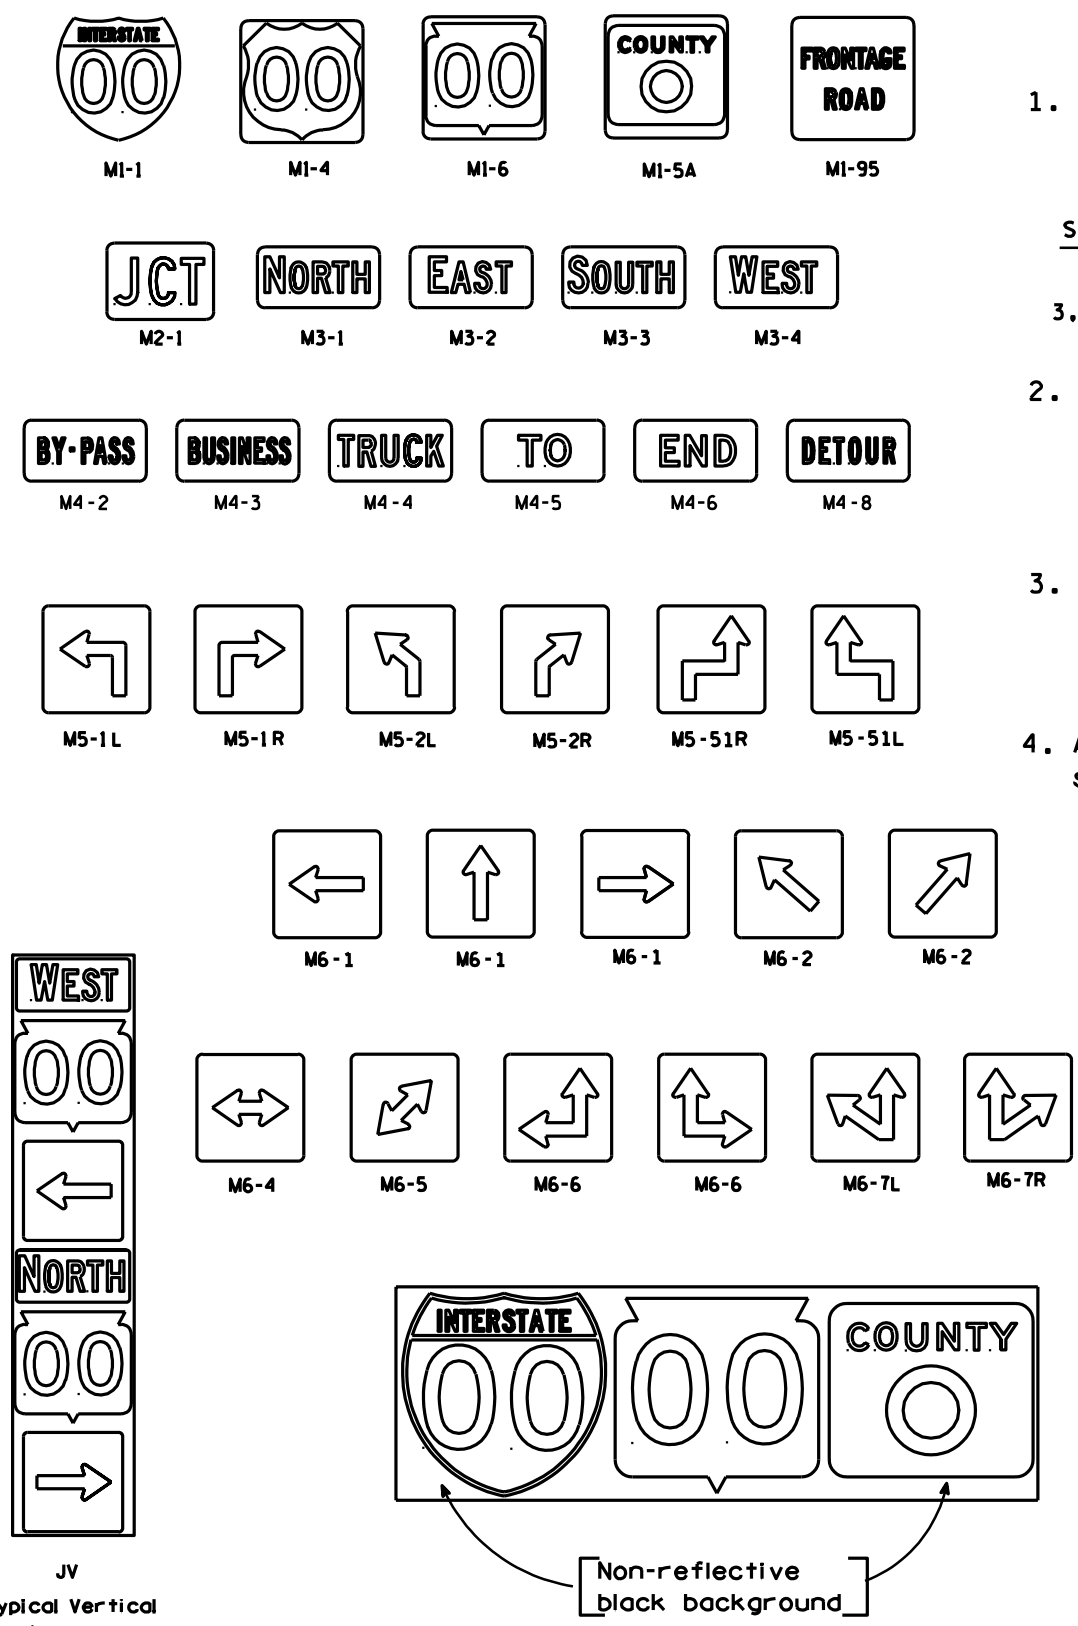

GENERAL NOTES


1. All components within any individual assembly shall be the same "size". The following table illustrates that situation:
2. For any assembly containing two or more route markers, the route markers SHALL be placed on a single high density overlay PLYWOOD panel. All other materials within the assembly can be either plywood or aluminum.
3. Certain marker heads require the component pieces to be the same color. As an example, all the components used with an M1-1 marker shall be blue.
4. All vertical J assemblies are given a sign code of JV.

| SIZE  | M1'S    | M2      | M3'S & M4'S | M5'S & M6'S |
|-------|---------|---------|-------------|-------------|
| 2     | 24 X 24 | 21 X 15 | 24 X 12     | 21 X 21     |
| 3,4-5 | 36 X 36 | 30 X 21 | 30 X 15     | 30 X 30     |

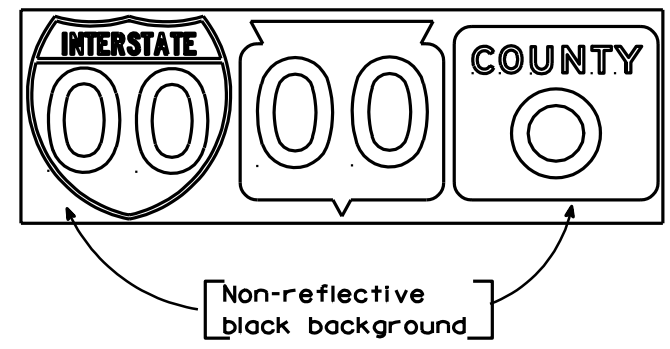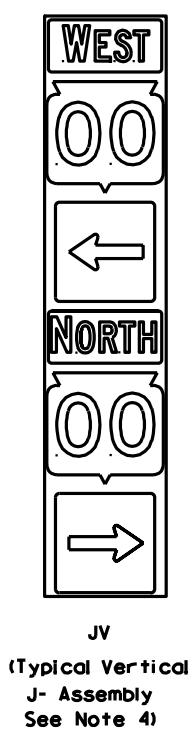


|                                                     |                                                       |
|-----------------------------------------------------|-------------------------------------------------------|
| ROUTE MARKERS & COMPONENTS<br>IN TYPICAL ASSEMBLIES |                                                       |
| WISCONSIN DEPT OF TRANSPORTATION                    |                                                       |
| APPROVED                                            | <i>Chester J. Spang</i><br>for State Traffic Engineer |
| DATE 3/06/00                                        | A2-1.6                                                |

URBAN AREA


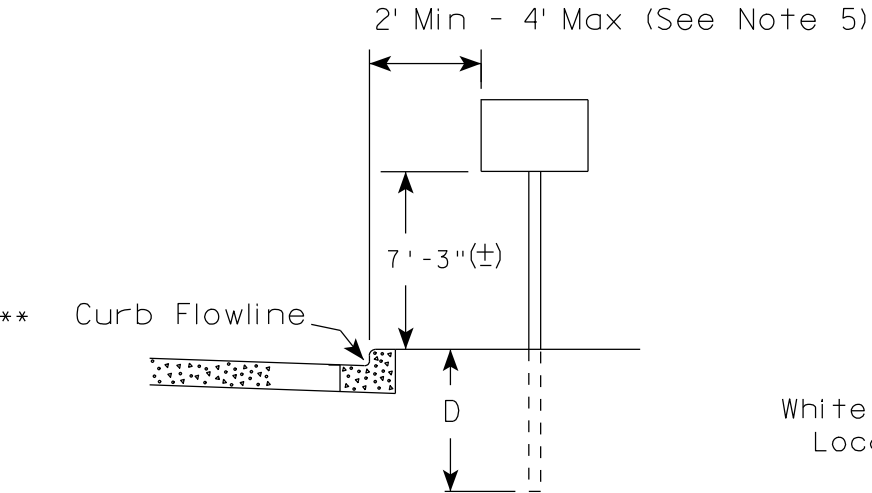


RURAL AREA (See Note 2)

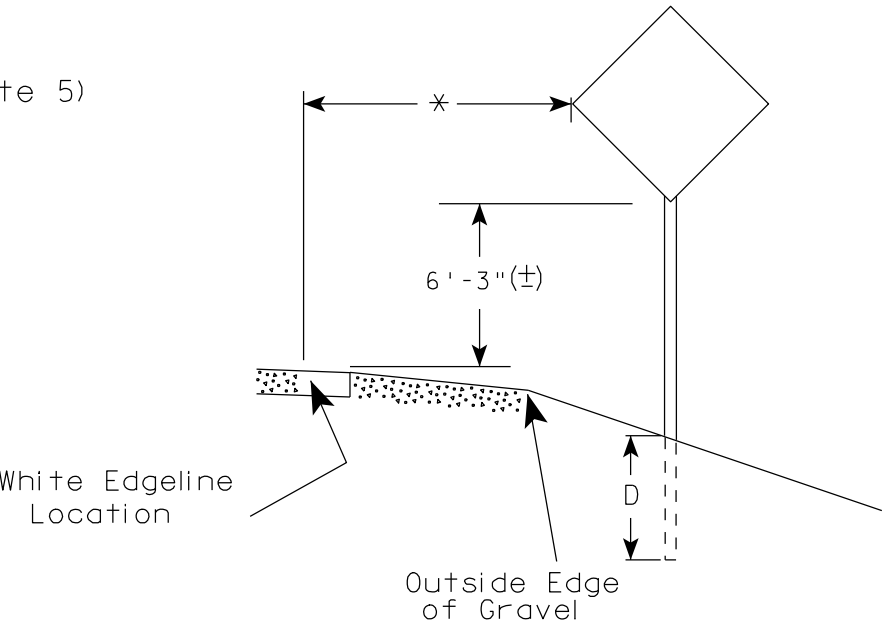

GENERAL NOTES

1. Signs wider than 4 feet or larger than 20 sq. ft. shall be mounted on multiple posts. Refer to plate A4-4.
2. If signs are mounted on barrier wall, see A4-10 sign plate.
3. For expressways and freeways, mounting height is 7'- 3" (±) or 6'-3" (±) depending upon existence of a sub-sign.
4. Minimum mounting height for J assemblies (A4-5) is 7'-3" (±) or 6'-3" (±) per urban or rural detail respectively.
5. Minimum mounting height for signs mounted on traffic signal poles is 5'- 3" (±).
6. Offset distance shall be consistent with existing signs or consistent throughout length of project.
7. The (±) tolerance for mounting height is 3 inches.
8. Folding stop signs (R1-1F) shall be mounted at a height of 5'-3" (±) or as directed by the Engineer.
9. The Double Arrow sign (W12-1) shall be mounted at a height of 2'-3" (±). The Chevron sign (W1-8), Roundabout Chevron panel (R6-4B), Clearance Markers (W5-52), Mile Markers (D10 series) & End of Road Markers (W5-56 & W5-56A) shall be mounted at a height of 4'-3" (±).

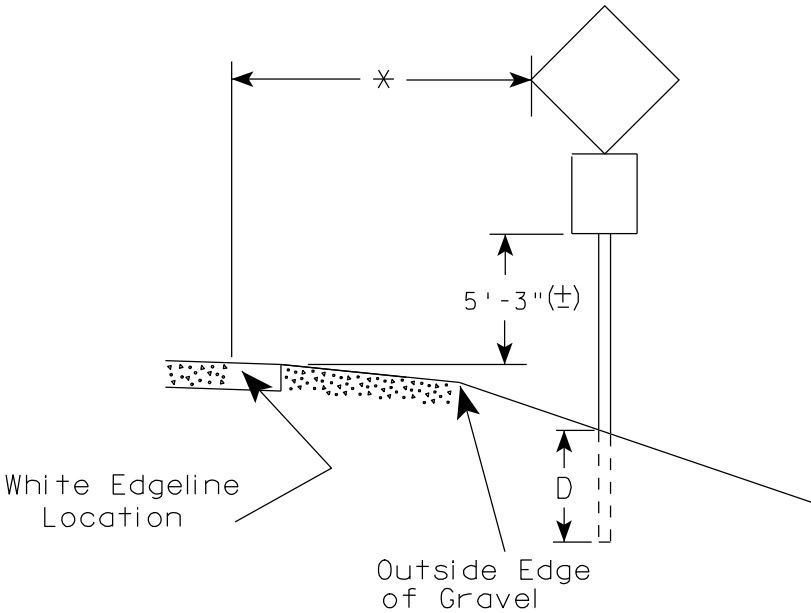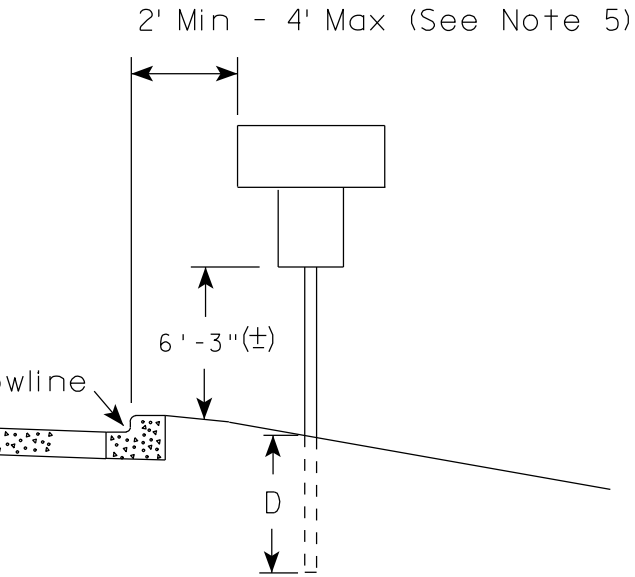

POST EMBEDMENT DEPTH

| Area of Sign Installation ( Sq. Ft. ) | D ( Min ) |
|---------------------------------------|-----------|
| 20 or Less                            | 4'        |
| Greater than 20                       | 5'        |

✱✱ The existence of curb and gutter does not in itself mandate the vertical clearance illustrated. That height is typically measured where there is sidewalk adjacent to the roadway or parking is permitted. In the absence of sidewalk vertical clearance is measured from the top of the curb. Offset of signs is measured from the flow line.


\* 6 feet from edge of a paved shoulder or 12 feet from the edge of pavement (edge line location) or 2 feet from outside edge of gravel, whichever is greater unless directed by project engineer.

TYPICAL INSTALLATION OF PERMANENT TYPE II SIGNS ON SINGLE POSTS

WISCONSIN DEPT OF TRANSPORTATION

APPROVED *Matthew R. Rauch*  
for State Traffic Engineer

DATE 9/21/2011 PLATE NO. A4-3.16

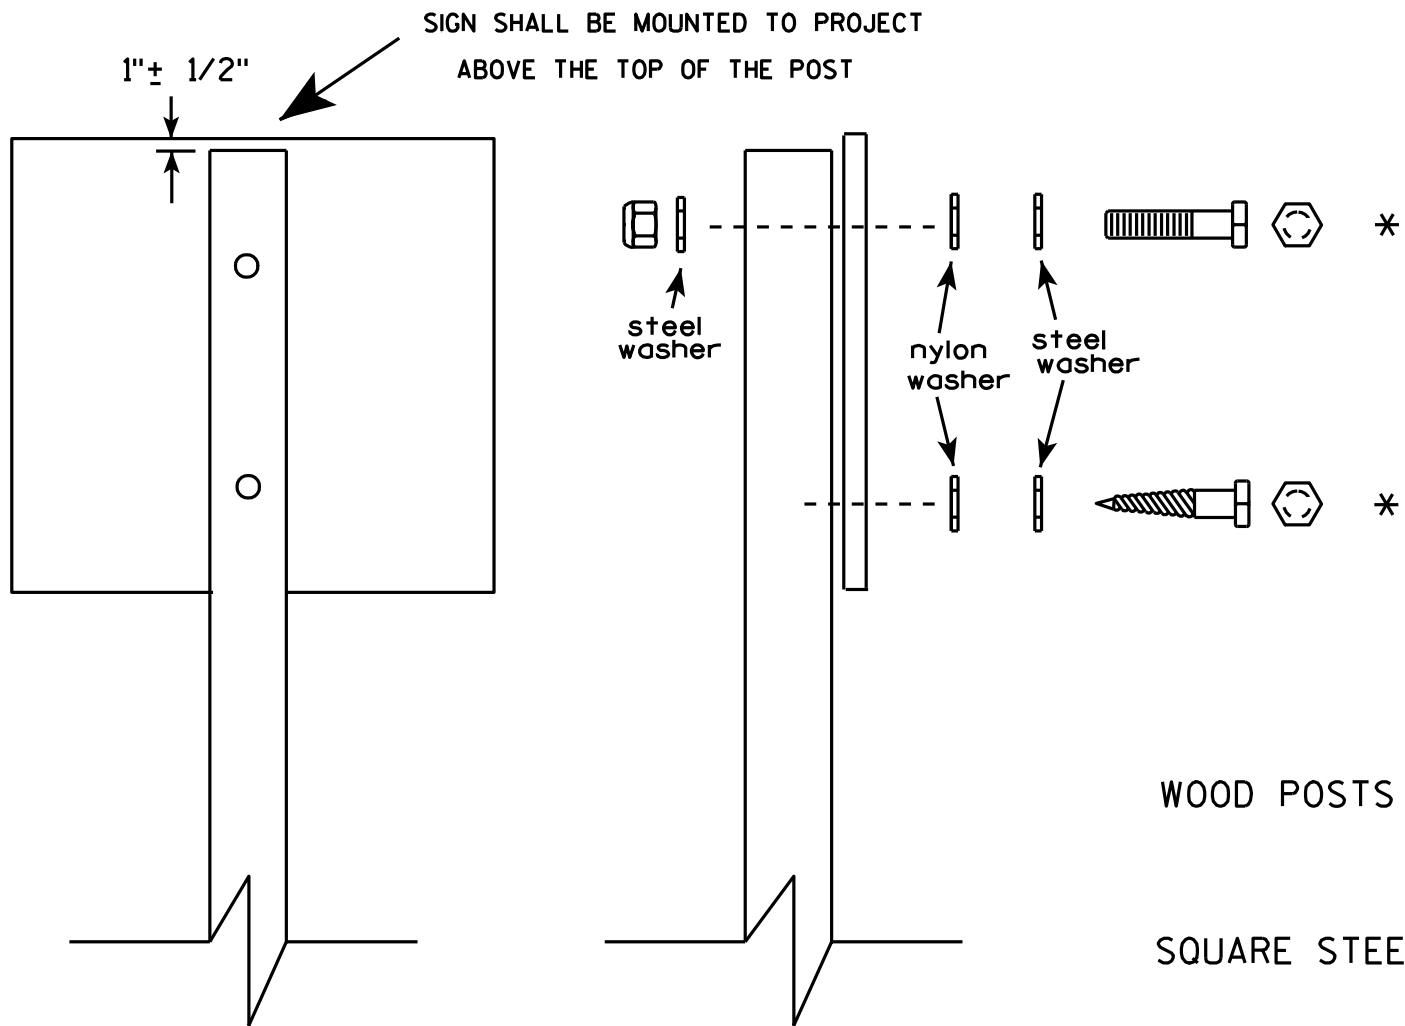


Nuts, bolts and lags used for mounting signs shall have hexagonal heads and shall be either :

- a. Hot dip galvanized in accordance with ASTM Designation: A 153, Class D, or SC 3
- b. Electro-galvanized in accordance with ASTM Designation : B 633, TYPE III, SC 3.

Threads on bolts and nuts shall be manufactured with sufficient allowance for the cadmium plate or galvanized coating to permit the nuts to run freely on the bolts.



- WOOD POSTS (4" x 4" or 4" x 6")  
LAG SCREWS - 3/8" X 3"  
MACHINE BOLTS - 5/16" X 6-1/2" or 7" Length w/ nuts
- SQUARE STEEL POSTS (2" x 2")  
MACHINE BOLTS - 3/8" X 3-1/4" Length w/ nuts  
RIVETS - 9/32" (6605-9-6) BULB-TITE, TRI-FOLD, ALUMINUM BODY/MANDREL  
O.D. FLANGE .720-.765 INCH, GRIP RANGE .042-.375 INCH
- WASHERS (ALL POSTS) -  
1-1/4" O.D. X 3/8" I.D. X 1/16" STEEL  
1-1/4" O.D. X 3/8" I.D. X .080 NYLON for all Type H signs.

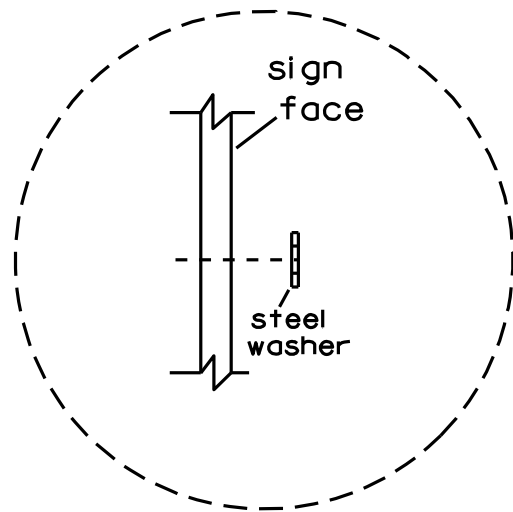

Washer Placement when Sign Has Other Than Type H or Type F Face

\* Two different fastening systems are shown for illustration purposes. On any individual sign, either one or the other system shall be used. Actual number of fasteners per sign varies with the sign area, but normally there are two. For a single post installation, all signs greater than 9 sq. ft. require the use of 3 fasteners.

|                                  |                                                       |
|----------------------------------|-------------------------------------------------------|
| ATTACHMENT OF SIGNS<br>TO POSTS  |                                                       |
| WISCONSIN DEPT OF TRANSPORTATION |                                                       |
| APPROVED                         | <i>Matthew R. Rauch</i><br>For State Traffic Engineer |
| DATE 3/23/10                     | PLATE NO. A4-8.7                                      |

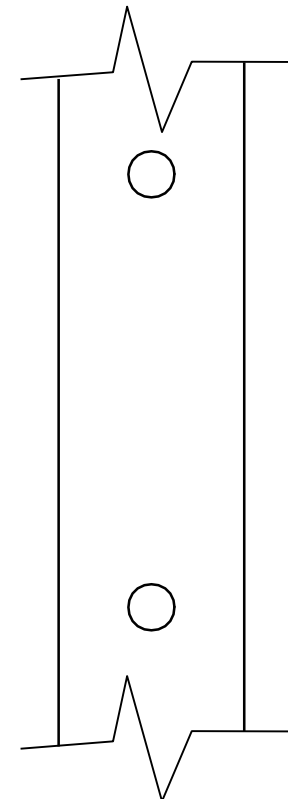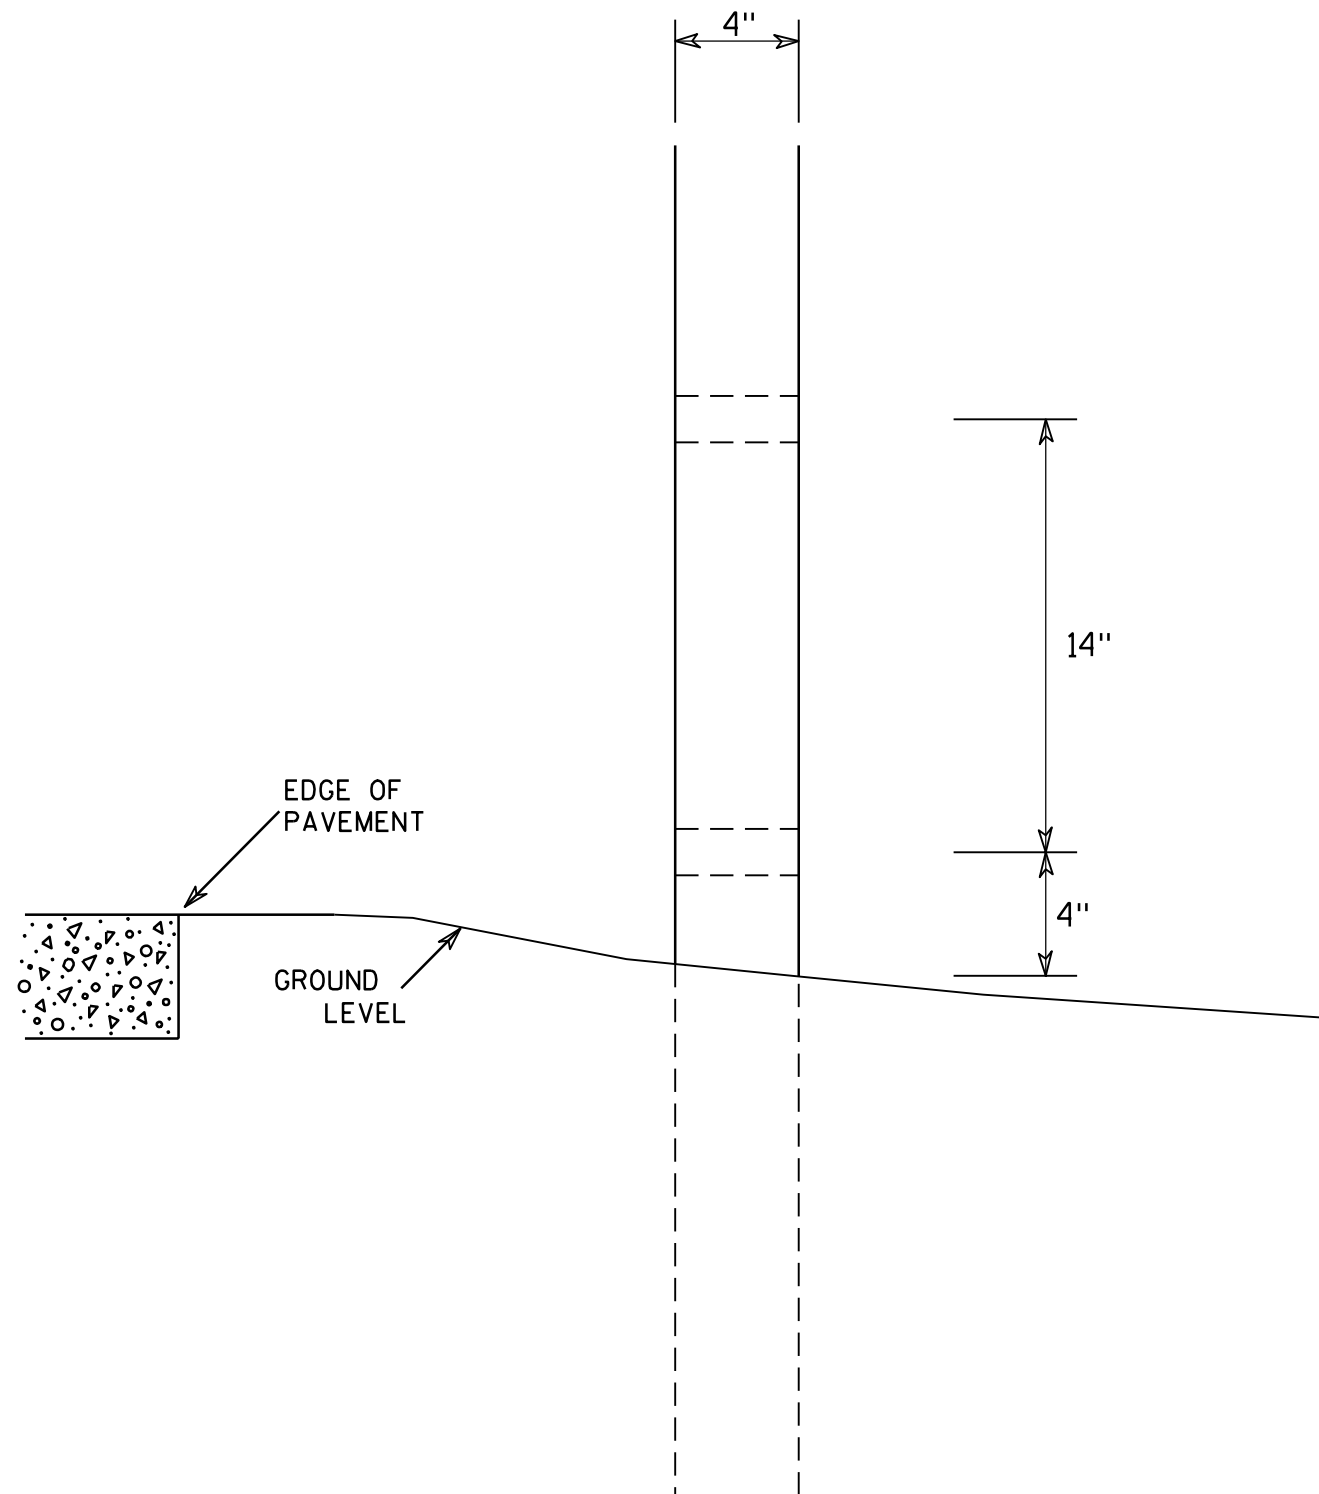

SIDE VIEW

# GENERAL NOTES

1. All 4 x 6 Wood Posts shall be modified by having two 1½" diameter holes drilled perpendicular to the roadway centerline.

## 4 X 6 WOOD POST MODIFICATIONS

WISCONSIN DEPT OF TRANSPORTATION

APPROVED

*Chester J. Spang*  
for State Traffic Engineer

DATE 3/27/97

PLATE NO. A4-11.2

PROJECT NO: 4867-03-70

HWY: CTH H


COUNTY: WASHINGTON

SIGN PLATES

SHEET NO:

E

7

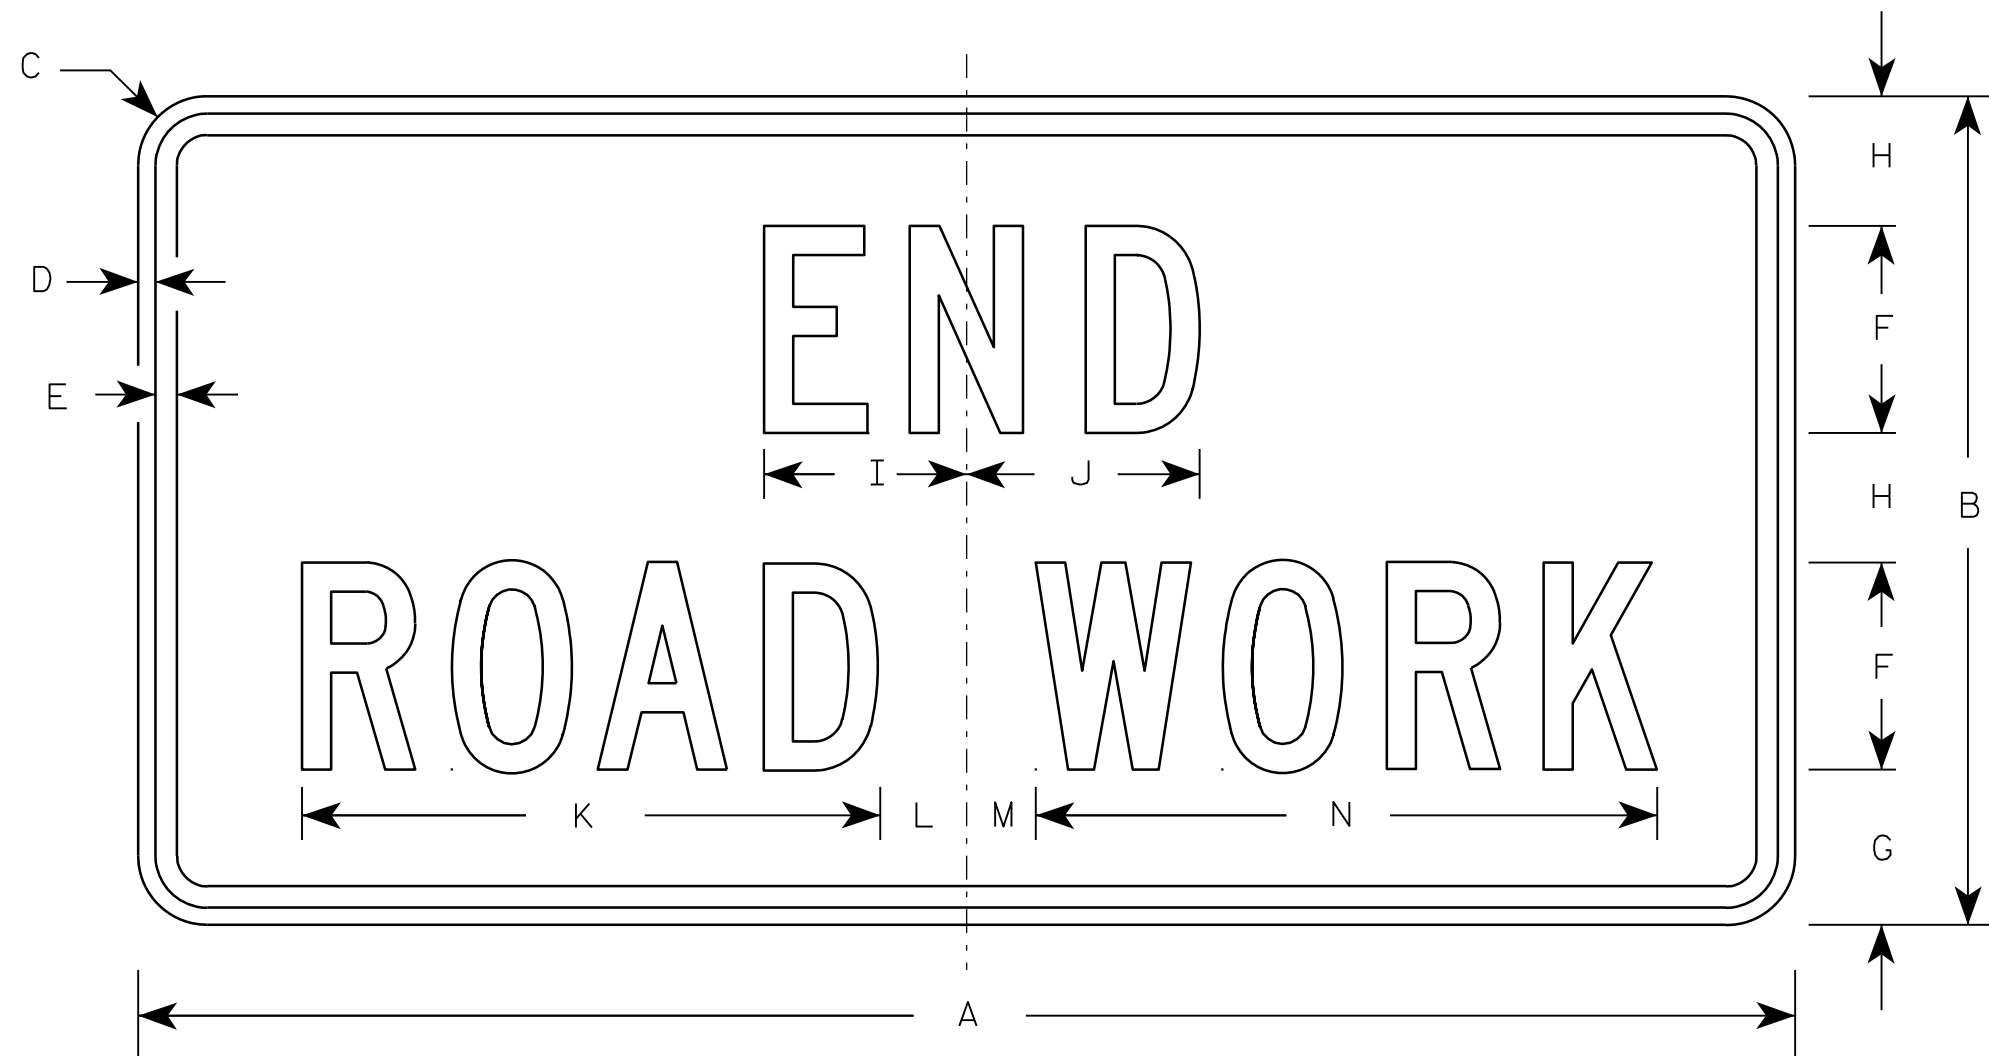

G20-2A

Metric equivalent  
for this sign is:

| SIZE |                  |
|------|------------------|
| 1    | 900 mm X 450 mm  |
| 2    | 1200 mm X 600 mm |
| 3    | 1200 mm X 600 mm |
| 4    | 1200 mm X 600 mm |
| 5    | 1200 mm X 600 mm |

| SIZE | A  | B  | C     | D   | E   | F | G     | H     | I     | J     | K      | L     | M     | N      | O | P | Q | R | S | T | U | V | W | X | Y | Z | Area<br>sq. ft. | Area<br>sq. m. |
|------|----|----|-------|-----|-----|---|-------|-------|-------|-------|--------|-------|-------|--------|---|---|---|---|---|---|---|---|---|---|---|---|-----------------|----------------|
| 1    | 36 | 18 | 1 1/8 | 3/8 | 1/2 | 4 | 3 3/4 | 2 1/2 | 4 1/8 | 4 1/8 | 11 1/8 | 2     | 1     | 12 1/8 |   |   |   |   |   |   |   |   |   |   |   |   | 4.5             | 0.41           |
| 2    | 48 | 24 | 1 1/2 | 1/2 | 5/8 | 6 | 4 1/2 | 3 3/4 | 5 7/8 | 6 3/4 | 16 3/4 | 2 1/2 | 1 3/4 | 18 1/2 |   |   |   |   |   |   |   |   |   |   |   |   | 8.0             | 0.72           |
| 3    | 48 | 24 | 1 1/2 | 1/2 | 5/8 | 6 | 4 1/2 | 3 3/4 | 5 7/8 | 6 3/4 | 16 3/4 | 2 1/2 | 1 3/4 | 18 1/2 |   |   |   |   |   |   |   |   |   |   |   |   | 8.0             | 0.72           |
| 4    | 48 | 24 | 1 1/2 | 1/2 | 5/8 | 6 | 4 1/2 | 3 3/4 | 5 7/8 | 6 3/4 | 16 3/4 | 2 1/2 | 1 3/4 | 18 1/2 |   |   |   |   |   |   |   |   |   |   |   |   | 8.0             | 0.72           |
| 5    | 48 | 24 | 1 1/2 | 1/2 | 5/8 | 6 | 4 1/2 | 3 3/4 | 5 7/8 | 6 3/4 | 16 3/4 | 2 1/2 | 1 3/4 | 18 1/2 |   |   |   |   |   |   |   |   |   |   |   |   | 8.0             | 0.72           |

NOTES

- Sign is Type II - Type F Reflective - reference WIS DOT Standard Specification for HIGHWAY and STRUCTURE CONSTRUCTION latest edition.
- Color:  
Background - Orange  
Message - Black
- Message Series - C
- Corners may be square or rounded when base material is plywood but borders shall be rounded as shown. When base material is metal, the corners and borders shall be rounded.

7

PROJECT NO: 4867-03-70

HWY: CTH H





COUNTY: WASHINGTON

SIGN PLATES

SHEET NO:

E

7

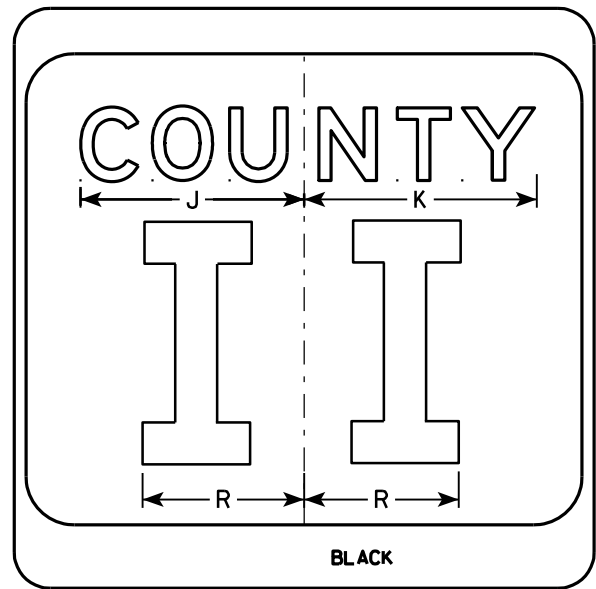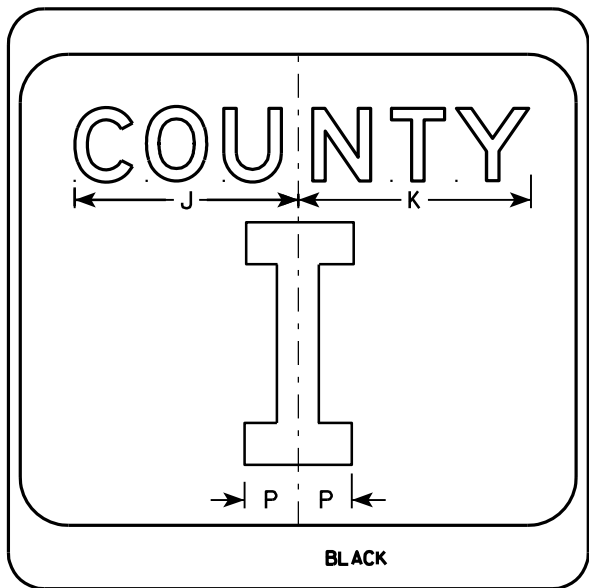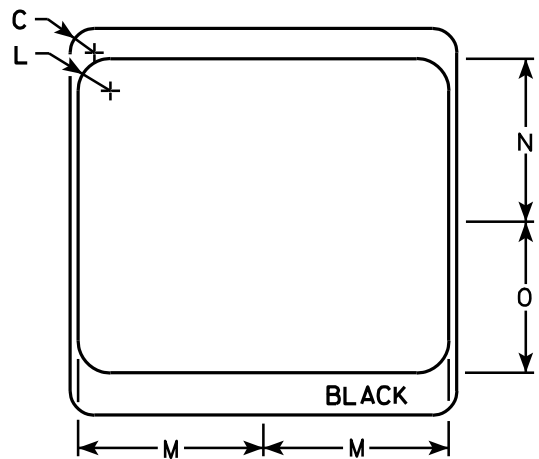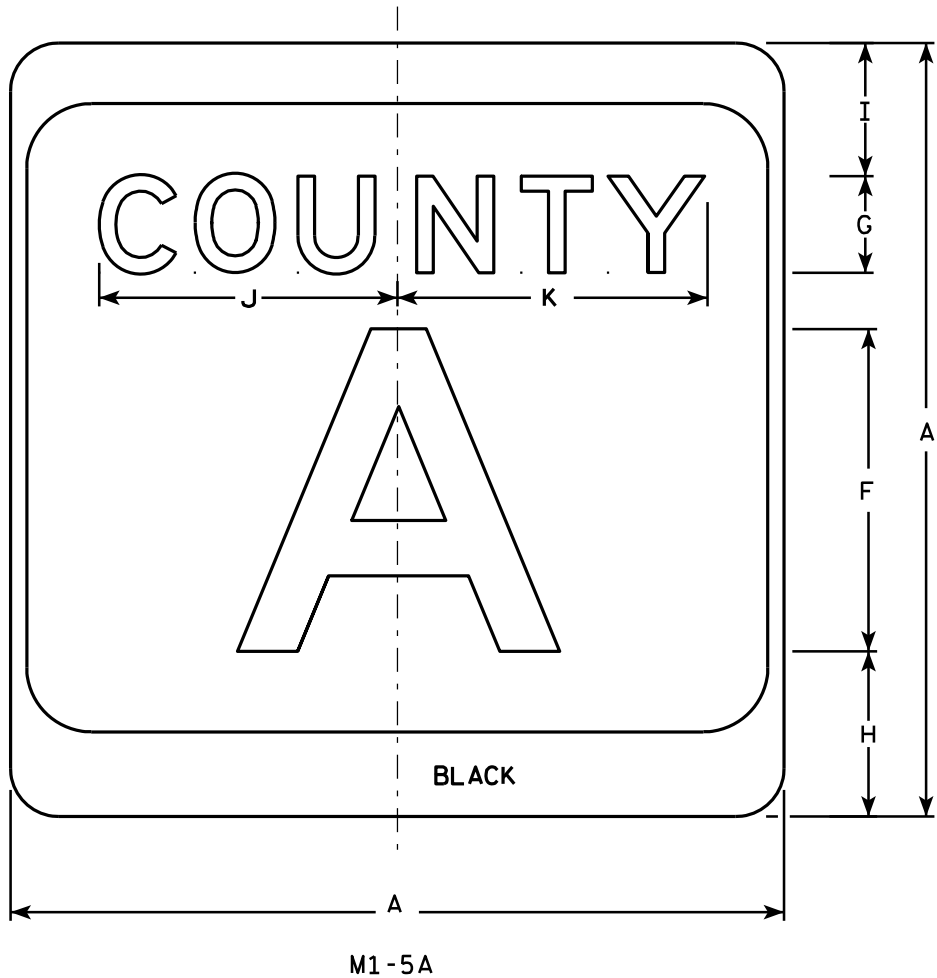

NOTES

1. Sign is Type II - see Note 7 - reference WIS DOT Standard Specification for HIGHWAY and STRUCTURE CONSTRUCTION latest edition.
2. Color:  
Background - White & Black - See Note 7  
Message - Black
3. Message Series - see Note 5
4. Corners may be square or rounded when base material is plywood but borders shall be rounded as shown. When base material is metal, the corners and borders shall be rounded.
5. Message Series E for 1 letter.  
Message Series D for 2 letters unless message is too big then Series C.  
Message Series C for 3 letters unless message is too big then Series B.
6. Substitute appropriate letters & optically center to achieve proper balance.
7. Permanent Signs  
Background - Type H Reflective  
Detour or temporary Signs  
Background - Reflective

| SIZE | A  | B | C     | D | E | F  | G | H     | I     | J      | K      | L | M      | N      | O     | P     | Q | R     | S | T | U | V | W | X | Y | Z | Area<br>sq. ft. |
|------|----|---|-------|---|---|----|---|-------|-------|--------|--------|---|--------|--------|-------|-------|---|-------|---|---|---|---|---|---|---|---|-----------------|
| 1    |    |   |       |   |   |    |   |       |       |        |        |   |        |        |       |       |   |       |   |   |   |   |   |   |   |   |                 |
| 2    | 24 |   | 1 1/2 |   |   | 10 | 3 | 5 1/8 | 4 1/8 | 9 1/4  | 9 5/8  | 2 | 11 1/2 | 10 1/8 | 9 3/8 | 2 1/4 |   | 6 5/8 |   |   |   |   |   |   |   |   | 4.0             |
| 3    | 36 |   | 2 1/4 |   |   | 16 | 4 | 7 5/8 | 5 5/8 | 12 1/4 | 12 7/8 | 3 | 17 1/8 | 15 1/4 | 14    | 3 3/8 |   | 10    |   |   |   |   |   |   |   |   | 9.0             |
| 4    | 36 |   | 2 1/4 |   |   | 16 | 4 | 7 5/8 | 5 5/8 | 12 1/4 | 12 7/8 | 3 | 17 1/8 | 15 1/4 | 14    | 3 3/8 |   | 10    |   |   |   |   |   |   |   |   | 9.0             |
| 5    | 36 |   | 2 1/4 |   |   | 16 | 4 | 7 5/8 | 5 5/8 | 12 1/4 | 12 7/8 | 3 | 17 1/8 | 15 1/4 | 14    | 3 3/8 |   | 10    |   |   |   |   |   |   |   |   | 9.0             |

CTH MARKER


M1-5A FOR ASSEMBLIES

WISCONSIN DEPT OF TRANSPORTATION

APPROVED *Matthew R. Rauch*  
for State Traffic Engineer

DATE 9/27/11 PLATE NO. M1-5A.8


7

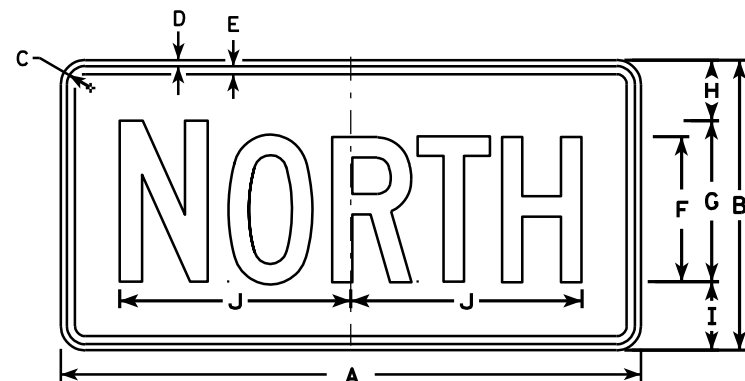


M3-1  
MK3-1  
M03-1




M3-2  
MK3-2  
M03-2

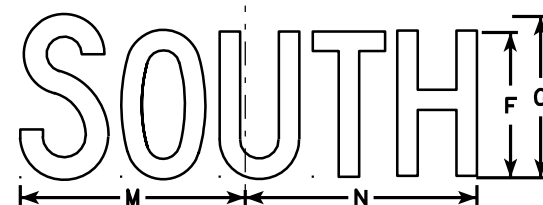


M3-3  
MK3-3  
M03-3

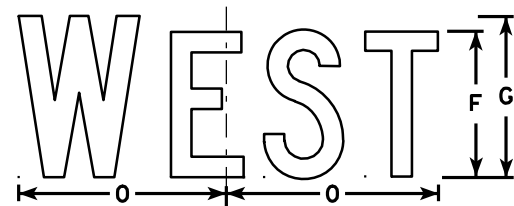


M3-4  
MK3-4  
M03-4

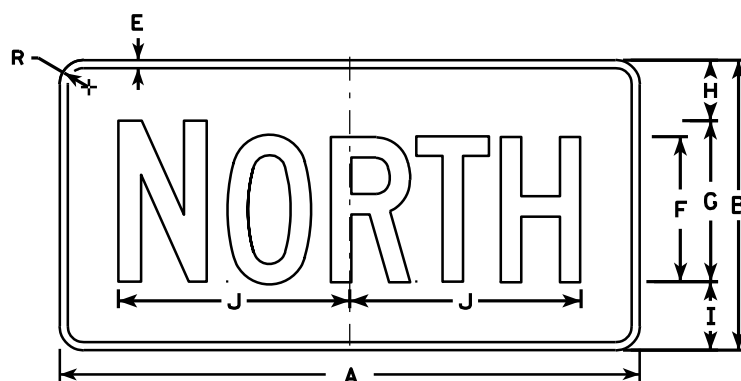


MB3-1  
MG3-1  
MM3-1  
MN3-1

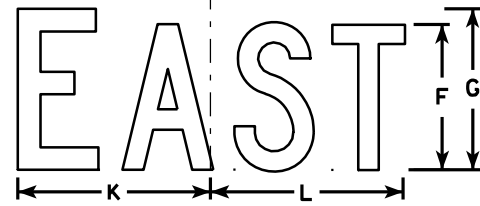

MB3-2  
MG3-2  
MM3-2  
MN3-2

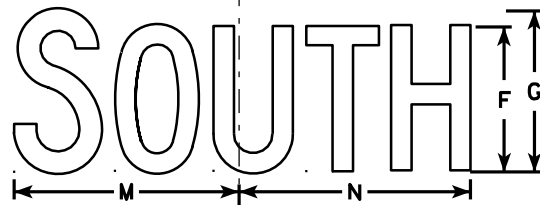

MB3-3  
MG3-3  
MM3-3  
MN3-3

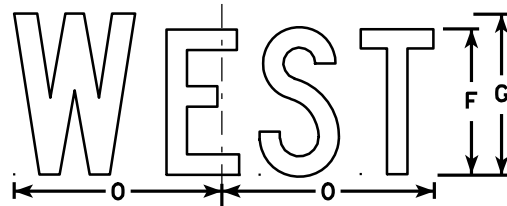

MB3-4  
MG3-4  
MM3-4  
MN3-4

## NOTES

1. All Signs Type II - See Note 5 - reference WIS DOT Standard Specification for HIGHWAY and STRUCTURE CONSTRUCTION latest edition.
2. Color:  
Background - See note 5  
Message - See note 5
3. Message Series - C
4. Corners may be square or rounded when base material is plywood but borders shall be rounded as shown. When base material is metal, the corners and borders shall be rounded.
5. M3-1 thru M3-4 Background - White - Type H Reflective (Detour or temporary signs - Reflective)  
Message - Black  
MB3-1 thru MB3-4 Background - Blue  
Message - White - Type H Reflective (Detour or temporary signs - Reflective)  
MG3-1 thru MG3-4 Background - Green  
Message - White - Type H Reflective  
MK3-1 thru MK3-4 Background - Green  
Message - White - Type H Reflective  
MM3-1 thru MM3-4 Background - White - Type H Reflective  
Message - Green  
MN3-1 thru MN3-4 Background - Brown  
Message - White - Type H Reflective  
M03-1 thru M03-4 Background - Orange - Reflective  
Message - Black
6. Note the first letter of each direction is larger than the remainder of the message.

| SIZE | A  | B  | C     | D   | E   | F | G  | H     | I     | J      | K     | L      | M      | N      | O     | P | Q | R     | S | T | U | V | W | X | Y | Z | Area<br>sq. ft. |
|------|----|----|-------|-----|-----|---|----|-------|-------|--------|-------|--------|--------|--------|-------|---|---|-------|---|---|---|---|---|---|---|---|-----------------|
| 1    |    |    |       |     |     |   |    |       |       |        |       |        |        |        |       |   |   |       |   |   |   |   |   |   |   |   |                 |
| 2    | 24 | 12 | 1 1/8 | 3/8 | 3/8 | 6 | 7  | 2 1/4 | 2 3/4 | 10 1/4 | 7 7/8 | 8 3/8  | 10 1/4 | 9 3/4  | 8 3/4 |   |   | 1 1/2 |   |   |   |   |   |   |   |   | 2.00            |
| 3    | 36 | 18 | 1 1/8 | 3/8 | 1/2 | 9 | 10 | 3 3/4 | 4 1/4 | 14 3/8 | 12    | 12 1/8 | 14     | 14 1/8 | 13    |   |   | 1 1/2 |   |   |   |   |   |   |   |   | 4.5             |
| 4    | 36 | 18 | 1 1/8 | 3/8 | 1/2 | 9 | 10 | 3 3/4 | 4 1/4 | 14 3/8 | 12    | 12 1/8 | 14     | 14 1/8 | 13    |   |   | 1 1/2 |   |   |   |   |   |   |   |   | 4.5             |
| 5    | 36 | 18 | 1 1/8 | 3/8 | 1/2 | 9 | 10 | 3 3/4 | 4 1/4 | 14 3/8 | 12    | 12 1/8 | 14     | 14 1/8 | 13    |   |   | 1 1/2 |   |   |   |   |   |   |   |   | 4.5             |

PROJECT NO: 4867-03-70

HWY: CTH H

COUNTY: WASHINGTON

SIGN PLATES

SHEET NO:

E

STANDARD SIGNS  
M3-1 thru M3-4  
SERIES

WISCONSIN DEPT OF TRANSPORTATION

APPROVED


*Matthew R. Rauch*  
for State Traffic Engineer

DATE 11/10/10

PLATE NO. M3-1.12

NOTES

- 1. Sign is Type II - Type F Reflective - reference WIS DOT Standard Specification for HIGHWAY and STRUCTURE CONSTRUCTION latest edition.
- 2. Color:
  - Background - Orange
  - Message - Black
- 3. Message Series - B
- 4. Corners may be square or rounded when base material is plywood but borders shall be rounded as shown. When base material is metal, the corners and borders shall be rounded.

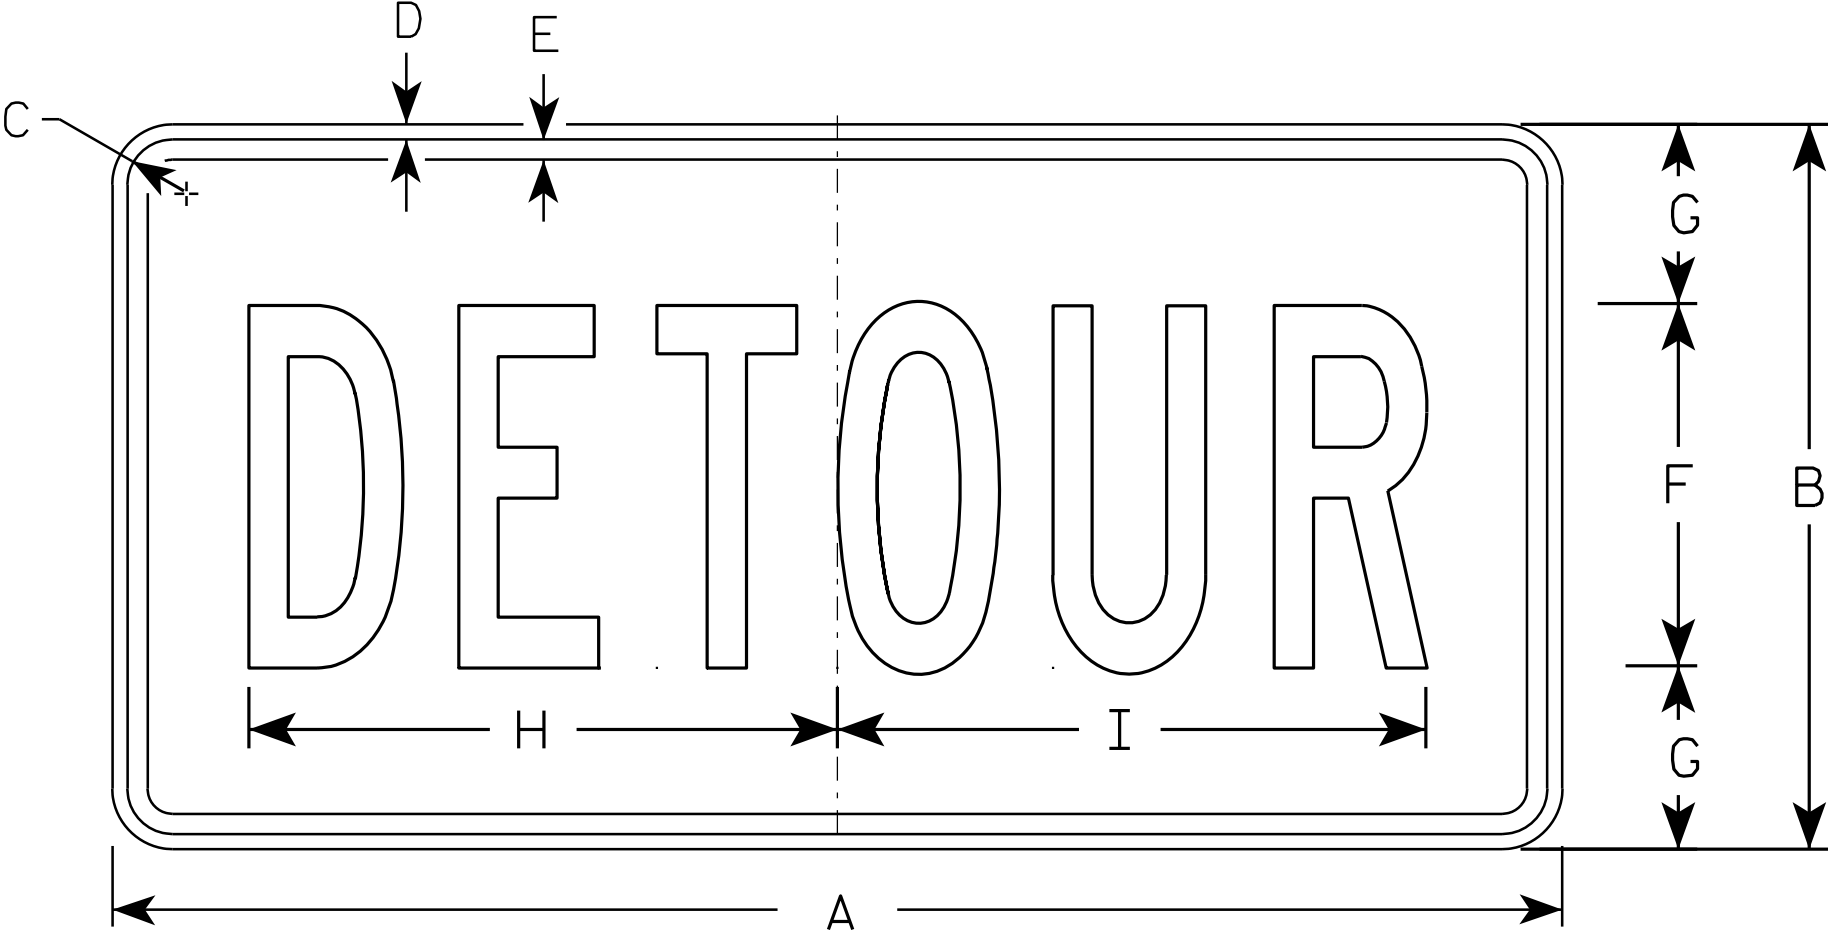

M4 - 8


| SIZE | A  | B  | C     | D   | E   | F | G     | H      | I      | J | K | L | M | N | O | P | Q | R | S | T | U | V | W | X | Y | Z | Area<br>sq. ft. |
|------|----|----|-------|-----|-----|---|-------|--------|--------|---|---|---|---|---|---|---|---|---|---|---|---|---|---|---|---|---|-----------------|
| 1    |    |    |       |     |     |   |       |        |        |   |   |   |   |   |   |   |   |   |   |   |   |   |   |   |   |   |                 |
| 2    | 24 | 12 | 1 1/8 | 3/8 | 3/8 | 6 | 3     | 10     | 10 1/4 |   |   |   |   |   |   |   |   |   |   |   |   |   |   |   |   |   | 2.0             |
| 3    | 36 | 18 | 1 1/8 | 3/8 | 1/2 | 9 | 4 1/2 | 14 5/8 | 14 1/2 |   |   |   |   |   |   |   |   |   |   |   |   |   |   |   |   |   | 4.5             |
| 4    |    |    |       |     |     |   |       |        |        |   |   |   |   |   |   |   |   |   |   |   |   |   |   |   |   |   |                 |
| 5    |    |    |       |     |     |   |       |        |        |   |   |   |   |   |   |   |   |   |   |   |   |   |   |   |   |   |                 |

STANDARD SIGN  
M4 - 8

WISCONSIN DEPT OF TRANSPORTATION

APPROVED  
*Matthew R. Rauch*  
for State Traffic Engineer

DATE 11/10/10 PLATE NO. M4-8.2

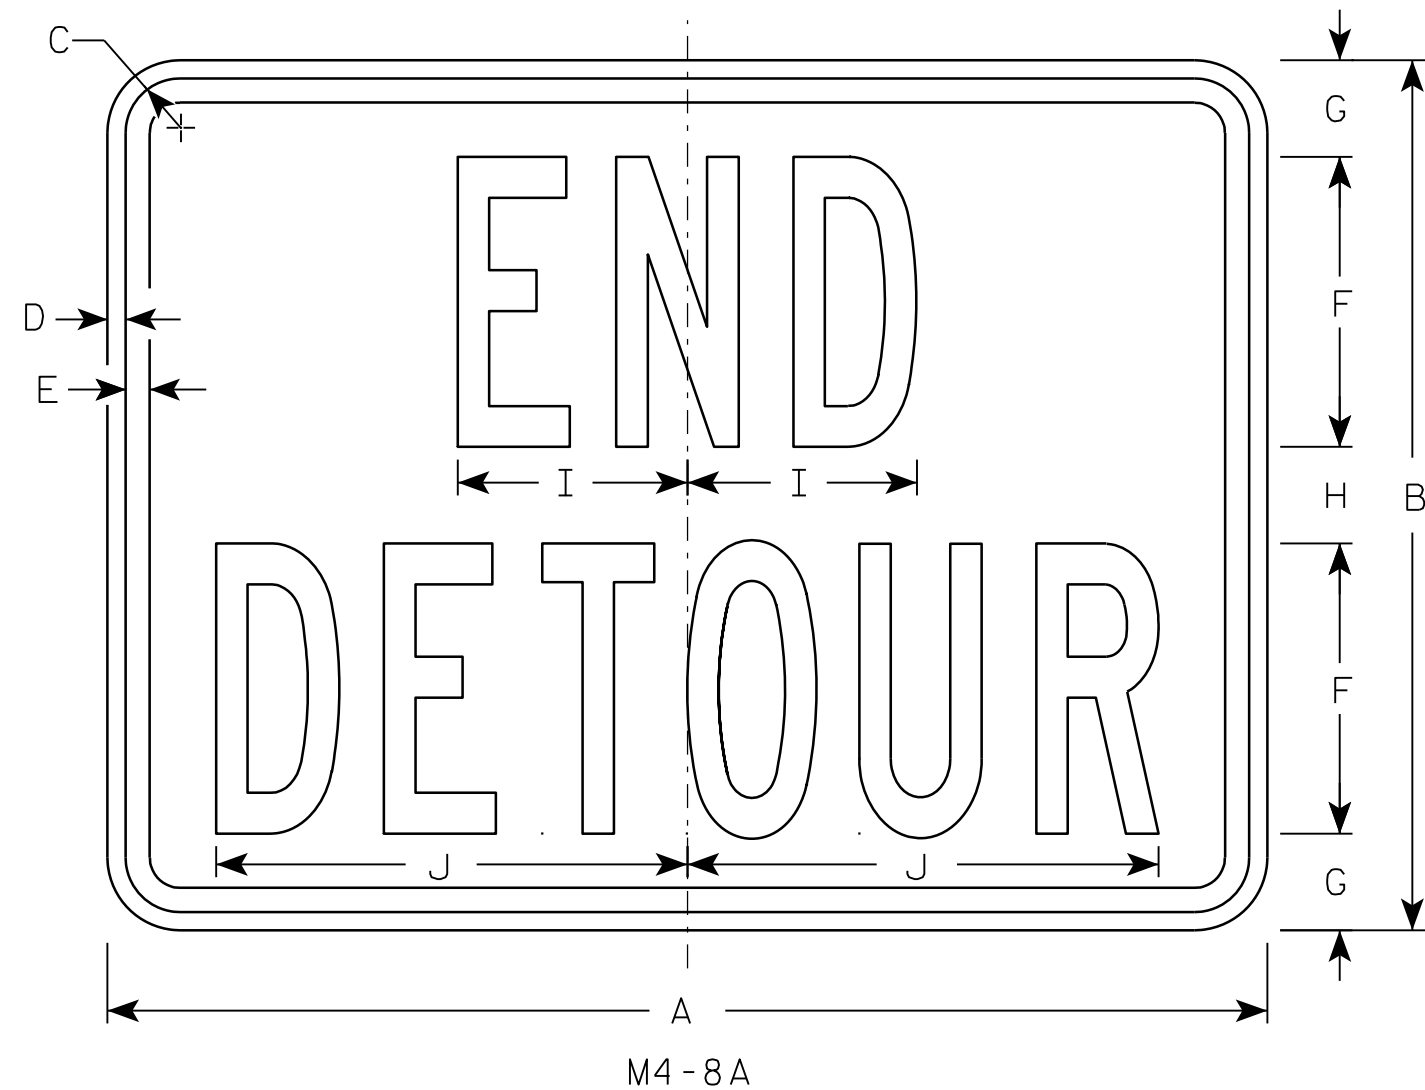

NOTES

1. Sign is Type II - Type F Reflective - reference WIS DOT Standard Specification for HIGHWAY and STRUCTURE CONSTRUCTION latest edition.
2. Color:  
Background - Orange  
Message - Black
3. Message Series - B
4. Corners may be square or rounded when base material is plywood but borders shall be rounded as shown. When base material is metal, the corners and borders shall be rounded.

| SIZE | A  | B  | C     | D   | E   | F | G     | H | I     | J     | K | L | M | N | O | P | Q | R | S | T | U | V | W | X | Y | Z | Area<br>sq. ft. |
|------|----|----|-------|-----|-----|---|-------|---|-------|-------|---|---|---|---|---|---|---|---|---|---|---|---|---|---|---|---|-----------------|
| 1    |    |    |       |     |     |   |       |   |       |       |   |   |   |   |   |   |   |   |   |   |   |   |   |   |   |   |                 |
| 2    | 24 | 18 | 1 1/8 | 3/8 | 1/2 | 6 | 2     | 2 | 4 3/4 | 9 3/4 |   |   |   |   |   |   |   |   |   |   |   |   |   |   |   |   | 3.0             |
| 3    | 30 | 24 | 1 1/8 | 3/8 | 1/2 | 8 | 2 1/2 | 3 | 6 3/4 | 13    |   |   |   |   |   |   |   |   |   |   |   |   |   |   |   |   | 5.0             |
| 4    |    |    |       |     |     |   |       |   |       |       |   |   |   |   |   |   |   |   |   |   |   |   |   |   |   |   |                 |
| 5    |    |    |       |     |     |   |       |   |       |       |   |   |   |   |   |   |   |   |   |   |   |   |   |   |   |   |                 |


|                        |            |                    |             |           |   |
|------------------------|------------|--------------------|-------------|-----------|---|
| PROJECT NO: 4867-03-70 | HWY: CTH H | COUNTY: WASHINGTON | SIGN PLATES | SHEET NO: | E |
|------------------------|------------|--------------------|-------------|-----------|---|

STANDARD SIGN  
M4-8A

WISCONSIN DEPT OF TRANSPORTATION


APPROVED *Matthew R. Rauch*  
for State Traffic Engineer

DATE 3/9/11 PLATE NO. M4-8A.2

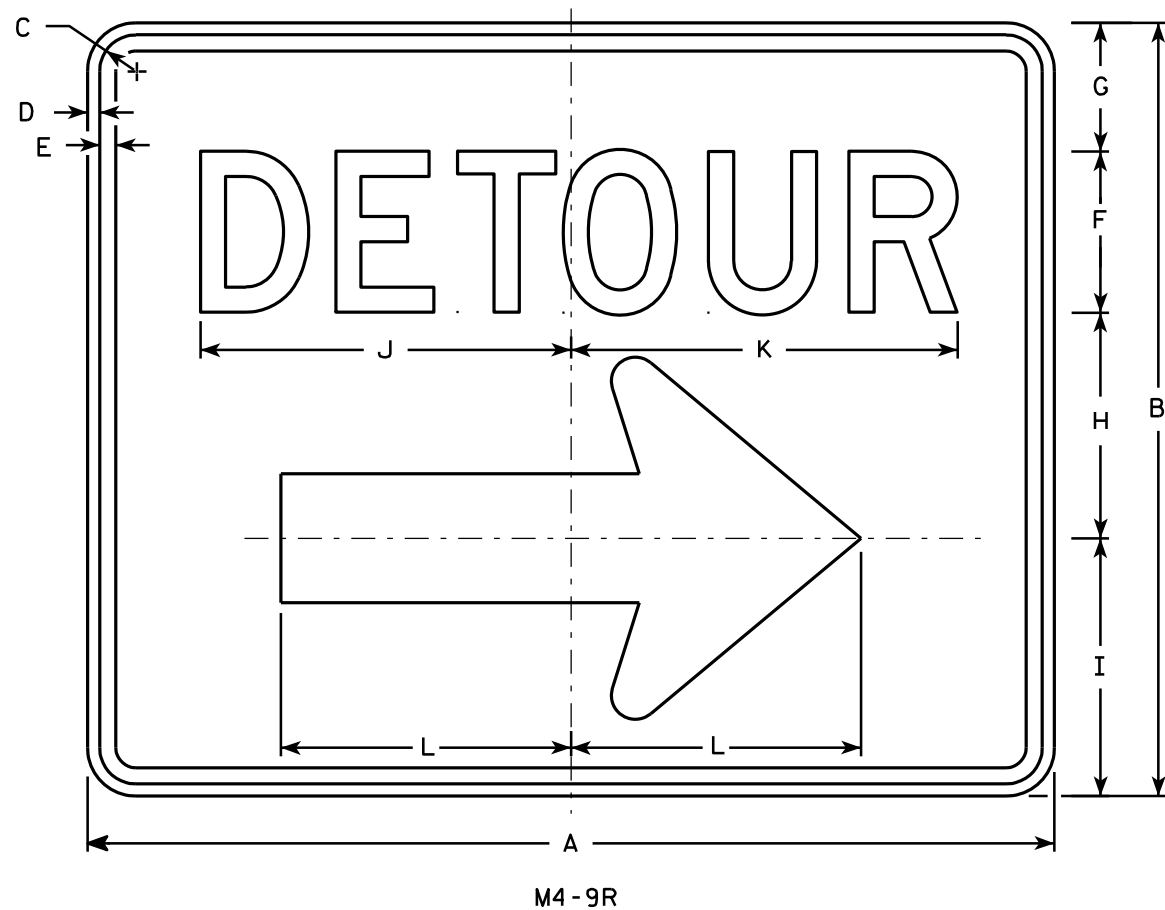

NOTES

- 1. Sign is Type II - Type F Reflective - reference WIS DOT Standard Specification for HIGHWAY and STRUCTURE CONSTRUCTION latest edition.
- 2. Color:  
Background - Orange  
Message - Black
- 3. Message Series - D
- 4. Corners may be square or rounded when base material is plywood but borders shall be rounded as shown. When base material is metal, the corners and borders shall be rounded.
- 5. M4-9L is the same as M4-9R except the arrow is reversed.

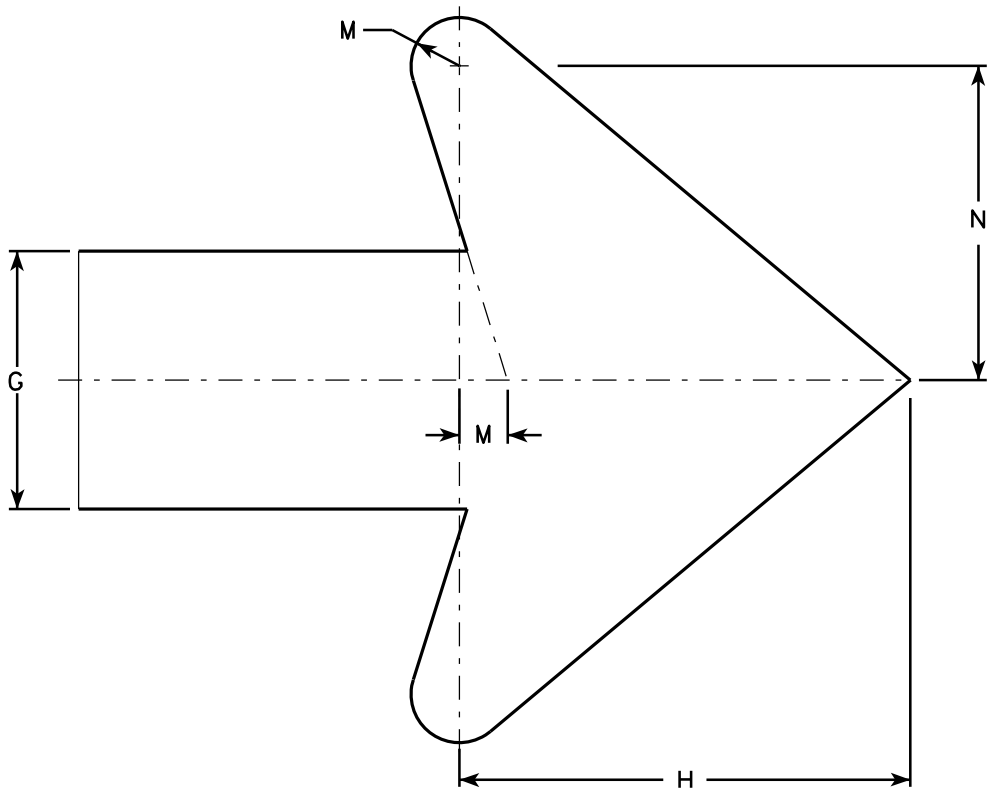

Arrow Detail

| SIZE | A  | B  | C     | D   | E   | F | G | H      | I      | J      | K      | L      | M     | N     | O | P | Q | R | S | T | U | V | W | X | Y | Z | Area<br>sq. ft. |
|------|----|----|-------|-----|-----|---|---|--------|--------|--------|--------|--------|-------|-------|---|---|---|---|---|---|---|---|---|---|---|---|-----------------|
| 1    |    |    |       |     |     |   |   |        |        |        |        |        |       |       |   |   |   |   |   |   |   |   |   |   |   |   |                 |
| 2    | 30 | 24 | 1 1/8 | 3/8 | 1/2 | 5 | 4 | 7      | 8      | 11 1/2 | 12     | 9      | 3/4   | 4 7/8 |   |   |   |   |   |   |   |   |   |   |   |   | 5.00            |
| 3    | 30 | 24 | 1 1/8 | 3/8 | 1/2 | 5 | 4 | 7      | 8      | 11 1/2 | 12     | 9      | 3/4   | 4 7/8 |   |   |   |   |   |   |   |   |   |   |   |   | 5.00            |
| 4    | 48 | 36 | 1 3/8 | 1/2 | 5/8 | 8 | 6 | 10 1/2 | 11 5/8 | 20 5/8 | 20 1/2 | 13 1/4 | 1 1/8 | 6 7/8 |   |   |   |   |   |   |   |   |   |   |   |   | 12.0            |
| 5    | 48 | 36 | 1 3/8 | 1/2 | 5/8 | 8 | 6 | 10 1/2 | 11 5/8 | 20 5/8 | 20 1/2 | 13 1/4 | 1 1/8 | 6 7/8 |   |   |   |   |   |   |   |   |   |   |   |   | 12.0            |

STANDARD SIGN

M4-9 R & L


WISCONSIN DEPT OF TRANSPORTATION

APPROVED *Matthew R. Rauch*


For State Traffic Engineer

DATE 3/9/11


PLATE NO. M4-9R.4

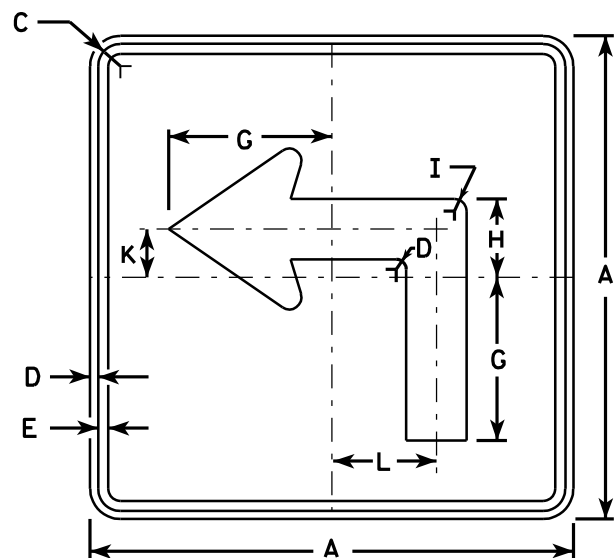


M5-1L  
MK5-1L  
MM5-1L  
MO5-1L  
MR5-1L

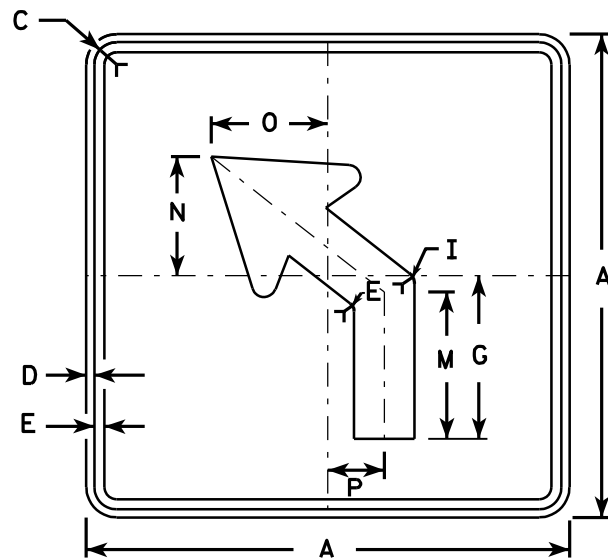


M5-2L  
MK5-2L  
MM5-2L  
MO5-2L  
MR5-2L

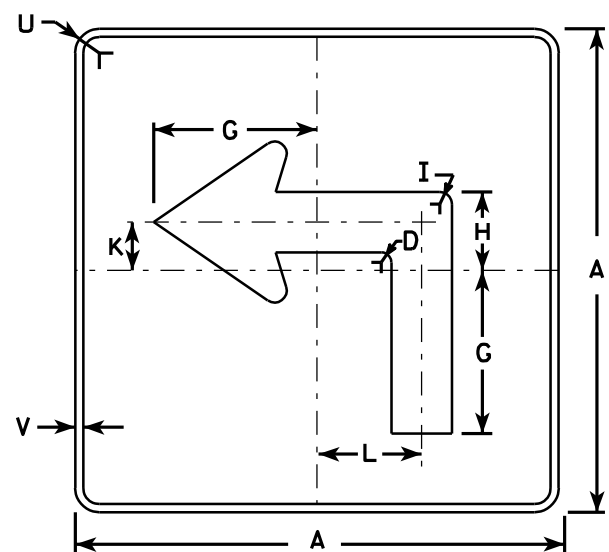

MB5-1L  
MG5-1L  
MN5-1L

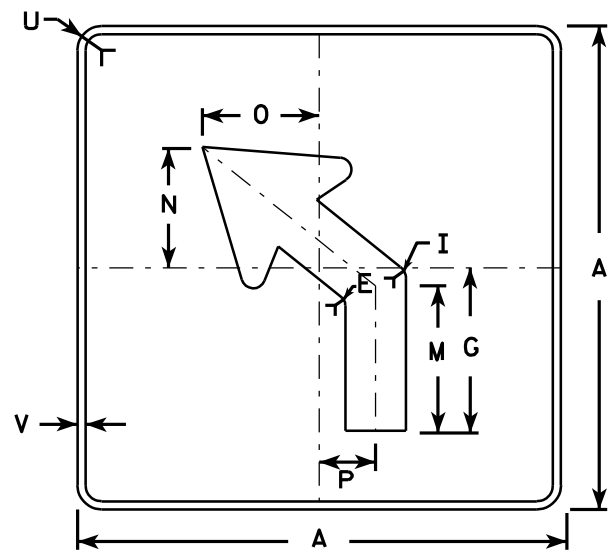

MB5-2L  
MG5-2L  
MN5-2L

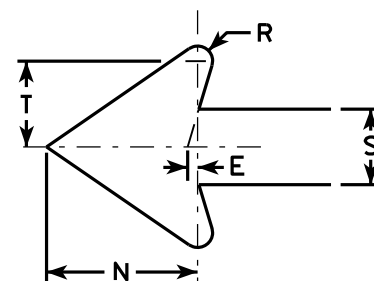

NOTES

- Signs are Type II - See Note 4 - reference WIS DOT Standard Specification for HIGHWAY and STRUCTURE CONSTRUCTION latest edition.
- Color:  
Background - See note 4  
Message - See note 4
- Corners may be square or rounded when base material is plywood but borders shall be rounded as shown. When base material is metal, the corners and borders shall be rounded.
- M5-1 and M5-2 Background - White - Type H Reflective (Detour or temporary Signs - Reflective)  
Message - Black  
MB5-1 and MB5-2 Background - Blue  
Message - White - Type H Reflective (Detour or temporary Signs - Reflective)  
MG5-1 and MG5-2 Background - Green  
Message - White - Type H Reflective  
MK5-1 and MK5-2 Background - Green  
Message - White Type H Reflective  
MM5-1 and MM5-2 Background - White - Type H Reflective  
Message - Green  
MN5-1 and MN5-2 Background - Brown  
Message - White - Type H Reflective  
MO5-1 and MO5-2 Background - Orange - Reflective  
Message - Black  
MR5-1 and MR5-2 Background - Brown  
Message - Yellow - Type H Reflective
- M5-1R same as M5-1L except arrow points right.
- M5-2R same as M5-2L except arrow tilts right.

Metric equivalent  
for this sign is:

| SIZE |                 |
|------|-----------------|
| 1    |                 |
| 2    | 525 mm X 525 mm |
| 3    | 750 mm X 750 mm |
| 4    | 750 mm X 750 mm |
| 5    | 750 mm X 750 mm |


| SIZE | A  | B | C     | D   | E   | F | G      | H     | I   | J | K     | L     | M     | N     | O     | P     | Q | R   | S     | T     | U     | V   | W | X | Y | Z | Area<br>sq. ft. | Area<br>m <sup>2</sup> |
|------|----|---|-------|-----|-----|---|--------|-------|-----|---|-------|-------|-------|-------|-------|-------|---|-----|-------|-------|-------|-----|---|---|---|---|-----------------|------------------------|
| 1    |    |   | 2    | 21 |   | 1 1/8 | 3/8 | 3/8 |   | 7      | 3 3/8 | 5/8 |   | 2 1/8 | 4 1/2 | 6 3/8 | 5 1/4 | 5     | 2 1/2 |   | 1/2 | 2 5/8 | 3     | 1 1/2 | 1/2 |   |   |   |   | 3.06            | 0.28                   |
| 3    | 30 |   | 1 3/8 | 1/2 | 5/8 |   | 10 1/8 | 4 7/8 | 7/8 |   | 3     | 6 1/2 | 9 1/8 | 7 1/2 | 7 1/4 | 3 1/2 |   | 3/4 | 3 3/4 | 4 1/4 | 1 7/8 | 1/2 |   |   |   |   | 6.25            | 0.56                   |
| 4    | 30 |   | 1 3/8 | 1/2 | 5/8 |   | 10 1/8 | 4 7/8 | 7/8 |   | 3     | 6 1/2 | 9 1/8 | 7 1/2 | 7 1/4 | 3 1/2 |   | 3/4 | 3 3/4 | 4 1/4 | 1 7/8 | 1/2 |   |   |   |   | 6.25            | 0.56                   |
| 5    | 30 |   | 1 3/8 | 1/2 | 5/8 |   | 10 1/8 | 4 7/8 | 7/8 |   | 3     | 6 1/2 | 9 1/8 | 7 1/2 | 7 1/4 | 3 1/2 |   | 3/4 | 3 3/4 | 4 1/4 | 1 7/8 | 1/2 |   |   |   |   | 6.25            | 0.56                   |

STANDARD SIGN  
M5-1 & M5-2


WISCONSIN DEPT OF TRANSPORTATION

APPROVED *Matthew R. Rauch*  
for State Traffic Engineer


DATE 3/16/10 PLATE NO. M5-1.11

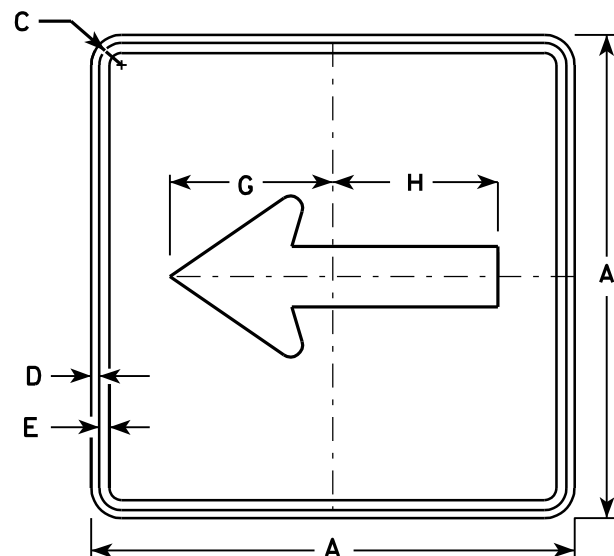


M6-1  
MK6-1  
MM6-1  
MO6-1  
MR6-1

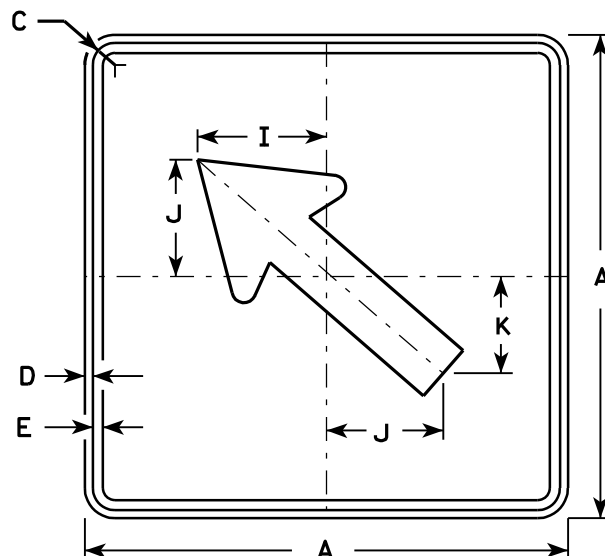

M6-2  
MK6-2  
MM6-2  
MO6-2  
MR6-2

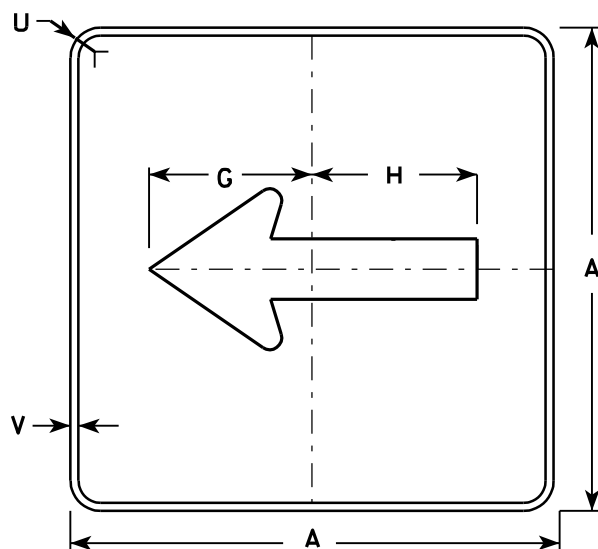


MB6-1  
MG6-1  
MN6-1

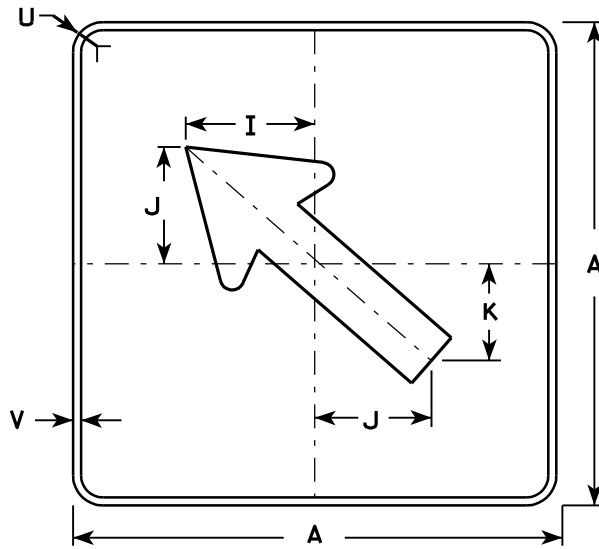

MB6-2  
MG6-2  
MN6-2

### NOTES

- Signs are Type II - See Note 4 - reference WIS DOT Standard Specification for HIGHWAY and STRUCTURE CONSTRUCTION latest edition.
- Color:  
Background - See note 4  
Message - See note 4
- Corners may be square or rounded when base material is plywood but borders shall be rounded as shown. When base material is metal, the corners and borders shall be rounded.
- M6-1 and M6-2 Background - White - Type H Reflective  
(Detour or temporary Signs - Reflective)  
Message - Black  
MB6-1 and MB6-2 Background - Blue  
Message - White - Type H Reflective  
(Detour or temporary Signs - Reflective)  
MG6-1 and MG6-2 Background - Green  
Message - White - Type H Reflective  
MK6-1 and MK6-2 Background - Green  
Message - White - Type H Reflective  
MM6-1 and MM6-2 Background - White - Type H Reflective  
Message - Green  
MN6-1 and MN6-2 Background - Brown  
Message - White - Type H Reflective  
MO6-1 and MO6-2 Background - Orange - Reflective  
Message - Black  
MR6-1 and MR6-2 Background - Brown  
Message - Yellow - Type H Reflective

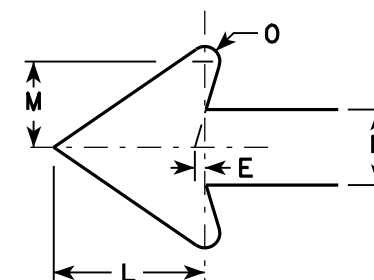

Metric equivalent  
for this sign is:

| SIZE |                 |
|------|-----------------|
| 1    |                 |
| 2    | 525 mm X 525 mm |
| 3    | 750 mm X 750 mm |
| 4    | 750 mm X 750 mm |
| 5    | 750 mm X 750 mm |

| SIZE | A  | B | C     | D   | E   | F | G      | H      | I     | J     | K     | L     | M     | N     | O   | P | Q | R | S | T | U     | V   | W | X | Y | Z | Area<br>sq. ft. | Area<br>m2 |
|------|----|---|-------|-----|-----|---|--------|--------|-------|-------|-------|-------|-------|-------|-----|---|---|---|---|---|-------|-----|---|---|---|---|-----------------|------------|
| 1    |    |   |       |     |     |   |        |        |       |       |       |       |       |       |     |   |   |   |   |   |       |     |   |   |   |   |                 |            |
| 2    | 21 |   | 1 1/8 | 3/8 | 3/8 |   | 7 1/2  | 7 1/8  | 5 5/8 | 5     | 4 1/4 | 5 1/4 | 3     | 2 5/8 | 1/2 |   |   |   |   |   | 1 1/2 | 1/2 |   |   |   |   | 3.06            | 0.28       |
| 3    | 30 |   | 1 3/8 | 1/2 | 5/8 |   | 10 3/4 | 10 1/4 | 8     | 7 1/4 | 6     | 7 1/2 | 4 1/4 | 3 3/4 | 3/4 |   |   |   |   |   | 1 7/8 | 1/2 |   |   |   |   | 6.25            | 0.56       |
| 4    | 30 |   | 1 3/8 | 1/2 | 5/8 |   | 10 3/4 | 10 1/4 | 8     | 7 1/4 | 6     | 7 1/2 | 4 1/4 | 3 3/4 | 3/4 |   |   |   |   |   | 1 7/8 | 1/2 |   |   |   |   | 6.25            | 0.56       |
| 5    | 30 |   | 1 3/8 | 1/2 | 5/8 |   | 10 3/4 | 10 1/4 | 8     | 7 1/4 | 6     | 7 1/2 | 4 1/4 | 3 3/4 | 3/4 |   |   |   |   |   | 1 7/8 | 1/2 |   |   |   |   | 6.25            | 0.56       |

PROJECT NO: 4867-03-70

HWY: CTH H

COUNTY: WASHINGTON

SIGN PLATES

SHEET NO:

E

STANDARD SIGN  
M6-1 & M6-2  
SERIES

WISCONSIN DEPT OF TRANSPORTATION

APPROVED


*Matthew R. Rauch*  
for State Traffic Engineer

DATE 3/16/10

PLATE NO. M6-1.12


NOTES

- 1. Sign is Type II - Type H Reflective
- 2. Color:
  - Background - White
  - Message - Black
- 3. Message Series - C
- 4. Corners may be square or rounded when base material is plywood but borders shall be rounded as shown. When base material is metal, the corners and borders shall be rounded.
- 5. Substitute appropriate numerals to nearest quarter mile and optically adjust spacing to achieve proper balance.

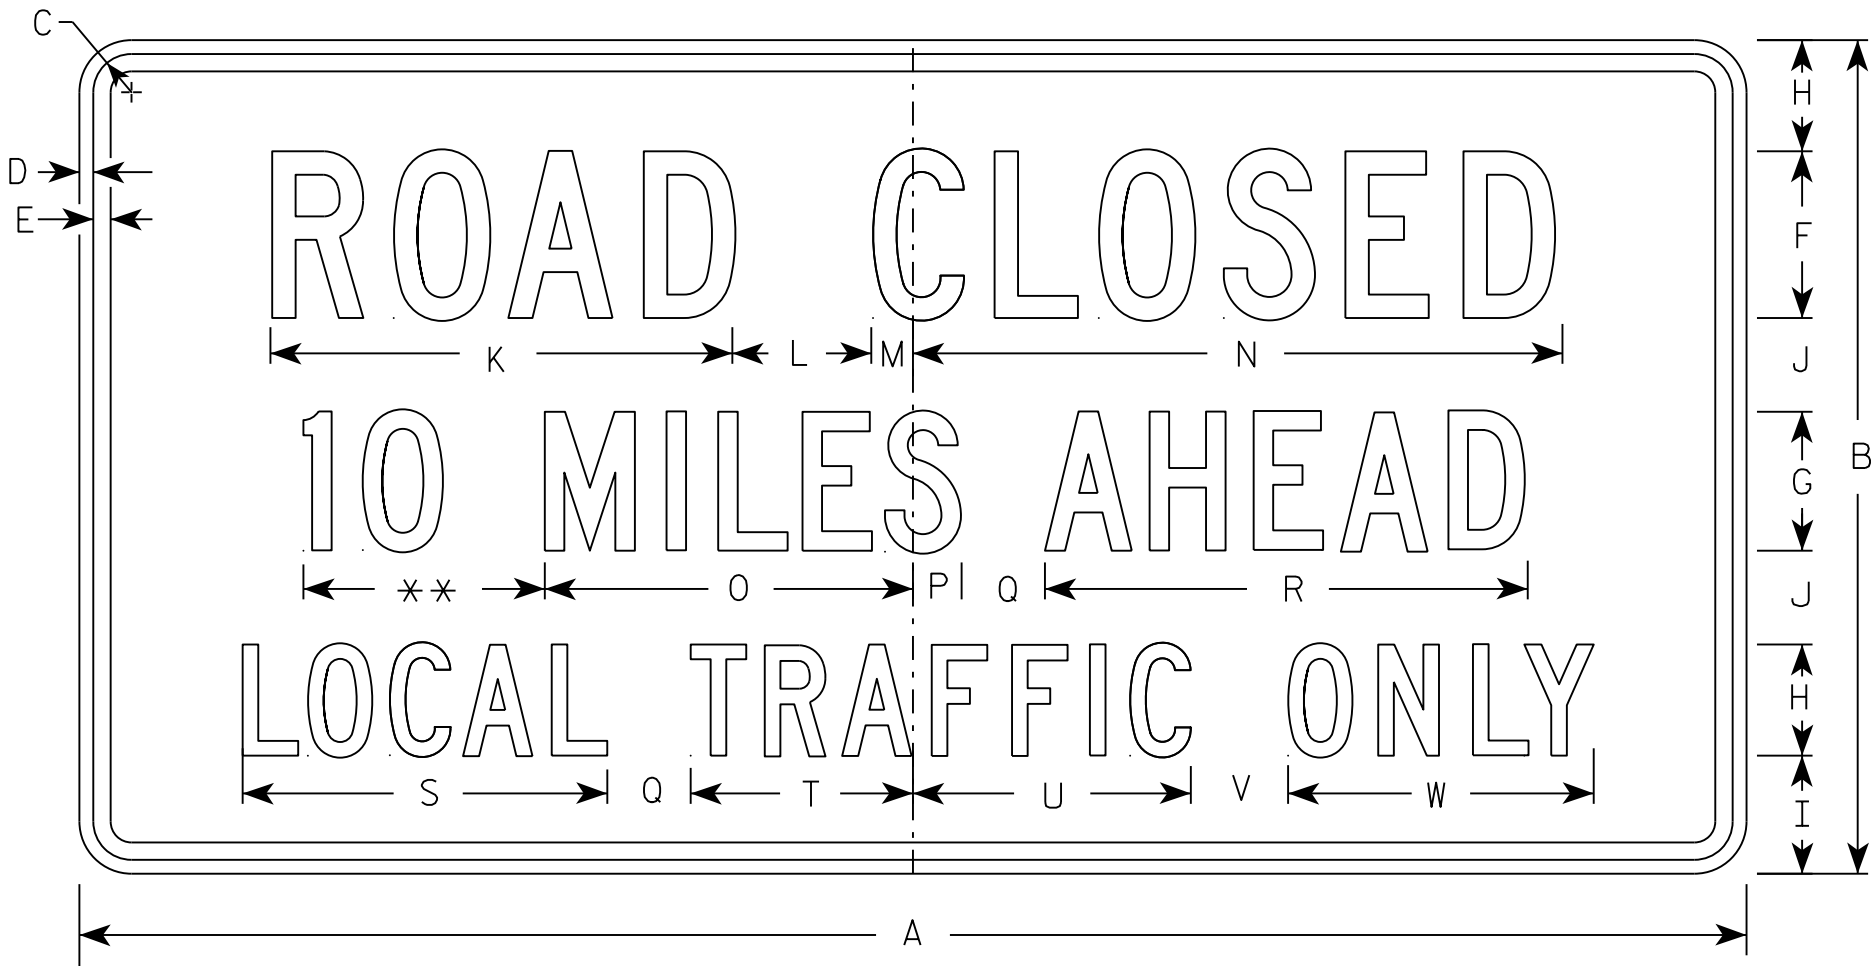

R11-3

\*\* See Note 5

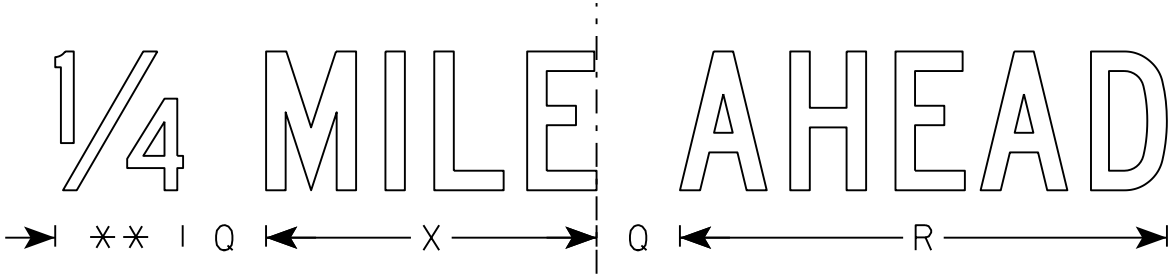


| SIZE | A  | B  | C     | D   | E   | F | G | H     | I     | J     | K      | L | M     | N      | O      | P     | Q | R      | S      | T     | U     | V     | W     | X      | Y | Z | Area<br>sq. ft. |
|------|----|----|-------|-----|-----|---|---|-------|-------|-------|--------|---|-------|--------|--------|-------|---|--------|--------|-------|-------|-------|-------|--------|---|---|-----------------|
| 1    | 36 | 18 | 1 3/8 | 1/2 | 5/8 | 4 | 3 | 2 1/2 | 2     | 2     | 11 1/8 | 3 | 1 1/8 | 15 1/4 | 8      | 1 1/2 | 2 | 10 3/4 | 8 3/8  | 4 3/4 | 6 1/2 | 2     | 6 3/4 | 7 1/8  |   |   | 4.5             |
| 2S   | 60 | 30 | 1 3/8 | 1/2 | 5/8 | 6 | 5 | 4     | 4 1/4 | 3 3/8 | 16 5/8 | 5 | 1 1/2 | 23     | 13 1/4 | 1 3/4 | 3 | 17 3/8 | 13 1/8 | 8     | 10    | 3 1/2 | 11    | 11 7/8 |   |   | 12.5            |
| 2M   | 60 | 30 | 1 3/8 | 1/2 | 5/8 | 6 | 5 | 4     | 4 1/4 | 3 3/8 | 16 5/8 | 5 | 1 1/2 | 23     | 13 1/4 | 1 3/4 | 3 | 17 3/8 | 13 1/8 | 8     | 10    | 3 1/2 | 11    | 11 7/8 |   |   | 12.5            |
| 3    |    |    | 4    |    |    | 5    |    |    
STANDARD SIGN  
R11-3

WISCONSIN DEPT OF TRANSPORTATION

APPROVED *Matthew R. Rauch*  
for State Traffic Engineer

DATE 3/15/17 PLATE NO. R11-3.8

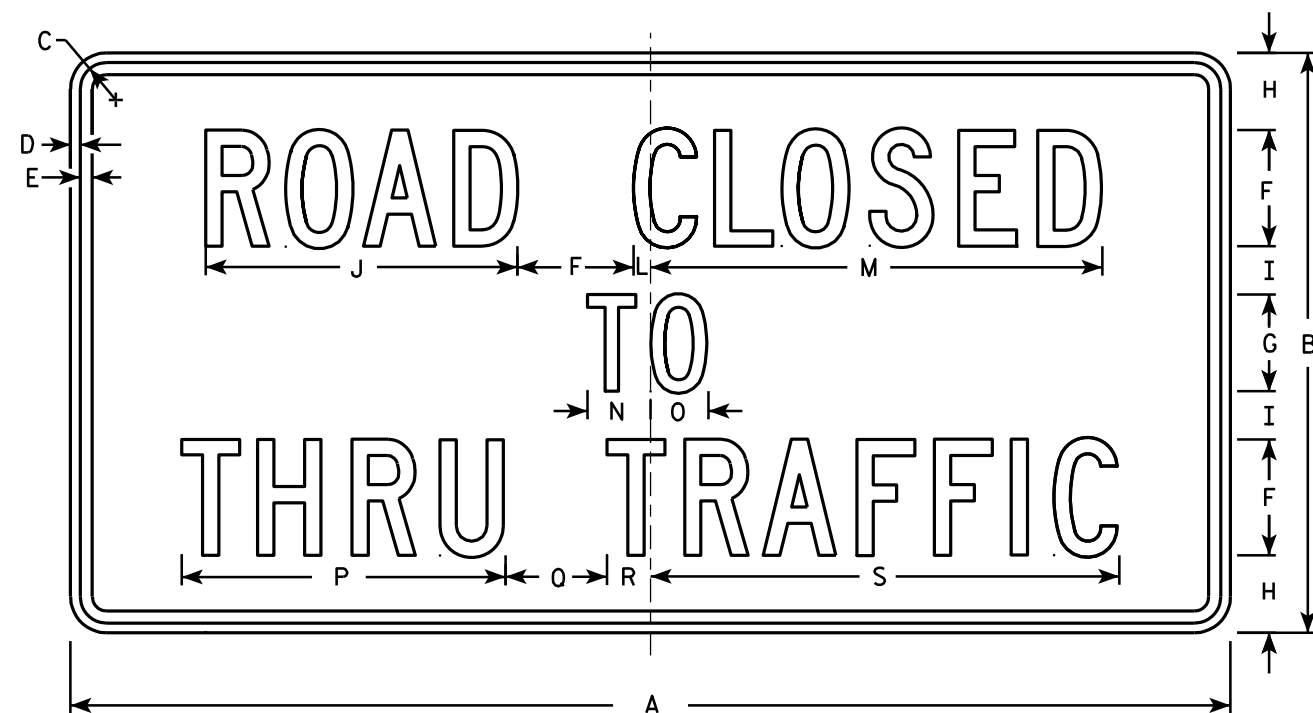

R11-4

NOTES

- 1. Sign is Type II - Type H Reflective - reference WIS DOT Standard Specification for HIGHWAY and STRUCTURE CONSTRUCTION latest edition.
- 2. Color:
  - Background - White
  - Message - Black
- 3. Message Series - C
- 4. Corners may be square or rounded when base material is plywood but borders shall be rounded as shown. When base material is metal, the corners and borders shall be rounded.


| SIZE | A  | B  | C     | D | E   | F | G | H | I   | J    | K | L   | M      | N   | O | P    | Q   | R   | S    | T | U | V | W | X | Y | Z | Area<br>sq. ft. |
|------|----|----|-------|---|-----|---|---|---|-----|------|---|-----|--------|-----|---|------|-----|-----|------|---|---|---|---|---|---|---|-----------------|
| 1    |    |    |       |   |     |   |   |   |     |      |   |     |        |     |   |      |     |     |      |   |   |   |   |   |   |   |                 |
| 2S   | 60 | 30 | 1 3⁄8 | ½ | 5⁄8 | 6 | 5 | 4 | 2 ½ | 16 ⅛ |   | 7⁄8 | 23 3⁄8 | 3 ¼ | 3 | 16 ¾ | 5 ¼ | 2 ¼ | 24 ¼ |   |   |   |   |   |   |   | 12.5            |
| 2M   | 60 | 30 | 1 3⁄8 | ½ | 5⁄8 | 6 | 5 | 4 | 2 ½ | 16 ⅛ |   | 7⁄8 | 23 3⁄8 | 3 ¼ | 3 | 16 ¾ | 5 ¼ | 2 ¼ | 24 ¼ |   |   |   |   |   |   |   | 12.5            |
| 3    |    |    |       |   |     |   |   |   |     |      |   |     |        |     |   |      |     |     |      |   |   |   |   |   |   |   |                 |
| 4    |    |    |       |   |     |   |   |   |     |      |   |     |        |     |   |      |     |     |      |   |   |   |   |   |   |   |                 |
| 5    |    |    |       |   |     |   |   |   |     |      |   |     |        |     |   |      |     |     |      |   |   |   |   |   |   |   |                 |

STANDARD SIGN  
R11 - 4


WISCONSIN DEPT OF TRANSPORTATION

APPROVED *Matthew R. Rauch*  
for State Traffic Engineer


DATE 4/1/11 PLATE NO. R11-4.3

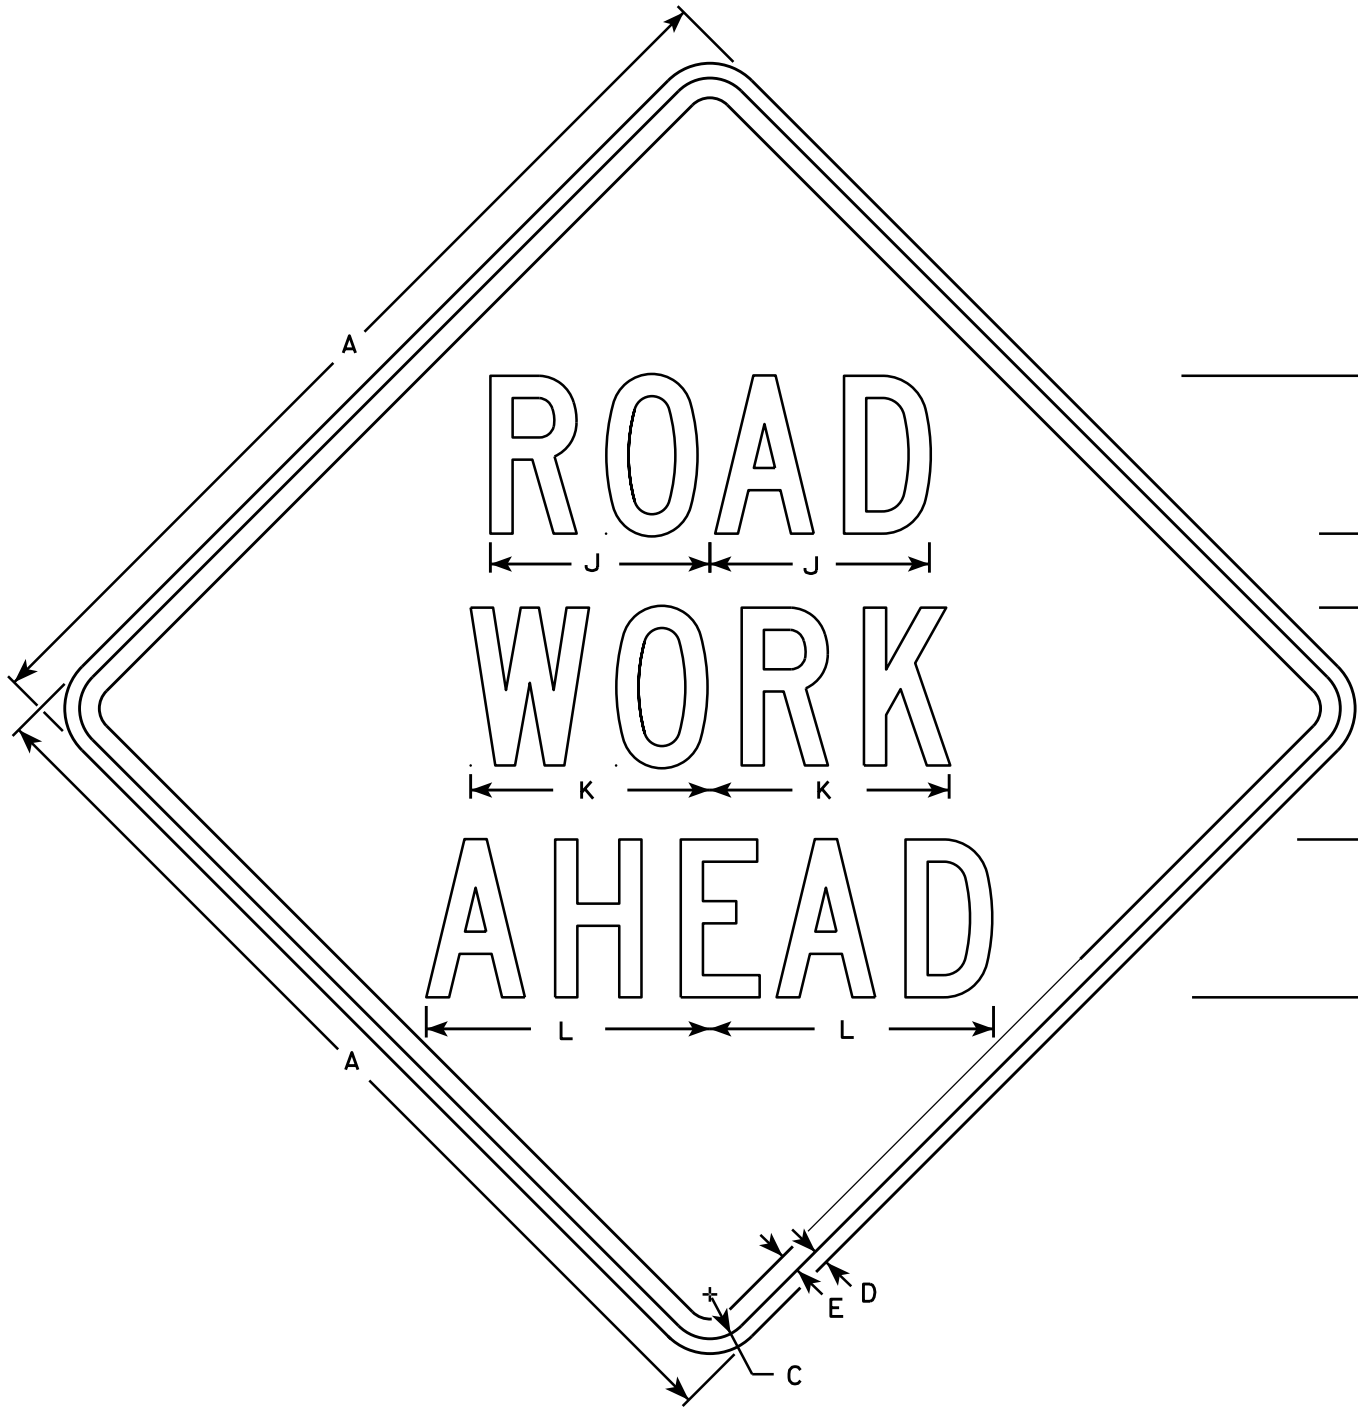


W20-1A

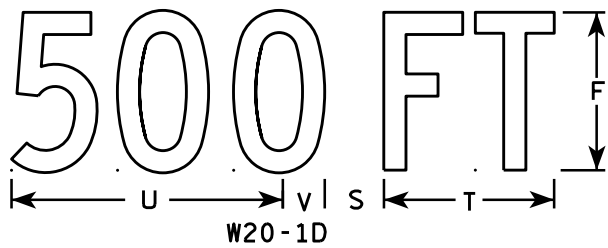

W20-1D

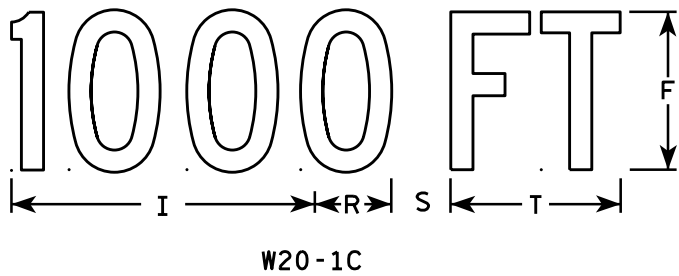


W20-1C

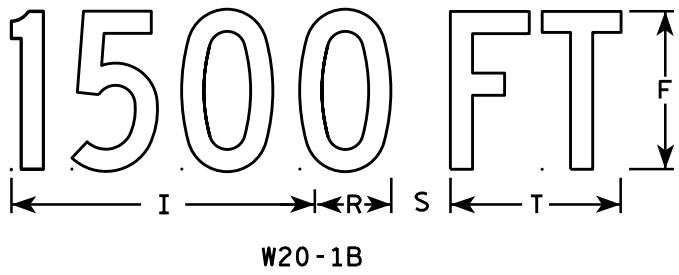


W20-1B



W20-1G

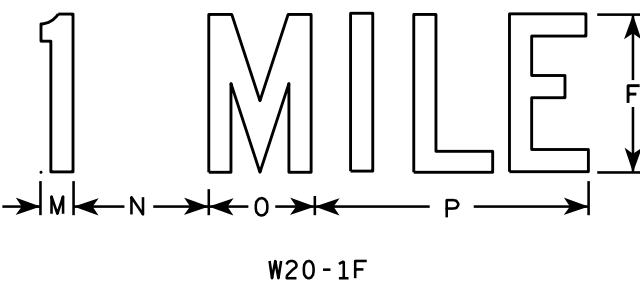

W20-1F

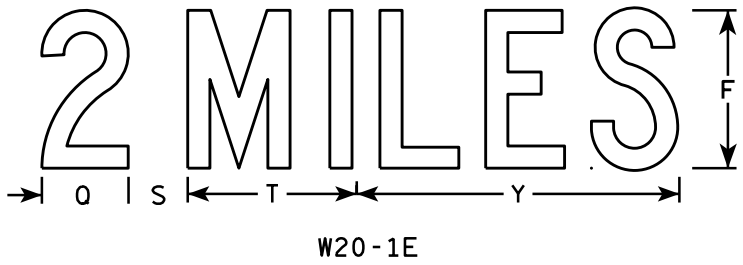

W20-1E

NOTES

- 1. Sign is Type II - Type F Reflective
- 2. Color:  
Background - Orange  
Message - Black
- 3. Message Series - C
- 4. Corners may be square or rounded when base material is plywood but borders shall be rounded as shown. When base material is metal, the corners and borders shall be rounded.

| SIZE | A  | B | C     | D   | E   | F | G     | H     | I      | J      | K      | L      | M     | N     | O     | P      | Q     | R     | S     | T     | U      | V     | W      | X     | Y      | Z | Area<br>sq. ft. |
|------|----|---|-------|-----|-----|---|-------|-------|--------|--------|--------|--------|-------|-------|-------|--------|-------|-------|-------|-------|--------|-------|--------|-------|--------|---|-----------------|
| 1    | 36 |   | 1 3/8 | 1/2 | 5/8 | 5 | 2 5/8 | 3 1/4 | 10 1/8 | 7      | 7 5/8  | 8 7/8  | 1 1/8 | 4 1/2 | 3 1/2 | 9      |       | 2 1/2 | 2 1/4 | 5 5/8 | 9      | 1 3/8 | 8      | 1 3/4 | 10 3/4 | 6 | 9.0             |
| 2S   | 48 |   | 2 1/4 | 3/4 | 1   | 8 | 3 3/4 | 5 1/8 | 15 3/8 | 11 1/8 | 12 1/8 | 14 3/8 | 1 5/8 | 6 7/8 | 5 3/8 | 13 7/8 | 4 3/8 | 3 7/8 | 3     | 8 5/8 | 13 3/4 | 2 1/8 | 11 7/8 | 2 3/4 | 16 3/8 | 9 | 16.0            |
| 2M   | 48 |   | 2 1/4 | 3/4 | 1   | 8 | 3 3/4 | 5 1/8 | 15 3/8 | 11 1/8 | 12 1/8 | 14 3/8 | 1 5/8 | 6 7/8 | 5 3/8 | 13 7/8 | 4 3/8 | 3 7/8 | 3     | 8 5/8 | 13 3/4 | 2 1/8 | 11 7/8 | 2 3/4 | 16 3/8 | 9 | 16.0            |
| 3    | 48 |   | 2 1/4 | 3/4 | 1   | 8 | 3 3/4 | 5 1/8 | 15 3/8 | 11 1/8 | 12 1/8 | 14 3/8 | 1 5/8 | 6 7/8 | 5 3/8 | 13 7/8 | 4 3/8 | 3 7/8 | 3     | 8 5/8 | 13 3/4 | 2 1/8 | 11 7/8 | 2 3/4 | 16 3/8 | 9 | 16.0            |
| 4    | 48 |   | 2 1/4 | 3/4 | 1   | 8 | 3 3/4 | 5 1/8 | 15 3/8 | 11 1/8 | 12 1/8 | 14 3/8 | 1 5/8 | 6 7/8 | 5 3/8 | 13 7/8 | 4 3/8 | 3 7/8 | 3     | 8 5/8 | 13 3/4 | 2 1/8 | 11 7/8 | 2 3/4 | 16 3/8 | 9 | 16.0            |
| 5    | 48 |   | 2 1/4 | 3/4 | 1   | 8 | 3 3/4 | 5 1/8 | 15 3/8 | 11 1/8 | 12 1/8 | 14 3/8 | 1 5/8 | 6 7/8 | 5 3/8 | 13 7/8 | 4 3/8 | 3 7/8 | 3     | 8 5/8 | 13 3/4 | 2 1/8 | 11 7/8 | 2 3/4 | 16 3/8 | 9 | 16.0            |

4867-03-70

CTHH

WASHINGTON

SIGN PLATES







STANDARD SIGN  
W20-1A, B, C, D, F & G

WISCONSIN DEPT OF TRANSPORTATION

APPROVED

State Traffic Engineer

DATE 5/07/15 PLATE NO. W20-1.10

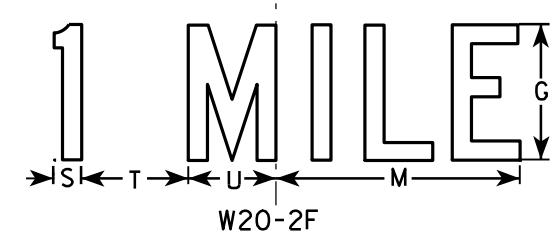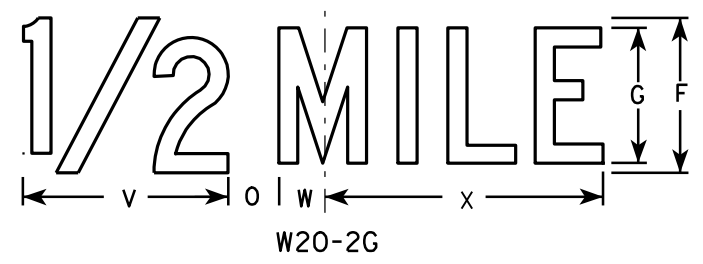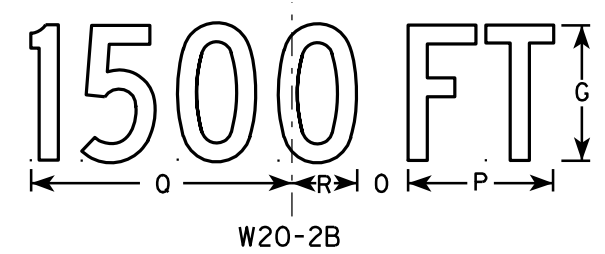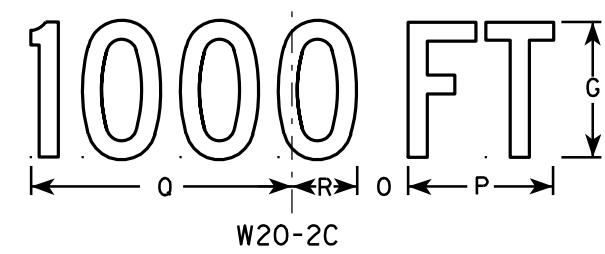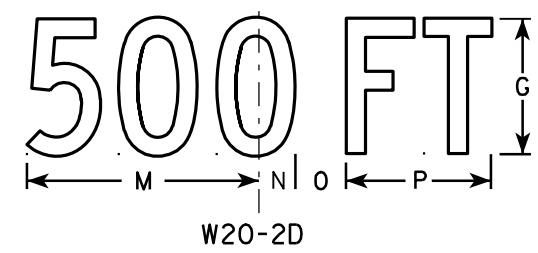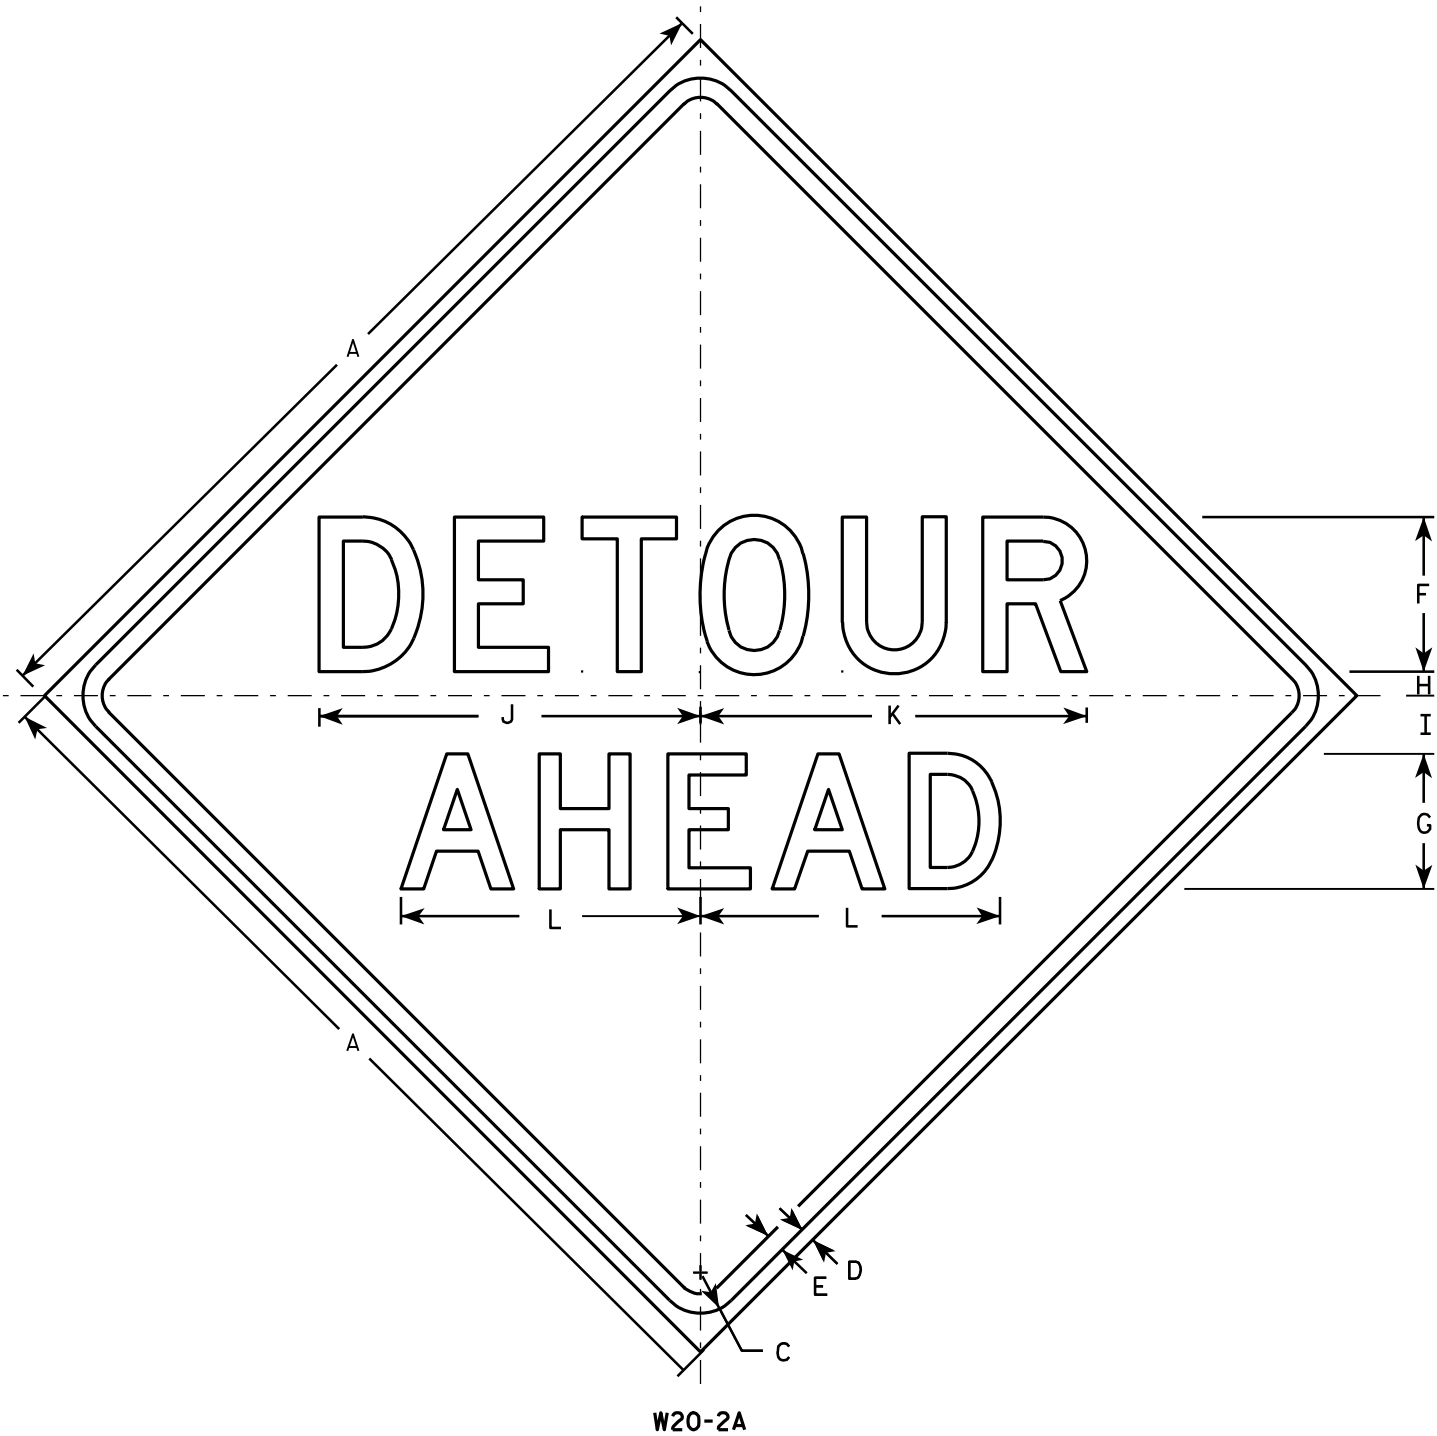

NOTES

1. Sign is Type II - Type F Reflective - reference WIS DOT Standard Specification for HIGHWAY and STRUCTURE CONSTRUCTION latest edition.
2. Color:  
Background - Orange  
Message - Black
3. Message Series - See note 5
4. Corners may be square or rounded when base material is plywood but borders shall be rounded as shown. When base material is metal, the corners and borders shall be rounded.
5. Line 1 is Series D.  
Line 2 is Series D for AHEAD and Series C for all other distances.


| SIZE | A  | B | C     | D   | E   | F | G | H     | I     | J      | K  | L      | M  | N     | O     | P     | Q      | R     | S     | T     | U     | V      | W     | X      | Y | Z | Area<br>sq. ft. |
|------|----|---|-------|-----|-----|---|---|-------|-------|--------|----|--------|----|-------|-------|-------|--------|-------|-------|-------|-------|--------|-------|--------|---|---|-----------------|
| 1    | 36 |   | 1 5/8 | 5/8 | 3/4 | 6 | 5 | 1     | 2 1/4 | 14 3/4 | 15 | 11 5/8 | 9  | 1 3/8 | 1 7/8 | 5 5/8 | 10 1/8 | 2 1/2 | 1 1/8 | 4 1/2 | 3 1/2 | 8      | 1 3/4 | 10 3/4 |   |   | 9.0             |
| 2S   | 48 |   | 2 1/4 | 3/4 | 1   | 8 | 7 | 1 1/4 | 3     | 19 3/4 | 20 | 15 1/2 | 12 | 1 7/8 | 2 5/8 | 7 1/2 | 13 1/2 | 3 3/8 | 1 1/2 | 6     | 4 5/8 | 10 5/8 | 2 3/8 | 14 3/8 |   |   | 16.0            |
| 2M   | 48 |   | 2 1/4 | 3/4 | 1   | 8 | 7 | 1 1/4 | 3     | 19 3/4 | 20 | 15 1/2 | 12 | 1 7/8 | 2 5/8 | 7 1/2 | 13 1/2 | 3 3/8 | 1 1/2 | 6     | 4 5/8 | 10 5/8 | 2 3/8 | 14 3/8 |   |   | 16.0            |
| 3    | 48 |   | 2 1/4 | 3/4 | 1   | 8 | 7 | 1 1/4 | 3     | 19 3/4 | 20 | 15 1/2 | 12 | 1 7/8 | 2 5/8 | 7 1/2 | 13 1/2 | 3 3/8 | 1 1/2 | 6     | 4 5/8 | 10 5/8 | 2 3/8 | 14 3/8 |   |   | 16.0            |
| 4    | 48 |   | 2 1/4 | 3/4 | 1   | 8 | 7 | 1 1/4 | 3     | 19 3/4 | 20 | 15 1/2 | 12 | 1 7/8 | 2 5/8 | 7 1/2 | 13 1/2 | 3 3/8 | 1 1/2 | 6     | 4 5/8 | 10 5/8 | 2 3/8 | 14 3/8 |   |   | 16.0            |
| 5    | 48 |   | 2 1/4 | 3/4 | 1   | 8 | 7 | 1 1/4 | 3     | 19 3/4 | 20 | 15 1/2 | 12 | 1 7/8 | 2 5/8 | 7 1/2 | 13 1/2 | 3 3/8 | 1 1/2 | 6     | 4 5/8 | 10 5/8 | 2 3/8 | 14 3/8 |   |   | 16.0            |

STANDARD SIGN  
W20-2A,B,C,D,F & G

WISCONSIN DEPT OF TRANSPORTATION

APPROVED *Matthew R. Rauch*  
for State Traffic Engineer

DATE 3/18/11 PLATE NO. W20-2.6

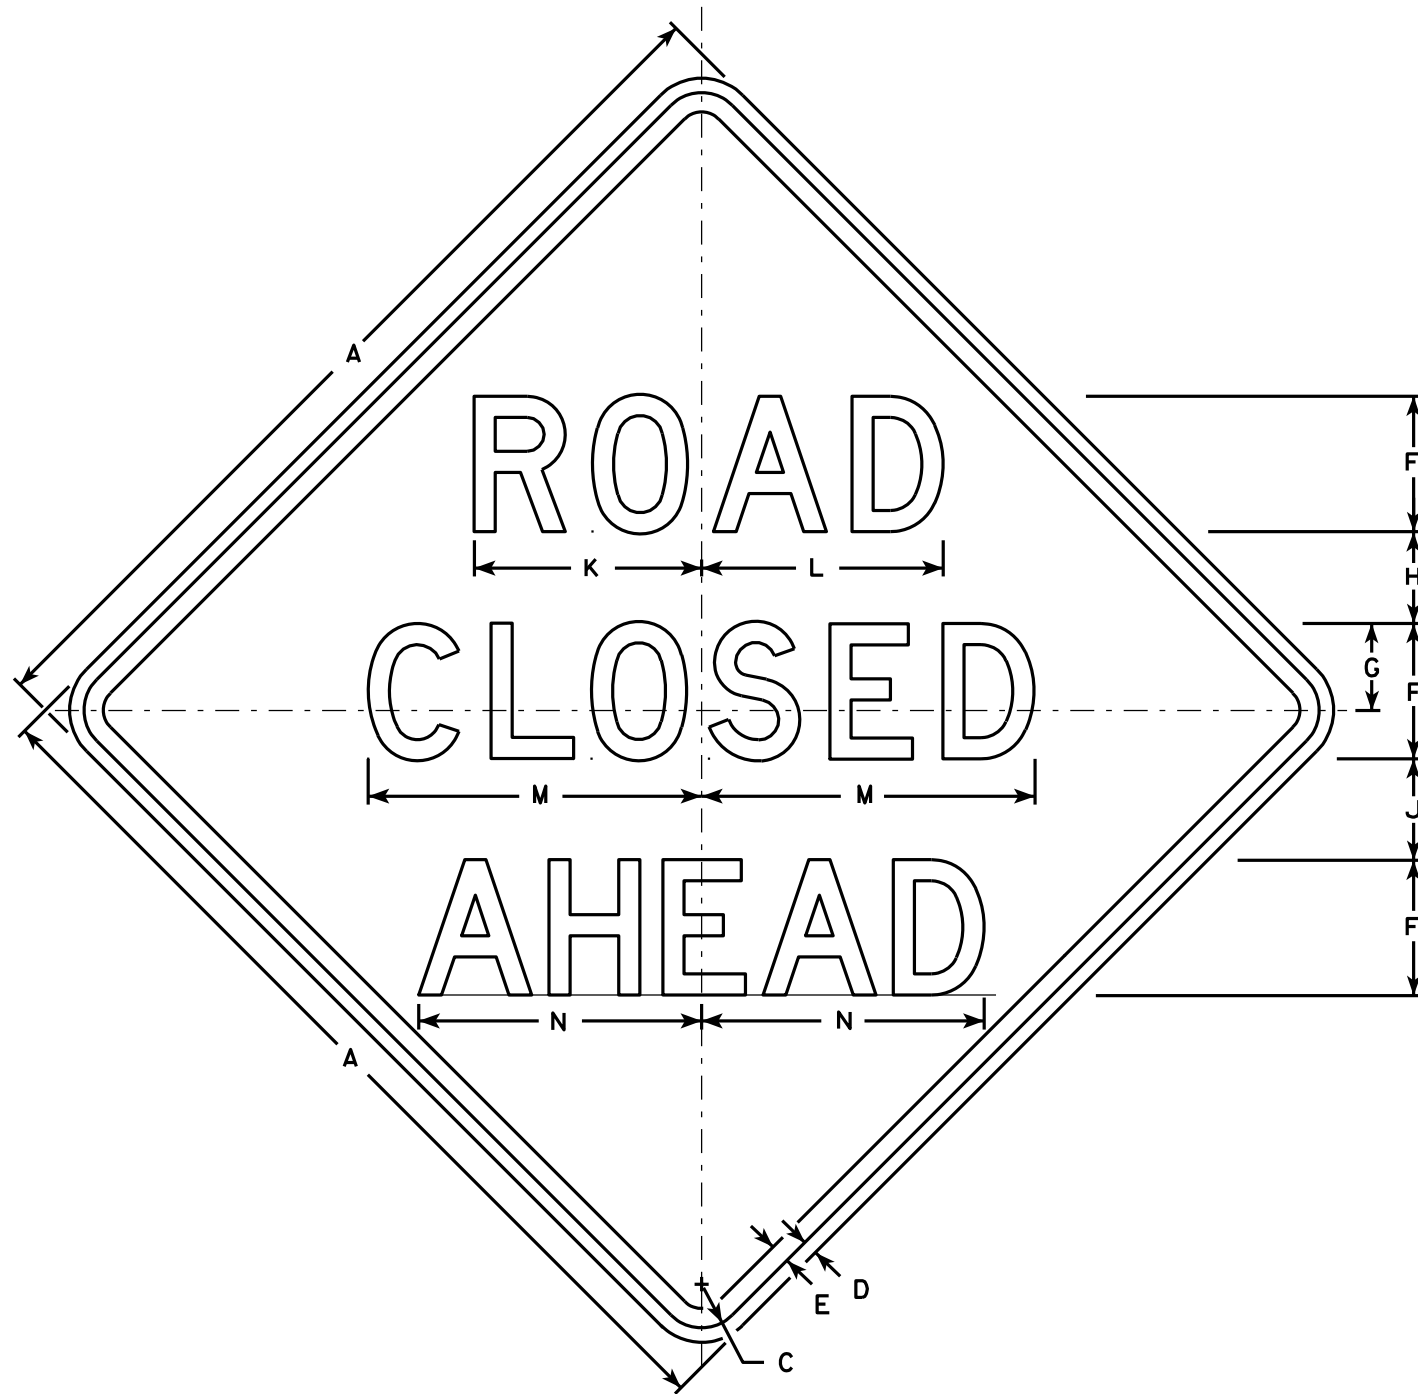

W20-3A

500 FT

W20-3D

1000 FT

W20-3C

1500 FT

W20-3B

1/2 MILE

W20-3G

1 MILE

W20-3F

**NOTES**

1. Sign is Type II - Type F Reflective - reference WIS DOT Standard Specification for HIGHWAY and STRUCTURE CONSTRUCTION latest edition.
2. Color:  
Background - Orange  
Message - Black
3. Message Series - see note 5
4. Corners may be square or rounded when base material is plywood but borders shall be rounded as shown. When base material is metal, the corners and borders shall be rounded.
5. Lines 1 and 2 are Series D.  
Line 3 is Series D for AHEAD and Series C for all other distances.

| SIZE | A  | B | C     | D   | E   | F | G     | H     | I     | J     | K      | L      | M      | N      | O  | P | Q      | R     | S     | T     | U      | V     | W     | X     | Y      | Z     | Area<br>sq. ft. |
|------|----|---|-------|-----|-----|---|-------|-------|-------|-------|--------|--------|--------|--------|----|---|--------|-------|-------|-------|--------|-------|-------|-------|--------|-------|-----------------|
| 1    | 36 |   | 1 5/8 | 5/8 | 3/4 | 5 | 3 3/8 | 3 1/2 | 1 1/8 | 4     | 8 3/8  | 8 7/8  | 12 1/2 | 11     | 9  | 6 | 10 1/8 | 2 1/2 | 1 7/8 | 5 5/8 | 8      | 1 3/8 | 4 1/2 | 3 1/2 | 10 3/4 | 1 3/4 | 9.0             |
| 2S   | 48 |   | 2 1/4 | 3/4 | 1   | 7 | 4 1/2 | 4 3/4 | 1 1/2 | 5 1/4 | 11 3/4 | 12 1/2 | 17 1/4 | 14 5/8 | 12 | 8 | 13 1/2 | 3 3/8 | 2 5/8 | 7 1/2 | 10 5/8 | 1 7/8 | 6     | 4 5/8 | 14 3/8 | 2 3/8 | 16.0            |
| 2M   | 48 |   | 2 1/4 | 3/4 | 1   | 7 | 4 1/2 | 4 3/4 | 1 1/2 | 5 1/4 | 11 3/4 | 12 1/2 | 17 1/4 | 14 5/8 | 12 | 8 | 13 1/2 | 3 3/8 | 2 5/8 | 7 1/2 | 10 5/8 | 1 7/8 | 6     | 4 5/8 | 14 3/8 | 2 3/8 | 16.0            |
| 3    | 48 |   | 2 1/4 | 3/4 | 1   | 7 | 4 1/2 | 4 3/4 | 1 1/2 | 5 1/4 | 11 3/4 | 12 1/2 | 17 1/4 | 14 5/8 | 12 | 8 | 13 1/2 | 3 3/8 | 2 5/8 | 7 1/2 | 10 5/8 | 1 7/8 | 6     | 4 5/8 | 14 3/8 | 2 3/8 | 16.0            |
| 4    | 48 |   | 2 1/4 | 3/4 | 1   | 7 | 4 1/2 | 4 3/4 | 1 1/2 | 5 1/4 | 11 3/4 | 12 1/2 | 17 1/4 | 14 5/8 | 12 | 8 | 13 1/2 | 3 3/8 | 2 5/8 | 7 1/2 | 10 5/8 | 1 7/8 | 6     | 4 5/8 | 14 3/8 | 2 3/8 | 16.0            |
| 5    | 48 |   | 2 1/4 | 3/4 | 1   | 7 | 4 1/2 | 4 3/4 | 1 1/2 | 5 1/4 | 11 3/4 | 12 1/2 | 17 1/4 | 14 5/8 | 12 | 8 | 13 1/2 | 3 3/8 | 2 5/8 | 7 1/2 | 10 5/8 | 1 7/8 | 6     | 4 5/8 | 14 3/8 | 2 3/8 | 16.0            |

STANDARD SIGN  
W20-3A, B, C, D, F & G

WISCONSIN DEPT OF TRANSPORTATION  
APPROVED *Matthew R. Rauch*  
For State Traffic Engineer  
DATE 3/18/11 PLATE NO. W20-3.7

PROJECT NO: 4867-03-70







HWY: CTH H

COUNTY: WASHINGTON

SIGN PLATES

SHEET NO:

E

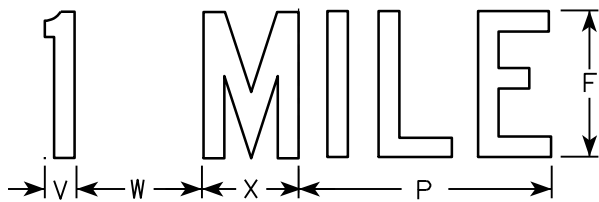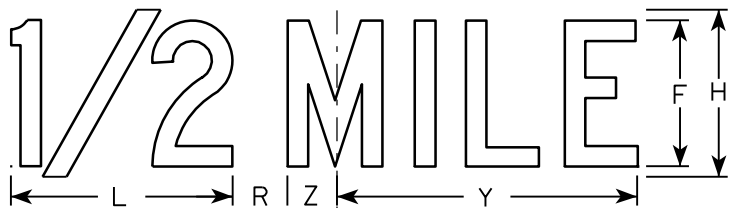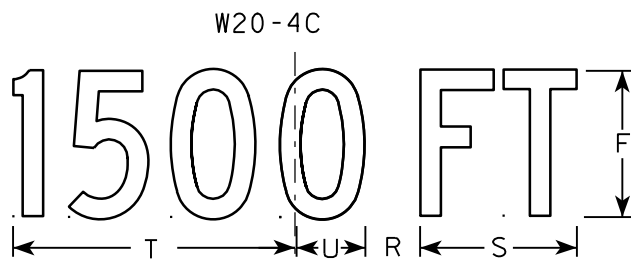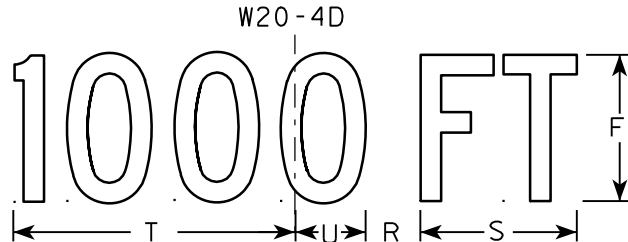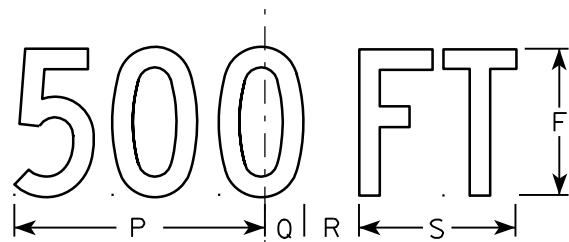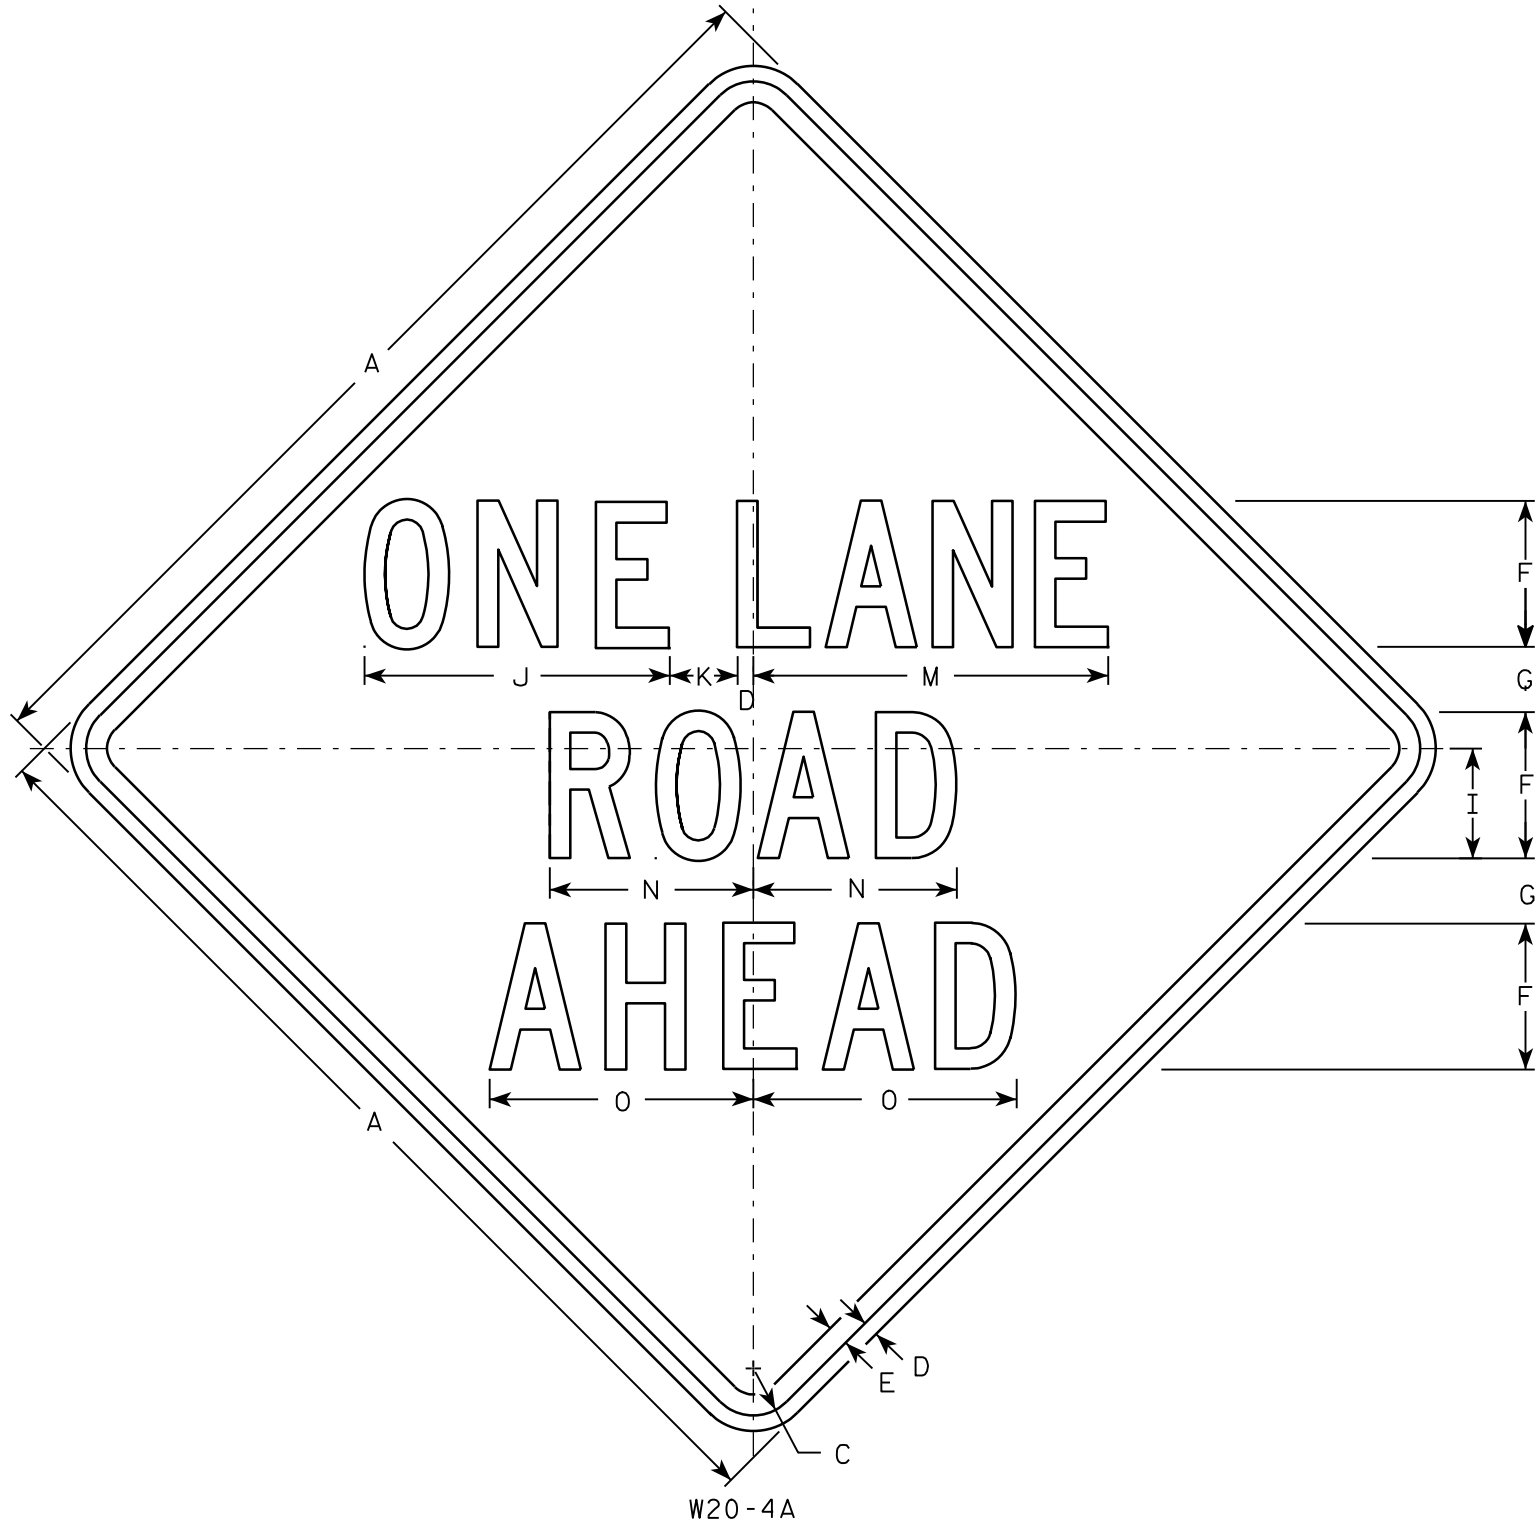

NOTES

- 1. Sign is Type II - Type F Reflective - reference WIS DOT Standard Specification for HIGHWAY and STRUCTURE CONSTRUCTION latest edition.
- 2. Color:
  - Background - Orange
  - Message - Black
- 3. Message Series - C
- 4. Corners may be square or rounded when base material is plywood but borders shall be rounded as shown. When base material is metal, the corners and borders shall be rounded.


| SIZE | A  | B | C     | D   | E   | F | G     | H | I     | J      | K     | L      | M      | N     | O      | P  | Q     | R     | S     | T      | U     | V     | W     | X     | Y      | Z     | Area<br>sq. ft. |
|------|----|---|-------|-----|-----|---|-------|---|-------|--------|-------|--------|--------|-------|--------|----|-------|-------|-------|--------|-------|-------|-------|-------|--------|-------|-----------------|
| 1    | 36 |   | 1 5⁄8 | 5⁄8 | 3⁄4 | 5 | 2 3⁄8 | 6 | 3 3⁄4 | 10 3⁄8 | 2 3⁄8 | 8      | 13 1⁄2 | 7     | 8 7⁄8  | 9  | 1 3⁄8 | 1 7⁄8 | 5 5⁄8 | 10 1⁄8 | 2 1⁄2 | 1 1⁄8 | 4 1⁄2 | 3 1⁄2 | 10 3⁄4 | 1 3⁄4 | 9.0             |
| 2S   | 48 |   | 2 1⁄4 | 3⁄4 | 1   | 7 | 3 1⁄8 | 8 | 5 1⁄4 | 14 5⁄8 | 3 1⁄4 | 10 5⁄8 | 17 3⁄4 | 9 3⁄4 | 12 5⁄8 | 12 | 1 7⁄8 | 2 5⁄8 | 7 1⁄2 | 13 1⁄2 | 3 3⁄8 | 1 1⁄2 | 6     | 4 5⁄8 | 14 3⁄8 | 2 3⁄8 | 16.0            |
| 2M   | 48 |   | 2 1⁄4 | 3⁄4 | 1   | 7 | 3 1⁄8 | 8 | 5 1⁄4 | 14 5⁄8 | 3 1⁄4 | 10 5⁄8 | 17 3⁄4 | 9 3⁄4 | 12 5⁄8 | 12 | 1 7⁄8 | 2 5⁄8 | 7 1⁄2 | 13 1⁄2 | 3 3⁄8 | 1 1⁄2 | 6     | 4 5⁄8 | 14 3⁄8 | 2 3⁄8 | 16.0            |
| 3    | 48 |   | 2 1⁄4 | 3⁄4 | 1   | 7 | 3 1⁄8 | 8 | 5 1⁄4 | 14 5⁄8 | 3 1⁄4 | 10 5⁄8 | 17 3⁄4 | 9 3⁄4 | 12 5⁄8 | 12 | 1 7⁄8 | 2 5⁄8 | 7 1⁄2 | 13 1⁄2 | 3 3⁄8 | 1 1⁄2 | 6     | 4 5⁄8 | 14 3⁄8 | 2 3⁄8 | 16.0            |
| 4    | 48 |   | 2 1⁄4 | 3⁄4 | 1   | 7 | 3 1⁄8 | 8 | 5 1⁄4 | 14 5⁄8 | 3 1⁄4 | 10 5⁄8 | 17 3⁄4 | 9 3⁄4 | 12 5⁄8 | 12 | 1 7⁄8 | 2 5⁄8 | 7 1⁄2 | 13 1⁄2 | 3 3⁄8 | 1 1⁄2 | 6     | 4 5⁄8 | 14 3⁄8 | 2 3⁄8 | 16.0            |
| 5    | 48 |   | 2 1⁄4 | 3⁄4 | 1   | 7 | 3 1⁄8 | 8 | 5 1⁄4 | 14 5⁄8 | 3 1⁄4 | 10 5⁄8 | 17 3⁄4 | 9 3⁄4 | 12 5⁄8 | 12 | 1 7⁄8 | 2 5⁄8 | 7 1⁄2 | 13 1⁄2 | 3 3⁄8 | 1 1⁄2 | 6     | 4 5⁄8 | 14 3⁄8 | 2 3⁄8 | 16.0            |

STANDARD SIGN  
W20-4A, B, C, D, F & G

WISCONSIN DEPT OF TRANSPORTATION

APPROVED *Matthew R. Rauch*  
for State Traffic Engineer

DATE 3/18/11 PLATE NO. W20-4.9

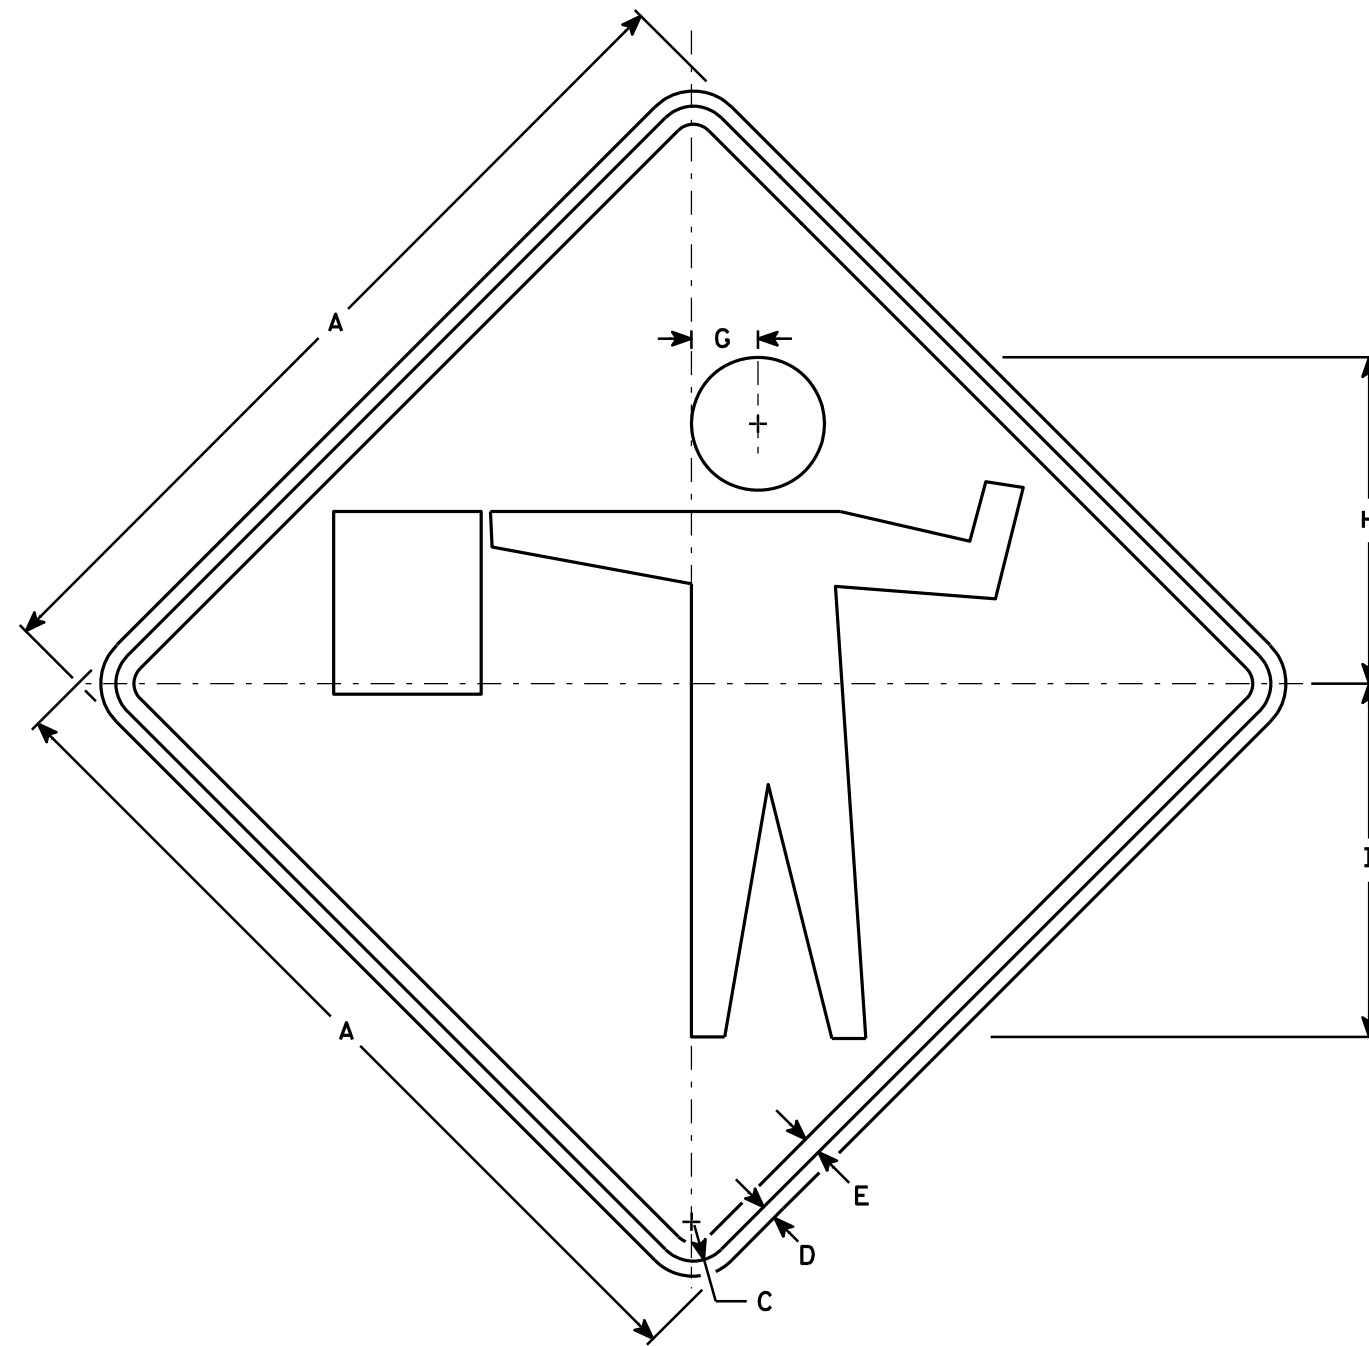

W20-7A

NOTES

1. Sign is Type II - Type F Reflective - reference WIS DOT Standard Specification for HIGHWAY and STRUCTURE CONSTRUCTION latest edition.
2. Color:  
Background - Orange  
Message - Black
3. Corners may be square or rounded when base material is plywood but borders shall be rounded as shown. When base material is metal, the corners and borders shall be rounded.

| SIZE | A  | B | C     | D   | E   | F | G     | H      | I      | J | K | L | M | N | O | P | Q | R | S | T | U | V | W | X | Y | Z | Area<br>sq. ft. |
|------|----|---|-------|-----|-----|---|-------|--------|--------|---|---|---|---|---|---|---|---|---|---|---|---|---|---|---|---|---|-----------------|
| 1    | 36 |   | 1 5/8 | 5/8 | 3/4 |   | 2 3/4 | 13 1/2 | 14 5/8 |   |   |   |   |   |   |   |   |   |   |   |   |   |   |   |   |   | 9.00            |
| 2S   | 48 |   | 2 1/4 | 3/4 | 1   |   | 3 3/4 | 18     | 19 1/2 |   |   |   |   |   |   |   |   |   |   |   |   |   |   |   |   |   | 16.00           |
| 2M   | 48 |   | 2 1/4 | 3/4 | 1   |   | 3 3/4 | 18     | 19 1/2 |   |   |   |   |   |   |   |   |   |   |   |   |   |   |   |   |   | 16.00           |
| 3    | 48 |   | 2 1/4 | 3/4 | 1   |   | 3 3/4 | 18     | 19 1/2 |   |   |   |   |   |   |   |   |   |   |   |   |   |   |   |   |   | 16.00           |
| 4    | 48 |   | 2 1/4 | 3/4 | 1   |   | 3 3/4 | 18     | 19 1/2 |   |   |   |   |   |   |   |   |   |   |   |   |   |   |   |   |   | 16.00           |
| 5    | 48 |   | 2 1/4 | 3/4 | 1   |   | 3 3/4 | 18     | 19 1/2 |   |   |   |   |   |   |   |   |   |   |   |   |   |   |   |   |   | 16.00           |

STANDARD SIGN  
W20-7A

WISCONSIN DEPT OF TRANSPORTATION

APPROVED *Matthew R. Rauch*  
for State Traffic Engineer

DATE 3/18/11 PLATE NO. W20-7A.5

PROJECT NO: 4867-03-70


HWY: CTH H

COUNTY: WASHINGTON

SIGN PLATES

SHEET NO:

E

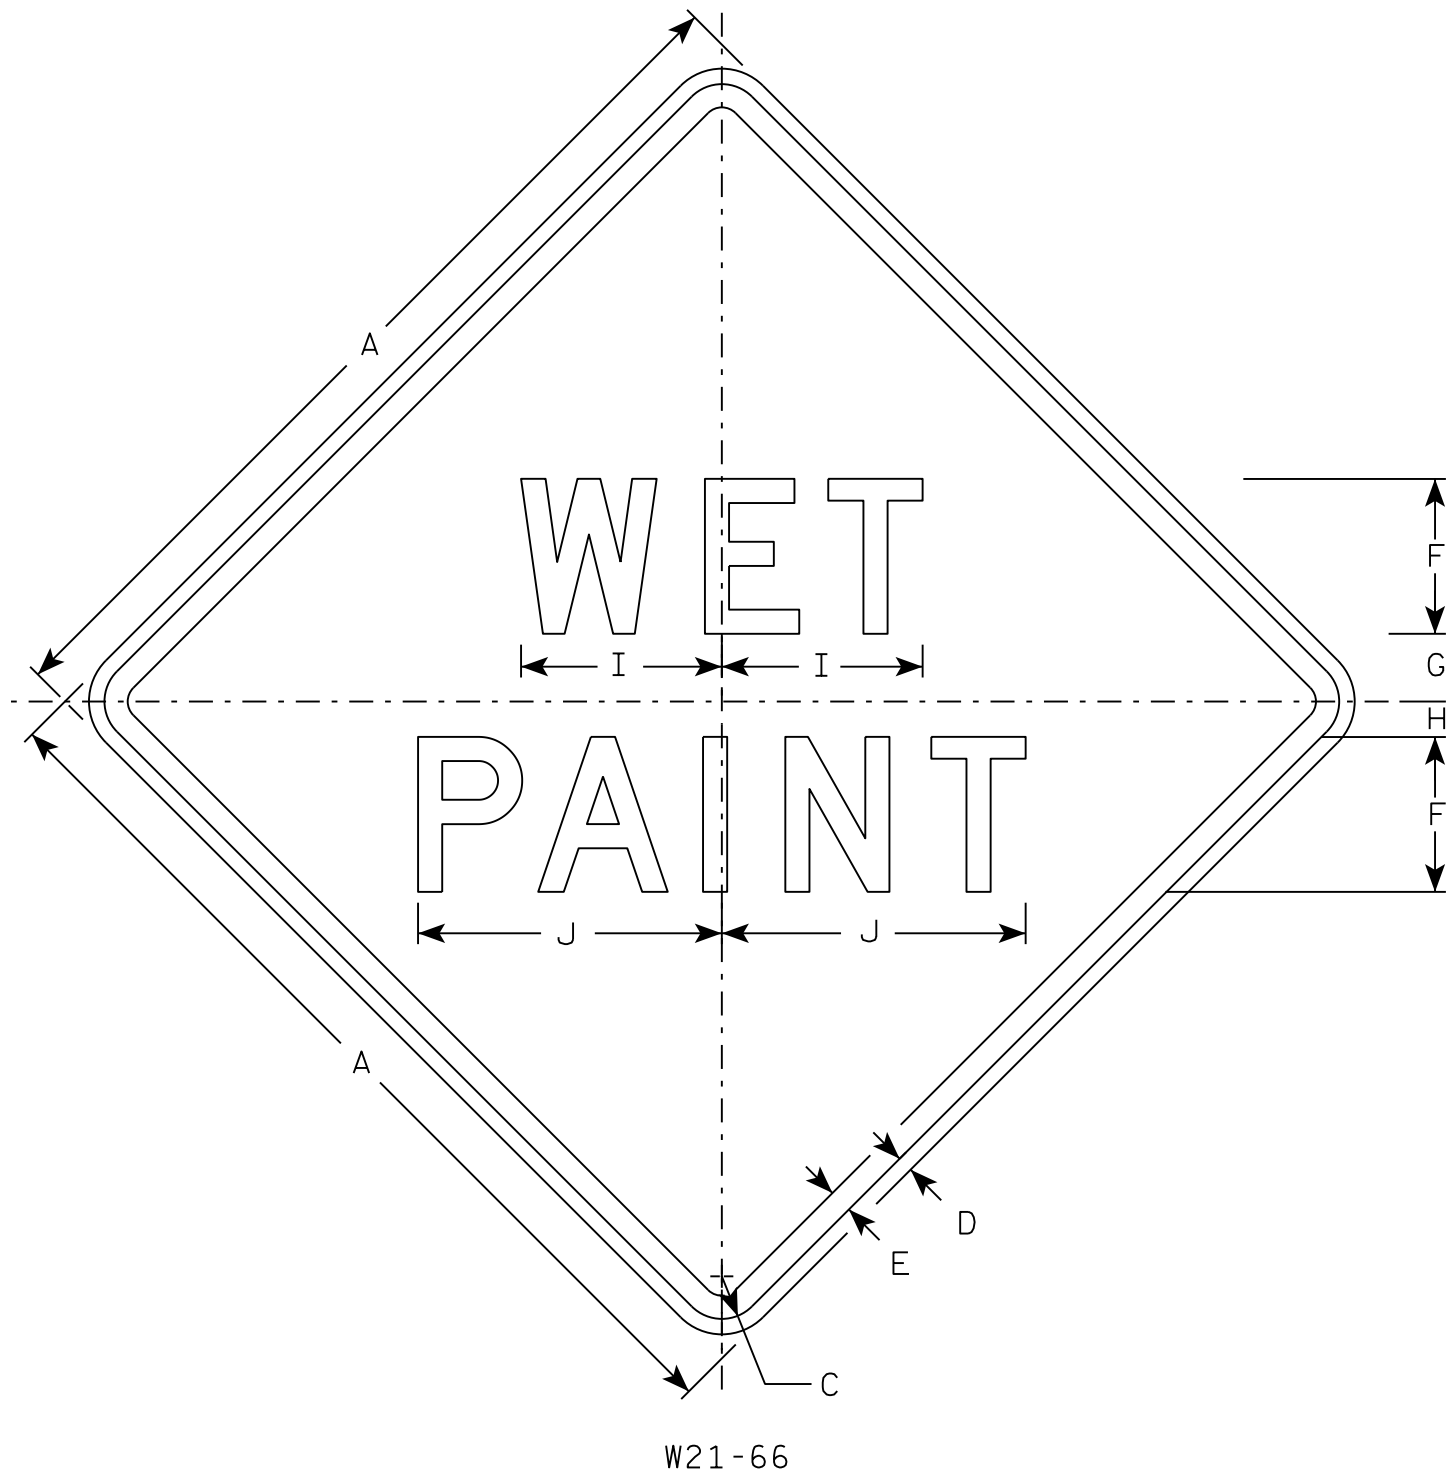

NOTES

- 1. Sign is Type II - Type F Reflective
- 2. Color:  
Background - Orange  
Message - Black
- 3. Message Series - D
- 4. Corners may be square or rounded when base material is plywood but borders shall be rounded as shown. When base material is metal, the corners and borders shall be rounded.

| SIZE | A  | B | C     | D   | E   | F | G     | H     | I      | J      | K | L | M | N | O | P | Q | R | S | T | U | V | W | X | Y | Z | Area<br>sq. ft. |
|------|----|---|-------|-----|-----|---|-------|-------|--------|--------|---|---|---|---|---|---|---|---|---|---|---|---|---|---|---|---|-----------------|
| 1    | 36 |   | 1 5/8 | 5/8 | 3/4 | 6 | 2 5/8 | 1 3/8 | 7 3/4  | 11 3/4 |   |   |   |   |   |   |   |   |   |   |   |   |   |   |   |   | 9.0             |
| 2S   | 48 |   | 2 1/4 | 3/4 | 1   | 8 | 3     | 3     | 10 3/8 | 15 3/4 |   |   |   |   |   |   |   |   |   |   |   |   |   |   |   |   | 16.0            |
| 2M   | 48 |   | 2 1/4 | 3/4 | 1   | 8 | 3     | 3     | 10 3/8 | 15 3/4 |   |   |   |   |   |   |   |   |   |   |   |   |   |   |   |   | 16.0            |
| 3    | 48 |   | 2 1/4 | 3/4 | 1   | 8 | 3     | 3     | 10 3/8 | 15 3/4 |   |   |   |   |   |   |   |   |   |   |   |   |   |   |   |   | 16.0            |
| 4    | 48 |   | 2 1/4 | 3/4 | 1   | 8 | 3     | 3     | 10 3/8 | 15 3/4 |   |   |   |   |   |   |   |   |   |   |   |   |   |   |   |   | 16.0            |
| 5    | 48 |   | 2 1/4 | 3/4 | 1   | 8 | 3     | 3     | 10 3/8 | 15 3/4 |   |   |   |   |   |   |   |   |   |   |   |   |   |   |   |   | 16.0            |


STANDARD SIGN

W21-66

WISCONSIN DEPT OF TRANSPORTATION

APPROVED *Matthew R. Rauch*  
For State Traffic Engineer

DATE 3/19/18 PLATE NO. W21-66.1

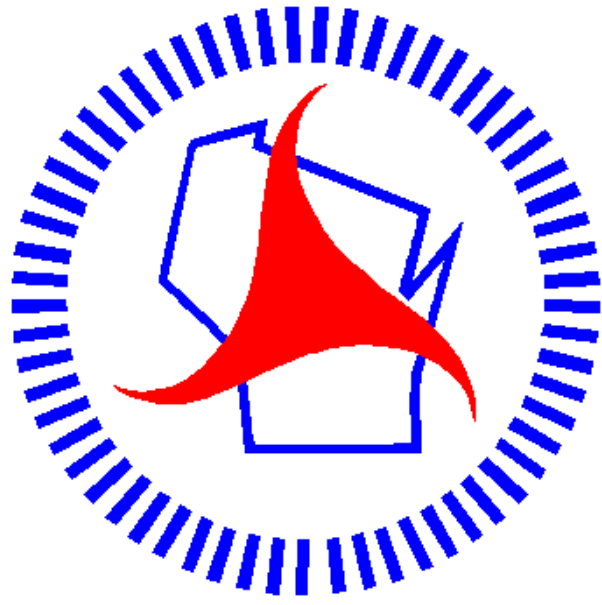

## ***Wisconsin Department of Transportation***

Dedicated people creating transportation solutions  
through innovation and exceptional service.

<http://www.dot.wisconsin.gov>