


STATE PROJECT NUMBER	SHEET NO.
1226-1-61	5/
LIGHTING LAYOUT	
NORTHBOUND REST AREA 52	
I.H. 43	MANITOWOC CO.

15' X 1300
20' X 600
15' X 801
15' X 700
150' X 5' 00

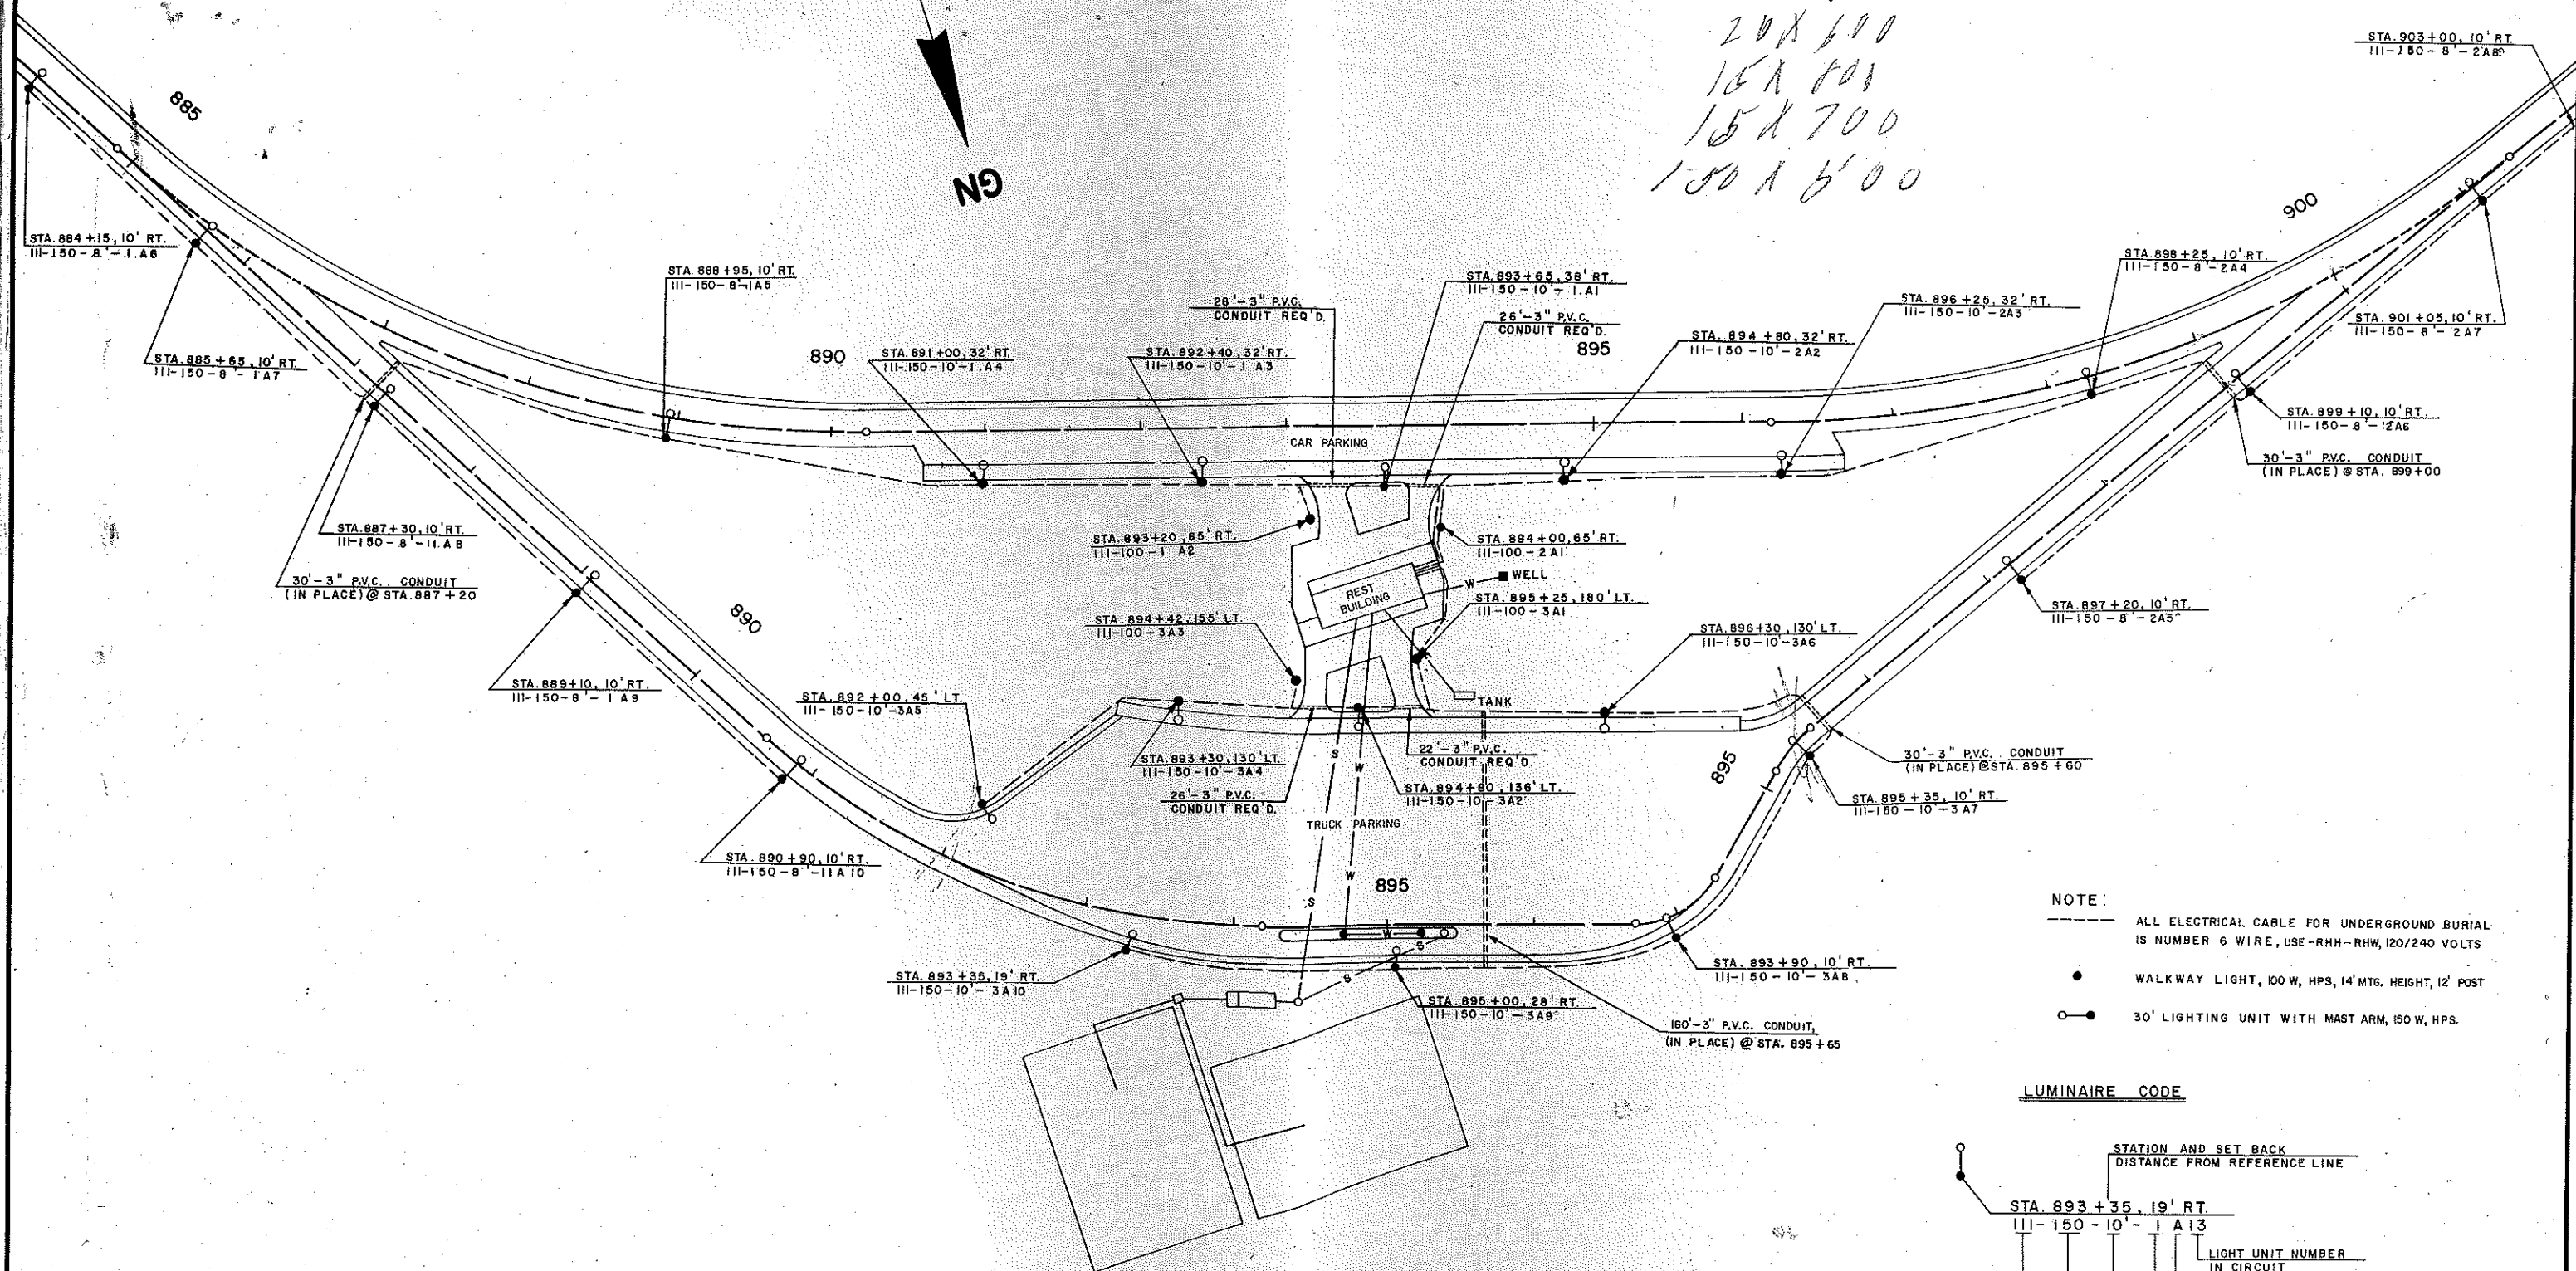

- NOTE:
- ALL ELECTRICAL CABLE FOR UNDERGROUND BURIAL IS NUMBER 6 WIRE, USE -RHH-RHW, 120/240 VOLTS
 - WALKWAY LIGHT, 100 W, HPS, 14' MTG. HEIGHT, 12' POST
 - 30' LIGHTING UNIT WITH MAST ARM, 150 W, HPS.

LUMINAIRE CODE

