

ROAD CLOSURE GATES				
POLE NO.	TYPE POLE BASE	FOUNDATION DIA. X DEPTH	GATE ARM	LUMINAIRE TYPE
1	ANCHOR	2.5' x 8'	24.0'	250W HPSV
2	ANCHOR	2.5' x 8'	24.0'	250W HPSV
3	ANCHOR	2.5' x 8'	24.0'	250W HPSV

NOTE: INSTALL FOUNDATIONS 7 FEET FROM EDGE OF PAVEMENT. POLE LOCATION IS APPROXIMATE AND MAY REQUIRE MINOR FIELD ADJUSTMENT.




ELECTRICAL LEGEND	
ELECTRICAL SERVICE ASSEMBLY	
CONDUIT	
ROAD CLOSURE GATE	

BARRETTS INTERCHANGE ROAD CLOSURE GATES


NEW SERVICE ASSEMBLY ON 40' WOOD POLE (SEE DETAIL ON SHEET E-2).
CONTACT ? (Phone #) NORTHWESTERN ENERGY

NEW 1 of 2" SCHEDULE 80 PCV CONDUIT
NEW 1 of 5AWG14 SIGNAL CABLE
NEW 2 of AWG10 CONDUCTOR (LIGHTING)
NEW 1 of AWG10 CONDUCTOR (POLE GROUND)


NEW 1 of 2" SCHEDULE 80 PCV CONDUIT
NEW 1 of 5AWG14 SIGNAL CABLE
NEW 2 of AWG10 CONDUCTOR (LIGHTING)
NEW 1 of AWG10 CONDUCTOR (POLE GROUND)

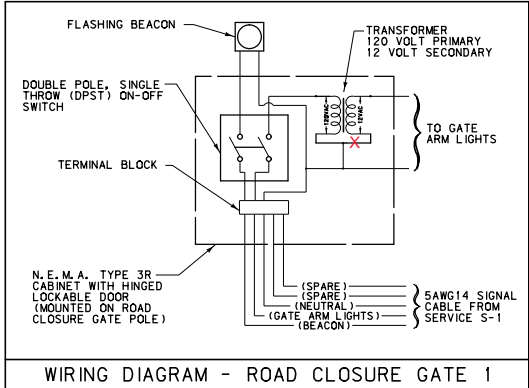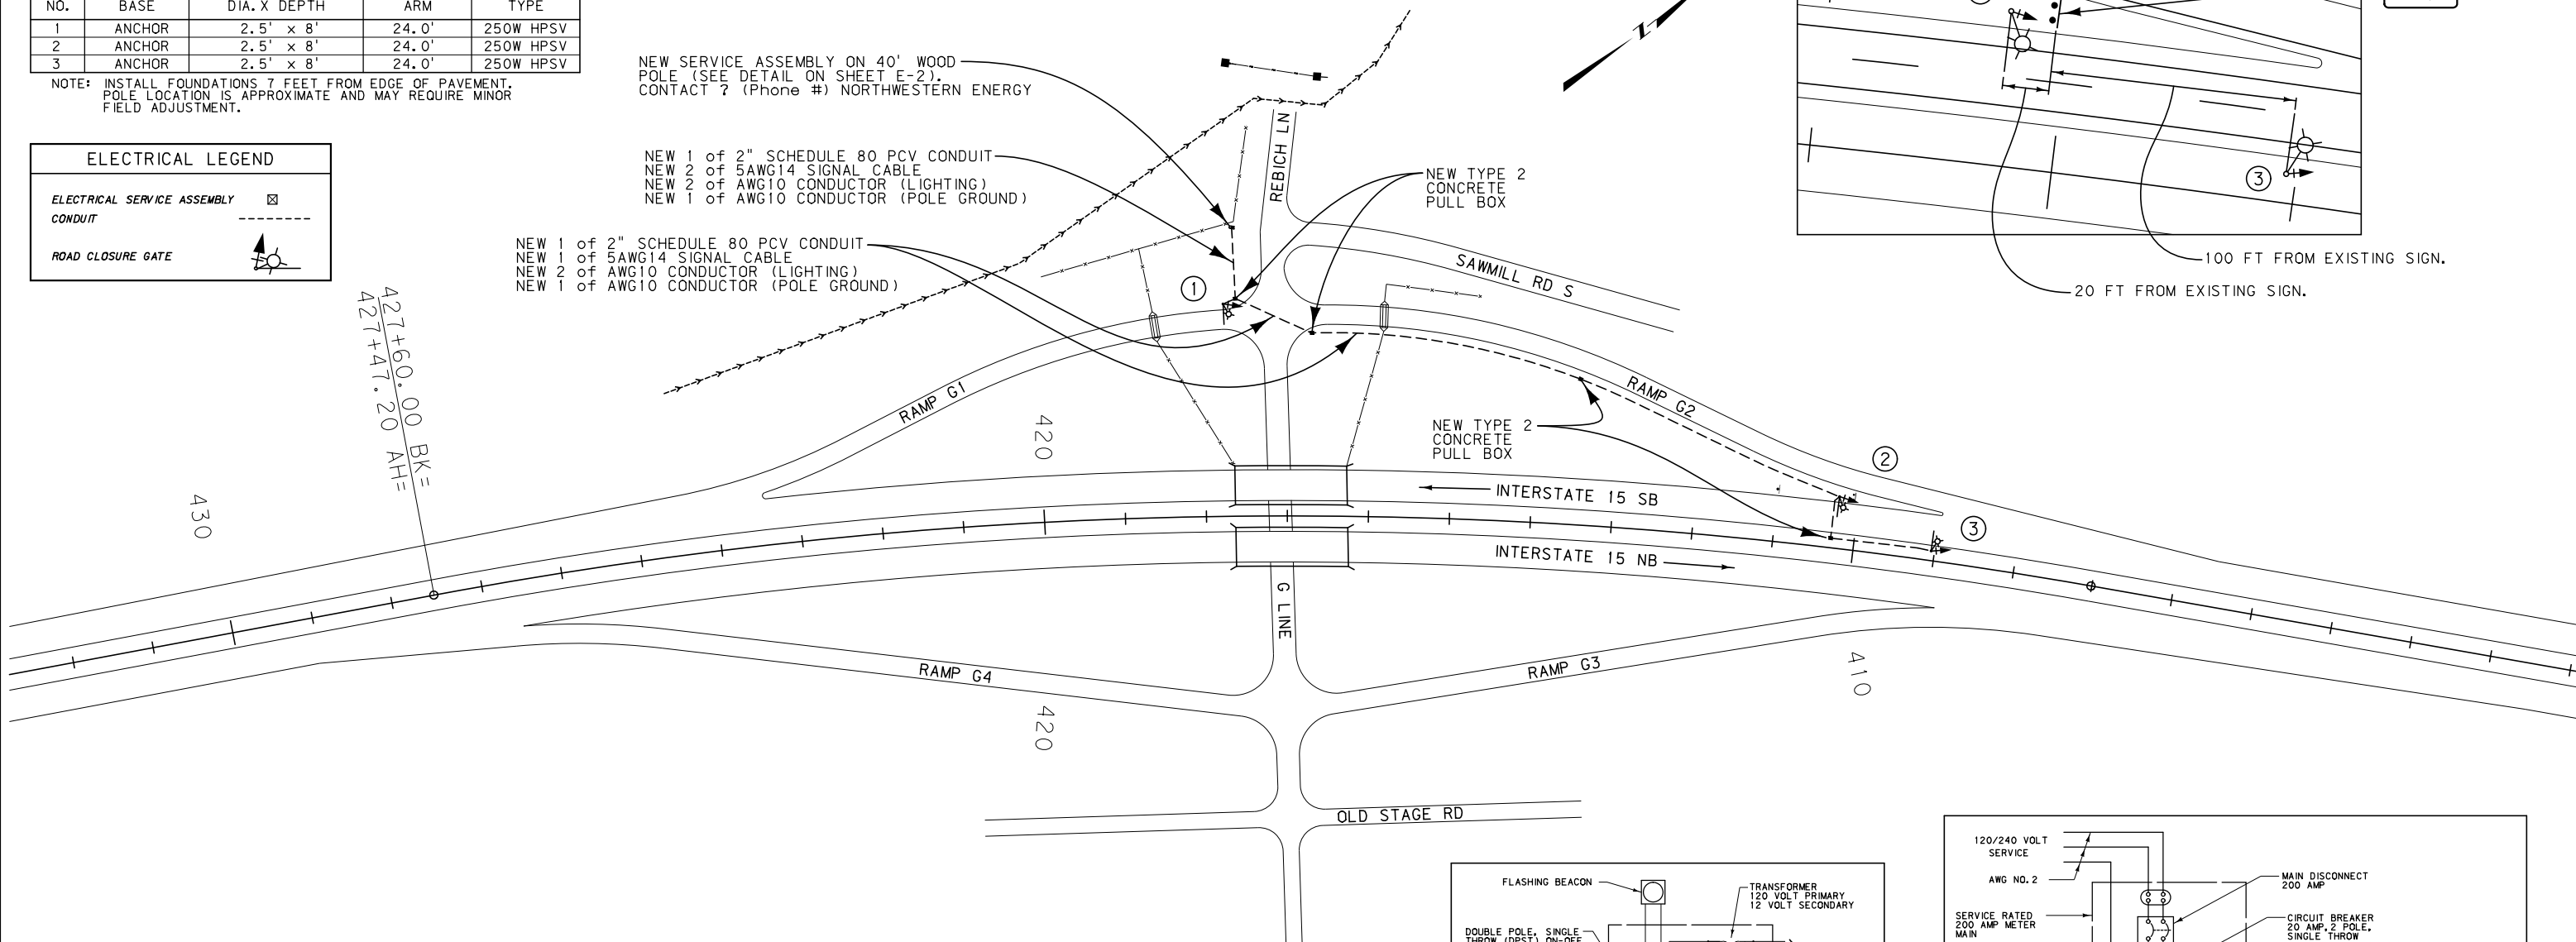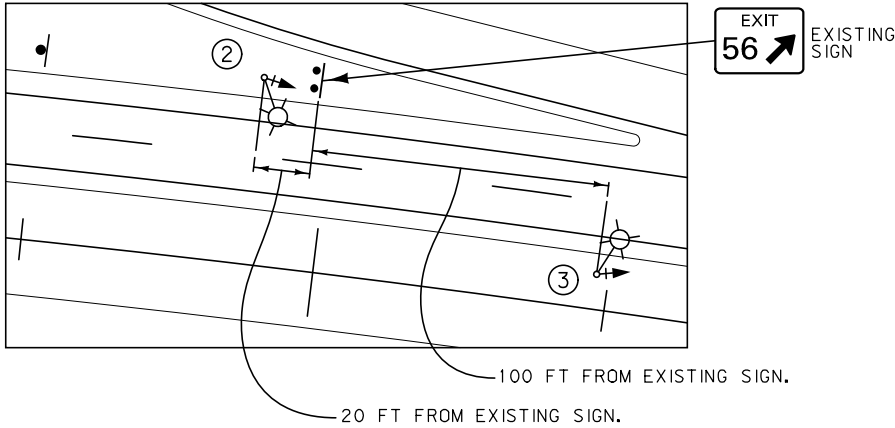


WIRING DIAGRAM - ROAD CLOSURE GATE 1

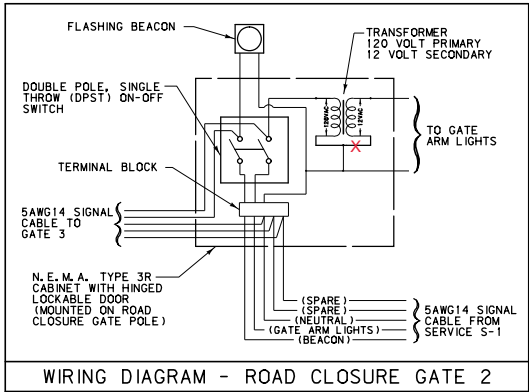


WIRING DIAGRAM - ROAD CLOSURE GATE 2

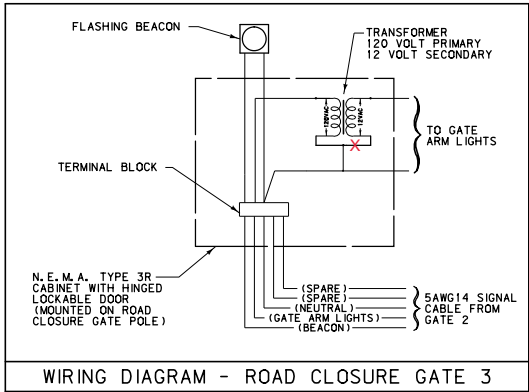

WIRING DIAGRAM - ROAD CLOSURE GATE 3

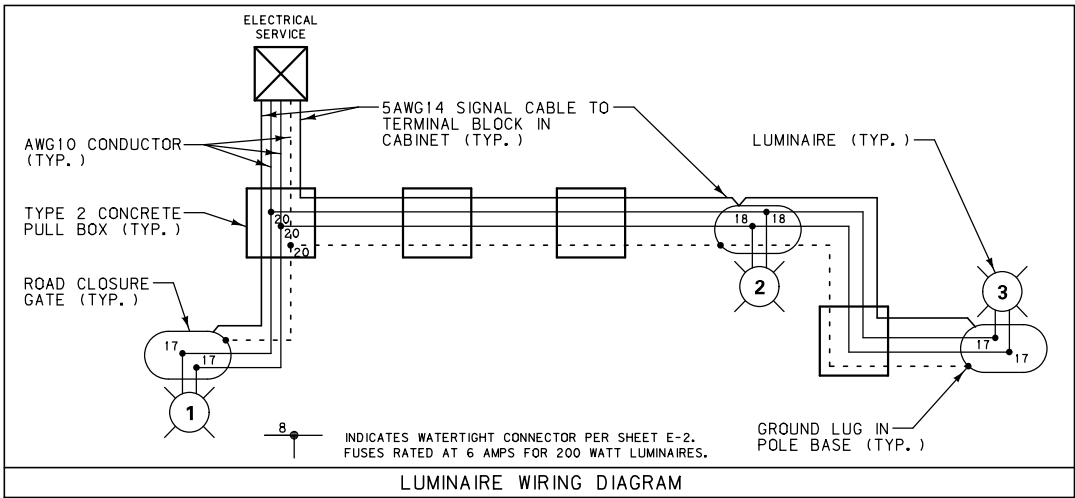

LUMINAIRE WIRING DIAGRAM

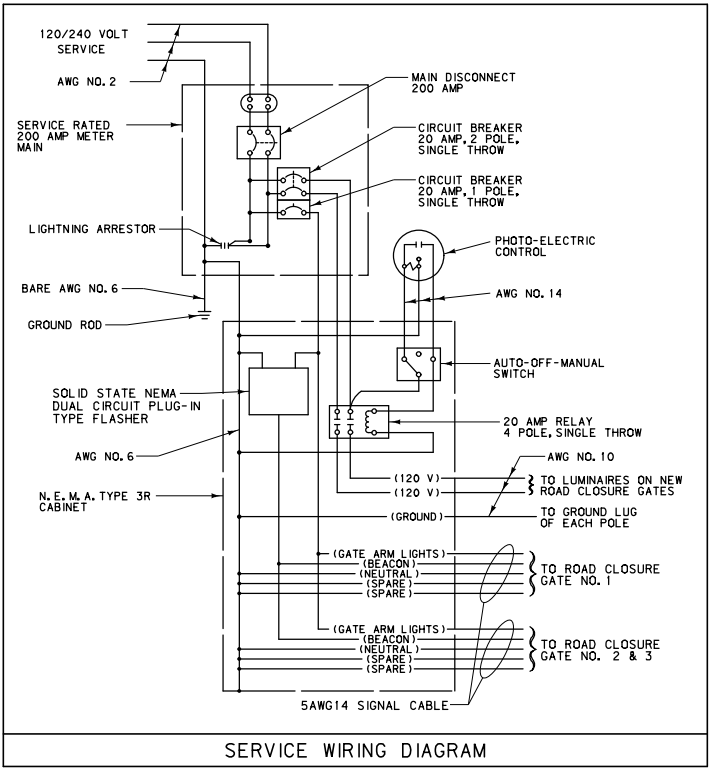

SERVICE WIRING DIAGRAM

SCALE: 1"=100'