



Dial  or (800)242-8511

www.DiggersHotline.com

UTILITIES CONTACTS

BRANDON STORM CHARTER COMMUNICATIONS - COMMUNICATION LINE 2701 DANIELS STREET MADISON, WI 53718 BRANDON.STORM@CHARTER.COM	RUSS RYAN FRONTIER COMMUNICATIONS OF WI LLC - COMMUNICATION LINE 107 PLEASANT VIEW DR PLYMOUTH, WI 53073 (920) 583-3275 RUSSELL.W.RYAN@FTR.COM
DANA GILLETT FRONTIER COMMUNICATIONS OF WI LLC - COMMUNICATION LINE 100 COMMUNICATIONS DR PO BOX 49 SUN PRAIRIE, WI 53590 (608) 837-1605 OFFICE DANA.GILLETT@FTR.COM	JOE GLISCZINSKI (PRIMARY CONTACT) MCIMETRO ACCESS TRANSMISSION SERVICES CORP D/B/A VERIZON ACCESS TRANSMISSION SERVICES 15725 W RYERSON RD NEW BERLIN, WI 53151 (262) 782-9845 OFFICE (414) 708-8861 MOBILE JOSEPH.GLISCZINSKI@VERIZON.COM
cc: THOMAS BUHER (LOCATOR/CONSTRUCTION) MCIMETRO ACCESS TRANSMISSION SERVICES CORP D/B/A VERIZON ACCESS TRANSMISSION SERVICES (708) 458-6410 OFFICE (708) 261-1394 MOBILE THOMAS.BUHER@VERIZON.COM	cc: DAVE CHOATE (CONTRACTOR/LOCATOR) MCIMETRO ACCESS TRANSMISSION SERVICES CORP D/B/A VERIZON ACCESS TRANSMISSION SERVICES BEAR COMMUNICATIONS, LLC (608) 209-7406 DCHOATE@BEARCOMMUNICATIONS.NET
RICK WICKLUND SUN PRAIRIE UTILITIES - ELECTRICITY/SEWER/STREET LIGHTING/WATER 125 W. MAIN ST SUN PRAIRIE, WI 53590 (608) 837-5500 RWICKLUND@SUNPRAIRIEUTILITIES.COM	JOHN KRUG SUN PRAIRIE WASTEWATER TREATMENT FACILITY - SEWER 3040 BAILEY RD SUN PRAIRIE, WI 53590 (608) 837-6292 JKRUG@CITYOFSUNPRAIRIE.COM
DAREN NEUENSCHWANDER (PRIMARY CONTACT) TDS METROCOM LLC - COMMUNICATION LINE 827 16TH AVE MONROE, WI 53566 (608) 328-1158 DAREN.NEUENSCHWANDER@TDSTELECOM.COM	JERRY MYERS TDS TELECOM 525 JUNCTION RD MADISON, WI 53717 (608) 664-4404 OFFICE (608) 279-7104 MOBILE JERRY.MYERS@TDSTELECOM.COM
NICOLE SMULLEN WE ENERGIES - GAS/PETROLEUM 333 WEST EVERETT ST, ROOM A299 MILWAUKEE, WI 53203 (414) 221-5617 NICOLE.SMULLEN@WECENERGYGROUP.COM	

WISDOT CONTACTS

BRAD SCHULTZ, P.E.
PROJECT MANAGER
SOUTHWEST REGION - MADISON OFFICE
2101 WRIGHT STREET
MADISON, WI 53704
(608) 242-8038

STEVEN PORTER, P.E.
PROJECT DESIGNER
SOUTHWEST REGION - MADISON OFFICE
2101 WRIGHT STREET
MADISON, WI 53704
(608) 243-3366

DNR LIASON

ERIC HEGGELUND
ENVIRONMENTAL ANALYSIS & REVIEW SPECIALIST
WISCONSIN DEPT. OF NATURAL RESOURCES
SOUTH CENTRAL REGION
3911 FISH HATCHERY ROAD
FITCHBURG, WI 53711
(608) -275-3301

THE LOCATIONS OF EXISTING AND PROPOSED UTILITY INSTALLATIONS AS SHOWN ON THE PLANS ARE APPROXIMATE. THERE MAY BE OTHER UTILITY INSTALLATIONS WITHIN THE PROJECT AREA THAT ARE NOT SHOWN. THE CONTRACTOR SHALL COORDINATE CONSTRUCTION ACTIVITIES WITH A CALL TO DIGGER HOTLINE AND/OR A DIRECT CALL TO THE UTILITIES THAT HAVE FACILITIES IN THE AREA.

THE ENGINEER SHALL ADJUST THE LOCATIONS OF ITEMS UNDER THIS CONTRACT TO AVOID CONFLICT WITH THE EXISTING UTILITY FACILITIES.

ALL SIGN LOCATIONS SHALL BE REVIEWED BY THE ENGINEER PRIOR TO INSTALLATION.

THE LOCATION AND WIDTH OF DRIVEWAYS WILL BE DETERMINED BY THE ENGINEER.

RADIUS DIMENSIONS FOR THE CURB AND GUTTER ARE TO THE FLANGE LINE UNLESS OTHERWISE NOTED.

STORM SEWER PIPE ELEVATIONS, LENGTH, AND LOCATIONS AS SHOWN ON PLANS MAY BE ADJUSTED TO FIT FIELD CONDITIONS.

THE CONTRACTOR'S PAVING OPERATIONS SHALL BE CONSISTENT WITH THE PLAN TYPICAL SECTIONS AND CONSTRUCTED TO PREVENT HMA LONGITUDINAL JOINTS FROM BEING LOCATED WITHIN DRIVING, TURNING, OR BIKE LANE.

CONTRACTOR SHALL MAINTAIN ACCESS TO ALL DRIVEWAYS AT ALL TIMES EXCEPT WHEN PIPE LAYING OPERATIONS REQUIRE THE DRIVEWAY TO BE CLOSED. ACCESS TO DRIVEWAY SHALL BE RE-ESTABLISHED IMMEDIATELY AFTER PIPE IN DRIVEWAY AREA IS INSTALLED. ACCESS SHALL BE PROVIDED DURING ALL NON-WORKING HOURS.


HMA PAVEMENT WEIGHT CALCULATIONS ARE BASED ON 112 LB/SY/IN.


ABBREVIATION

NB NORTH BRISTOL STREET
SB SOUTH BRISTOL STREET
M MAIN STREET
R/L REFERENCE LINE
M/L MATCH LINE


SECTION 2 ORDER OF SHEETS

PROJECT OVERVIEW
TYPICAL SECTIONS
CONSTRUCTION DETAILS
PLAN DETAILS
PAVEMENT GRADES
EROSION CONTROL
STORM SEWER
PERMANENT SIGNING
LIGHTING PLAN
TRAFFIC SIGNALS
PAVEMENT MARKING
ALIGNMENT DETAILS

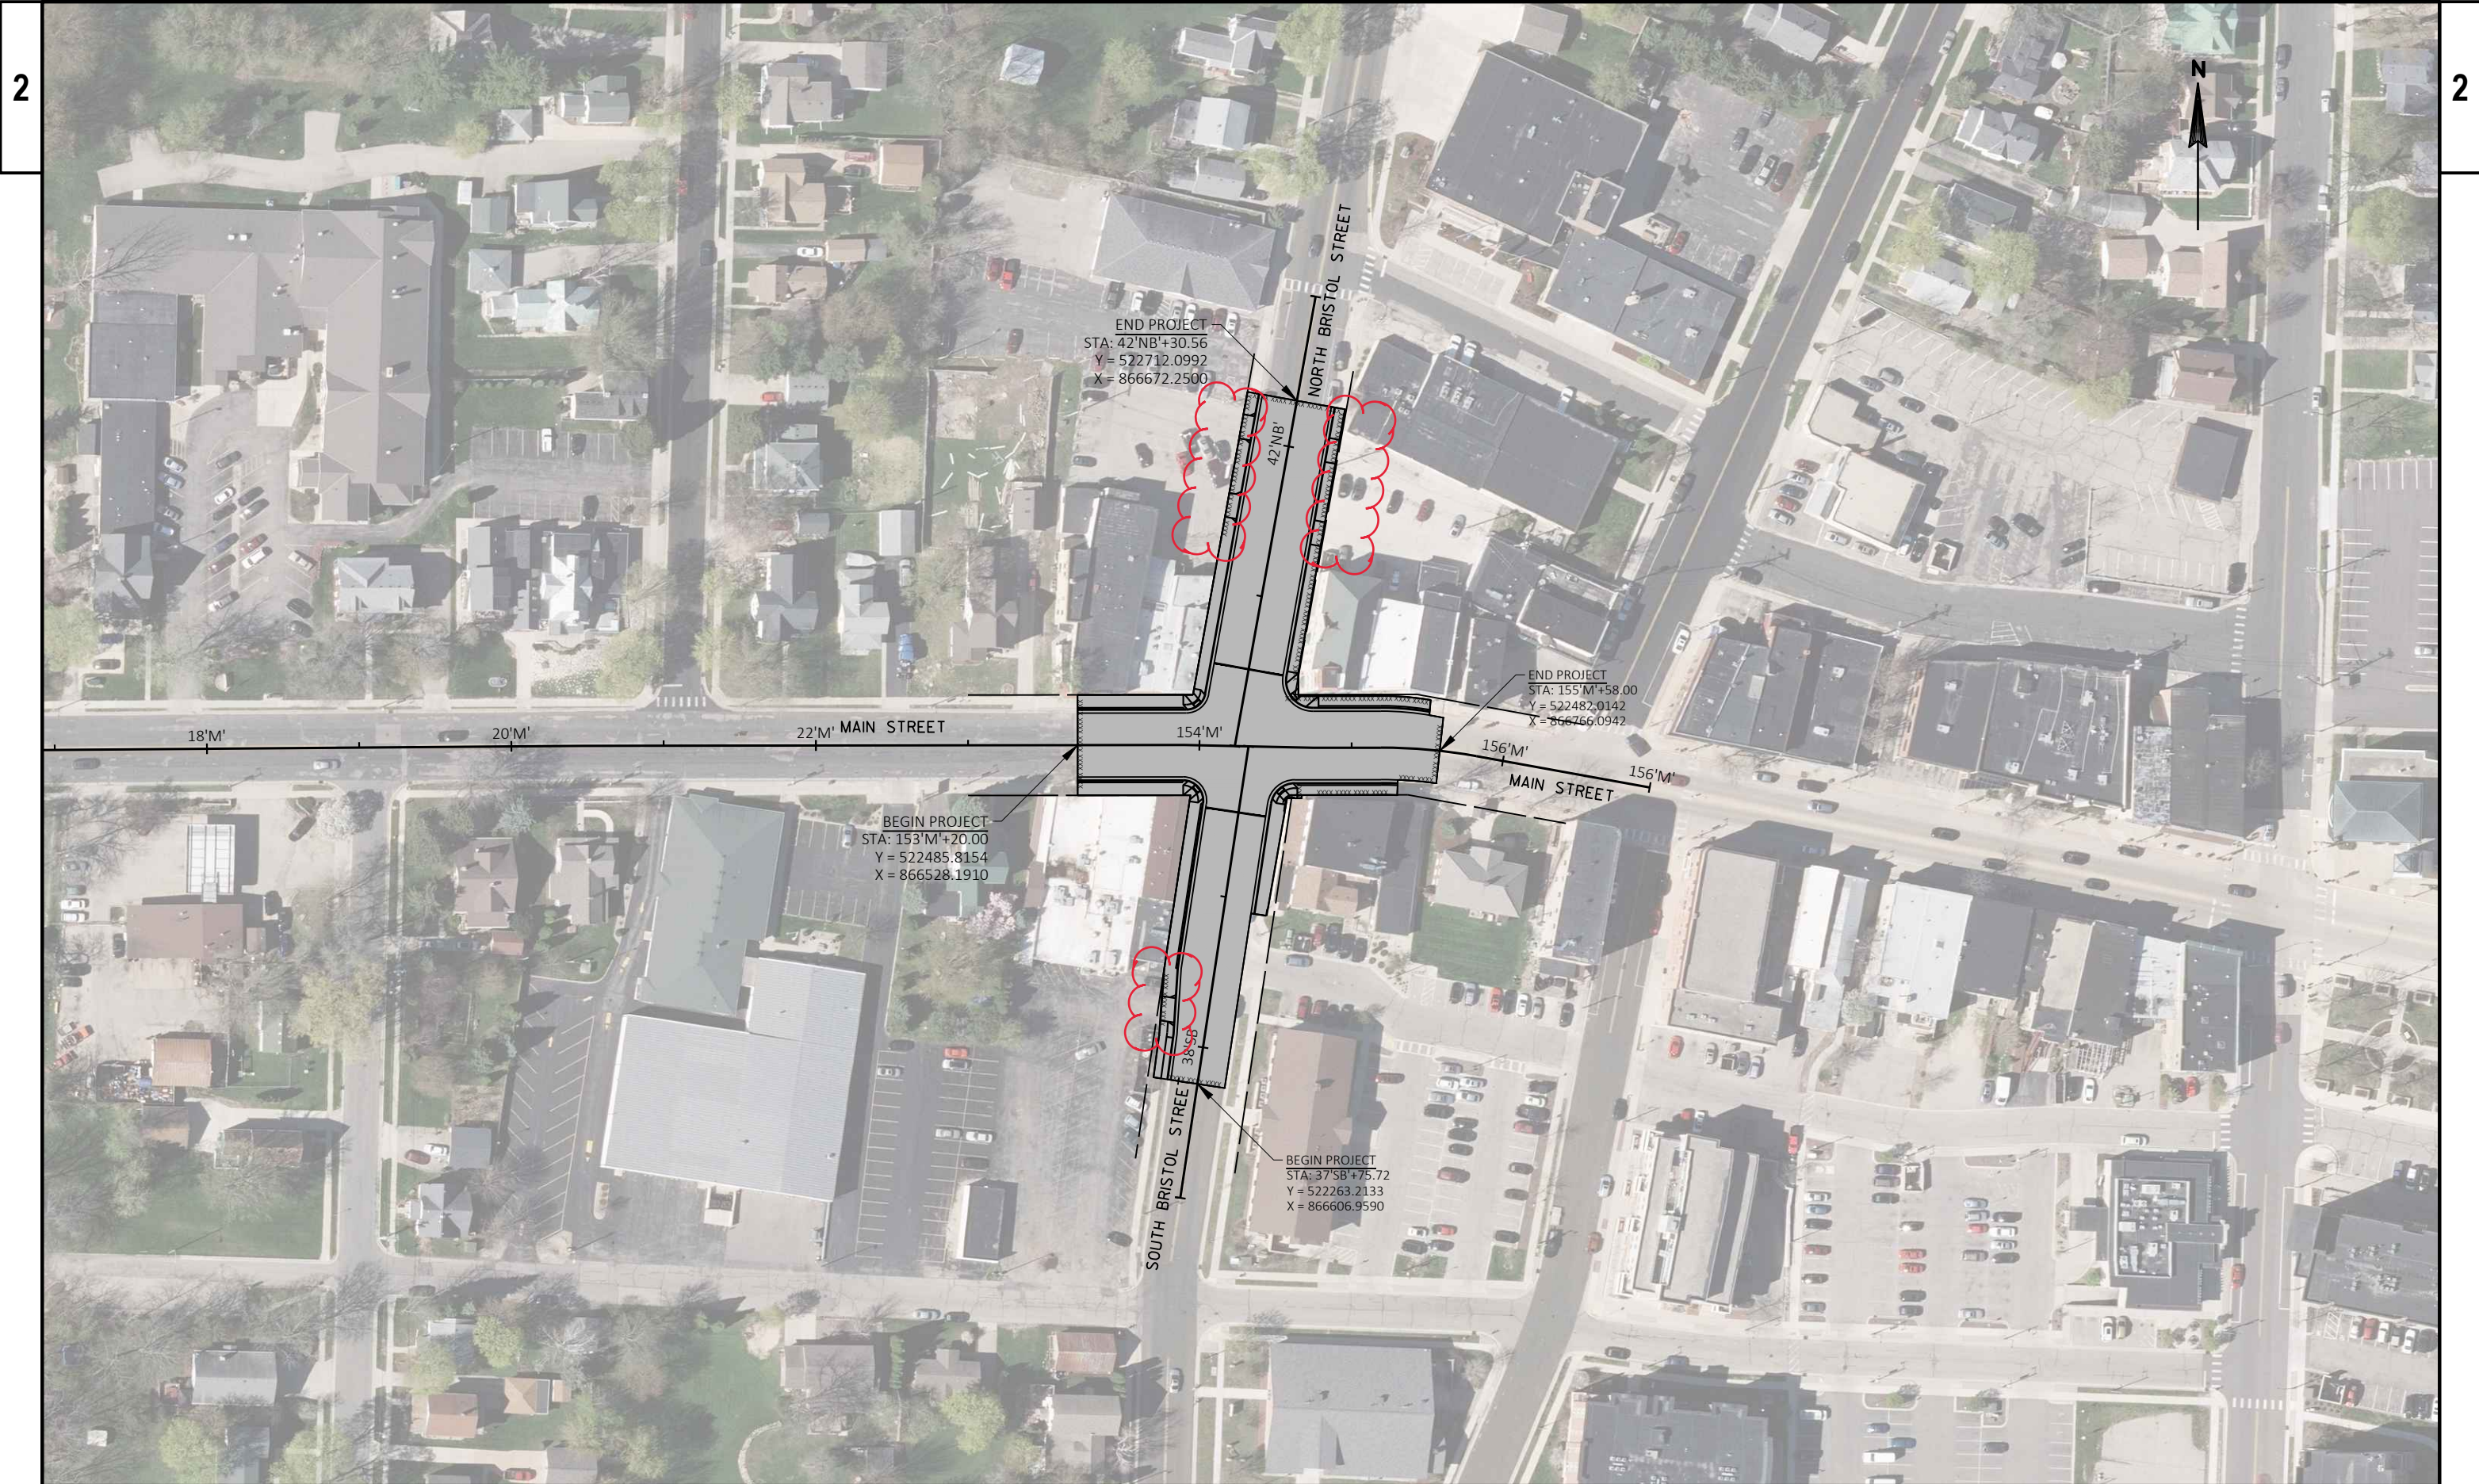


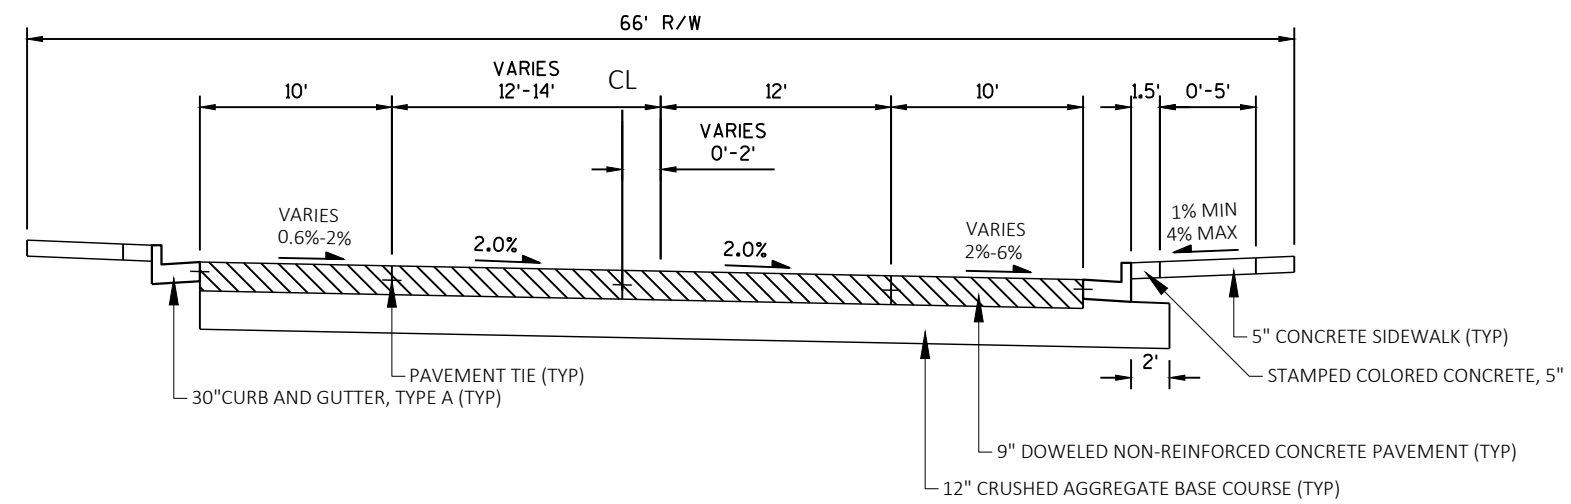


TYPICAL EXISTING SECTION
MAIN STREET
153'M'+20.00 TO 155'M'+58.00

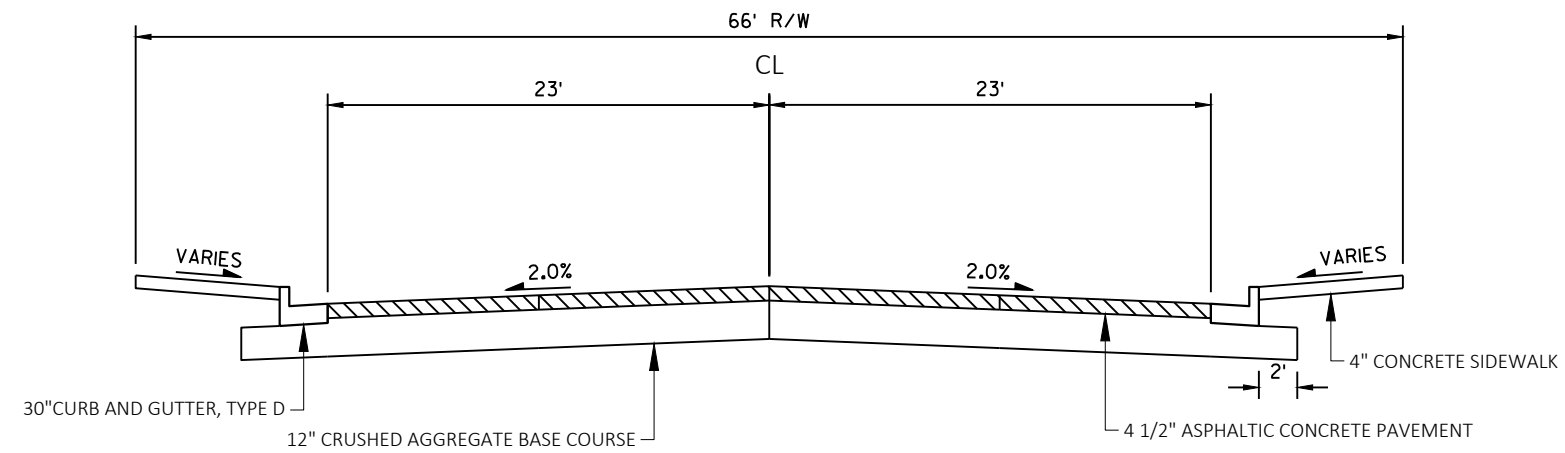


TYPICAL EXISTING SECTION
NORTH BRISTOL STREET
40'NB'+51.28 TO 42'NB'+30.56

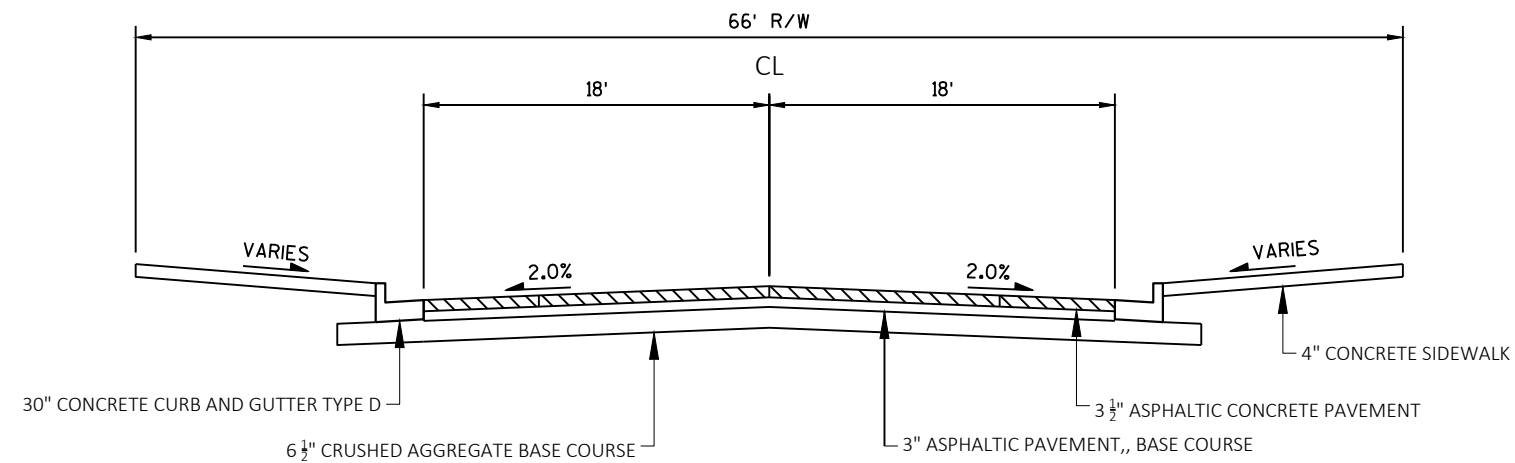

TYPICAL EXISTING SECTION
SOUTH BRISTOL STREET
37'SB'+75.72 TO 39'SB'+56.07

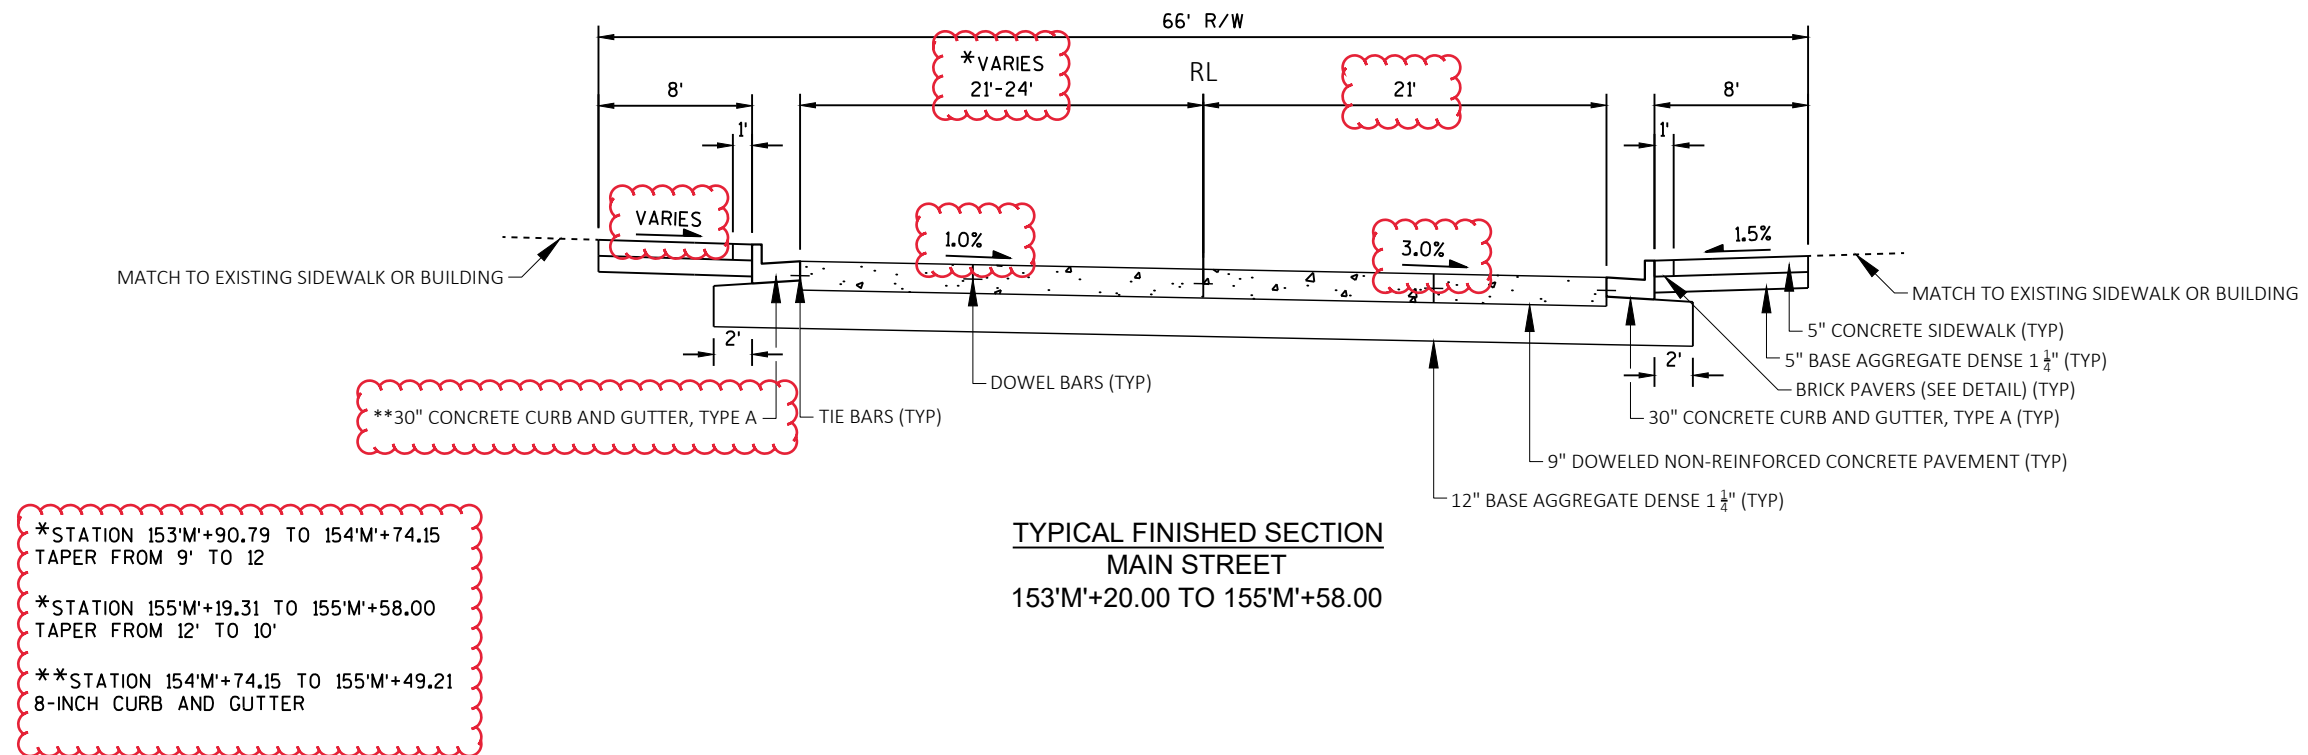

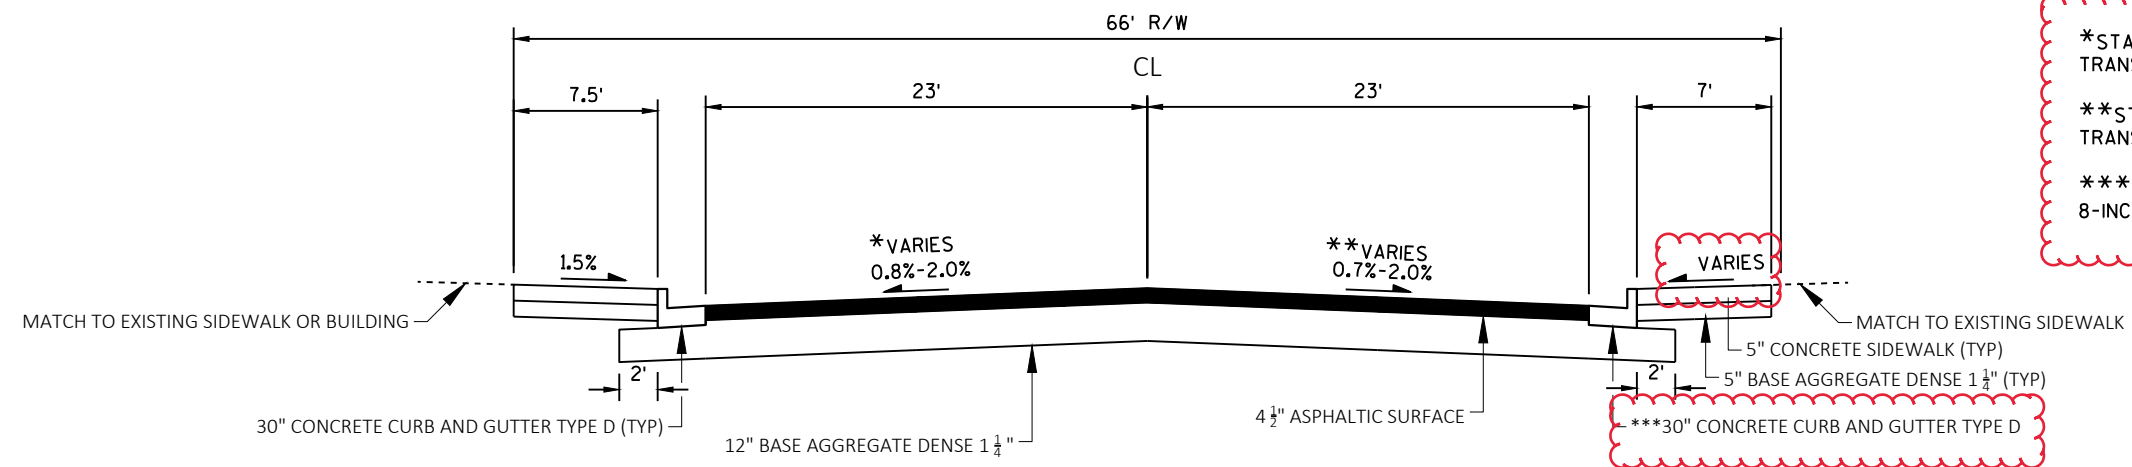


**TYPICAL FINISHED SECTION
NORTH BRISTOL STREET
40'NB'+51.28 TO 42'NB'+30.56**

*STATION 40'NB'+30.49 TO 41'NB'+00
TRANSITION FROM 0.8% TO 2.0%

**STATION 40'NB'+51.28 TO 41'NB'+00
TRANSITION FROM 0.7% TO 2.0%

***STATION 40'NB'+51.28 TO 41'NB'+39.24
8-INCH CURB AND GUTTER

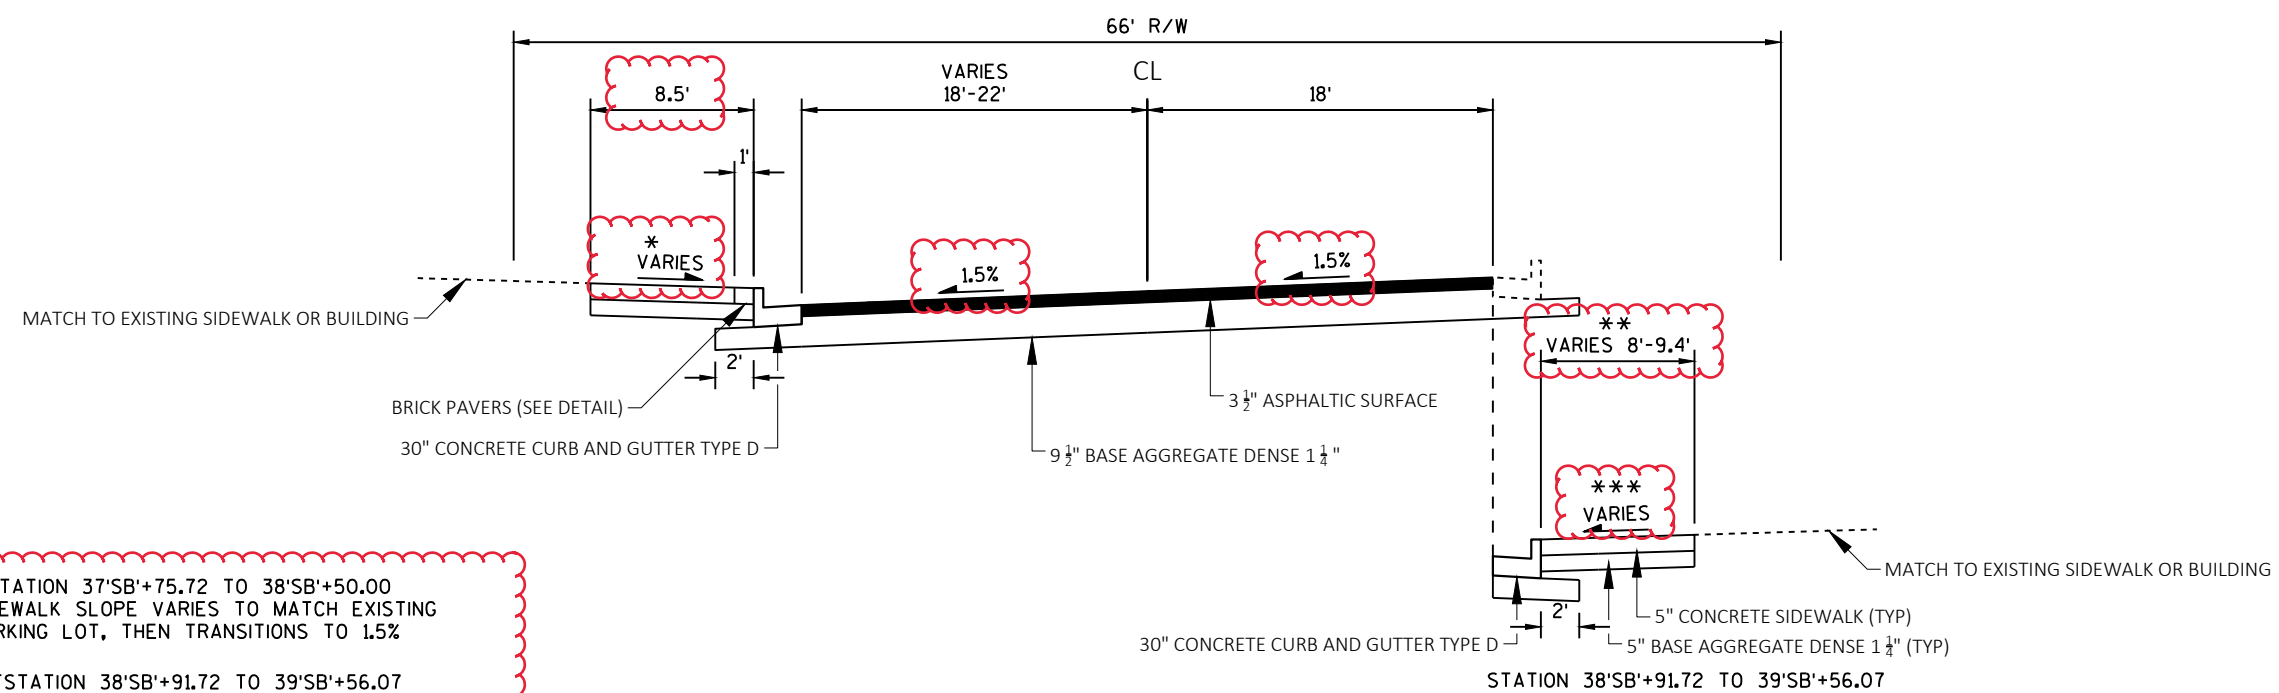



**TYPICAL FINISHED SECTION
SOUTH BRISTOL STREET
37'SB'+75.72 TO 39'SB'+56.07**

*STATION 37'SB'+75.72 TO 38'SB'+50.00
SIDEWALK SLOPE VARIES TO MATCH EXISTING
PARKING LOT, THEN TRANSITIONS TO 1.5%

**STATION 38'SB'+91.72 TO 39'SB'+56.07
WIDTH VARIES TO MATCH EXISTING BUILDING FACE




***STATION 38'SB'+91.72 TO 39'SB'+10
SIDEWALK SLOPE VARIES TO MATCH EXISTING
WALK BEFORE TRANSITIONING TO 1.5%

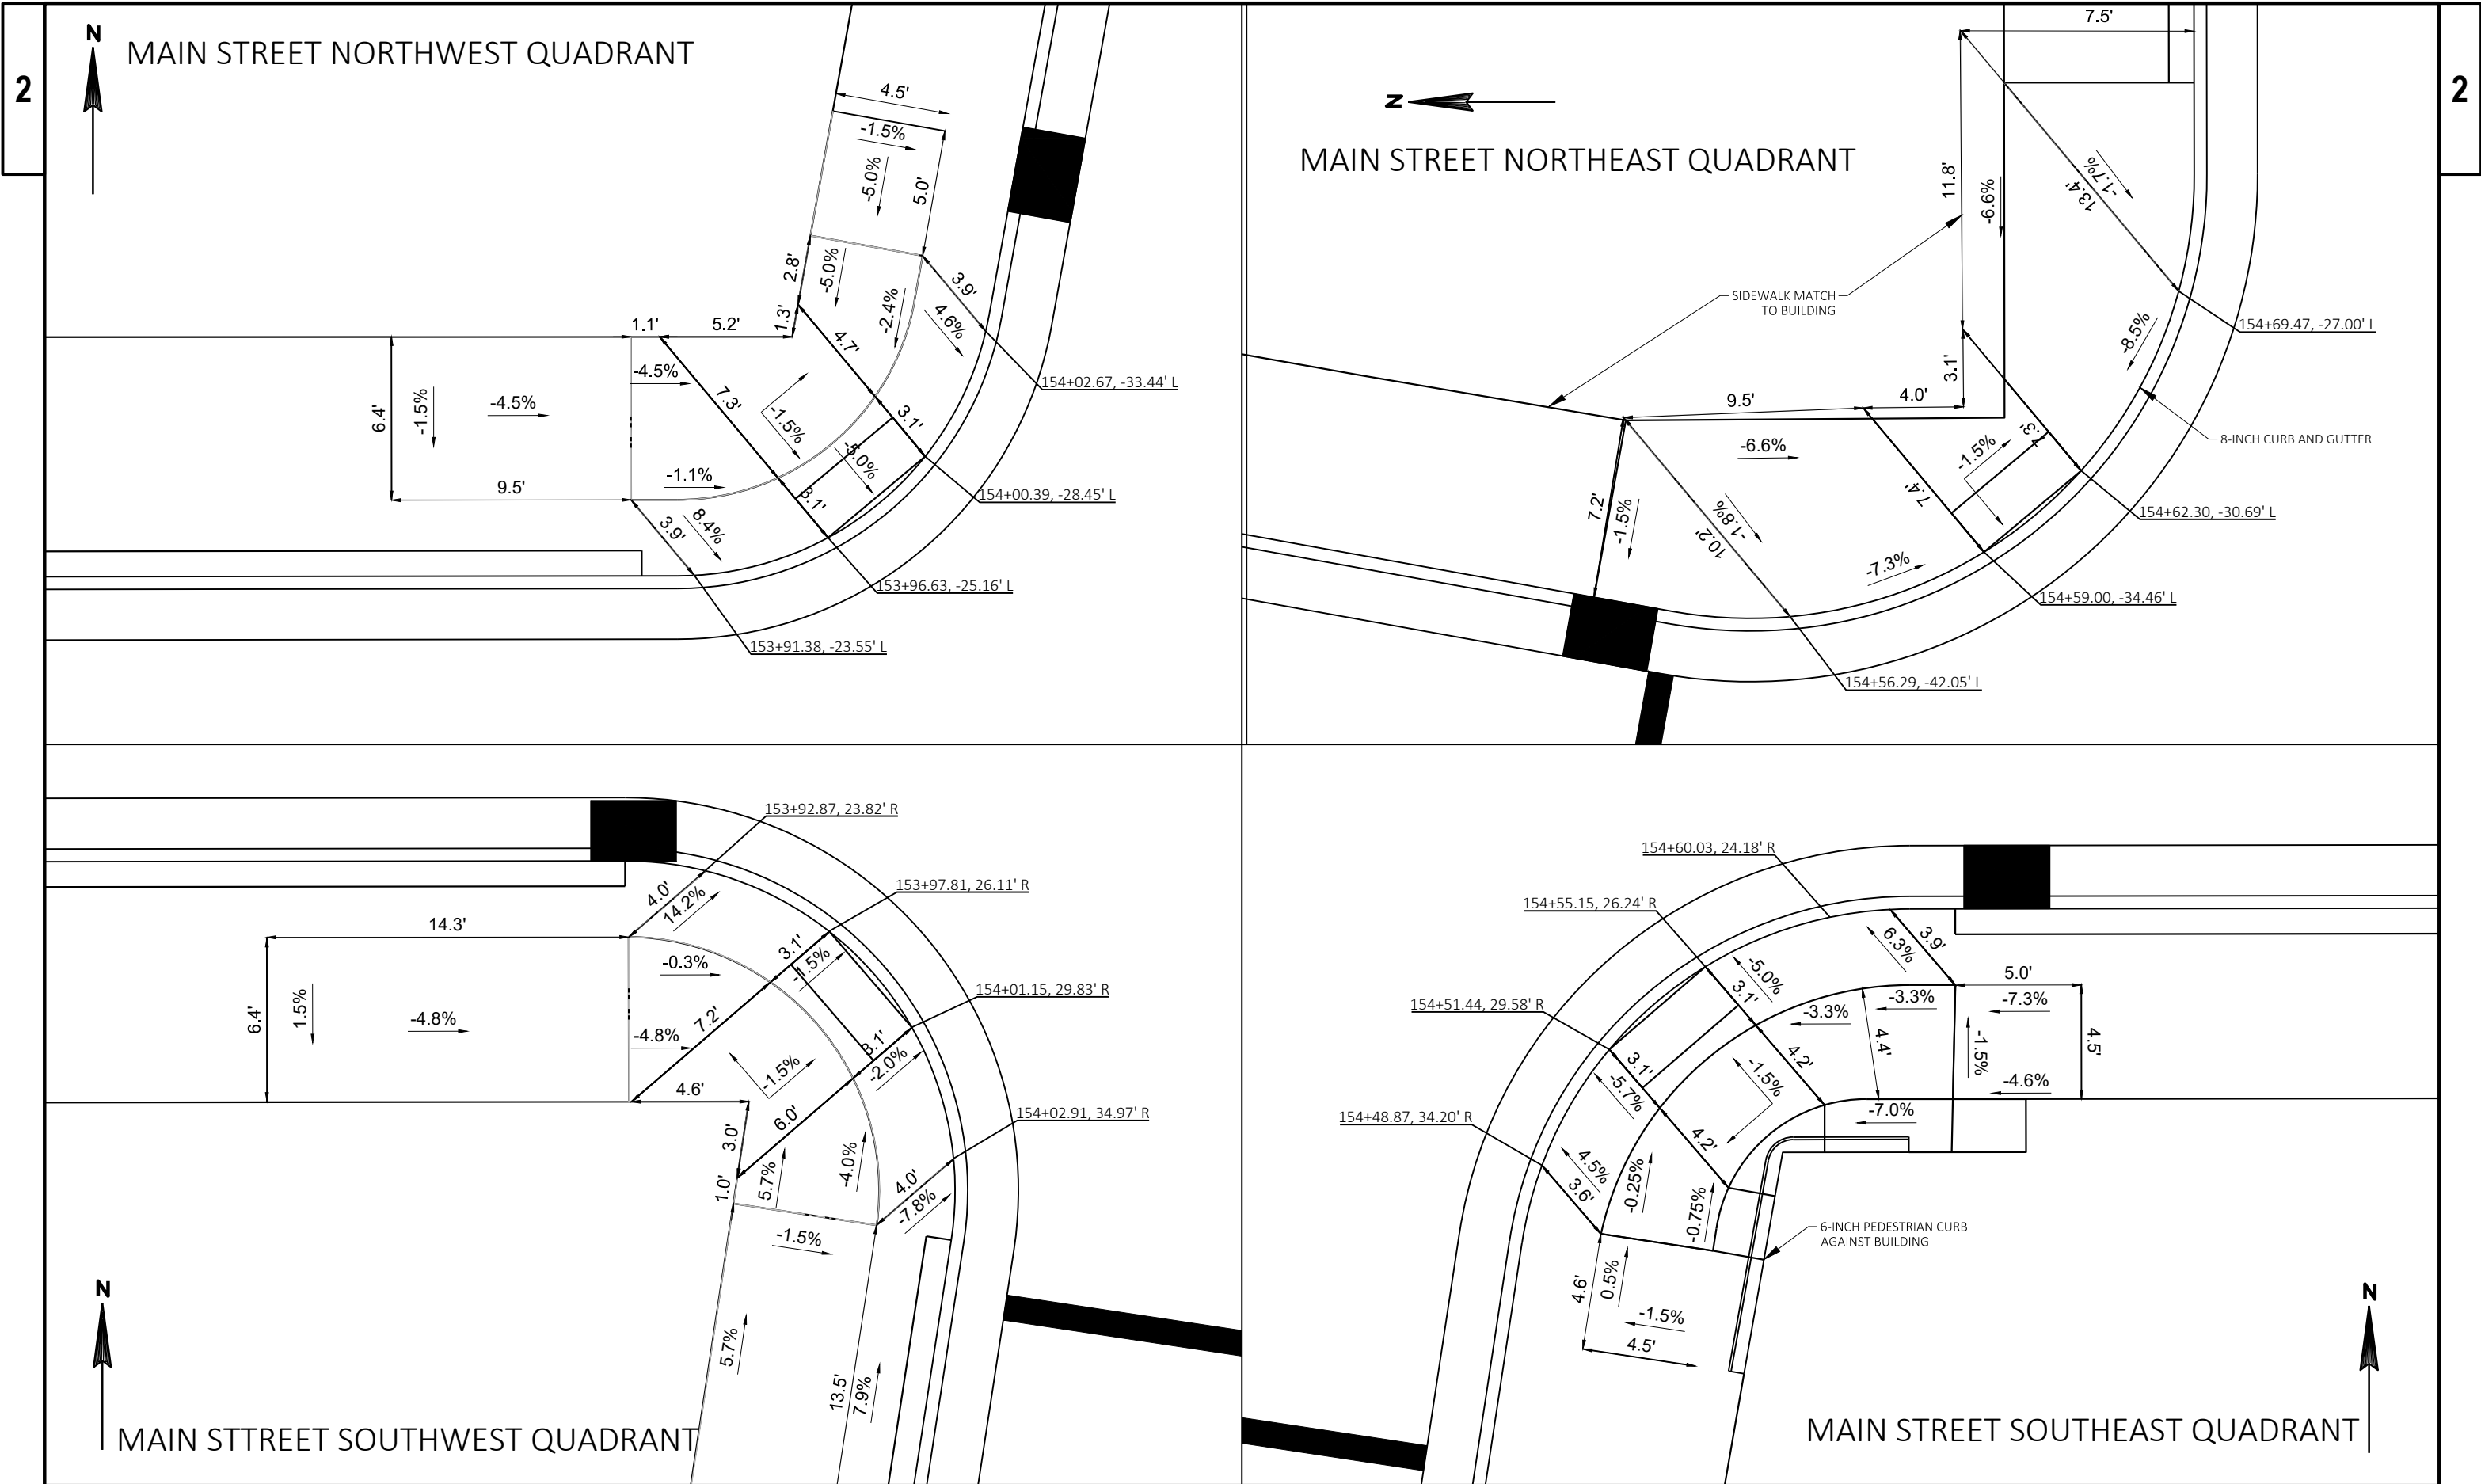

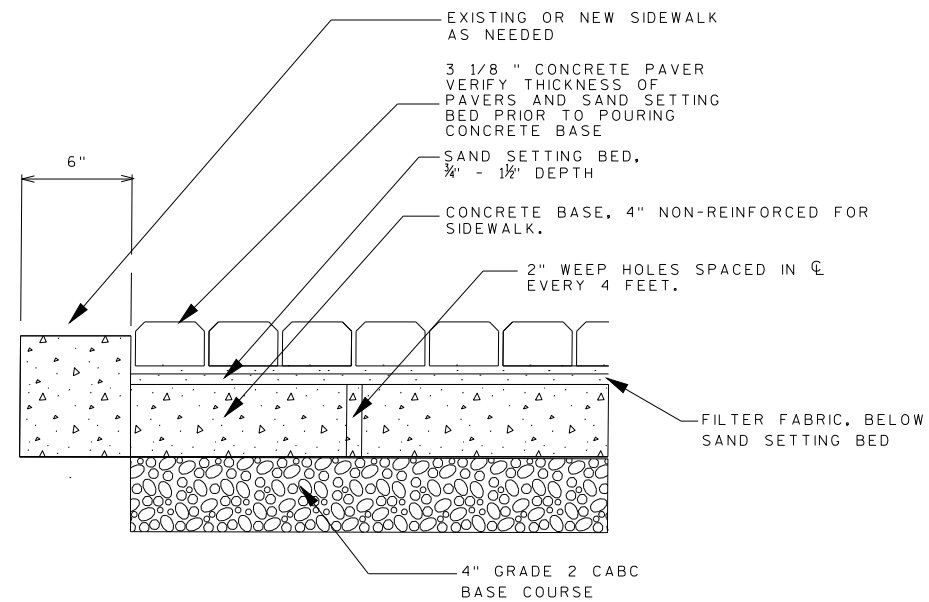


CONCRETE SUPPORTED PAVERS
SCALE: NONE

NOTE: PAY LIMITS INLCUDE THE 6-INCH CONCRETE HEADER.

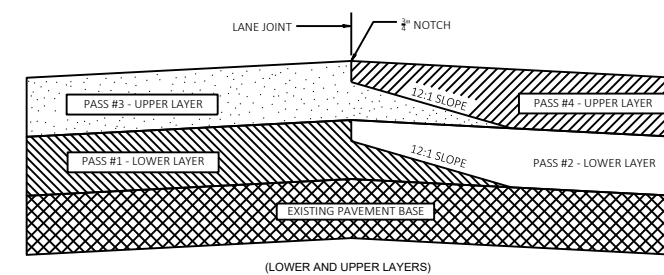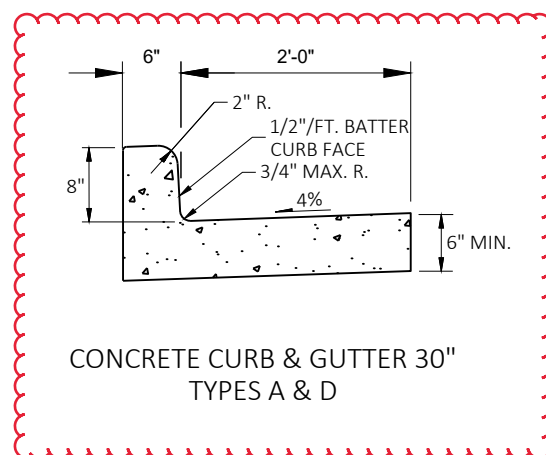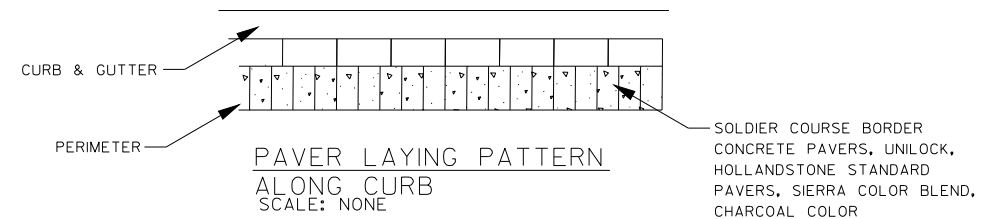

TYPICAL PAVEMENT CROSS SECTIONS OF
TAPERED AND NOTCHED LONGITUDINAL JOINTS

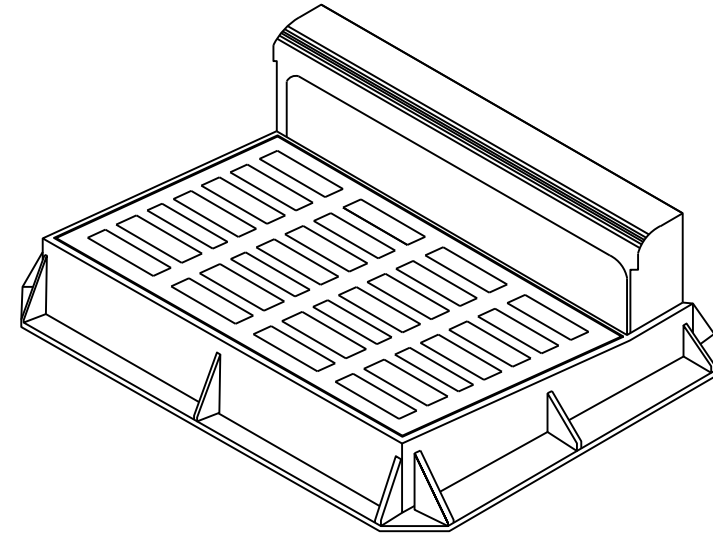


COMBINATION INLETS, WITH CURB BOX
R-3246-A

- EQUATION 
$$\begin{array}{r} \text{STA BACK} = 23+72.00'\text{M}' \\ \hline \text{STA AHEAD} = 153+20.00'\text{M}' \end{array}$$



2

2

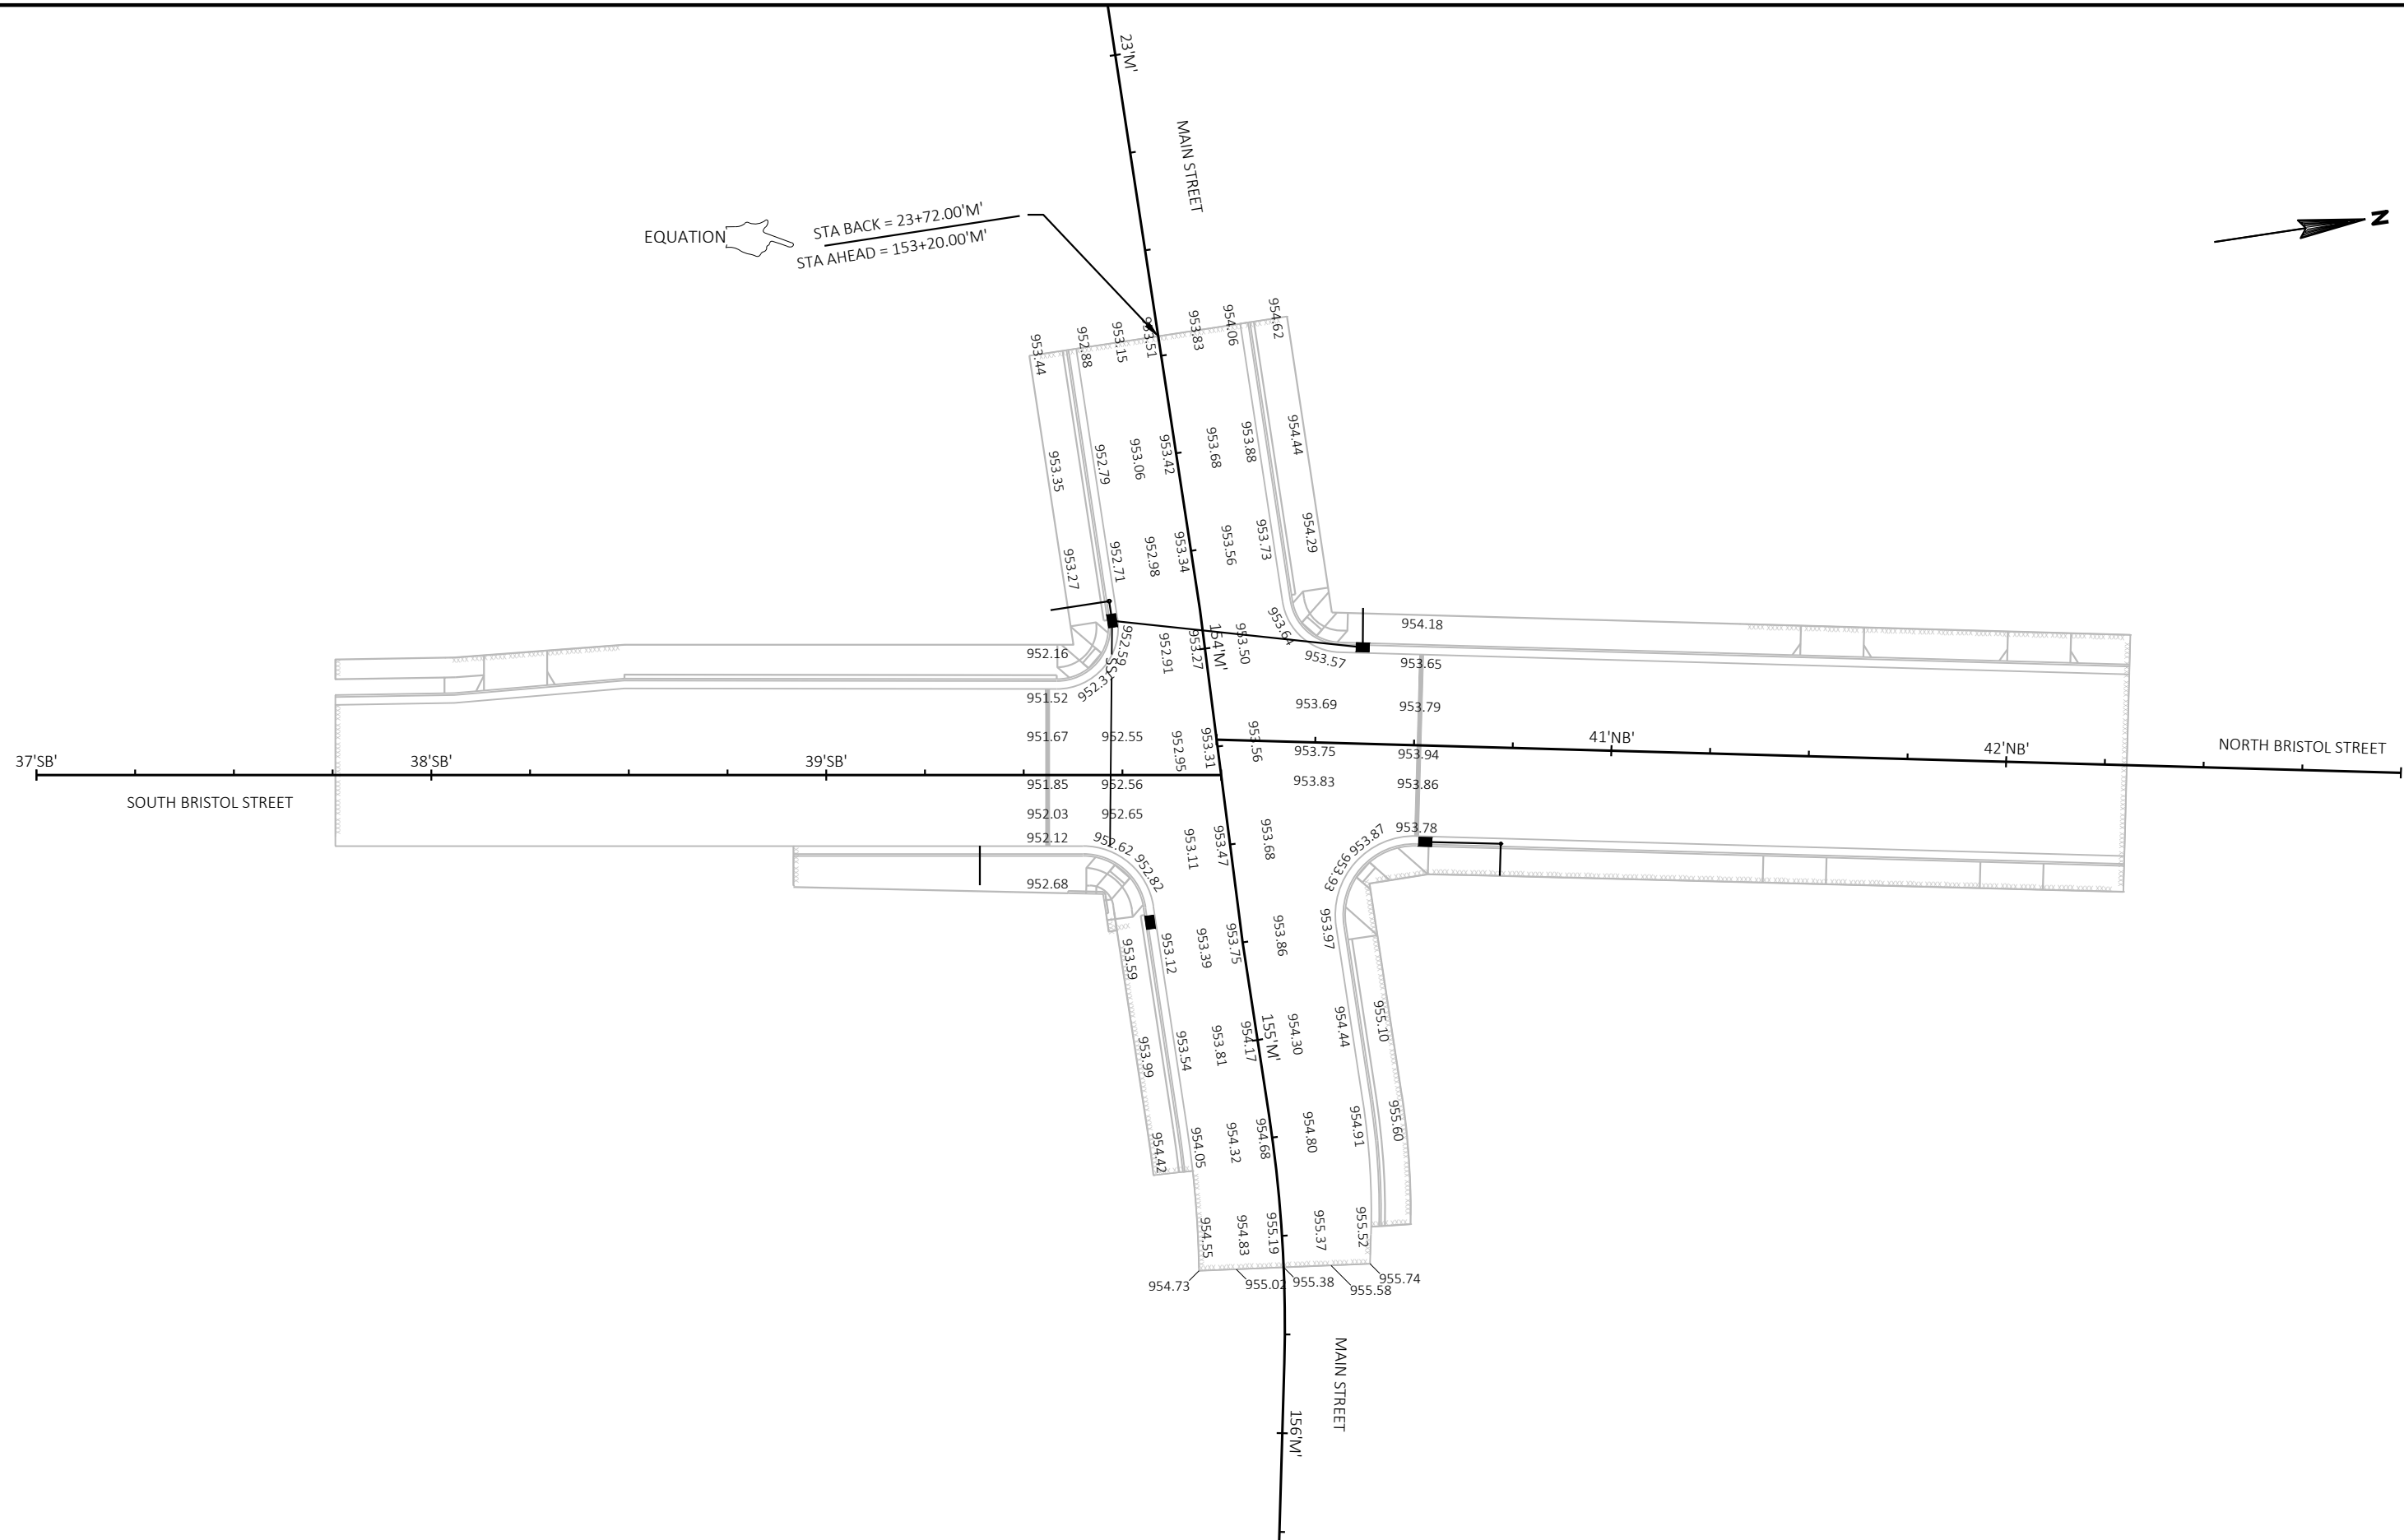

PROJECT NO:	3050-05-70
-------------	------------

HWY: STH 19

COUNTY: DANE

PAVEMENT GRADES

SHEET Page 12 of 102

E

FILE NAME : N:\PDS\C3D\30500500\SHEETSPLAN\021401_PG.DWG
LAYOUT NAME - 021401_pg



PLOT DATE : 8/23/2018 8:44 AM

PLOT BY : PORTER, STEVEN J

PLOT NAME :



PLOT SCALE : 1 IN:40 FT

WISDOT/CADDS SHEET 42

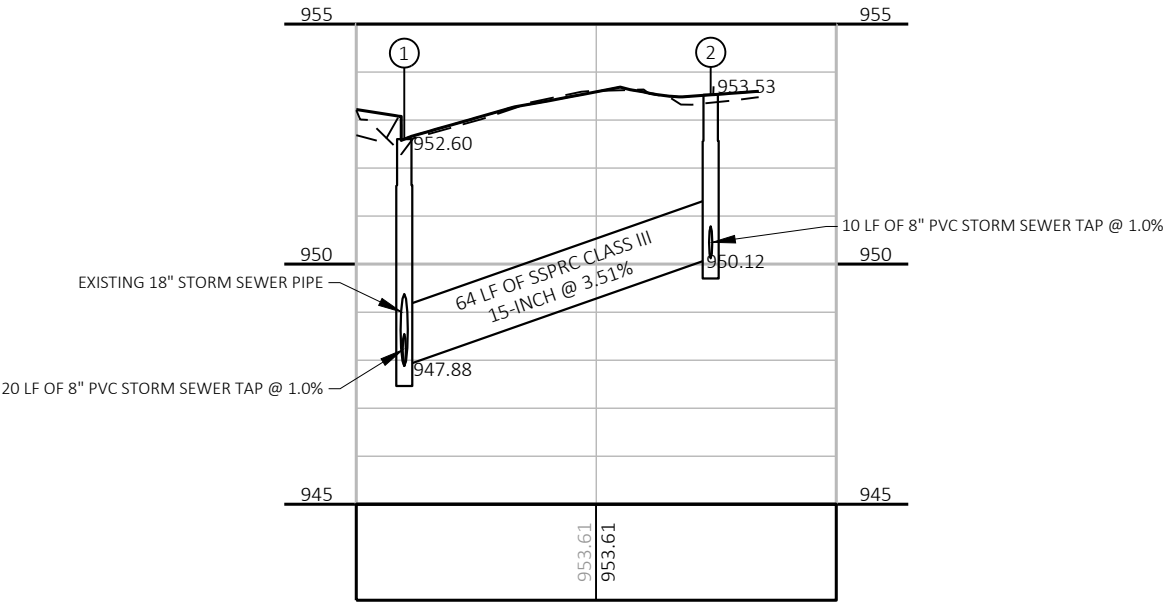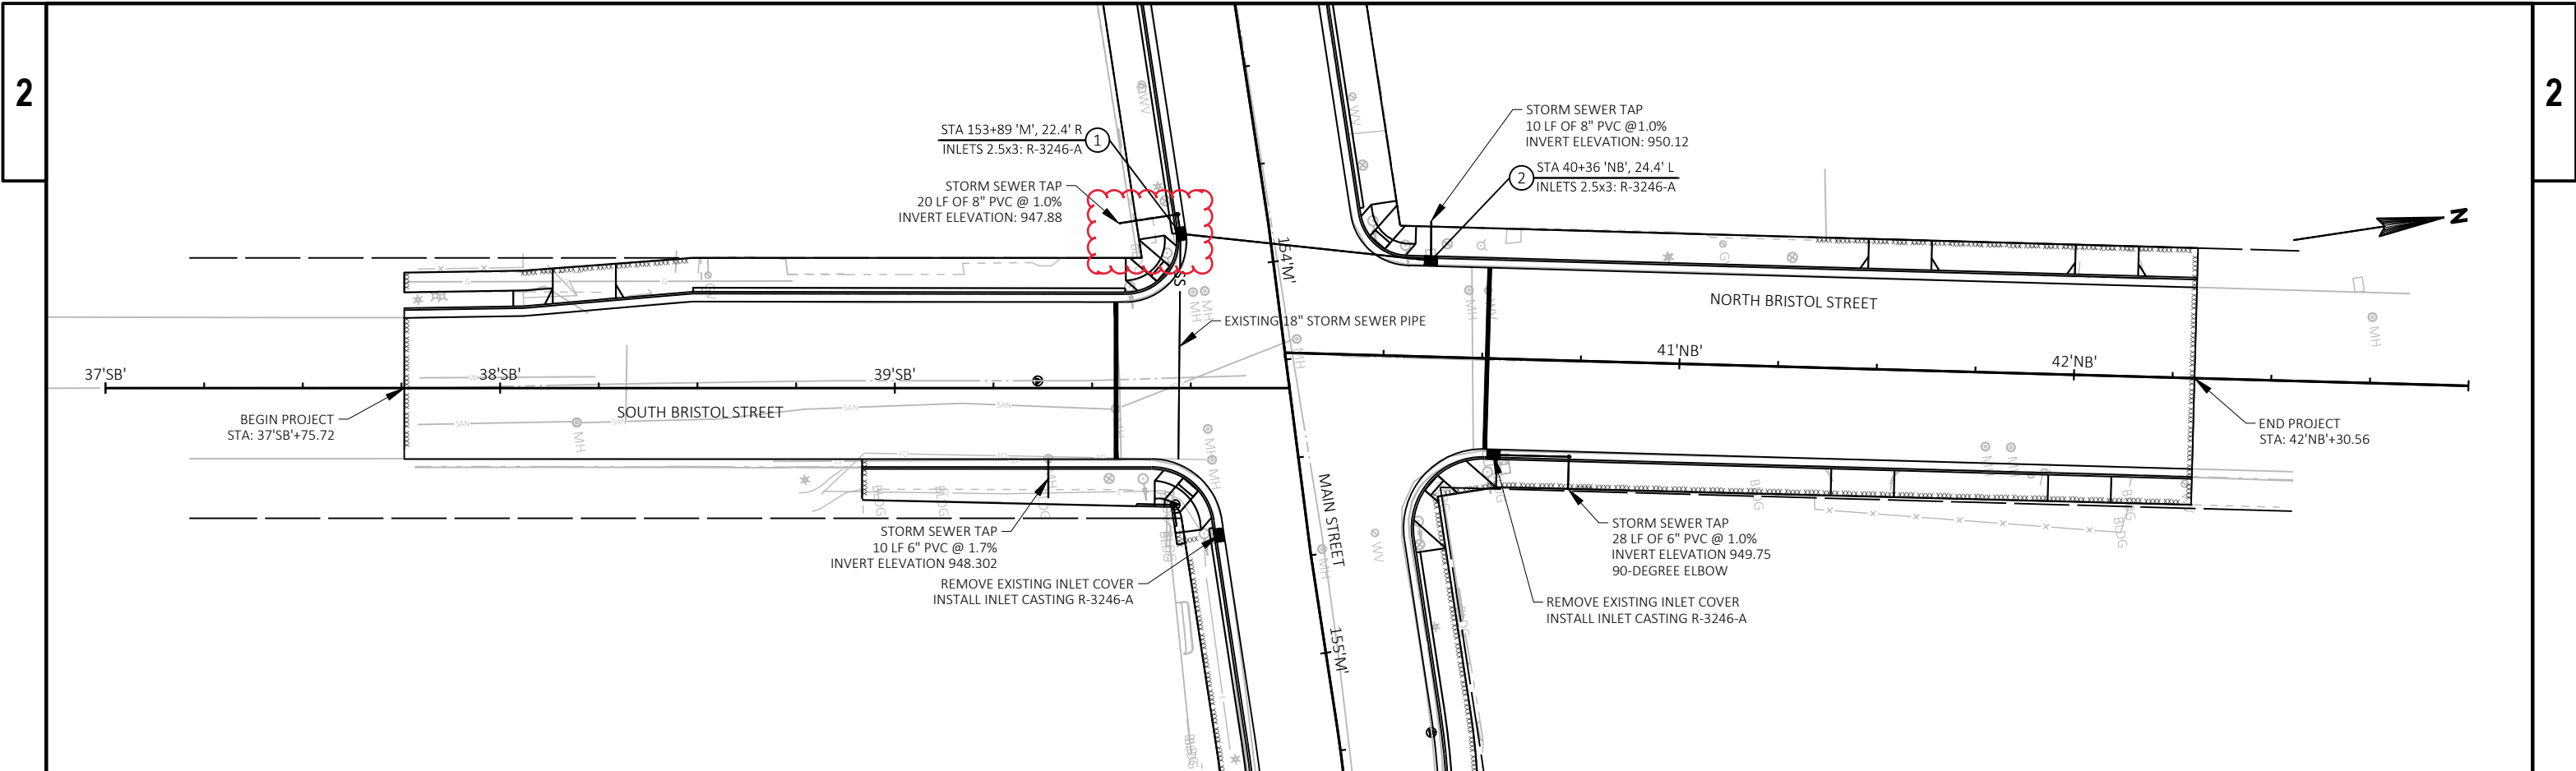


STRUCTURE DATA TABLE					
NUMBER	STATION	OFFSET	RIM ELEVATION	INVERT ELEVATION	(5)STRUCTUR E DEPTH
1	153+89'M'	22.4' RT	952.547	947.880	3.7'
2	40+36'NB'	24.4' LT	953.420	950.120	2.3'

1. RIM ELEVATIONS ARE GIVEN AT THE CURB AND GUTTER FLANGE LINE FOR INLET GRATES
2. STATIONS AND OFFSETS ARE TO THE CENTER OF THE STRUCTURE
3. FOR STRUCTURES UNDER CURB & GUTTER: THE CENTER OF THE 2.5x3-FT INLET WAS CALCULATED TO BE 9" IN FRONT OF THE FACE OF CURB
4. PIPE LENGTHS ARE MEASURED TO THE CENTER OF STRUCTURES
5. STRUCTURE DEPTH = RIM/GRATE ELEV - INVERT ELEV - CASTING HEIGHT- ADJUSTMENTS
CASTING HEIGHT 6" AND ADJUSTMENT = 6" TYPICAL

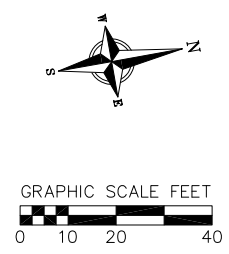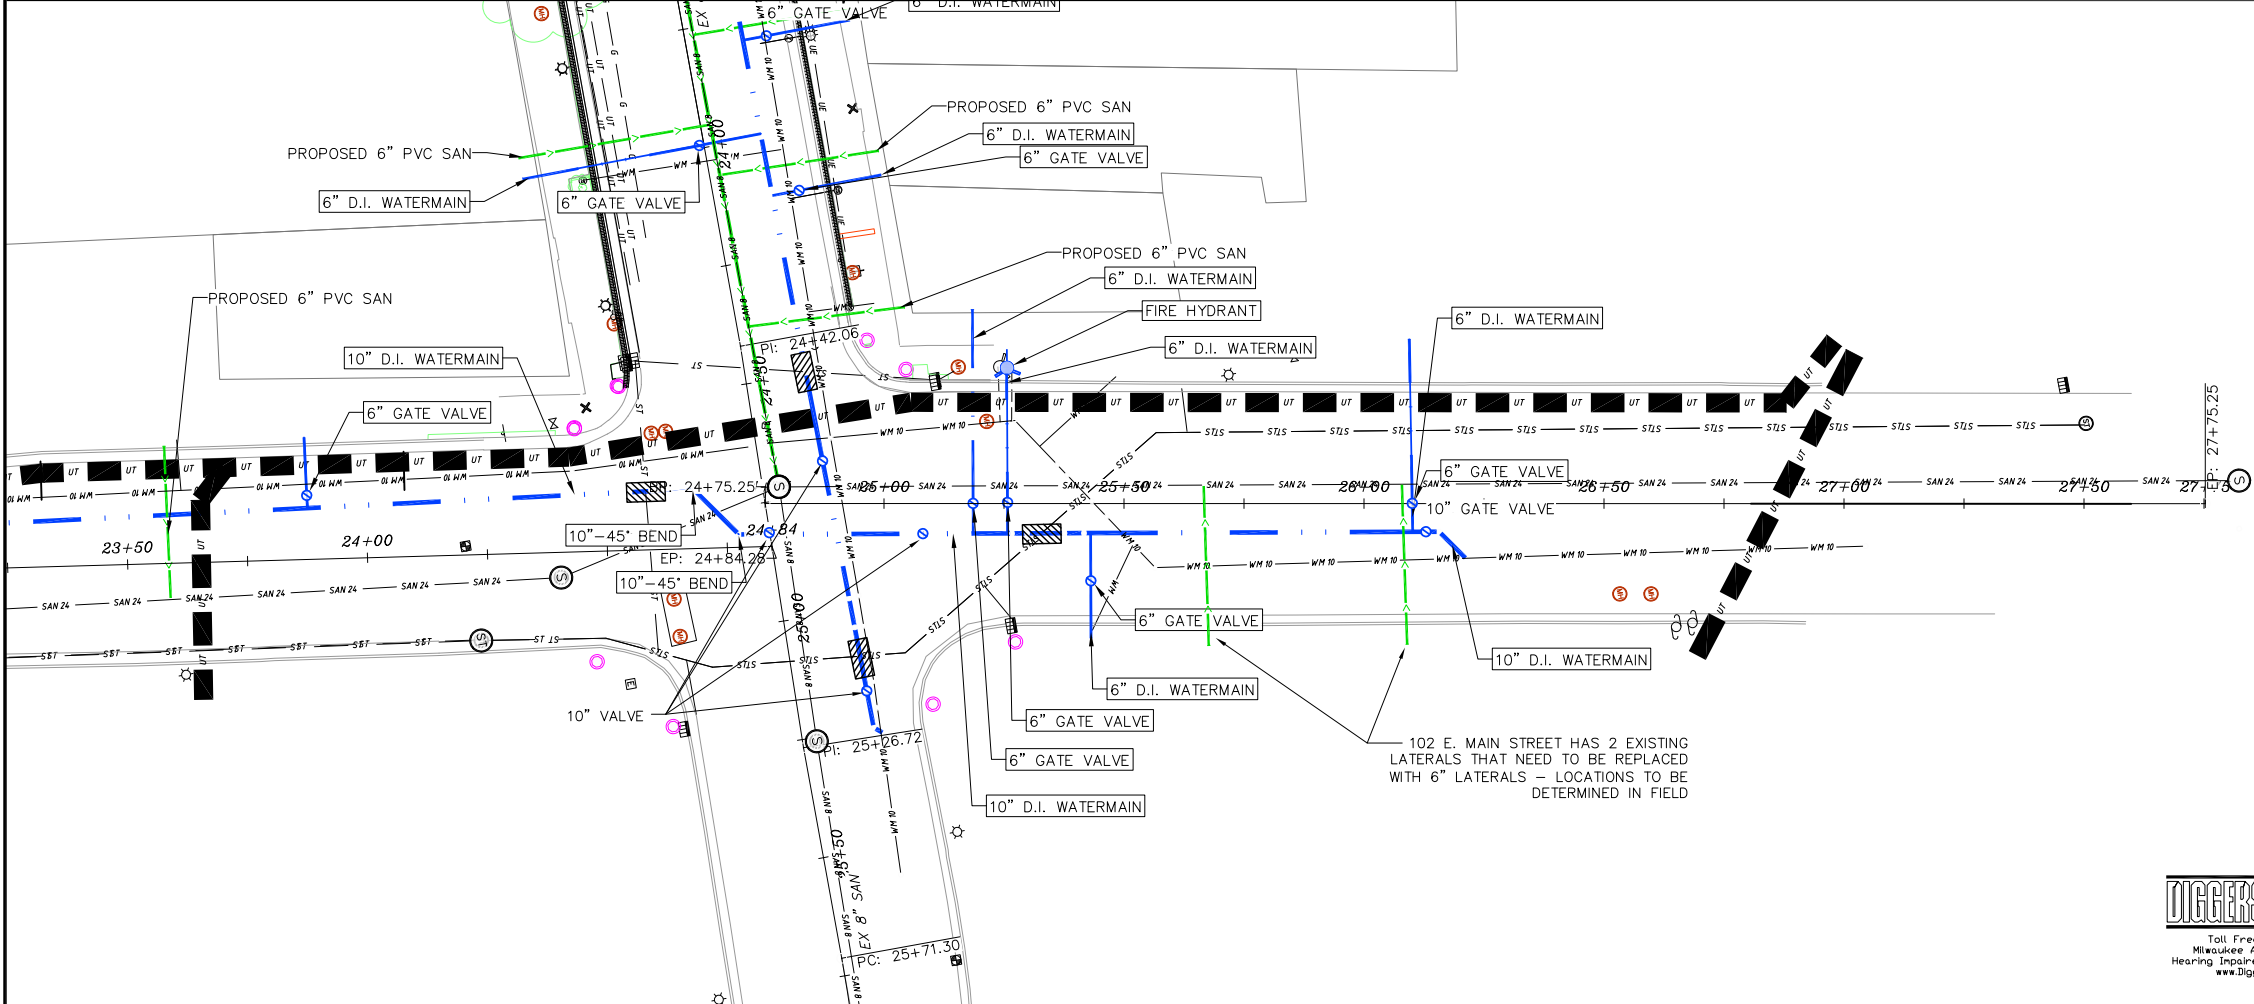

SANITARY SEWER NOTES:
- SANITARY SEWER LATERAL LOCATIONS ARE APPROXIMATE, BOTH HORIZONTAL & VERTICAL.
- ALL EXISTING SANITARY CASTINGS SHALL BE REMOVED, CONTRACTOR SHALL SALVAGE CASTINGS & DELIVER TO THE WASTE WATER TREATMENT PLANT.

WATER MAIN NOTES:
- WATER MAIN LOCATION IS APPROXIMATE, BOTH HORIZONTAL & VERTICAL.
- WATER MAIN TO BE INSULATED AT ALL STORM SEWER CROSSINGS WITH 4"x8"x2" STYROFOAM BOARD.
- CONTRACTOR SHALL CONTACT SUN PRAIRIE UTILITIES PRIOR TO THE OPERATION OF WATER MAIN VALVES.
- ALL VALVES & CURB BOXES WITHIN THE LIMITS OF CONSTRUCTION THAT REMAIN, SHALL BE ADJUSTED TO GRADE.

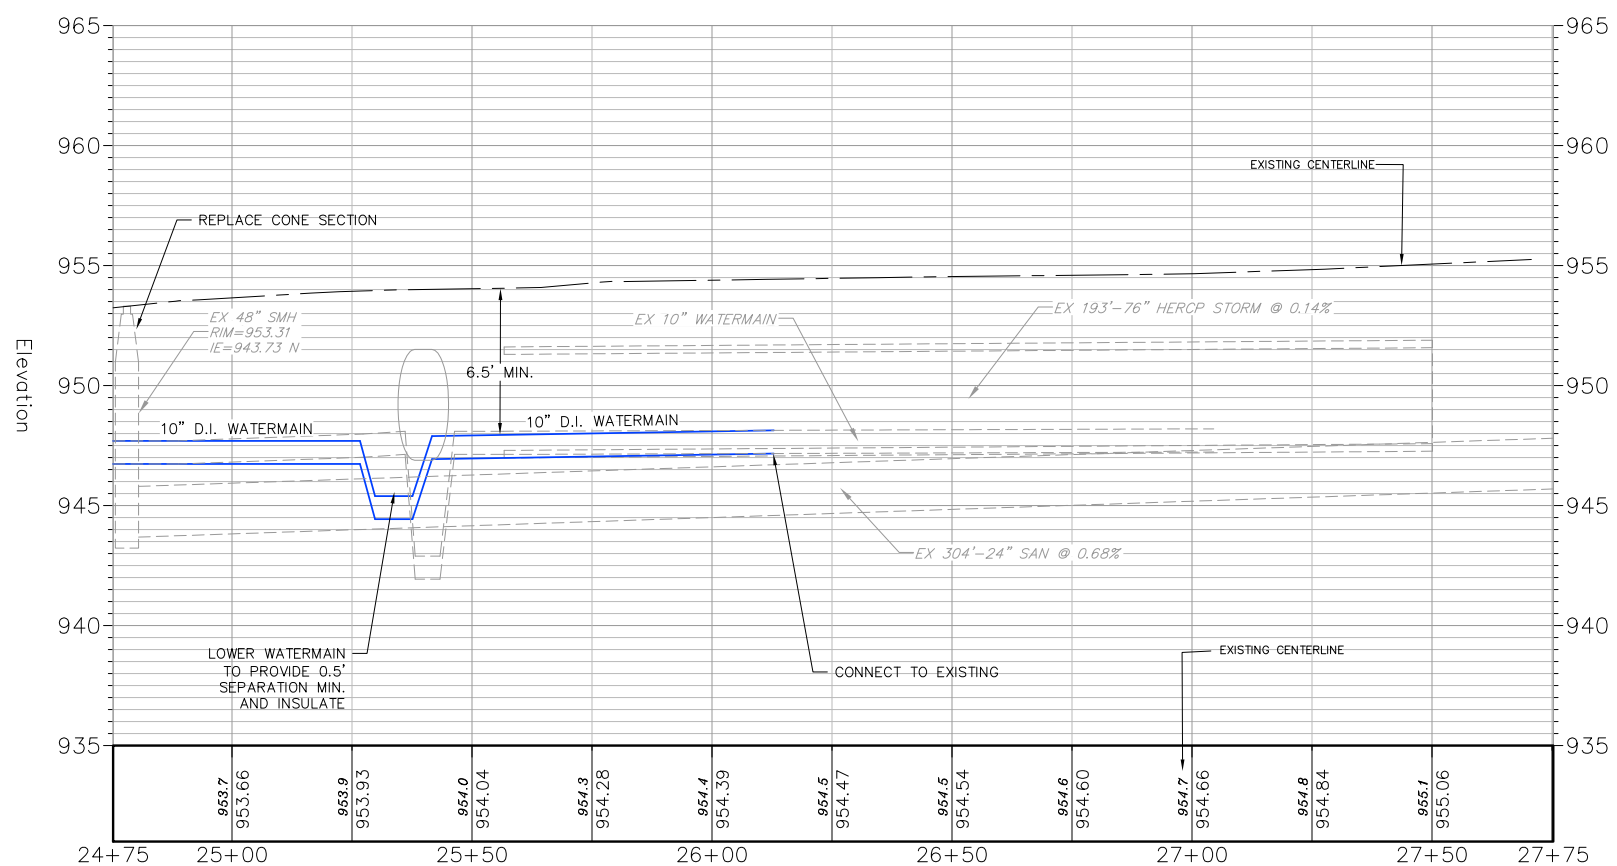

PLANS PREPARED BY
THE CITY OF SUN PRAIRIE
300 East Main Street
Sun Prairie, Wisconsin 53590

NORTH BRISTOL STREET
Bristol and Main Street Reconstruction Project
City of Sun Prairie
Dane County, Wisconsin

REVISIONS		REVISIONS	
NO.	DATE	NO.	DATE

SCALE:
AS SHOWN

DATE:
8/15/18


DR BY:
TJA, TRV

CHK BY:

JOB NO:


SHEET
2 OF 3

DWG. NO.

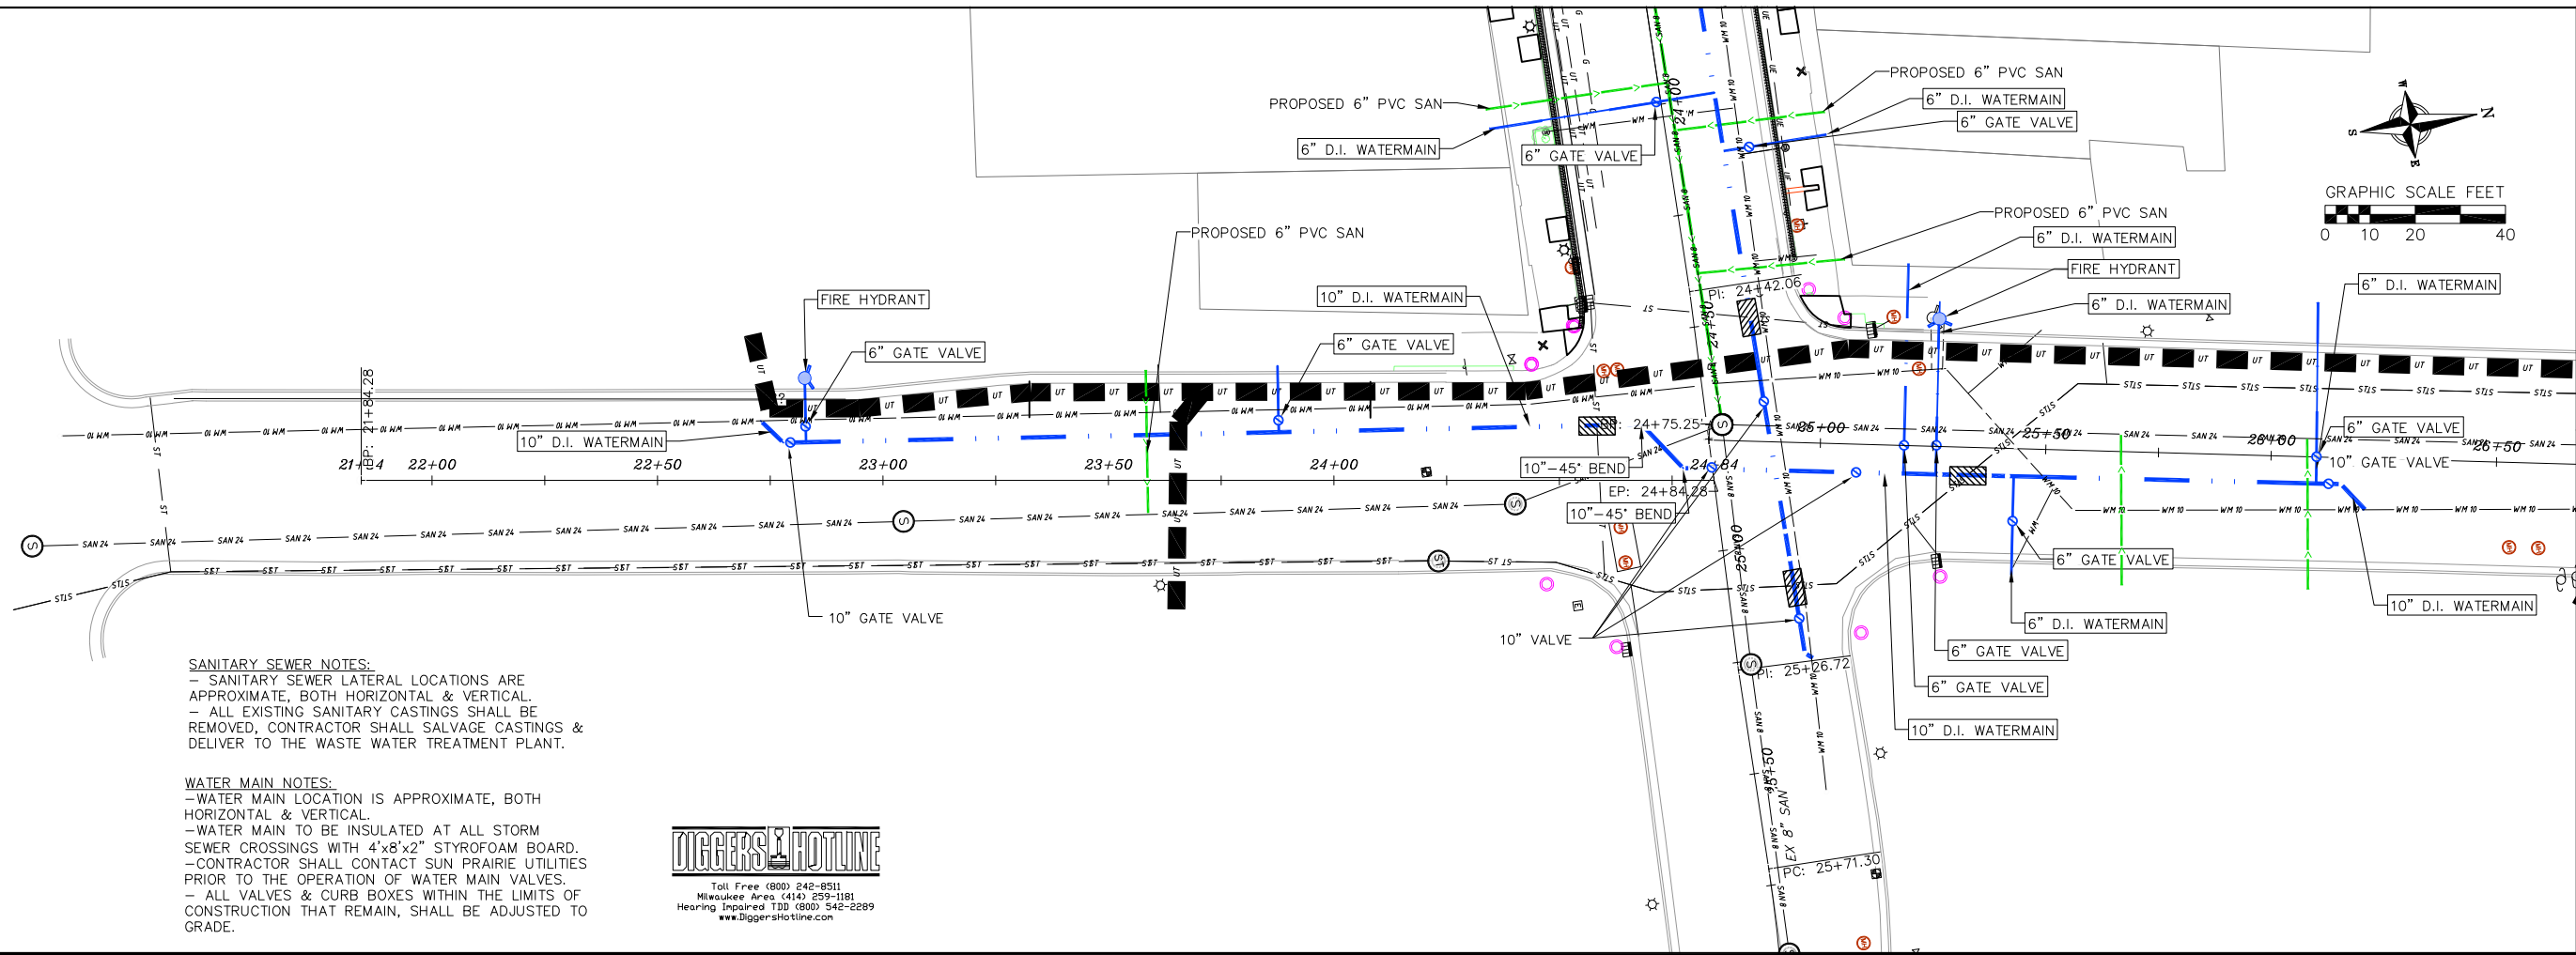

SANITARY SEWER NOTES:
- SANITARY SEWER LATERAL LOCATIONS ARE APPROXIMATE, BOTH HORIZONTAL & VERTICAL.
- ALL EXISTING SANITARY CASTINGS SHALL BE REMOVED, CONTRACTOR SHALL SALVAGE CASTINGS & DELIVER TO THE WASTE WATER TREATMENT PLANT.

WATER MAIN NOTES:
- WATER MAIN LOCATION IS APPROXIMATE, BOTH HORIZONTAL & VERTICAL.
- WATER MAIN TO BE INSULATED AT ALL STORM SEWER CROSSINGS WITH 4"x8"x2" STYROFOAM BOARD.
- CONTRACTOR SHALL CONTACT SUN PRAIRIE UTILITIES PRIOR TO THE OPERATION OF WATER MAIN VALVES.
- ALL VALVES & CURB BOXES WITHIN THE LIMITS OF CONSTRUCTION THAT REMAIN, SHALL BE ADJUSTED TO GRADE.

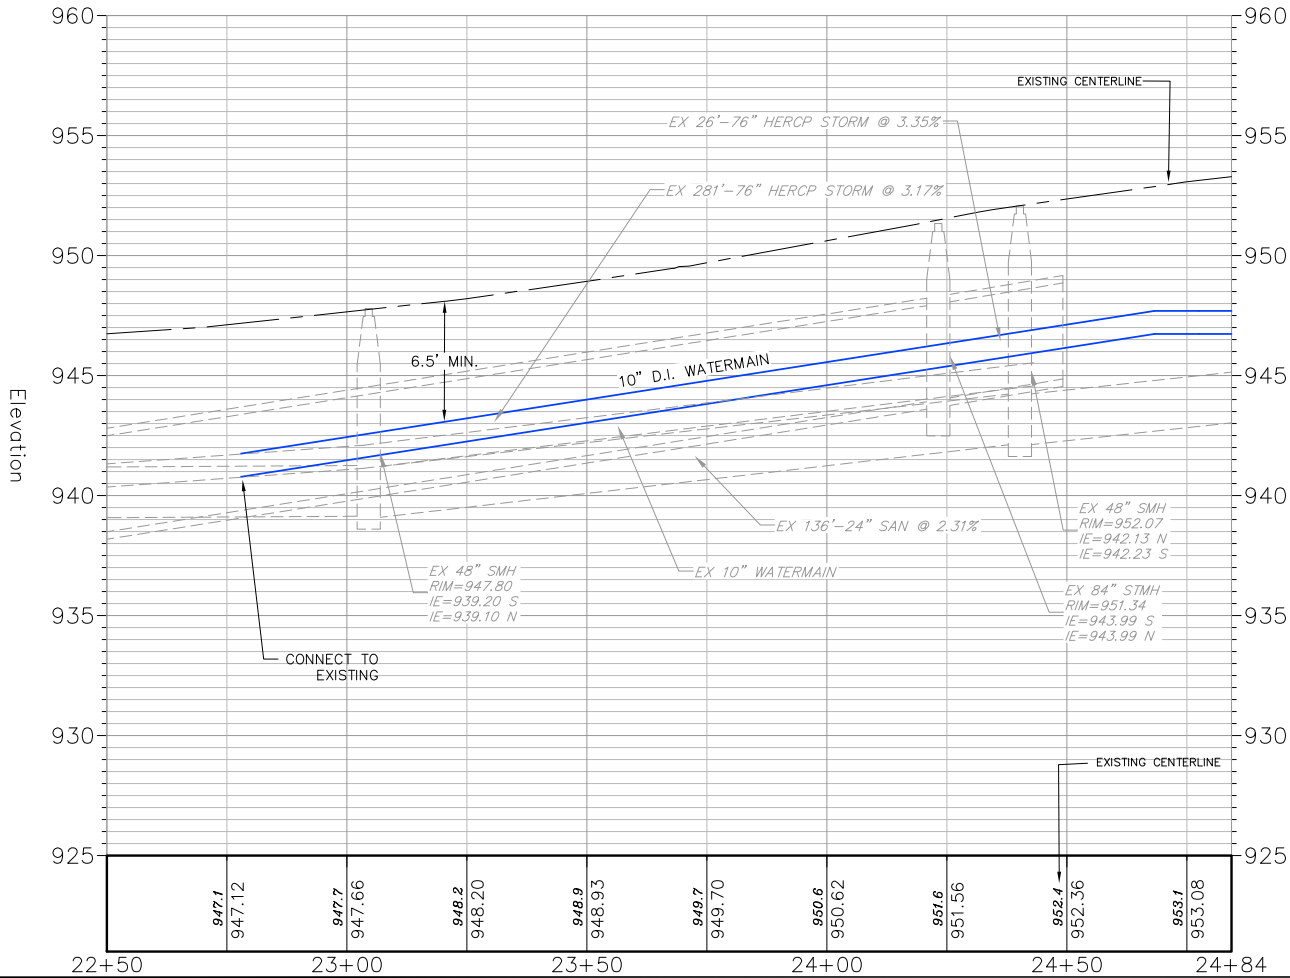

THE CITY OF SUN PRAIRIE
300 East Main Street
Sun Prairie, Wisconsin 53590

PLANS PREPARED BY

SOUTH BRISTOL STREET
Bristol and Main Street Reconstruction Project
City of Sun Prairie
Dane County, Wisconsin

REVISIONS		REVISIONS	
NO.	DATE	NO.	DATE

SCALE:
AS SHOWN

DATE:
8/15/18


DR BY:
TJA, TRV

CHK BY:


JOB NO:


SHEET
3 OF 3


DWG. NO.

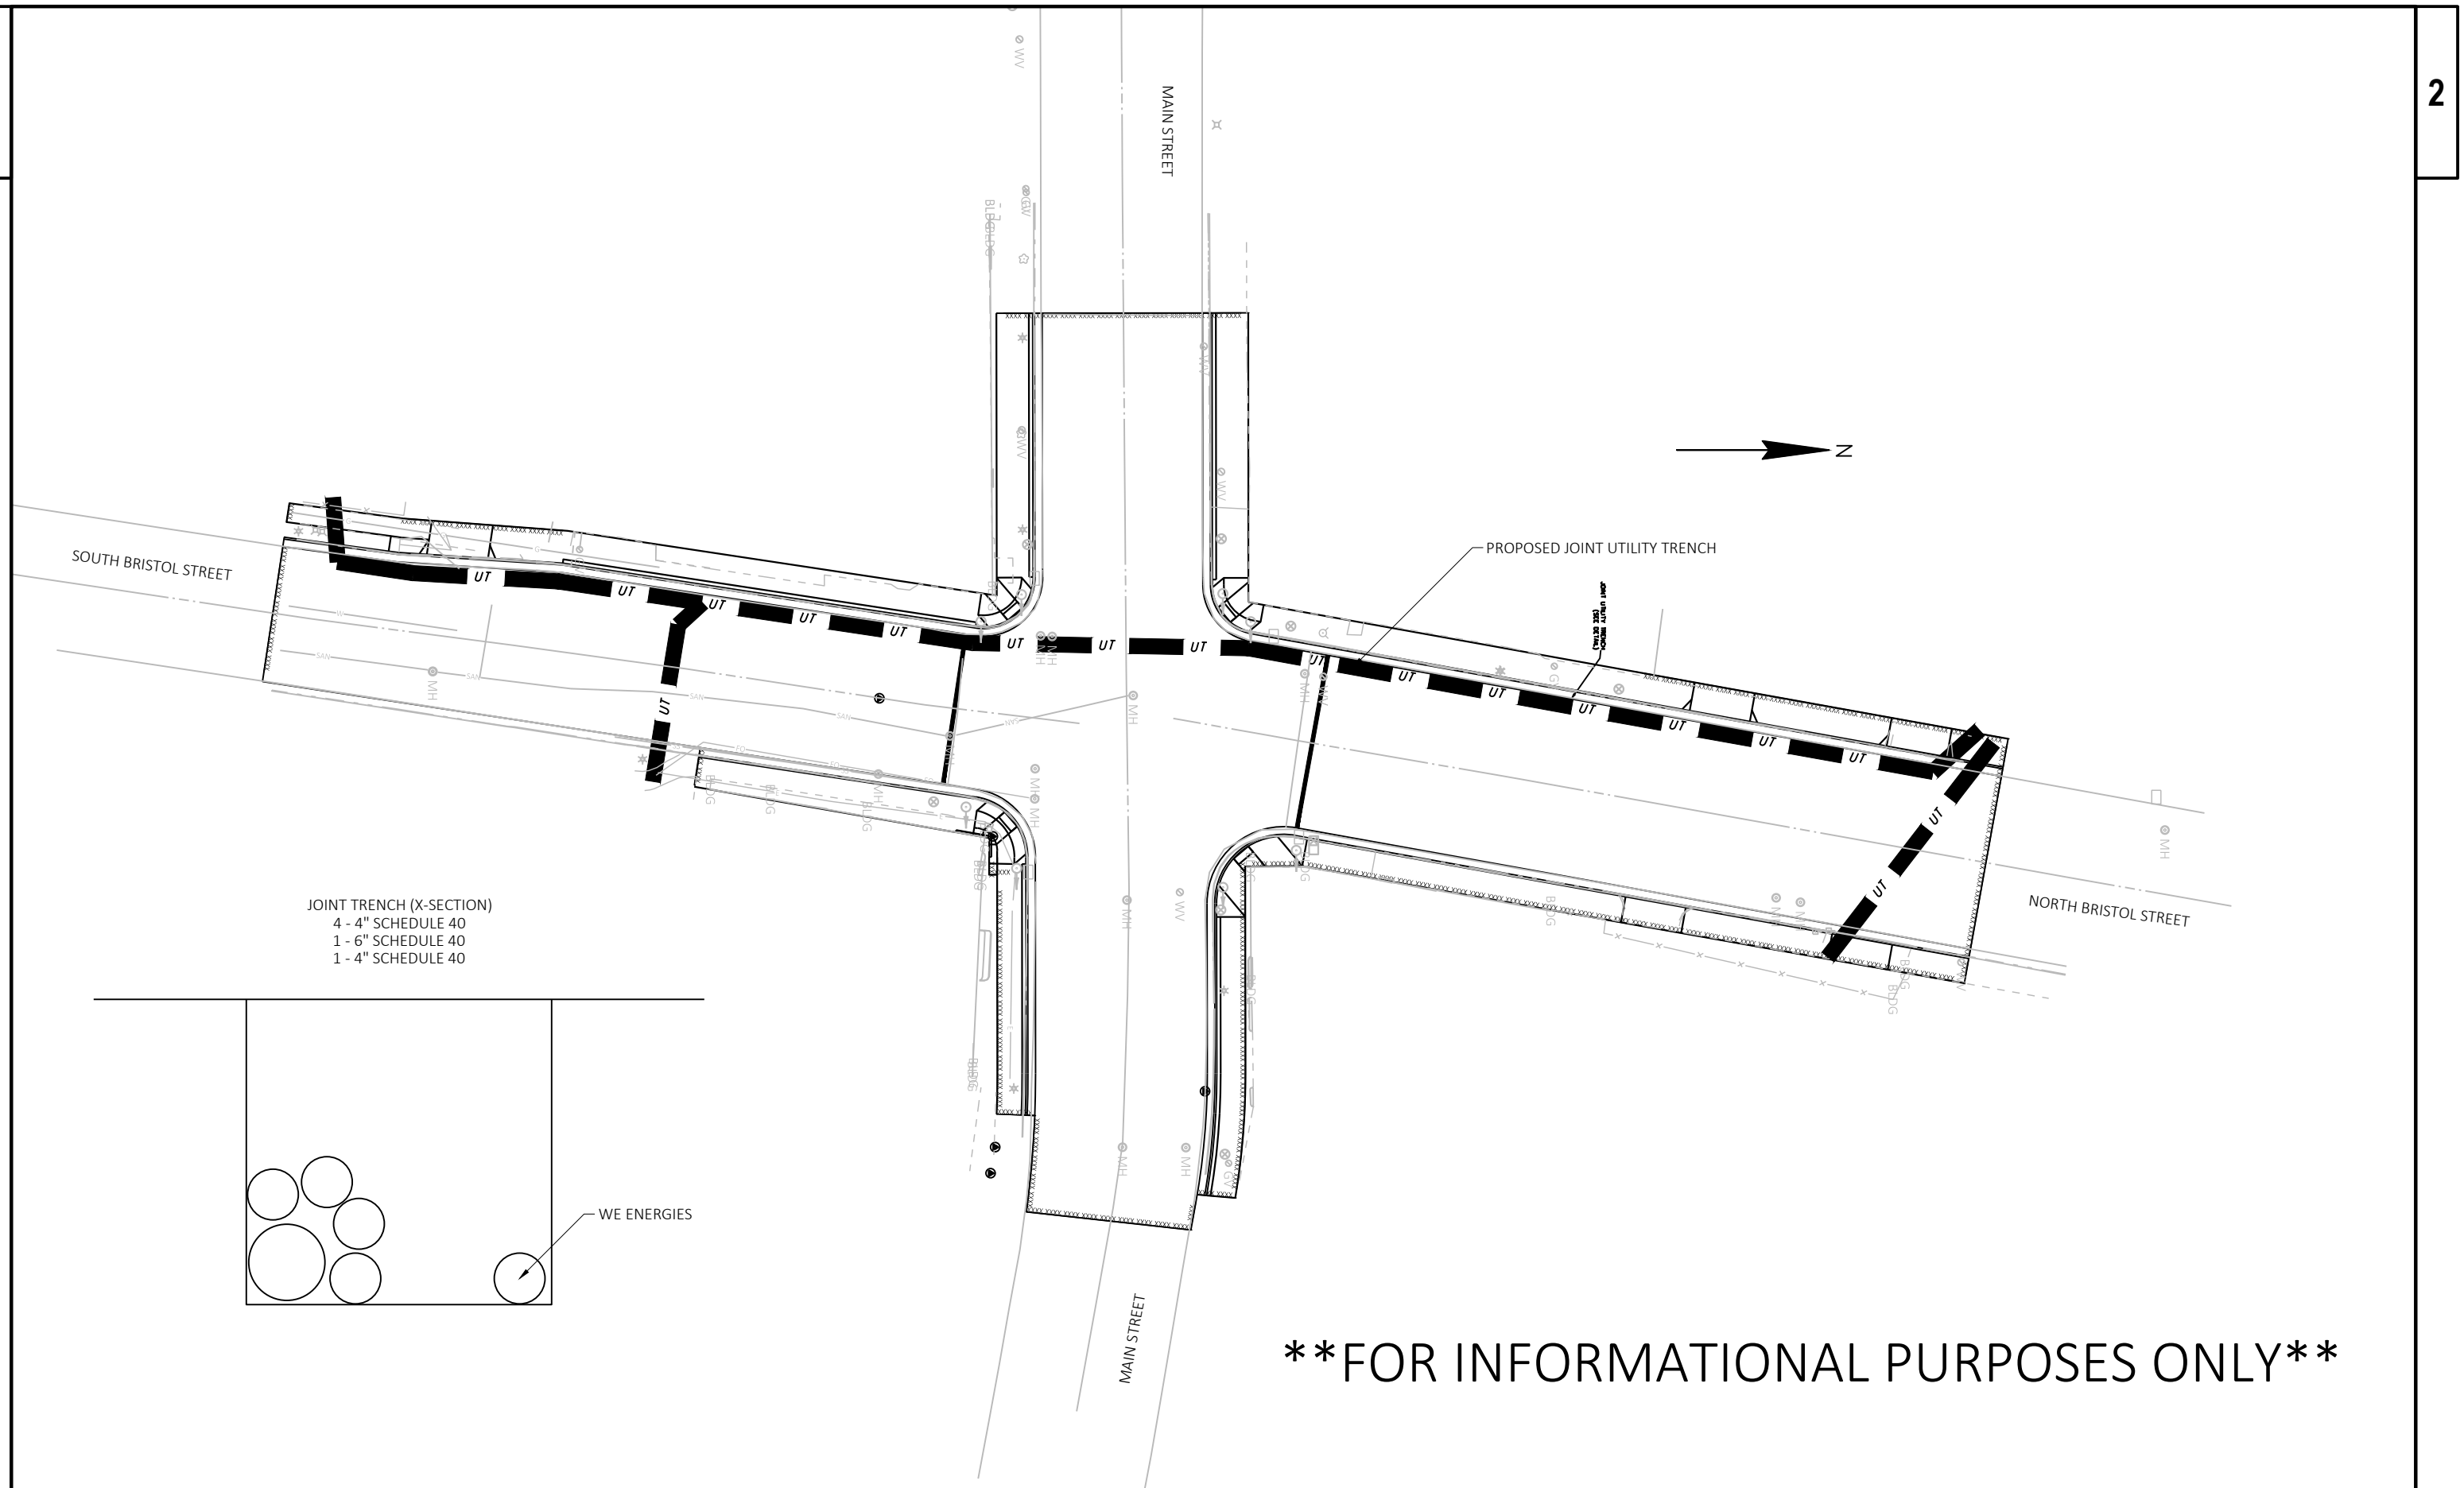

****FOR INFORMATIONAL PURPOSES ONLY****

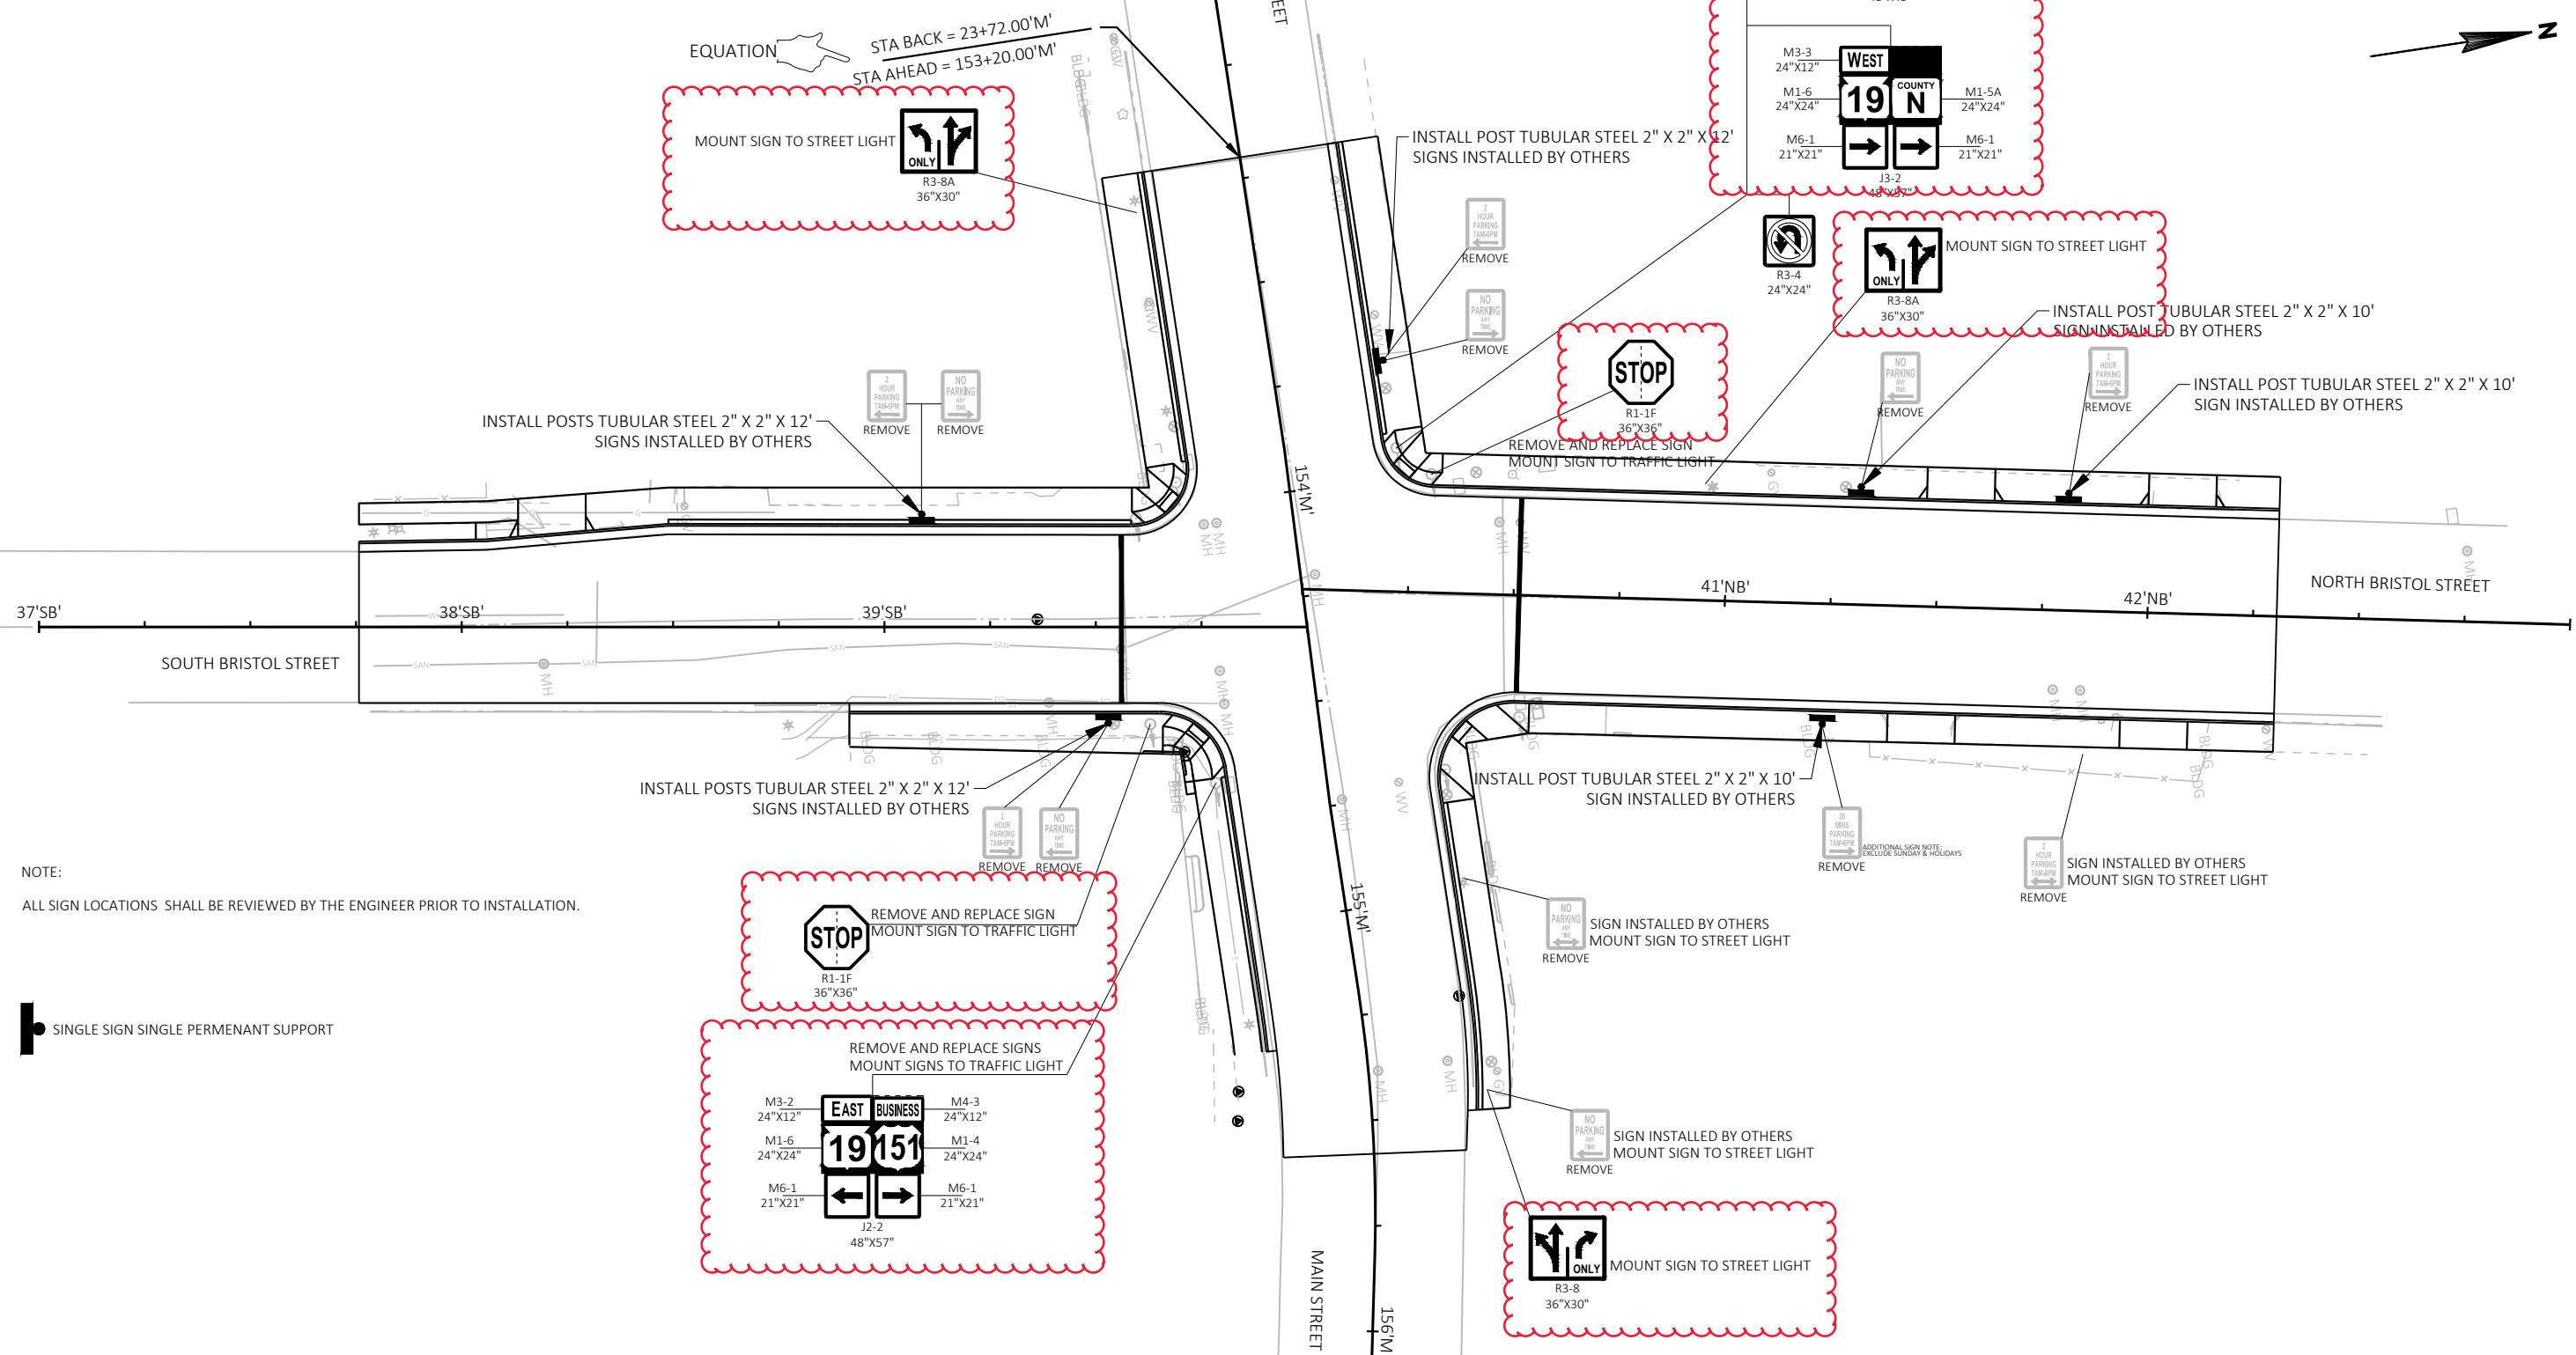

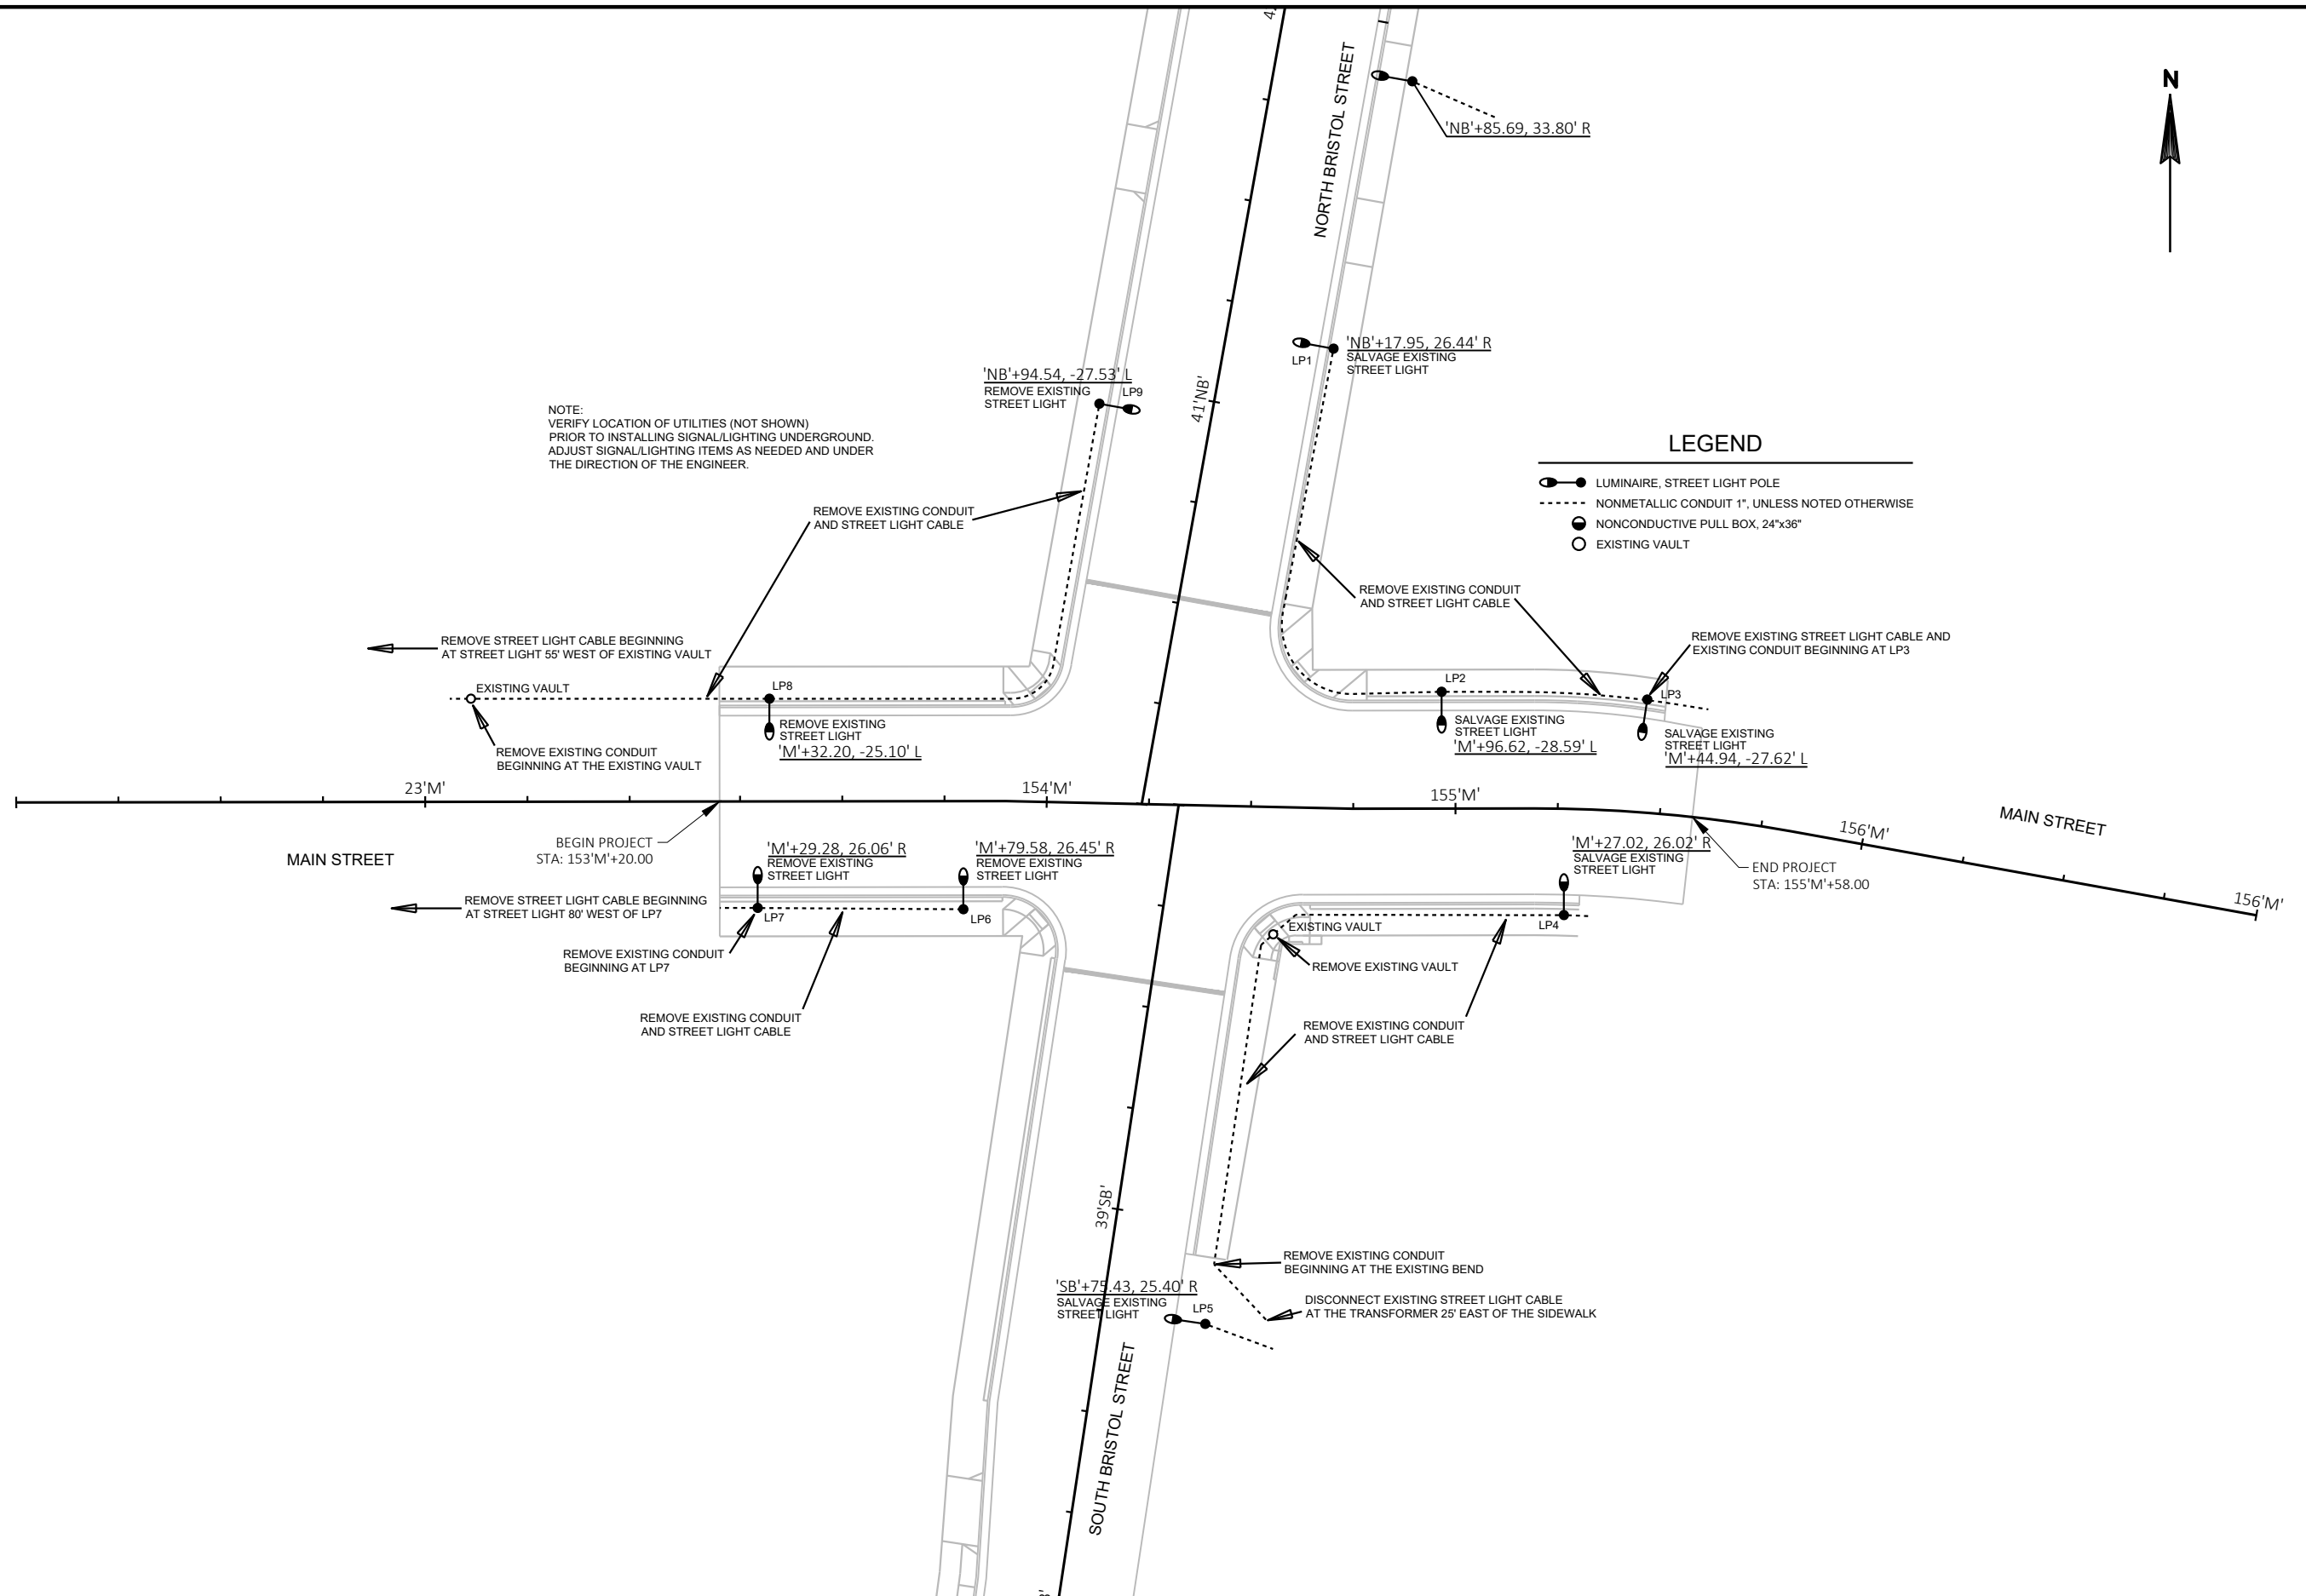

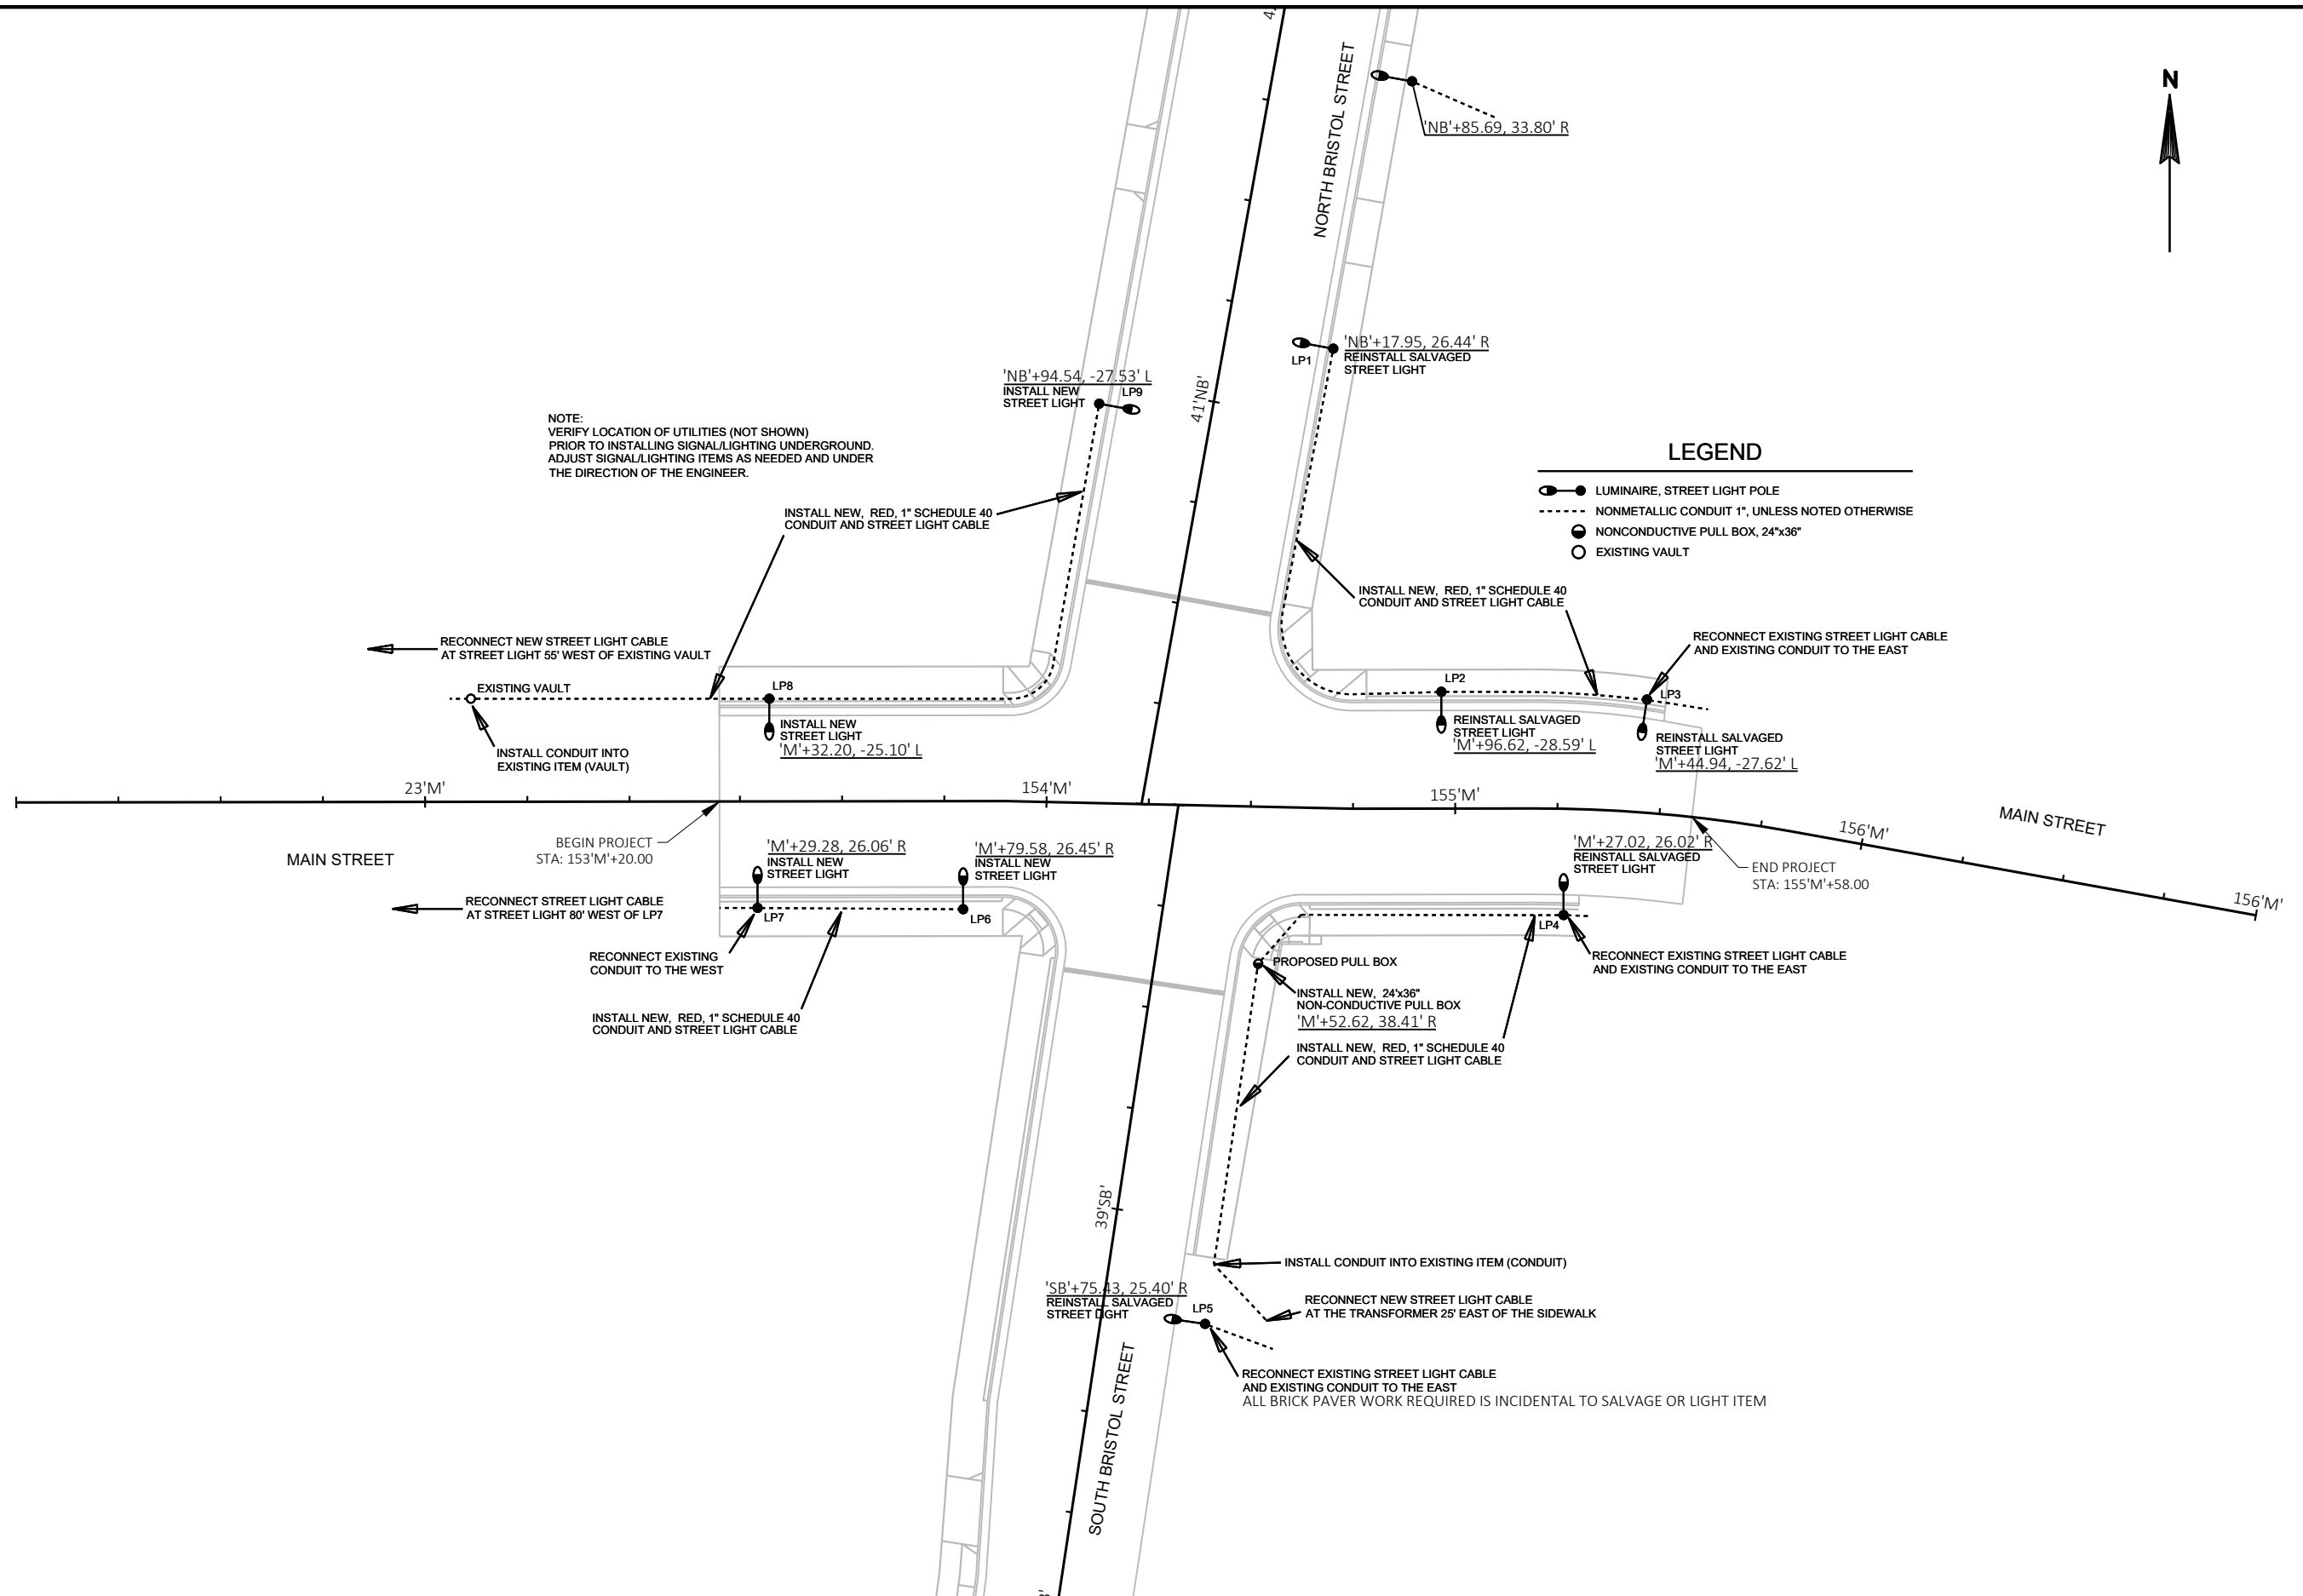

LOOPS TO BE COORDINATED WITH
CITY OF SUN PRAIRIE CONSTRUCTION PROJECT ON MAIN STREET

BEGIN PROJECT
STA: 153'M'+20.00

NOTE:
VERIFY LOCATION OF UTILITIES (NOT SHOWN)
PRIOR TO INSTALLING SIGNAL/LIGHTING UNDERGROUND.
ADJUST SIGNAL/LIGHTING ITEMS AS NEEDED AND UNDER
THE DIRECTION OF THE ENGINEER.

LEGEND

- ☐ CONTROL CABINET
- NONMETALLIC CONDUIT 2" UNLESS NOTED OTHERWISE
- SIGNAL HEAD, TRAFFIC SIGNAL STANDARD, PEDESTAL BASE
- SIGNAL HEAD, TRAFFIC SIGNAL POLE, TRANSFORMER BASE
- LUMINAIRE, TRAFFIC POLE, TRANSFORMER BASE
- ACCESSABLE PEDESTRIAN DETECTION
- ☐ LOOP DETECTOR IN 1" NONMETALLIC CONDUIT
- NONCONDUCTIVE PULL BOX, 24"x42"
- NONCONDUCTIVE PULL BOX, 24"x36"
- ☉ TRAFFIC SIGNAL HEAD
- ☐ PEDESTRIAN COUNT-DOWN HEAD
- ④ EVP DESIGNATOR
- EVP DETECTOR HEAD
- ◆ NON-INTRUSIVE VEHICLE DETECTOR (VIDEO)

N

MAIN STREET

WISDOT TO VERIFY EXISTING LOOP IN FIELD


END PROJECT
STA: 155'M'+58.00

STATION AND OFFET

CABINET AND PULL BOXES		SIGNAL BASES		LOOP DECTECTOR	
CB1	154+59.21'M', 53.17' L	SB1	154+59.61'M', 47.86' L	21	156+04.00'M', 9.00' L
PB1	154+57.64'M', 46.01' L	SB2	154+76.85'M', 29.49' L	22	155+44.02'M', 8.12' L
PB2	154+75.46'M', 28.01' L	SB3	154+67.48'M', 26.77' R	41	41+11.92'NB', 19.50' L
PB3	155+44.00'M', 27.14' L	SB4	154+50.94'M', 39.47' R	42	154+08.95'M', 43.07' L
PB4	156+04.00'M', 25.06' L	SB5	153+99.61'M', 40.16' R	61	23+06.55'M', 19.72' R
PB5	154+75.30'M', 26.00' R	SB6	153+86.76'M', 26.53' R	62	23+66.55'M', 19.72' R
PB6	154+51.06'M', 50.95' R	SB7	153+86.94'M', 26.49' L	63	153+89.55'M', 8.29' R
PB7	154+00.09'M', 44.03' R	SB8	154+00.46'M', 38.84' L	71	154+20.34'M', 41.48' L
PB8	153+83.64'M', 25.20' R			81	154+34.94'M', 38.52' R
PB9	23+66.56'M', 25.16' R			82	154+43.86'M', 39.67' R
PB10	23+06.56'M', 25.12' R				
PB11	153+78.59'M', 25.04' L				
PB12	154+00.48'M', 42.26' L				
PB13	41+11.92'NB', 29.14' L				

	HEAD NUMBERS	F L A S H
φ1		
φ2	1,2,3	R
φ3		
φ4	4,5,6	R
φ5		
φ6	7,8,9	R
φ7/φ7 RT	5,6,1,2	
φ8	10,11,12	R
φ2 PED	14,19	
φ4 PED	17,20	
φ6 PED	15,18	
φ8 PED	13,16	
OLA		
OLB		
OLC		
OLD		
OLE		
OLF		
OLG		
OLH		

OL ASSIGNMENTS

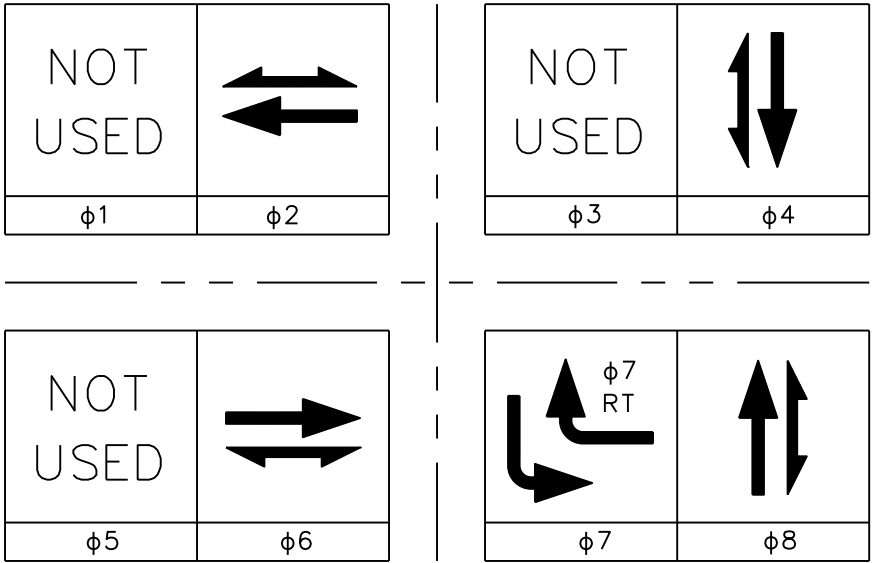

CONTROLLER LOGIC

PHASE NUMBER	PHASE LOCKING	DUAL ENTRY W / φ	PHASE RECALL	PHASE ACTIVE
1				
2	X	6	MIN	X
3				
4	X	3		X
5				
6	X	2	MIN	X
7				X
8	X	4		X

TYPE OF INTERCONNECT	
NONE	X
TBC	
CLOSED LOOP TWISTED PAIR	
CLOSED LOOP FIBER OPTIC	
RADIO	

TYPE OF LIGHTING	
BY OTHER AGENCY	
IN TRAFFIC SIGNAL CABINET	X
IN SEPERATE DOT LIGHTING CABINET	

TYPE OF PRE-EMPT	
NONE	
RAILROAD	
EMERGENCY VEHICLE	X
GTT	
TOMAR	X
HARDWIRE	
OTHER	
LIFT BRIDGE	
QUEUE DETECTOR	

TYPE OF REMOTE COMMUNICATION	
NONE	X
FIBER	
CELL MODEM	
PHONE	

SYSTEM INFORMATION	
LOCATION OF MASTER	
CONTROLLER NO:	S
SIGNAL SYSTEM:	SS

DETECTOR INPUT

DETECTOR NO.	3	1	7	5	11	9	15	13
PHASE CALLED	21	41	61	63	81			
PHASE EXTENDED	2		6		8			
CALLING DELAY	2	4	6	6	8			
EXTENSION STRETCH					3			
ALT. LOOP FUNCTION								

DETECTOR INPUT

DETECTOR NO.	4	2	8	6	12	10	16	14
PHASE CALLED	22	42	62	71	82			
PHASE EXTENDED	2	4	6	7	8			
CALLING DELAY	2	4	6	7				
EXTENSION STRETCH		10		3	15			
ALT. LOOP FUNCTION								

RACK 2 RESERVED FOR NON-INTRUSIVE DETECTION

19	17	23	21	27	25	31	29

20	18	24	22	28	26	32	30

DETECTOR INPUT

DETECTOR NO.							
PHASE CALLED							
PHASE EXTENDED							
CALLING DELAY							
EXTENSION STRETCH							
ALT. LOOP FUNCTION							

DETECTOR INPUT

DETECTOR NO.							
PHASE CALLED							
PHASE EXTENDED							
CALLING DELAY							
EXTENSION STRETCH							
ALT. LOOP FUNCTION							

PREEMPTION ASSIGNMENTS

PREEMPTION DESIGNATION	PREEMPTION TYPE	EVP CHANNEL	PHASE(S) CALLED	APPROACH
1	EVP	1	2 & 6	EB
2	EVP	2	2 & 6	WB
3	EVP	3	4 & 8	NB
4	EVP	4	4 & 7*	SB
5	NOT USED			
6	NOT USED			

* NOTE: WHEN CALLED, THE CONTROLLER SHALL TRANSITION THRU AN ALL-RED INTERVAL TO PREVENT PHASE 8 LEFT TURN TRAP.

STH 19 & MAIN ST./BRISTOL ST. TRAFFIC SIGNAL CABLING CHART NO. 14 CABLE						
CABLE RUN	CABLE	HEAD NUMBER	MOVEMENT	LENS	CONDUCTOR COLOR	REMARKS
CABINET TO SB-1	9C	11	NB	R	R	φ8
				Y	O	
				G	G	
		13	E LEG	W	BLU	φ8 PED
				DW	BLK	
PB	W/BLK					
CABINET TO SB-2	12C	1	WB	R	R	φ8
				Y	O	
				G	G	
				Y→	BLU/BLK	
		G→	BLK/W			
		9	EB	R	R/BLK	φ6
				Y	O/BLK	
				G	G/BLK	
		14	N LEG	W	BLU	φ2 PED
				DW	BLK	
PB	W/BLK					
CABINET TO SB-3	9C	8	EB	R	R	φ6
				Y	O	
				G	G	
		15	E LEG	W	BLU	φ6 PED
				DW	BLK	
PB	W/BLK					
CABINET TO SB-4	12C	6	SB	R	R	φ4
				Y	O	
				G	G	
				←Y	BLU/BLK	
				←G	BLK/W	
		10	NB	R	R/BLK	φ8
				Y	O/BLK	
				G	G/BLK	
		16	E LEG	W	BLU	φ8 PED
				DW	BLK	
				PB	W/BLK	

STH 19 & MAIN ST./BRISTOL ST. TRAFFIC SIGNAL CABLING CHART NO. 14 CABLE						
CABLE RUN	CABLE	HEAD NUMBER	MOVEMENT	LENS	CONDUCTOR COLOR	REMARKS
CABINET TO SB-5	9C	5	SB	R	R	φ4
				Y	O	
				←Y	BLU/BLK	
				←G	BLK/W	
				G	G	
		17	W LEG	G	G	
				W	BLU	φ4 PED
				DW	BLK	
				PB	W/BLK	
				PB	W/BLK	
CABINET TO SB-6	12C	3	WB	R	R	φ2
				Y	O	
				G	G	
		7	EB	R	R/BLK	φ6 PED
				Y	O/BLK	
				G	G/BLK	
		18	S LEG	W	BLU	φ6 PED
				DW	BLK	
				PB	W/BLK	
				PB	W/BLK	
CABINET TO SB-7	9C	2	WB	PB	W/BLK	
				R	R	φ2
				Y	O	
				G	G	
				Y→	BLU/BLK	
		19	N LEG	G→	BLK/W	
				W	BLU	φ2 PED
				DW	BLK	
				PB	W/BLK	
				PB	W/BLK	
CABINET TO SB-8	12C	4	SB	R	R	φ4
				Y	O	
				G	G	
		12	NB	Y→	BLU/BLK	
				Y	O/BLK	φ8
				G	G/BLK	
				W	BLU	φ4 PED
				DW	BLK	
		20	W LEG	PB	W/BLK	
				PB	W/BLK	


STH 19 & MAIN ST./BRISTOL ST. NON-INTRUSIVE DETECTION CABLING CHART CAT5E CABLE		
DEVICE	CABLE RUN	DEVICE LOCATION
ND-1	CABINET TO SB-1	NE QUADRANT
ND-2	CABINET TO SB-3	SE QUADRANT
ND-3	CABINET TO SB-5	SW QUADRANT
ND-4	CABINET TO SB-7	NW QUADRANT


STH 19 & MAIN ST./BRISTOL ST. EVP CABLING CHART EVP DETECTOR CABLE		
EVP DESIGNATOR	CABLE RUN	DEVICE LOCATION
1	CABINET TO SB-3	SE QUADRANT
2	CABINET TO SB-7	NW QUADRANT
3	CABINET TO SB-1	NE QUADRANT
4	CABINET TO SB-5	SW QUADRANT


STH 19 & MAIN ST./BRISTOL ST. LIGHTING CABLING CHART NO. 12 UF W/GROUND	
CABLE RUN	LUMINAIRE LOCATION
CABINET TO SB-3	SE QUADRANT
CABINET TO SB-7	NW QUADRANT

ELECTRICAL WIRE #10 AWG XLP (WHITE)	
FROM	TO
CB-1	PB-1
PB-1	PB-2
PB-2	PB-5
PB-5	PB-6
PB-6	PB-7
PB-7	PB-8
PB-8	PB-11
PB-11	PB-12
PB-12	PB-1
PB-1	CB-1
PB-1	SB-1
PB-2	SB-2
PB-5	SB-3
PB-6	SB-4
PB-7	SB-5
PB-8	SB-6
PB-11	SB-7
PB-12	SB-8


ELECTRICAL WIRE #10 AWG XLP (GREEN)	
FROM	TO
CB-1	PB-1
PB-1	PB-2
PB-2	PB-3
PB-3	PB-4
PB-2	PB-5
PB-5	PB-6
PB-6	PB-7
PB-7	PB-8
PB-8	PB-9
PB-9	PB-10
PB-8	PB-11
PB-11	PB-12
PB-12	PB-1
PB-1	CB-1
PB-1	SB-1
PB-2	SB-2
PB-5	SB-3
PB-6	SB-4
PB-7	SB-5
PB-8	SB-6
PB-11	SB-7
PB-12	SB-8

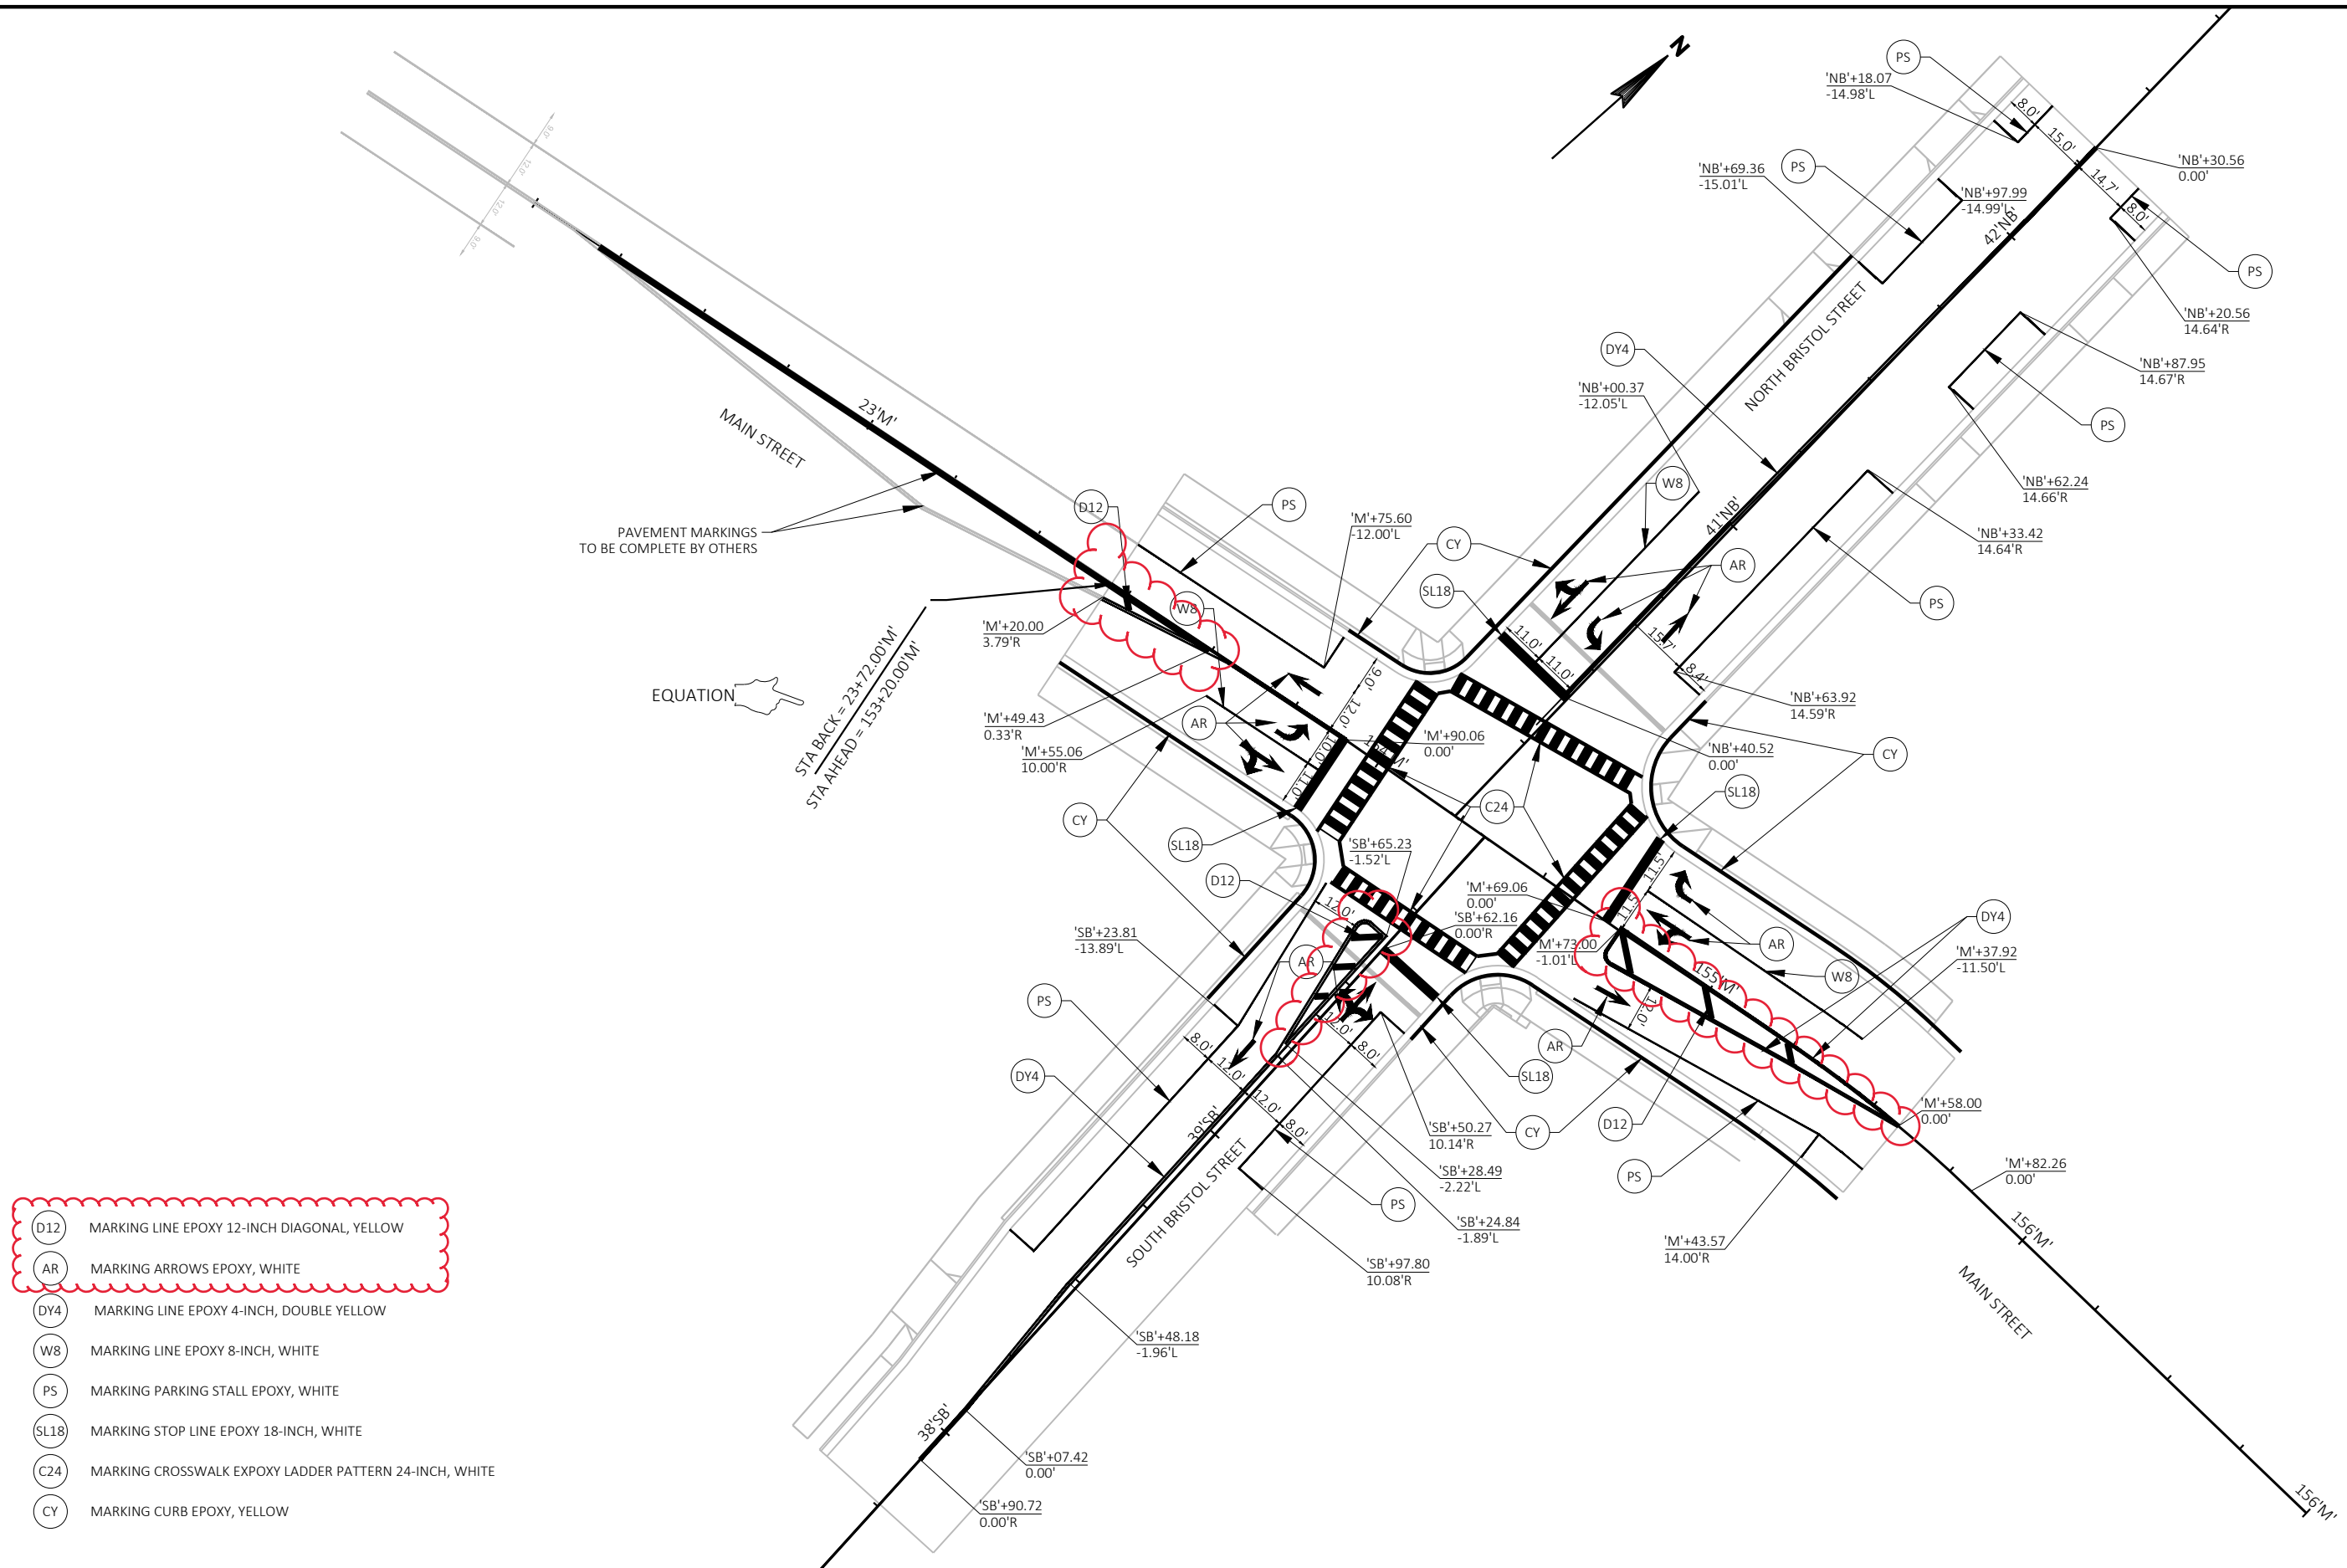

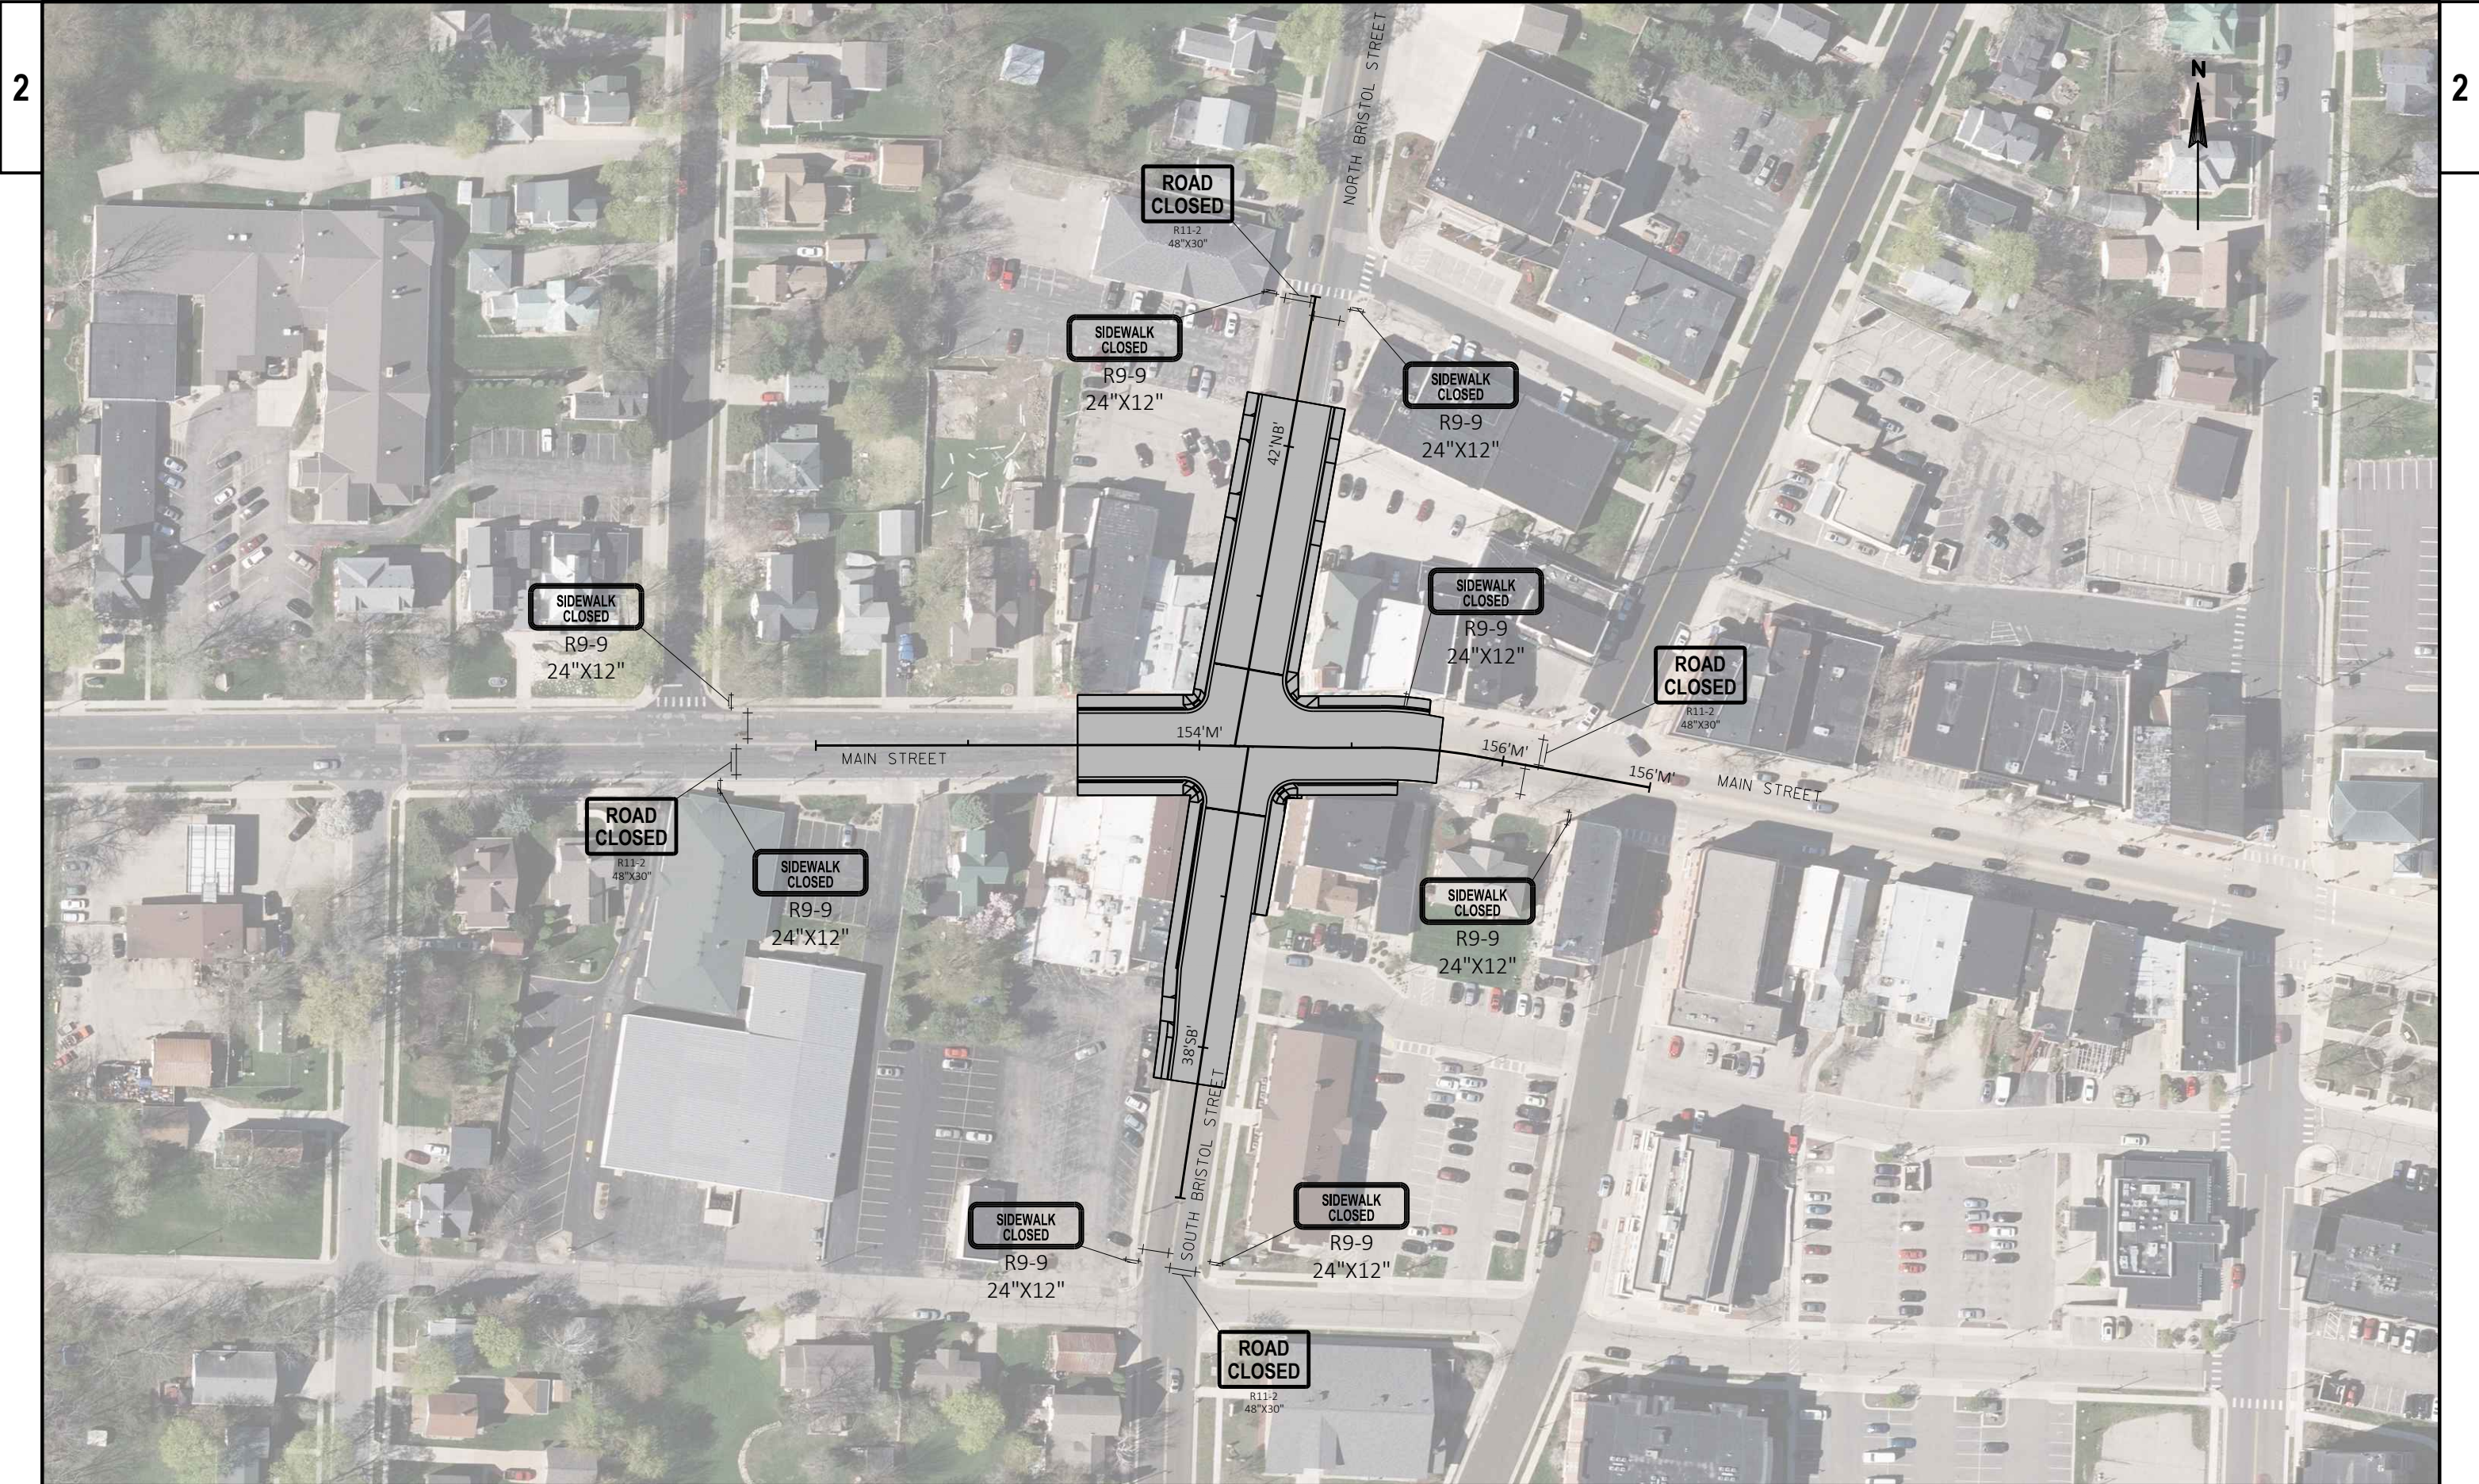


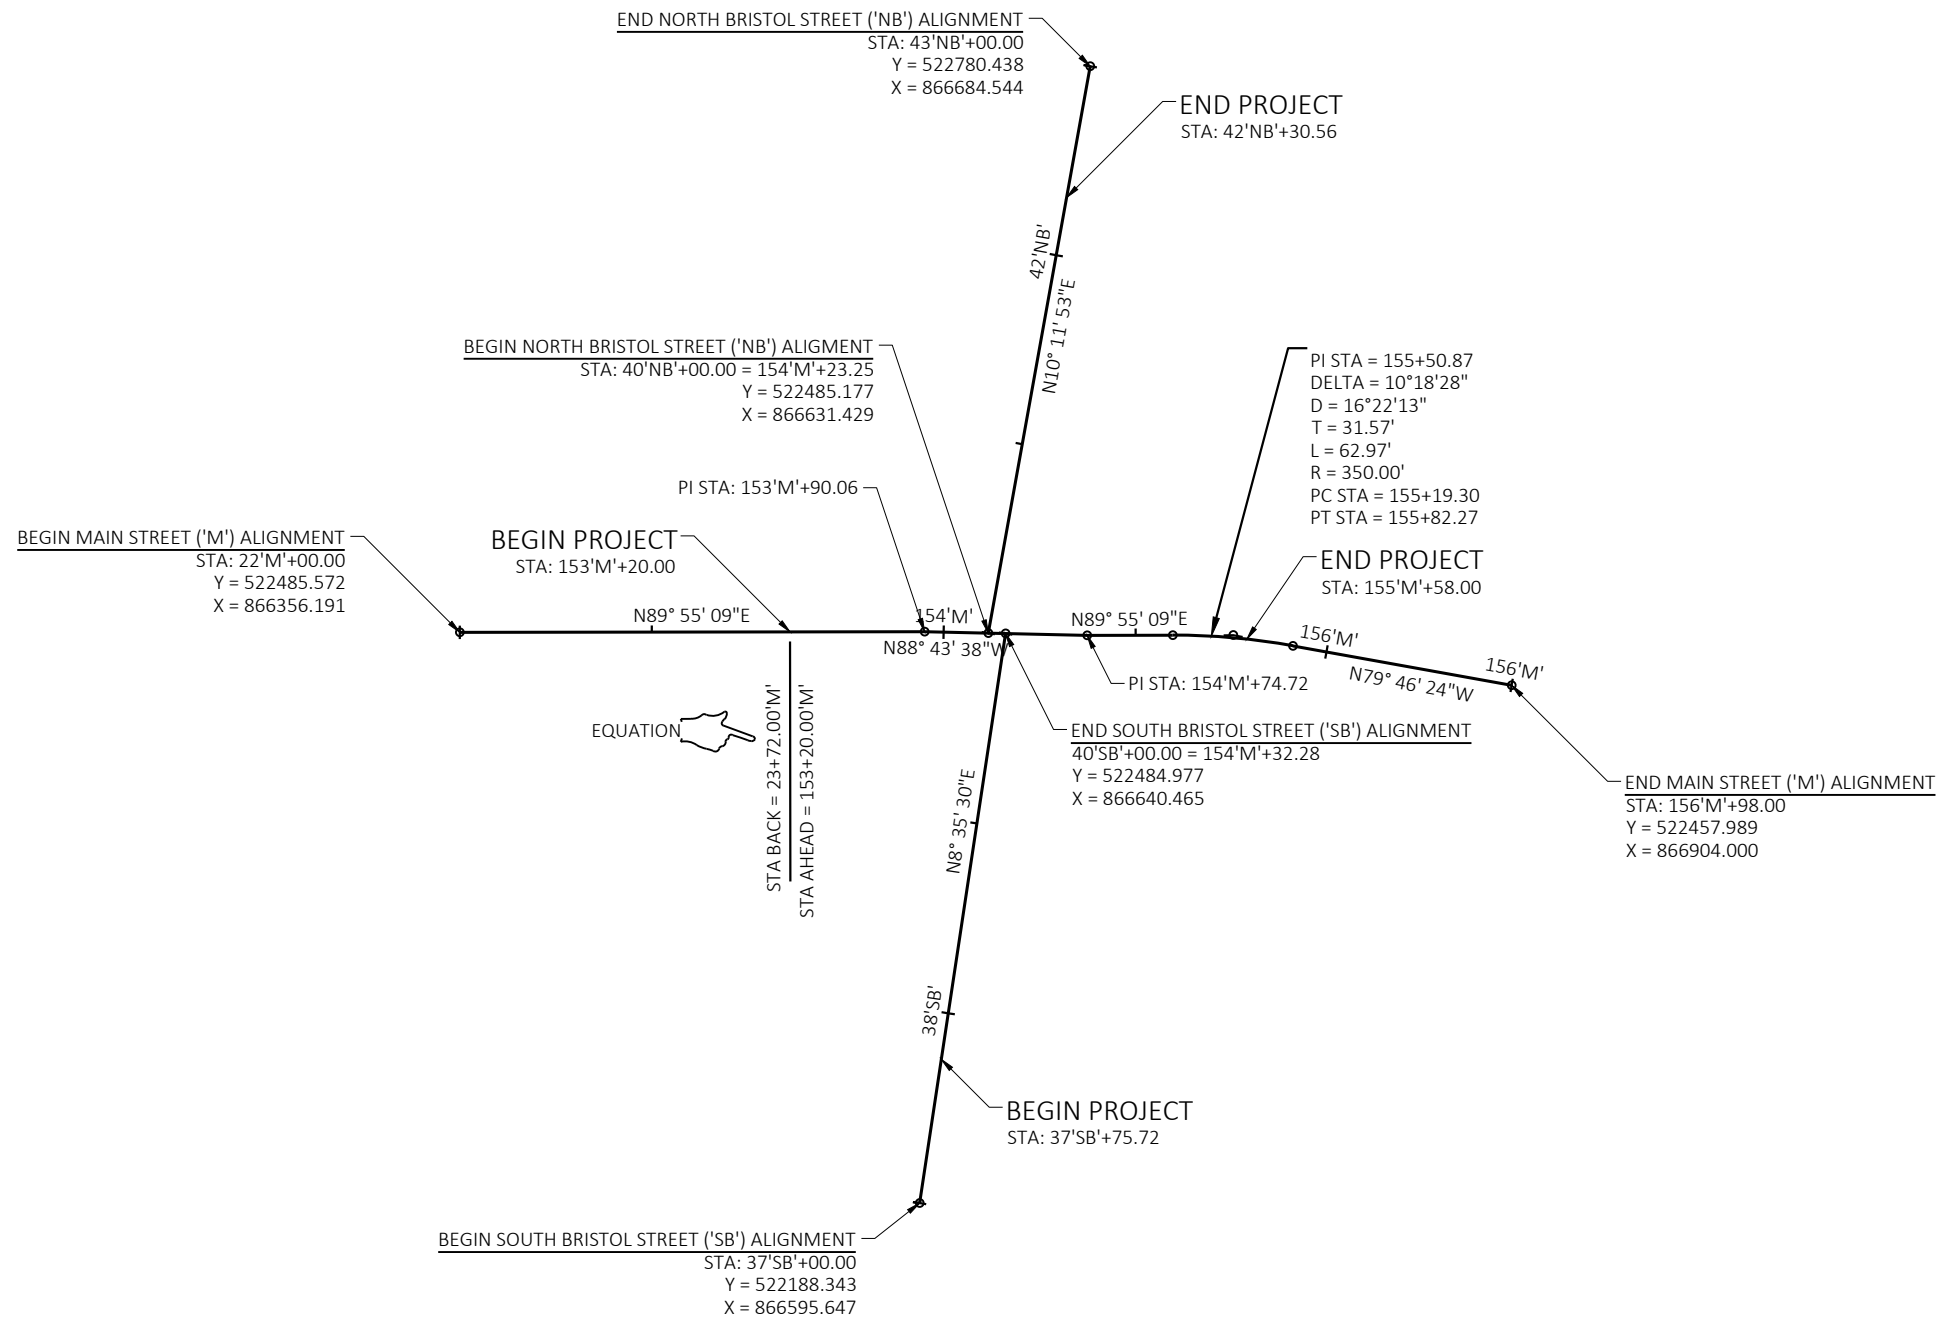


5

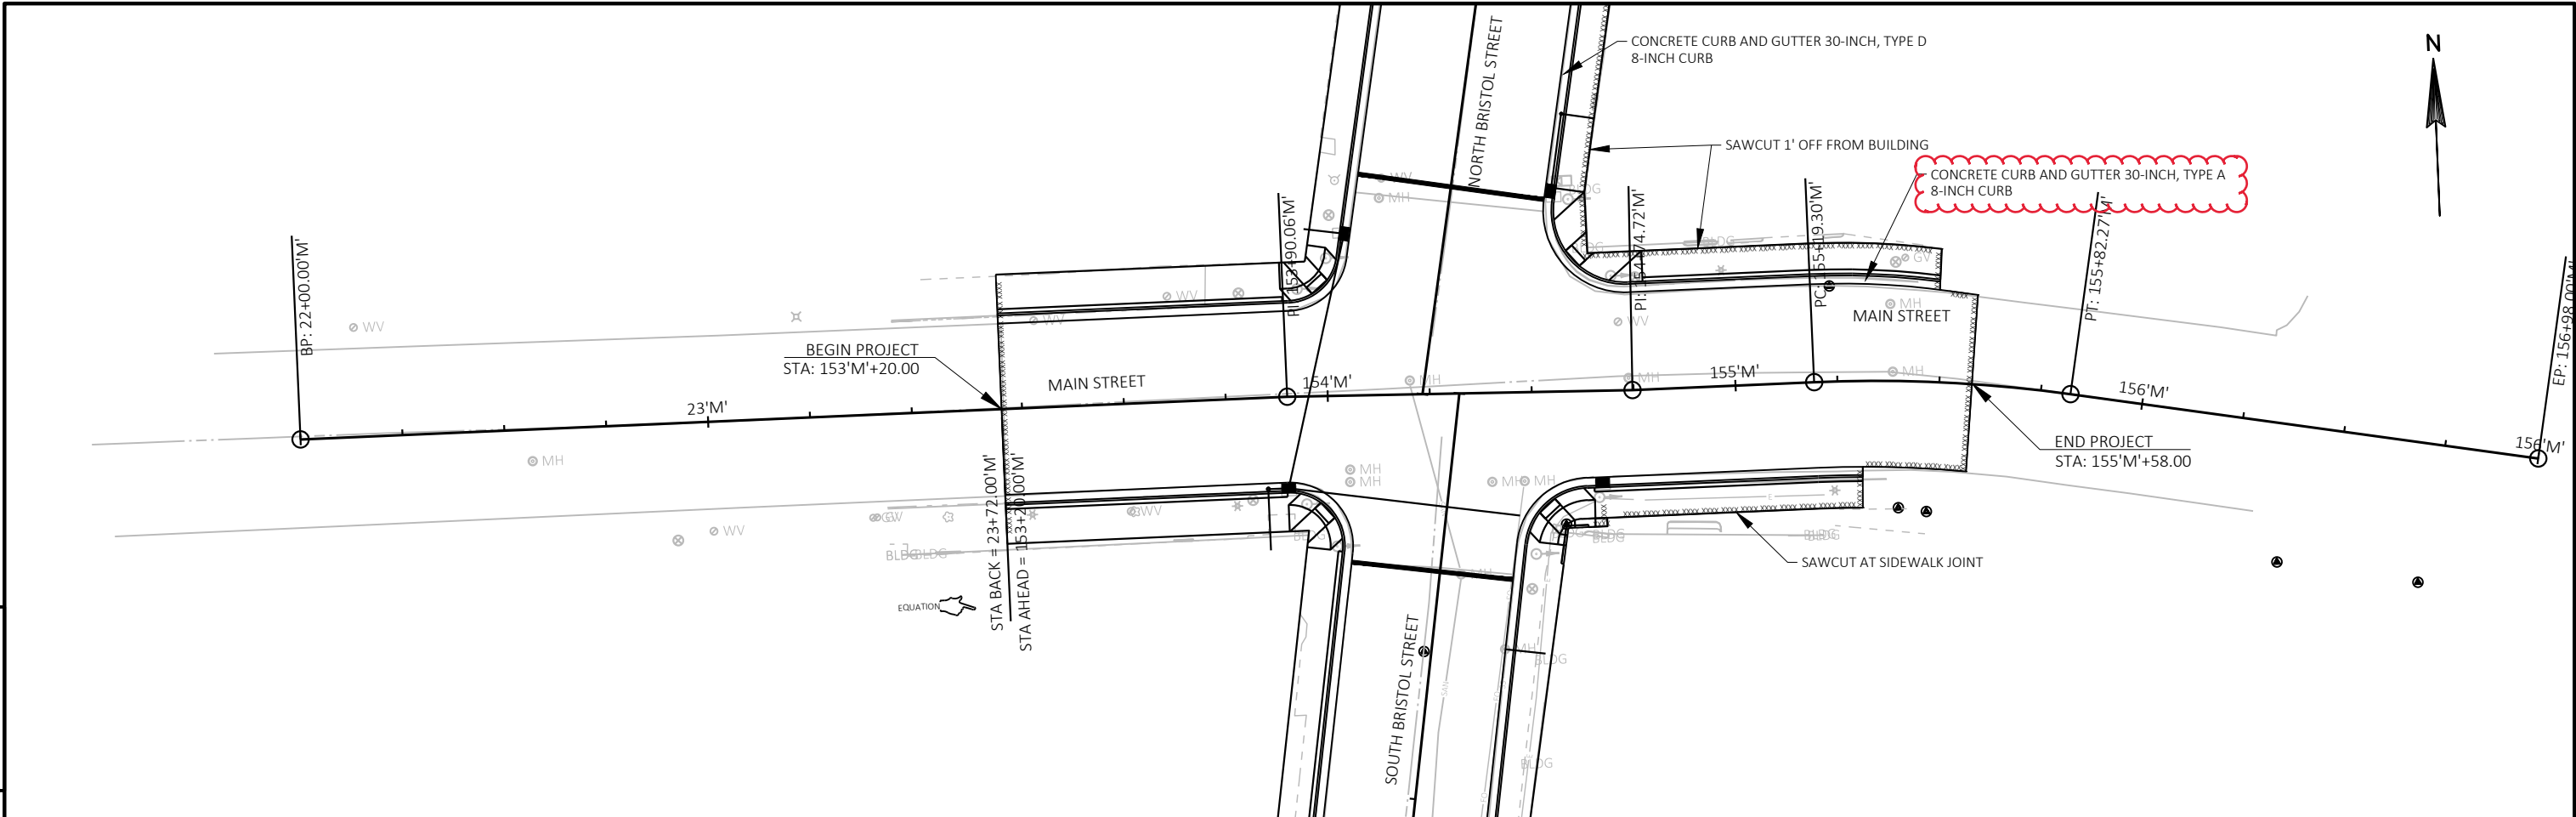


5


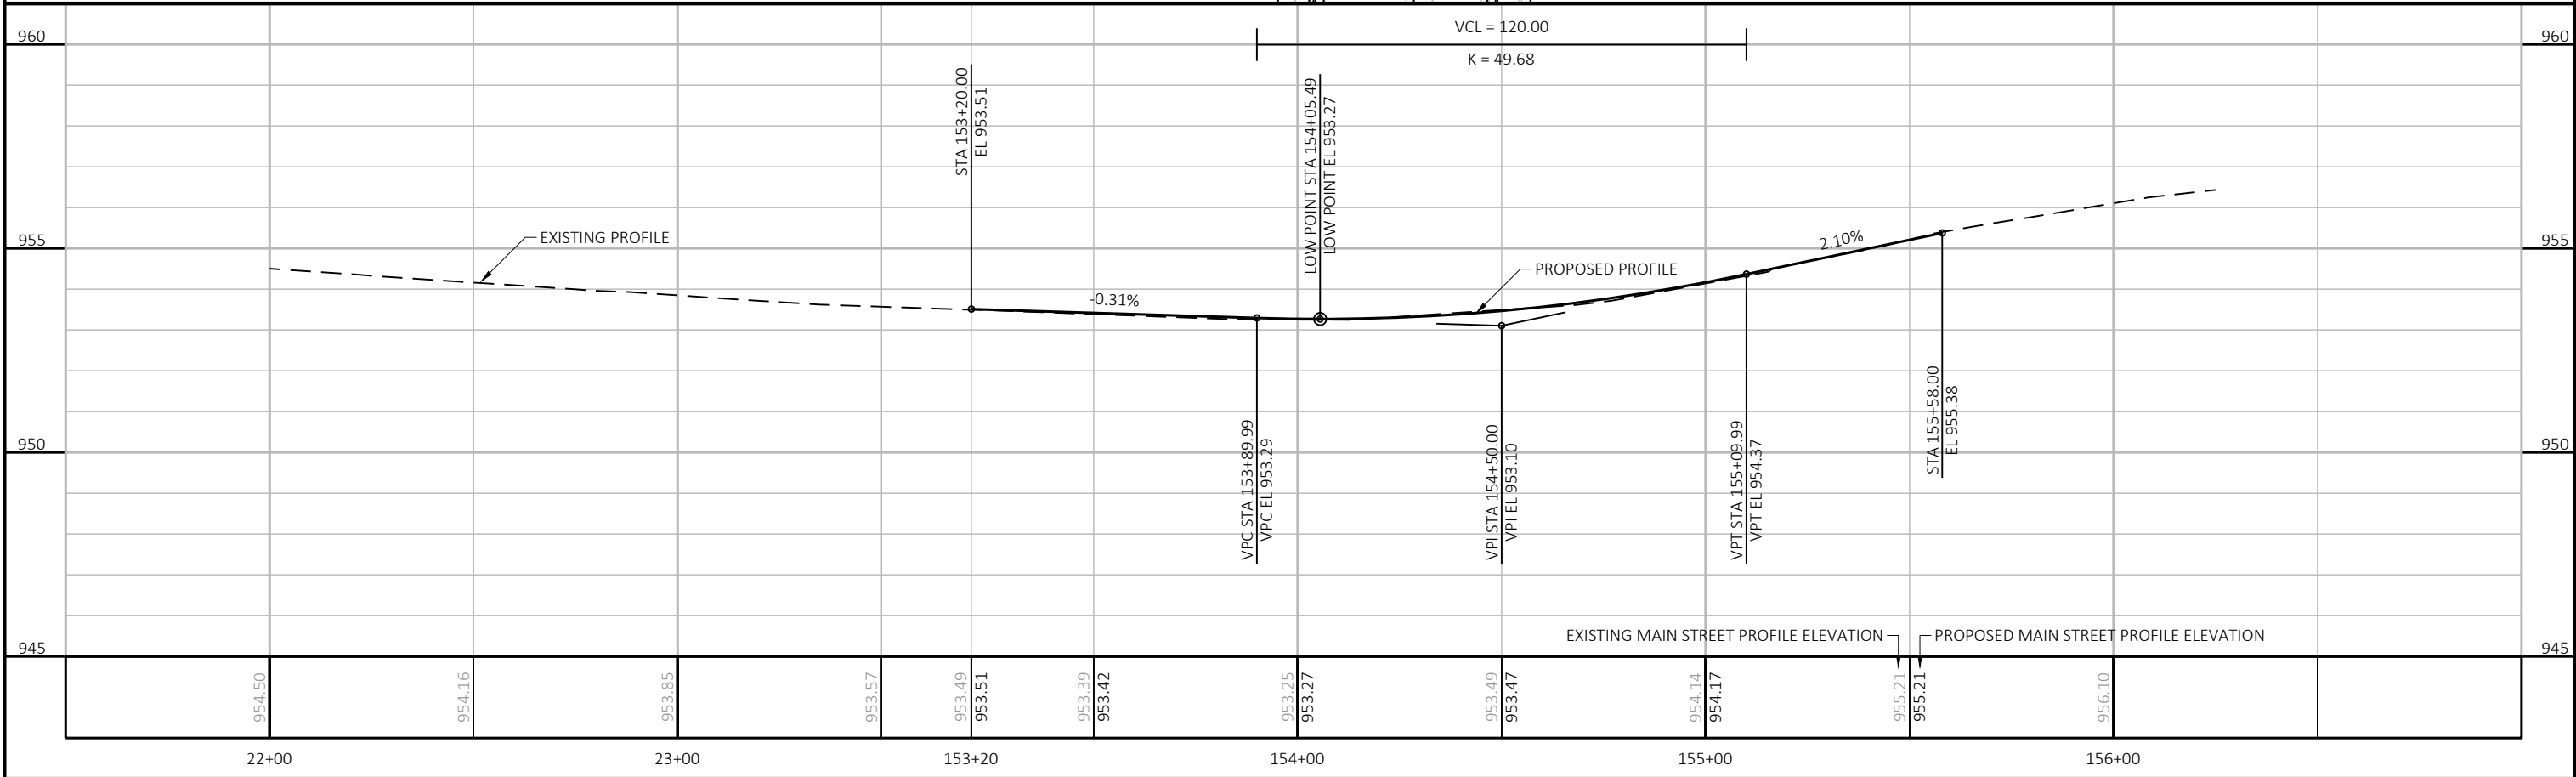



5

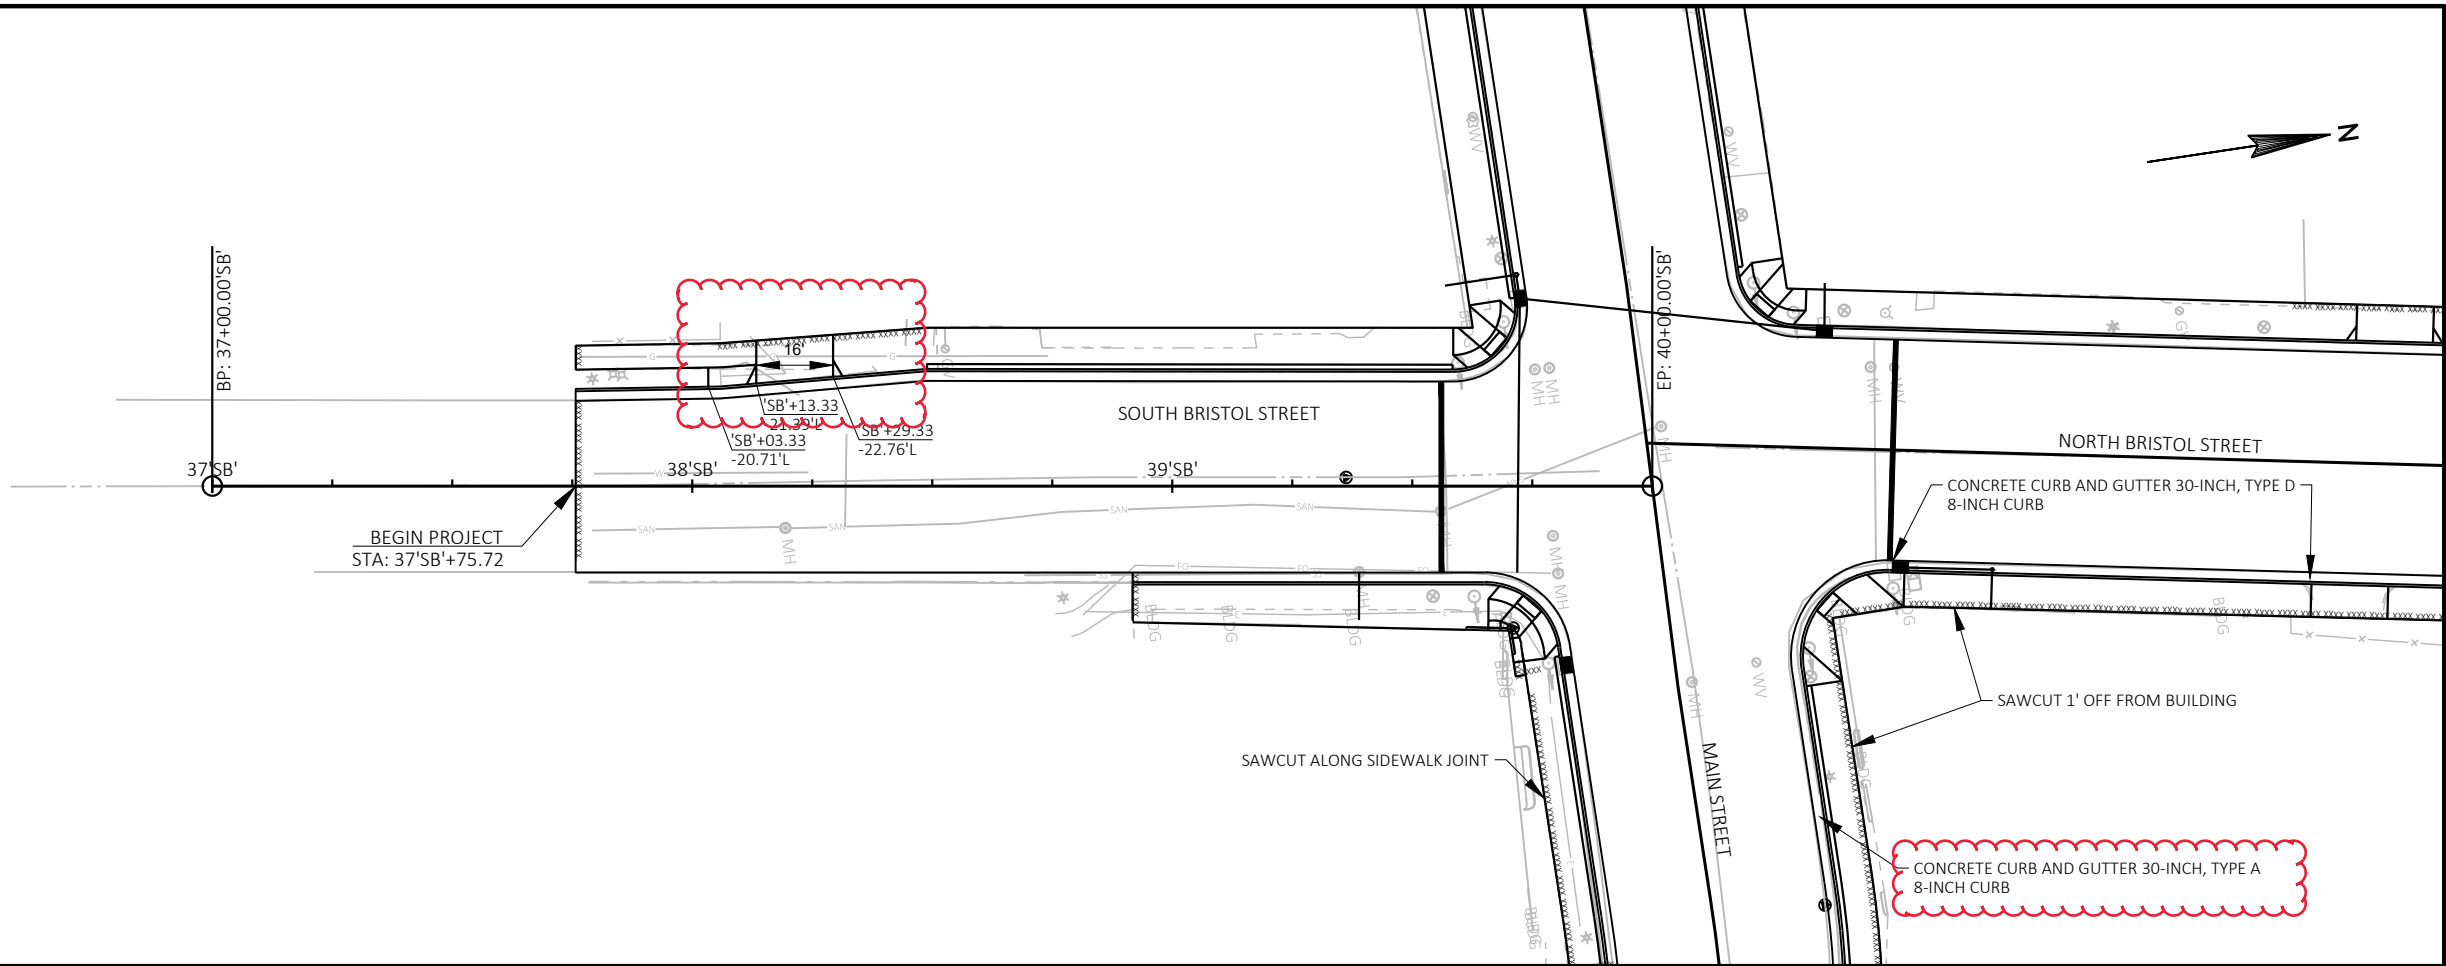


5

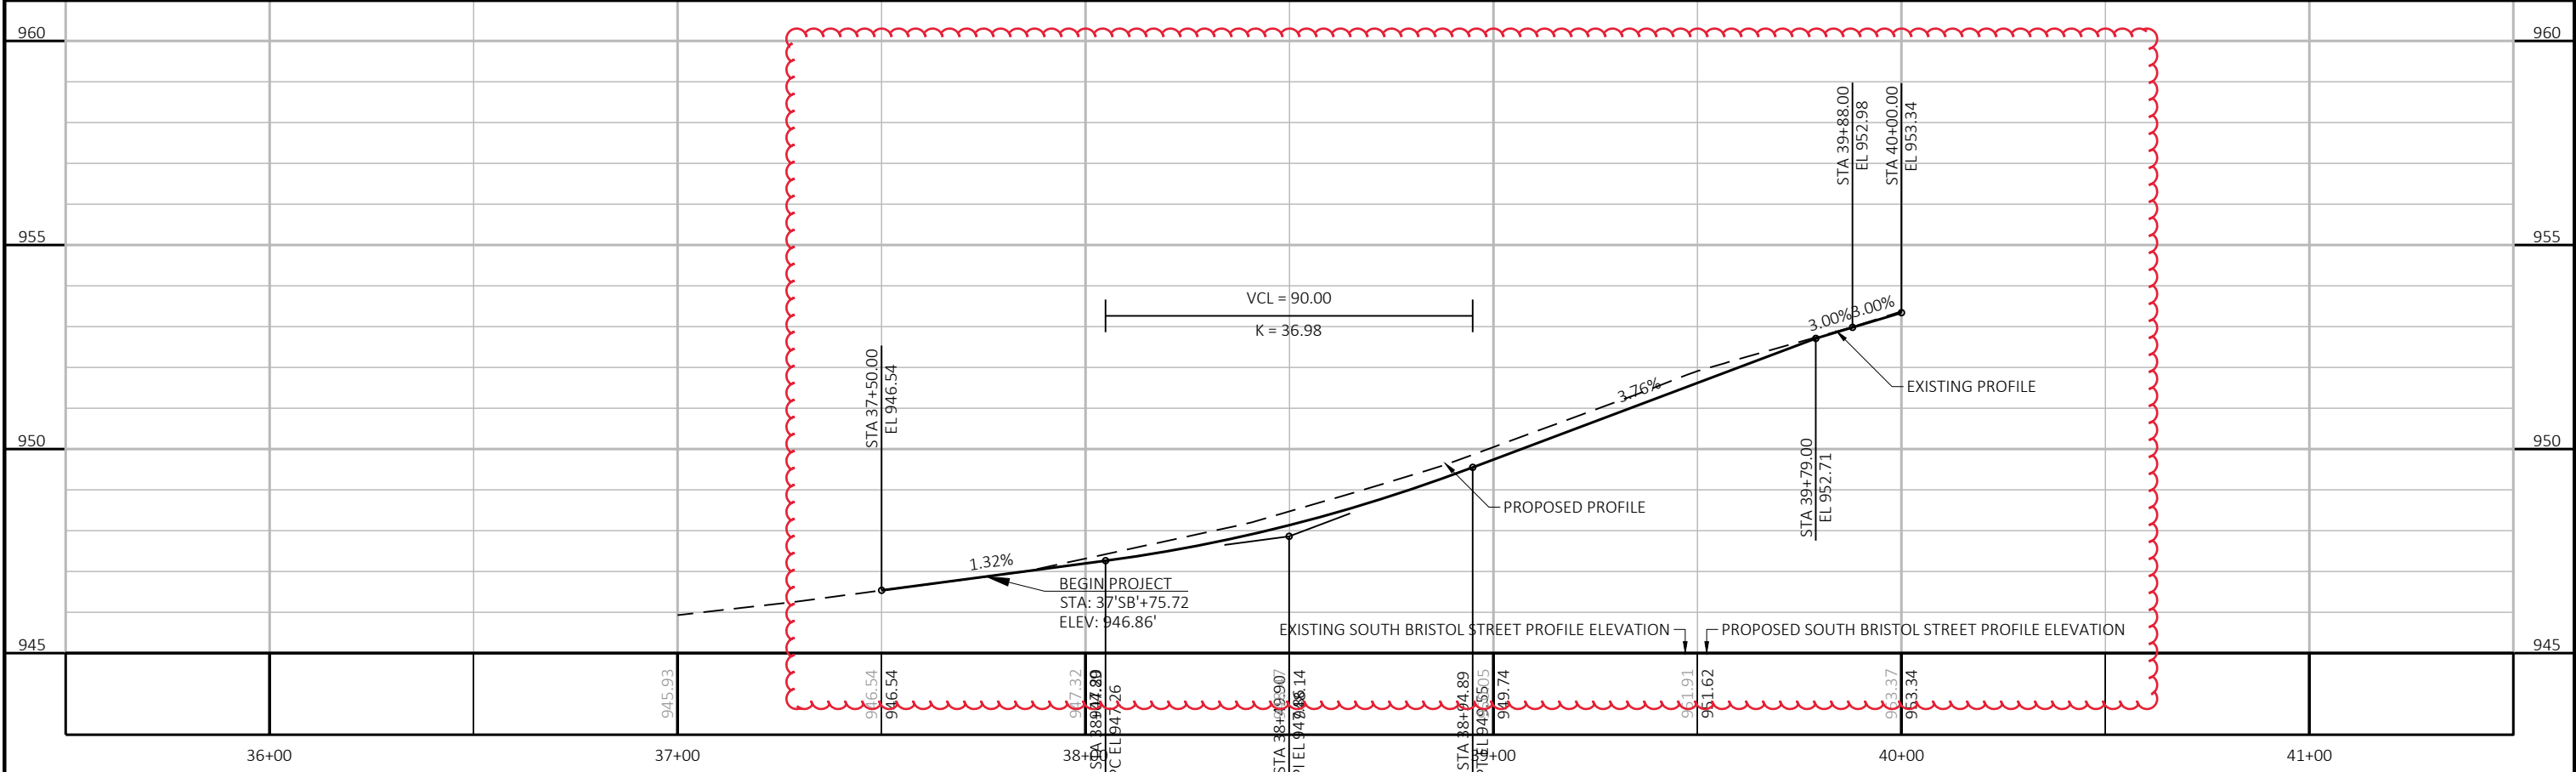

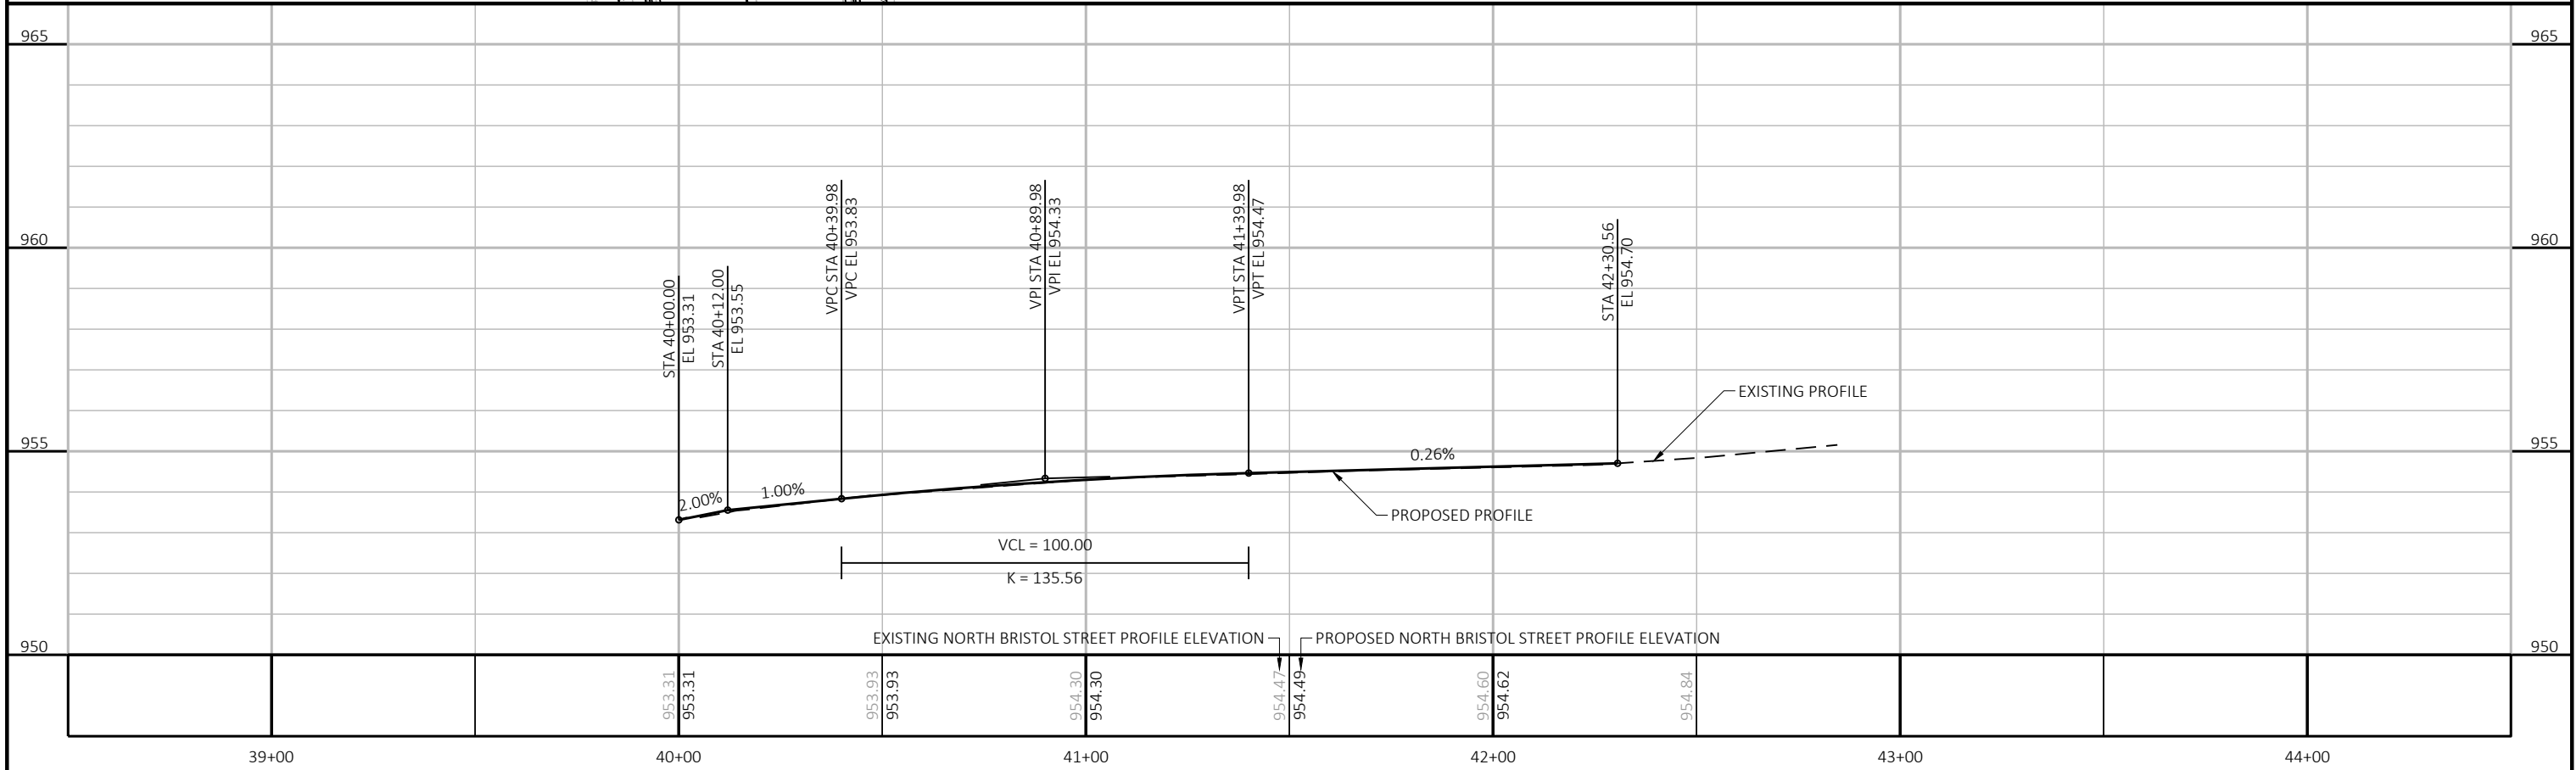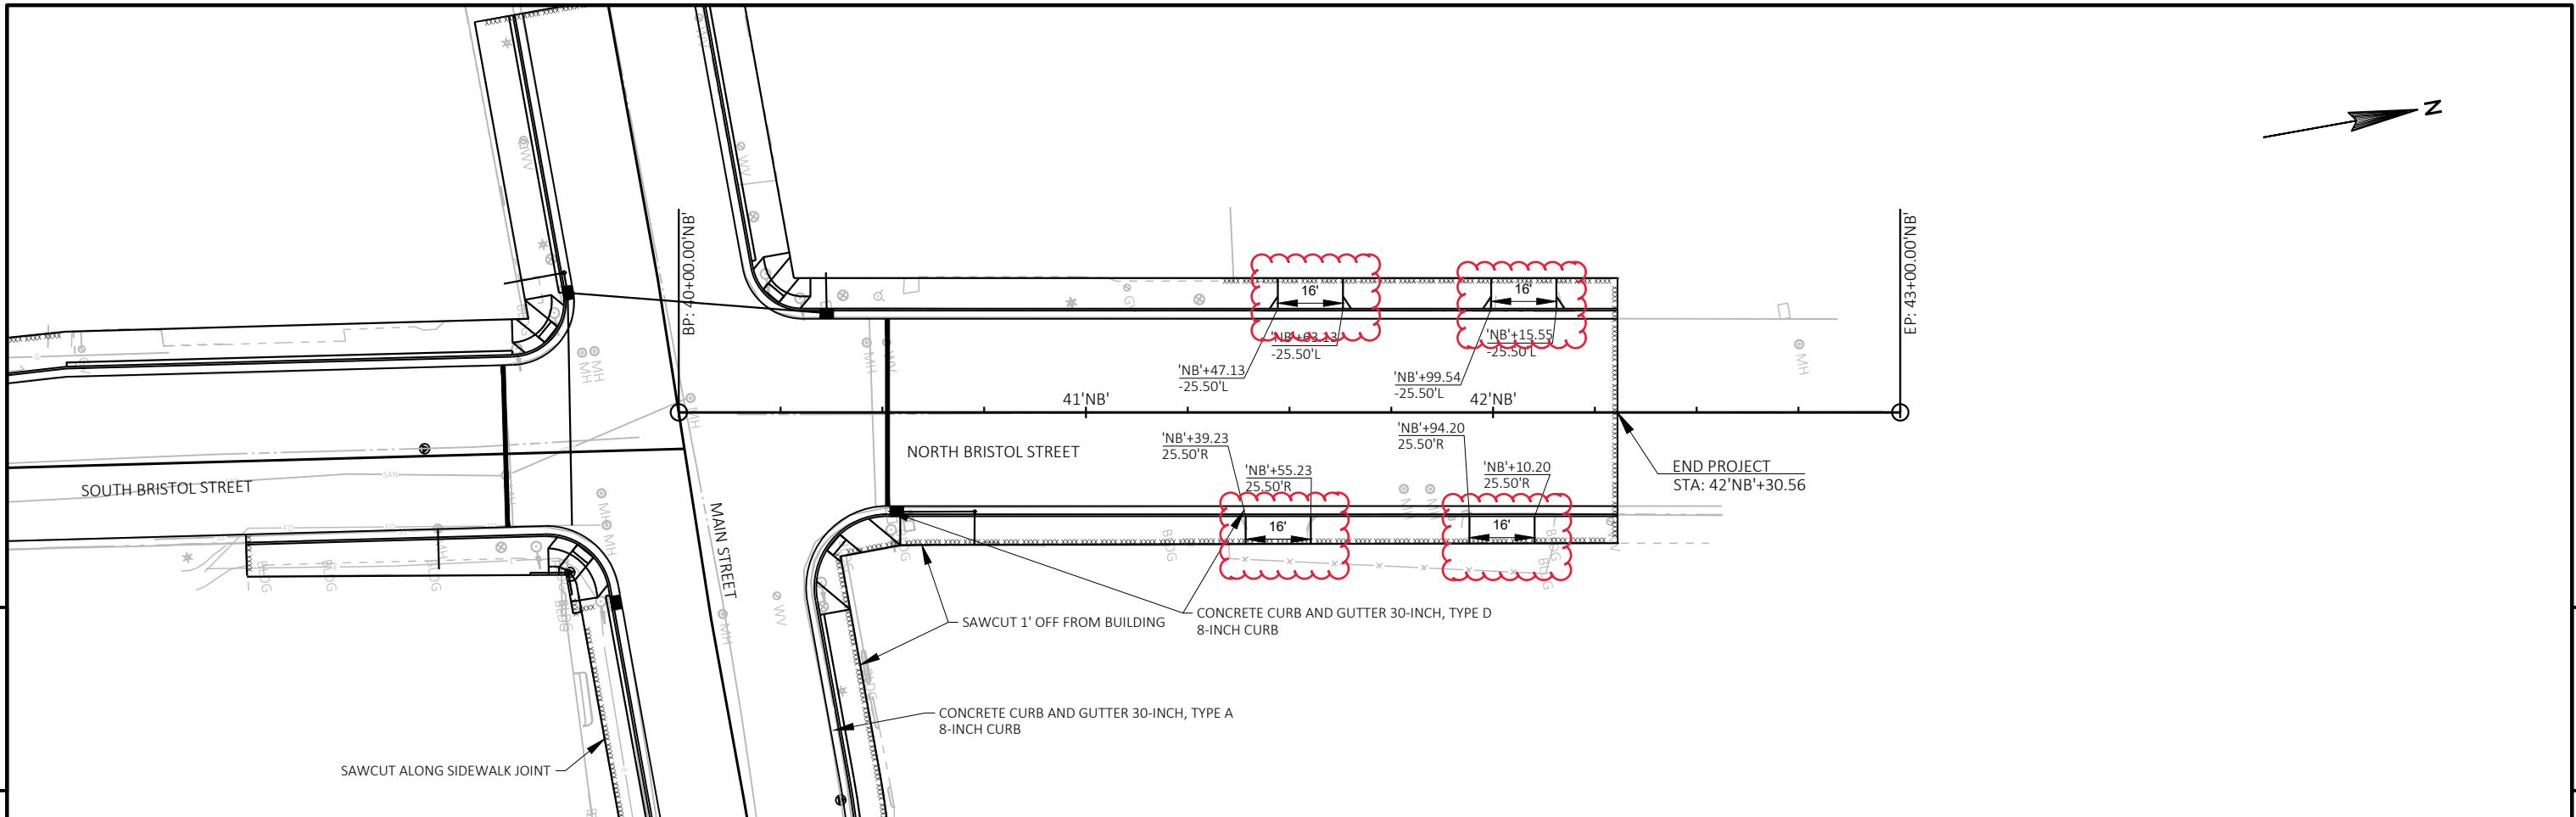


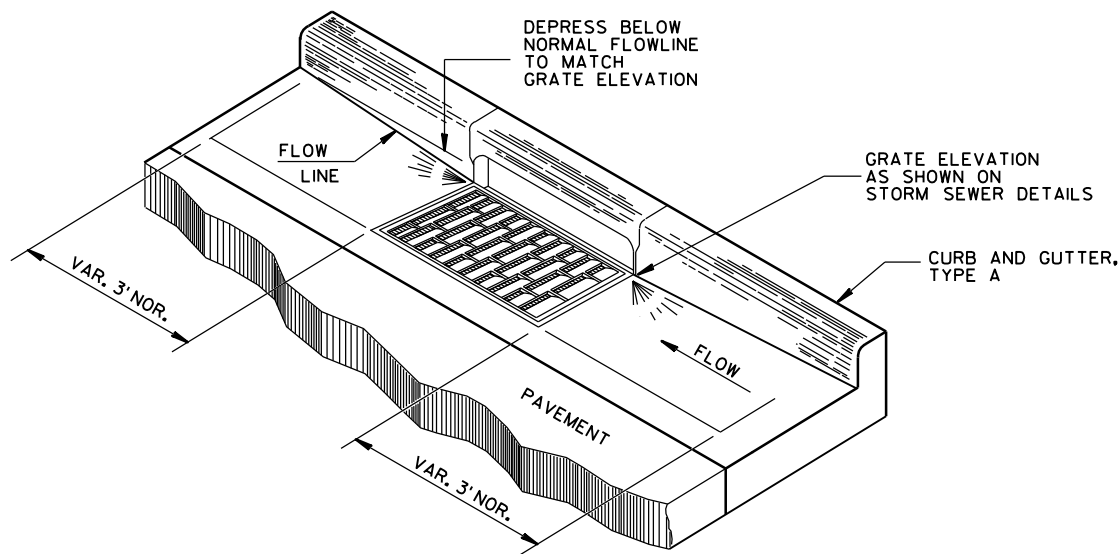


DETAIL OF CURB AND GUTTER AT INLETS
(TYPE H INLET COVER SHOWN)

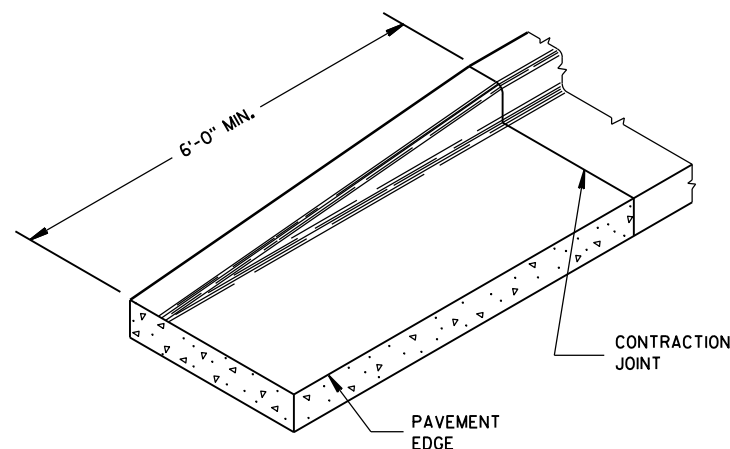


END SECTION CURB & GUTTER

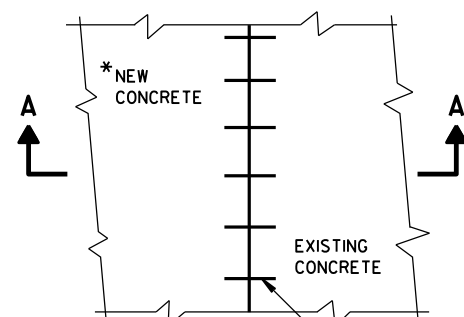


PLAN VIEW

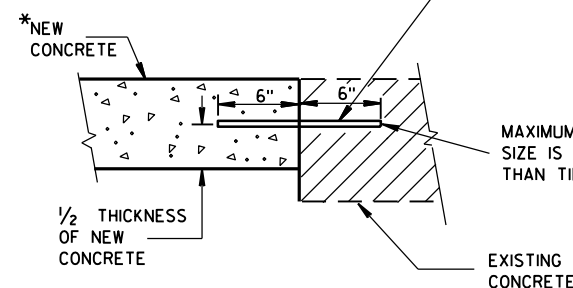

SECTION A-A
TIE BARS DRILLED
INTO EXISTING PAVEMENT

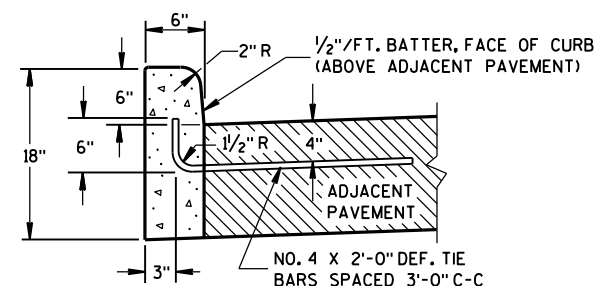

TYPES A^① & D

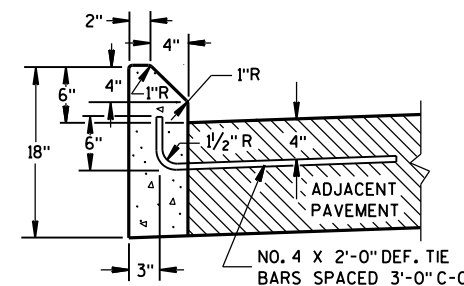

TYPES G^① & J

GENERAL NOTES


DETAILS OF CONSTRUCTION, MATERIALS AND WORKMANSHIP NOT SHOWN ON THIS DRAWING SHALL CONFORM TO THE PERTINENT REQUIREMENTS OF THE CONTRACT.

PAVEMENT TIES AND TIE BARS SHALL BE EPOXY COATED IN CONFORMANCE WITH SUBSECTION 505.2.6.2 OF THE STANDARD SPECIFICATIONS.


UNLESS OTHERWISE SHOWN ON THE TYPICAL CROSS SECTIONS, THE BASE AGGREGATE AND COMMON EXCAVATION LIMITS ARE 2'-0" BEHIND THE BACK OF CURBS.

- ① TIE BARS ARE REQUIRED FOR CURB AND GUTTER TYPES A, G, K, R AND TBTT.
- ② THE BOTTOM OF CURB AND GUTTER MAY BE CONSTRUCTED EITHER LEVEL OR PARALLEL TO THE SLOPE OF THE SUBGRADE OR BASE AGGREGATE PROVIDED A 6" MINIMUM GUTTER THICKNESS IS MAINTAINED.
- ⑨ REFER TO SDD 8D18 AND SDD 8D19 FOR ADDITIONAL DRIVEWAY ENTRANCE CURB DETAILS.

CONCRETE CURB

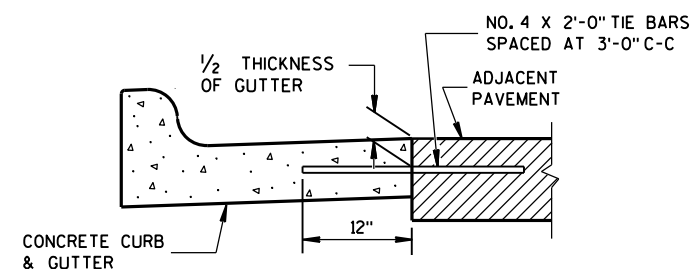

TYPICAL TIE BAR LOCATION^①

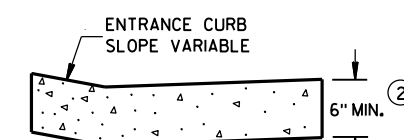


DRIVEWAY ENTRANCE CURB^⑨
(WHEN DIRECTED BY THE ENGINEER)

CONCRETE CURB, TIES AND CURB AND GUTTER APPLICATIONS



STATE OF WISCONSIN
DEPARTMENT OF TRANSPORTATION

APPROVED
June, 2017
DATE
FHWA





/S/ Rodney Taylor
ROADWAY STANDARDS DEVELOPMENT
UNIT SUPERVISOR

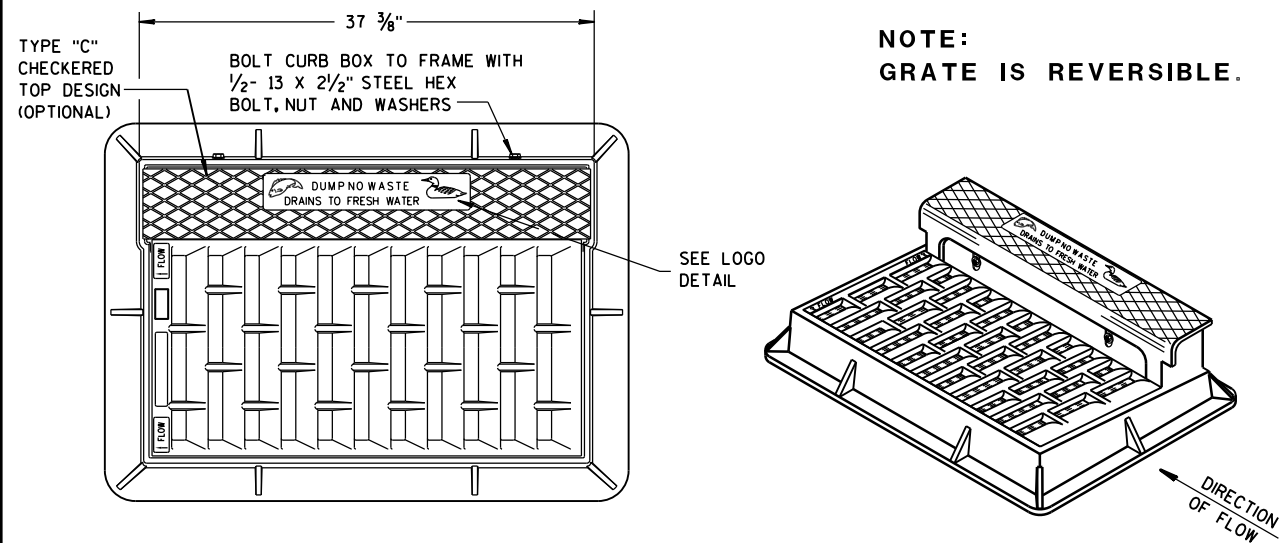

NOTE:
GRATE IS REVERSIBLE.

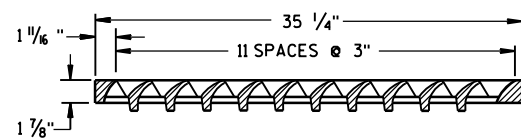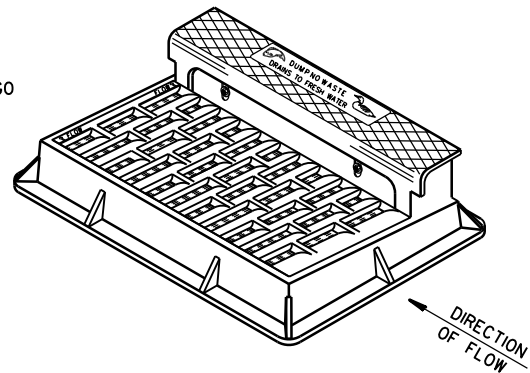


NOTE: CURB BOX HEIGHT ADJUSTABLE 6" TO 9"

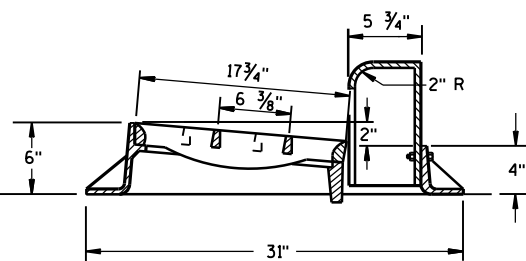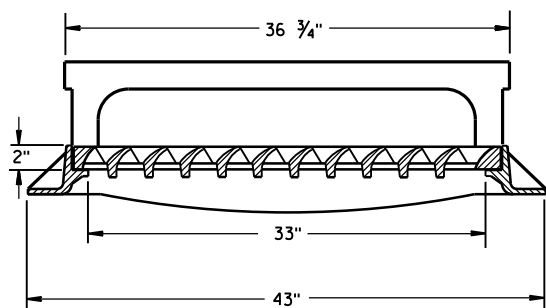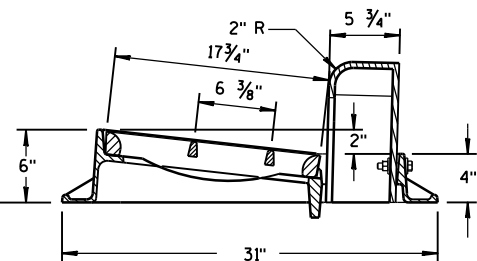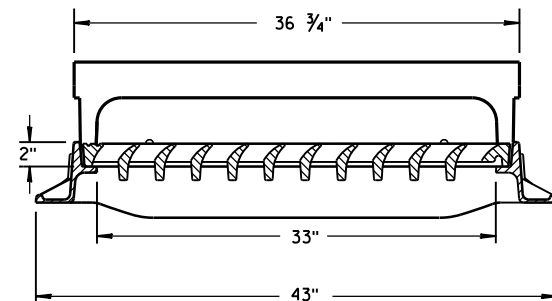


TYPE "H"

NOTE: EITHER CASTING IS ACCEPTABLE

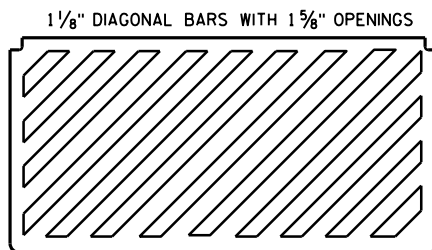


SPECIAL GRATE FOR
TYPE "H" COVER

(MEASURES 35 1/4" X 17 3/4" X 2")
(NOTED AS TYPE H-S ON DRAINAGE TABLE)

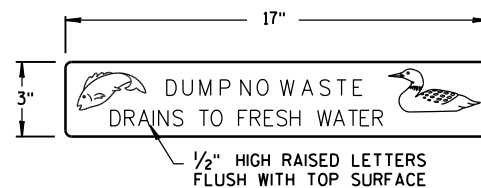


LOGO DETAIL

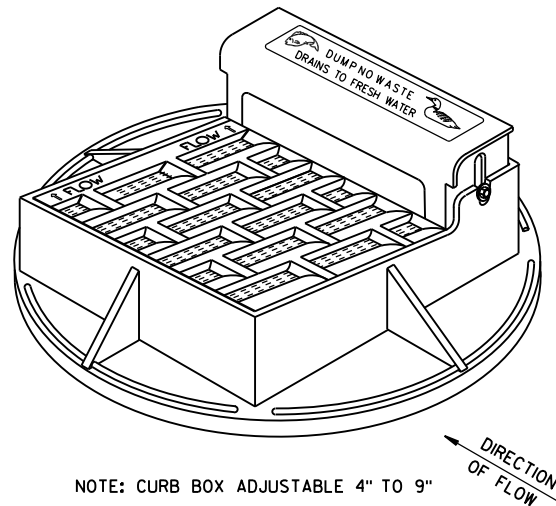


NOTE: CURB BOX ADJUSTABLE 4" TO 9"



NOTE:
GRATE IS REVERSIBLE.

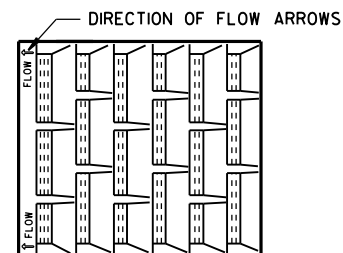



1" DIAGONAL BARS
WITH 1 1/2" OPENINGS

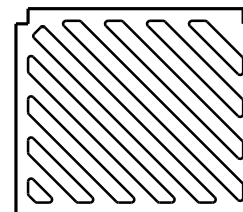


(MEASURES 19 3/4" X 17" X 1 1/8")
(NOTED AS TYPE A-S ON DRAINAGE TABLE)

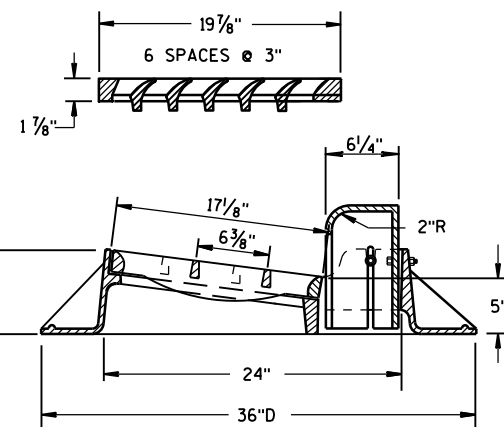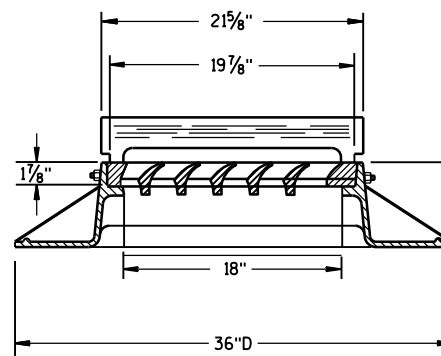

TYPE "A"

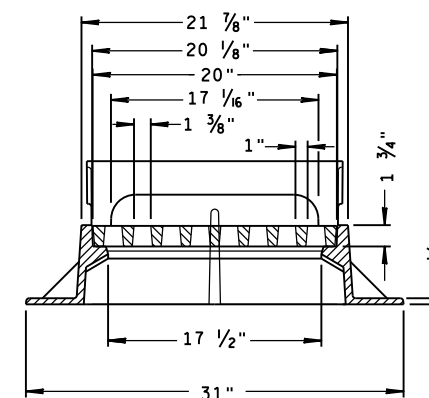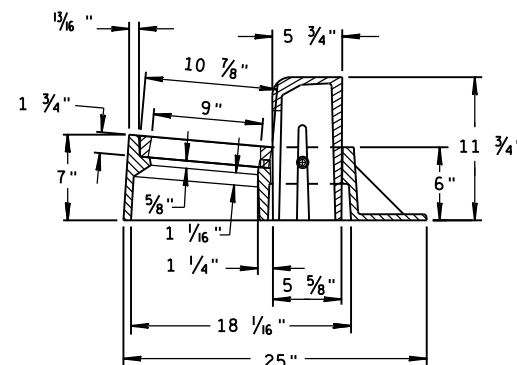

TYPE "Z"

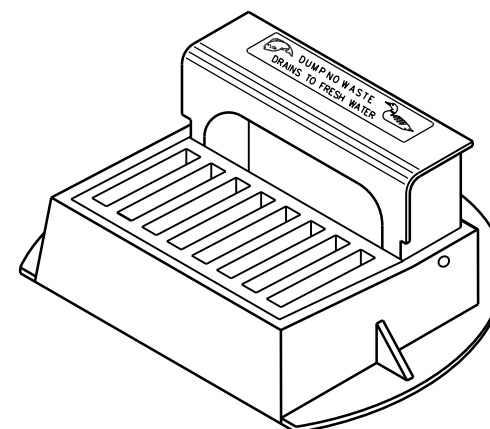


INLET COVERS
TYPE A, H, A-S, H-S & Z


STATE OF WISCONSIN
DEPARTMENT OF TRANSPORTATION

APPROVED
11-27-13
DATE
FHWA


/S/ Jerry H. Zogg
ROADWAY STANDARDS DEVELOPMENT
ENGINEER

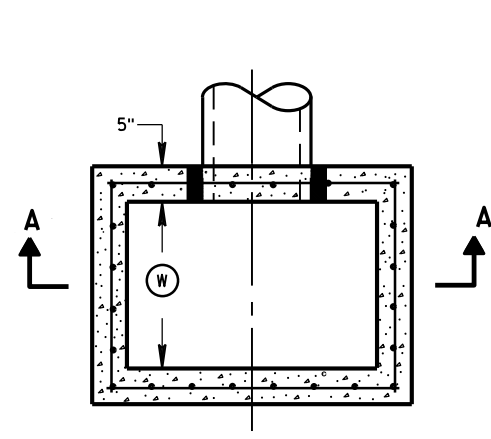


PLAN VIEW

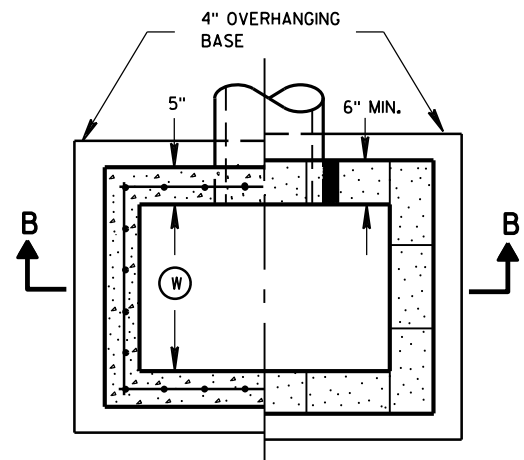


PLAN VIEW

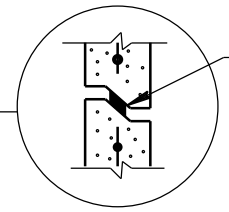


RISER JOINTS TO BE SEALED WITH A BUTYL RUBBER SEAL PER SEALANT MANUFACTURERS RECOMMENDATIONS CONFORMING TO ASTM C 990 (TYP)

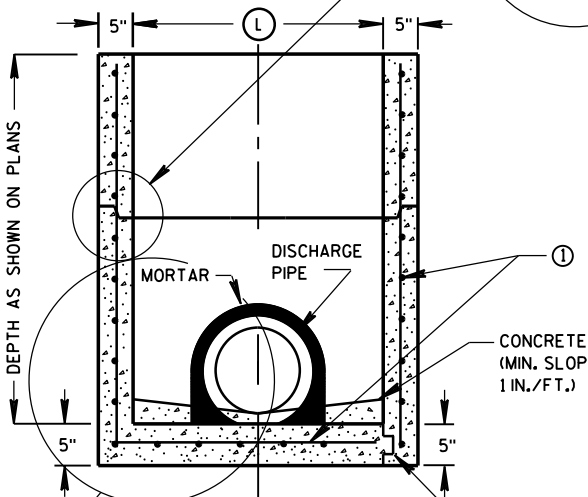

SECTION A-A

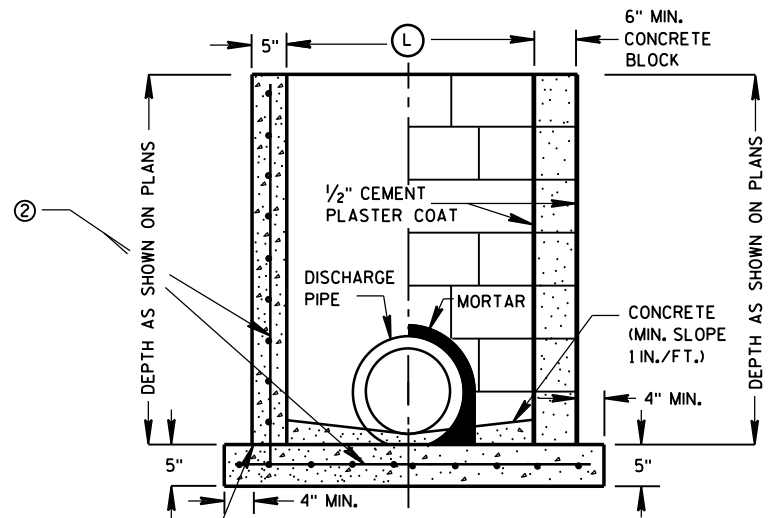

SECTION B-B

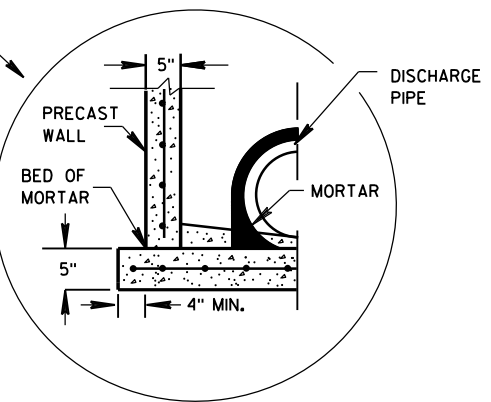

SEPARATE PRECAST REINFORCED CONCRETE BASE OPTION

GENERAL NOTES

DETAILS OF CONSTRUCTION, MATERIALS AND WORKMANSHIP NOT SHOWN ON THIS DRAWING SHALL CONFORM TO THE PERTINENT REQUIREMENTS OF THE STANDARD SPECIFICATIONS AND THE APPLICABLE SPECIAL PROVISIONS.

UNLESS OTHERWISE AUTHORIZED IN WRITING BY THE ENGINEER, THE CONTRACTOR SHALL NOT ORDER AND DELIVER PRECAST INLET UNITS REQUIRED FOR THE PROJECT UNTIL A LIST OF SIZES IS FURNISHED BY THE ENGINEER.

DETAILED DRAWINGS FOR PROPOSED ALTERNATE DESIGNS FOR UNDERGROUND DRAINAGE STRUCTURES SHALL BE SUBMITTED TO THE ENGINEER FOR APPROVAL PROVIDING THAT SUCH ALTERNATE DESIGNS MAKE PROVISION FOR EQUIVALENT CAPACITY AND STRENGTH.

ALL PRECAST INLET UNITS SHALL CONFORM TO THE PERTINENT REQUIREMENTS OF ASTM C 913.

ALL DRAINAGE STRUCTURES ARE DESIGNATED ON THE PLANS AS "MANHOLES 3X3-L", "CATCH BASINS 4-B", "INLETS 2X3-H", ETC. THE FIRST NUMBERS DESIGNATES THE SIZE OF THE STRUCTURE, AND THE FOLLOWING LETTER DESIGNATES THE TYPE OF COVER TO BE USED TO COMPRISE THE COMPLETE UNIT.

BASES SHALL BE PLACED ON A BED OF MATERIAL AT LEAST 6 INCHES IN DEPTH, WHICH MEETS THE REQUIREMENTS OF FOUNDATION BACKFILL. THIS BEDDING SHALL BE COMPACTED AND PROVIDE UNIFORM SUPPORT FOR THE ENTIRE AREA OF THE BASE.

ALL BAR STEEL REINFORCEMENT SHALL BE EMBEDDED 2 INCHES CLEAR UNLESS OTHERWISE SHOWN OR NOTED.

PRECAST REINFORCED RISERS SHALL HAVE A TONGUE AND GROOVE JOINT WITH TONGUE UP OR DOWN.

4" OVERHANGING BASES ARE REQUIRED FOR CAST-IN-PLACE REINFORCED CONCRETE AND CONCRETE BLOCK INSTALLATIONS. 4" OVERHANG IS REQUIRED WHEN SEPARATE PRECAST BASE IS PROVIDED. OVERHANG IS NOT REQUIRED ON PRECAST STRUCTURES WITH AN INTEGRAL OR MONOLITHIC BASE.

MAXIMUM INSIDE PIPE DIAMETER DETERMINED BY 3 INCH CLEARANCE ON EACH SIDE OF THE OUTSIDE WALL OF THE PIPE. SEE DETAIL "A". ASSUMES PIPE ENTERS PERPENDICULAR TO THE STRUCTURE.


- ① FOR PRECAST INLETS PROVIDE REINFORCING STEEL IN ACCORDANCE TO ASTM C 913.
- ② CONTRACTOR TO PROVIDE DRAWING(S) STAMPED BY A PROFESSIONAL ENGINEER FOR STEEL REINFORCING DESIGN FOR CAST-IN-PLACE STRUCTURES.

INLET COVER MATRIX

INLET SIZE	WIDTH ① (FT)	INLET COVER TYPE	ALL A'S	ALL B'S	BW	F	ALL H'S	S	T	V	WM
		LENGTH ② (FT)									
2X2-FT	2	2	X	X				X		X	
2X2.5-FT	2	2.5			X			X	X	X	X
2X3-FT	2	3					X				
2.5X3-FT	2.5	3				X					

PIPE MATRIX

INLET SIZE	MAXIMUM INSIDE PIPE DIAMETER	
	WIDTH (IN)	LENGTH (IN)
2X2-FT	12	12
2X2.5-FT	12	18
2X3-FT	12	24
2.5X3-FT	18	24

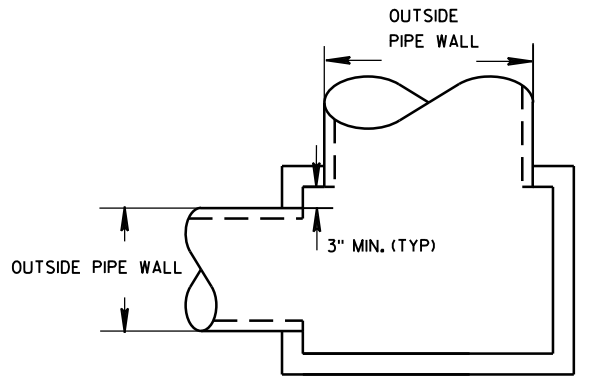


DETAIL "A"

INLETS 2X2-FT, 2X2.5-FT, 2X3-FT AND 2.5X3-FT


STATE OF WISCONSIN
DEPARTMENT OF TRANSPORTATION

APPROVED
Sept., 2016 /S/ Rodney Taylor
DATE ROADWAY STANDARDS DEVELOPMENT
FHWA UNIT SUPERVISOR


INLETS 2X2-FT, 2X2.5-FT, 2X3-FT AND 2.5X3-FT

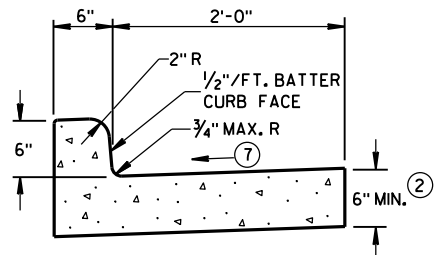


TYPES A^① & D

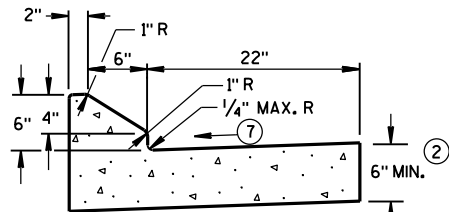


6" SLOPED CURB TYPES G^① & J

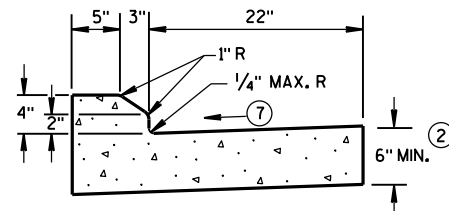

4" SLOPED CURB TYPES G^① & J

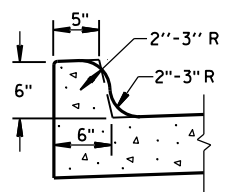


TYPES K^① & L
(OPTIONAL CURB SHAPE)

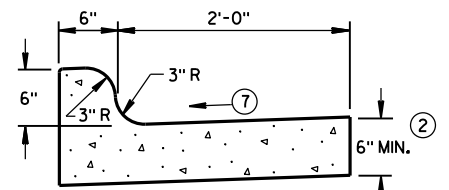


TYPES K^① & L

CONCRETE CURB & GUTTER 30"

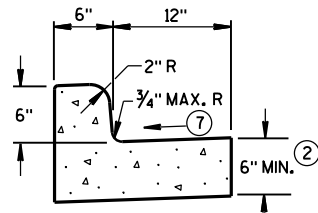


TYPES A^① & D


CONCRETE CURB & GUTTER 18"

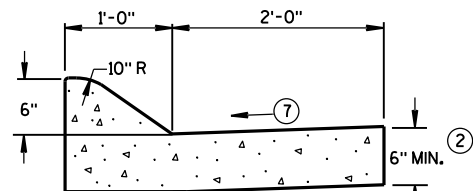

6" SLOPED CURB TYPES A^① & D

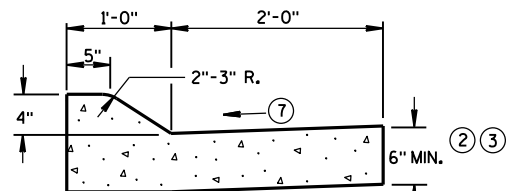


4" SLOPED CURB TYPES A^① & D

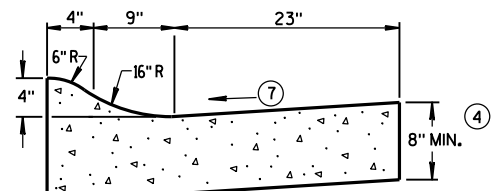

4" SLOPED CURB TYPES R^① & T^⑤


CONCRETE CURB & GUTTER 36"

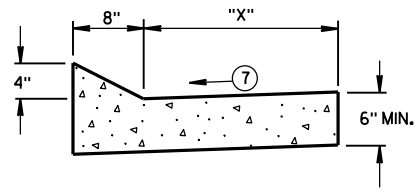


TYPES TBT & TBTT^①

CONCRETE CURB & GUTTER

TBT & TBTT	"X"
30"	22"
36"	28"

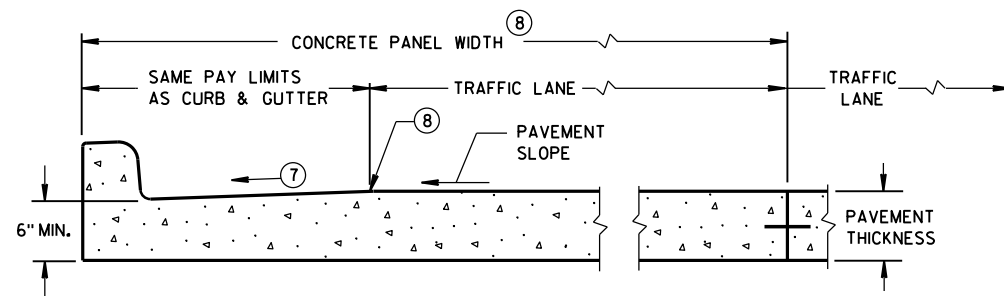

PARTIAL SECTION OF PAVEMENT
WITH INTEGRAL CURB & GUTTER

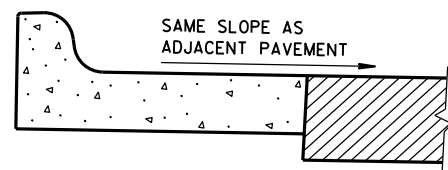

REVERSE SLOPE GUTTER^⑥
(TYPICAL FOR ALL CURB & GUTTER TYPES)

GENERAL NOTES

DETAILS OF CONSTRUCTION, MATERIALS AND WORKMANSHIP NOT SHOWN ON THIS DRAWING SHALL CONFORM TO THE PERTINENT REQUIREMENTS OF THE CONTRACT.

PAVEMENT TIES AND TIE BARS SHALL BE EPOXY COATED IN CONFORMANCE WITH SUBSECTION 505.2.6.2 OF THE STANDARD SPECIFICATIONS.

INTEGRAL CURB & GUTTER SHALL CONFORM TO THE DETAILS SHOWN FOR CONCRETE CURB & GUTTER INCLUDING THE TRANSVERSE GUTTER SLOPE.

WHERE THE TRANSVERSE JOINTS IN THE PAVEMENT ARE REQUIRED TO BE SEALED, THE JOINTS IN THE INTEGRAL CURB AND GUTTER SHALL BE SEALED TO THE FACE OF CURB WITH THE SAME TYPE OF SEALANT. THE COST OF FURNISHING AND INSTALLING THIS SEALANT SHALL BE INCIDENTAL TO THE ITEM CONCRETE CURB AND GUTTER.

UNLESS OTHERWISE SHOWN ON THE TYPICAL CROSS SECTIONS, THE BASE AGGREGATE AND COMMON EXCAVATION LIMITS ARE 2'-0" BEHIND THE BACK OF CURBS.

- ① TIE BARS ARE REQUIRED FOR CURB AND GUTTER TYPES A, G, K, R AND TBTT.
- ② THE BOTTOM OF CURB AND GUTTER MAY BE CONSTRUCTED EITHER LEVEL OR PARALLEL TO THE SLOPE OF THE SUBGRADE OR BASE AGGREGATE PROVIDED A 6" MINIMUM GUTTER THICKNESS IS MAINTAINED.
- ③ USE 8" MINIMUM GUTTER THICKNESS WHEN USED WITH AN ADJACENT CONCRETE TRUCK APRON PLACED BEHIND BACK OF CURB.
- ④ THE BOTTOM OF CURB AND GUTTER MAY BE CONSTRUCTED EITHER LEVEL OR PARALLEL TO THE SLOPE OF THE SUBGRADE OR BASE AGGREGATE PROVIDED A 8" MINIMUM GUTTER THICKNESS IS MAINTAINED.
- ⑤ THE FACE OF CURB IS 6" FROM THE BACK OF CURB.
- ⑥ WHEN REVERSE SLOPE GUTTER IS REQUIRED, THE LOCATION(S) WILL BE SHOWN ELSEWHERE IN THE PLAN.
- ⑦ USE 4% GUTTER CROSS SLOPE UNLESS OTHERWISE NOTED IN THE PLANS.
- ⑧ INCLUDE LONGITUDINAL JOINT AND TIE BARS ALONG LANE EDGE WHEN CONCRETE PANEL WIDTH EXCEEDS THE MAXIMUM WIDTH PER TABLE BELOW. LONGITUDINAL JOINT(S) ARE NOT ALLOWED WITHIN TRAFFIC LANES AND BIKE LANES. LONGITUDINAL JOINT MAY BE SAWED.


PAVEMENT THICKNESS AND MAXIMUM CONCRETE PANEL WIDTH TABLE

PAVEMENT THICKNESS	MAXIMUM PANEL WIDTH
LESS THAN 10"	12'
10" & ABOVE	15'


* BIKE LANE IS NOT SHOWN.

CONCRETE CURB & GUTTER

STATE OF WISCONSIN
DEPARTMENT OF TRANSPORTATION

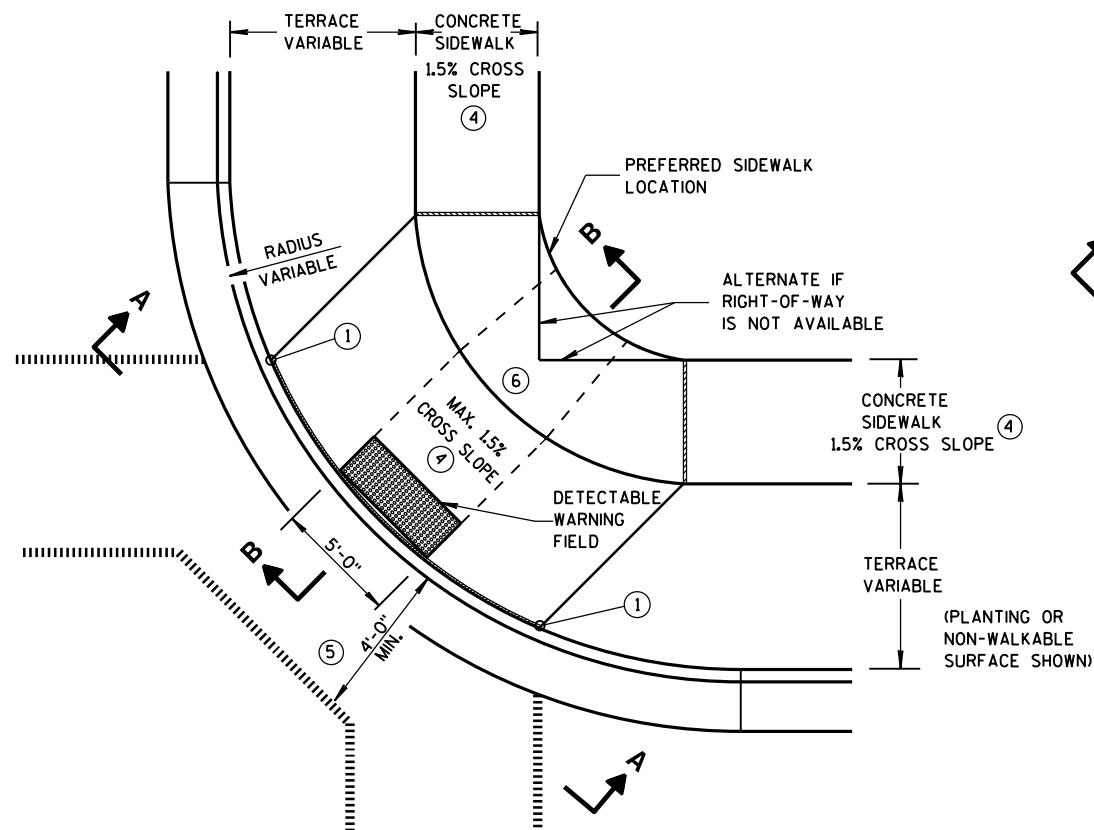


**PLAN VIEW
TYPE 1 RAMP**
(CENTER OF CORNER RADIUS)

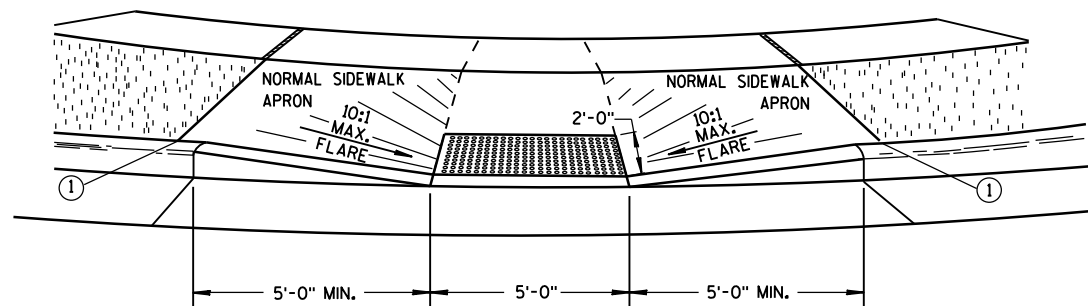


VIEW A-A


** WIDTH SHOWN ELSEWHERE
IN THE PLANS

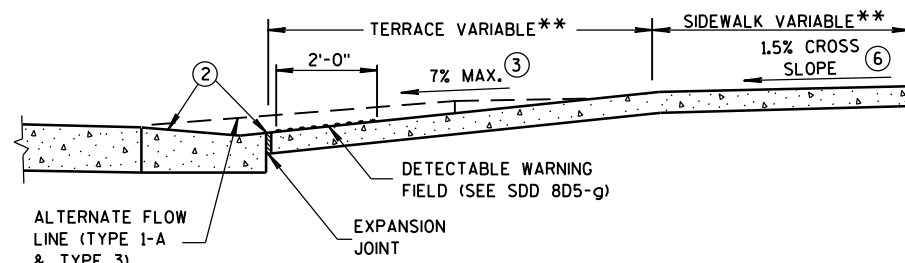


SECTION B-B

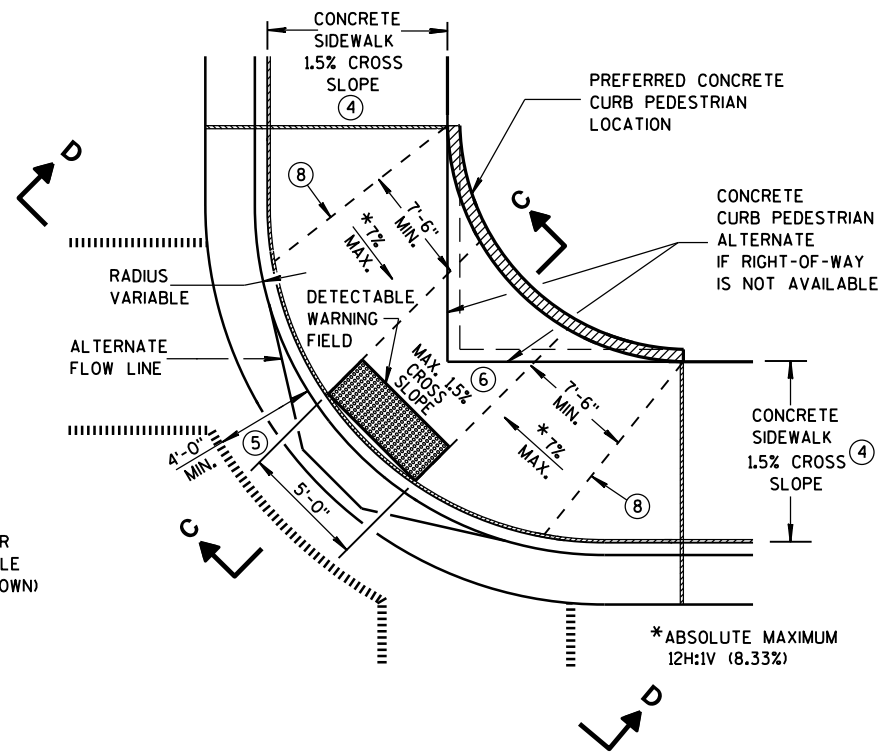

**PLAN VIEW
TYPE 1-A RAMP**
(NO TERRACE)

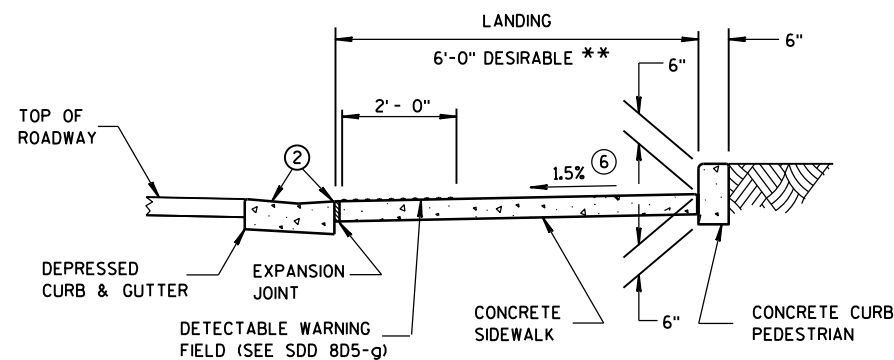

SECTION C-C

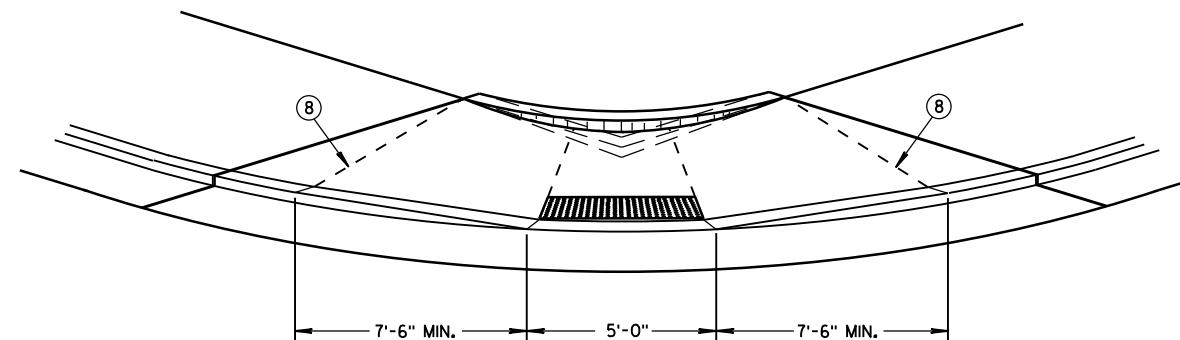

VIEW D-D

GENERAL NOTES

AVOID PLACING DRAINAGE STRUCTURES, JUNCTION BOXES OR OTHER OBSTRUCTIONS IN FRONT OF RAMP ACCESS AREAS.

DETAILS OF CONSTRUCTION, MATERIALS AND WORKMANSHIP NOT SHOWN ON THIS DRAWING SHALL CONFORM TO THE PERTINENT REQUIREMENTS OF THE STANDARD SPECIFICATIONS AND THE APPLICABLE SPECIAL PROVISIONS.

WHEN NECESSARY, THE SIDEWALK ELEVATION MAY BE LOWERED TO MEET THE HIGH POINT ON THE RAMP.

TYPE 1 RAMPS SHALL HAVE A NORMAL SIDEWALK APRON AND CURB ON BOTH SIDES OF RAMP.

DETECTABLE WARNING FIELD SHALL BE MEASURED AND PAID BY THE SQUARE FOOT AS "CURB RAMP DETECTABLE WARNING FIELD". THE CONCRETE PEDESTRIAN CURB, IF NEEDED, SHALL BE MEASURED AND PAID BY THE LINEAL FOOT AS "CONCRETE CURB PEDESTRIAN". CONCRETE SIDEWALK IN THE CURB RAMP AREA SHALL BE MEASURED AND PAID BY THE SQUARE FOOT AS CONCRETE SIDEWALK, INCLUDING THE AREA UNDER THE DETECTABLE WARNING FIELD.

SELECT CURB RAMP DETECTABLE WARNING FIELD MATERIALS AND DEVICES FROM THE DEPARTMENT'S APPROVED MATERIALS LIST. THE COLOR OF THE DETECTABLE WARNING FIELD IS SPECIFIED ELSEWHERE AND IS INCIDENTAL TO THE BID ITEM OF "CURB RAMP DETECTABLE WARNING FIELD".

DETECTABLE WARNING FIELDS THAT ARE INSTALLED AS A GROUP OR SIDE BY SIDE, SHALL BE FROM THE SAME MANUFACTURER.

SURFACE TEXTURE OF THE RAMP SHALL BE OBTAINED BY COARSE BROOMING TRANSVERSE TO THE SLOPE OF THE RAMP.

- ① THIS POINT IS AN EXTENSION OF OUTSIDE EDGE OF APPROACHING SIDEWALK WHERE IT MEETS THE BACK OF CONCRETE CURB. POINT LOCATION MAY BE ADJUSTED TO ALIGN WITH BEGINNING OF FULL-HEIGHT CURB IF THIS DISTANCE IS SHORT.
- ② GRADE CHANGE BETWEEN GUTTER FLAG SLOPE AND THE CURB RAMP SLOPE SHALL NOT EXCEED 11%. MAXIMUM GUTTER FLAG SLOPE IS 4%. PROVIDE LONGITUDINAL DRAINAGE AROUND CURB AND AWAY FROM CURB RAMP. NO VERTICAL LIPS OR DISCONTINUITIES GREATER THAN 1/4-INCH ARE ALLOWED. SLOPE OF CURB HEAD OPENING SHALL MATCH THE RAMP SLOPE, MINIMALLY 1.5% AND NOT TO EXCEED 7%. WHEN ADJACENT TO 1.5% LANDING, CONSTRUCT CURB HEAD OPENING AT 1.5% IN THE DIRECTION OF PEDESTRIAN TRAVEL.
- ③ ABSOLUTE MAXIMUM 12H:1V (8.33%) CURB RAMP SLOPE IS ALLOWABLE WITH FLATTENED GUTTER FLAG SLOPE AND NOT TO EXCEED 11% GRADE CHANGE.
- ④ ±0.5% CONSTRUCTION TOLERANCE IN SIDEWALK CROSS SLOPE. THE SIDEWALK CROSS SLOPE SHALL NOT EXCEED 2% WITHOUT PRIOR APPROVAL FROM THE ENGINEER.
- ⑤ PROVIDE A LEVEL LANDING IN THE STREET AND GUTTER AREA. (2% MAXIMUM SLOPE IN ANY DIRECTION). WHEN THE GUTTER SLOPE EXCEEDS 2%, CONSTRUCT THE LEVEL LANDING IN THE STREET AREA.
- ⑥ PROVIDE A LEVEL LANDING (MAXIMUM 2% SLOPE) IN ANY DIRECTION OF PEDESTRIAN TRAVEL. STANDARD LANDING SIZE IS 5 FEET X 5 FEET.
- ⑧ PROVIDE GRADE BREAK PERPENDICULAR TO DIRECTION OF WHEELCHAIR TRAVEL.

LEGEND



- 1/2" EXPANSION JOINT-SIDEWALK
- CONTRACTION JOINT FIELD LOCATED
- PAVEMENT MARKING CROSSWALK (WHITE)
- ALTERNATIVE LAYOUT

**CURB RAMPS
TYPES 1 AND 1-A**


STATE OF WISCONSIN
DEPARTMENT OF TRANSPORTATION

	MIN.	MAX.
A	1.6"	2.4"
B	0.65"	1.5"
C	*	*
D	0.9"	1.4"

* THE C DIMENSION IS 50% TO 65% OF THE D DIMENSION.

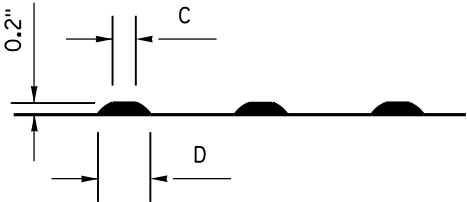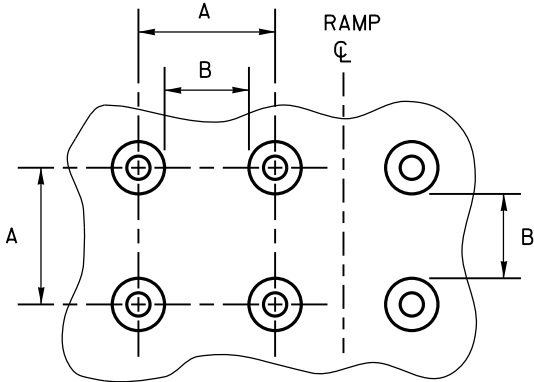

TRUNCATED DOMES
DETECTABLE WARNING PATTERN DETAIL

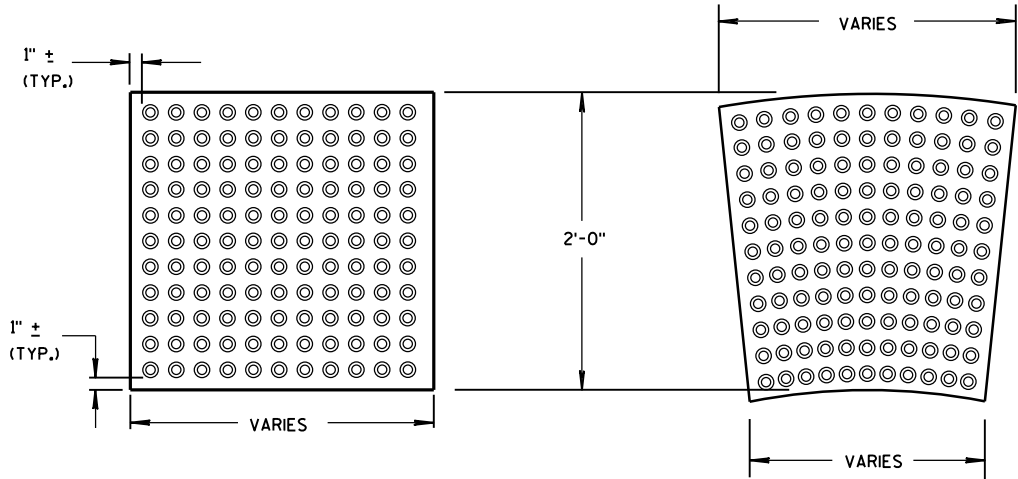

RECTANGULAR
PLATES

RADIAL
PLATES

DETECTABLE WARNING FIELDS (TYPICAL)

PLAN VIEW

GENERAL NOTES

DETECTABLE WARNING FIELDS THAT ARE INSTALLED AS A GROUP OR SIDE BY SIDE, SHALL BE FROM THE SAME MANUFACTURER.

PLACE ALL DETECTABLE WARNING FIELD SYSTEMS IN ACCORDANCE TO THE MANUFACTURER'S RECOMMENDATION.

FIELD CUTS AT INTERMEDIATE JOINTS WITHIN THE RADIAL DETECTABLE WARNING FIELD ARE PROHIBITED.


DETERMINE FINAL RADIAL WARNING FIELD CONFIGURATION AND ITS INDIVIDUAL PLATE LOCATIONS. PERFORM PRE-LAYOUT PRIOR TO PLACEMENT IN PLASTIC CONCRETE. FOLLOW MANUFACTURER'S PRODUCT LIST AND INSTALLATION RECOMMENDATIONS.

FOR RADIAL DETECTABLE WARNING FIELD APPLICATIONS WHERE STANDARD RADIAL PLATES ARE NOT AVAILABLE AT AN INTERSECTION CURB RADIUS, A COMBINATION OF SQUARE OR RECTANGULAR PLATES AND RADIAL PLATES MAY BE USED TO FORM RADIAL CONFIGURATION. RADIAL WEDGES IN COMBINATION WITH SQUARE PANELS ARE ALSO ACCEPTABLE. FOLLOW MANUFACTURER'S RECOMMENDATIONS.

REFER TO CONTRACT AND STANDARD SPECIFICATIONS FOR FIELD CUTTING REQUIREMENTS.

DO NOT EMBED IN CONCRETE ANY FIELD-CUT PLATES WITH CUT EDGES SHORTER THAN 6 INCHES. CONSULT WITH MANUFACTURER FOR RE-DRILLING AND ANCHORING REQUIREMENTS OF FIELD-CUT PLATES.

15 FIELD SAW CUTS ALONG RADIAL DETECTABLE WARNING PLATES WILL BE NECESSARY TO MATCH EACH CURB RAMP EDGE. AVOID CUTTING THROUGH DOMES WHENEVER POSSIBLE. MAKE FIELD CUTS TRUE TO LINE AND WITHIN 1/8" DEVIATION. SMOOTH EDGES OF FIELD CUT PLATES.

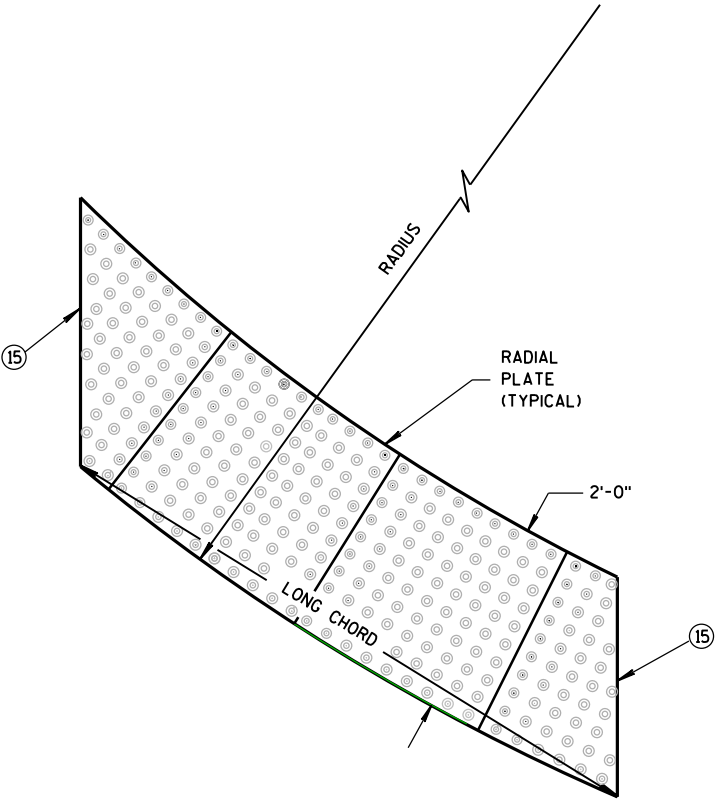


RADIAL DETECTABLE
WARNING FIELD ATTRIBUTES


CURB RAMPS
RECTANGULAR AND RADIAL
DETECTABLE WARNING PLATES

STATE OF WISCONSIN
DEPARTMENT OF TRANSPORTATION


APPROVED
June, 2017 /S/ Rodney Taylor
DATE ROADWAY STANDARDS DEVELOPMENT
FHWA UNIT SUPERVISOR

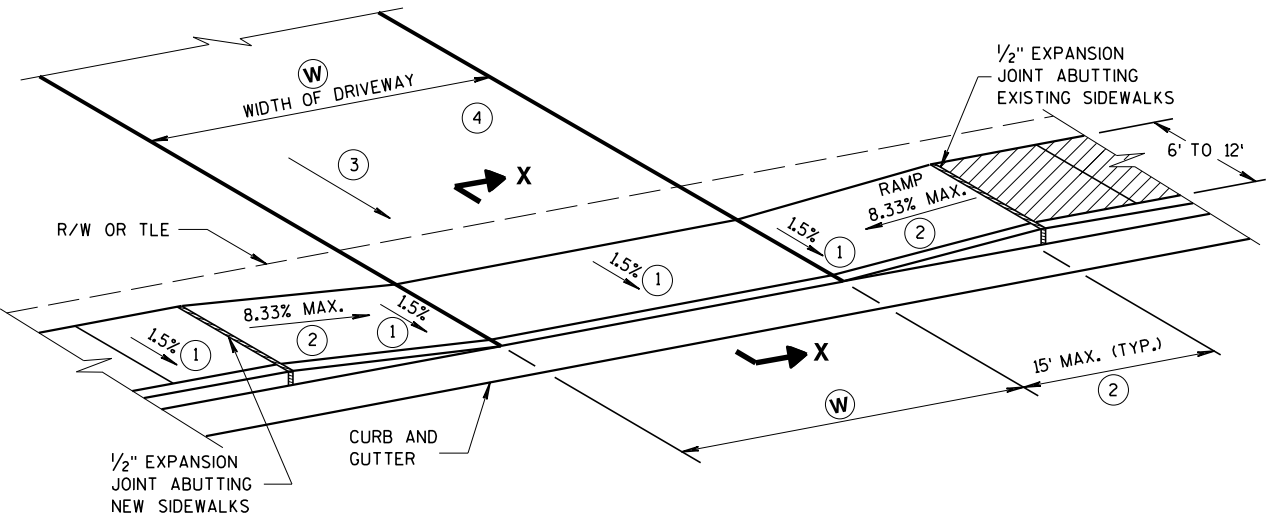

TYPE X
SIDEWALK ABUTS CURB & GUTTER
TERRACE VARIES 0 TO 3 FEET

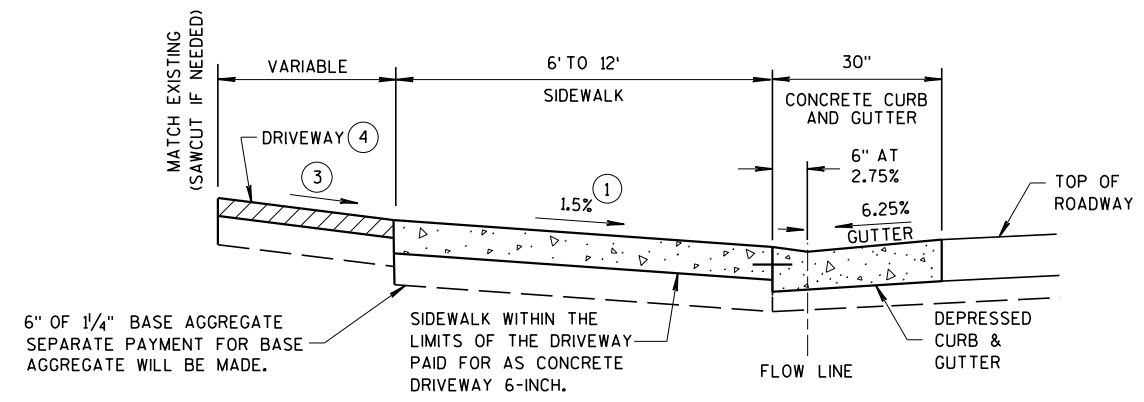

SECTION X-X

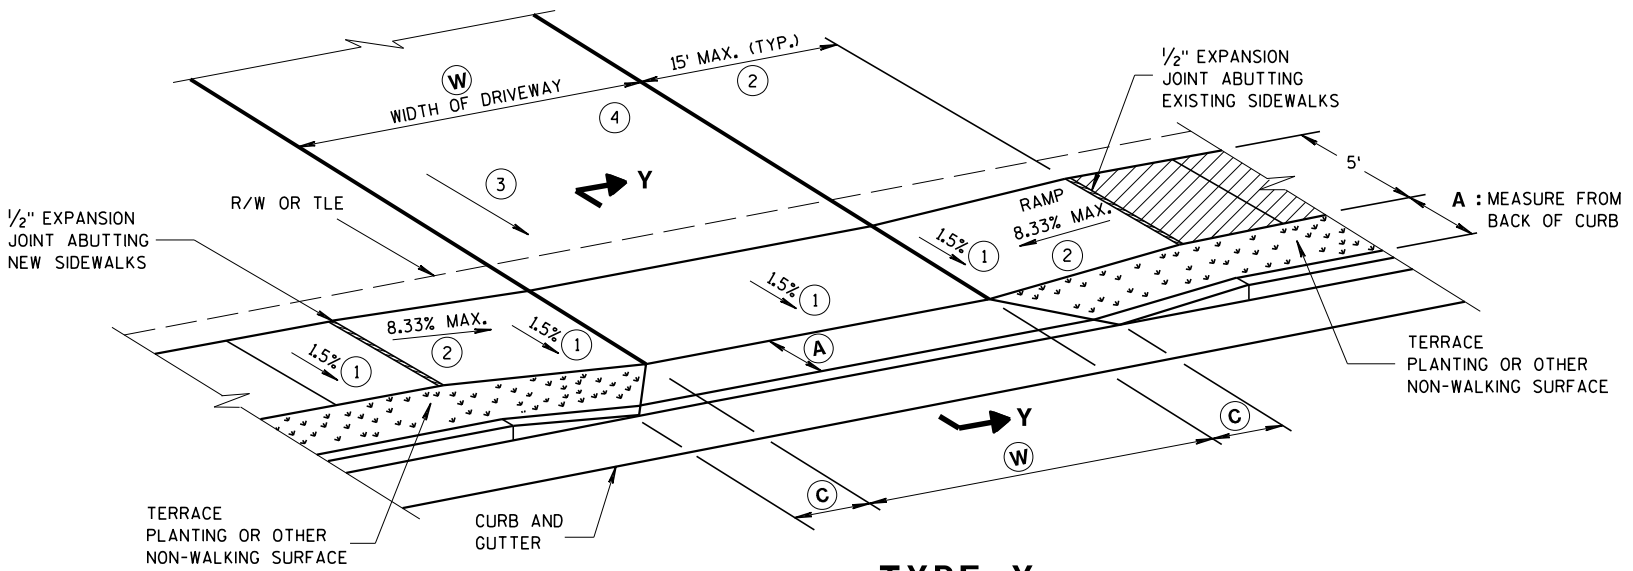

TYPE Y
SIDEWALK WITH NARROWER TERRACE
TERRACE VARIES 4 TO 6 FEET

W: 12' MIN. - 24' MAX. RESIDENTIAL AND NON-COMMERCIAL (PE & FE)
16' MIN. - 35' MAX. COMMERCIAL (CE)


GENERAL NOTES

PROVIDE CONSTRUCTION JOINTS ALONG THE CENTER OF THE CONCRETE FOR DRIVEWAYS UNDER 20 FEET IN WIDTH AND AT THE THIRD POINTS OVER 20 FEET IN WIDTH.


W IS SHOWN ON PLAN AND PROFILE SHEETS.

OFFSETS, ELEVATIONS, AND PERCENT GRADE ARE SHOWN ON THE CROSS SECTIONS.

- 1 CONSTRUCTION TOLERANCE OF 0.5% ± FOR SIDEWALK CROSS SLOPE. THE SIDEWALK CROSS SLOPE SHALL NOT EXCEED 2%.
- 2 THE SIDEWALK RAMP MAXIMUM RUNNING SLOPE SHALL NOT REQUIRE THE RAMP LENGTH TO EXCEED 15 FEET TO AVOID CHASING THE SLOPE INDEFINITELY WHEN CONNECTING TO STEEP GRADES. WHEN APPLYING THE 15 FOOT MAXIMUM LENGTH, THE RUNNING SLOPE OF THE SIDEWALK SHALL BE AS FLAT AS FEASIBLE AND NOT EXCEED THE LONGITUDINAL GRADE OF THE ROADWAY. SLOPE SIDEWALK RAMP TOWARD APRON AS SHOWN WHERE THERE IS NO TERRACE OR WHERE THE TERRACE WIDTH IS LESS THAN 6 FEET WIDE.
- 3 DRIVEWAY SLOPES: DESIRABLE MAXIMUM
10.5% UP AWAY FROM SIDEWALK (SAG)
8.5% DOWN AWAY FROM SIDEWALK (CREST)
ABSOLUTE MAXIMUM 15% FOR BOTH CREST AND SAG
- 4 DRIVEWAY TYPES
 - 6-INCH CONCRETE DRIVEWAY PAVEMENT OVER 6-INCH BASE AGGREGATE
 - 2-INCH TO 3-INCH ASPHALTIC SURFACE OVER 6-INCH BASE AGGREGATE
 - 6-INCH BASE AGGREGATE (MAY BE INCREASED FOR CLAY SUBGRADES)

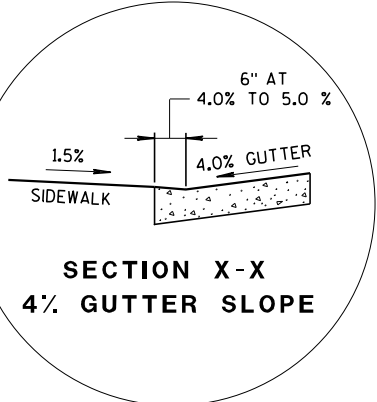


SECTION X-X
4% GUTTER SLOPE

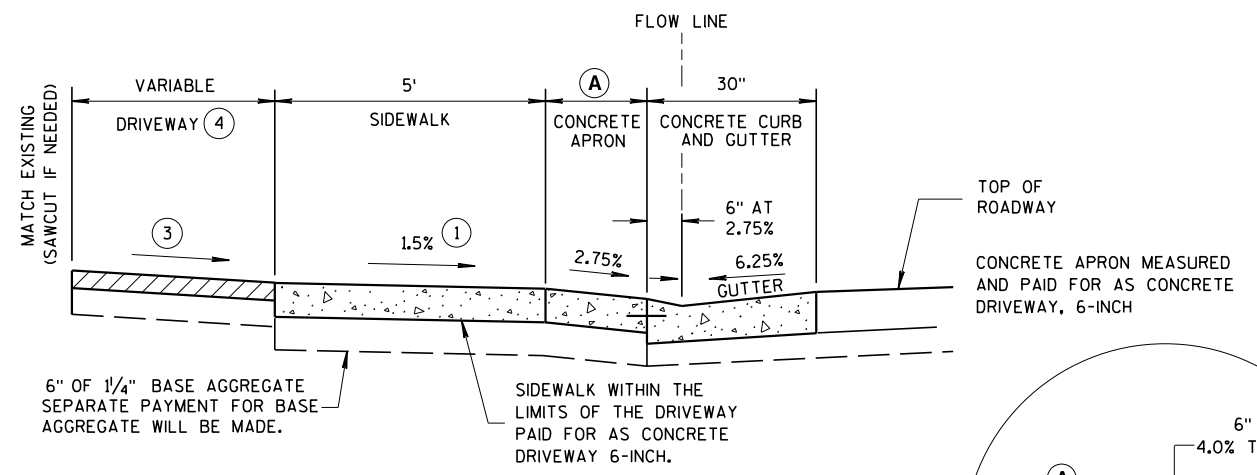

NOTE: SIDEWALK MAY BE DEPRESSED IN DRIVEWAY AREAS

SECTION Y-Y
DRIVEWAY DETAIL
WITH CONCRETE CURB & GUTTER
(URBAN AND SUBURBAN)

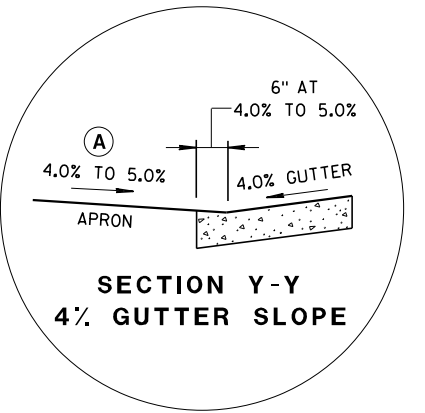

SECTION Y-Y
4% GUTTER SLOPE

TABLE Y

A FEET	C FEET
3.5'	2.0'
4.5'	3.0'
5.5'	3.5'



NOT TO SCALE

DRIVEWAY AND SIDEWALK
RAMPS
TYPES X & Y

STATE OF WISCONSIN
DEPARTMENT OF TRANSPORTATION

APPROVED
March 2018
DATE
FHWA

/S/ Rodney Taylor
ROADWAY STANDARDS DEVELOPMENT
UNIT SUPERVISOR

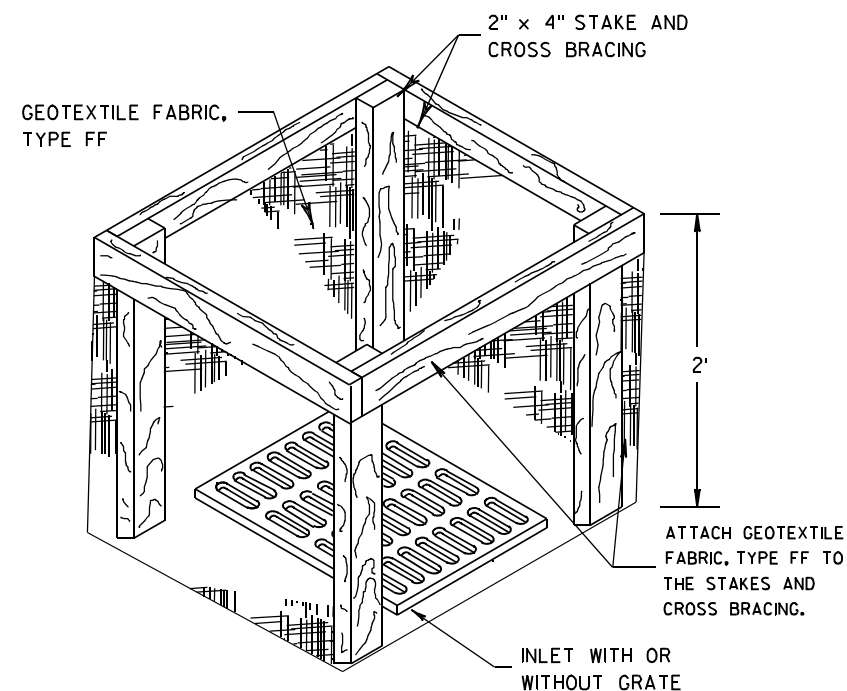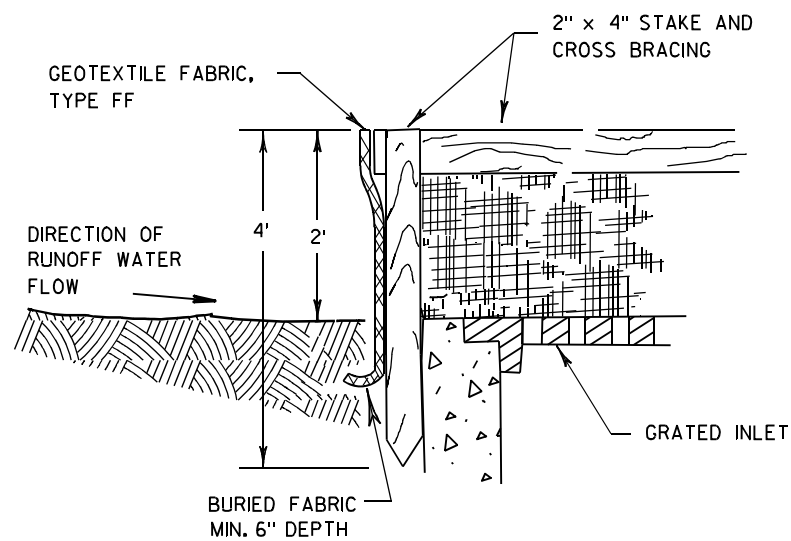

INLET PROTECTION, TYPE A


GENERAL NOTES

INLET PROTECTION DEVICES SHALL BE MAINTAINED OR REPLACED AT THE DIRECTION OF THE ENGINEER.

MANUFACTURED ALTERNATIVES APPROVED AND LISTED ON THE DEPARTMENT'S EROSION CONTROL PRODUCT ACCEPTABILITY LIST MAY BE SUBSTITUTED.


WHEN REMOVING OR MAINTAINING INLET PROTECTION, CARE SHALL BE TAKEN SO THAT THE SEDIMENT TRAPPED ON THE GEOTEXTILE FABRIC DOES NOT FALL INTO THE INLET. ANY MATERIAL FALLING INTO THE INLET SHALL BE REMOVED IMMEDIATELY.

- ① FINISHED SIZE, INCLUDING FLAP POCKETS WHERE REQUIRED, SHALL EXTEND A MINIMUM OF 10" AROUND THE PERIMETER TO FACILITATE MAINTENANCE OR REMOVAL.
- ② FOR INLET PROTECTION, TYPE C (WITH CURB BOX), AN ADDITIONAL 18" OF FABRIC IS WRAPPED AROUND THE WOOD AND SECURED WITH STAPLES. THE WOOD SHALL NOT BLOCK THE ENTIRE HEIGHT OF THE CURB BOX OPENING.
- ③ FLAP POCKETS SHALL BE LARGE ENOUGH TO ACCEPT WOOD 2X4.

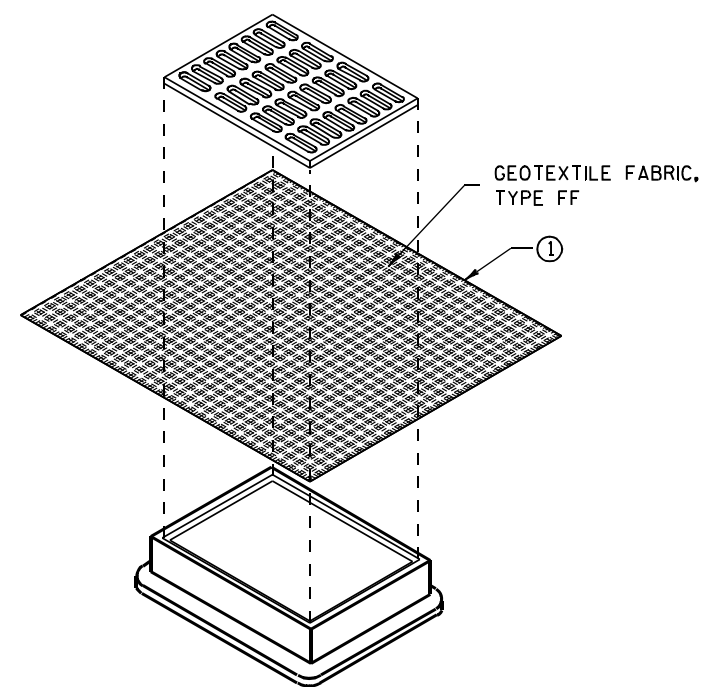

**INLET PROTECTION, TYPE B
(WITHOUT CURB BOX)**

(CAN BE INSTALLED IN ANY INLET WITHOUT A CURB BOX)

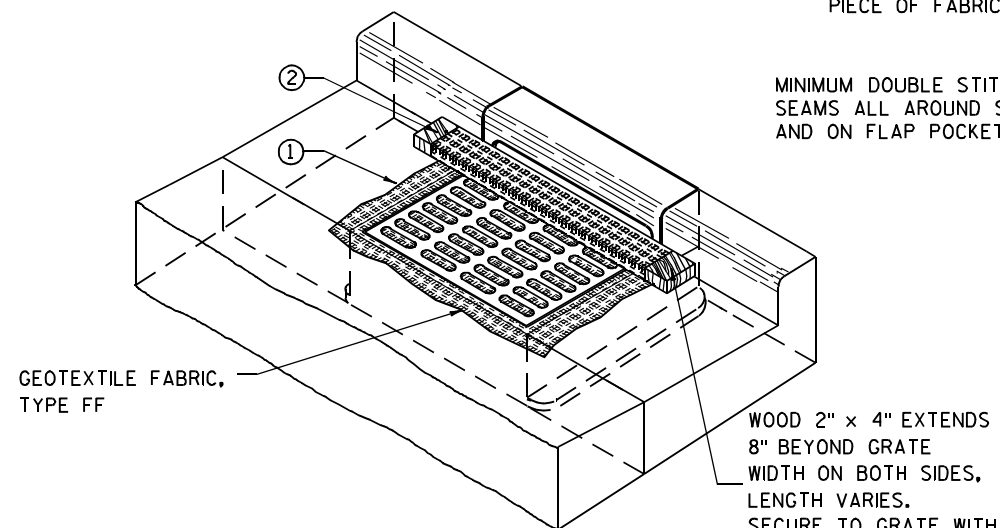

INLET PROTECTION, TYPE C (WITH CURB BOX)

INSTALLATION NOTES

TYPE B & C

TRIM EXCESS FABRIC IN THE FLOW LINE TO WITHIN 3" OF THE GRATE.


THE CONTRACTOR SHALL DEMONSTRATE A METHOD OF MAINTENANCE, USING A SEWN FLAP, HAND HOLDS OR OTHER METHOD TO PREVENT ACCUMULATED SEDIMENT FROM ENTERING THE INLET.

TYPE D

DO NOT INSTALL INLET PROTECTION TYPE D IN INLETS SHALLower THAN 30", MEASURED FROM THE BOTTOM OF THE INLET TO THE TOP OF THE GRATE.


TRIM EXCESS FABRIC IN THE FLOW LINE TO WITHIN 3" OF THE GRATE.

THE INSTALLED BAG SHALL HAVE A MINIMUM SIDE CLEARANCE, BETWEEN THE INLET WALLS AND THE BAG, MEASURED AT THE BOTTOM OF THE OVERFLOW HOLES, OF 3". WHERE NECESSARY THE CONTRACTOR SHALL CINCH THE BAG, USING PLASTIC ZIP TIES, TO ACHIEVE THE 3" CLEARANCE. THE TIES SHALL BE PLACED AT A MAXIMUM OF 4" FROM THE BOTTOM OF THE BAG.

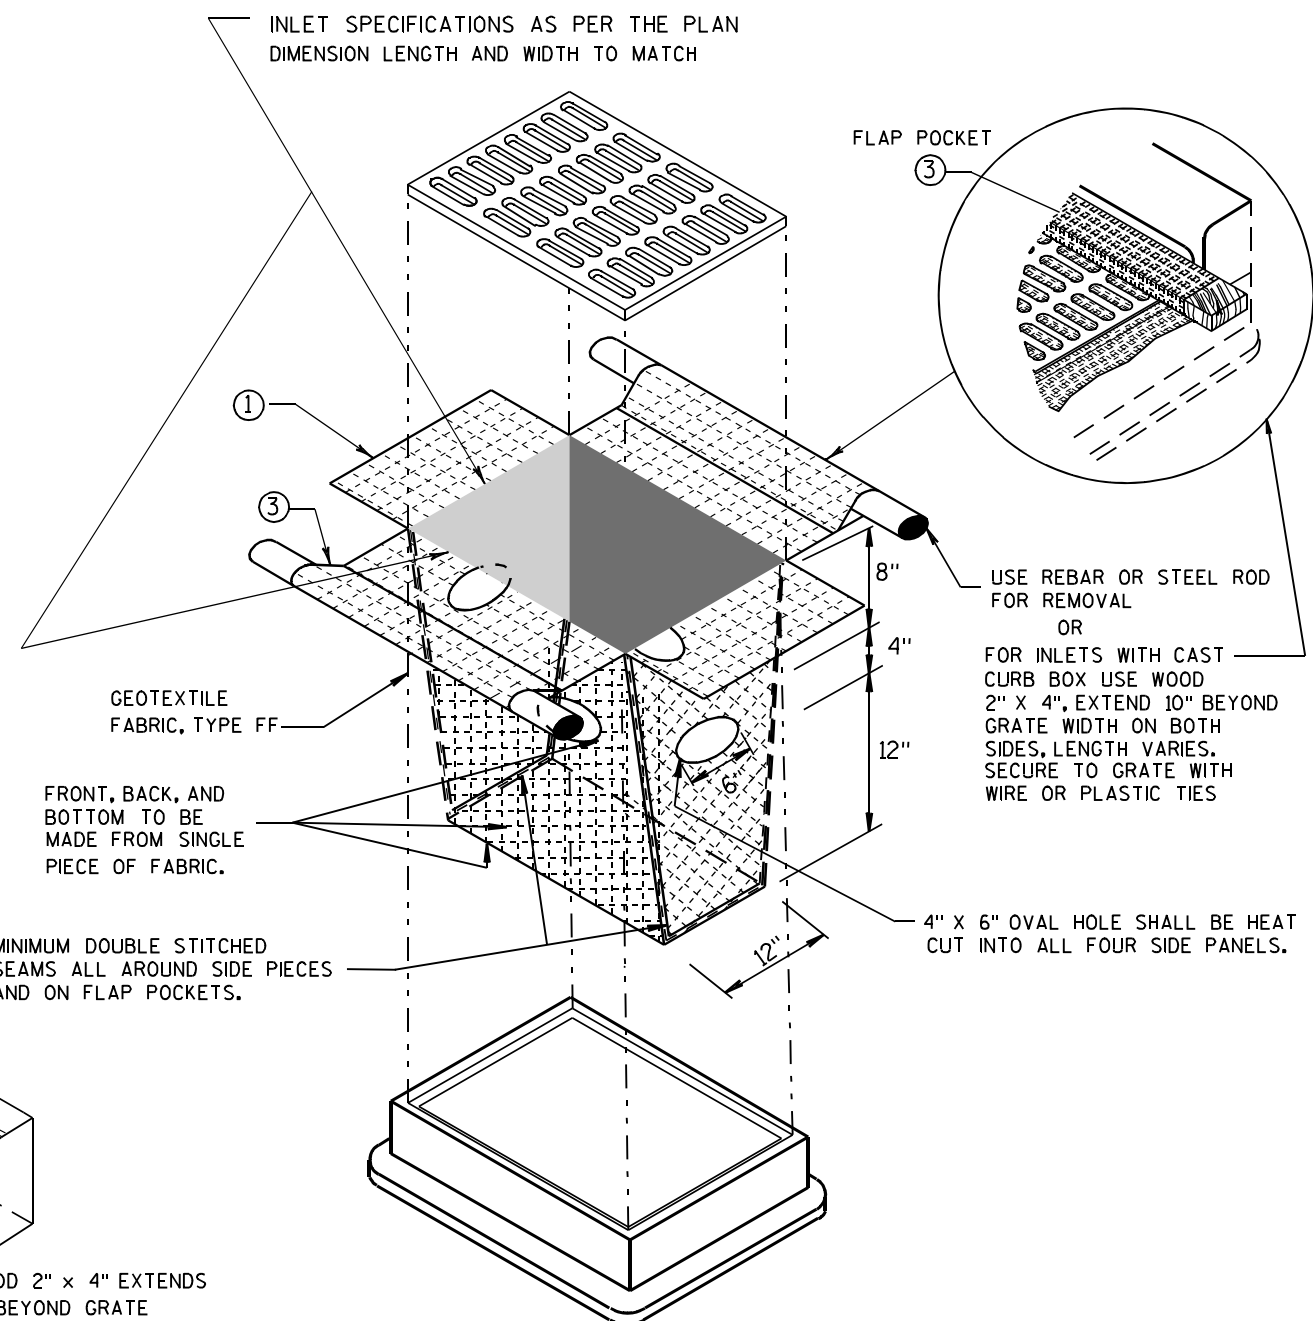

INLET PROTECTION, TYPE D

(CAN BE INSTALLED IN ANY INLET TYPE WITH OR WITHOUT A CURB BOX AS PER NOTE ②)

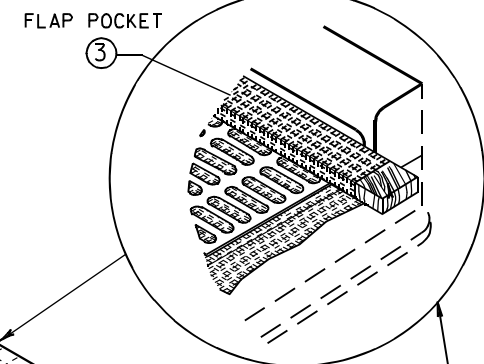

USE REBAR OR STEEL ROD FOR REMOVAL OR FOR INLETS WITH CAST CURB BOX USE WOOD 2" X 4", EXTEND 10" BEYOND GRATE WIDTH ON BOTH SIDES, LENGTH VARIES. SECURE TO GRATE WITH WIRE OR PLASTIC TIES

MINIMUM DOUBLE STITCHED SEAMS ALL AROUND SIDE PIECES AND ON FLAP POCKETS.





4" X 6" OVAL HOLE SHALL BE HEAT CUT INTO ALL FOUR SIDE PANELS.

**INLET PROTECTION
TYPE A, B, C, AND D**

STATE OF WISCONSIN
DEPARTMENT OF TRANSPORTATION

APPROVED
10/16/02 /S/ Beth Cannestra
DATE
FHWA CHIEF ROADWAY DEVELOPMENT ENGINEER


6

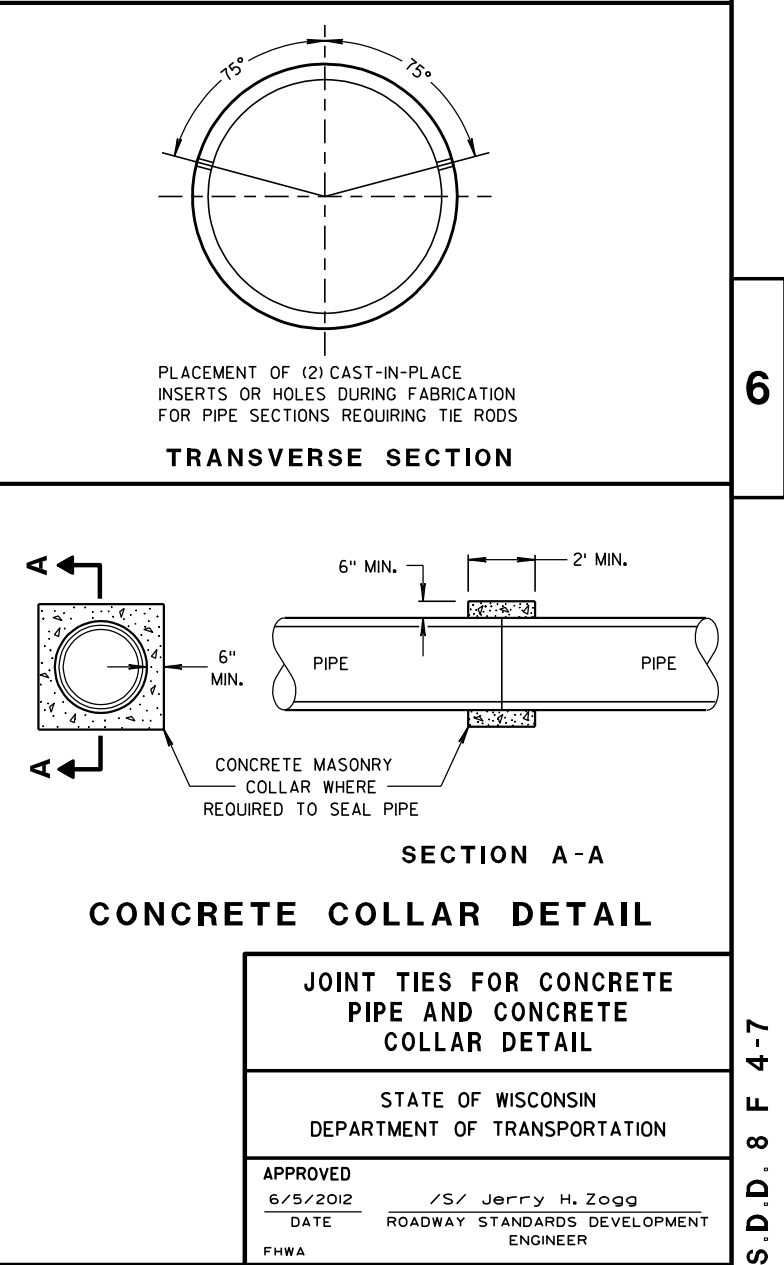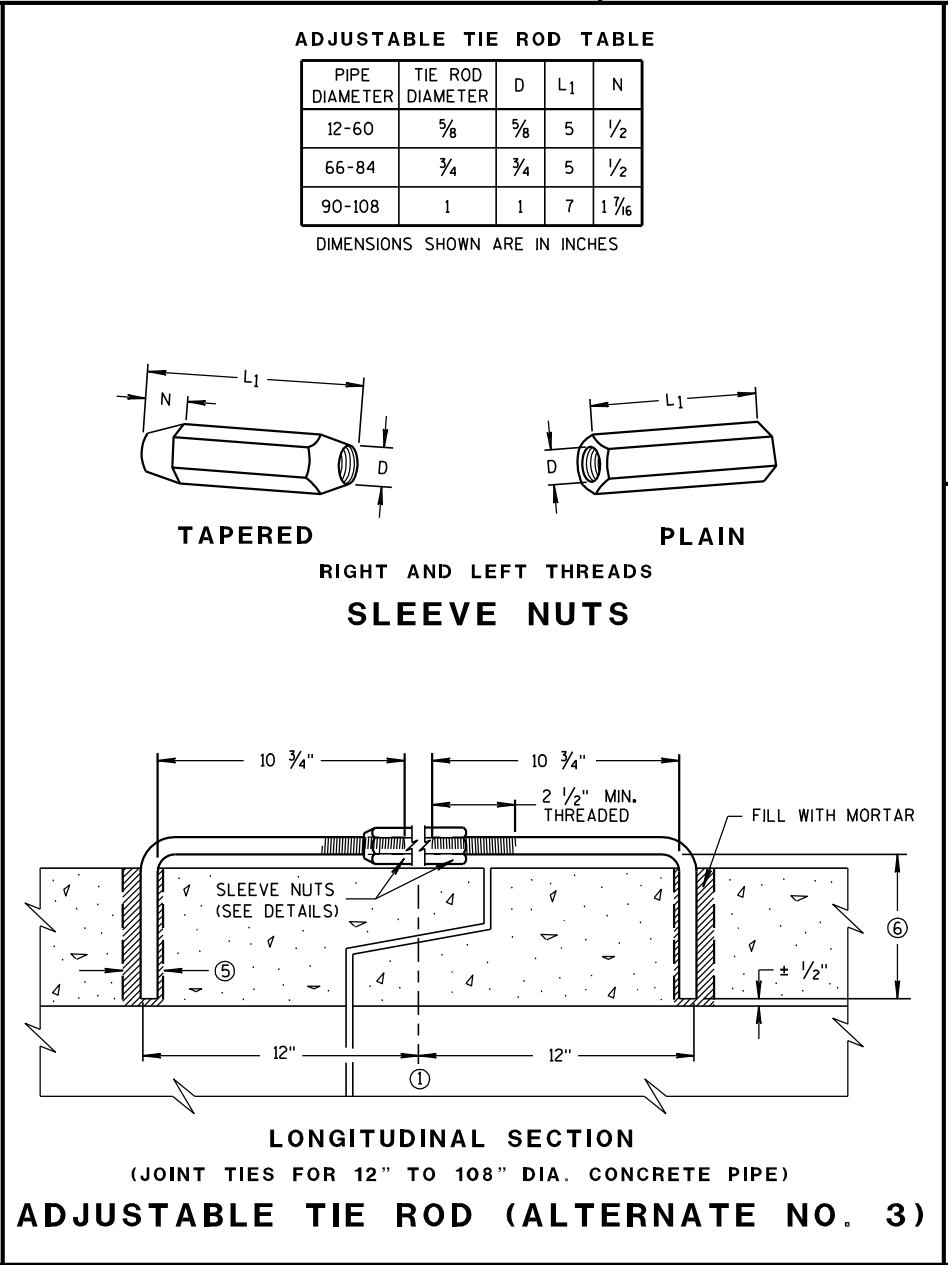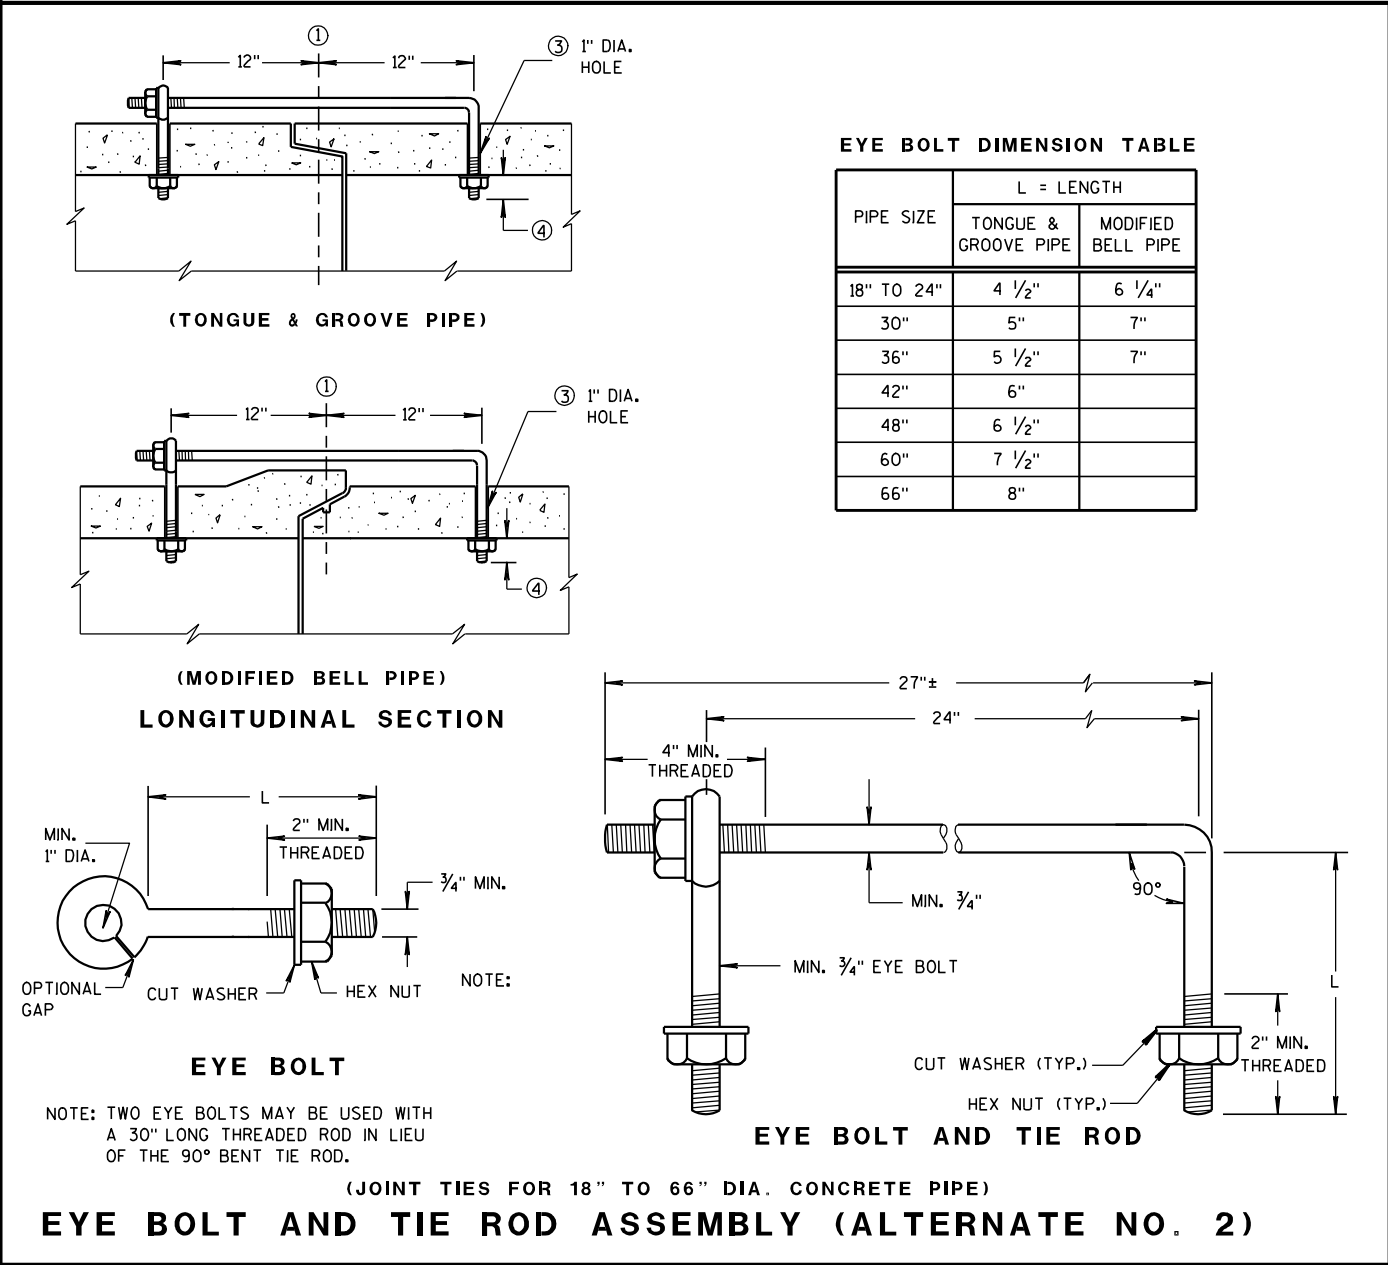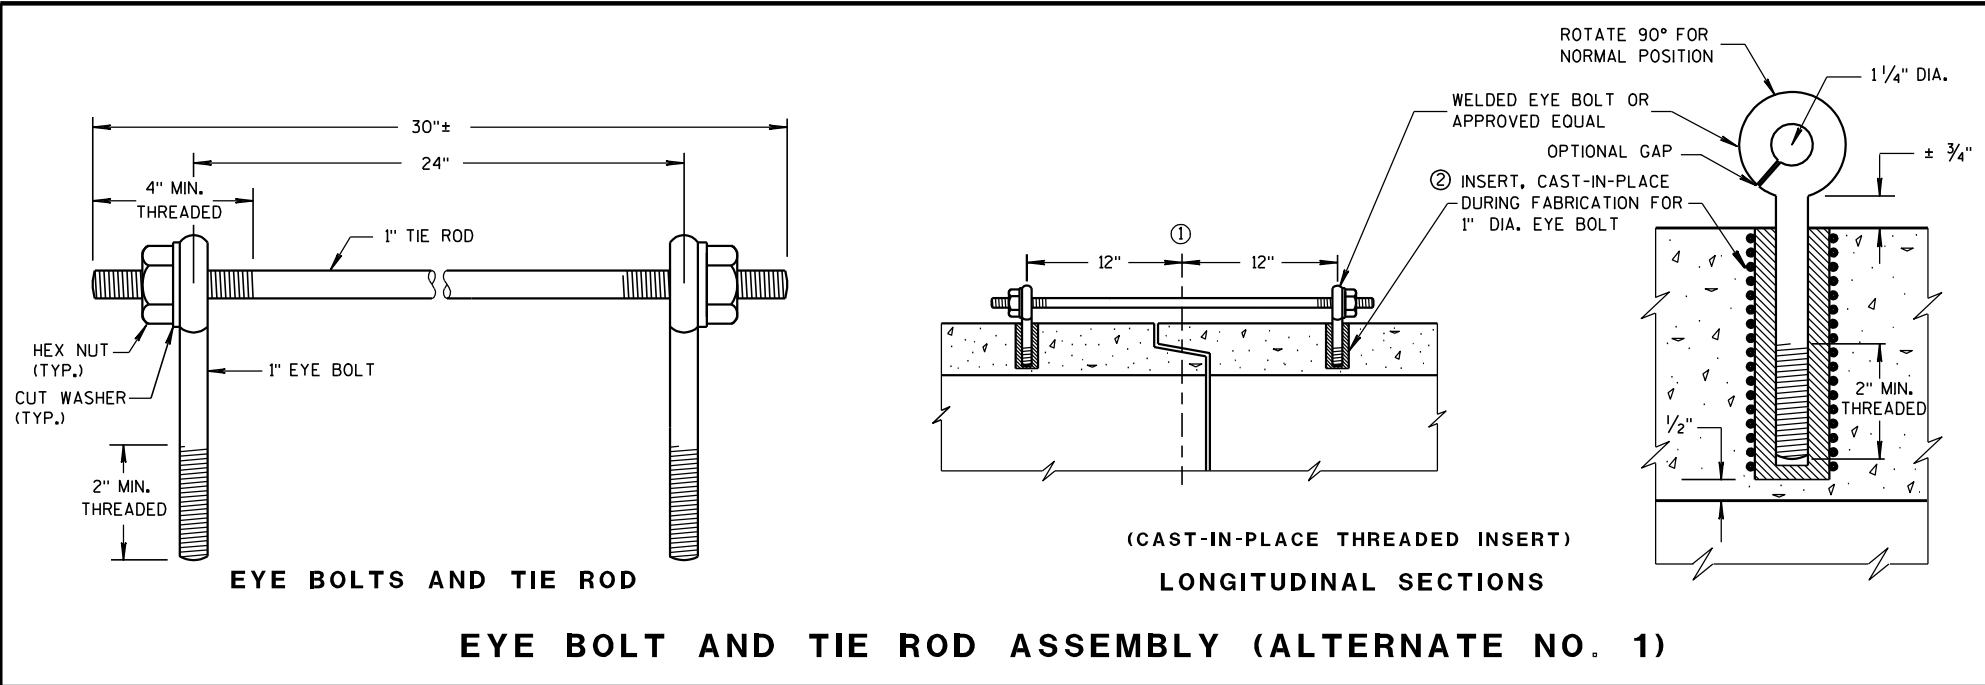


6

S.D.D. 8 F 4-7

S.D.D. 8 F 4-7

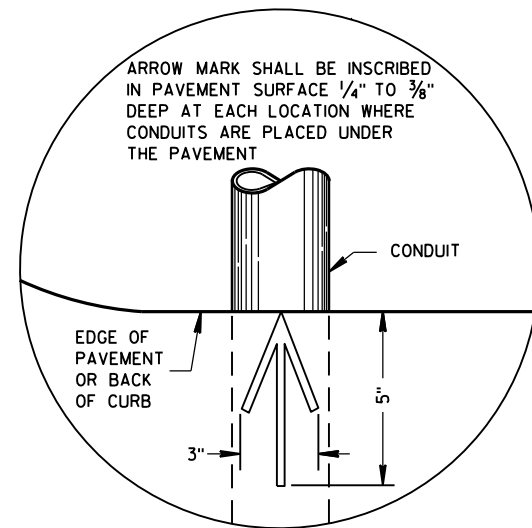

PLAN VIEW
ARROW MARK

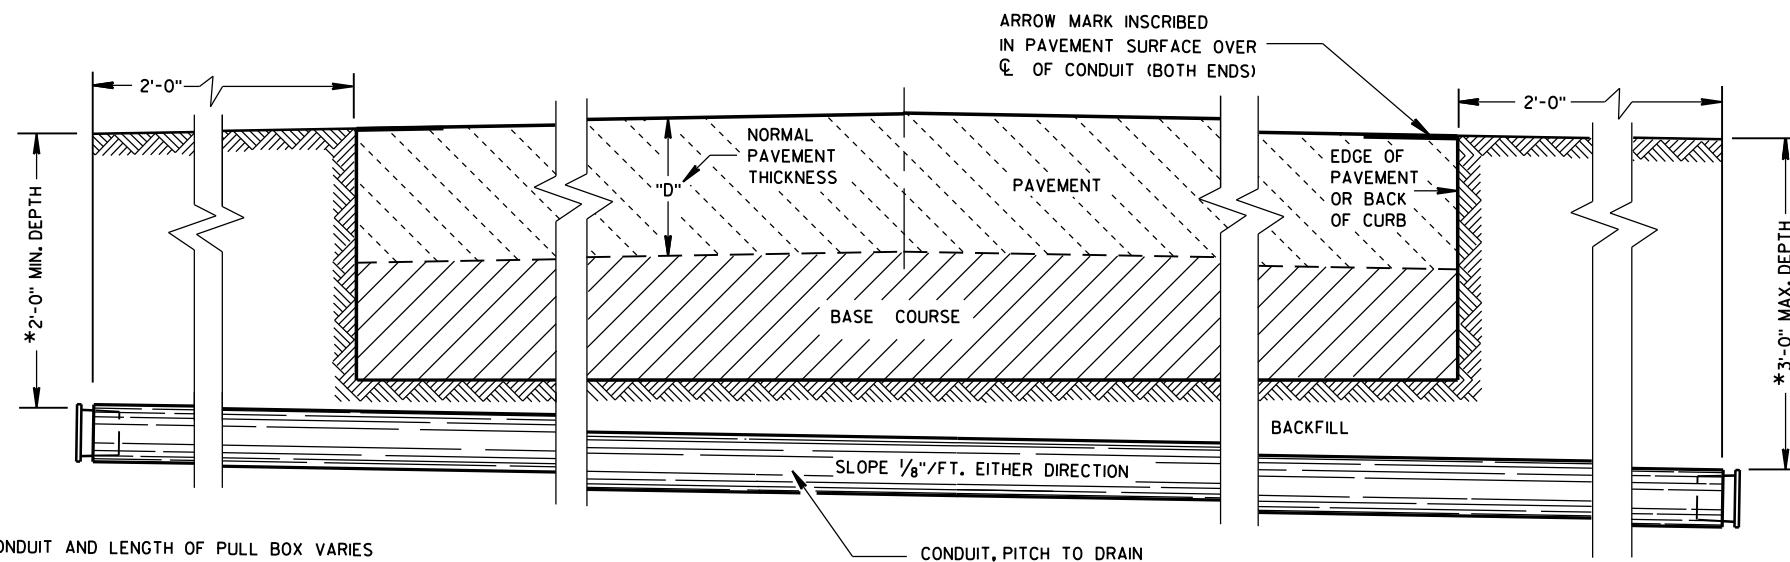

SIDE ELEVATION
DETAIL FOR CONDUIT UNDER PAVED HIGHWAYS

*DEPTH OF CONDUIT AND LENGTH OF PULL BOX VARIES
WITH HEIGHT OF CURB USED. ALSO SEE PULL BOX S.D.D. 9B4

GENERAL NOTES

DETAILS OF CONSTRUCTION, MATERIALS AND WORKMANSHIP NOT SHOWN ON THIS DRAWING SHALL CONFORM TO THE PERTINENT REQUIREMENTS OF THE CONTRACT.

METALLIC (STANDARD SPECIFICATION 652.2.2) OR NONMETALLIC (STANDARD SPECIFICATION 652.2.3) CONDUIT SHALL BE FURNISHED AND PLACED AS SHOWN.

DEPTH OF CONDUIT INSTALLED BELOW THE TRAVELED WAY SHALL BE 24 INCHES MINIMUM AND 36 INCHES MAXIMUM.

DEPTH OF CONDUIT INSTALLED THAT IS NOT BELOW THE TRAVELED WAY SHALL BE 18 INCHES MINIMUM AND 36 INCHES MAXIMUM.

ANY EXCEPTION TO THE MAXIMUM DEPTH SHALL BE ONLY WITH THE WRITTEN APPROVAL OF THE ENGINEER.

THE TRENCH SHALL NOT BE BACKFILLED PRIOR TO INSPECTION OF THE CONDUIT.

ALL METALLIC CONDUIT RACEWAY ENDS SHALL BE REAMED AND THREADED.

ALL METALLIC CONDUIT IN WHICH WIRE OR CABLE IS TO BE INSTALLED SHALL BE BUSHED WITH APPROVED THREADED BUSHINGS BEFORE INSTALLATION OF THE WIRE OR CABLE.

ALL METALLIC CONDUITS IN WHICH WIRE OR CABLE IS NOT TO BE INSTALLED SHALL BE CAPPED WITH THREADED PROTECTIVE CAPS, AS APPROVED BY THE ENGINEER.

ALL NONMETALLIC CONDUIT SHALL BE CAPPED OR PLUGGED IMMEDIATELY AFTER INSTALLATION AND SHALL REMAIN CAPPED OR PLUGGED UNTIL WIRE/CABLES ARE INSTALLED.

NONMETALLIC CONDUITS IN WHICH WIRE OR CABLE IS NOT BEING INSTALLED SHALL REMAIN CAPPED OR PLUGGED.

BENDING OF PVC ELECTRICAL CONDUIT SHALL BE ACCOMPLISHED BY USING A BLANKET OR EMERSION TYPE TANK DESIGNED FOR THE PURPOSE OF BENDING PVC ELECTRICAL CONDUIT.

ALL CUT ENDS SHALL BE TRIMMED INSIDE AND OUTSIDE TO REMOVE ALL ROUGH EDGES ON NONMETALLIC CONDUIT. (SEE NEC 347.5)

WHEN REQUIRED TO CONNECT NONMETALLIC CONDUIT TO METALLIC CONDUIT, ONLY U.L. LISTED ADAPTER FITTINGS SHALL BE USED.

PRIOR TO CONDUIT ACCEPTANCE, CONDUIT CAPS OR PLUGS SHALL BE REMOVED, AND THE CAPS, PLUGS AND CONDUIT ENDS SHALL BE THOROUGHLY CLEANED AND THEN THE CAPS OR PLUGS REINSTALLED TO ENSURE THAT THE CAPS OR PLUGS CAN BE EASILY REMOVED IN THE FUTURE.

ALL CONDUIT BEING FURNISHED AND INSTALLED SHALL HAVE THE U.L. LABEL FIRMLY ATTACHED.

CONDUIT RUNS SHALL BE THE SAME SIZE OF CONDUIT FROM ONE END TO THE OTHER (FROM PULL BOX TO PULL BOX-OR-JUNCTION BOX TO JUNCTION BOX-OR-BASE TO BASE, ETC.).

TRACER WIRE SHALL BE INSTALLED AS STATED IN THE STANDARD SPECIFICATION, ITEM 652.3.1.1.

ALL CONDUIT RUNS SHALL BE STRAIGHT (WITHOUT BENDS) FROM PULL BOX TO PULL BOX, PULL BOX TO BASE AND BASE TO BASE AS SHOWN ON THE PLANS.

CONDUIT

STATE OF WISCONSIN
DEPARTMENT OF TRANSPORTATION

APPROVED
March, 2017 /S/ Ahmet Demirbilek
DATE STATE ELECTRICAL ENGINEER
FHWA

TABLE OF NOMINAL DIMENSIONS AND WEIGHTS

DIMENSION IN INCHES		NON-CONDUCTIVE PULL BOX	
BOX DIAMETER ** (INSIDE)	A	24	24
BOX OVERALL OUTSIDE DIAMETER	B	27	27
BOX LENGTH	C	36	42
FRAME OPENING	D	22 1/2	22 1/2
WEIGHT IN POUNDS *			
COVER		50	50
BOX ONLY		75	85

* THE ACTUAL WEIGHT OF THE COVER OR BOX ONLY MAY VARY NOT TO EXCEED 100 LBS INDIVIDUALLY.

** DIAMETER VARIES FROM TOP TO BOTTOM WITH THE DIAMETER LARGER AT THE BOTTOM TO PREVENT FROST HEAVE

GENERAL NOTES

DETAILS OF CONSTRUCTION, MATERIALS AND WORKMANSHIP NOT SHOWN ON THIS DRAWING SHALL CONFORM TO THE PERTINENT REQUIREMENTS OF THE CONTRACT.

ALL BOXES, FRAMES AND COVERS SHALL BE SUITABLE FOR TIER 15 LOADING AS SPECIFIED IN ANSI/SCTE 77.

PROVIDE AN OPENING FOR TOOL ASSISTED COVER REMOVAL NOT LARGE ENOUGH TO PERMIT PASSAGE OF A SPHERE MORE THAN 1/2" DIAMETER

ENSURE COVER SURFACE IS SKID RESISTANT WITH A COEFFICIENT OF FRICTION OF AT LEAST 0.5 AND VERTICAL SURFACE DISCONTINUITIES LESS THAN 1/4".

COVER SHALL BE MAGNETICALLY LOCATABLE.

BOXES AND EXTENSIONS ARE TRIMMABLE FOR CUSTOM LENGTHS. TRIMMED PIECES SHALL MAINTAIN A UNIFORM LENGTH.

ENTRANCE HOLES INTO PULL BOXES SHALL BE CUT WITH A CIRCULAR HOLE SAW OR HYDRAULIC CONDUIT PUNCH. HOLE SIZE SHALL BE THE OUTSIDE DIAMETER OF THE CONDUIT THAT IS TO FIT IN THE OPENING PLUS NO MORE THAN 1/4".


THE CONTRACTOR SHALL NOT INSTALL WIRE IN ANY PULL BOX UNTIL ITS INSTALLATION HAS BEEN INSPECTED AND ACCEPTED BY THE ENGINEER.

ALL METALLIC CONDUIT IN WHICH WIRE AND/OR CABLE IS TO BE INSTALLED, SHALL BE BUSHED BEFORE INSTALLATION OF THE WIRE AND/OR CABLE.


ENTIRE BOX MUST BE CONSTRUCTED OF NON-CONDUCTIVE MATERIALS WITH THE EXCEPTION OF STAINLESS STEEL FASTENERS AND MAGNETIC LOCATABLE DEVICE.

WHEN A PULL BOX IS INSTALLED IN CRUSHED AGGREGATE SHOULDERS, PLACE IT 2-3 INCHES BELOW GRADE AND COVER IT WITH 2-3 INCHES OF CRUSHED AGGREGATE



LABEL ON COVER SHALL READ "ELECTRIC" FOR SIGNAL AND LIGHTING SYSTEMS, "WISDOT ITS" FOR COMMUNICATIONS AND ITS EQUIPMENT SYSTEMS.

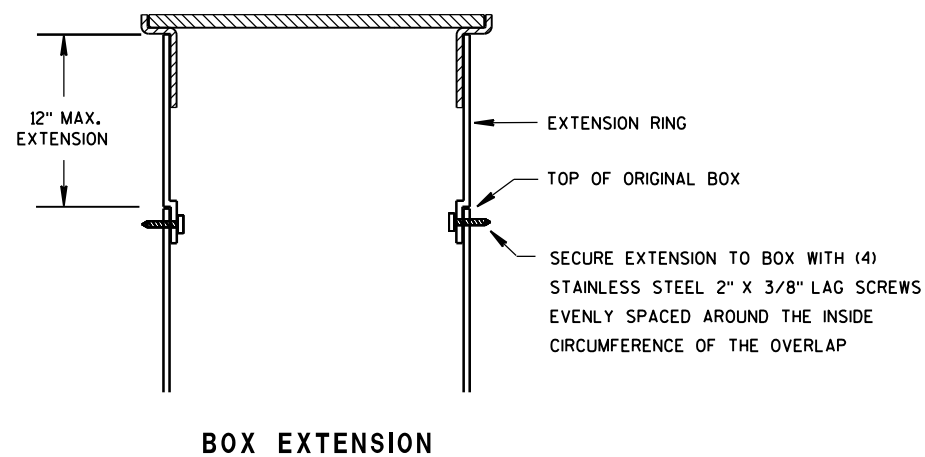

INSTALLED IN SOD OR CRUSHED AGGREGATE

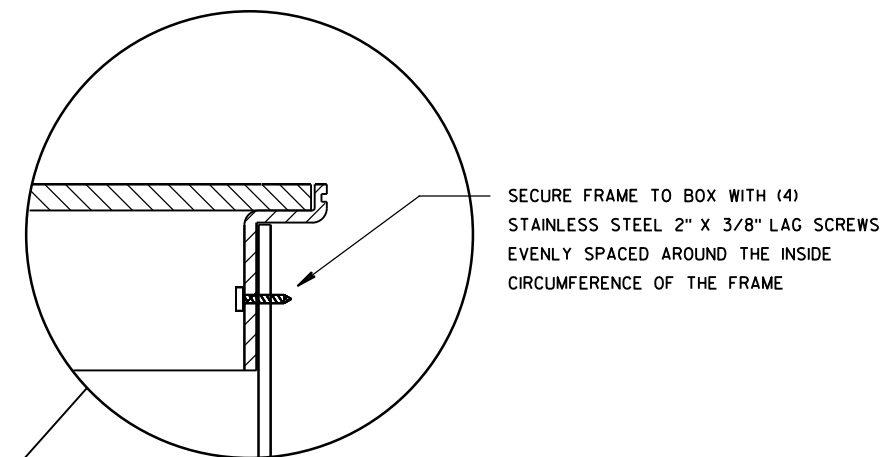

INSTALLED IN SIDEWALK

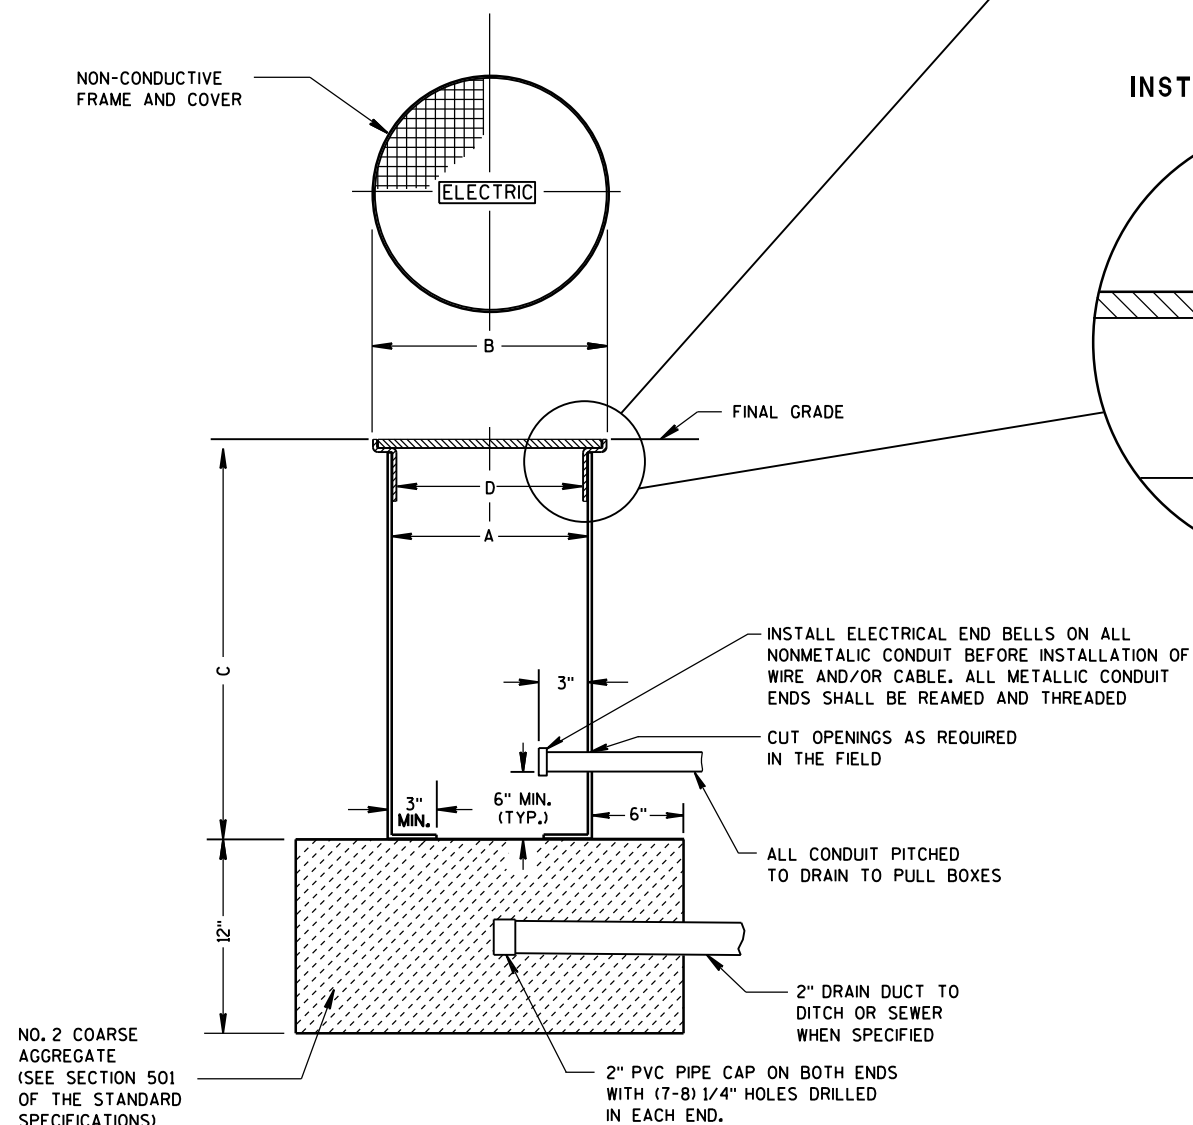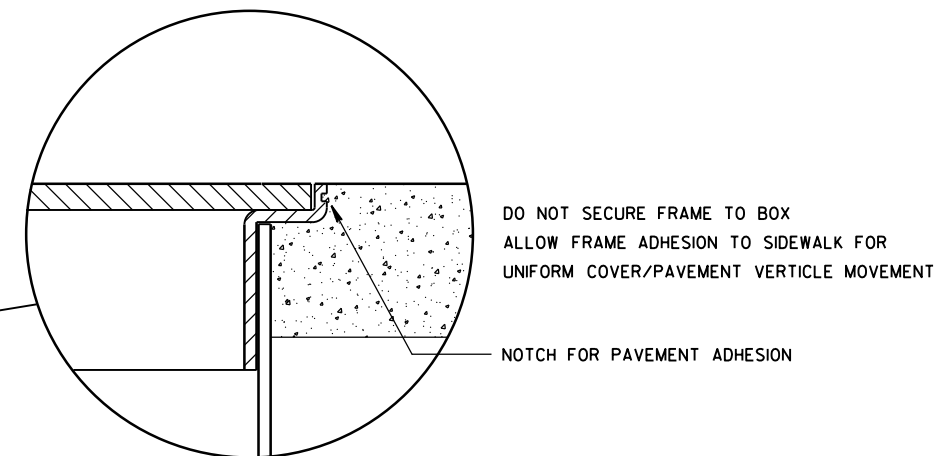

NON-CONDUCTIVE PULL BOX

PULL BOX
NON-CONDUCTIVE

STATE OF WISCONSIN
DEPARTMENT OF TRANSPORTATION


APPROVED

May 2017
DATE

FHWA

/S/ Ahmet Demirbilek
STATE ELECTRICAL ENGINEER

FORM DEPTH SHALL BE NO MORE THAN 6" BELOW GRADE ON THE LOWER SIDE OF BASE

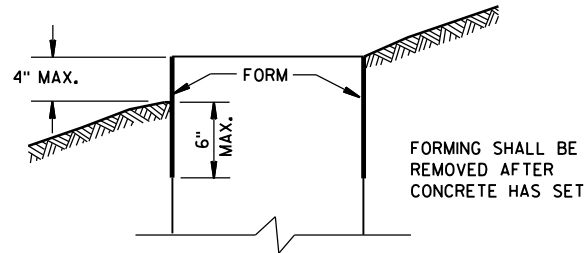

FORMING DETAIL

QUANTITY REQUIREMENTS	CONCRETE BASE TYPE		
	1	2	5 & 6
APPROX. CUBIC YARDS OF CONCRETE	0.40	0.57	0.40
LBS. OF HOOP BAR STEEL	NONE	23	16
LBS. OF VERTICAL BAR STEEL	NONE	60	18

GENERAL NOTES

DETAILS OF CONSTRUCTION, MATERIALS AND WORKMANSHIP NOT SHOWN ON THIS DRAWING SHALL CONFORM TO THE PERTINENT REQUIREMENTS OF THE CONTRACT.

BASES SHALL BE EXCAVATED BY USE OF A CIRCULAR AUGER.

TOP SURFACES OF CONCRETE BASES SHALL BE TROWEL FINISHED SMOOTH AND LEVEL.

CONDUIT SIZES AND LOCATIONS SHALL BE AS SHOWN ON THE PLANS.

THE FINAL OR TERMINATING CONCRETE BASE IN A CONDUIT RUN SHALL HAVE A 6" EXIT STUB INSTALLED FOR FUTURE CABLING USE. THE EXIT STUB SHALL BE SIZED AS USED THROUGHOUT THE CONDUIT RUN AS SHOWN AT THE ENTRANCE OF THE BASE.

MINIMUM BENDING RADIUS OF CONDUIT IS EQUAL TO 6 X THE DIAMETER.

CONDUIT HEIGHT ABOVE CONCRETE BASES SHALL BE 1 INCH. ALL METALLIC CONDUIT ENDS SHALL BE REAMED AND THREADED.

ALL CONDUIT ENDS AT THE TOP OF CONCRETE BASES SHALL BE CAPPED IF METALLIC OR PLUGGED IF NONMETALLIC IMMEDIATELY AFTER PLACEMENT AND BEFORE CONCRETE IS POURED. CONDUITS IN WHICH WIRE OR CABLE IS NOT INSTALLED SHALL REMAIN CAPPED OR PLUGGED.

GENERAL NOTES (CONTINUED)

BELL ENDS SHALL BE INSTALLED ON ALL PVC CONDUIT EXPOSED AT THE TOP OF CONCRETE BASES BEFORE INSTALLATION OF CABLE OR WIRE.

ENDS OF CONDUIT INSTALLED BELOW GRADE FOR FUTURE USE SHALL BE CAPPED IF METALLIC OR PLUGGED IF NONMETALLIC.

WHEN REQUIRED TO CONNECT NONMETALLIC CONDUIT TO METALLIC CONDUIT, ONLY ADAPTER FITTINGS, U.L. LISTED FOR ELECTRICAL USE, SHALL BE USED.

IF A BASE REQUIRES A DEEP FORM BECAUSE OF LOOSE DIRT OR FILL, THE FORM SHALL BE REMOVED BEFORE BACKFILLING AROUND THE BASE. BACKFILL SHALL BE TAMPED TIGHT AGAINST THE BARE CONCRETE BASE IN LAYERS OF 1 FOOT OR LESS.

A NO. 4 AWG. STRANDED COPPER EQUIPMENT GROUNDING CONDUCTOR SHALL BE EXOTHERMICALLY WELDED TO THE EQUIPMENT GROUNDING ELECTRODE (GROUND ROD) FOR TYPE 1, TYPE 2, TYPE 5, AND TYPE 6 BASES.

THE EQUIPMENT GROUNDING CONDUCTOR SHALL BE FURNISHED AND INSTALLED TO ENTER THE BASE OF THE TYPE 2 AND TYPE 5 BASES THROUGH A 1 INCH CONDUIT INSTALLED FOR GROUNDING PURPOSES, LEAVING A 4 FOOT COIL OF WIRE ABOVE THE CONCRETE BASE. THE EQUIPMENT GROUNDING CONDUCTOR SHALL BE NEATLY COILED AND THE COILS TIED TOGETHER.

ANCHOR RODS SHALL BE THREADED 12" IN LENGTH ON EACH END OF THE ROD. ANCHOR RODS SHALL BE MANUFACTURED IN ACCORDANCE WITH SECTION 654.2.1 OF THE STANDARD SPECIFICATIONS.

WASHERS AND LOCK WASHERS ARE REQUIRED ON ALL ANCHOR RODS.

WHEN ANCHOR RODS USING THE ALTERNATE "L" BEND ARE FURNISHED, THE 4" "L" BEND SHALL BE IN ADDITION TO THE SPECIFIED ANCHOR ROD BAR LENGTH. THE "L" BEND END SHALL NOT BE THREADED.

ANCHOR RODS SHALL BE INSTALLED WITH MISALIGNMENTS OF LESS THAN 1:40 FROM VERTICAL.


WELDING OF THE ANCHOR RODS TO THE CAGE IS UNACCEPTABLE. TIE WIRES SHALL BE USED.

BAR STEEL REINFORCEMENT SHALL BE COATED WITH POWDERED EPOXY RESIN IN ACCORDANCE WITH SECTION 505 OF THE STANDARD SPECIFICATIONS (LATEST EDITION).

- 1 THE MINIMUM DEPTH OF CONDUIT EXITING THE CONCRETE BASE AND INSTALLED BELOW THE TRAVELED WAY SHALL BE 24 INCHES. THE MINIMUM DEPTH OF CONDUIT EXITING THE CONCRETE BASE THAT IS NOT INSTALLED BELOW THE TRAVELED WAY SHALL BE 18 INCHES. THE MAXIMUM DEPTH OF ALL CONDUIT SHALL BE 36 INCHES EXCEPT WITH WRITTEN APPROVAL BY THE ENGINEER.


- 2 (4) 1" DIA. X 3'-6" ANCHOR RODS.
3 (4) 1" DIA. X 5'-0" ANCHOR RODS.
4 (6) NO. 6 X 6'-8" BAR STEEL REINFORCEMENT.
5 (7) NO. 4 X 5'-1" BAR STEEL REINFORCEMENT @ 1'-0" C-C.
6 (4) 1" DIA. X 3'-6" ANCHOR RODS.
7 (6) NO. 4 X 4'-8" BAR STEEL REINFORCEMENT.
8 (5) NO. 4 X 5'-1" BAR STEEL REINFORCEMENT @ 1'-0" C-C.

HALF SECTION IN UNPAVED AREA
(TYPICAL FOR TYPES 1, 2, 5, & 6)

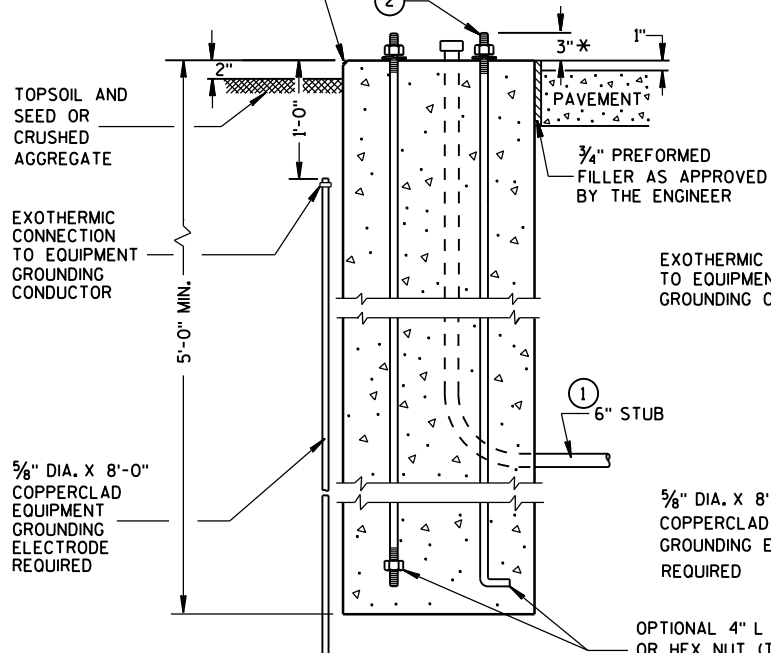


TYPE 1

HALF SECTION IN PAVEMENT
(TYPICAL FOR TYPES 1, 2, 5, & 6)

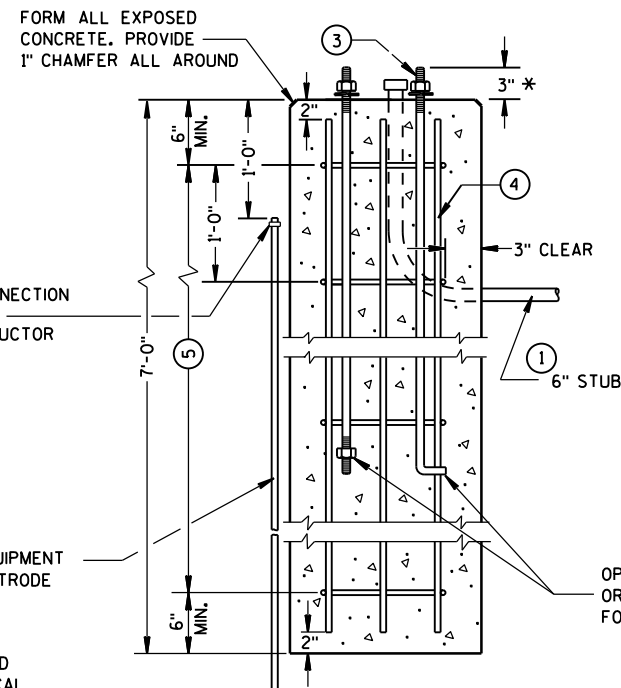

TYPE 2

FORM ALL EXPOSED CONCRETE. PROVIDE 1" CHAMFER ALL AROUND

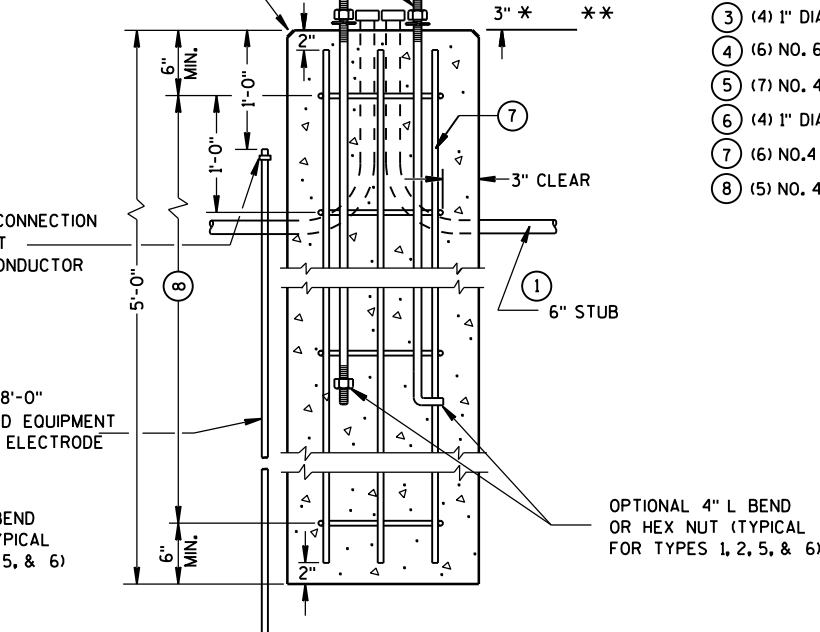

TYPE 5 & 6

CONCRETE BASES

* ANY ANCHOR ROD PROJECTION SHORTER THAN 2 3/4" OR LONGER THAN 3 1/4" SHALL REQUIRE THE BASE TO BE REMOVED AND REPLACED AT THE CONTRACTORS EXPENSE.

** FOR NONBREAKAWAY INSTALLATIONS, 4 1/2" ± ANCHOR ROD PROJECTION WITH THE USE OF LEVELING NUTS. RODENT SCREEN REQUIRED.

CONCRETE BASES,
TYPES 1, 2, 5, & 6

STATE OF WISCONSIN
DEPARTMENT OF TRANSPORTATION

APPROVED

Sept. 2014

DATE

FHWA

/S/ Ahmet Demirbilek
STATE ELECTRICAL ENGINEER

GENERAL NOTES

DETAILS OF CONSTRUCTION, MATERIALS AND WORKMANSHIP NOT SHOWN ON THIS DRAWING SHALL CONFORM TO THE PERTINENT REQUIREMENTS OF THE CONTRACT.

FOUR (4) BOLTS SHALL BE FURNISHED WITH EACH TRANSFORMER BASE. BOLTS SHALL BE 1" DIAMETER, 4" IN LENGTH, WITH WASHERS, LOCK WASHERS AND NUTS. BOLTS, NUTS AND WASHERS SHALL BE MANUFACTURED IN ACCORDANCE WITH SECTION 641.2.2 OF THE STANDARD SPECIFICATIONS.

LEVELING SHIMS, IF NEEDED, SHALL BE DESIGNED FOR THE PURPOSE AND USED UNDER CAST BASES WHEN PLUMBING POLES OR STANDARDS DURING INSTALLATION. THE USE OF WASHERS IN LIEU OF PROPER LEVELING SHIMS IS NOT ACCEPTABLE.

SHIM LENGTH SHALL BE LONG ENOUGH TO COMPLETELY COVER THE AREA UNDER THE LENGTH AND WIDTH OF THE BASE MOUNTING FLANGE.

DOUBLE NUTTING IS NOT ACCEPTABLE FOR LEVELING OR MOUNTING PURPOSES.

A NEMA APPROVED, U.L. LISTED, COPPER WITH BRASS OR STAINLESS STEEL SET SCREW, DIRECT BURY RATED, MECHANICAL CONNECTOR (LUG), SIZED TO ACCEPT AWG. #10 TO #4 COPPER STRANDED WIRE SHALL BE FURNISHED AND INSTALLED IN THE PEDESTAL AND TRANSFORMER BASES.


THE MECHANICAL CONNECTOR SHALL BE INSTALLED USING A 1/4" - 20 (TPI) STAINLESS STEEL HEX HEAD BOLT OF SUFFICIENT LENGTH TO FIRMLY ATTACH THE LUG TO THE BASE.

SHOULD THE MANNER OF ATTACHMENT OF THE LUG REQUIRE WASHERS, HEX NUTS, LOCK WASHER - THEY SHALL BE STAINLESS STEEL AS IS THE BOLT. THE MANNER OF ATTACHMENT SHALL NOT BLOCK ACCESSIBILITY TO WIRE PLACEMENT IN THE CONNECTOR.

PEDESTAL BASE COLLAR THREADING SHALL BE TAPERED AND IN ACCORDANCE WITH NATIONAL PIPE THREADING DIMENSIONS.

BASE COLLAR THREADING SHALL EXTEND INTO THE BASE COLLAR WITH SUFFICIENT DEPTH TO ACCEPT THE INSTALLATION OF TRAFFIC SIGNAL STANDARDS TO A DEPTH OF 1/2", THEN TIGHTENING TO A POINT OF BEING IMMOVABLE.

THE ACCESS DOOR SHALL BE OF THE SAME MATERIAL AS THE BASE.

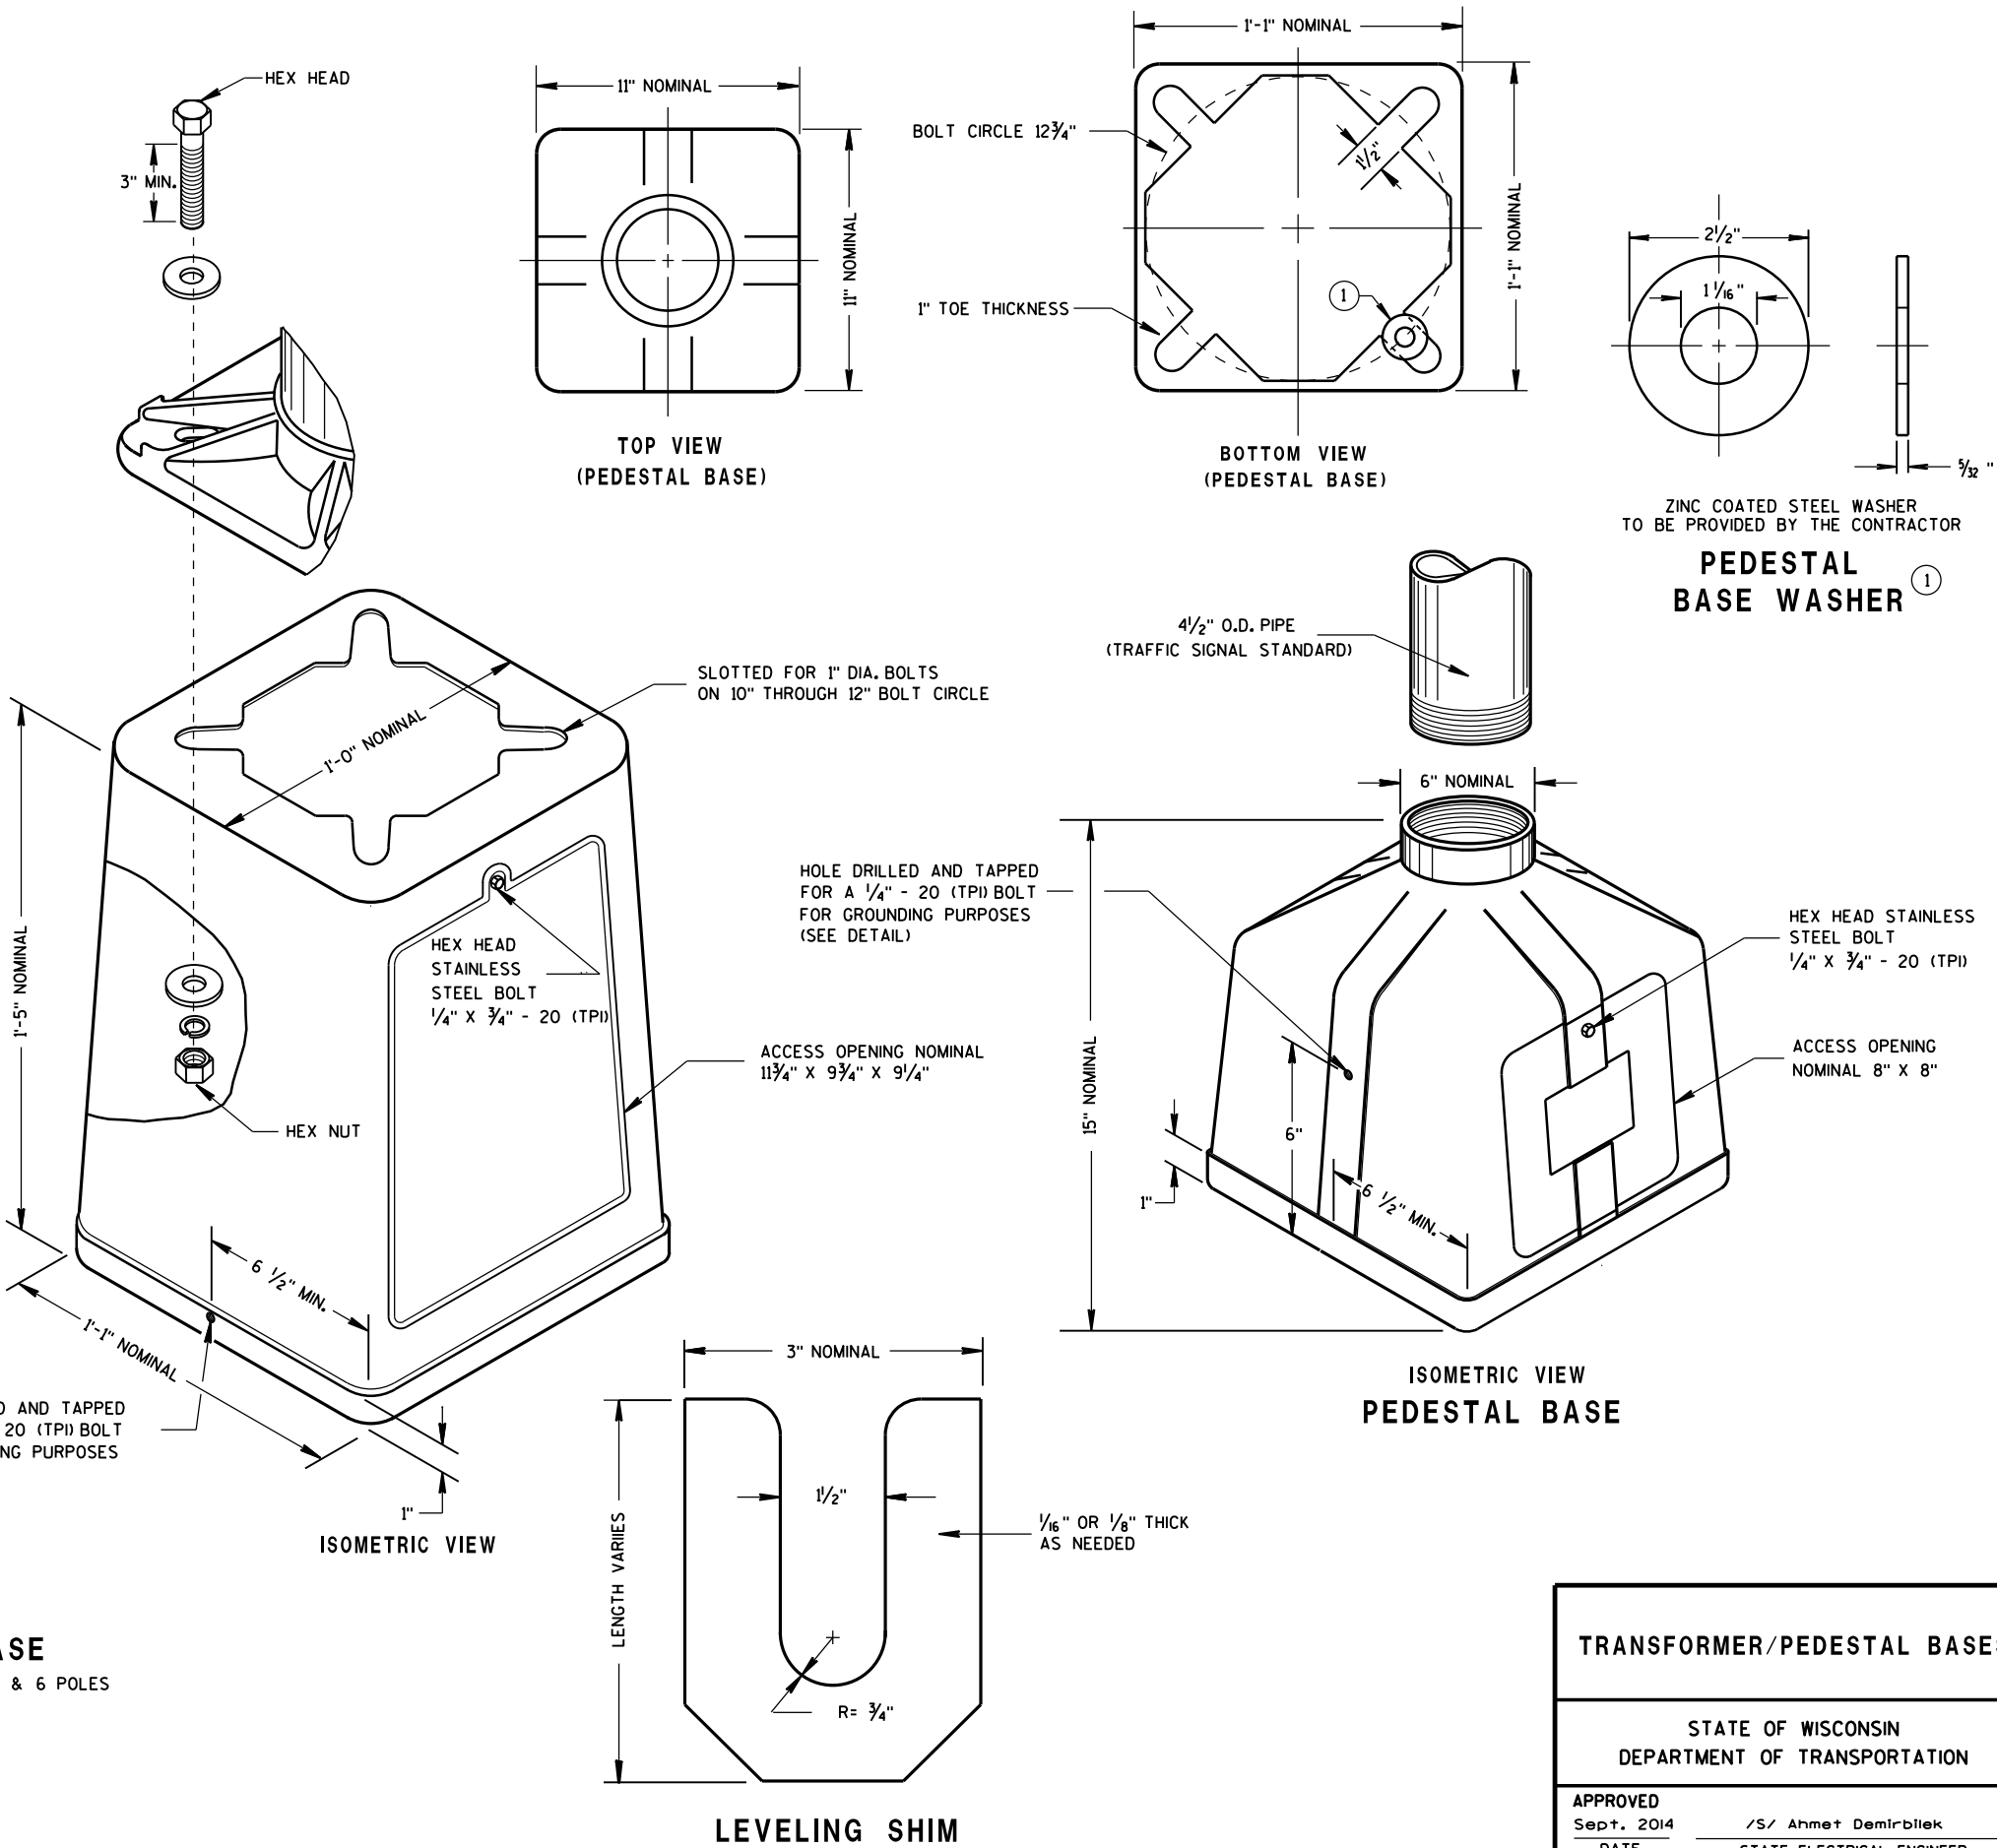

6

6


S.D.D. 9 C 3-4

S.D.D. 9 C 3-4

TRANSFORMER/PEDESTAL BASES


STATE OF WISCONSIN
DEPARTMENT OF TRANSPORTATION

APPROVED
Sept. 2014
DATE
FWHA
/S/ Ahmet Demirbilek
STATE ELECTRICAL ENGINEER

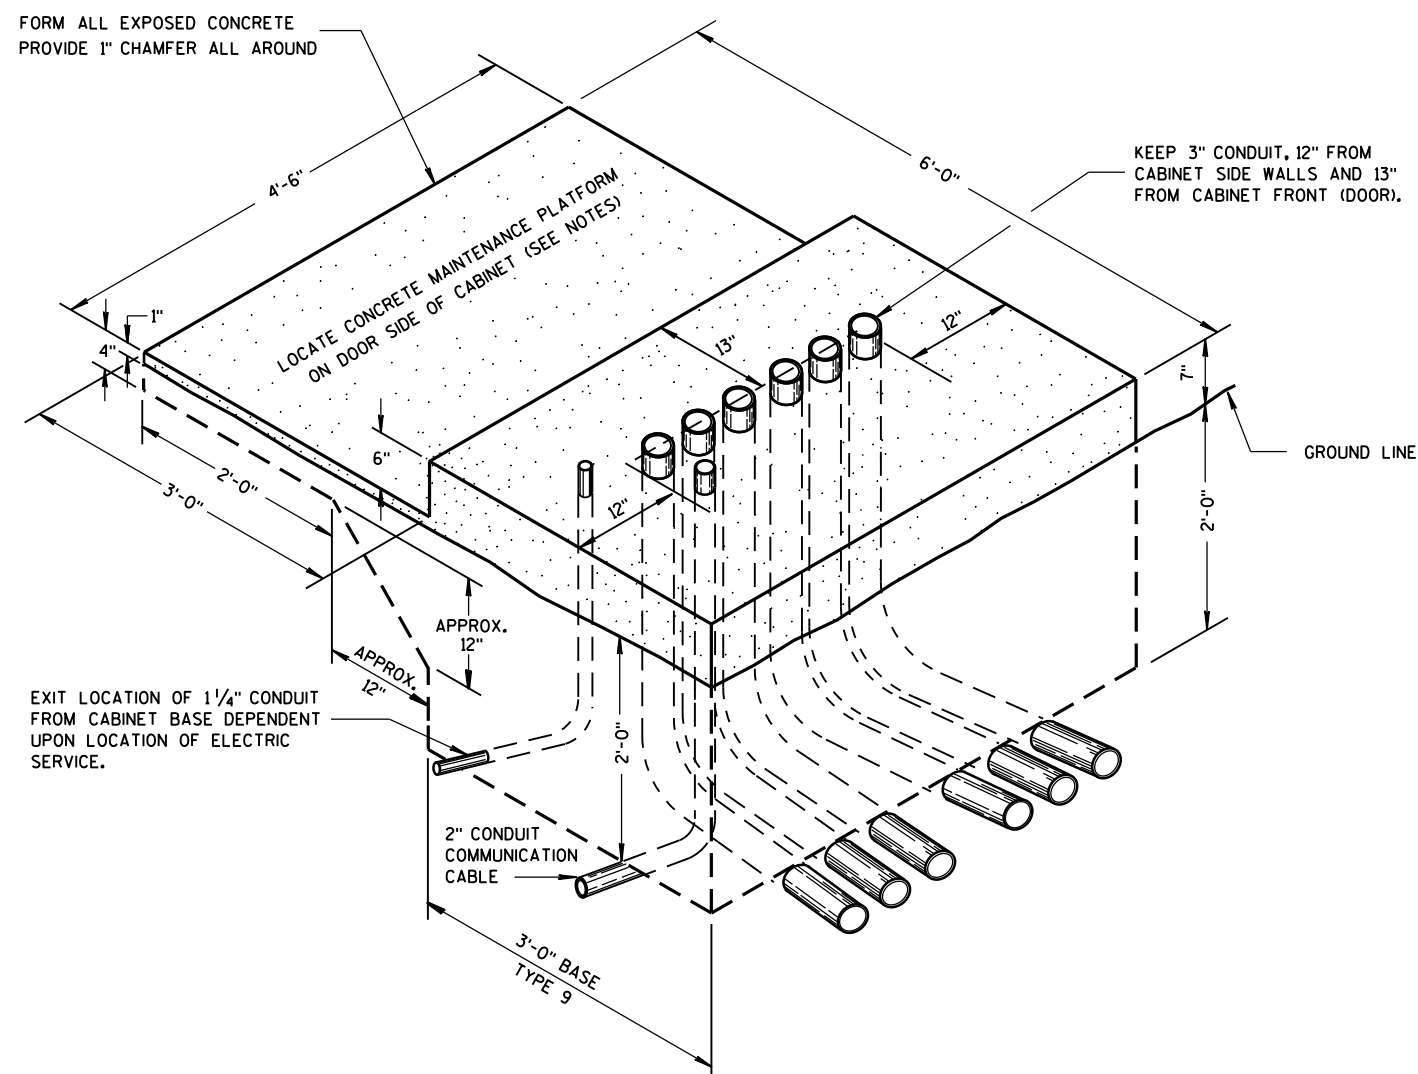

**ISOMETRIC VIEW
TYPE 9, SPECIAL**

(C.Y. CONCRETE = APPROX. 1.56)

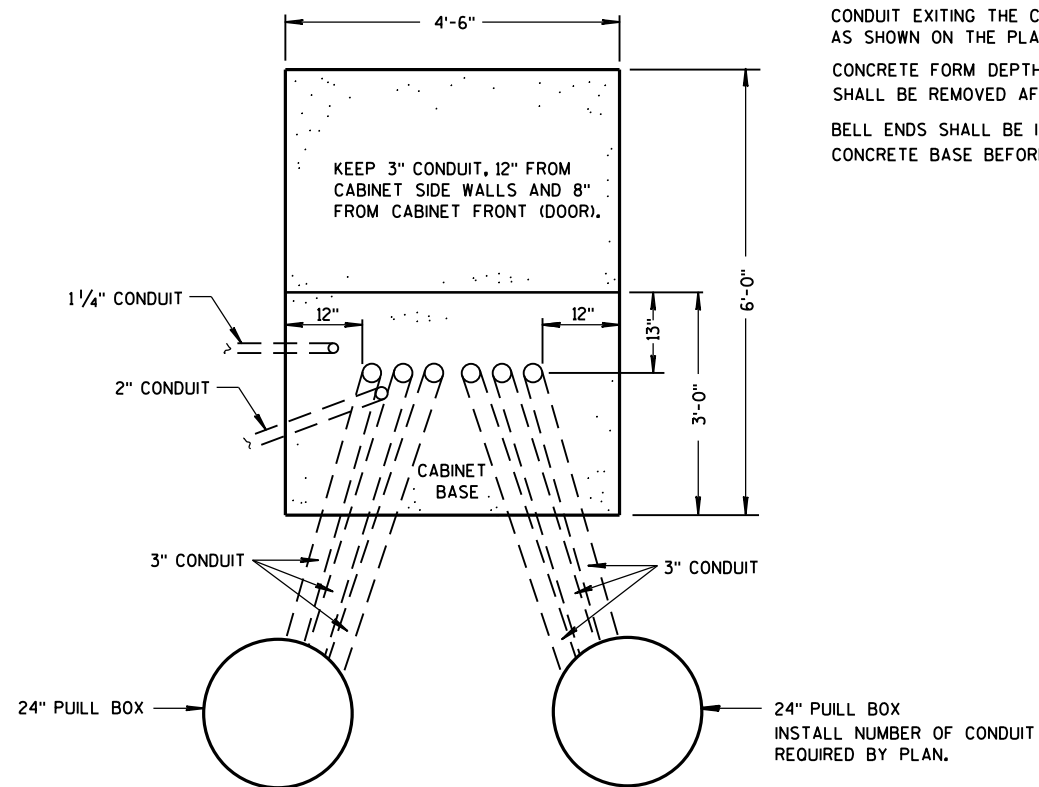

PLAN VIEW

CONCRETE CONTROL CABINET BASE, TYPE 9, SPECIAL

GENERAL NOTES

DETAILS OF CONSTRUCTION, MATERIALS AND WORKMANSHIP NOT SHOWN ON THIS DRAWING SHALL CONFORM TO THE PERTINENT REQUIREMENTS OF THE CONTRACT.

INSTALL FOUR 1/2 INCH MINIMUM DIAMETER X 4 INCH MINIMUM LENGTH STAINLESS STEEL APPROVED CONCRETE MASONRY ANCHORS WITH A PULLOUT STRENGTH OF 9,000 LBS. TO ANCHOR THE CABINET TO TYPE 6, 7, 8, AND 9 BASES. THE ANCHOR STUDS SHALL BE LOCATED AS DIRECTED BY THE ENGINEER TO PROPERLY ANCHOR THE CONTROL CABINET TO THE BASE.

WHEN REQUIRED TO CONNECT NONMETALLIC CONDUIT TO METALLIC CONDUIT, ONLY ADAPTER FITTINGS, U.L. LISTED FOR ELECTRICAL USE, SHALL BE USED.

CONDUIT HEIGHT ABOVE THE CONCRETE BASE SHALL BE 1 INCH.

DEPTH OF CONDUIT INSTALLED BELOW THE TRAVELED WAY SHALL BE 24 INCHES MINIMUM AND 36 INCHES MAXIMUM.

DEPTH OF CONDUIT INSTALLED THAT IS NOT BELOW THE TRAVELED WAY SHALL BE 18 INCHES MINIMUM AND 36 INCHES MAXIMUM.

ANY EXCEPTION TO THE MAXIMUM DEPTH SHALL BE ONLY WITH THE WRITTEN APPROVAL OF THE ENGINEER.

CONTROL CABINET BASE TOP SURFACE SHALL BE TROWEL FINISHED SMOOTH AND LEVEL.

MAINTENANCE PLATFORM SHALL BE FLOAT OR BROOM FINISHED AND BE LEVEL.

MAINTENANCE PLATFORMS ARE NOT REQUIRED WHEN THE SURROUNDING AREA IS PAVED.

MINIMUM BENDING RADIUS OF CONDUIT = 6 X THE DIAMETER.

ALL METALLIC CONDUIT ENDS SHALL BE REAMED AND THREADED.

CAP ALL BELOW GRADE METALLIC CONDUIT ENDS IN WHICH WIRE OR CABLE IS NOT BEING INSTALLED.

PLUG ALL BELOW GRADE NONMETALLIC CONDUIT ENDS IN WHICH WIRE OR CABLE IS NOT BEING INSTALLED.

ALL CONDUIT ENDS AT THE TOP OF CONCRETE BASES SHALL BE CAPPED IF METALLIC OR PLUGGED IF NONMETALLIC IMMEDIATELY AFTER PLACEMENT AND BEFORE CONCRETE IS POURED. CONDUITS IN WHICH WIRE OR CABLE IS NOT BEING INSTALLED SHALL REMAIN CAPPED OR PLUGGED.

CONDUIT EXITING THE CONCRETE BASE (SIX THREE INCH) SHALL TERMINATE IN PULL BOXES AS SHOWN ON THE PLANS.

CONCRETE FORM DEPTH BELOW FINISHED GRADE SHALL BE 6" MAXIMUM. CONCRETE FORMS SHALL BE REMOVED AFTER CONCRETE HAS SET.


BELL ENDS SHALL BE INSTALLED ON ALL PVC CONDUIT EXPOSED AT THE TOP OF THE CONCRETE BASE BEFORE INSTALLATION OF CABLE OR WIRE.

**CONCRETE CONTROL CABINET
BASE, TYPE 9, SPECIAL**

STATE OF WISCONSIN
DEPARTMENT OF TRANSPORTATION

APPROVED
Sept. 2014
DATE
FHWA

/S/ Ahmet Demirbilek
STATE ELECTRICAL ENGINEER

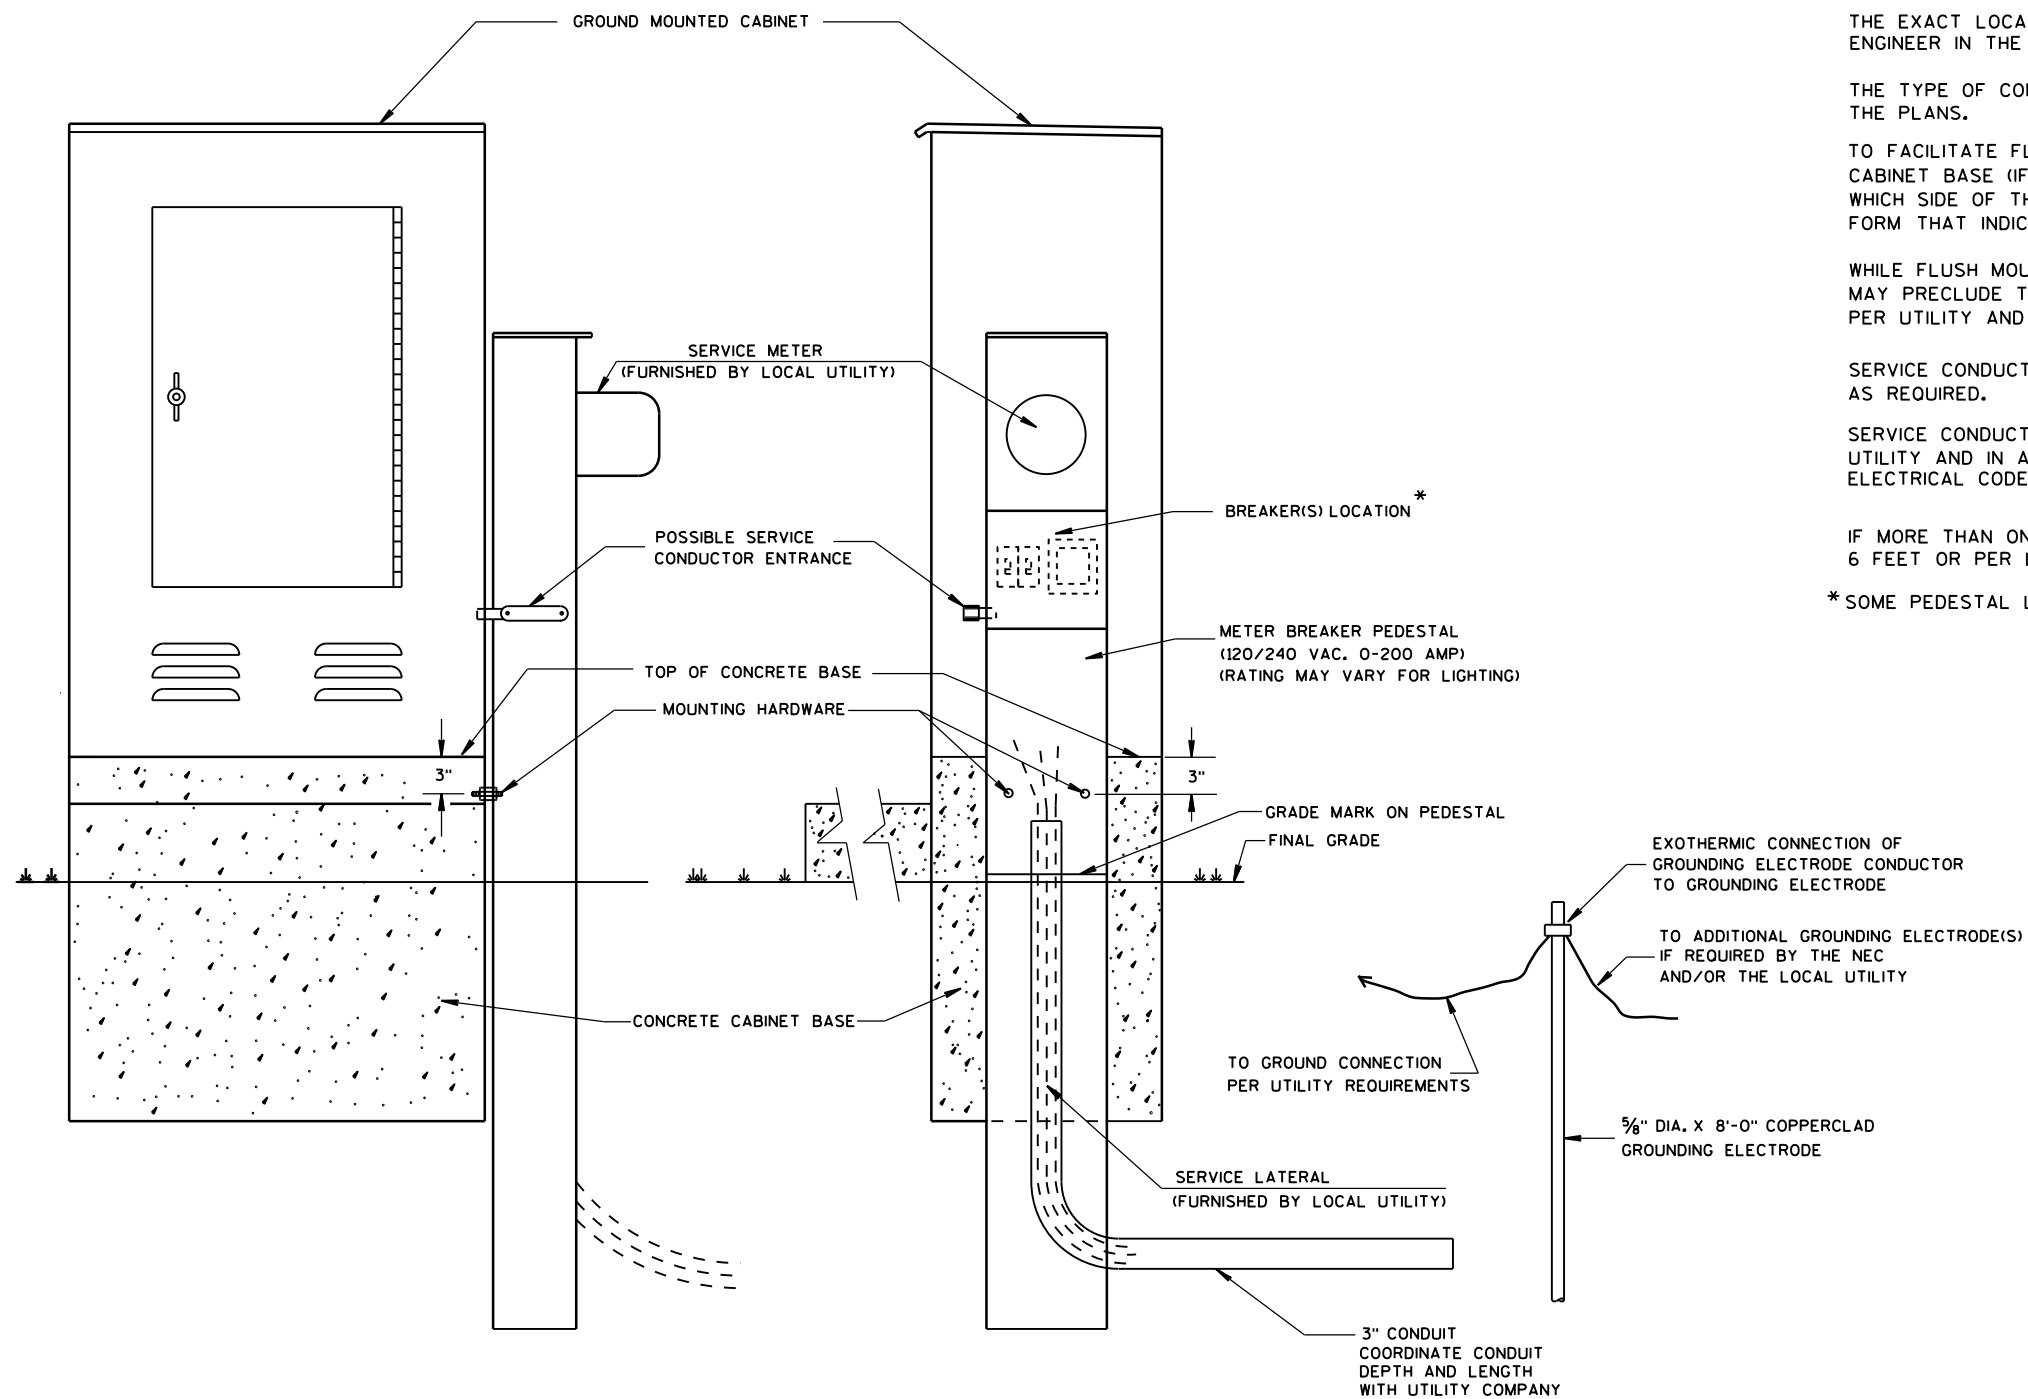

TYPICAL CABINET SERVICE INSTALLATION

GENERAL NOTES

DETAILS OF CONSTRUCTION, MATERIALS AND WORKMANSHIP NOT SHOWN ON THIS DRAWING SHALL CONFORM TO THE PERTINENT REQUIREMENTS OF THE CONTRACT.

THE EXACT LOCATION OF THE METER BREAKER PEDESTAL SHALL BE DETERMINED BY THE ENGINEER IN THE FIELD.

THE TYPE OF CONCRETE CABINET BASE TO BE INSTALLED SHALL BE AS CALLED FOR IN THE PLANS.

TO FACILITATE FLUSH MOUNTING OF THE METER BREAKER PEDESTAL AGAINST THE SIDE OF THE CABINET BASE (IF FLUSH MOUNTING POSSIBLE, CONFER WITH THE LOCAL UTILITY TO DETERMINE WHICH SIDE OF THE CONCRETE BASE THE ELECTRICAL SERVICE LATERAL WILL APPROACH, THEN FORM THAT INDICATED SIDE FOR FULL SIDE DEPTH.

WHILE FLUSH MOUNTING IS THE MOST DESIRABLE MOUNTING CONFIGURATION UTILITY REQUIREMENTS MAY PRECLUDE THIS OPTION. CONTRACTOR MUST PROVIDE UTILITY APPROVED PEDESTAL AND INSTALL PER UTILITY AND MANUFACTURERS REQUIREMENTS.

SERVICE CONDUCTOR ENTRANCES SHALL BE RIGID METALLIC CONDUIT, NIPPLES AND/OR CONDULETS AS REQUIRED.

SERVICE CONDUCTOR ENTRANCES SHALL BE SIZED AND LOCATED AS REQUIRED BY THE LOCAL UTILITY AND IN ACCORDANCE WITH APPROPRIATE ARTICLES OF THE LATEST ACCEPTED NATIONAL ELECTRICAL CODE.

IF MORE THAN ONE GROUNDING ELECTRODE IS REQUIRED, THE DISTANCE APART SHALL BE 6 FEET OR PER LOCAL UTILITY REGULATIONS.

* SOME PEDESTAL LIGHTING PLANS SHOW MAIN LUGS ONLY.

CABINET SERVICE INSTALLATION
(METER BREAKER PEDESTAL)


STATE OF WISCONSIN
DEPARTMENT OF TRANSPORTATION

APPROVED
Sept. 2014
DATE


/S/ Ahmet Demirbilek
STATE ELECTRICAL ENGINEER

FHWA


6

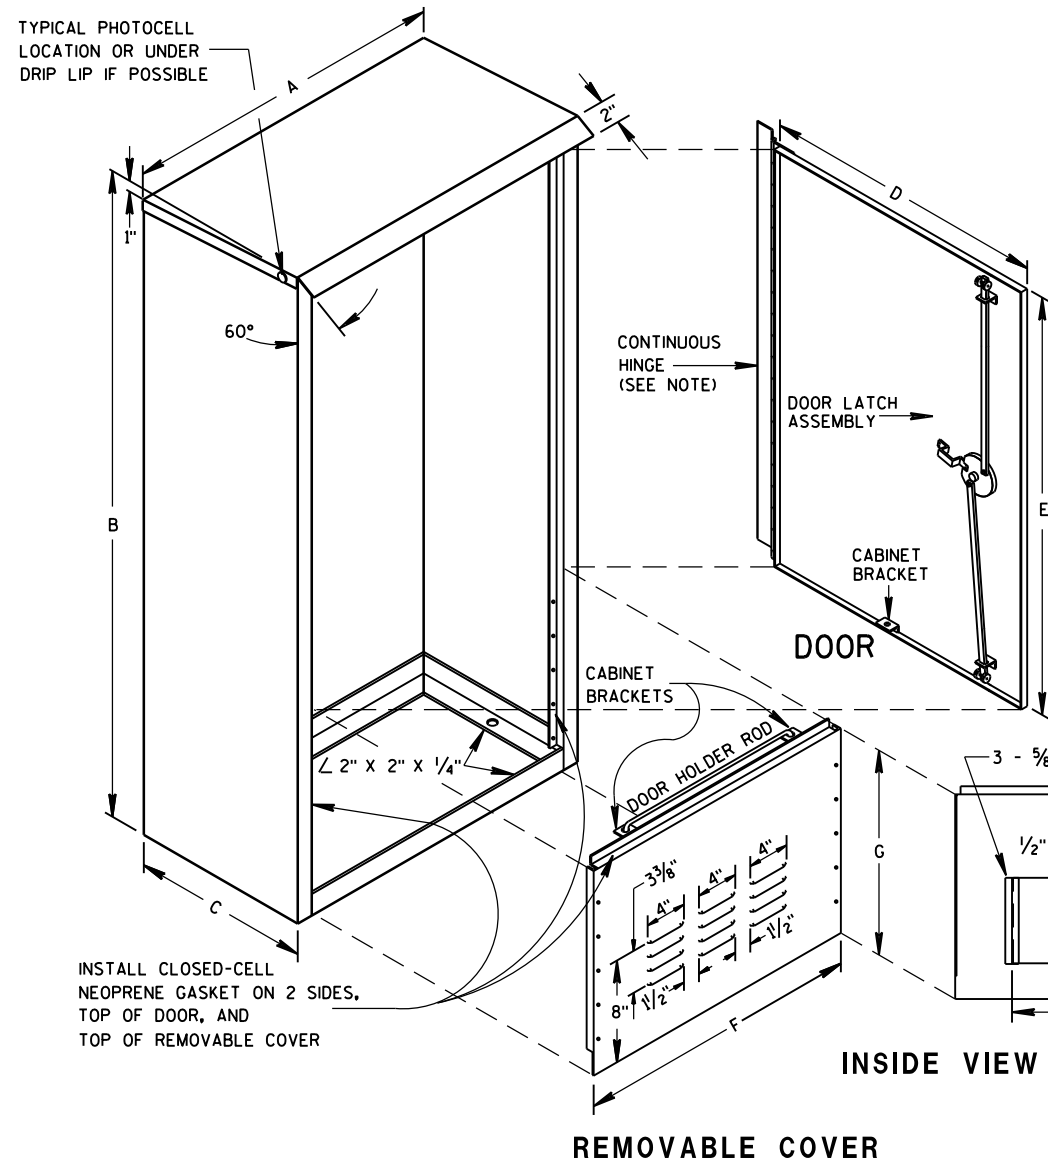


INSTALL CLOSED-CELL NEOPRENE GASKET ON 2 SIDES, TOP OF DOOR, AND TOP OF REMOVABLE COVER

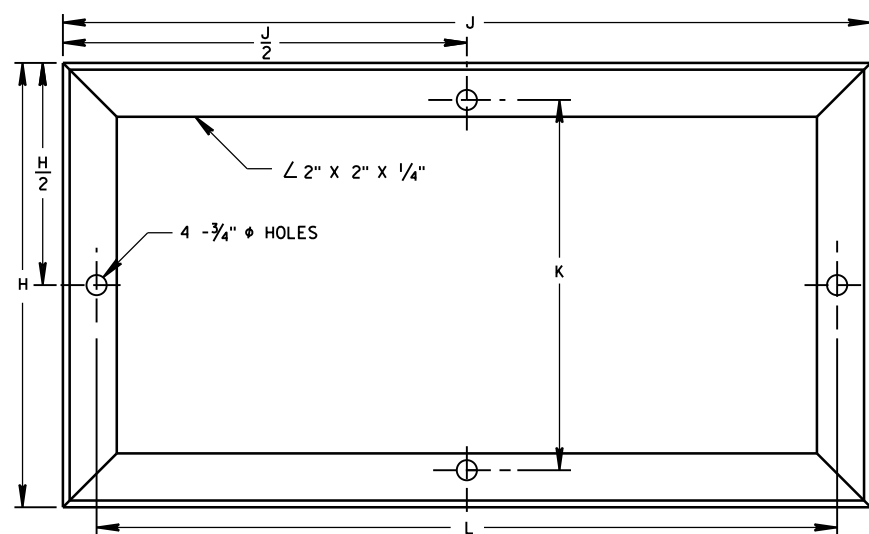


MOUNTING BASE

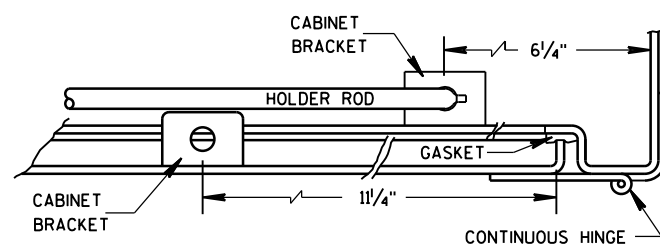


HINGE & DOOR HOLDER

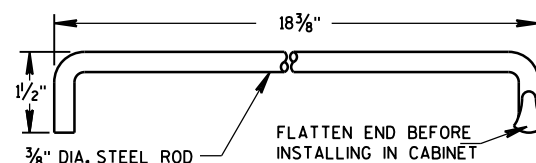

HOLDER ROD

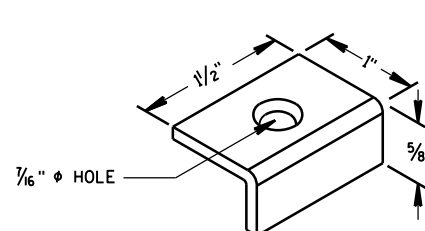


CABINET BRACKET

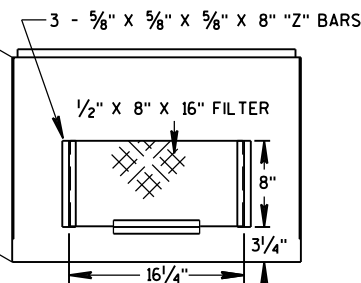


INSIDE VIEW SHOWING FILTER

TABLE OF DIMENSIONS (INCHES)

MARK	CABINET TYPE		
	3060	3860	3866
A	30	38	38
B	60	60	66
C	16 1/2	16 1/2	24
D	26 1/2	34 3/4	33 3/4
E	38 3/4	38 3/4	38 3/4
F	26 1/2	34 3/4	33 3/4
G	19	19	25
H	16 1/2	16 1/2	24
H/2	8 1/4	8 1/4	12
J	30	38	38
J/2	15	19	19
K	13 3/4	13 3/4	21 1/4
L	27 1/2	35 1/2	35 1/2

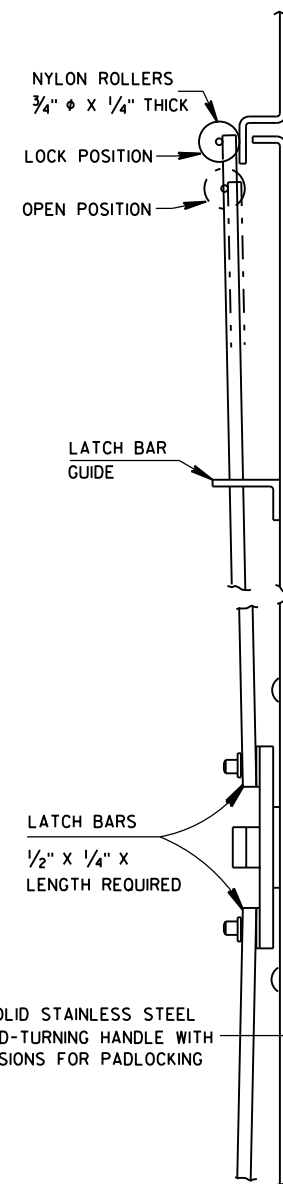


SIDE VIEW

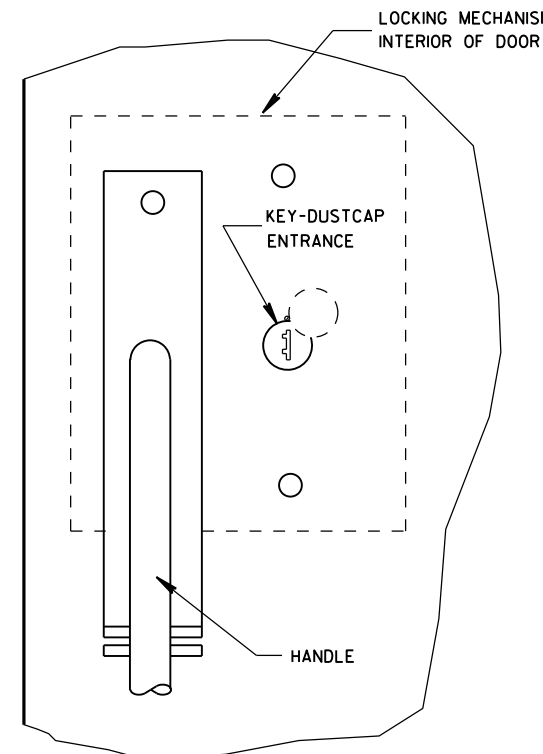

FRONT VIEW

LATCH ASSEMBLY

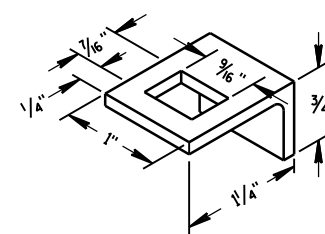

LATCH BAR GUIDE

GENERAL NOTES

DETAILS OF CONSTRUCTION, MATERIALS AND WORKMANSHIP NOT SHOWN ON THIS DRAWING SHALL CONFORM TO THE PERTINENT REQUIREMENTS OF THE STANDARD SPECIFICATIONS AND APPLICABLE SPECIAL PROVISIONS.

PRIME WITH PHOSPHATE TREATMENT AND PRIMER.

FINISH EXTERIOR SURFACES WITH RUSTOLEUM #906 SILVER GRAY OR APPROVED EQUAL.

FINISH INTERIOR WITH RUSTOLEUM #2766 HIGH GLOSS WHITE ENAMEL OR APPROVED EQUAL.

ALL SHEET METAL PARTS SHALL BE .125 INCH THICK ALUMINUM.

ALL SEAMS SHALL BE CONTINUOUSLY WELDED.

ALUMINUM SHALL BE TYPE 5052-H32.

CONTINUOUS HINGE SHALL BE HEAVY GAUGE ALUMINUM WITH 1/4" DIAMETER STAINLESS STEEL HINGE PIN. HINGE IS SECURED WITH 1/4" X 20 TPI STAINLESS STEEL CARRIAGE BOLTS AND STAINLESS STEEL NYLOCK NUTS.

A SINGLE PHOTOCELL SHALL BE LOCATED ON THE NORTH-NORTHEAST SIDE OF THE CABINET UNLESS OTHERWISE CALLED FOR IN THE SPECIAL PROVISIONS. THE PHOTOCELL SHALL BE PLACED AS SHOWN AND SHALL BE LISTED ON THE DEPARTMENTS APPROVED PRODUCTS LIST.

DOOR LATCH ASSEMBLY TO BE PROVIDED WITH THREE-POINT LOCKING MECHANISM.

SIGNAL
CONTROL CABINET

STATE OF WISCONSIN
DEPARTMENT OF TRANSPORTATION

APPROVED
Sept. 2014
DATE
FHWA

/S/ Ahmet Demirbilek
STATE ELECTRICAL ENGINEER

S.D.D. 9 D 2-3

S.D.D. 9 D 2-3

6

S.D.D. 9 D 4-2


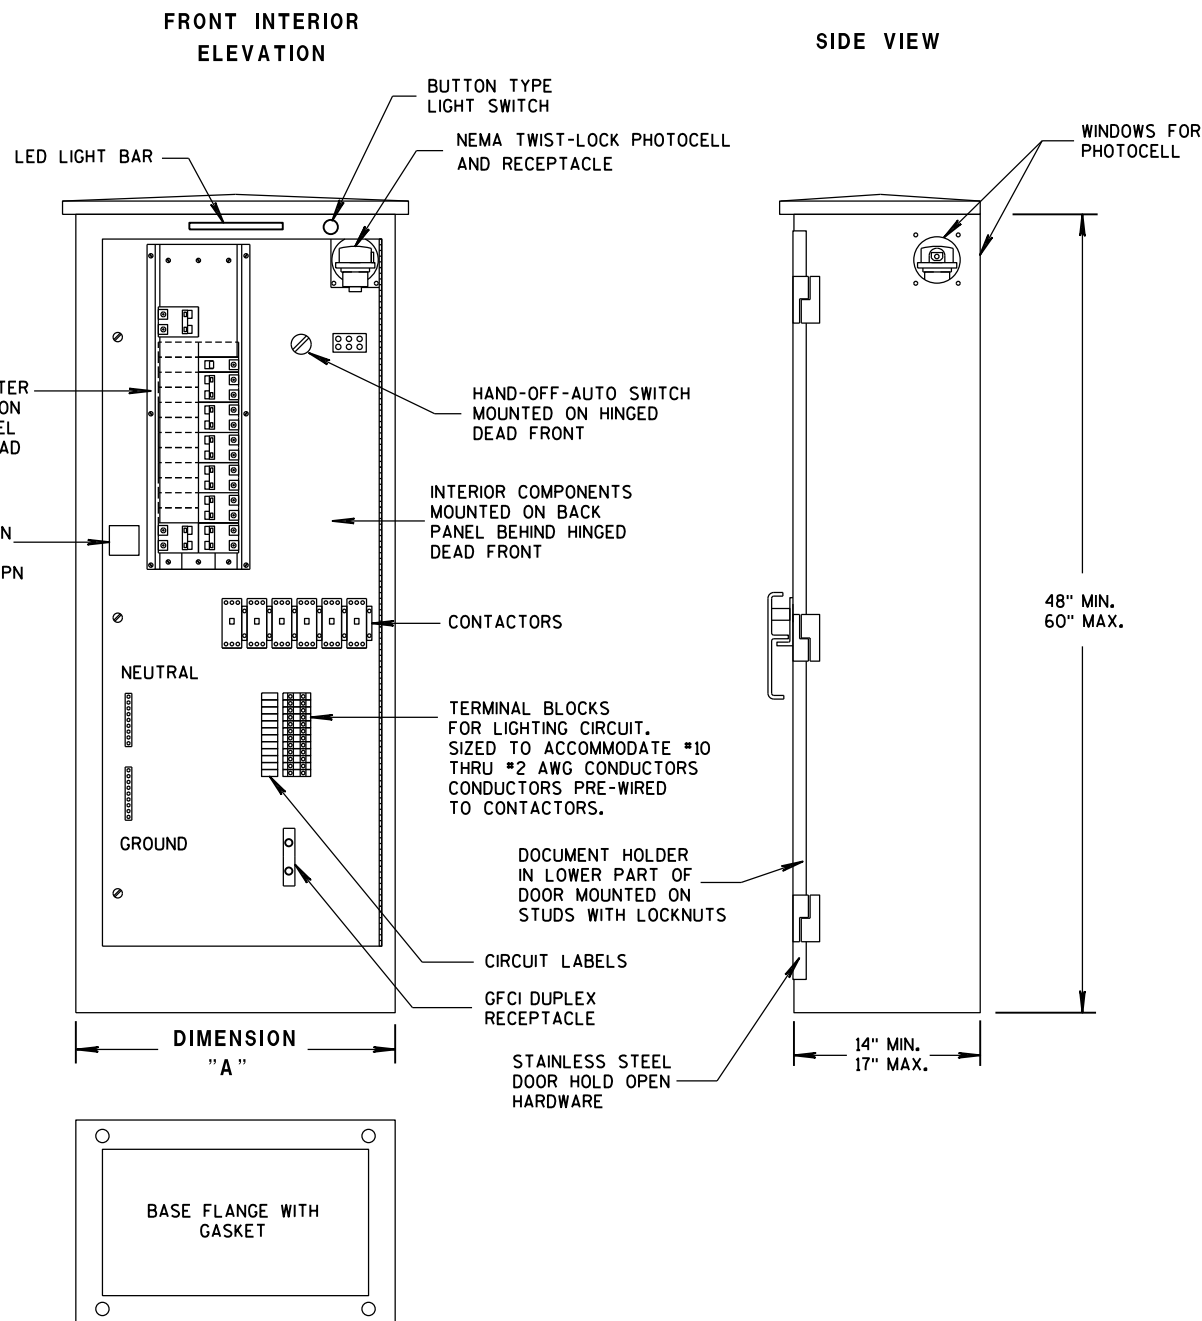


TABLE OF DIMENSIONS (INCHES)		
CONCRETE BASE TYPE	CABINET WIDTH	DIMENSION "A"
L24	24"	24"
L30	30"	30"

LIGHTING CONTROL CABINET

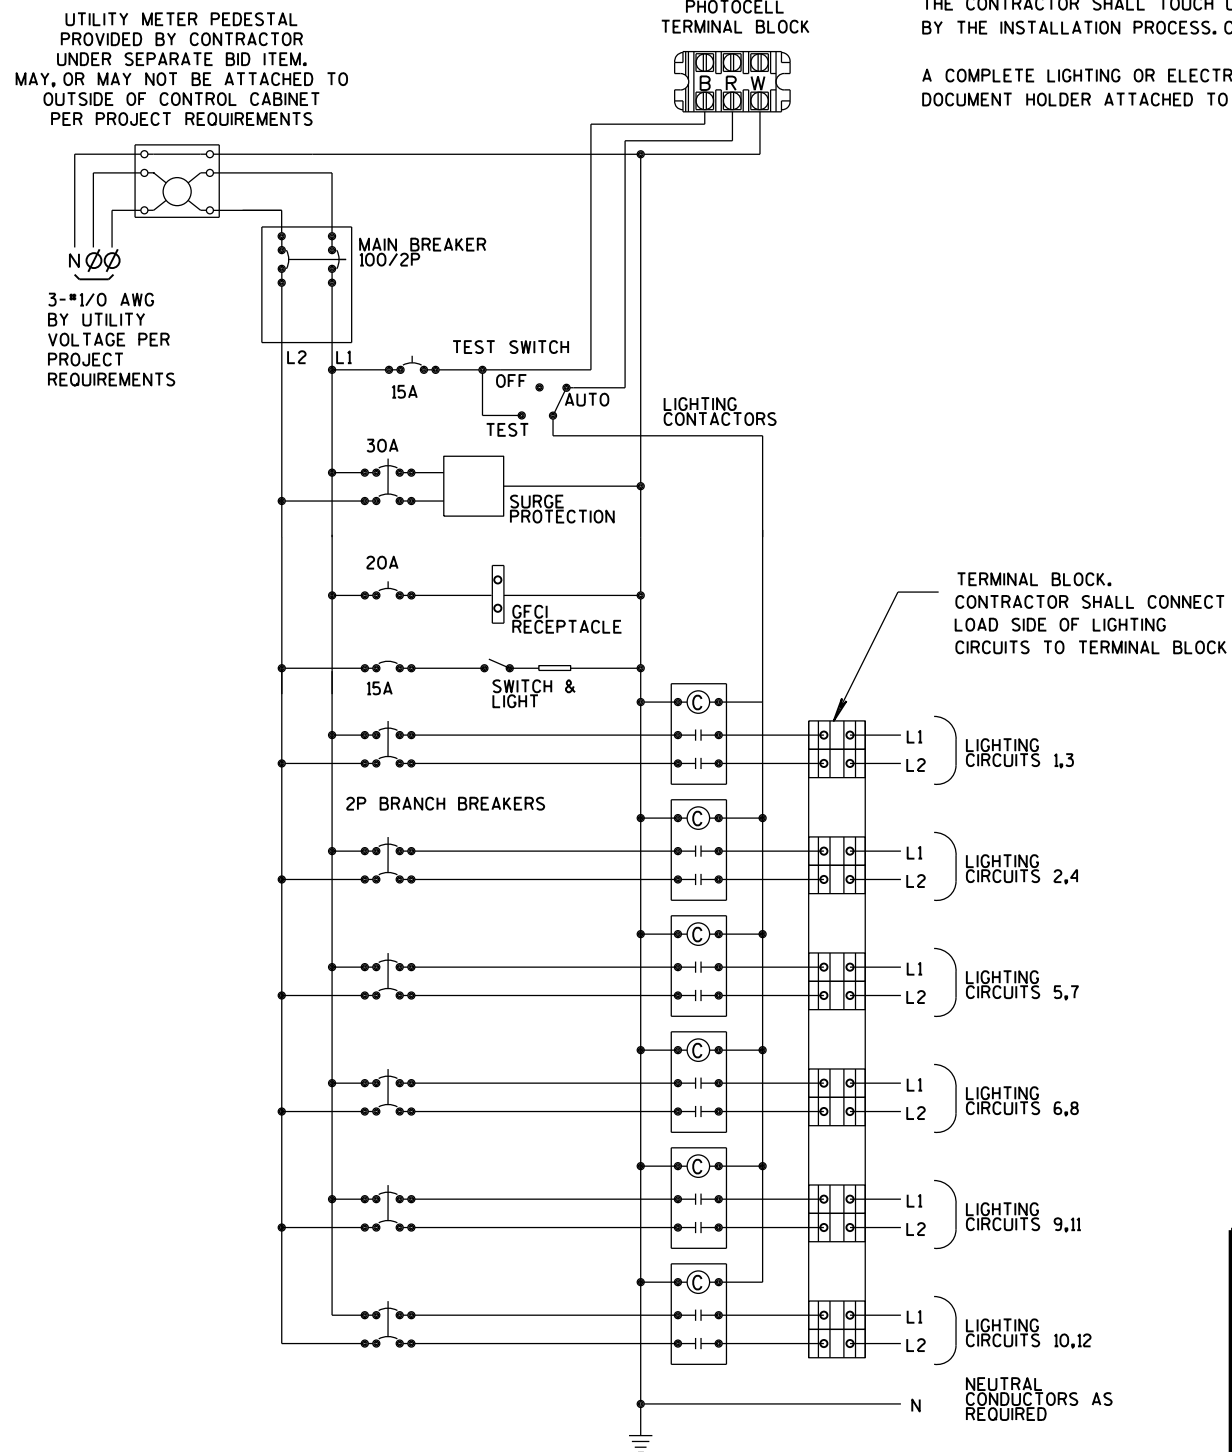

CONTROL CABINET SCHEMATIC

GENERAL NOTES

DETAILS OF CONSTRUCTION, MATERIALS AND WORKMANSHIP NOT SHOWN ON THIS DRAWING SHALL CONFORM TO THE PERTINENT REQUIREMENTS OF THE STANDARD SPECIFICATIONS AND APPLICABLE SPECIAL PROVISIONS.

ALL INTERNAL ELECTRICAL COMPONENTS WILL BE PRE-WIRED BY THE CABINET FABRICATOR.

ALL CONDUIT ENTRIES SHALL BE SEALED WITH AN APPROPRIATE DUCT SEALING COMPOUND.

ORIENT PHOTOCELL AWAY FROM AMBIENT LIGHT SOURCES AND ONCOMING TRAFFIC HEADLIGHTS.

THE CONTRACTOR SHALL TOUCH UP ANY DAMAGE TO THE ANODIZED FINISH CAUSED BY THE INSTALLATION PROCESS. COLOR MATCH PAINT SHALL BE USED.

A COMPLETE LIGHTING OR ELECTRICAL PLAN SHALL BE SECURELY PLACED IN THE DOCUMENT HOLDER ATTACHED TO THE DOOR.

6

S.D.D. 9 D 4-2


LIGHTING CONTROL CABINET 120/240 VOLT	
STATE OF WISCONSIN DEPARTMENT OF TRANSPORTATION	
APPROVED DATE FWHA	/S/ Thomas Gorring STATE LIGHTING ENGINEER FOR HWYS.

FOR MANUFACTURERS USE ONLY


WELD TO BE 100% R.T. OR U.T. TESTED AS PER THE REQUIREMENTS OF AWS D 1.5-88. RECORDS OF COMPLIANCE OF SUCH TESTING SHALL BE FURNISHED TO THE OFFICE OF DESIGN/BRIDGE FOR VERIFICATION AND APPROVAL.

* RISE FOR 4' ARM SHALL BE 2'-0".


POLE SPLICE DETAIL

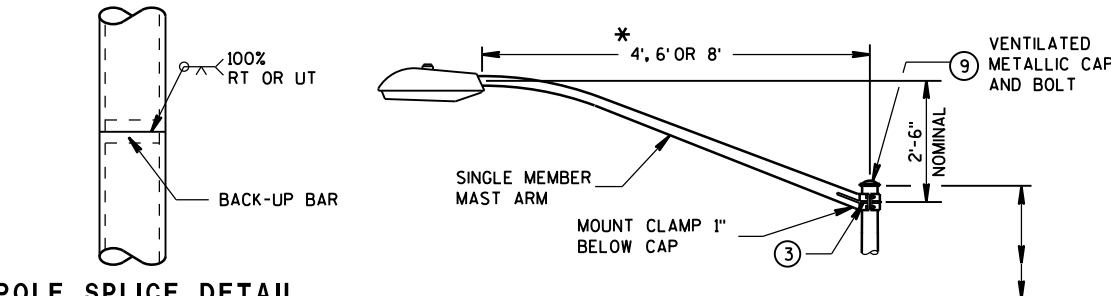


INTERCHANGEABLE MOUNTING DETAIL

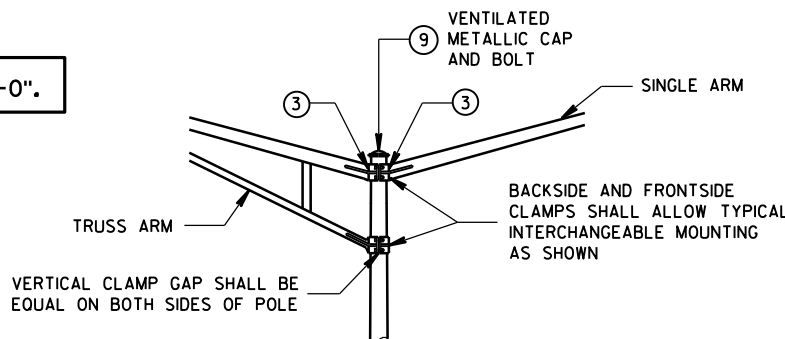


LUMINAIRE
WT. - 50 LBS.
EFFECTIVE PROJECTED
AREA FOR WIND
LOADING = 1.5 SQ. FT.

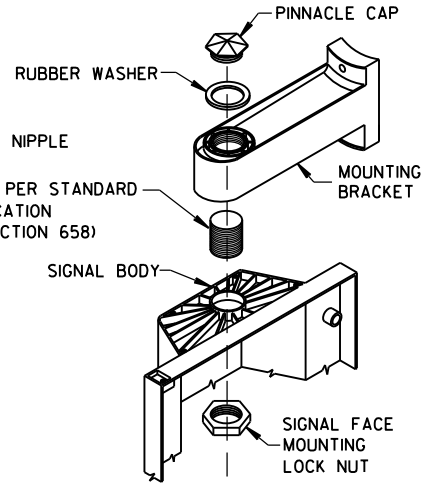

SIGNAL FACE MOUNTING DETAIL (BANDED)

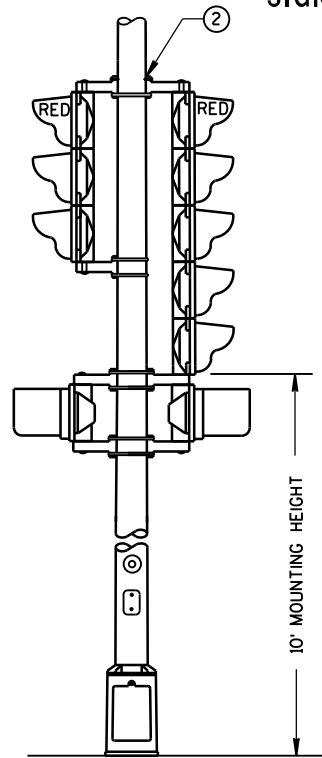

TYPICAL MOUNTING OF BACK TO BACK
3 AND 5 SECTION SIGNAL FACES

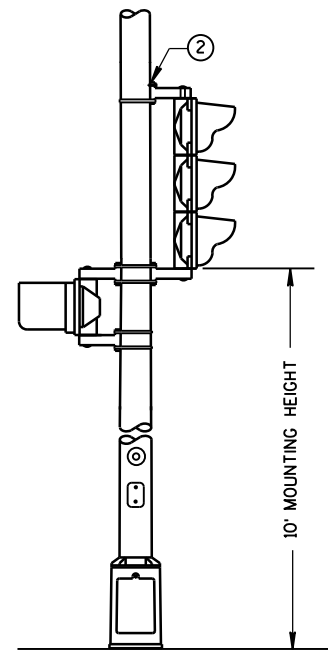

TYPICAL MOUNTING OF 3 SECTION
SIGNAL FACE

TYPE 3 POLE MOUNTING CONFIGURATION

GENERAL NOTES

DETAILS OF CONSTRUCTION, MATERIALS AND WORKMANSHIP NOT SHOWN ON THIS DRAWING SHALL CONFORM TO THE PERTINENT REQUIREMENTS OF THE CONTRACT.

ALL TYPE 3 POLE MOUNTINGS SHALL BE DESIGNED TO INCLUDE TWIN 15' ARMS WITH LUMINAIRES.

POLES SHALL BE GALVANIZED STEEL.


SECTION 657, POLES, OF THE STANDARD SPECIFICATIONS SHALL APPLY TO THIS DRAWING.

A PULL WIRE/ROPE IN ACCORDANCE WITH STANDARD SPECIFICATION 652, SHALL BE INSTALLED IN EACH TROMBONE ARM RACEWAY DURING THE MANUFACTURING PROCESS.

THE SLIPFITTER END OF THE LUMINAIRE MAST ARM SHALL BE A NOMINAL 2 3/8" INCHES IN OUTSIDE DIAMETER. THE STRAIGHT PORTION OF THE SLIPFITTER END OF THE LUMINAIRE MAST ARM SHALL BE A NOMINAL 12 INCHES IN LENGTH.

WHEN TRANSFORMER BASES ARE USED, WIRE CONNECTIONS SHALL BE MADE IN THE TRANSFORMER BASE.

- ① 4" X 6" REINFORCED HANDHOLE & COVER ASSEMBLY WITH 2 (TWO) 1/4" X 3/4" - 20 TPI HEX HEAD STAINLESS STEEL BOLTS.
- ② SIGNAL FACE MOUNTING BRACKETS, MOUNT WITH CAP SCREWS AND BANDING. (SEE STANDARD SPECIFICATIONS - SEC. 658)
- ③ GROMMETS, 1" CHASE NIPPLES OR 1" CLOSE CONDUIT NIPPLES WITH BUSHINGS SHALL BE PROVIDED FOR 1 3/8" HOLE IN POLE SHAFT FOR WIRING.
- ④ SECURELY MOUNT DULL BLACK POLYCARBONATE BACKPLATES, PROJECTING 5" BEYOND ALL SIDES OF THE SIGNAL FACE HOUSING, PER MANUFACTURER'S RECOMMENDATIONS.
- ⑤ POLE MOUNTED SIGNAL FACES SHALL REQUIRE 1 OR MORE MOUNTING SPACERS UNDER THE TOP MOUNTING BRACKET(S) AS REQUIRED, TO PLUMB THE SIGNAL FACE.
- ⑥ TYPE 3 POLE CONFIGURATIONS SHALL BE MOUNTED DIRECTLY TO THEIR CONCRETE BASES.
- ⑦ MOUNTING BRACKET NIPPLES FOR THE SIGNAL FACE(S) SHALL BE 2 INCHES IN LENGTH AND 1 1/2 INCHES IN DIAMETER. (SEE STANDARD SPECIFICATION - SECTION 658)
- ⑧ VERTICAL STRUT (ADJUSTABLE). ONE (1) SET SCREW (1/4" X 3/4" - 20 TPI, STAINLESS STEEL, HEX HEAD) INTO EACH ARM MEMBER IF STRUT IS THE SLIDING TYPE.
- ⑨ FURNISH AND INSTALL VENTILATED, CAST, METALLIC (ALUMINUM ALLOY) CAPS. FASTEN CAPS WITH ONE (1) 1/4" X 3/4" - 20 TPI STAINLESS STEEL, HEX HEAD BOLT.
- ⑩ SHIMMING, IF NEEDED, SHALL BE LOCATED BETWEEN THE CONCRETE FOUNDATION AND POLE.
- ⑪ USE SERRATED LOCK WASHERS WITH NOTCHES BETWEEN END TEE AND SIGNAL HEAD.

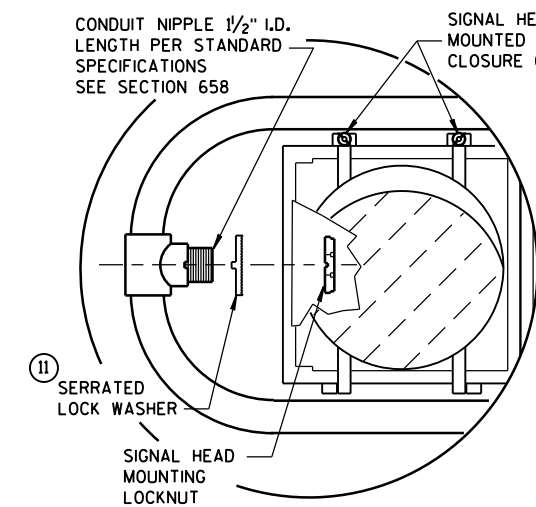

HORIZONTAL SIGNAL HEAD MOUNTING DETAIL **

** SIGNAL HEAD ATTACHMENT ALSO APPLYS TO MOUNTING AT CROSS BAR

**POLE MOUNTINGS FOR
TRAFFIC SIGNALS AND
LIGHTING UNITS, TYPE 3
(HEAVY DUTY)**

STATE OF WISCONSIN
DEPARTMENT OF TRANSPORTATION



6

6



S.D.D. 9 E 1-14b

S.D.D. 9 E 1-14b

* RISE FOR 4' ARM SHALL BE 2'-0".

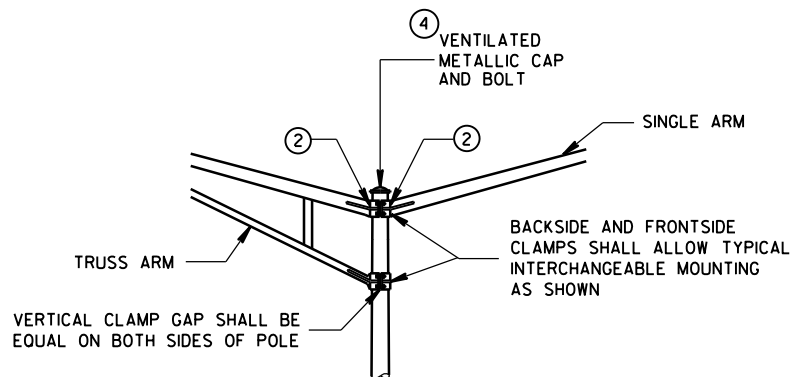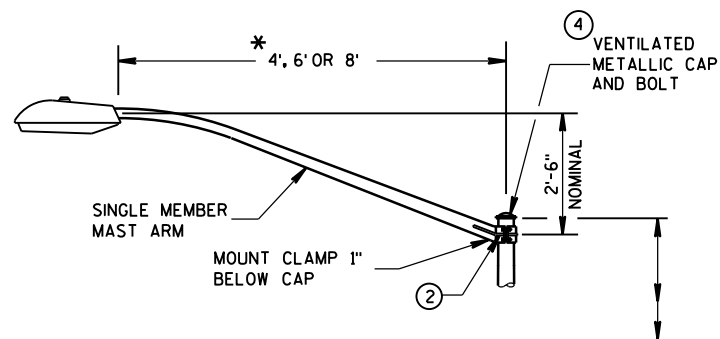

INTERCHANGEABLE MOUNTING DETAIL

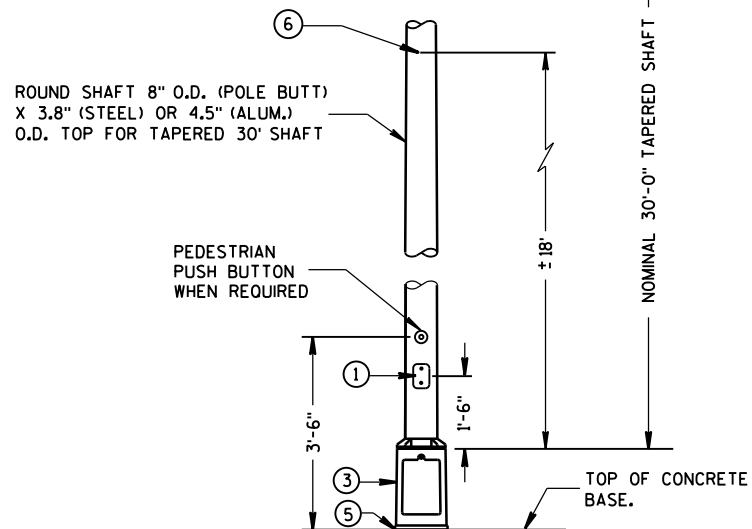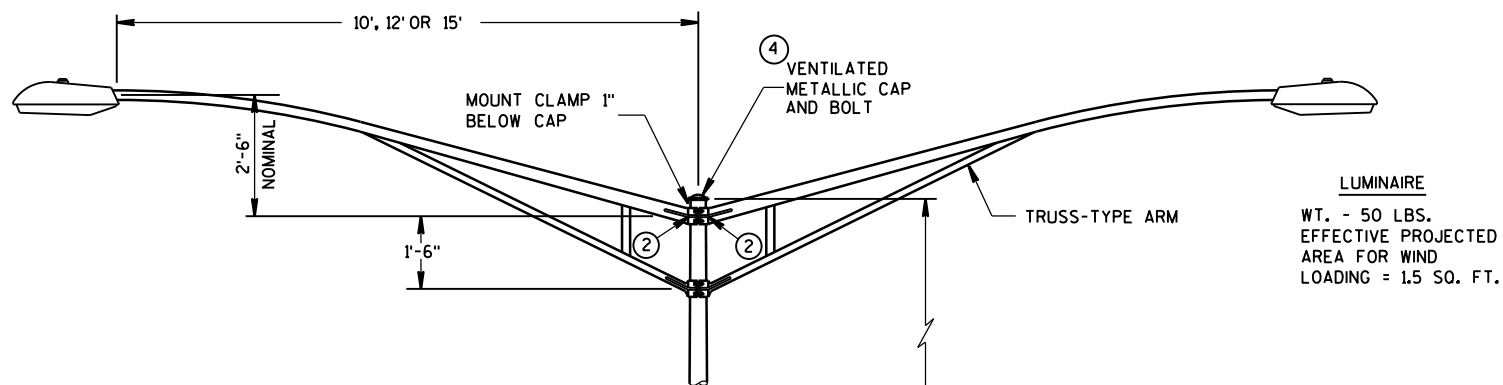

TYPE 5 POLE MOUNTING CONFIGURATION
(MAXIMUM LOAD)
LIGHTING ONLY

GENERAL NOTES

DETAILS OF CONSTRUCTION, MATERIALS AND WORKMANSHIP NOT SHOWN ON THIS DRAWING SHALL CONFORM TO THE PERTINENT REQUIREMENTS OF THE CONTRACT.
ALL TYPE 5 POLE MOUNTINGS SHALL BE DESIGNED TO INCLUDE TWIN 15' ARMS WITH LUMINAIRES.

POLES SHALL BE GALVANIZED STEEL OR ALUMINUM, AS CALLED FOR IN THE CONTRACT.

TYPE 5 ALUMINUM POLES SHALL BE CONSTRUCTED OF 6063-T6 ALUMINUM ALLOY. SLEEVING INSIDE THE POLE IS NOT ACCEPTABLE.

THE TYPE 5 ALUMINUM POLES SHALL HAVE A MINIMUM WALL THICKNESS OF 0.188".

TYPE 5 STEEL POLES SHALL HAVE A MINIMUM WALL THICKNESS OF U.S. STANDARD 11 GAGE (.1196").


THE SLIPFITTER END OF THE LUMINAIRE MAST ARM SHALL BE A NOMINAL 2 3/8 INCHES IN OUTSIDE DIAMETER. THE STRAIGHT PORTION OF THE SLIPFITTER END OF THE LUMINAIRE ARM SHALL BE A NOMINAL 12 INCHES IN LENGTH.

WHEN TRANSFORMER BASES ARE USED, WIRE CONECTIONS SHALL BE MADE IN THE TRANSFORMER BASE.


- ① 4" x 6" REINFORCED HANDHOLE & COVER ASSEMBLY WITH 2 (TWO) 1/4" x 3/4" - 20 TPI HEX HEAD STAINLESS STEEL BOLTS.
- ② GROMMETS, 1" CHASE NIPPLES OR 1" CLOSE CONDUIT NIPPLES WITH BUSHINGS SHALL BE PROVIDED FOR 1 3/8" HOLE IN POLE SHAFT FOR WIRING.
- ③ CAST ALUMINUM TRANSFORMER BASE, WHEN REQUIRED.
- ④ FURNISH AND INSTALL VENTILATED, CAST, METALLIC (ALUMINUM ALLOY) CAPS. FASTEN CAPS WITH ONE (1) 1/4" x 3/4" - 20 TPI STAINLESS STEEL, HEX HEAD BOLT.
- ⑤ SHIMMING, IF NEEDED, SHALL BE LOCATED BETWEEN THE CONCRETE FOUNDATION AND THE TRANSFORMER BASE.
- ⑥ INTERNAL DUMBBELL-TYPE VIBRATION DAMPER.

POLE MONTINGS FOR
LIGHTING UNITS, TYPE 5
(30 FEET)


STATE OF WISCONSIN
DEPARTMENT OF TRANSPORTATION

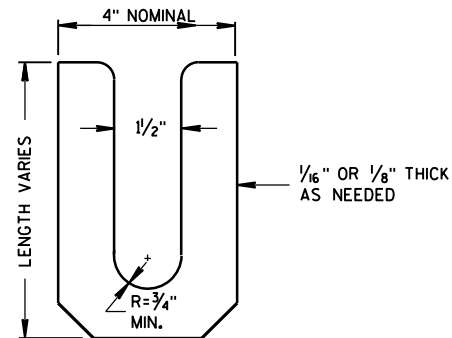

LEVELING SHIM
SHALL BE ALUMINUM

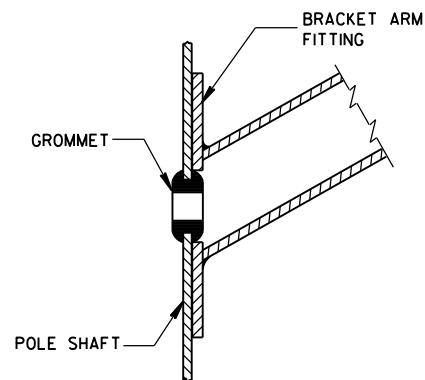

TYPICAL APPLICATION OF GROMMET IN POLE SHAFT

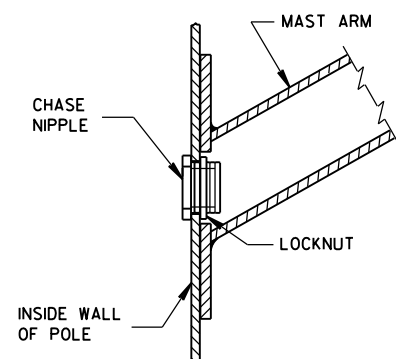


TYPICAL APPLICATION OF CHASE NIPPLE IN POLE SHAFT

GENERAL NOTES


CLAMP BOLT-NUT TIGHTENING TORQUE SHALL BE INDICATED BY INDENT STAMPING (1/2 INCH NUMERALS AND LETTERS) OR WEATHERPROOF PRINTING ON THE INSIDE OF THE CLAMP THAT IS WELDED TO THE ARM MEMBER.

- ⑩ 4.5" I.D. FOR LUMINAIRE MAST ARM CLAMP.
6.625" I.D. FOR TROMBONE MAST ARM CLAMP.
- ⑪ INDIVIDUAL BASE PLATE ANCHOR ROD COVERS. (4 REQUIRED)
- ⑫ BASE PLATE SLOTTED TO ACCEPT 11" THROUGH 12" BOLT
CIRCLE USING 1" DIAMETER ANCHOR RODS.
- ⑬ LEVELING SHIMS, DESIGNED FOR THE PURPOSE, SHALL BE USED WHEN PLUMBING
POLES. THE USE OF WASHERS IN LIEU OF PROPER LEVELING SHIMS IS NOT
ACCEPTABLE. LEVELING SHIMS SHALL BE USED ONLY BETWEEN THE TOP OF THE
CONCRETE BASE AND A METALLIC BASE PLATE.


SHIMS SHALL BE LONG ENOUGH AND WIDE ENOUGH TO COMPLETELY COVER THE
AREA UNDER THE LENGTH AND WIDTH OF THE BASE MOUNTING FLANGE.

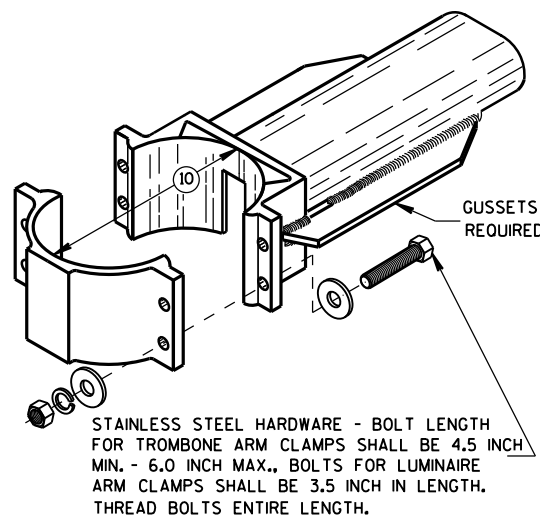


TYPICAL TROMBONE MAST ARM AND SINGLE LUMINAIRE MAST ARM MOUNTING CLAMP

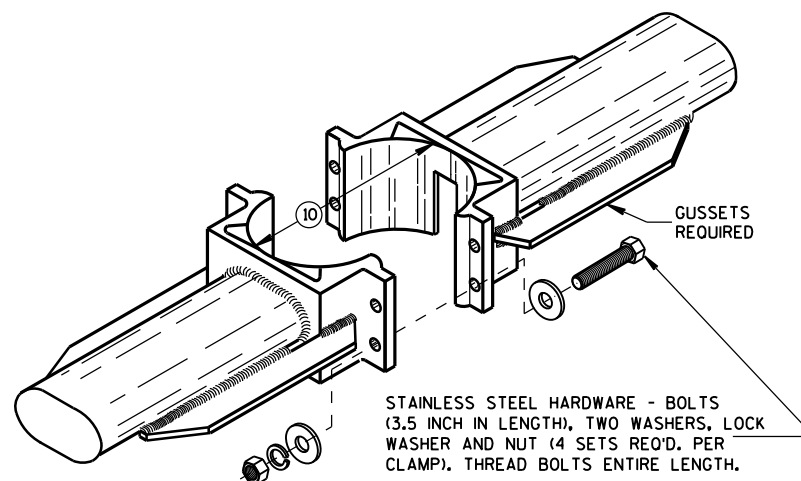



TYPICAL LUMINAIRE MAST ARM (DOUBLE) MOUNTING BRACKETS

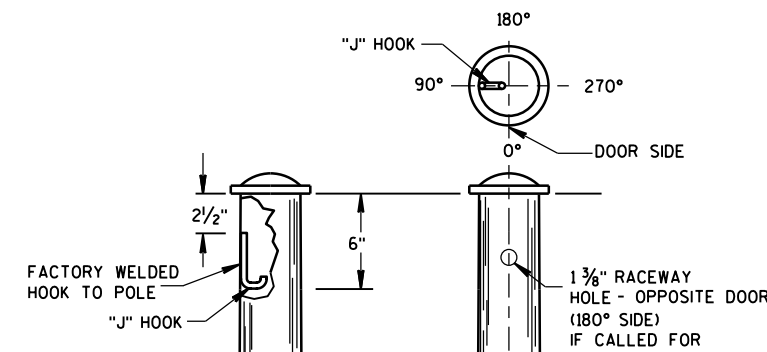


TYPICAL "J" HOOK LOCATION

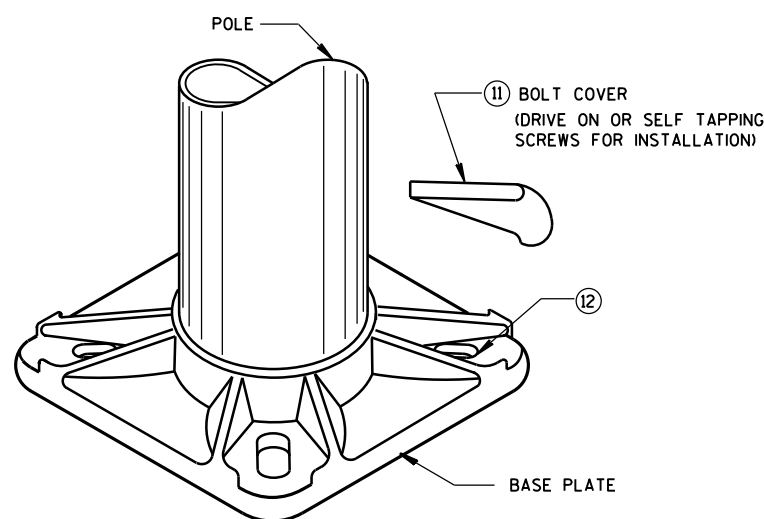

BASE PLATE

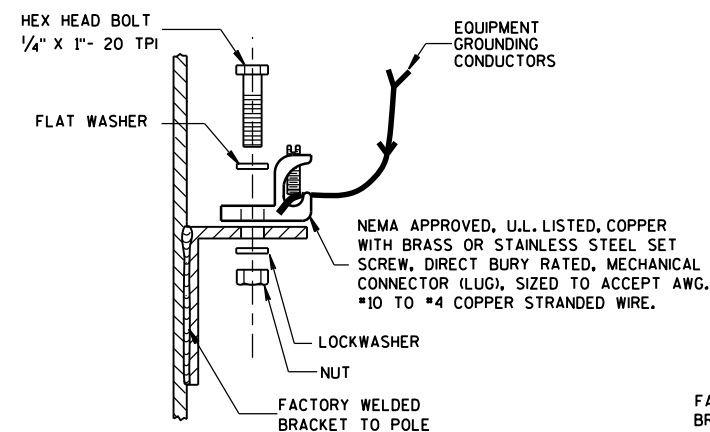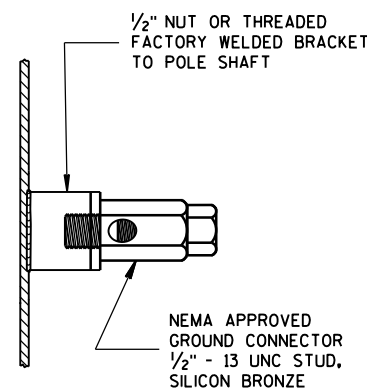


TYPICAL GROUNDING CONNECTIONS
NUT, BOLT AND WASHERS SHALL
BE STAINLESS STEEL

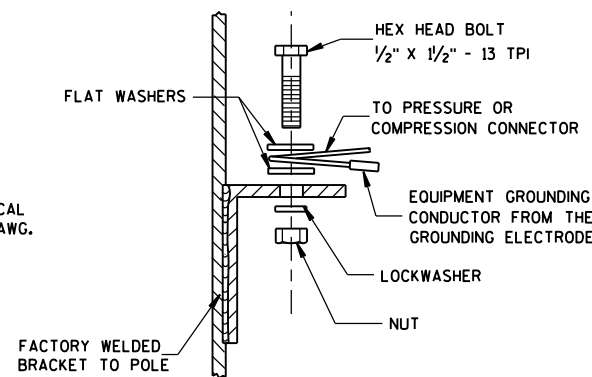


HARDWARE DETAILS FOR POLE MOUNTINGS

STATE OF WISCONSIN
DEPARTMENT OF TRANSPORTATION


APPROVED
Feb. 2015
DATE /S/ Ahmet Demirbilek
STATE ELECTRICAL ENGINEER
FHWA

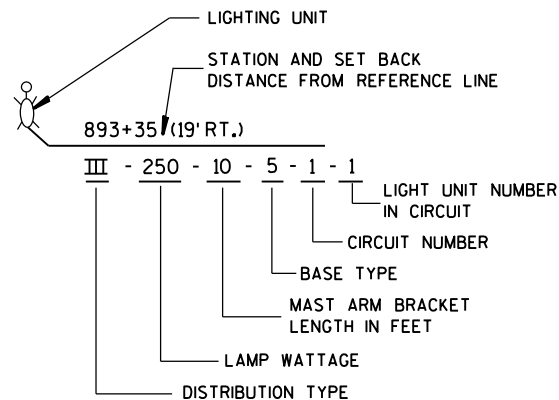



**LIGHTING UNIT CODE
(TYPICAL)**

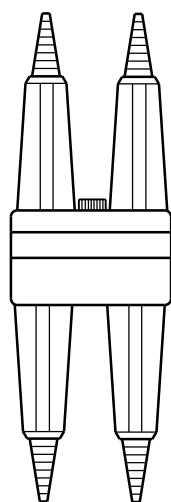

 
**DETAIL "A"
BREAKAWY
DOUBLE POLE WITH
WATERPROOF
INSULATING BOOT**



**DETAIL "B"
BREAKAWY
SINGLE POLE WITH
WATERPROOF
INSULATING BOOT**

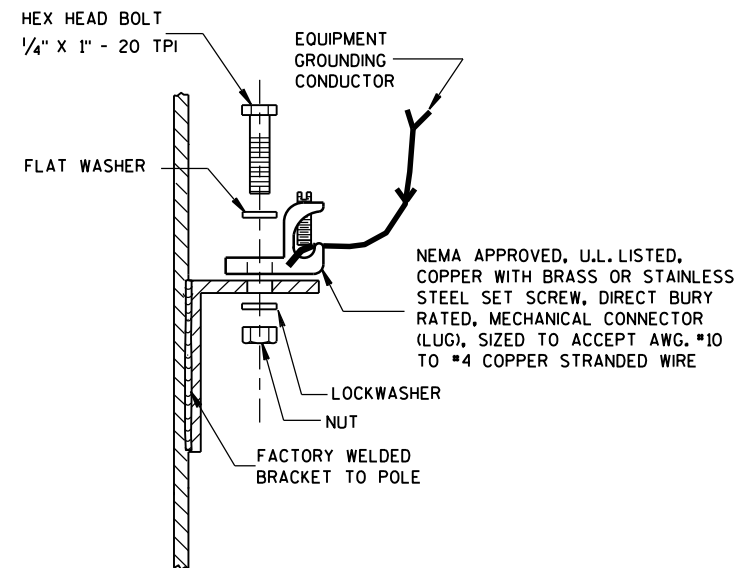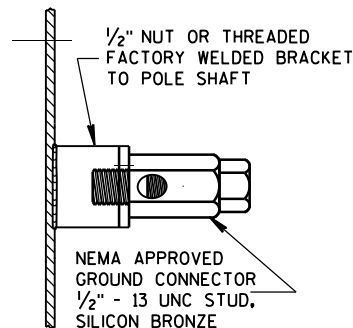

TYPICAL GROUNDING CONNECTIONS
NUT, BOLT, WASHERS AND LOCKWASHERS SHALL BE STAINLESS STEEL

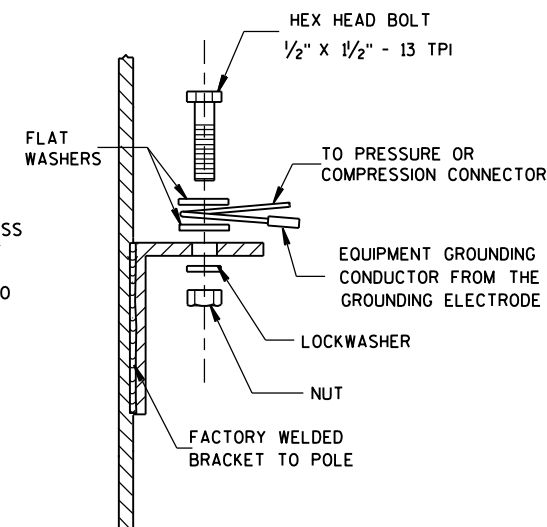

ADDITIONAL CONDUCTORS
AND FUSE FOR TWIN
LIGHTING UNITS

EQUIPMENT GROUNDING
CONDUCTOR(S) TO LUMINAIRE(S)

APPROVED MECHANICAL TYPE
CONNECTOR FOR EQUIPMENT
GROUNDING CONDUCTORS.
COMPRESSION, CRIMP OR
WIRE NUT CONNECTORS ARE
NOT ALLOWED.

TYPICAL GROUNDING CONNECTION -
STAINLESS STEEL BOLT,
NUT AND WASHERS
1/2" X 1/2" - 13 TPI

AWG #4 (MIN.) BARE EQUIPMENT
GROUNDING CONDUCTOR.
NOTE: THIS WIRE SHALL BE
CONTINUOUS WITHOUT SPLICES
FROM THE GROUNDING ELECTRODE
TO THE EQUIPMENT GROUNDING
CONDUCTOR SPICE CONNECTOR.

INSULATED EQUIPMENT GROUNDING
CONDUCTORS FROM SYSTEM RACEWAY

EXOTHERMICALLY WELDED
TO GROUNDING ELECTRODE

CONDUCTORS TO
LUMINAIRES SHALL BE #12 AWG,
COPPER STRANDED, U.S.E. RATED,
XLP INSULATED. SINGLE
LIGHTING UNIT SHOWN

CIRCUIT TAGS, BOTH SIDES
OF ALL FUSES (TYPICAL)

IN LINE SINGLE POLE FUSE ASSEMBLY.
600 VAC, WITH 5 AMP FAST ACTING
FUSE (SEE DETAIL "B")
TAPE AND VARNISH
CRIMPED END FERRULES

HANDHOLE & COVER

18" PIGTAIL BETWEEN
CONNECTOR AND FUSEHOLDER

APPROVED INSULATED MULTITAP
TERMINAL BLOCK TYPE CONNECTORS.
COMPRESSION, CRIMP OR WIRE NUT
CONNECTORS ARE NOT ALLOWED.

INSULATED UNGROUNDED CIRCUIT
CONDUCTORS FROM SYSTEM RACEWAY

ALTERNATE PHASE UNGROUNDED
CIRCUIT CONDUCTOR PASSING
THROUGH THIS POLE

**3 WIRE - 120, 240 OR 480 VAC (UNGROUND CONDUCTOR)
WITH GROUNDED CONDUCTOR AND
WITH EQUIPMENT GROUNDING CONDUCTOR**

TWIN LIGHTING UNITS REQUIRE
INDIVIDUAL SETS OF UNGROUNDED
CONDUCTORS AND FUSE ASSEMBLY.

AWG #4 (MIN.) BARE EQUIPMENT
GROUNDING CONDUCTOR.
NOTE: THIS WIRE SHALL BE
CONTINUOUS WITHOUT SPLICES
FROM THE GROUNDING ELECTRODE
TO THE EQUIPMENT GROUNDING
CONDUCTOR SPICE CONNECTOR.

EQUIPMENT GROUNDING
CONDUCTOR(S) TO LUMINAIRE(S)

TYPICAL GROUNDING CONNECTION -
STAINLESS STEEL BOLT,
NUT AND WASHERS
1/2" X 1/2" - 13 TPI

APPROVED MECHANICAL TYPE
CONNECTOR FOR EQUIPMENT
GROUNDING CONDUCTORS.
COMPRESSION, CRIMP OR
WIRE NUT CONNECTORS ARE
NOT ALLOWED.

INSULATED EQUIPMENT GROUNDING
CONDUCTORS FROM SYSTEM RACEWAY

EXOTHERMICALLY WELDED
TO GROUNDING ELECTRODE

**2 WIRE - 240 OR 480 VAC (UNGROUND CONDUCTORS)
WITH EQUIPMENT GROUNDING CONDUCTOR**

GENERAL NOTES

DETAILS OF CONSTRUCTION, MATERIALS AND WORKMANSHIP NOT SHOWN ON THIS DRAWING
SHALL CONFORM TO THE PERTINENT REQUIREMENTS OF THE CONTRACT.

THE EQUIPMENT GROUNDING CONNECTOR SHALL BE TAPED WITH 3 WRAPS (MINIMUM) OF
APPROVED RUBBER TAPE AND THEN 3 WRAPS (MINIMUM) OF APPROVED VINYL TAPE
TO COVER SHARP WIRE ENDS AFTER THE CONNECTION IS COMPLETED.

WHEN TRANSFORMER BASES ARE USED, ALL WIRING CONNECTIONS SHALL OCCUR WITHIN
THE TRANSFORMER BASES.

CIRCUIT TAGS, BOTH SIDES
OF ALL FUSES (TYPICAL)

IN LINE FUSE ASSEMBLY
TWO POLE, 600 VAC,
WITH 5 AMP FAST ACTING
FUSE (SEE DETAIL "A")
TAPE AND VARNISH
CRIMPED END FERRULES

HANDHOLE & COVER

18" PIGTAIL BETWEEN
CONNECTORS AND FUSEHOLDERS


APPROVED INSULATED MULTITAP
TERMINAL BLOCK TYPE CONNECTORS.
COMPRESSION, CRIMP OR WIRE NUT
CONNECTORS ARE NOT ALLOWED.

INSULATED UNGROUNDED CIRCUIT
CONDUCTORS FROM SYSTEM RACEWAY

**NON-FREEWAY LIGHTING UNIT
POLE WIRING**

STATE OF WISCONSIN
DEPARTMENT OF TRANSPORTATION

APPROVED
Sept. 2014 /S/ Ahmet Demirbilek
DATE STATE ELECTRICAL ENGINEER
FHWA

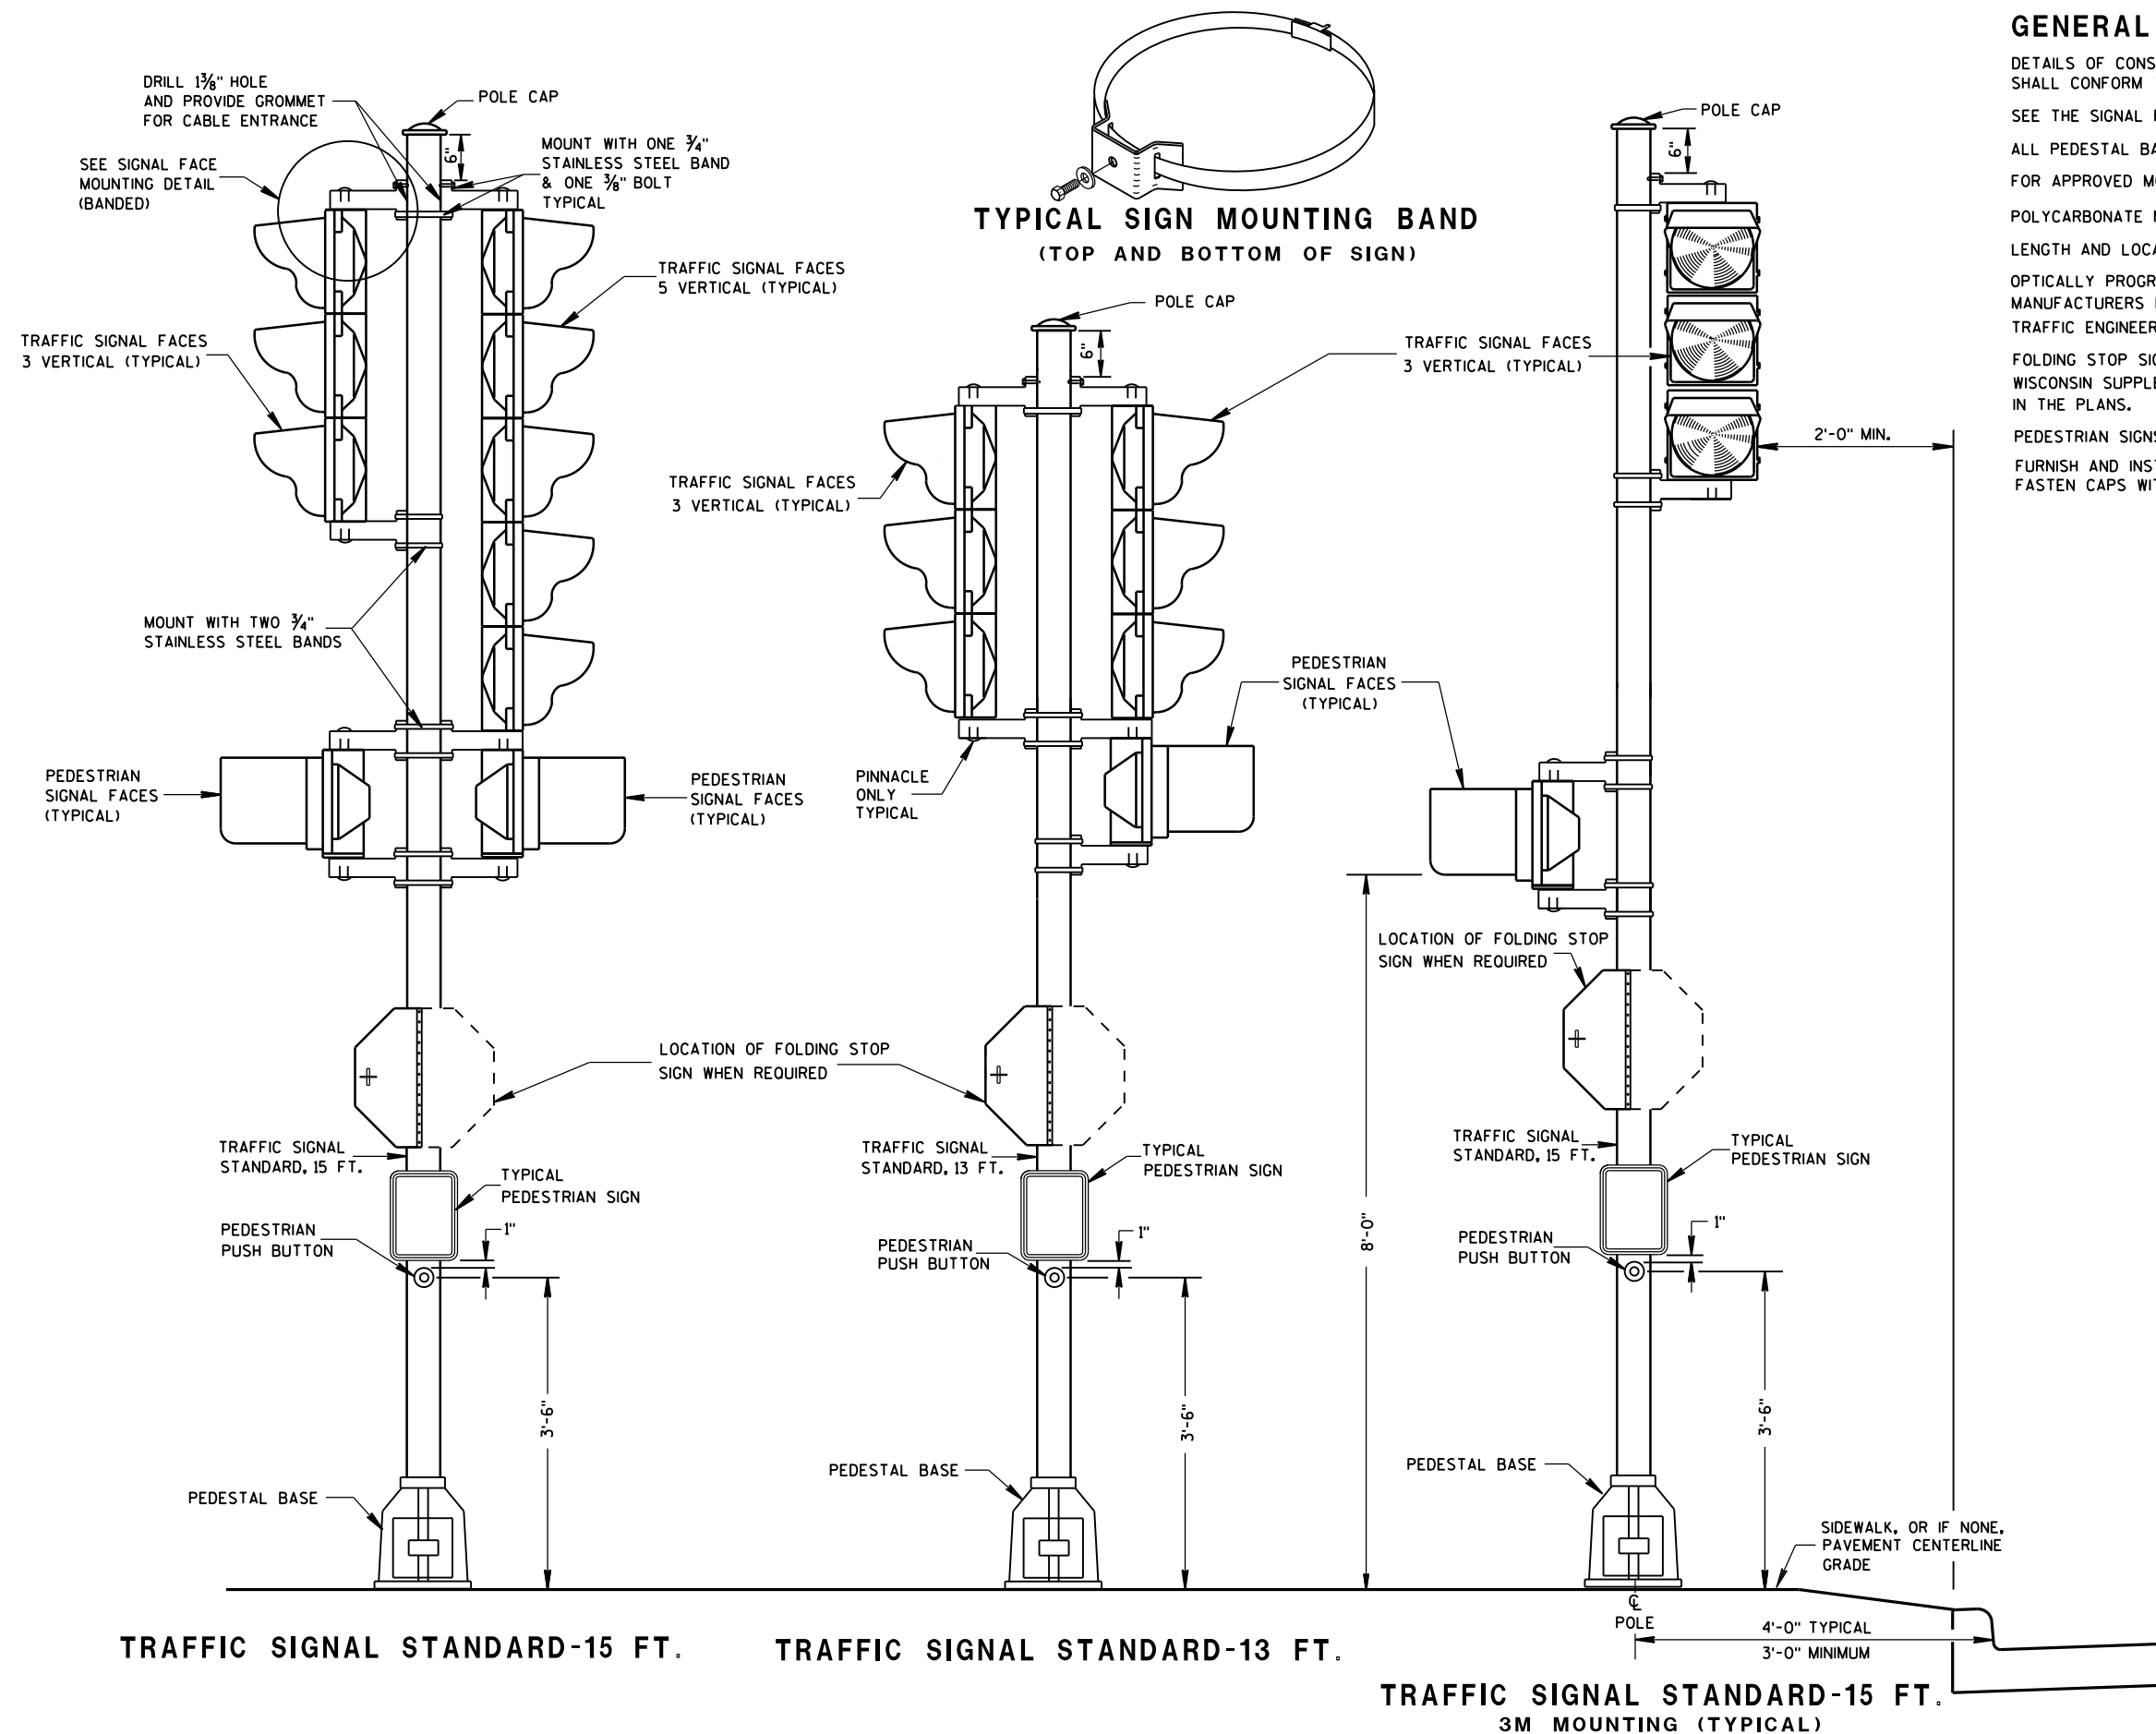

GENERAL NOTES

DETAILS OF CONSTRUCTION, MATERIALS AND WORKMANSHIP NOT SHOWN ON THIS DRAWING SHALL CONFORM TO THE PERTINENT REQUIREMENTS OF THE CONTRACT.

SEE THE SIGNAL PLAN FOR REQUIRED SIGNAL FACE SIZES.

ALL PEDESTAL BASES SHALL BE MOUNTED ON CONCRETE BASE - TYPE 1.

FOR APPROVED MOUNTING HARDWARE, SEE THE CONTRACT SPECIAL PROVISIONS.

POLYCARBONATE MOUNTING BRACKETS SHALL BE USED.


LENGTH AND LOCATION OF TRAFFIC SIGNAL STANDARDS SHALL BE AS SHOWN ON THE PLANS.

OPTICALLY PROGRAMMED SIGNAL FACES SHALL BE MASKED IN ACCORDANCE WITH MANUFACTURERS INSTRUCTIONS, AND UNDER THE DIRECTIONS OF THE REGION TRAFFIC ENGINEER.

FOLDING STOP SIGNS SHALL BE IN ACCORDANCE WITH THE MUTCD AND/OR THE LATEST WISCONSIN SUPPLEMENT. THE SIGNS SHALL BE SIZED AND LOCATED AS CALLED FOR IN THE PLANS.

PEDESTRIAN SIGNS SHALL BE AS DESIGNATED IN THE PLANS.

FURNISH AND INSTALL VENTILATED, CAST, METALLIC (ALUMINUM ALLOY) CAPS. FASTEN CAPS WITH ONE (1) $\frac{1}{4}$ " X $\frac{3}{4}$ " - 20 TPI STAINLESS STEEL, HEX HEAD BOLT.

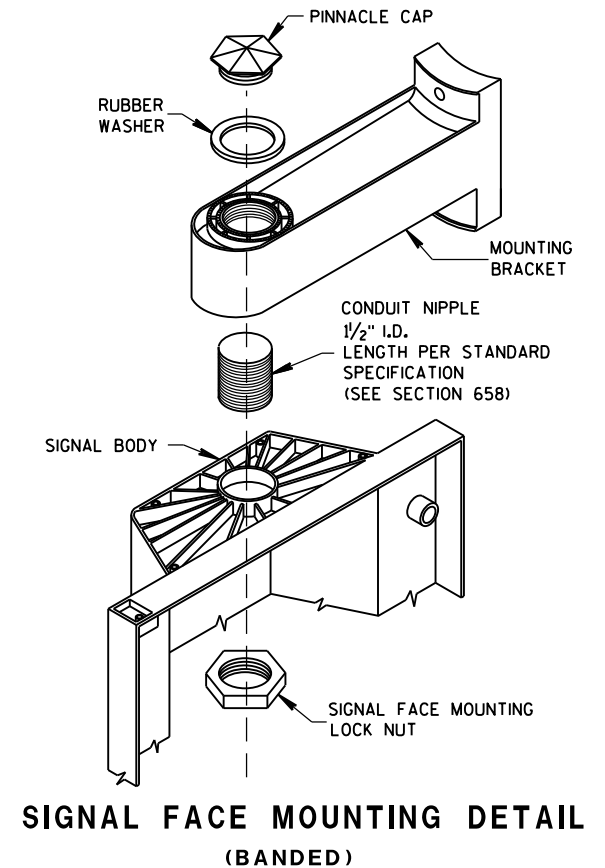


**TRAFFIC SIGNAL STANDARD
POLY BRACKET MOUNTINGS
(TYPICAL) 13 FT. OR 15 FT.**

STATE OF WISCONSIN
DEPARTMENT OF TRANSPORTATION

APPROVED
2/28/2013
DATE

/S/ Ahmet Demirbilek
STATE ELECTRICAL ENGINEER

FHWA

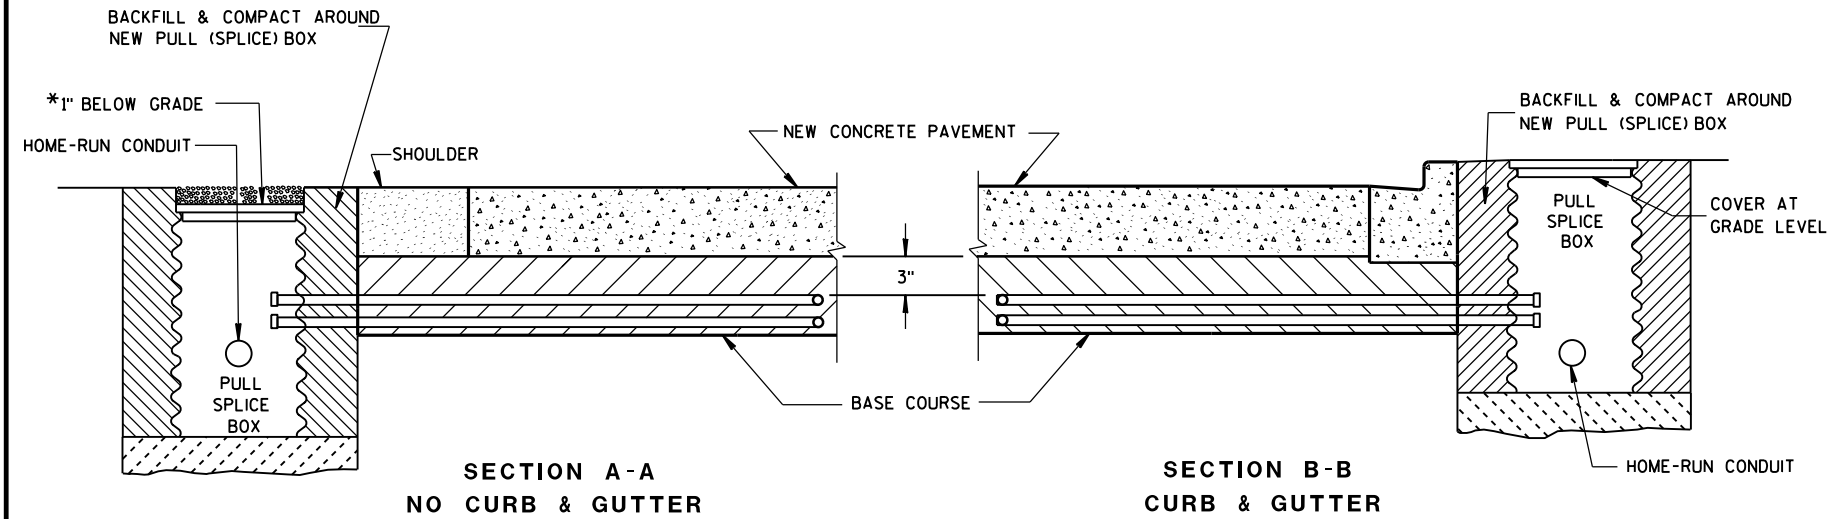


*RECESS PULL (SPICE) BOX SO THAT THE COVER IS 3" BELOW GRADE IN SHOULDER AREAS OF CRUSHED AGGREGATE. BACKFILL OVER COVER WITH THE CRUSHED AGGREGATE TO BRING THE AREA TO GRADE LEVEL.


LOOP DETECTOR INSTALLATION DETAIL

GENERAL NOTES

- DETAILS OF CONSTRUCTION, MATERIALS AND WORKMANSHIP NOT SHOWN ON THIS DRAWING SHALL CONFORM TO THE PERTINENT REQUIREMENTS OF THE CONTRACT.
- LOOP SIZE, CONFIGURATION LOCATION, NUMBER OF TURNS OF WIRE AND ASSOCIATED SIGNAL PHASE SHALL BE AS SHOWN ON THE PLANS.
- PITCH LEAD OUT CONDUIT TO DRAIN TO ROADSIDE PULL (SPICE) BOX.
- SPLICES SHALL BE INSTALLED BY USING CAST IN PLACE SPLICE KITS LISTED ON THE DEPARTMENTS APPROVED PRODUCTS LIST OR AN ENGINEER APPROVED EQUAL. NON-INSULATED BUTT SPLICES TO FIT #12 AWG STRANDED WIRE SHALL BE USED. SPLICES SHALL BE SOLDERED AND INSULATED FROM EACH OTHER AS PER INSTRUCTIONS INCLUDED IN THE SPLICE KIT.
- MEASURE GROUND RESISTANCE USING A MEGGER. REPLACE LOOP WIRE NOT ATTAINING A READING OF INFINITY TO GROUND.
- AFTER SPLICING THE LOOP WIRE TO THE LOOP LEAD-IN CABLE, THE CONTRACTOR SHALL MEASURE INDUCTANCE, GROUND RESISTANCE AND WIRE RESISTANCE AT THE CABINET END OF THE LEAD-IN CABLE AND FURNISH A COPY OF THE READINGS TO THE PROJECT ENGINEER FOR EVALUATION.
- LOOP DETECTOR LEADS SHALL BE IDENTIFIED WITH THEIR ASSOCIATED LOOP BY USE OF WATERPROOF TAGS AT BOTH ENDS OF THE CABLE. A LISTING OF THE CABLE IDENTIFICATION PER INDIVIDUAL LOOP LEAD-IN SHALL BE PLACED IN THE CABINET.
- THE #12 AWG. LOOP WIRE IN THE PULL (SPICE) BOX SHALL BE HAND TWISTED AT LEAST 3 TWISTS PER FOOT BEFORE BEING SPLICED TO THE LOOP LEAD-IN CABLE.
- SPLICES OF LOOP WIRE TO LEAD-IN CABLE SHALL BE MADE ONLY IN PULL (SPICE) BOXES AT THE SIDE OF THE ROAD.
- THE #12 AWG LOOP WIRE SHALL BE INSTALLED FROM THE ROADSIDE PULL (SPICE) BOX, THROUGH THE LOOP CONDUIT, BACK TO THE ROADSIDE PULL (SPICE) BOX, AND BE INSTALLED IN ONE, NON-SPLICED CONTINUOUS LENGTH.
- PROTECTION OF THE CONDUITS IN THE BASE COURSE SHALL BE REQUIRED AFTER INSTALLATION AND BEFORE NEW PAVEMENT IS INSTALLED.
- SHOULD INSTALLATION REPAIR BE REQUIRED, IT SHALL BE DONE UNDER THE DIRECTION OF THE PROJECT ENGINEER.

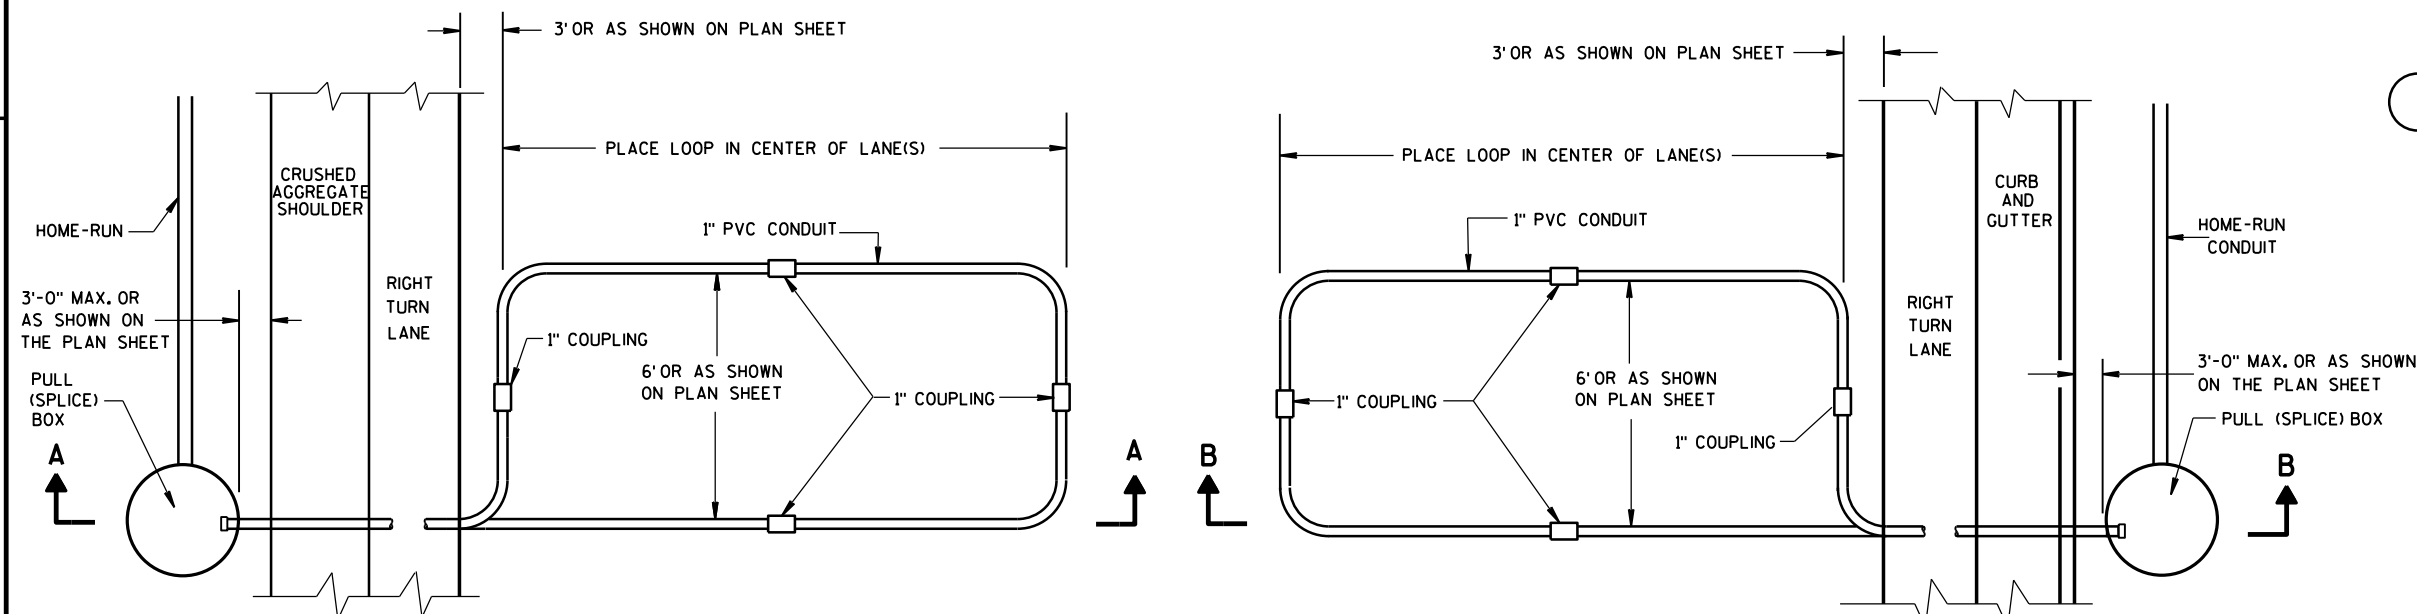

TYPICAL PLAN OF LOOP DETECTOR WITH 24" PULL (SPICE) BOX

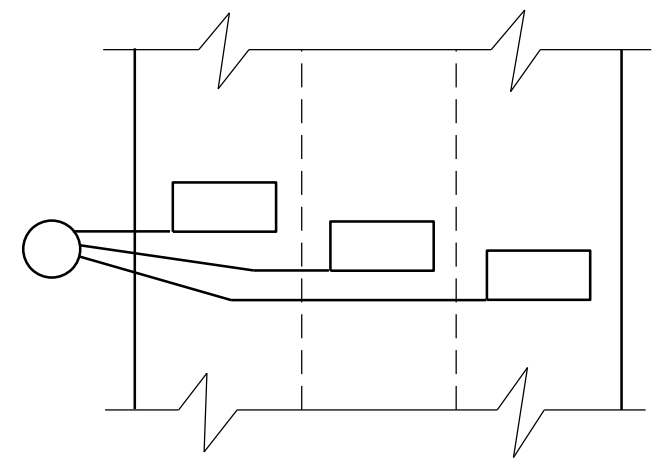


MULTI-LANE INSTALLATION


LOOP DETECTOR INSTALLED IN BASE COURSE WITH PULL (SPICE) BOX OFF ROADWAY (OPTION 2)	
STATE OF WISCONSIN DEPARTMENT OF TRANSPORTATION	
APPROVED Sept. 2014 DATE	/S/ Ahmet Demirelek STATE ELECTRICAL ENGINEER
FHWA	

6
S.D.D. 9 F 15-4b

6
S.D.D. 9 F 15-4b

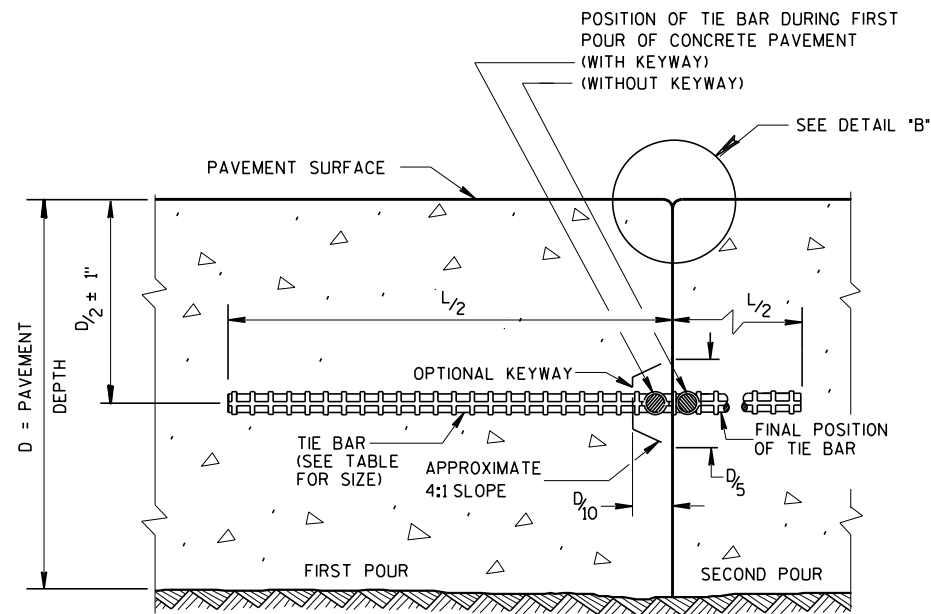


CONSTRUCTION JOINT

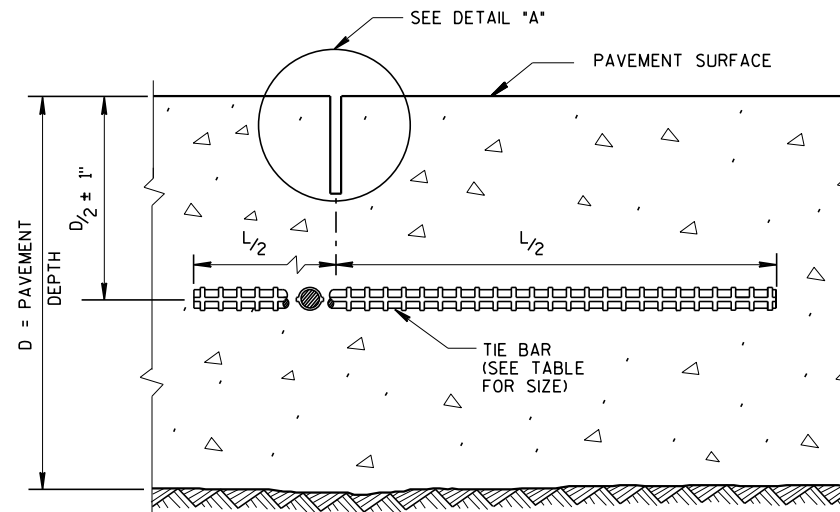


SAWED JOINT

GENERAL NOTES

- CREATE A LONGITUDINAL JOINT FOR PAVEMENT WIDTHS GREATER THAN 15 FEET.
- CORRELATE LONGITUDINAL JOINTS WITH LANE LINES WHEN POSSIBLE.
- 1 ANCHOR TIE BARS INTO DRILLED HOLES WITH AN EPOXY.
 - 2 PAVEMENT THAT WAS IN PLACE PRIOR TO THE CONTRACT.

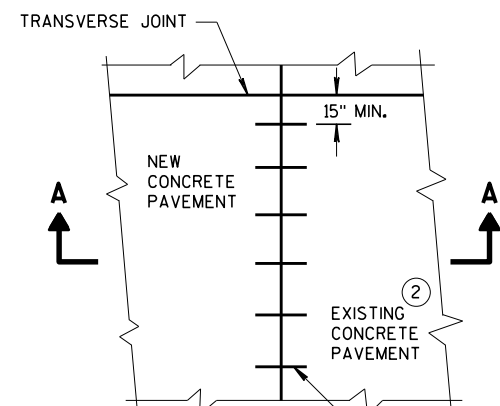


PLAN VIEW

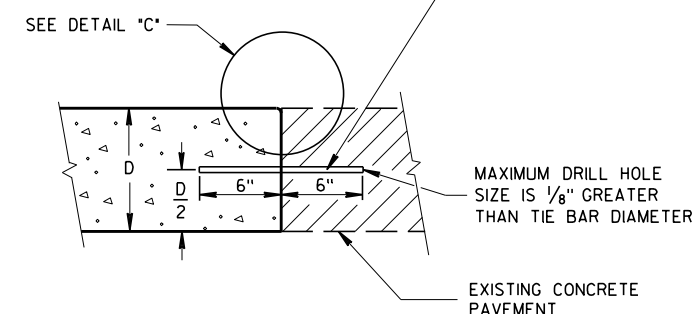


SECTION A-A
LONGITUDINAL CONSTRUCTION JOINT
TIE BARS ANCHORED
INTO EXISTING PAVEMENT


NO. 6 TIE BARS SPACED 30" C-C, INSTALLED PERPENDICULAR TO THE LONGITUDINAL JOINT. ①

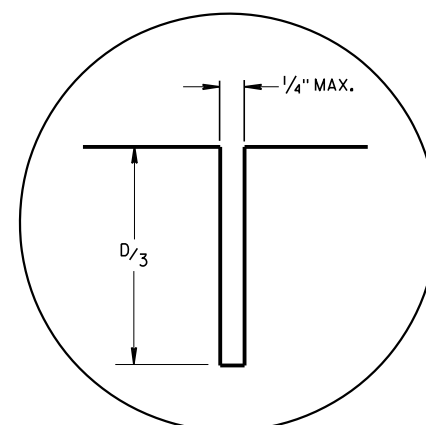

DETAIL "A"

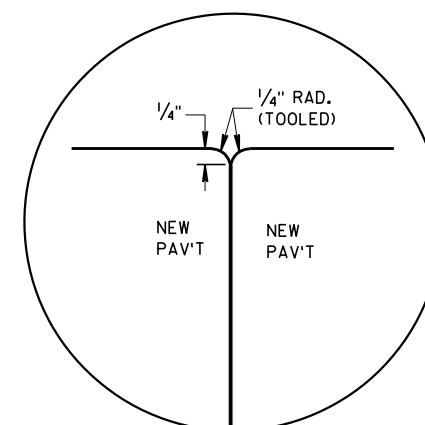

DETAIL "B"

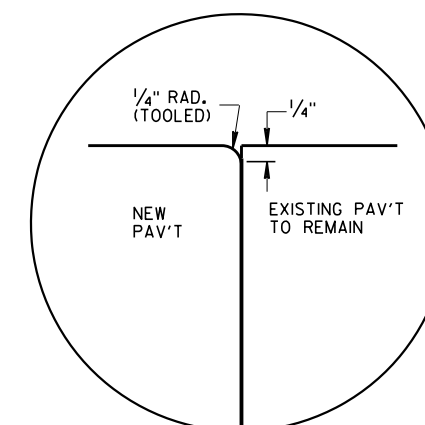


DETAIL "C"

TIE BAR TABLE

PAVEMENT DEPTH (D)	TIE BAR SIZE	TIE BAR LENGTH (L)	MAX. TIE BAR SPACING
$< 10 \frac{1}{2}"$	NO. 4	30"	36"
$\geq 10 \frac{1}{2}"$	NO. 5	36"	36"
	NO. 4 *	30"	24" **

* SUBSTITUTE BENT BARS AT LONGITUDINAL JOINTS WHEN EQUIPMENT LIMITATIONS DURING CONSTRUCTION WARRANT (e.g. AUXILIARY LANES OR TURN LANES)

** CONFORM TO 15" MINIMUM SPACING FROM TRANSVERSE JOINTS; SPACING BETWEEN TIE BARS WILL BE 30" AT TRANSVERSE JOINTS.

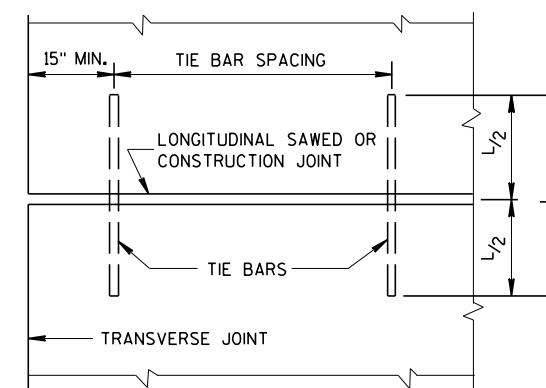


PLAN VIEW
SHOWING LOCATION OF TIE BARS


CONCRETE PAVEMENT
LONGITUDINAL JOINTS AND TIES

STATE OF WISCONSIN
DEPARTMENT OF TRANSPORTATION


APPROVED
March 2018 /S/ Peter Kemp, P.E.
DATE PAVEMENT SUPERVISOR
FHWA

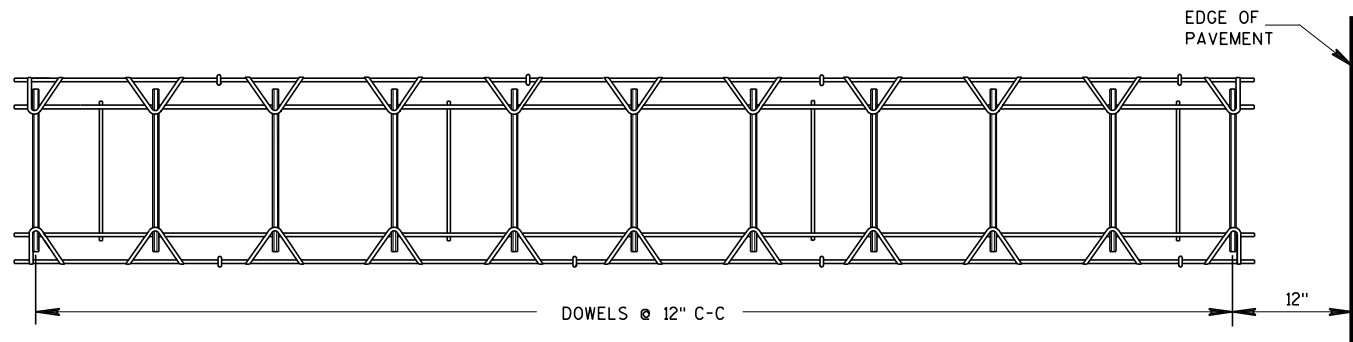


PLAN VIEW

 

SIDE VIEW
CONTRACTION JOINT DOWEL ASSEMBLY ②

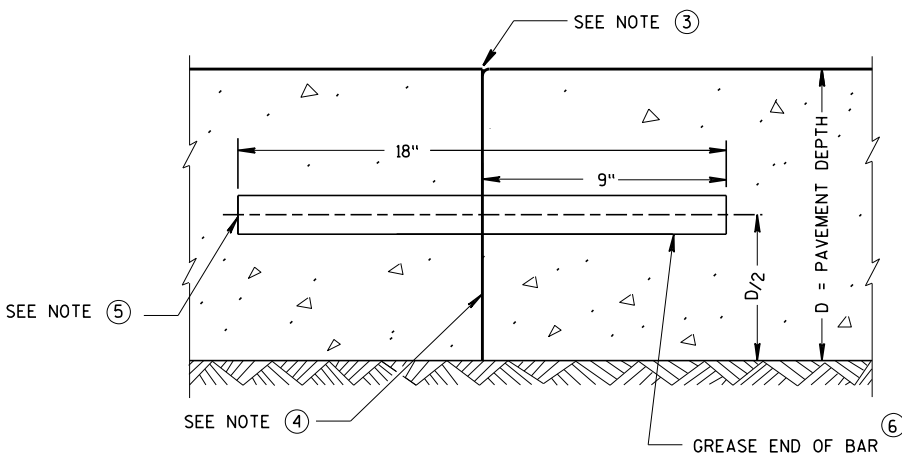

TRANSVERSE CONSTRUCTION JOINT

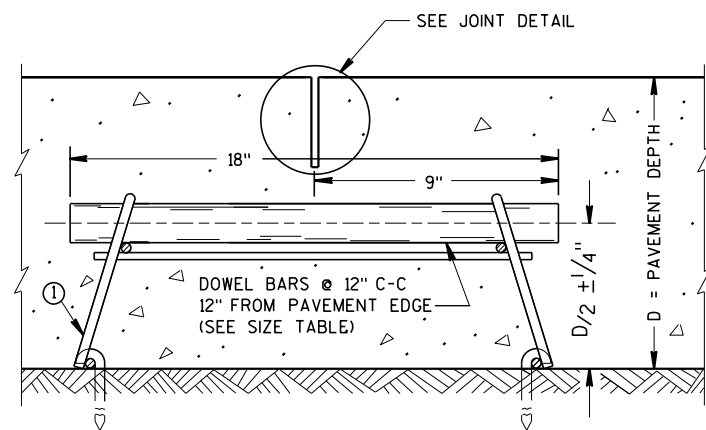

DOWELED CONTRACTION JOINT

PAVEMENT DEPTH, DOWEL BAR SIZE
AND JOINT SPACING TABLE

PAVEMENT DEPTH (D)	DOWEL BAR DIAMETER	CONTRACTION JOINT SPACING
5 1/2", 6", 6 1/2"	NONE	12'
7", 7 1/2"	1"	14'
8", 8 1/2"	1 1/4"	15'
9", 9 1/2"	1 1/4"	15'
10" & ABOVE	1 1/2"	15'

GENERAL NOTES

CONTRACTION JOINTS

CONSTRUCT TRANSVERSE CONTRACTION JOINTS NORMAL TO THE CENTERLINE. SHOW THE LOCATION OF CONTRACTION JOINTS THROUGH INTERSECTIONS ON THE PLANS OR AS DIRECTED BY THE ENGINEER.


INSTALL DOWEL BARS PARALLEL TO THE PAVEMENT CENTERLINE AND PAVEMENT SURFACE.

FOR PAVEMENT SLABS OF VARYING WIDTHS, LOCATE THE OUTER MOST DOWEL BAR SO THAT THE CENTER OF THE BAR IS A MINIMUM OF 6 INCHES AND A MAXIMUM OF 18 INCHES FROM THE LONGITUDINAL JOINT AND THE FREE EDGE OF PAVEMENT.


CONSTRUCTION JOINTS

LOCATE CONSTRUCTION JOINTS A MINIMUM OF 6 FEET FROM THE NEAREST CONTRACTION JOINT AND ALIGN PARALLEL TO CONTRACTION JOINTS.


- ① OBTAIN THE ENGINEER'S APPROVAL FOR THE USE OF ALTERNATIVE DESIGNS OF THE DOWEL ASSEMBLY. USE MECHANICAL DOWEL BAR INSERTERS OR DOWEL ASSEMBLIES WHEN CONSTRUCTING CONTRACTION JOINTS.
- ② SECURE BASKETS WITH ANCHORS TO HOLD DOWEL BARS IN THE CORRECT POSITION AND ALIGNMENT. TYPE, LOCATION, NUMBER AND LENGTH OF ANCHORS ARE DEPENDENT UPON FIELD CONDITIONS.
- ③ FORM OR SAW CONSTRUCTION JOINTS. PROVIDE A 1/4-INCH RADIUS AT FORMED JOINTS.
- ④ PROVIDE A SMOOTH VERTICAL FACE FOR THE ENTIRE DEPTH OF THE PAVEMENT WHEN FORMING CONSTRUCTION JOINTS.
- ⑤ INSTALL DOWEL BARS AT CONSTRUCTION JOINTS BY FORMING OR DRILLING. INSTALL FORMED DOWEL BARS 12 INCHES C-C AND 12 INCHES FROM PAVEMENT EDGE. REMOVE EXCESS CONCRETE FROM THE FREE END OF THE DOWEL BAR IF DOWEL BARS ARE FORMED THROUGH A HEADER BOARD. INSTALL DRILLED DOWEL BARS ACCORDING TO *DRILLED DOWEL BAR CONSTRUCTION JOINT* DETAIL.
- ⑥ APPLY A THIN UNIFORM COATING OF SURFACE TREATMENT TO THE FREE END OF DOWEL BARS TO PREVENT BONDING.
- ⑦ ANCHOR DOWEL BARS INTO DRILLED HOLES WITH AN EPOXY. MAXIMUM DRILLED HOLE SIZE IS 1/8-INCH GREATER THAN DOWEL BAR DIAMETER, 9 INCHES IN LENGTH.

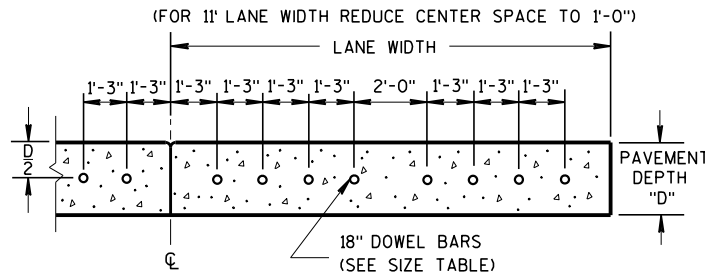

DRILLED DOWEL BAR CONSTRUCTION JOINT ⑦

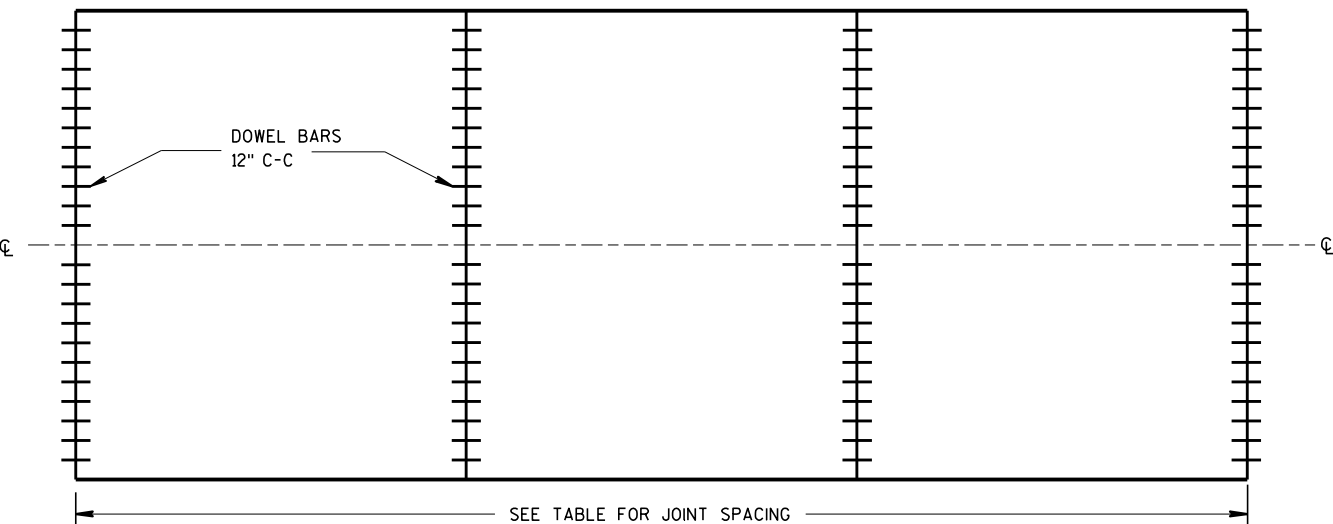

CONTRACTION JOINT LOCATIONS

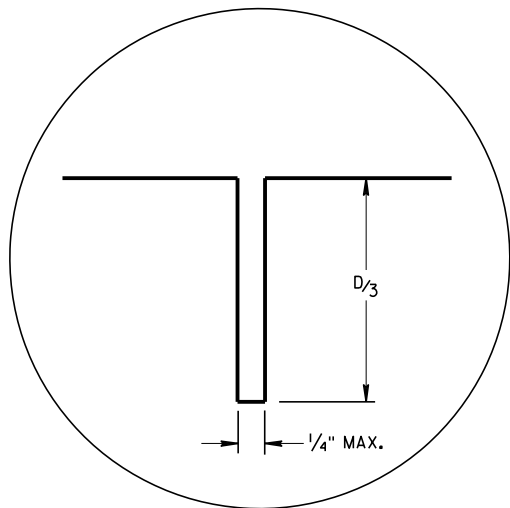


JOINT DETAIL


URBAN DOWELED
CONCRETE PAVEMENT

STATE OF WISCONSIN
DEPARTMENT OF TRANSPORTATION


APPROVED
March 2018 /S/ Peter Kemp, P.E.
DATE PAVEMENT SUPERVISOR
FHWA

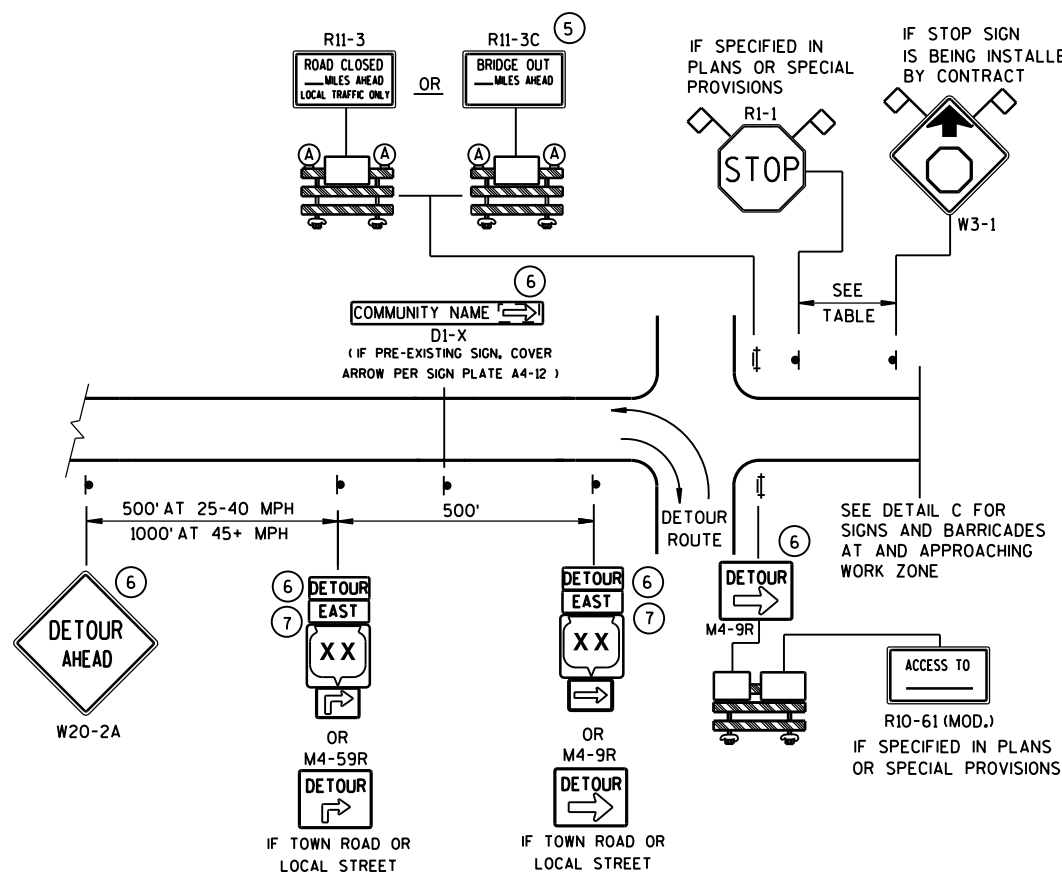

DETAIL A
MAINLINE CLOSURE WITH POSTED DETOUR
WORK ZONE GREATER THAN 1/2 MILE FROM DETOUR ROUTE (1000 FEET IF URBAN)

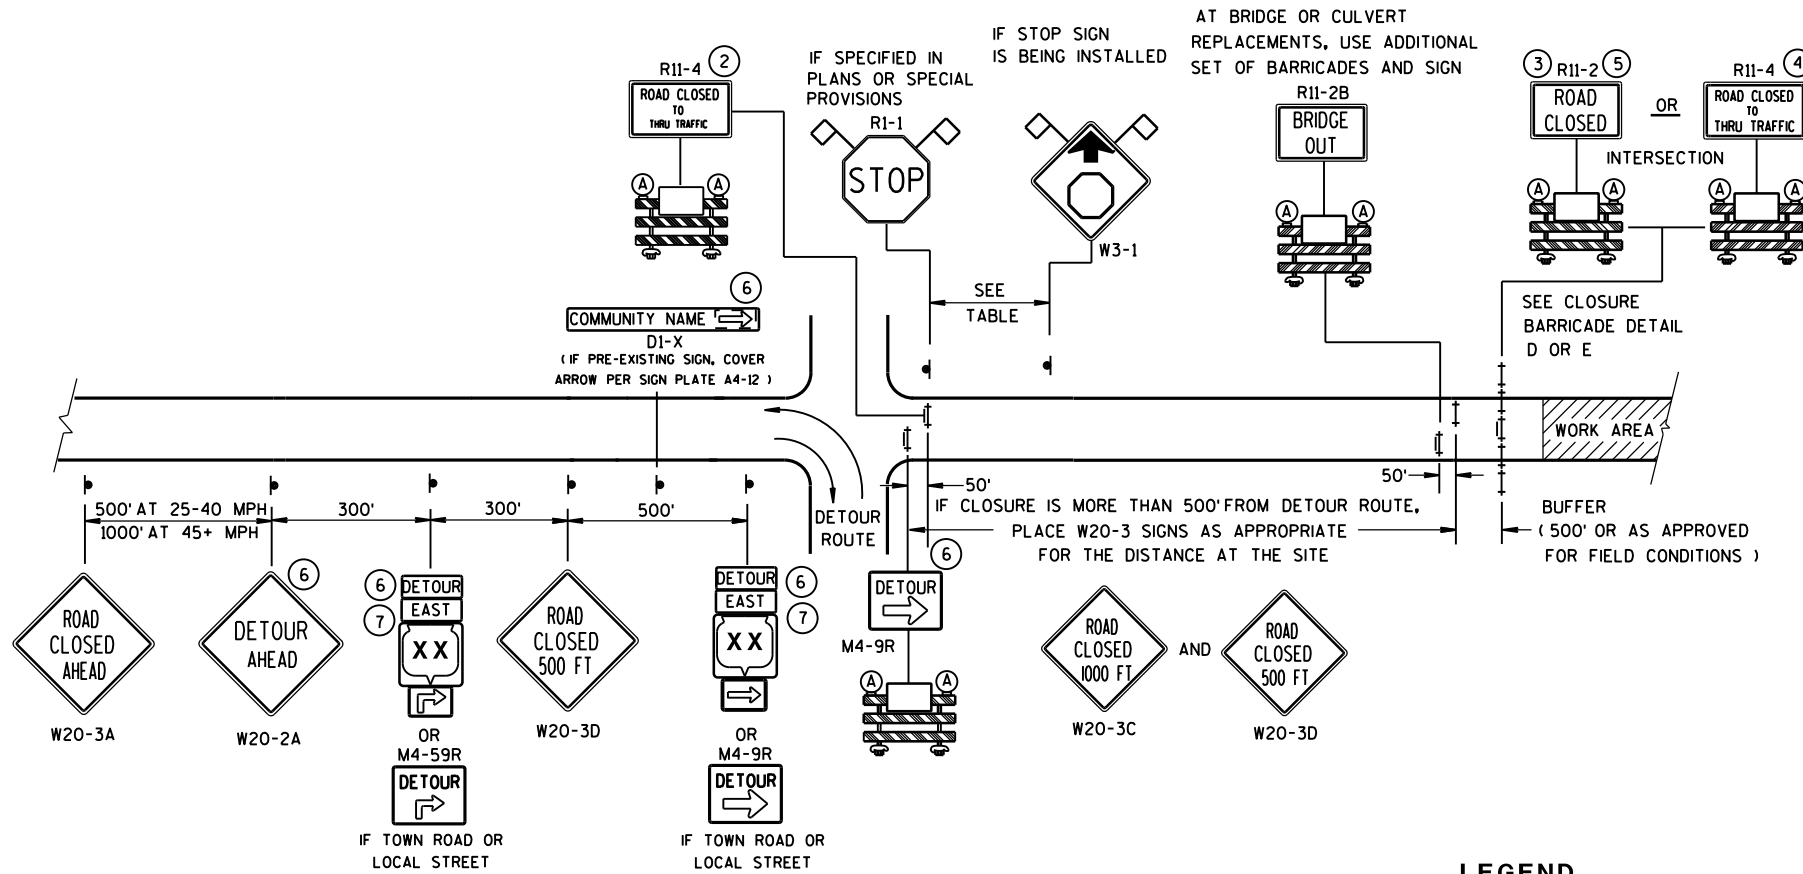

DETAIL B
MAINLINE CLOSURE WITH POSTED DETOUR
WORK ZONE LESS THAN 1/2 MILE FROM DETOUR ROUTE (1000 FEET IF URBAN)

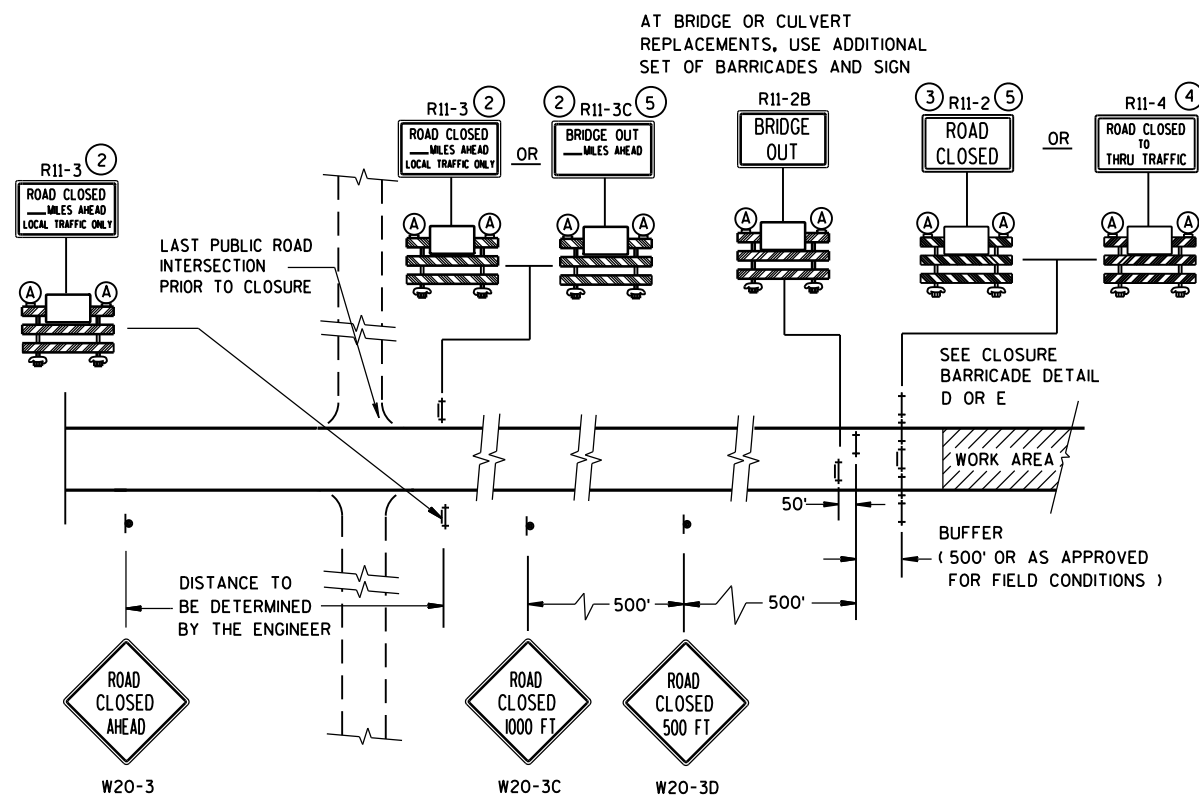

DETAIL C
MAINLINE CLOSURE, NO POSTED DETOUR

LEGEND

- SIGN ON PERMANENT SUPPORT
- ⊥ TYPE III BARRICADE
- ⊥ TYPE III BARRICADE WITH ATTACHED SIGN
- Ⓐ TYPE "A" WARNING LIGHT (FLASHING)

WORK AREA

DETOUR EAST M4-8 M3-X
XX OR COUNTY XX OR XX
M1-4 M1-5A M1-6

M05-1 OR M06-1

FLAGS, 16" X 16" MIN., (ORANGE)



SPEED LIMIT (MPH)	"STOP AHEAD" ADVANCE WARNING DISTANCE (FT)
25	200
30	200
35	350
40	350
45	500
50	550
55	750

SEE SDD 15C2-SHEET "b"
FOR GENERAL NOTES
AND FOOTNOTES ① THROUGH ⑦

**BARRICADES AND SIGNS
FOR
MAINLINE CLOSURES**

STATE OF WISCONSIN
DEPARTMENT OF TRANSPORTATION

Sept. 2015 /S/ Peter Amokobe Atepe
DATE STATEWIDE WORK ZONE TRAFFIC
FHWA SAFETY ENGINEER

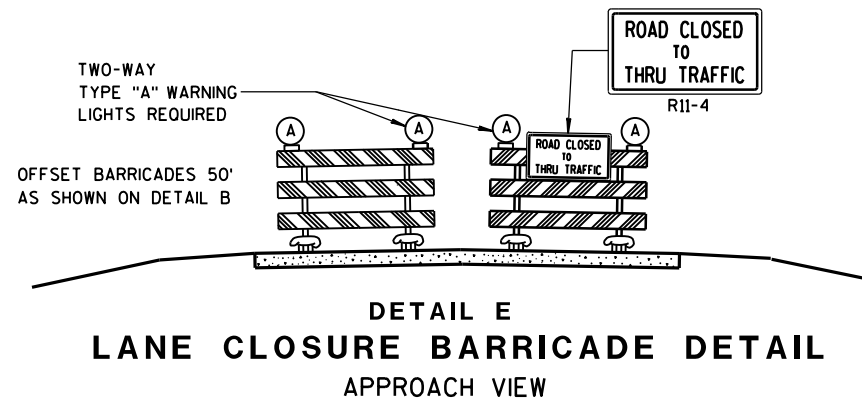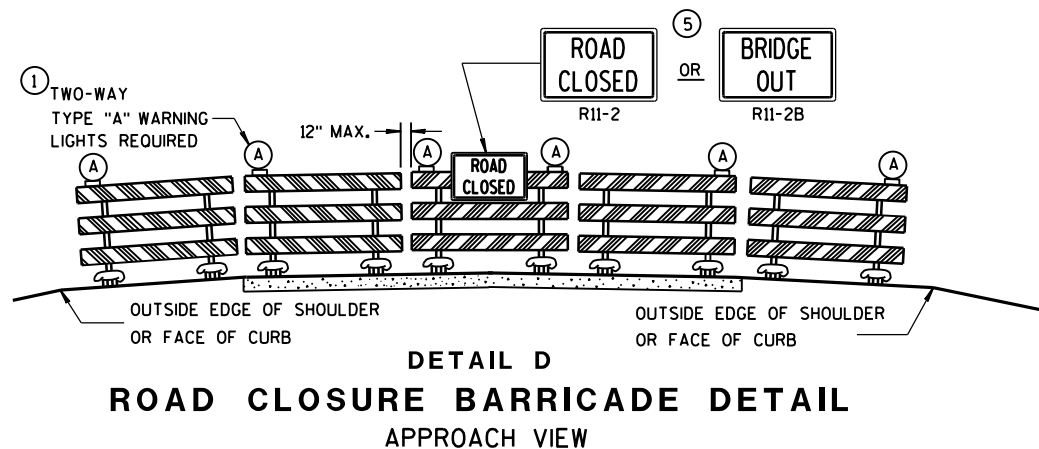

SEE SDD 15C2-SHEET "a" FOR LEGEND

GENERAL NOTES

THE EXACT NUMBER, LOCATION, AND SPACING OF ALL SIGNS AND BARRICADES SHALL BE ADJUSTED TO FIT FIELD CONDITIONS AS APPROVED BY THE ENGINEER.

ANY SIGNS TEMPORARY OR EXISTING, WHICH CONFLICT WITH TRAFFIC CONTROL "IN USE" SHALL BE REMOVED OR COVERED AS NEEDED AND AS APPROVED BY THE ENGINEER.

THE SPACING BETWEEN TRAFFIC CONTROL SIGNS SHOULD BE ADJUSTED TO NOT CONFLICT WITH AND SHOULD PROVIDE A DESIRABLE MINIMUM OF 200 FEET CLEARANCE TO EXISTING SIGNS THAT WILL REMAIN IN PLACE.

BARRICADES THAT MUST BE MOVED FOR A WORK OPERATION SHALL BE IMMEDIATELY RE-ESTABLISHED UPON COMPLETION OF THE OPERATION OR, FOR CONTINUING OPERATIONS, AT THE END OF EACH WORKING DAY.

SIGNS THAT WILL BE IN PLACE LESS THAN 7 CONTINUOUS DAYS AND NIGHTS MAY BE MOUNTED ON PORTABLE SUPPORTS.

ALL TYPE III BARRICADES SHALL HAVE RAILS REFLECTORIZED ON BOTH FACES. STRIPES SHALL BE PROPERLY SLOPED DOWN TOWARD THE TRAFFIC SIDE OR AS SHOWN IN THE ROAD CLOSURE BARRICADE DETAIL D FOR FULL ROAD CLOSURES.

TYPE "A" LOW-INTENSITY FLASHING WARNING LIGHTS SHALL BE VISIBLE ON BOTH SIDES OF THE BARRICADE.

THE R11-2, R11-3, M4-9, R11-4 AND R10-61 SIGNS PLACED ON BARRICADES SHALL COVER NO MORE THAN THE TOP RAIL. THE SIGNS SHALL NOT COVER ANY PORTION OF THE MIDDLE OR BOTTOM RAILS.


"WO AND "MO" SIGNS ARE THE SAME AS "W" AND "M" SIGNS EXCEPT THE BACKGROUND IS ORANGE.

ALL SIGNS SHALL BE 48" X 48" UNLESS OTHERWISE NOTED BELOW:


- R11-2 SHALL BE 48" X 30".
- R11-3, R11-4 AND R10-61 SHALL BE 60" X 30".
- M4-9 SHALL BE 30" X 24".
- M3-X SHALL BE 24" X 12". (36" X 18" IF NEEDED TO MATCH EXISTING SIGNS.)
- M4-8 SHALL BE 24" X 12". (30" X 15" IF NEEDED TO MATCH EXISTING SIGNS.)
- M1-4, M1-5A, AND M1-6 SHALL BE 24" X 24". (36" X 36" IF NEEDED TO MATCH EXISTING SIGNS.)
- MO5-1 AND MO6-1 SHALL BE 21" X 21". (30" X 30" IF NEEDED TO MATCH EXISTING SIGNS.)
- D1-X SHALL BE AS SHOWN ON SPECIFIC PROJECT SIGNING DETAIL SHEETS.
- R1-1 SHALL BE 36" X 36".

- 1 TWO WARNING LIGHTS SHALL BE PROVIDED ON THE CENTER BARRICADE AND A MINIMUM OF ONE WARNING LIGHT SHALL BE PROVIDED ON EACH OF THE OTHER BARRICADES WITHIN THE ROADWAY LIMITS. SPACING OF THE WARNING LIGHTS SHALL BE UNIFORM TO THE EDGE OF ROADWAY AS SHOWN (APPROX. 8-FOOT LIGHT SPACING).
- 2 THESE SIGNS AND BARRICADES ARE NOT REQUIRED IF ROAD CLOSURE BEGINS AT INTERSECTION.
- 3 FOR ROAD CLOSURE WITHOUT LOCAL ACCESS TO PROJECT, SEE ROAD CLOSURE BARRICADE DETAIL D.
- 4 FOR ROAD CLOSURE WITH LOCAL ACCESS TO PROJECT, SEE LANE CLOSURE BARRICADE DETAIL E.
- 5 FOR BRIDGE OR CULVERT REPLACEMENTS, SUBSTITUTE "BRIDGE OUT" INSTEAD OF "ROAD CLOSED" ON R11-2 AND R11-3 SIGNS.
- 6 INSTALL DETOUR AND COMMUNITY GUIDE SIGNS AND ARROWS ONLY IF SPECIFIED IN THE CONTRACT. IF THERE ARE EXISTING ROUTE MARKER ASSEMBLIES THAT WILL REMAIN IN PLACE, ADJUST THE LOCATION OF THE DETOUR ROUTE SIGNS TO CORRESPOND WITH THE EXISTING ASSEMBLIES. MODIFY EXISTING SIGNS WHERE POSSIBLE. SEE SPECIFIC PROJECT DETOUR SIGNING DETAIL SHEETS. IF DETOUR SIGNS ARE BEING INSTALLED BY OTHERS, PLACE THE CONTRACTED TRAFFIC CONTROL SIGNS TO ALLOW FOR PLACEMENT OF ALL WARNING, DETOUR AND GUIDE SIGNS AS SHOWN.
- 7 "EAST" CARDINAL DIRECTION MARKERS AND RIGHT TURN ARROWS ARE SHOWN. USE OTHER CARDINAL DIRECTIONS AND ARROWS AS APPROPRIATE.


BARRICADES AND SIGNS FOR MAINLINE CLOSURES	
STATE OF WISCONSIN DEPARTMENT OF TRANSPORTATION	
Sept. 2015 DATE	/S/ Peter Amokobe Atepe STATEWIDE WORK ZONE TRAFFIC SAFETY ENGINEER
FHWA	

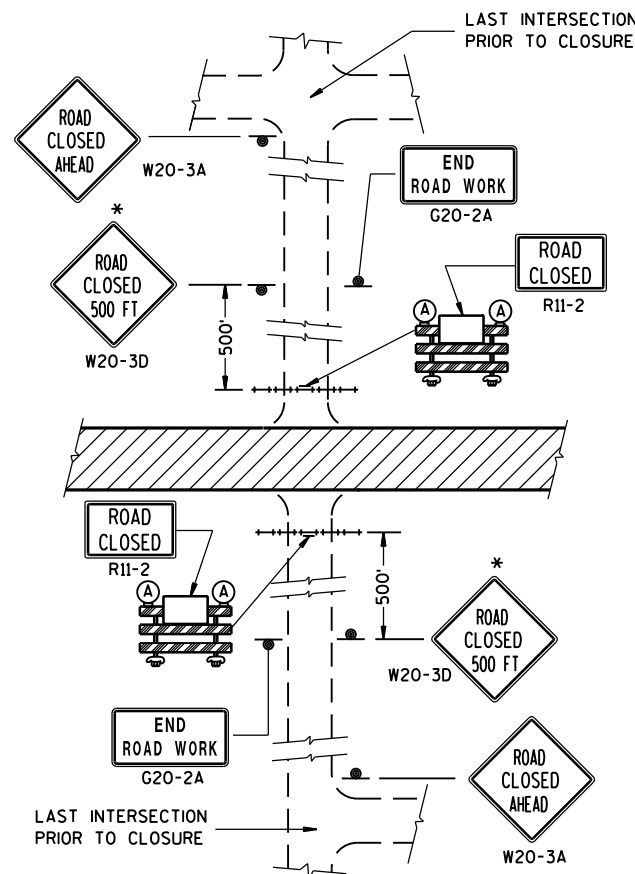


DETAIL 1
(NO ACCESS TO PROJECT)

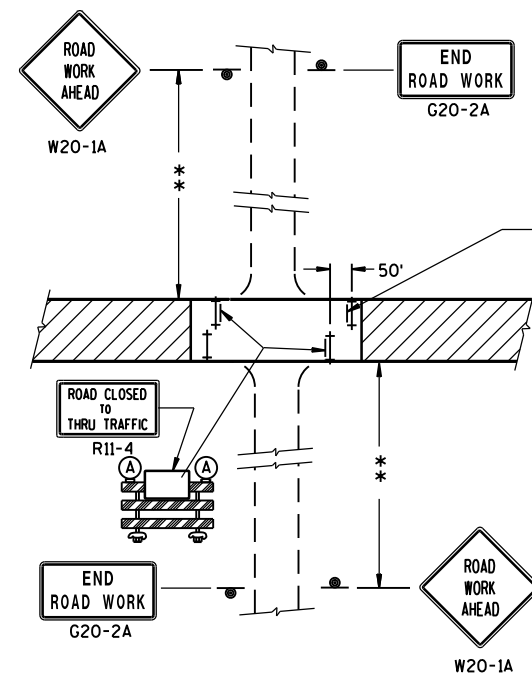

DETAIL 3
(PUBLIC CROSS-TRAFFIC MAINTAINED. CONTRACTOR, LOCAL BUSINESS AND RESIDENT ACCESS).

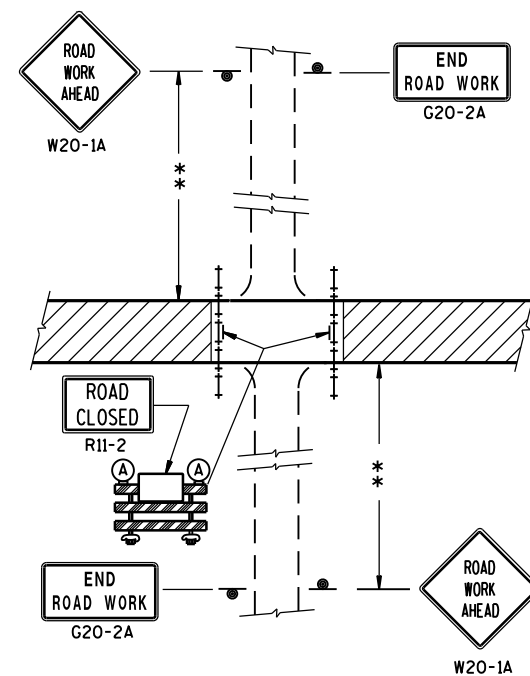

DETAIL 2
(PUBLIC CROSS-TRAFFIC MAINTAINED.
NO ACCESS TO PROJECT).

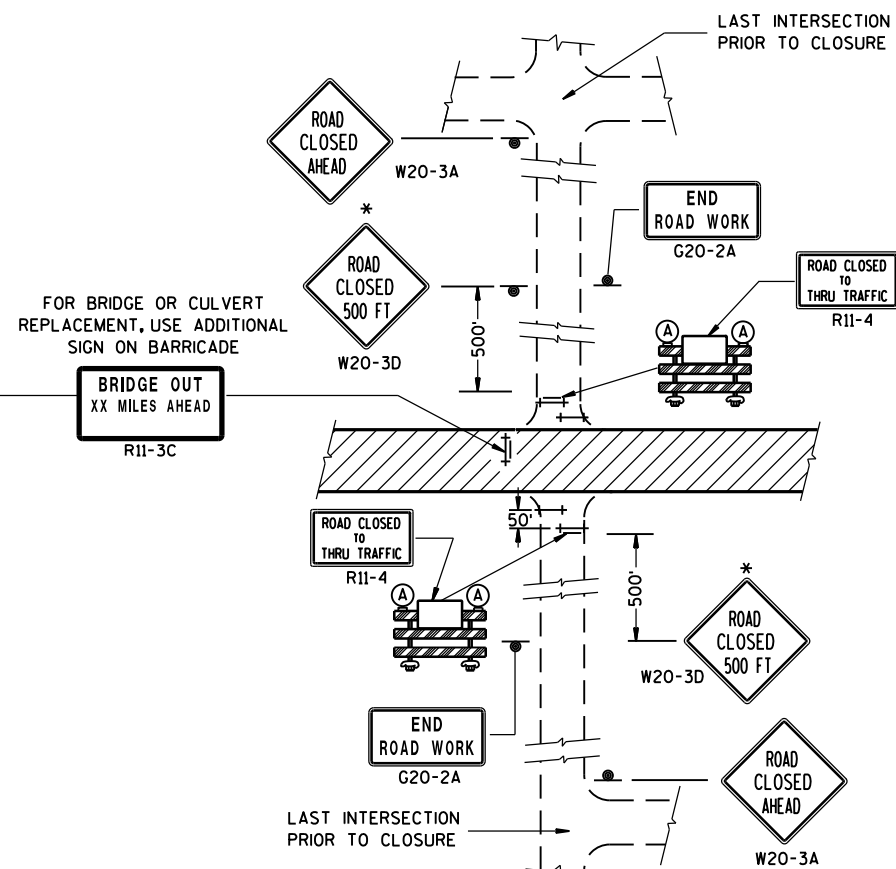

DETAIL 4
(CONTRACTOR, LOCAL BUSINESS AND
RESIDENT ACCESS TO PROJECT)

GENERAL NOTES

THE EXACT NUMBER, LOCATION, AND SPACING OF ALL SIGNS AND BARRICADES SHALL BE ADJUSTED TO FIT FIELD CONDITIONS AS APPROVED BY THE ENGINEER.

ANY SIGNS TEMPORARY OR EXISTING, WHICH CONFLICT WITH TRAFFIC CONTROL "IN USE" SHALL BE REMOVED OR COVERED AS NEEDED AND AS APPROVED BY THE ENGINEER.

THE SPACING BETWEEN TRAFFIC CONTROL SIGNS SHOULD BE ADJUSTED TO NOT CONFLICT WITH AND SHOULD PROVIDE A DESIRABLE MINIMUM OF 200 FEET CLEARANCE TO EXISTING SIGNS THAT WILL REMAIN IN PLACE.

IF A "STOP" SIGN MUST BE REMOVED FOR A WORK OPERATION, A TEMPORARY "STOP" SIGN SHALL BE PLACED PRIOR TO THE SIGN REMOVAL, OR A FLAGGER SHALL BE PROVIDED UNTIL THE SIGN IS RE-ESTABLISHED.

BARRICADES THAT MUST BE MOVED FOR A WORK OPERATION SHALL BE IMMEDIATELY RE-ESTABLISHED UPON COMPLETION OF THE OPERATION OR, FOR CONTINUING OPERATIONS, AT THE END OF EACH WORKING DAY.

SIGNS THAT WILL BE IN PLACE LESS THAN 7 CONTINUOUS DAYS AND NIGHTS MAY BE MOUNTED ON PORTABLE SUPPORTS.

ALL TYPE III BARRICADES SHALL HAVE RAILS REFLECTORIZED ON BOTH FACES. STRIPES SHALL BE PROPERLY SLOPED DOWN TOWARD THE TRAFFIC SIDE OR AS SHOWN IN THE ROAD CLOSURE BARRICADE DETAIL D FOR FULL ROAD CLOSURES.

TYPE "A" LOW-INTENSITY FLASHING WARNING LIGHTS SHALL BE VISIBLE ON BOTH SIDES OF THE BARRICADE.

THE R11-2, R11-3 AND R11-4 SIGNS PLACED ON BARRICADES SHALL COVER NO MORE THAN THE TOP RAIL. THE SIGNS SHALL NOT COVER ANY PORTION OF THE MIDDLE OR BOTTOM RAILS.

ALL SIGNS SHALL BE 48" X 48" UNLESS OTHERWISE NOTED BELOW:

R11-2 SHALL BE 48" X 30".

R11-4 AND R11-3 SHALL BE 60" X 30".

*OMIT THE "ROAD CLOSED 500 FT." SIGN IF THE LAST INTERSECTION IS 500 FT. OR LESS FROM THE WORK ZONE.

**500' MAX. OR AT LAST INTERSECTION WHICHEVER IS CLOSER.

LEGEND

- ⊙ SIGN ON PERMANENT SUPPORT
- ⊥ TYPE III BARRICADE
- ⊥ TYPE III BARRICADE WITH ATTACHED SIGN
- Ⓐ TYPE "A" WARNING LIGHT (FLASHING)
- ▨ WORK AREA

BARRICADES AND SIGNS FOR SIDEROAD CLOSURES


STATE OF WISCONSIN
DEPARTMENT OF TRANSPORTATION

APPROVED


Sept. 2017
DATE

/S/ Andrew Heidtke
WORK ZONE ENGINEER


FHWA

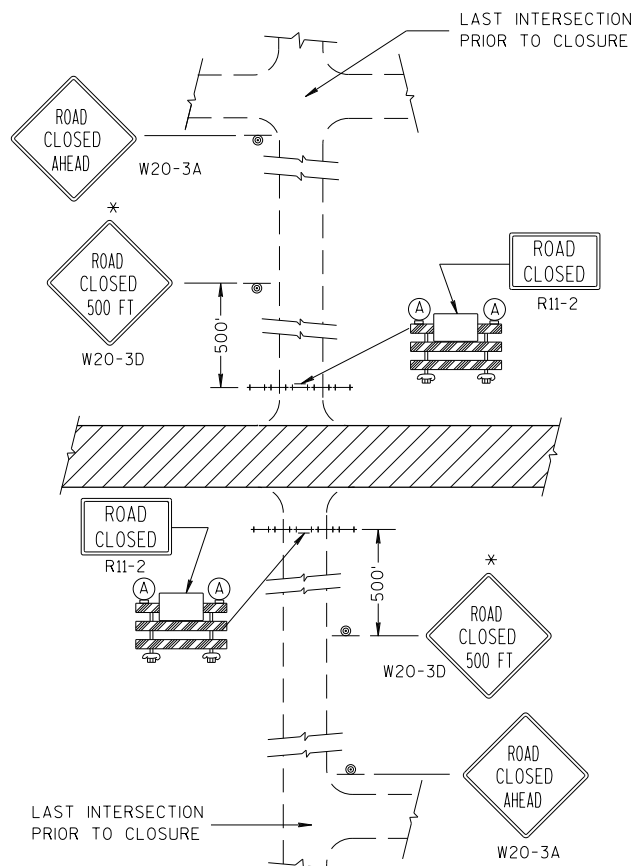


DETAIL 1
(NO ACCESS TO PROJECT)

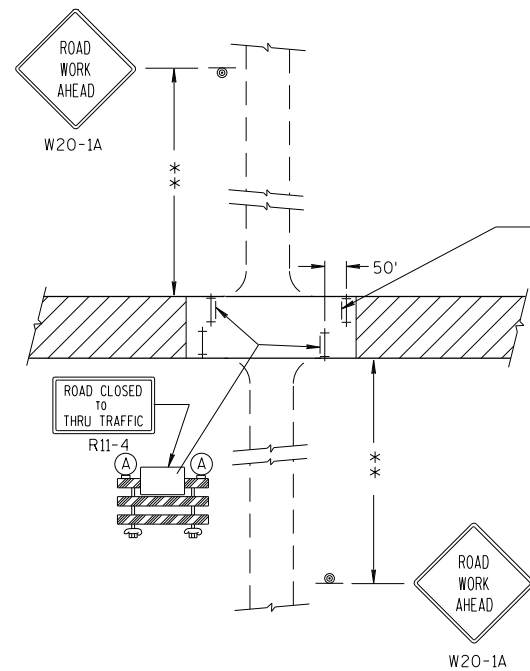

DETAIL 3
(PUBLIC CROSS-TRAFFIC MAINTAINED. CONTRACTOR, LOCAL BUSINESS AND RESIDENT ACCESS).

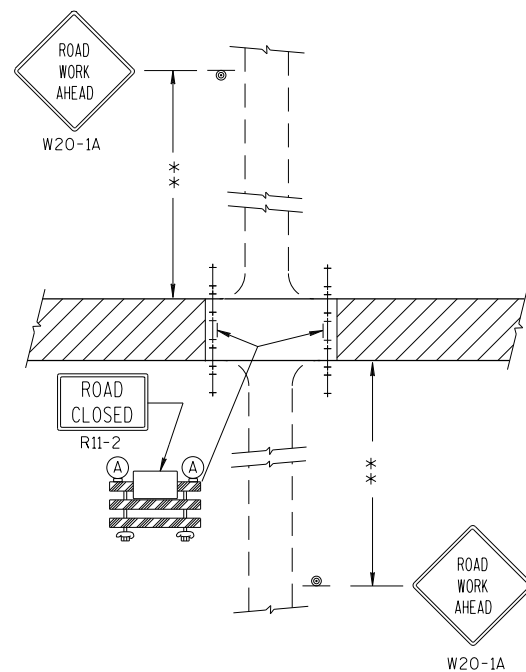

DETAIL 2
(PUBLIC CROSS-TRAFFIC MAINTAINED.
NO ACCESS TO PROJECT).

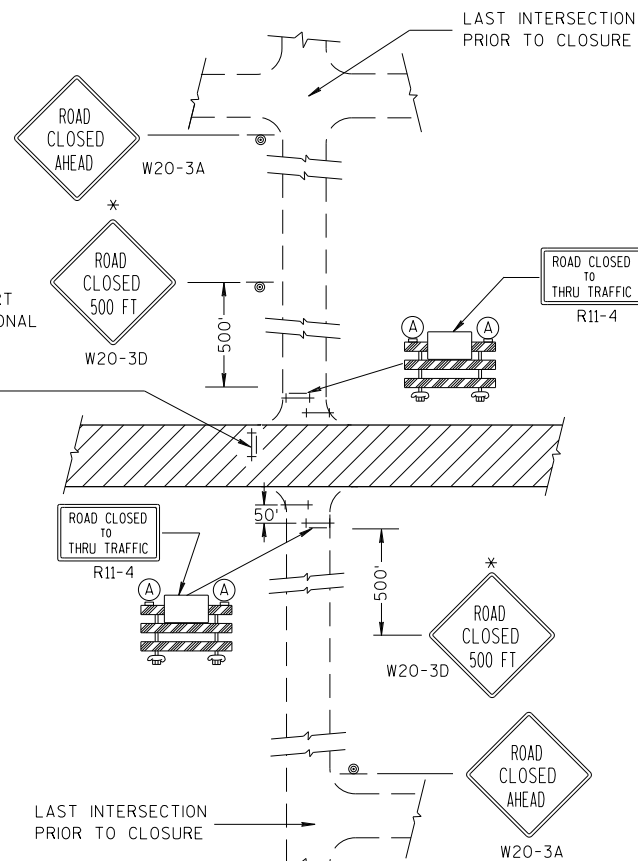

DETAIL 4
(CONTRACTOR, LOCAL BUSINESS AND
RESIDENT ACCESS TO PROJECT)

GENERAL NOTES

THE EXACT NUMBER, LOCATION, AND SPACING OF ALL SIGNS AND BARRICADES SHALL BE ADJUSTED TO FIT FIELD CONDITIONS AS APPROVED BY THE ENGINEER.

ANY SIGNS TEMPORARY OR EXISTING, WHICH CONFLICT WITH TRAFFIC CONTROL "IN USE" SHALL BE REMOVED OR COVERED AS NEEDED AND AS APPROVED BY THE ENGINEER.

THE SPACING BETWEEN TRAFFIC CONTROL SIGNS SHOULD BE ADJUSTED TO NOT CONFLICT WITH AND SHOULD PROVIDE A DESIRABLE MINIMUM OF 200 FEET CLEARANCE TO EXISTING SIGNS THAT WILL REMAIN IN PLACE.

IF A "STOP" SIGN MUST BE REMOVED FOR A WORK OPERATION, A TEMPORARY "STOP" SIGN SHALL BE PLACED PRIOR TO THE SIGN REMOVAL, OR A FLAGGER SHALL BE PROVIDED UNTIL THE SIGN IS RE-ESTABLISHED.

BARRICADES THAT MUST BE MOVED FOR A WORK OPERATION SHALL BE IMMEDIATELY RE-ESTABLISHED UPON COMPLETION OF THE OPERATION OR, FOR CONTINUING OPERATIONS, AT THE END OF EACH WORKING DAY.

SIGNS THAT WILL BE IN PLACE LESS THAN 7 CONTINUOUS DAYS AND NIGHTS MAY BE MOUNTED ON PORTABLE SUPPORTS.

ALL TYPE III BARRICADES SHALL HAVE RAILS REFLECTORIZED ON BOTH FACES. STRIPES SHALL BE PROPERLY SLOPED DOWN TOWARD THE TRAFFIC SIDE OR AS SHOWN IN THE ROAD CLOSURE BARRICADE DETAIL D FOR FULL ROAD CLOSURES.

TYPE "A" LOW-INTENSITY FLASHING WARNING LIGHTS SHALL BE VISIBLE ON BOTH SIDES OF THE BARRICADE.

THE R11-2, R11-3 AND R11-4 SIGNS PLACED ON BARRICADES SHALL COVER NO MORE THAN THE TOP RAIL. THE SIGNS SHALL NOT COVER ANY PORTION OF THE MIDDLE OR BOTTOM RAILS.

ALL SIGNS SHALL BE 48" X 48" UNLESS OTHERWISE NOTED BELOW:

R11-2 SHALL BE 48" X 30".

R11-4 AND R11-3 SHALL BE 60" X 30".

*OMIT THE "ROAD CLOSED 500 FT." SIGN IF THE LAST INTERSECTION IS 500 FT. OR LESS FROM THE WORK ZONE.

**500' MAX. OR AT LAST INTERSECTION WHICHEVER IS CLOSER.


LEGEND

- SIGN ON PERMANENT SUPPORT
- TYPE III BARRICADE
- TYPE III BARRICADE WITH ATTACHED SIGN
- TYPE "A" WARNING LIGHT (FLASHING)
- WORK AREA

BARRICADES AND SIGNS FOR SIDEROAD CLOSURES

STATE OF WISCONSIN
DEPARTMENT OF TRANSPORTATION

APPROVED
7/2018 /S/ Andrew Heidtke
DATE WORK ZONE ENGINEER
FHWA

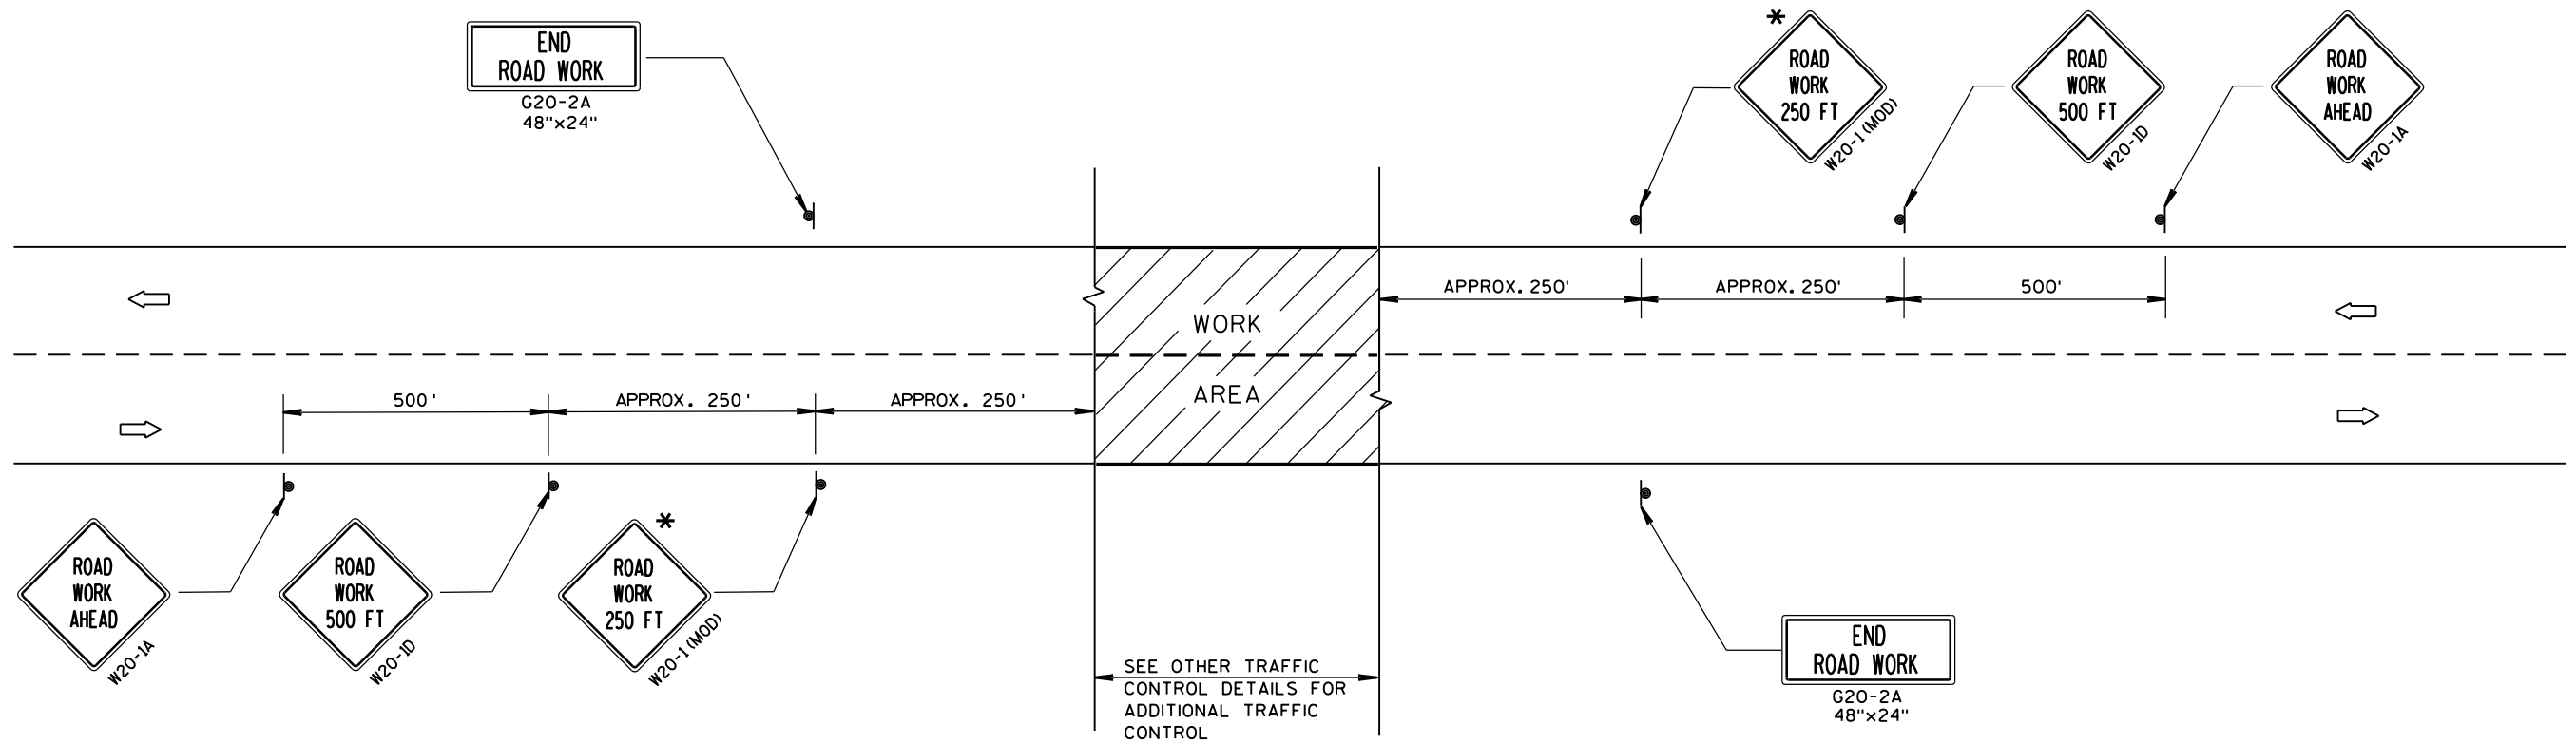

TYPICAL SIDEROAD APPROACH WARNING SIGN DETAIL

GENERAL NOTES

THE EXACT NUMBER, LOCATION, AND SPACING OF ALL SIGNS AND DEVICES SHALL BE ADJUSTED TO FIT FIELD CONDITIONS.


THE SPACING BETWEEN TRAFFIC CONTROL SIGNS SHOULD BE ADJUSTED TO NOT CONFLICT WITH AND SHOULD PROVIDE A DESIRABLE MINIMUM OF 200 FEET CLEARANCE TO EXISTING SIGNS THAT WILL REMAIN IN PLACE.

ALL SIGNS ARE 48"x48" UNLESS OTHERWISE NOTED. IF NECESSARY DUE TO SPACE CONSTRAINTS, 36"x36" SIGNS MAY BE USED INSTEAD OF 48"x48" SIGNS.

SIGNS THAT WILL BE IN PLACE LESS THAN 7 CONTINUOUS DAYS AND NIGHTS MAY BE MOUNTED ON PORTABLE SUPPORTS.

IF A "STOP" SIGN MUST BE REMOVED FOR A WORK OPERATION, A TEMPORARY "STOP" SIGN SHALL BE PLACED PRIOR TO THE SIGN REMOVAL, OR A FLAGGER SHALL BE PROVIDED UNTIL THE SIGN IS RE-ESTABLISHED.

* THE THIRD W20-1 SIGN IS REQUIRED ONLY IF THERE IS AN INTERSECTION BETWEEN THE "ROAD WORK 500 FT" SIGN AND THE WORK ZONE. ADJUST THE PLACEMENT OF THIS SIGN BASED ON INTERSECTION LOCATION AND OTHER FIELD CONDITIONS.

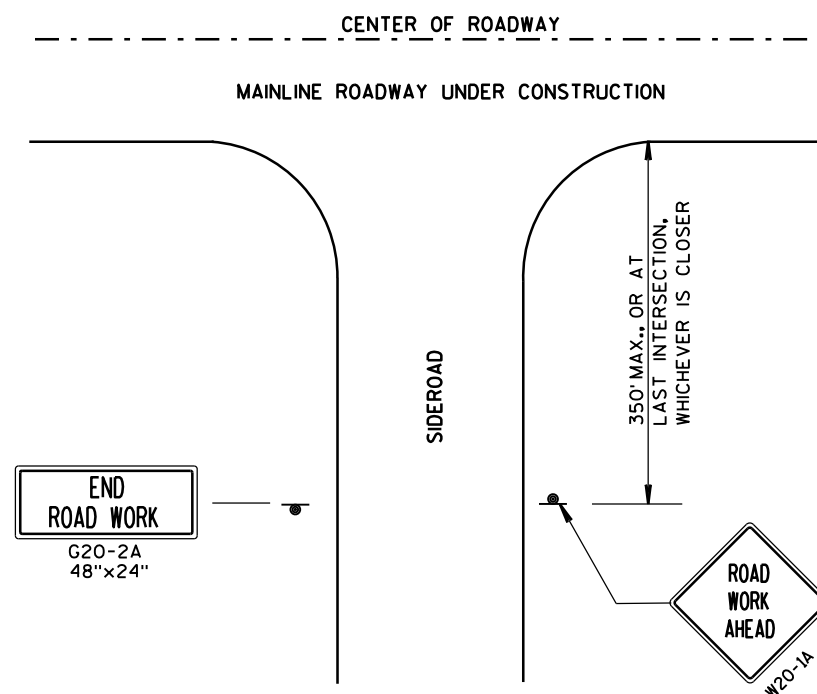


LEGEND

- SIGN ON PERMANENT SUPPORT
- DIRECTION OF TRAFFIC
- WORK AREA

TRAFFIC CONTROL, ADVANCE
WARNING SIGNS 40 M.P.H.
OR LESS TWO-WAY UNDIVIDED
ROAD OPEN TO TRAFFIC

STATE OF WISCONSIN
DEPARTMENT OF TRANSPORTATION

APPROVED
Sept. 2017 /S/ Andrew Heldtke
DATE WORK ZONE ENGINEER
FHWA

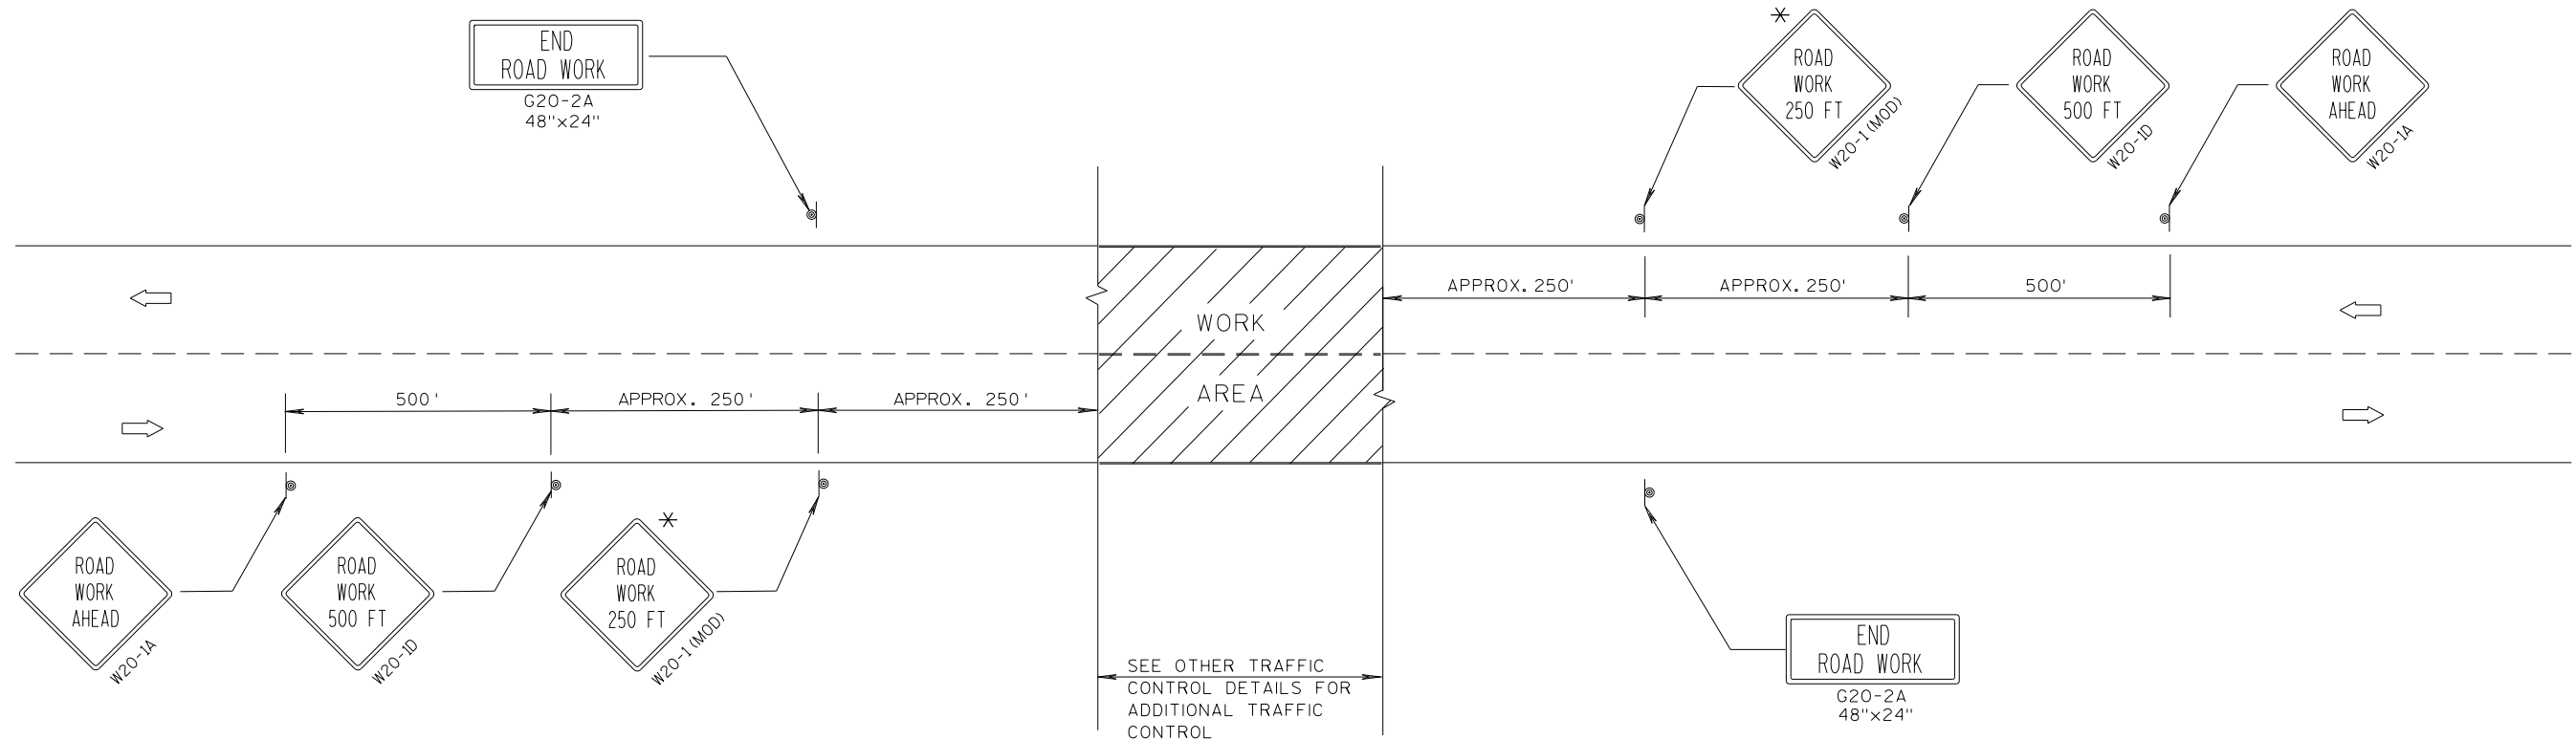

TYPICAL SIDEROAD APPROACH WARNING SIGN DETAIL

GENERAL NOTES

THE EXACT NUMBER, LOCATION, AND SPACING OF ALL SIGNS AND DEVICES SHALL BE ADJUSTED TO FIT FIELD CONDITIONS.


THE SPACING BETWEEN TRAFFIC CONTROL SIGNS SHOULD BE ADJUSTED TO NOT CONFLICT WITH AND SHOULD PROVIDE A DESIRABLE MINIMUM OF 200 FEET CLEARANCE TO EXISTING SIGNS THAT WILL REMAIN IN PLACE.

ALL SIGNS ARE 48"x48" UNLESS OTHERWISE NOTED. IF NECESSARY DUE TO SPACE CONSTRAINTS, 36"x36" SIGNS MAY BE USED INSTEAD OF 48"x48" SIGNS.

SIGNS THAT WILL BE IN PLACE LESS THAN 7 CONTINUOUS DAYS AND NIGHTS MAY BE MOUNTED ON PORTABLE SUPPORTS.

IF A "STOP" SIGN MUST BE REMOVED FOR A WORK OPERATION, A TEMPORARY "STOP" SIGN SHALL BE PLACED PRIOR TO THE SIGN REMOVAL, OR A FLAGGER SHALL BE PROVIDED UNTIL THE SIGN IS RE-ESTABLISHED.


* THE THIRD W20-1 SIGN IS REQUIRED ONLY IF THERE IS AN INTERSECTION BETWEEN THE "ROAD WORK 500 FT" SIGN AND THE WORK ZONE. ADJUST THE PLACEMENT OF THIS SIGN BASED ON INTERSECTION LOCATION AND OTHER FIELD CONDITIONS.

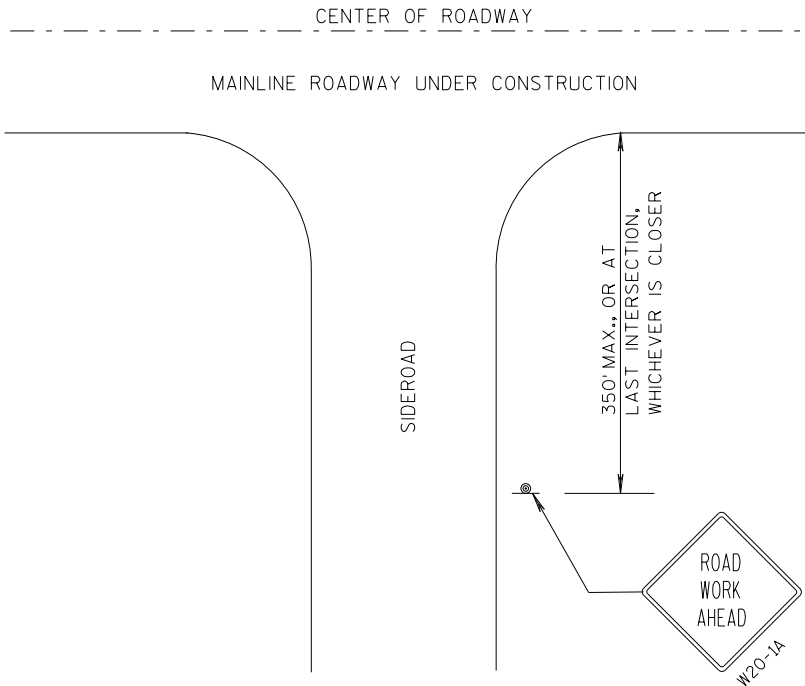

LEGEND

- ⊙ SIGN ON PERMANENT SUPPORT
- ➡ DIRECTION OF TRAFFIC
- ▨ WORK AREA

TRAFFIC CONTROL. ADVANCE WARNING SIGNS 40 M.P.H. OR LESS TWO-WAY UNDIVIDED ROAD OPEN TO TRAFFIC	
STATE OF WISCONSIN DEPARTMENT OF TRANSPORTATION	
APPROVED 7/2018 DATE	/S/ Andrew Heidtke WORK ZONE ENGINEER
FHWA	

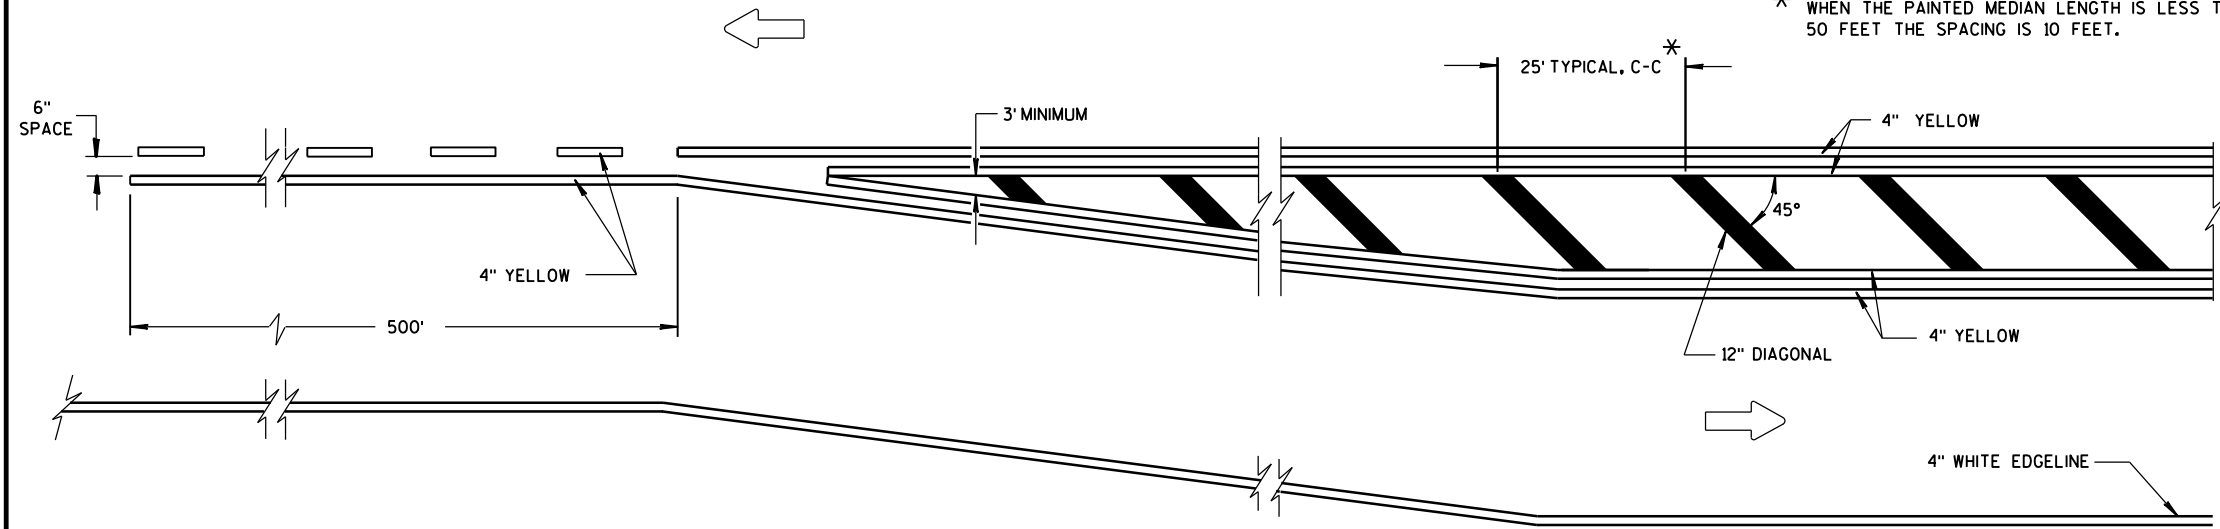


GENERAL NOTE


DIAGONALS ARE OPTIONAL WHEN PAINTED ISLAND IS LESS THAN 6 FEET AT WIDEST POINT.

➡ DIRECTION OF TRAVEL

MEDIAN ISLAND DETAIL

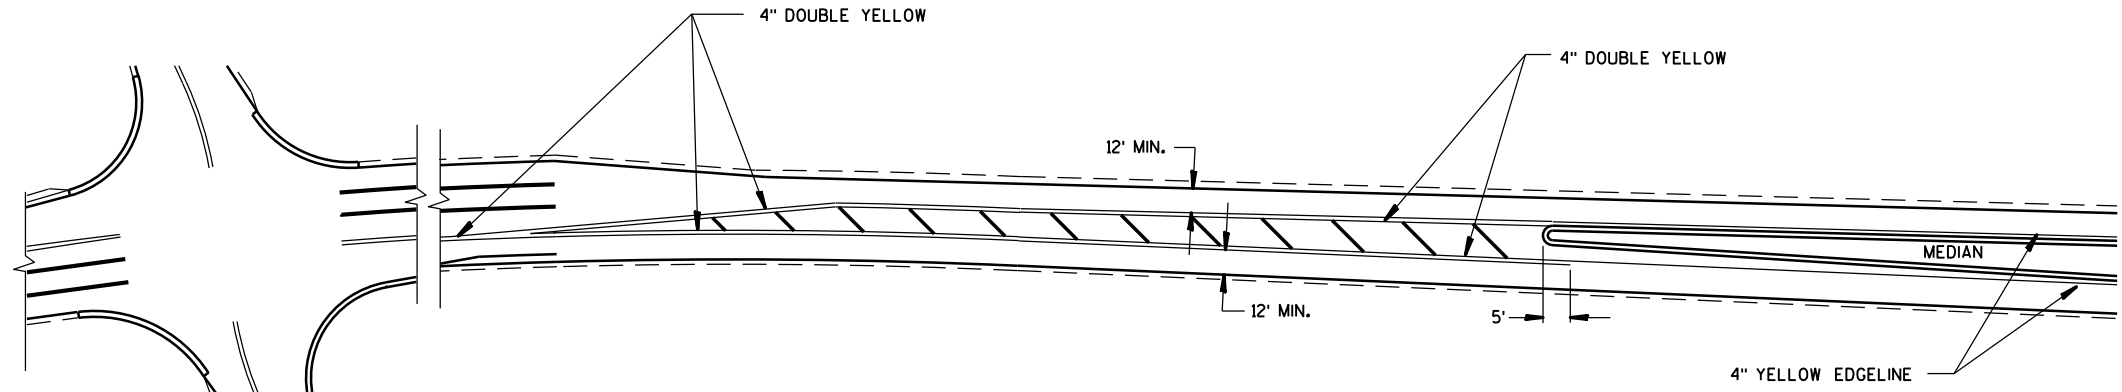

APPROACH MARKINGS FOR OTHER MEDIAN TYPES

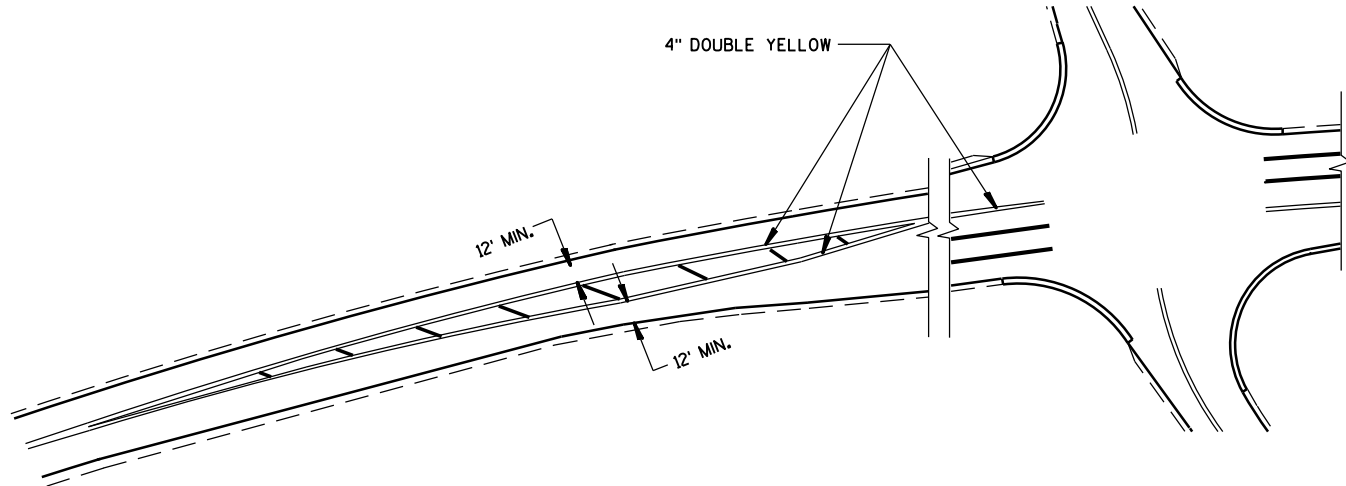

NON APPROACH MARKINGS


MEDIAN ISLAND MARKING	
STATE OF WISCONSIN DEPARTMENT OF TRANSPORTATION	
APPROVED June 2017 DATE	/S/ Matthew Rauch STATE SIGNING AND MARKING ENGINEER FHWA

6


6

S.D.D. 15 C 18-4

S.D.D. 15 C 18-4

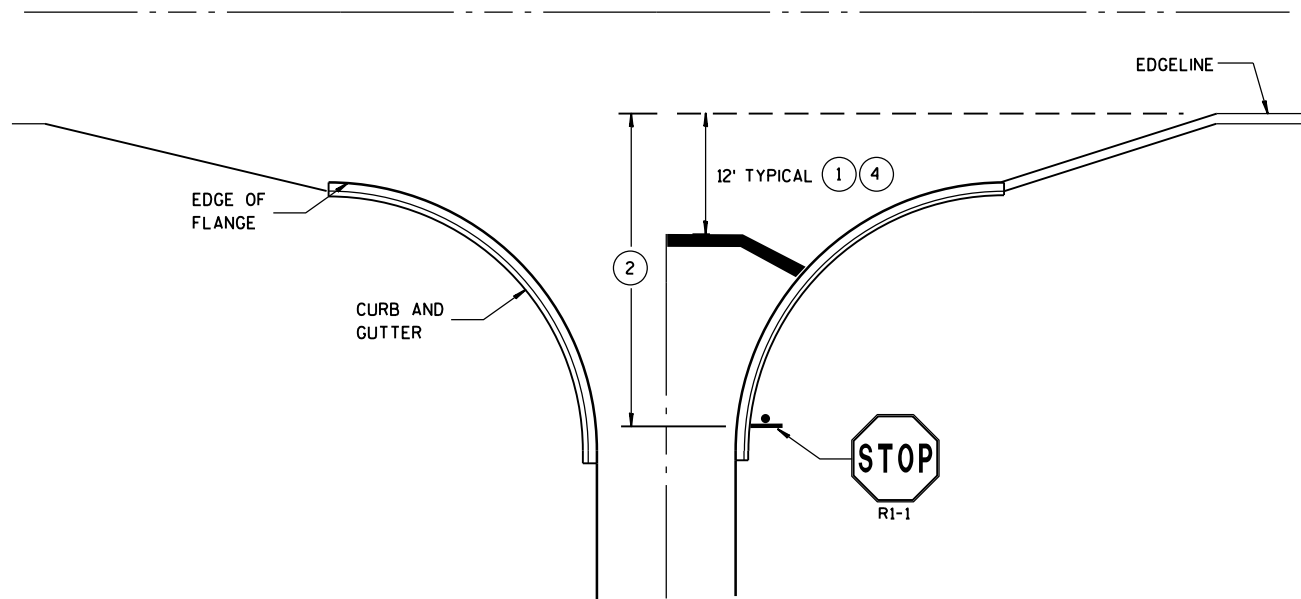

TYPICAL STOP LINE PAVEMENT MARKING
WITH CURB AND GUTTER

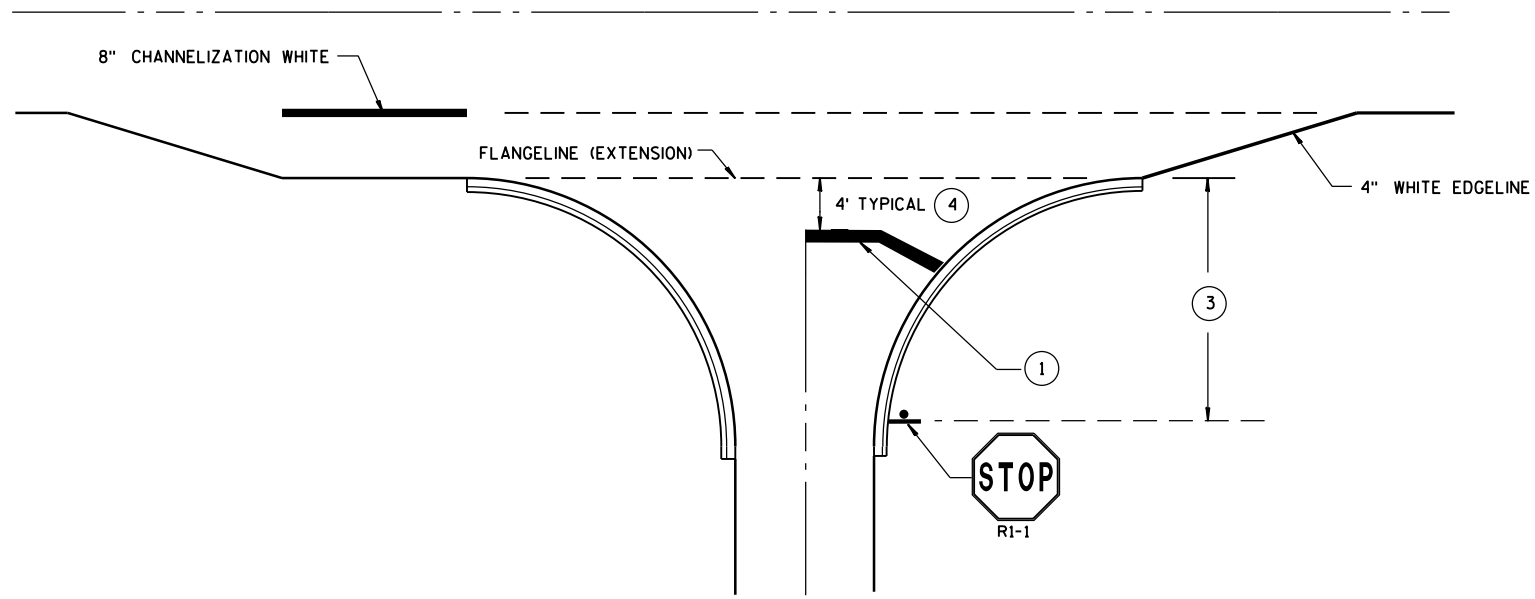


TYPICAL STOP LINE PAVEMENT MARKING
FOR SIDEROADS WITH RIGHT TURN LANE


GENERAL NOTES

STOP SIGN SHALL BE PLACED A MINIMUM OF 6 FEET TO A MAXIMUM OF 50 FEET FROM THE EDGE LINE LOCATION.

- 1 18-INCH STOP LINES MAY BE DELETED OR ADDED BY THE PROJECT ENGINEER BASED ON VISIBILITY AND SIGHT LINES.
- 2 IF STOP SIGN IS LESS THAN OR EQUAL TO 40 FEET FROM THE EDGE LINE THAN NO STOP LINE IS REQUIRED.
- 3 IF STOP SIGN IS LESS THAN OR EQUAL TO 30 FEET FROM THE FLANGELINE EXTENSION THAN NO STOP LINE IS REQUIRED.
- 4 MOVE CLOSER TO EDGE OF TRAVEL LANE AS NEEDED FOR VISIBILITY AND SIGHT LINES. (NO CLOSER THAN 4 FEET).

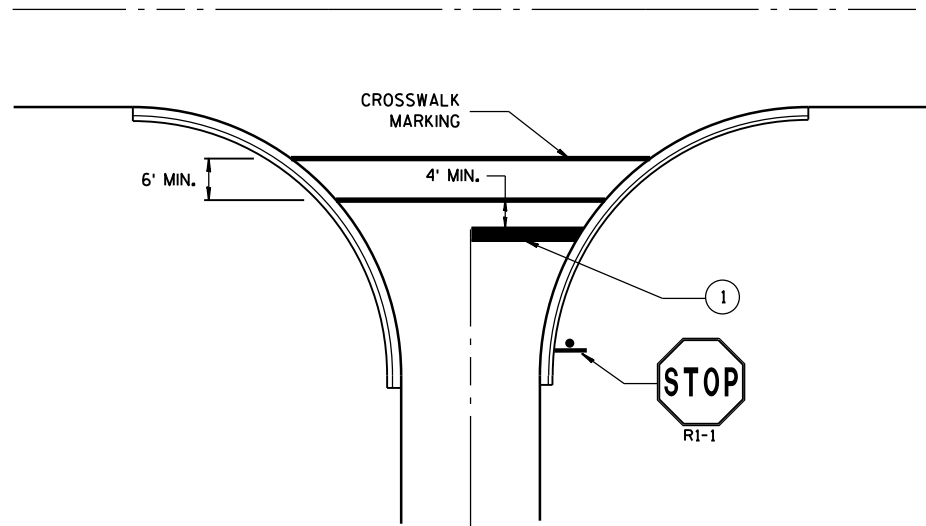


TYPICAL STOP LINE PAVEMENT MARKING
FOR SIDEROADS WITH CROSSWALK MARKING

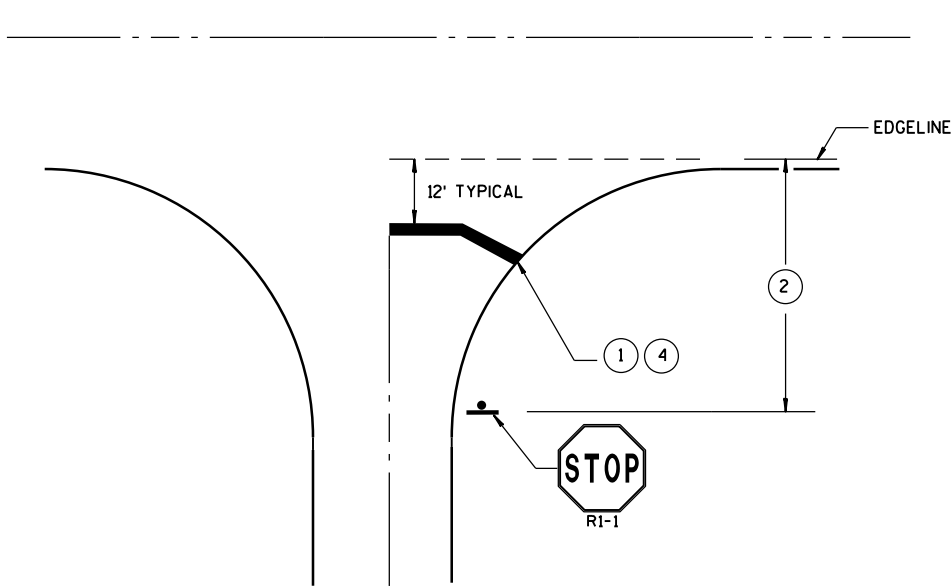

TYPICAL STOP LINE PAVEMENT MARKING
WITHOUT CURB AND GUTTER

STOP LINE AND CROSSWALK PAVEMENT MARKING	
STATE OF WISCONSIN DEPARTMENT OF TRANSPORTATION	
APPROVED DATE Sept., 2017	/S/ Matthew R. Rauch STATE SIGNING AND MARKING ENGINEER
FHWA	

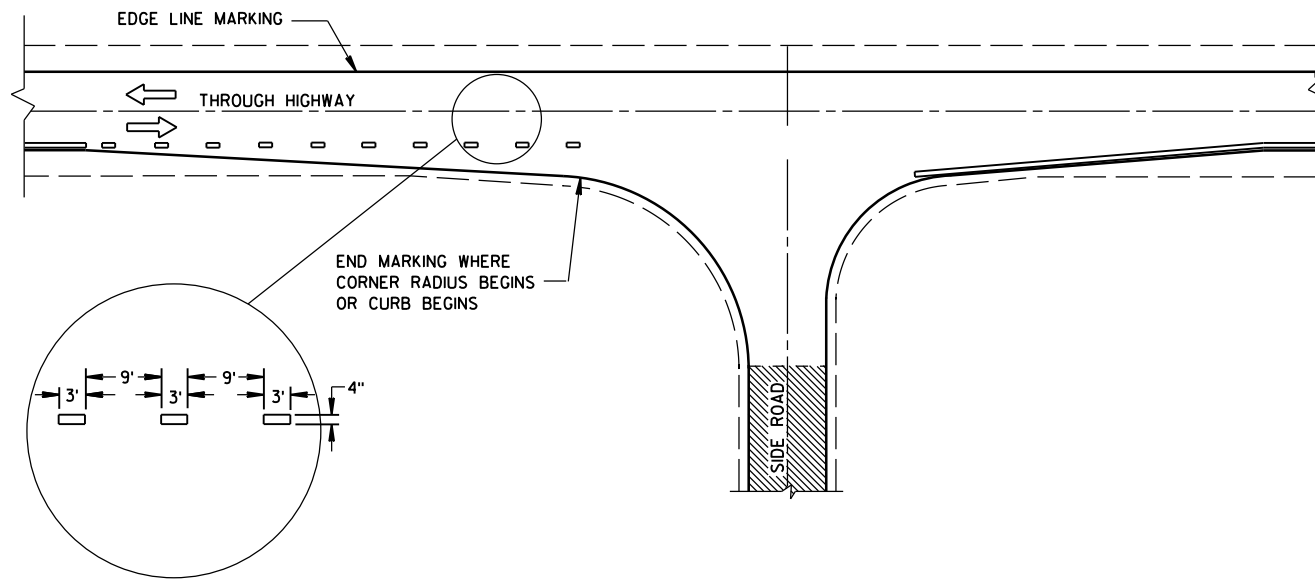


MINOR INTERSECTION

GENERAL NOTES

OMIT EDGE LINES THROUGH INTERSECTIONS. CONTINUE EDGE LINES THROUGH DRIVEWAYS.

- ① WHEN DISTANCE "A" IS LESS THAN 250 FEET, OMIT LANE LINE.
- ② WHEN DISTANCE "B" IS LESS THAN 100 FEET, OMIT CHANNELIZING LANE LINE.
- ③ BARRIER LINE ENDS AT SIDE ROAD PAVEMENT/SURFACE EDGE EXTENSION.
- ④ BARRIER LINE STARTS 500 FEET PRIOR TO THE BYPASS TAPER.


ARROW SYMBOL () SHOWS DIRECTION OF TRAVEL

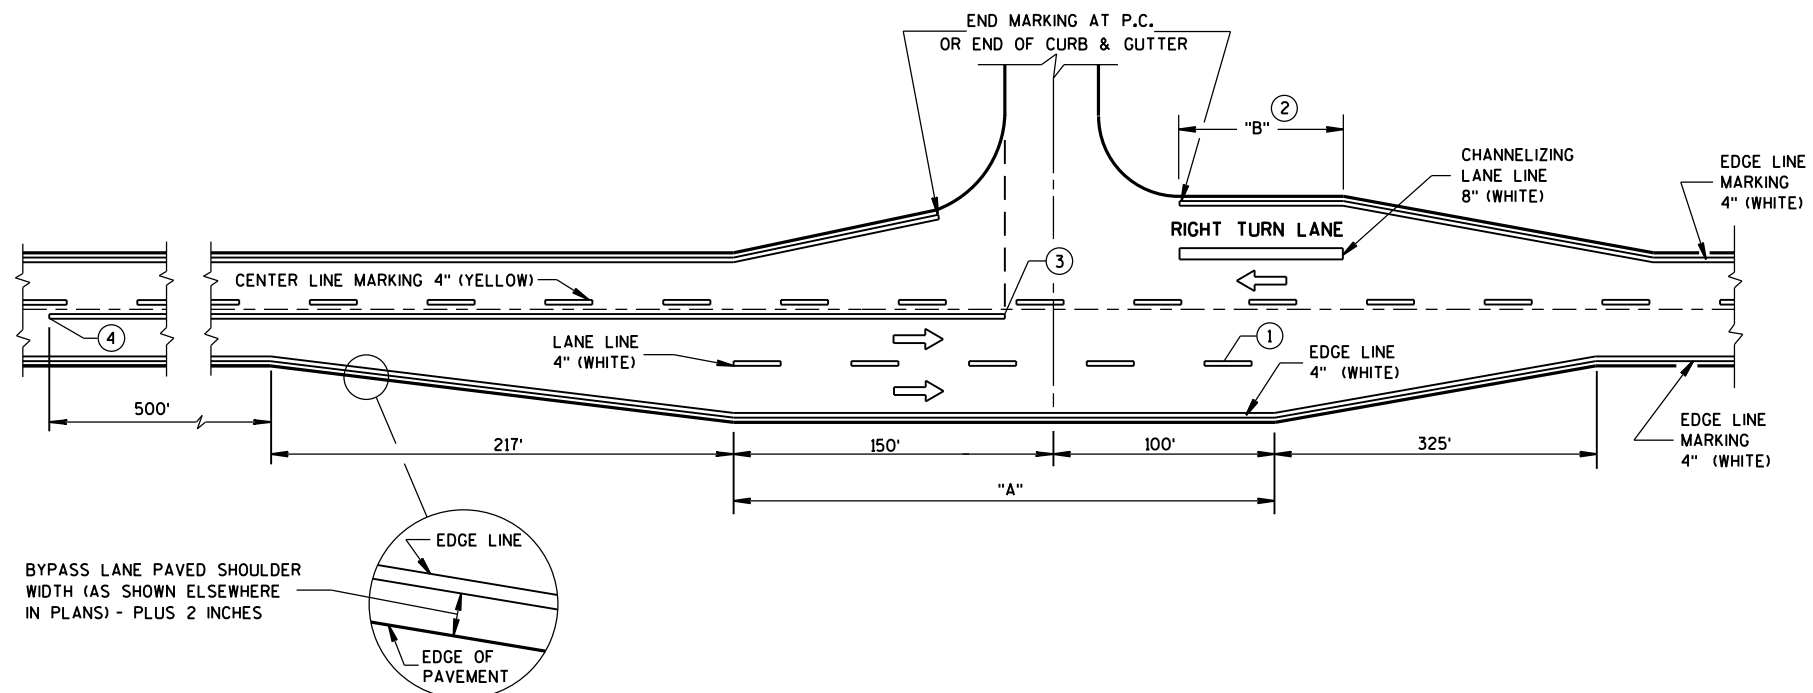


MAJOR INTERSECTIONS
(INTERSECTION WITH FULL RIGHT TURN LANE OR BYPASS LANE)

**PAVEMENT MARKING
(INTERSECTIONS)**

STATE OF WISCONSIN
DEPARTMENT OF TRANSPORTATION

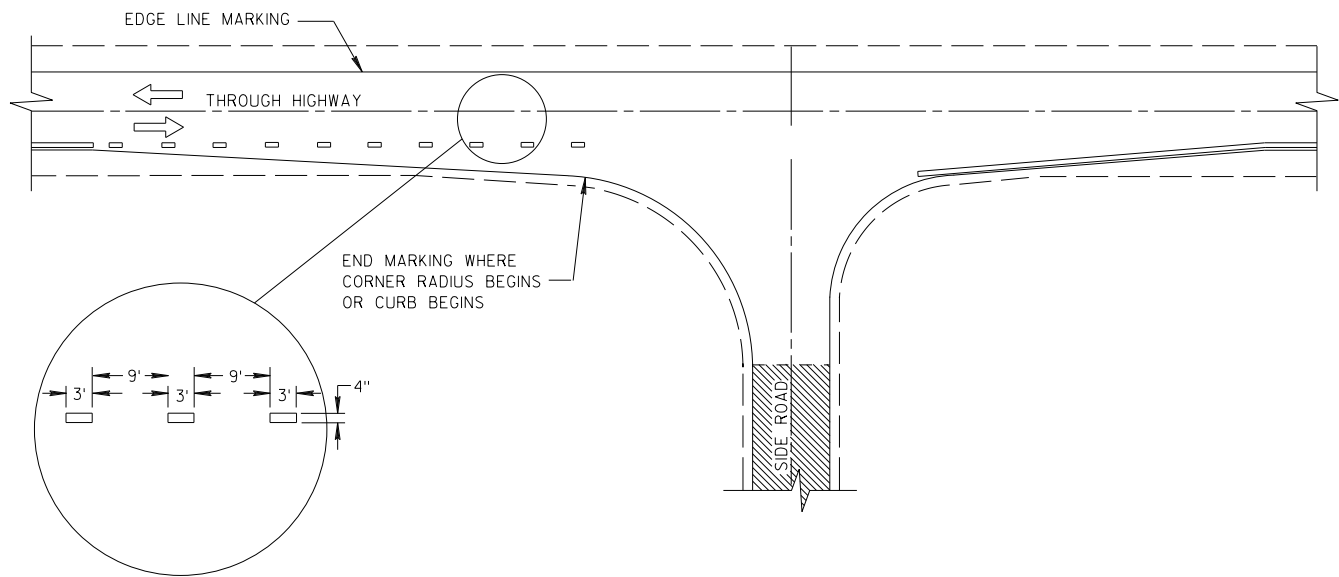

MINOR INTERSECTION

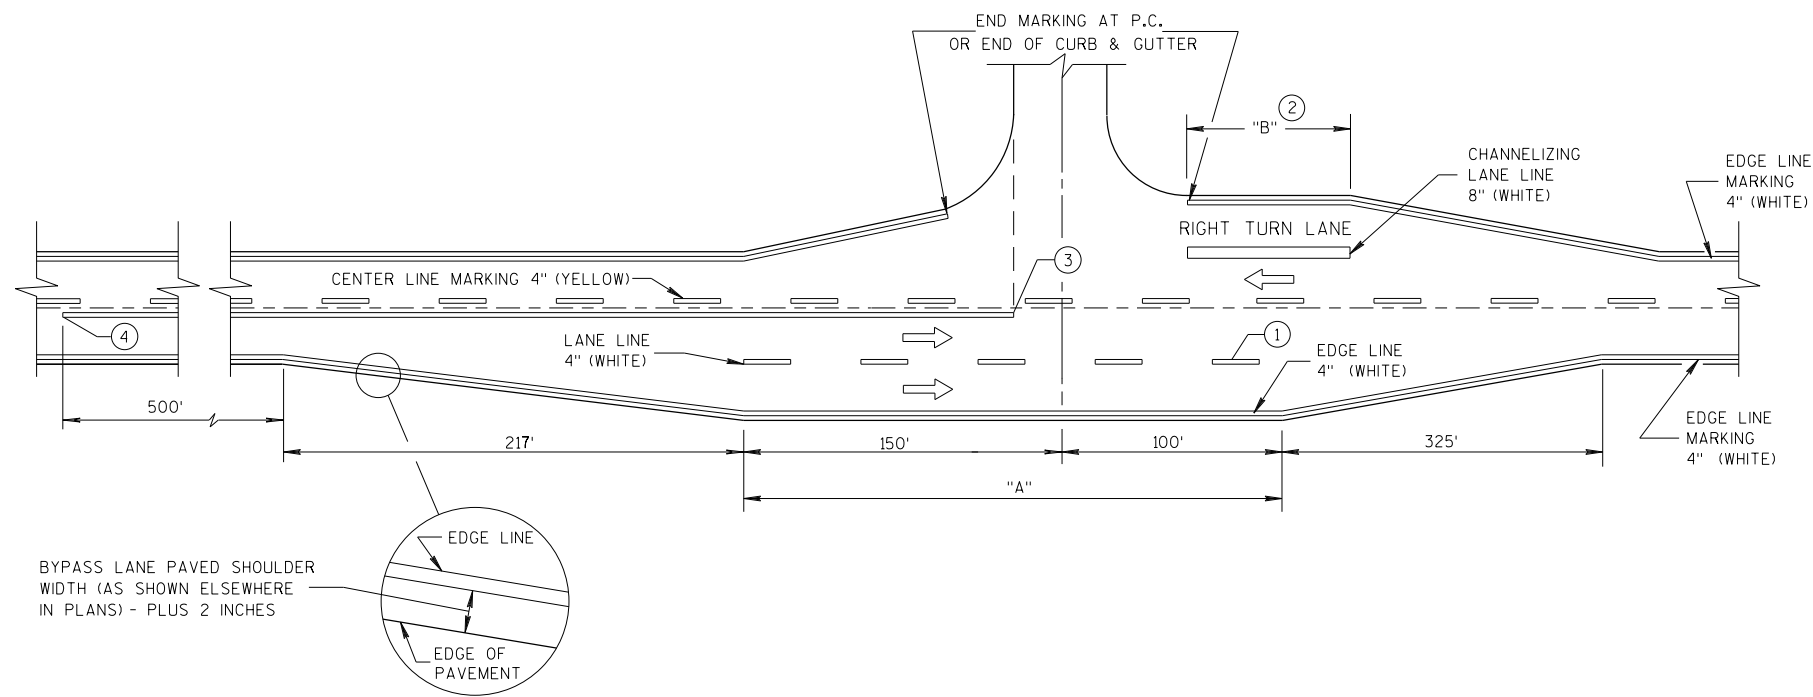


MAJOR INTERSECTIONS
(INTERSECTION WITH FULL RIGHT TURN LANE OR BYPASS LANE)

GENERAL NOTES


OMIT EDGE LINES THROUGH INTERSECTIONS. CONTINUE EDGE LINES THROUGH DRIVEWAYS.

- ① WHEN DISTANCE "A" IS LESS THAN 250 FEET, OMIT LANE LINE.
- ② WHEN DISTANCE "B" IS LESS THAN 100 FEET, OMIT CHANNELIZING LANE LINE.
- ③ BARRIER LINE ENDS AT SIDE ROAD PAVEMENT/SURFACE EDGE EXTENSION.
- ④ BARRIER LINE STARTS 500 FEET PRIOR TO THE BYPASS TAPER.


ARROW SYMBOL (➡) SHOWS DIRECTION OF TRAVEL

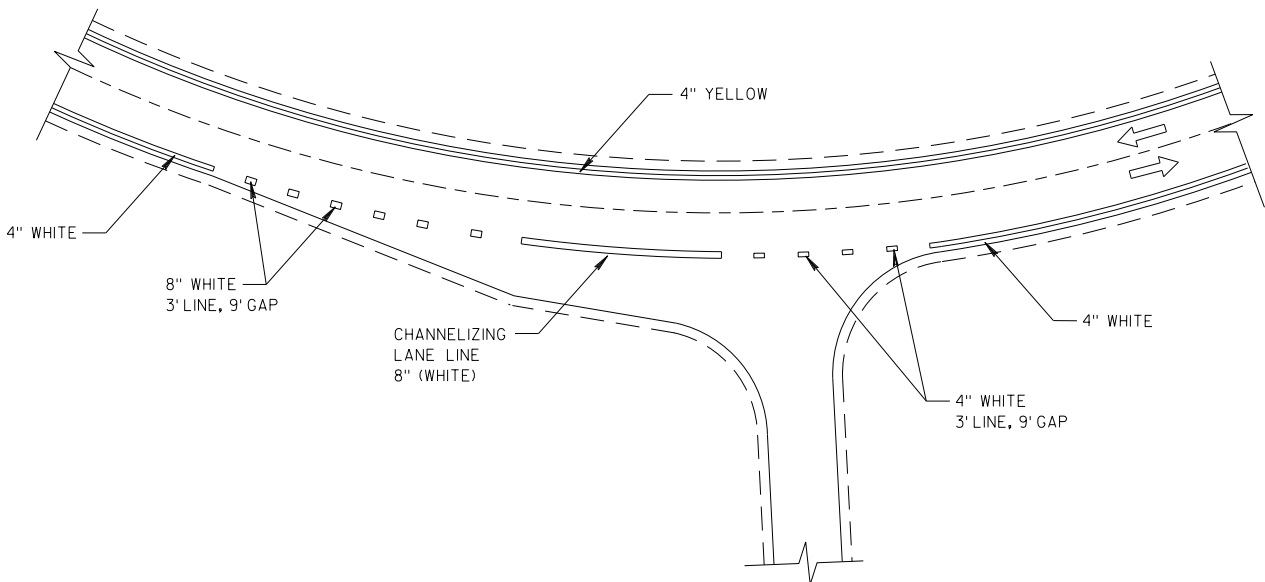

INTERSECTION ON OUTSIDE OF CURVE

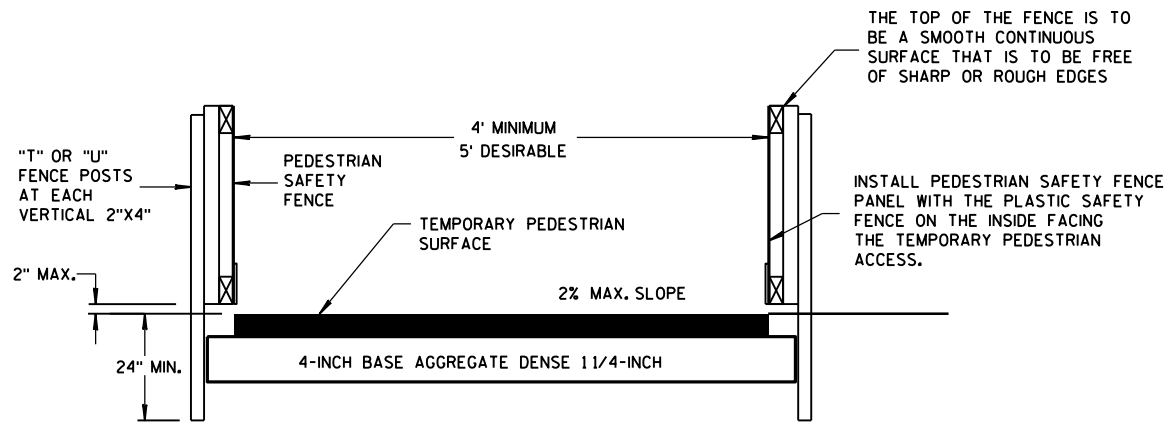


TEMPORARY PEDESTRIAN ACCESS

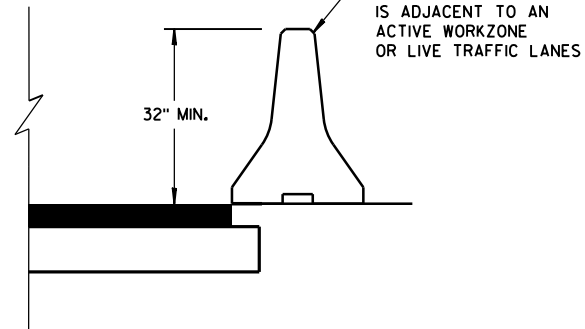


GENERAL NOTES


- ① INTERCHANGEABLE WITH THE PEDESTRIAN SAFETY FENCE.

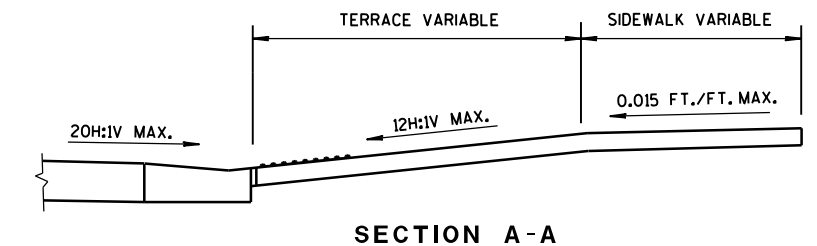


SECTION A-A

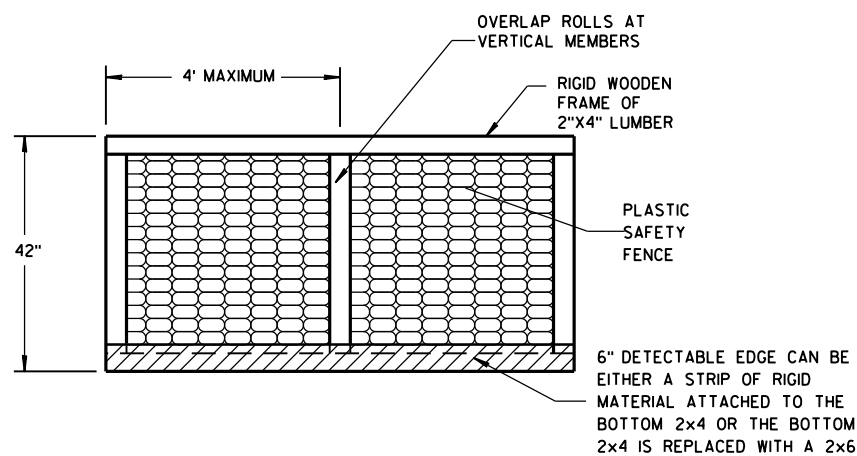

PEDESTRIAN SAFETY FENCE

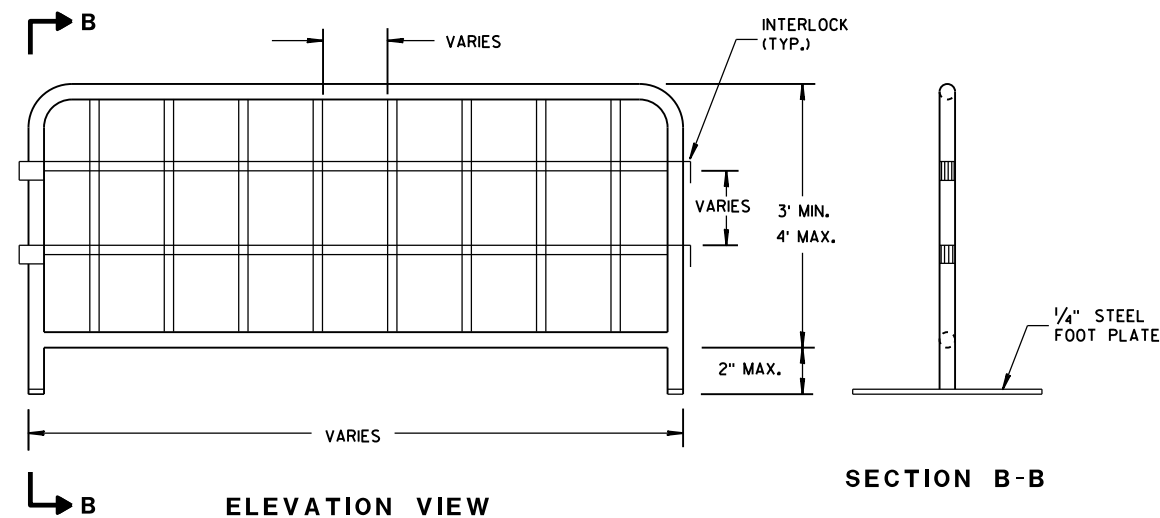


TEMPORARY PEDESTRIAN STEEL BARRICADE

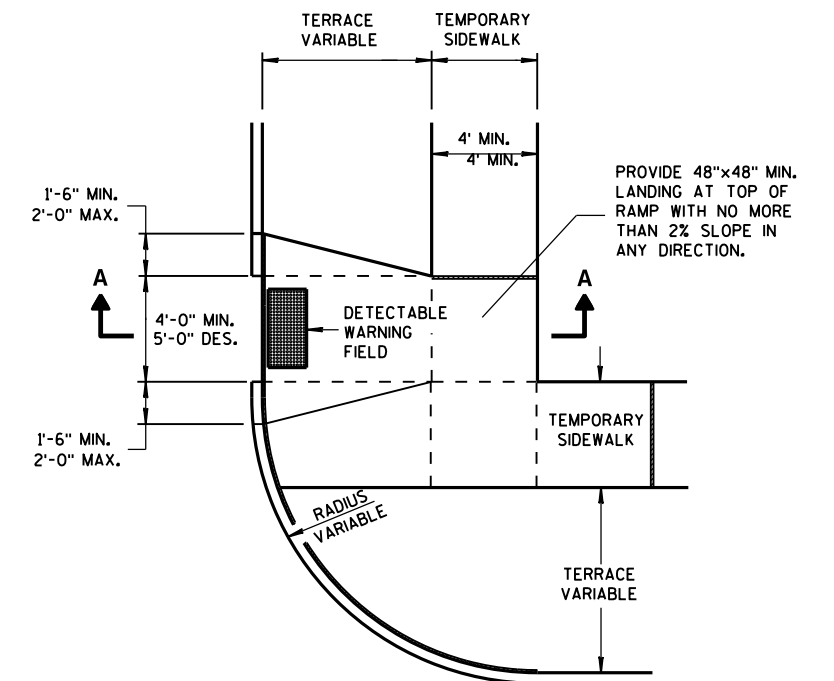


PLAN VIEW

TEMPORARY TYPE 3 RAMP

(OUTSIDE OF CROSSWALK AREA)

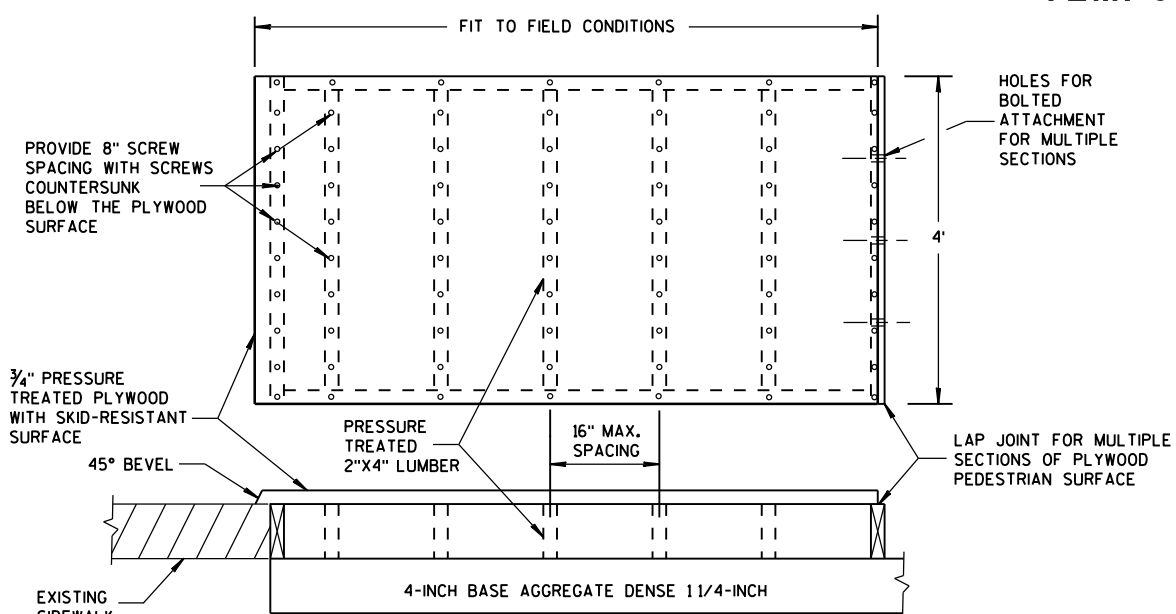


TEMPORARY PEDESTRIAN SURFACE PLYWOOD

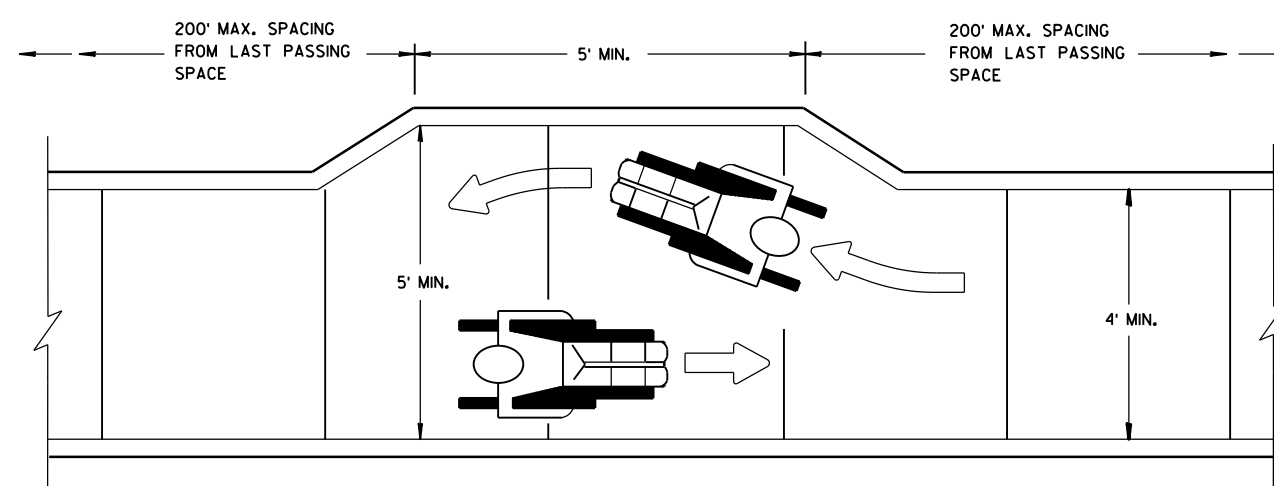


NARROW SIDEWALK PASSING DETAIL

TRAFFIC CONTROL, PEDESTRIAN ACCOMMODATION	
STATE OF WISCONSIN DEPARTMENT OF TRANSPORTATION	
APPROVED June 2016 DATE	/S/ Peter Amakobe Atepe STATEWIDE WORK ZONE TRAFFIC SAFETY ENGINEER
FHWA	


TYPICAL ASSEMBLIES

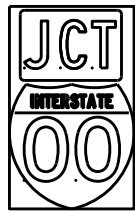

J1-1

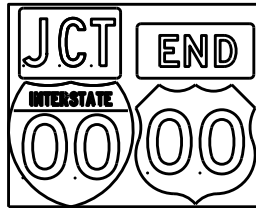


J1-2

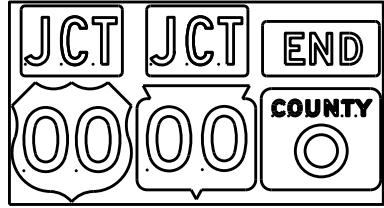


J1-3




J2-1

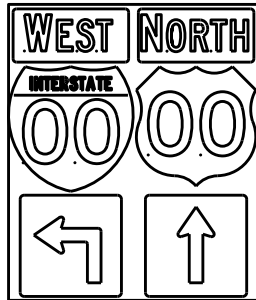


J2-2

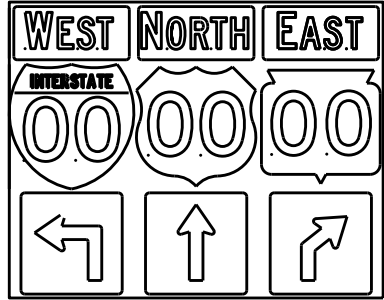


J2-3

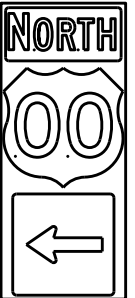

J3-1

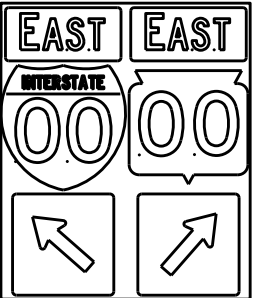


J3-2

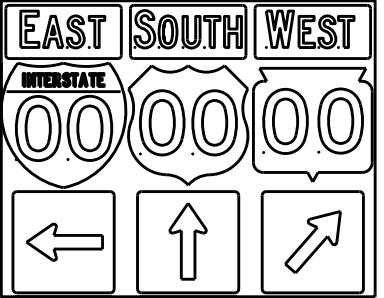


J3-3




J4-1

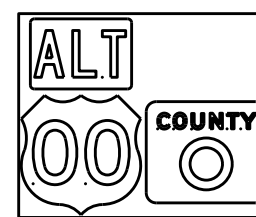

J4-2

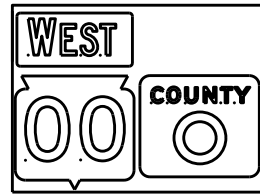

J4-2

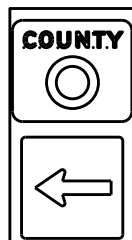

J13-1



J12-1



J32-1



J33-1



J23-1




J22-1



JV



(Typical Vertical J-Assembly
See Note 10 and 11)

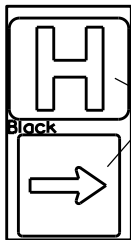

JH-1

Blue Background

[blue background
with interstate]

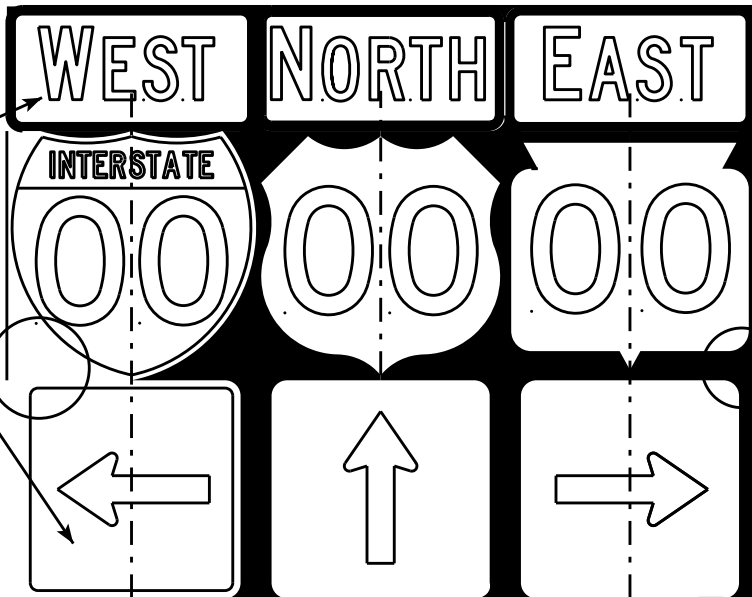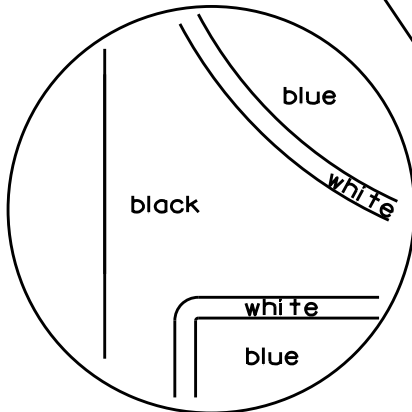

[black background]

ROUTE MARKERS & COMPONENTS
IN TYPICAL ASSEMBLIES

WISCONSIN DEPT OF TRANSPORTATION



APPROVED *Matthew R. Rauch*
For State Traffic Engineer

DATE 2/06/14 PLATE NO. A2-1S.8

NOTES


1. Signs are Type II - Type H Reflective - reference WIS DOT Standard Specification for HIGHWAY and STRUCTURE CONSTRUCTION latest edition.
2. Color:
Background - Black Non-reflective
Message - see Note 5
3. Message Series - See Note 5
4. Corners shall be square or rounded if base material is plywood. If base material is metal the corners shall be rounded.
5. The colors and message spacing on each marker shall be according to the applicable route marker panel specifications.
6. Certain marker heads require the component pieces to be the same color. As an example, all the components used with an M1-1 Interstate marker shall be blue.
7. Single panel j-assemblies shall only be used with route marker shields that are same size. If the route marker shields are different size use multiple piece component.
8. Route assemblies that have 24 inch route shields and have dimensions greater than 48 inches (both vertical and horizontal) shall have one horizontal splice between the arrows and route shields. Vertical splices shall not be used on route assemblies with a horizontal dimension of 144 inches or less. The contractor shall not use more than one vertical joint per sign and the joint shall be between route shields.
9. Route assemblies that have 36 inch shields and have dimensions greater than 48 inches (both vertical and horizontal) shall have two horizontal splices. One horizontal splice shall be between the cardinal direction and route shields and the other horizontal splice shall be between the arrows and route shields. Vertical splices shall not be used on route assemblies with a horizontal dimension of 144 or less. The contractor shall not use more than one vertical joint per sign and the joint shall be between route shields.
10. All Vertical J Assemblies are given a Sign Code of JV
11. For JV Assemblies that have a mixture of Interstate and non Interstate shields, arrows and cardinals shall be white on blue.

URBAN AREA

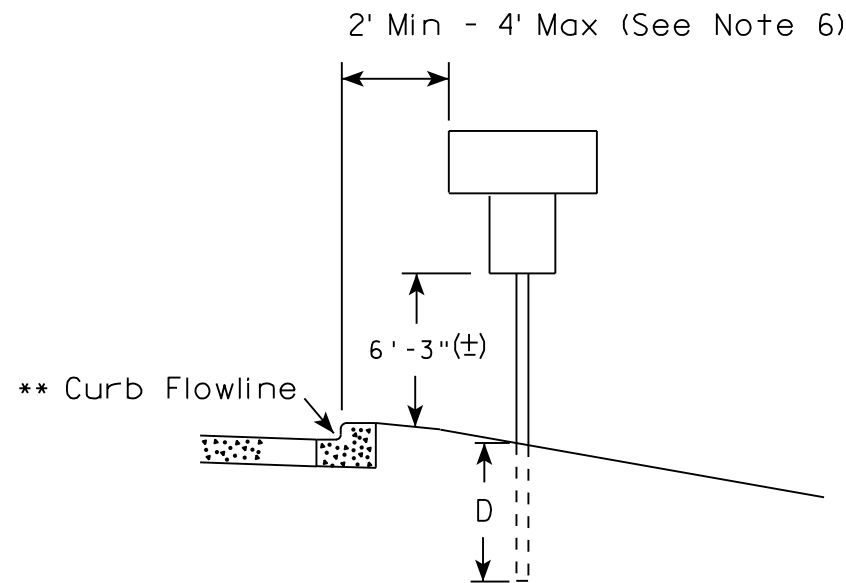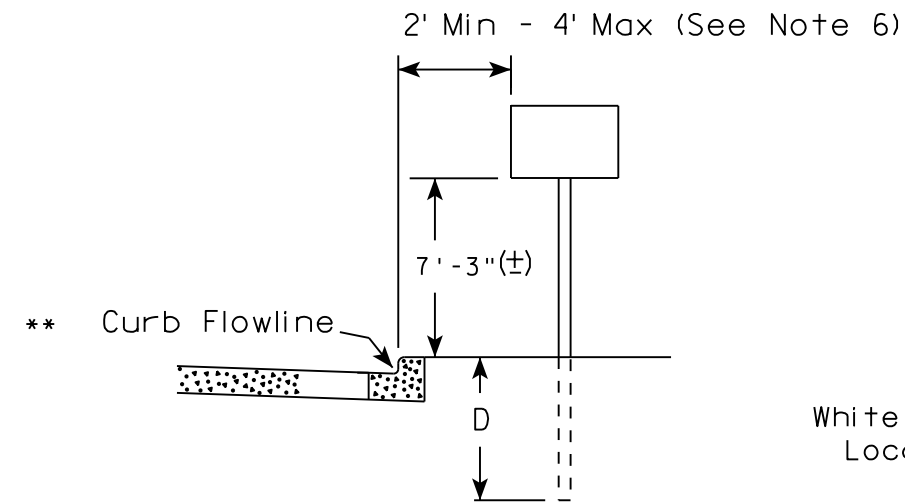


White Edgeline
Location

RURAL AREA (See Note 2)

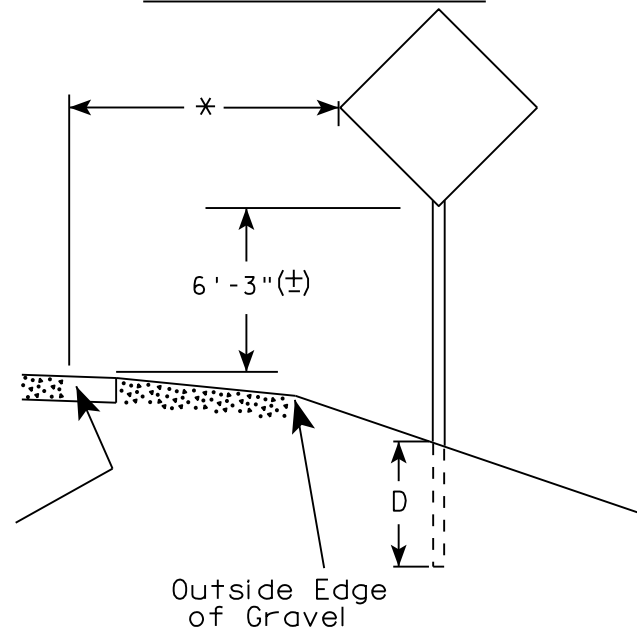

White Edgeline
Location

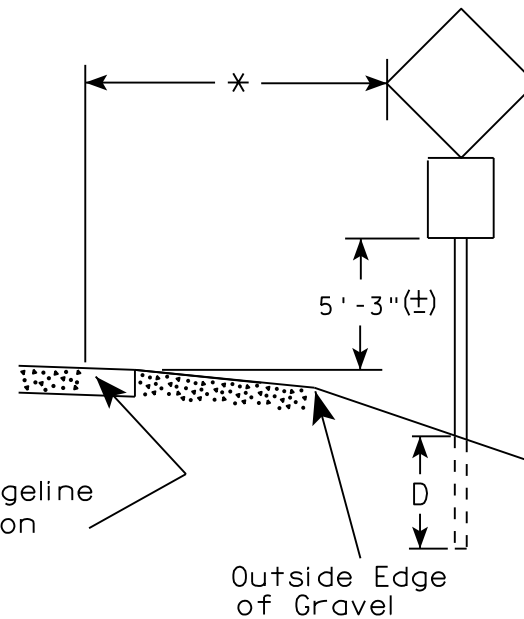

Outside Edge
of Gravel

POST EMBEDMENT DEPTH

Area of Sign Installation (Sq. Ft.)	D (Min)
20 or Less	4'
Greater than 20	5'

GENERAL NOTES

1. Signs wider than 4 feet or 20 sq.ft or larger, shall be mounted on multiple posts. Refer to plate A4-4.
2. If signs are mounted on barrier wall, see A4-10 sign plate.
3. For expressways and freeways, mounting height is 7'- 3" (±) or 6'-3" (±) depending upon existence of a sub-sign.
4. J-Assemblies are considered to be one sign for mounting height.
5. Minimum mounting height for signs mounted on traffic signal poles is 5'- 3" (±).
6. Offset distance shall be consistent with existing signs or consistent throughout length of project.
7. The (±) tolerance for mounting height is 3 inches.
8. Folding signs shall be mounted at a height of 5'-3" (±) or as directed by the Engineer.
9. The Double Arrow sign (W12-1) shall be mounted at a height of 2'-3" (±). The Chevron sign (W1-8), Roundabout Chevron panel (R6-4B), Enhanced Reference Markers, Clearance Markers (W5-52), Mile Markers (D10 series), In Road Object Markers (W5-54) & End of Road Markers (W5-56) shall be mounted at a height of 4'-3" (±).

✱✱ The existence of curb and gutter does not in itself mandate the vertical clearance illustrated. That height is typically measured where there is sidewalk adjacent to the roadway or parking is permitted. In the absence of sidewalk vertical clearance is measured from the top of the curb. Offset of signs is measured from the flow line.

* 6 feet from edge of a paved shoulder or 12 feet from the edge of pavement (edge line location) or 2 feet from outside edge of gravel, whichever is greater unless directed by project engineer.


TYPICAL INSTALLATION
OF PERMANENT TYPE II
SIGNS ON SINGLE POSTS

WISCONSIN DEPT OF TRANSPORTATION

APPROVED *Matthew R. Rauch*
for State Traffic Engineer

DATE 8/21/17 PLATE NO. A4-3.21


PROJECT NO: HWY: COUNTY: SHEET NO: E

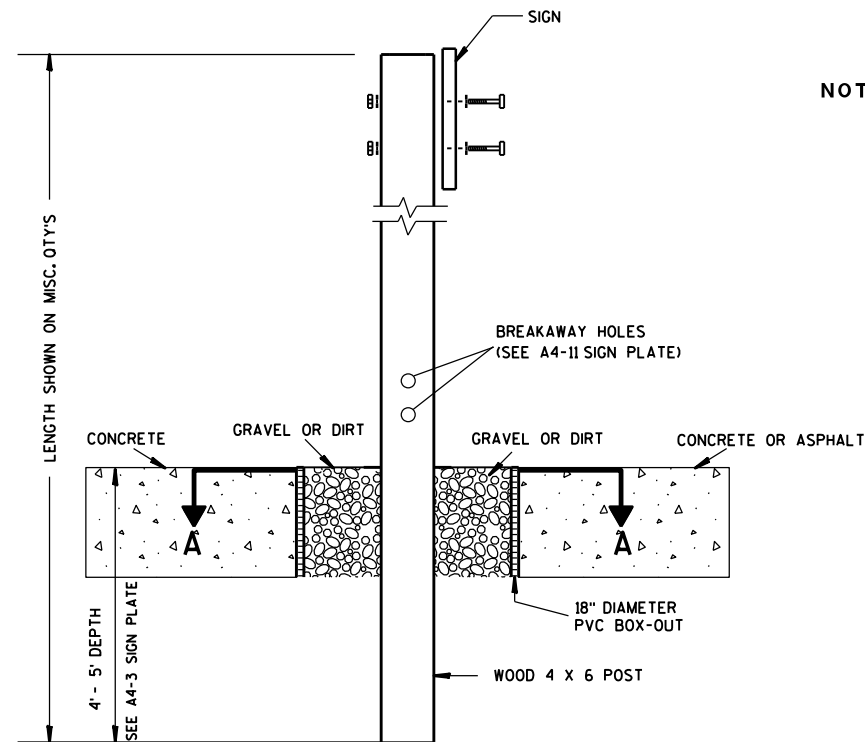

ELEVATION VIEW


DETAIL OF WOOD 4 X 6 SIGN POST IN BOX-OUT

- NOTES: 1. ALL MATERIAL TO BE APPROVED BY ENGINEER PRIOR TO INSTALLATION
2. SEE SIGN PLATE A4-8 FOR SIGN HARDWARE REQUIREMENTS
3. 18 INCH X 18 INCH SQUARE BOX-OUTS MAY BE USED FOR INSTALLATIONS IN EXISTING CONCRETE OR ASPHALT LOCATIONS.

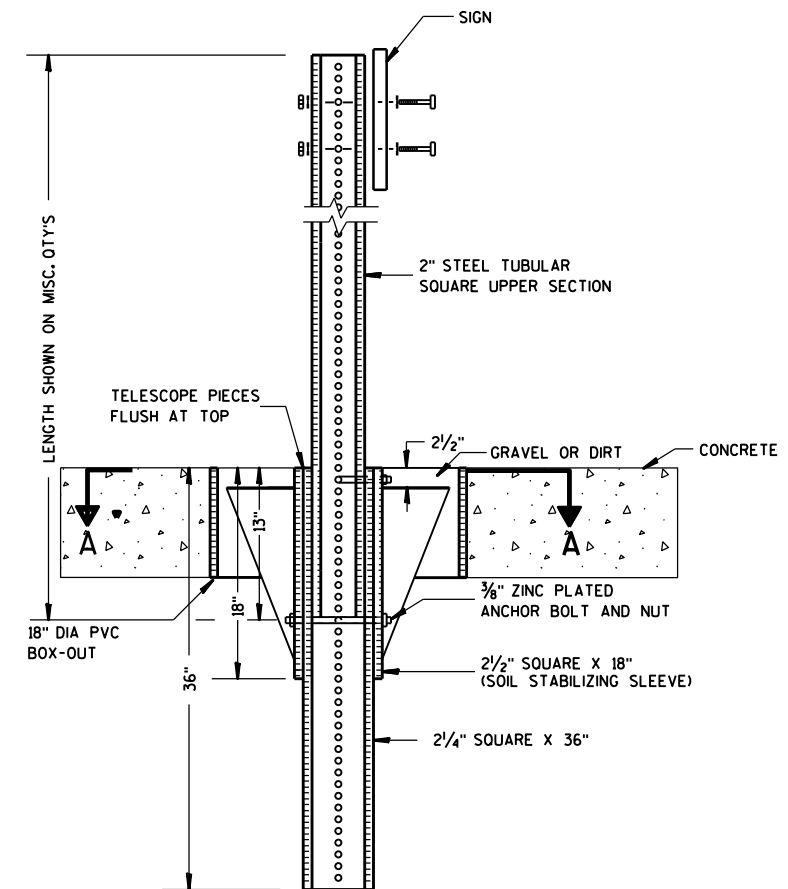

ELEVATION VIEW

DETAIL OF STEEL 2 X 2 SIGN POST IN BOX-OUT

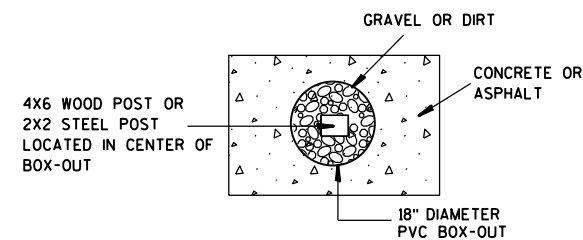

PLAN VIEW


FOR NEW CONCRETE/ASPHALT INSTALLATIONS

SIGN POST
BOX-OUTS
A4-3B

WISCONSIN DEPT OF TRANSPORTATION

APPROVED *Matthew R. Rauch*
for State Traffic Engineer

DATE 1/27/14 PLATE NO. A4-3B.1

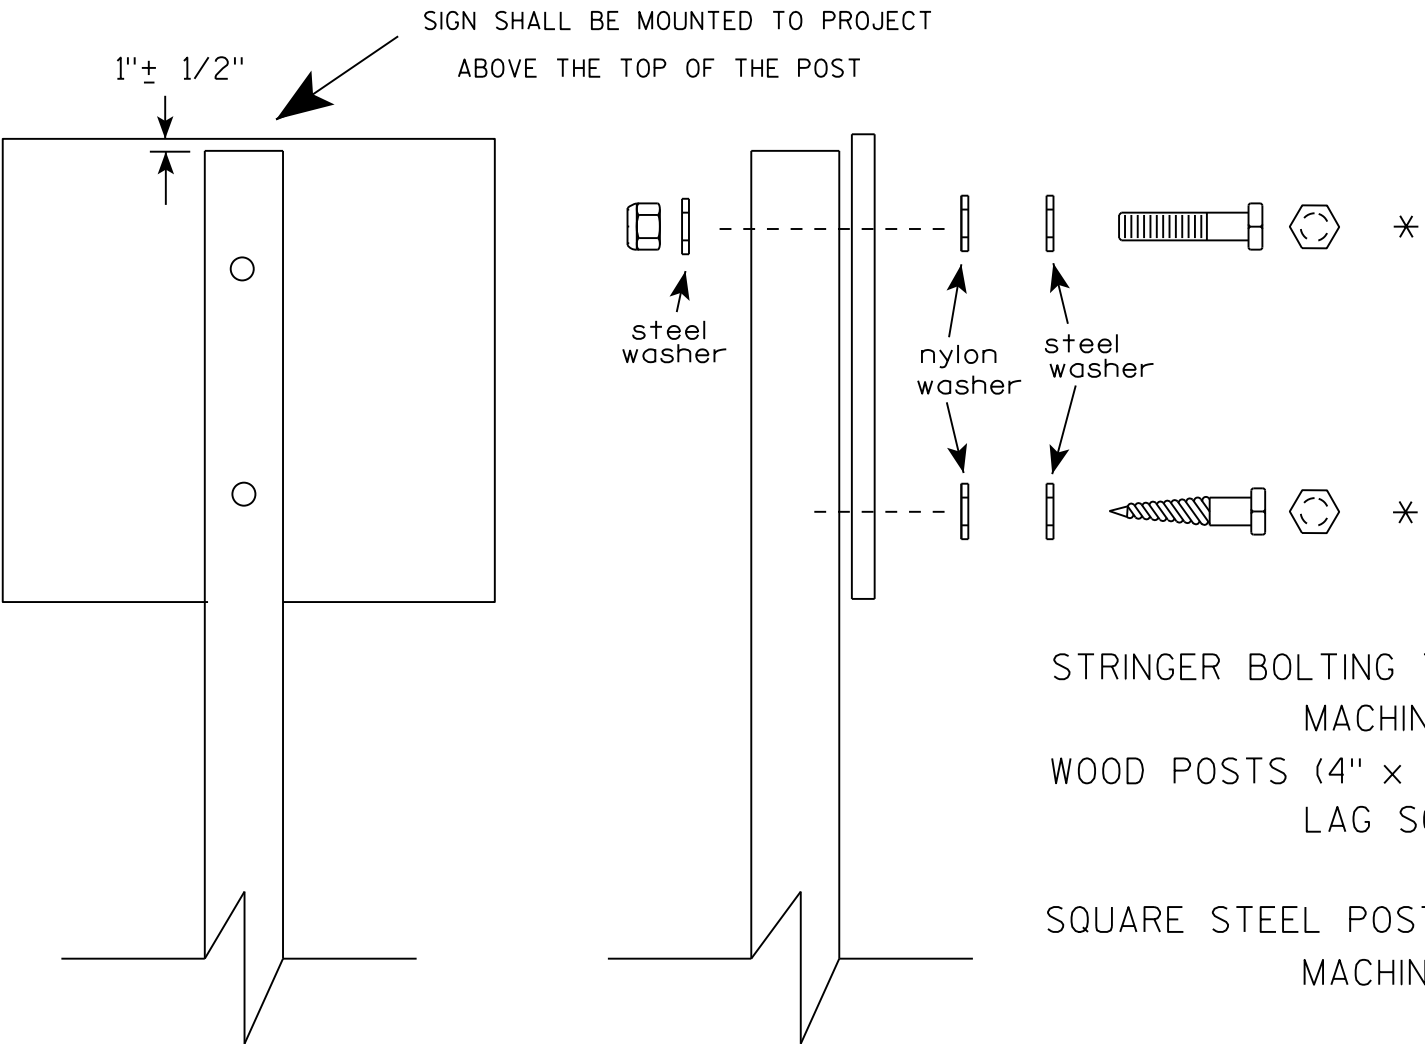

Nuts, bolts and lags used for mounting signs shall have hexagonal heads and shall be either :

- a. Hot dip galvanized in accordance with ASTM Designation: A 153, Class D, or SC 3
- b. Electro-galvanized in accordance with ASTM Designation : B 633, TYPE III, SC 3.


Threads on bolts and nuts shall be manufactured with sufficient allowance for the cadmium plate or galvanized coating to permit the nuts to run freely on the bolts.

- STRINGER BOLTING TO ALUMINUM SIGNS (SEE SIGN PLATE A4-18)
- MACHINE BOLTS - 5/16" X 1-3/4" Length w/ lock nuts
- WOOD POSTS (4" x 4" or 4" x 6")
- LAG SCREWS - 3/8" X 3" (NO STRINGERS ON BACK OF SIGN)
 - 3/8" X 4" (STRINGERS ON BACK OF SIGN)
- SQUARE STEEL POSTS (2" x 2")
- MACHINE BOLTS - 3/8" X 3-1/4" Length w/ nuts (NO STRINGER ON BACK OF SIGN)
 - 3/8" X 5" Length w/ nuts (STRINGERS ON BACK OF SIGN)
- RIVETS - 9/32" (6605-9-6) BULB-TITE, TRI-FOLD, ALUMINUM BODY/MANDREL
- O.D. FLANGE .720-.765 INCH, GRIP RANGE .042-.375 INCH
- WASHERS (ALL POSTS) -
- 1-1/4" O.D. X 3/8" I.D. X 1/16" STEEL
 - 1-1/4" O.D. X 3/8" I.D. X .080 NYLON


* Two different fastening systems are shown for illustration purposes. On any individual sign, either one or the other system shall be used. Actual number of fasteners per sign varies with the sign area, but normally there are two. For a single post installation, all signs greater than 9 sq. ft. require the use of 3 fasteners.

ATTACHMENT OF SIGNS TO POSTS	
WISCONSIN DEPT OF TRANSPORTATION	
APPROVED	<i>Matthew R. Rauch</i> For State Traffic Engineer
DATE 8/11/16	PLATE NO. A4-8.8



TELESCOPIC TUBING ANCHORS
TWO PIECE SYSTEM

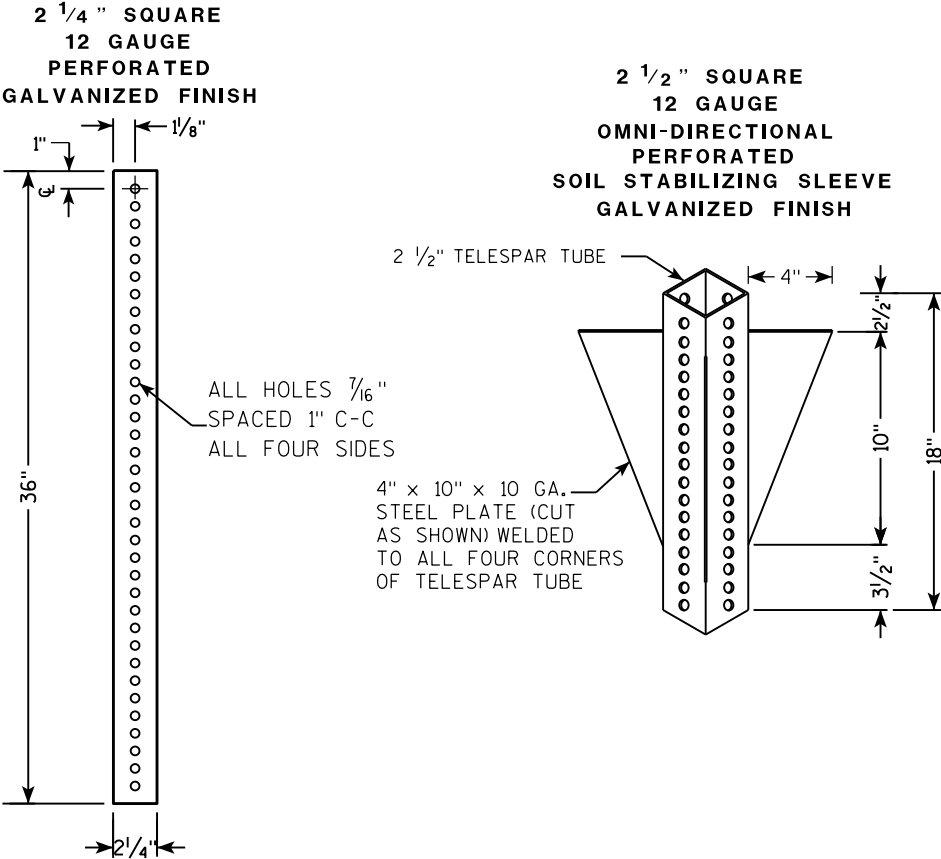

DETAIL OF TUBULAR STEEL SIGN POST
(IN POURED CONCRETE OR ASPHALT)

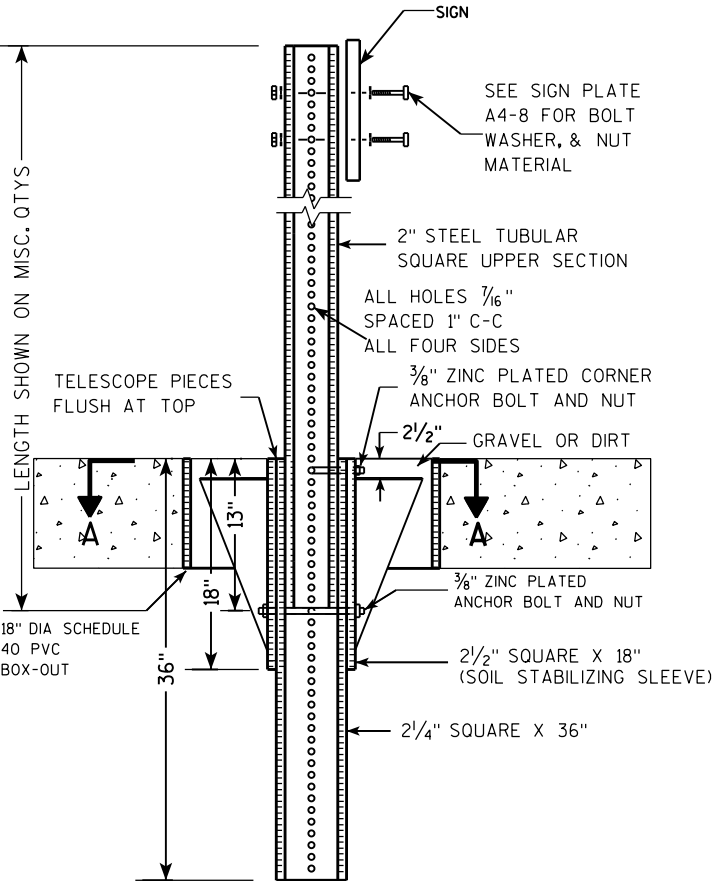

DETAIL OF TUBULAR STEEL SIGN POST
(IN LOCATIONS OTHER THAN POURED CONCRETE OR ASPHALT)

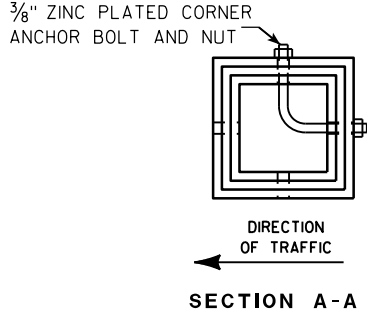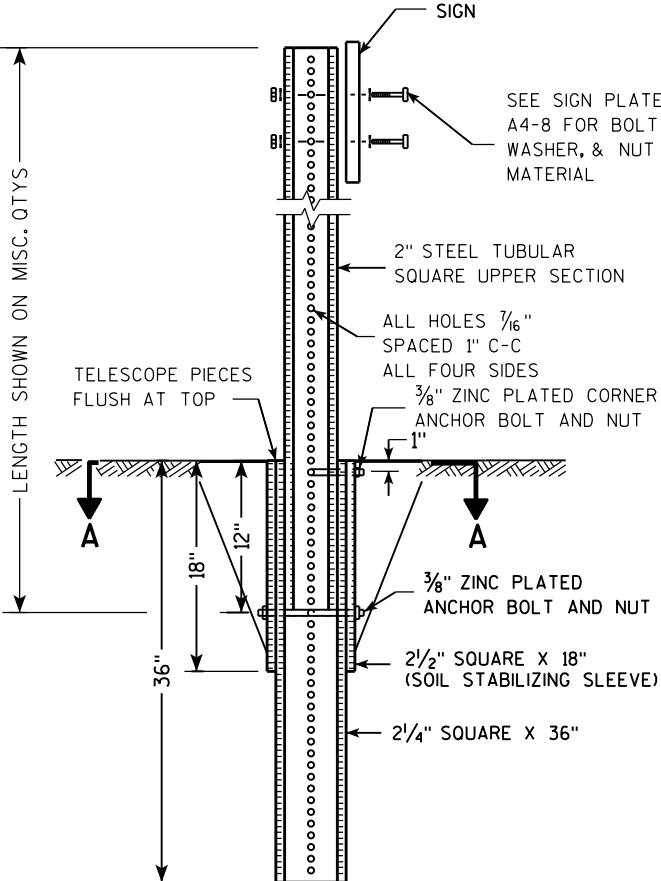

Area of Sign Installation (Sq. Ft.)	Number of Required Posts
9 or less	1
Greater than 9 less than or equal to 18	2
Greater than 18 less than or equal to 27	3

Signs wider than 3 feet or larger than 9 sq. ft shall be mounted on multiple posts (see above table).

TUBULAR STEEL
SIGN POST
A4-9



WISCONSIN DEPT OF TRANSPORTATION

APPROVED *Matthew R. Rauch*
for State Traffic Engineer

DATE 2/05/15 PLATE NO. A4-9.9

NOTES

1. Sign is Type II - Type H Reflective
2. Color:
Background - White
Message - Black
3. Message Series - D except 3 number signs Series C
4. Corners may be square or rounded when base material is plywood but borders shall be rounded as shown. When base material is metal, the corners and borders shall be rounded.

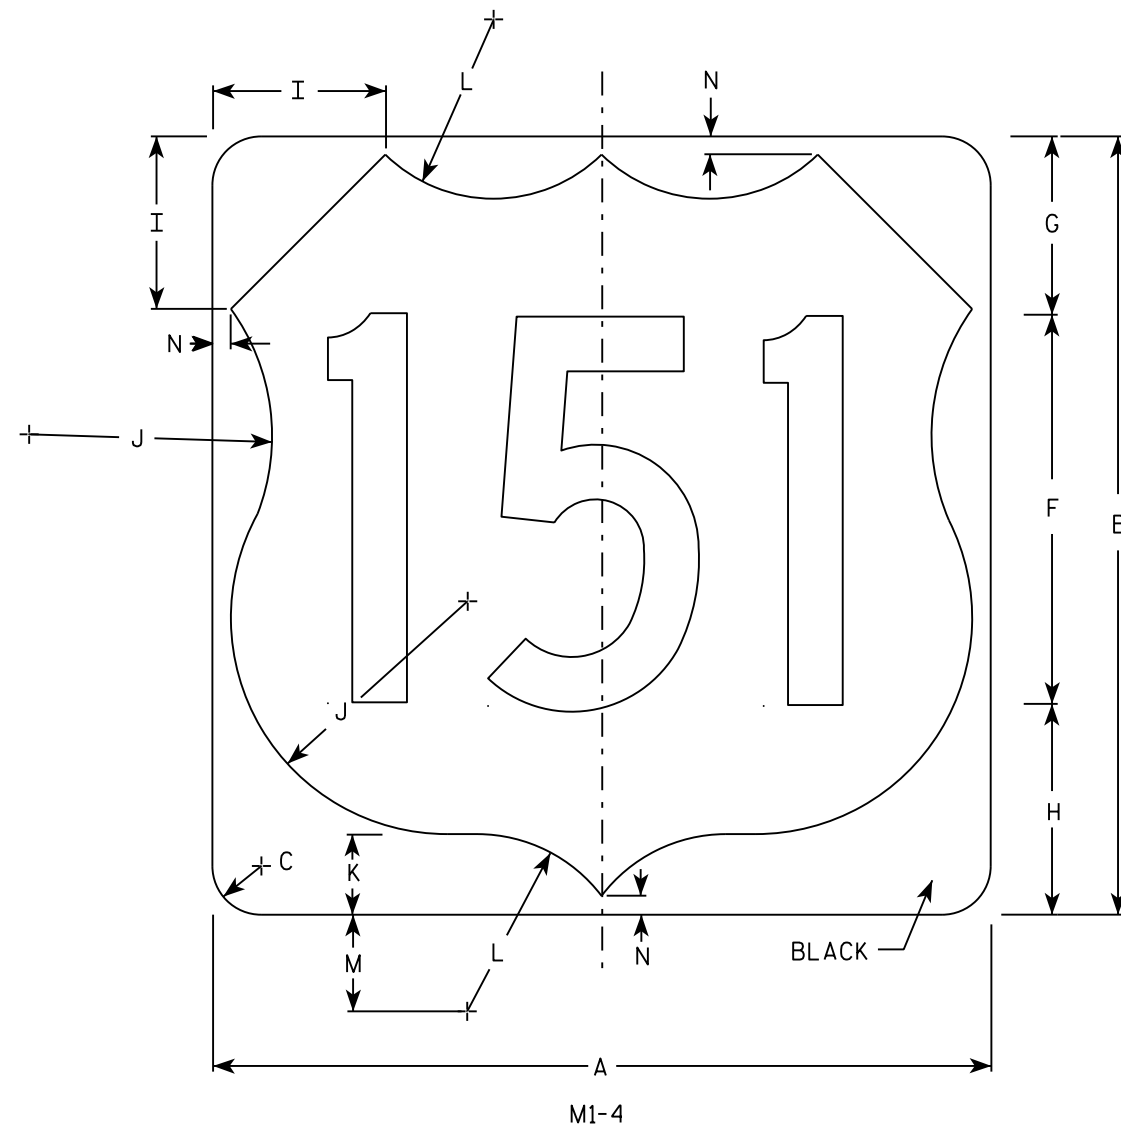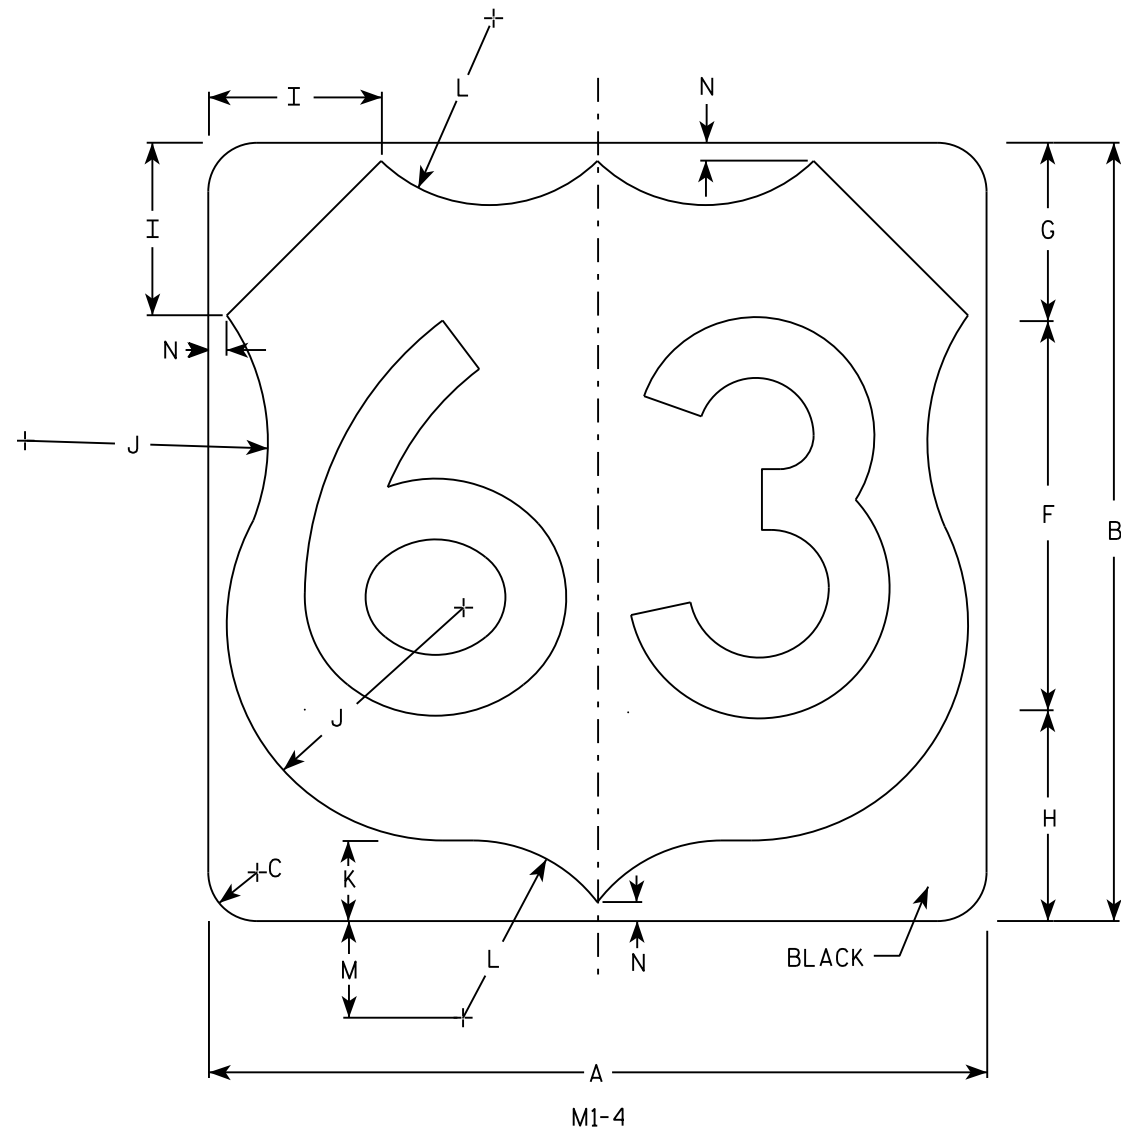

SIZE	A	B	C	D	E	F	G	H	I	J	K	L	M	N	O	P	Q	R	S	T	U	V	W	X	Y	Z	Area sq. ft.
1																											
2	24	24	1 1/2			12	5 1/2	6 1/2	5	7 1/2	2 1/2	5 1/2	3	1/2													4.0
3	36	36	2 1/4			18	8 1/4	9 1/4	7 1/4	11 1/4	3 3/4	8 1/4	4 1/2	3/4													9.0
4	36	36	2 1/4			18	8 1/4	9 1/4	7 1/4	11 1/4	3 3/4	8 1/4	4 1/2	3/4													9.0
5	36	36	2 1/4			18	8 1/4	9 1/4	7 1/4	11 1/4	3 3/4	8 1/4	4 1/2	3/4													9.0

PROJECT NO:	HWY:	COUNTY:		SHEET NO:	E
-------------	------	---------	--	-----------	---





USH MARKER
M1-4 FOR ASSEMBLIES

WISCONSIN DEPT OF TRANSPORTATION

APPROVED
Matthew R. Rauch
for State Traffic Engineer

DATE 3/16/18 PLATE NO. M1-4.10

7

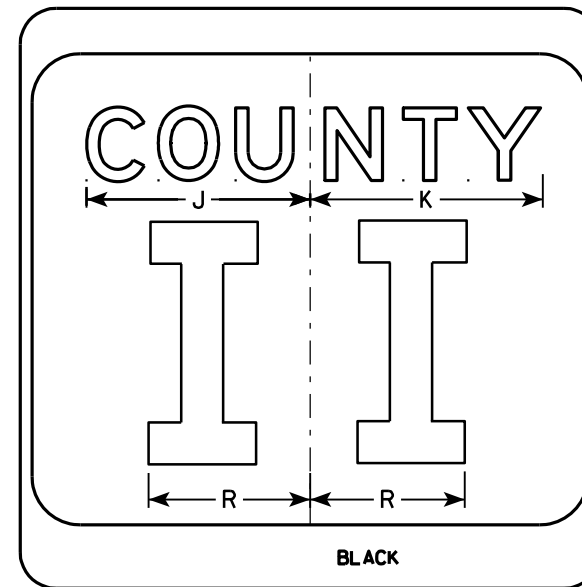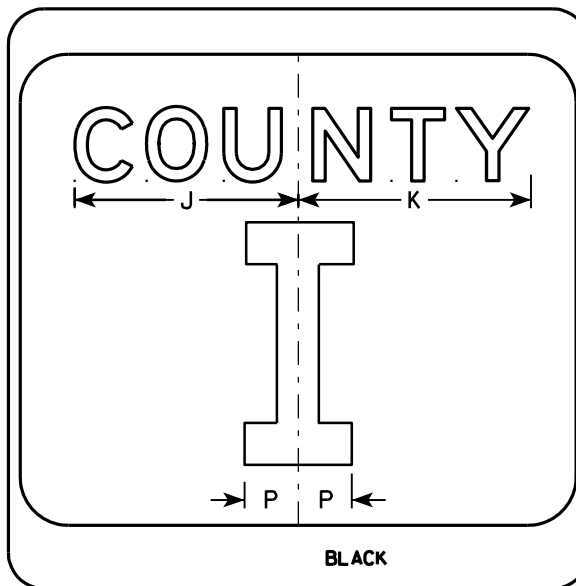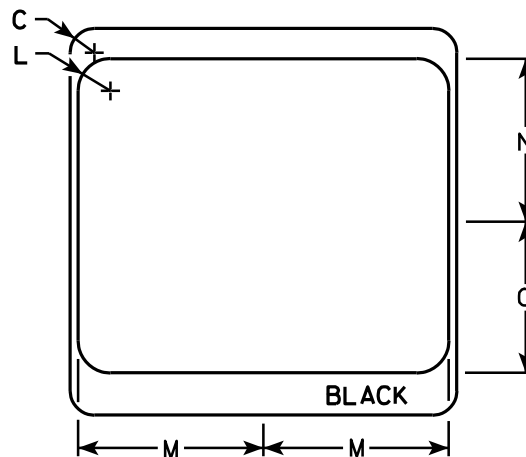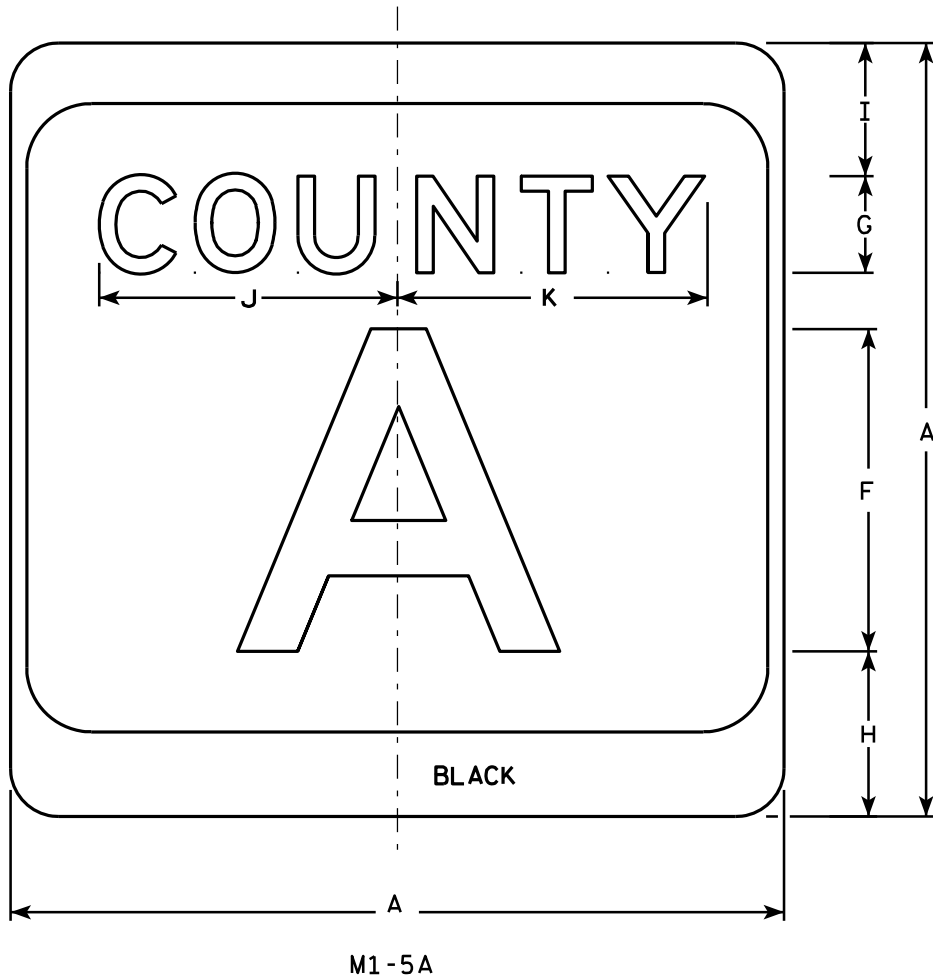

NOTES

- Sign is Type II - see Note 7 - reference WIS DOT Standard Specification for HIGHWAY and STRUCTURE CONSTRUCTION latest edition.
- Color:
Background - White & Black - See Note 7
Message - Black
- Message Series - see Note 5
- Corners may be square or rounded when base material is plywood but borders shall be rounded as shown. When base material is metal, the corners and borders shall be rounded.
- Message Series E for 1 letter.
Message Series D for 2 letters unless message is too big then Series C.
Message Series C for 3 letters unless message is too big then Series B.
- Substitute appropriate letters & optically center to achieve proper balance.
- Permanent Signs
Background - Type H Reflective
Detour or temporary Signs
Background - Reflective

7

SIZE	A	B	C	D	E	F	G	H	I	J	K	L	M	N	O	P	Q	R	S	T	U	V	W	X	Y	Z	Area sq. ft.
1																											
2	24		1 1/2			10	3	5 1/8	4 1/8	9 1/4	9 5/8	2	11 1/2	10 1/8	9 3/8	2 1/4		6 5/8									4.0
3	36		2 1/4			16	4	7 5/8	5 5/8	12 1/4	12 7/8	3	17 1/8	15 1/4	14	3 3/8		10									9.0
4	36		2 1/4			16	4	7 5/8	5 5/8	12 1/4	12 7/8	3	17 1/8	15 1/4	14	3 3/8		10									9.0
5	36		2 1/4			16	4	7 5/8	5 5/8	12 1/4	12 7/8	3	17 1/8	15 1/4	14	3 3/8		10									9.0

PROJECT NO:	HWY:	COUNTY:		SHEET NO:	E
-------------	------	---------	--	-----------	---

CTH MARKER


M1-5A FOR ASSEMBLIES

WISCONSIN DEPT OF TRANSPORTATION

APPROVED *Matthew R. Rauch*
for State Traffic Engineer


DATE 9/27/11 PLATE NO. M1-5A.8

7

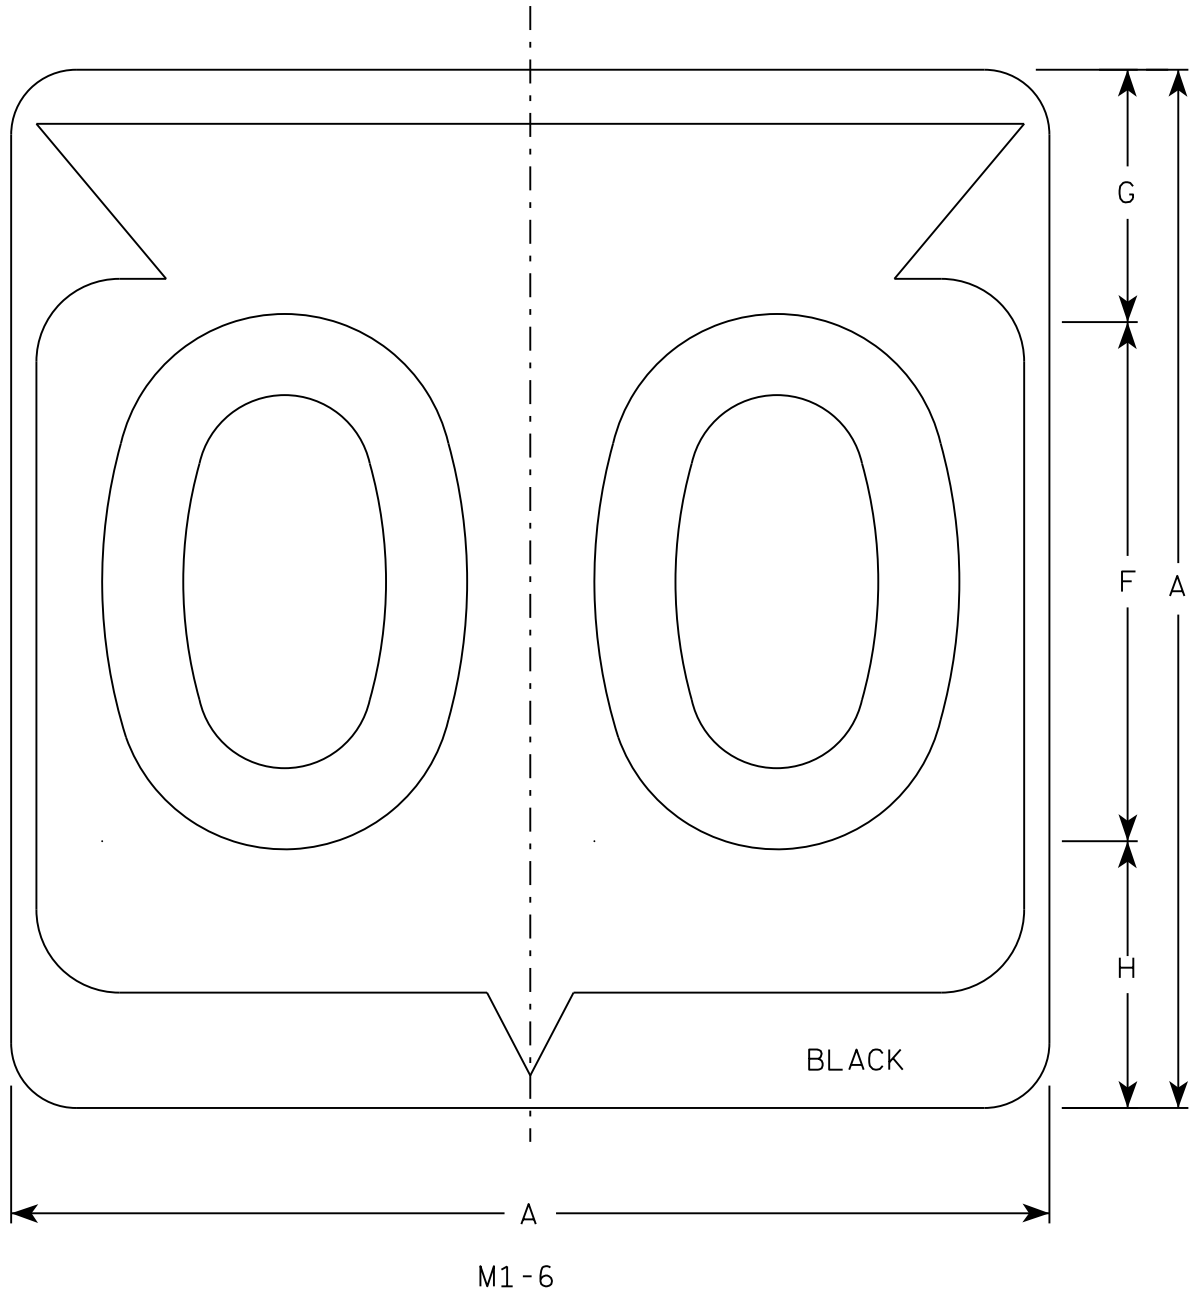

NOTES

- 1. Sign is Type II - Type H Reflective
- 2. Color:
Background - White
Message - Black
- 3. Message Series - D except 3 number signs Series C
- 4. Corners may be square or rounded when base material is plywood but borders shall be rounded as shown. When base material is metal, the corners and borders shall be rounded.

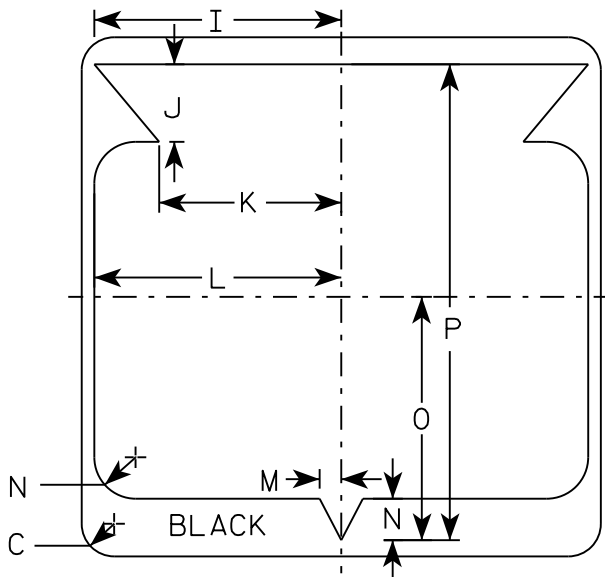

7

SIZE	A	B	C	D	E	F	G	H	I	J	K	L	M	N	O	P	Q	R	S	T	U	V	W	X	Y	Z	Area sq. ft.
1																											
2	24		1 1/2			12	5 1/2	6 1/2	10 1/4	2 1/2	8 7/8	11 1/2	1	1 7/8	11 1/4	21 7/8											4.0
3	36		2 1/4			18	8 3/4	9 1/4	15 3/8	5 3/8	12 5/8	17 1/8	1 1/2	2 7/8	16 7/8	33											9.0
4	36		2 1/4			18	8 3/4	9 1/4	15 3/8	5 3/8	12 5/8	17 1/8	1 1/2	2 7/8	16 7/8	33											9.0
5	36		2 1/4			18	8 3/4	9 1/4	15 3/8	5 3/8	12 5/8	17 1/8	1 1/2	2 7/8	16 7/8	33											9.0

PROJECT NO:

HWY:

COUNTY:

SHEET NO:


E

STATE ROUTE MARKER
M1-6 FOR ASSEMBLIES


WISCONSIN DEPT OF TRANSPORTATION

APPROVED
Matthew R. Rauch
for State Traffic Engineer

DATE 3/16/18 PLATE NO. M1-6.10

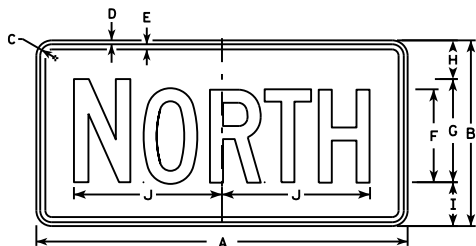

M3-1
MM3-1
MP3-1

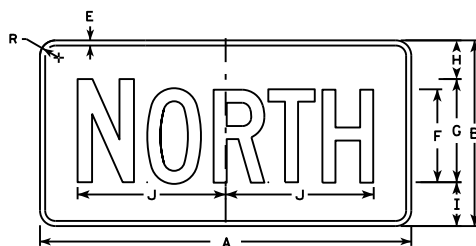


MB3-1
MK3-1
MN3-1




M3-2
MM3-2
MP3-2



MB3-2
MK3-2
MN3-2

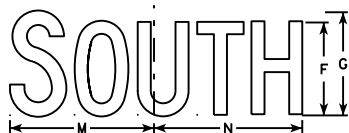


M3-3
MM3-3
MP3-3

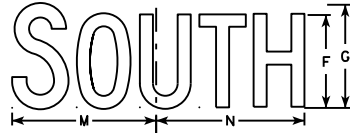

MB3-3
MK3-3
MN3-3



M3-4
MM3-4
MP3-4

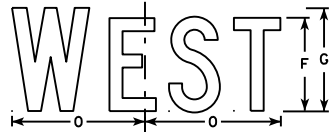

MB3-4
MK3-4
MN3-4

NOTES

1. All Signs Type II - Type H
2. Color:
Background - See note 5
Message - See note 5
3. Message Series - C
4. Corners may be square or rounded when base material is plywood but borders shall be rounded as shown. When base material is metal, the corners and borders shall be rounded.
5. M3-1 thru M3-4 Background - White
Message - Black
MB3-1 thru MB3-4 Background - Blue
Message - White
MK3-1 thru MK3-4 Background - Green
Message - White
MM3-1 thru MM3-4 Background - White
Message - Green
MN3-1 thru MN3-4 Background - Brown
Message - White
MP3-1 thru MP3-4 Background - White
Message - Blue
6. Note the first letter of each direction is larger than the remainder of the message.

SIZE	A	B	C	D	E	F	G	H	I	J	K	L	M	N	O	P	Q	R	S	T	U	V	W	X	Y	Z	Area sq. ft.
1																											
2	24	12	1 1/8	3/8	3/8	6	7	2 1/4	2 3/4	10 1/4	7 7/8	8 3/8	10 1/4	9 3/4	8 3/4			1 1/2									2.00
3	36	18	1 1/8	3/8	1/2	9	10	3 3/4	4 1/4	14 3/8	12	12 1/8	14	14 1/8	13			1 1/2									4.5
4	36	18	1 1/8	3/8	1/2	9	10	3 3/4	4 1/4	14 3/8	12	12 1/8	14	14 1/8	13			1 1/2									4.5
5	36	18	1 1/8	3/8	1/2	9	10	3 3/4	4 1/4	14 3/8	12	12 1/8	14	14 1/8	13			1 1/2									4.5

PROJECT NO:

HWY:

COUNTY:

SHEET NO:

E

STANDARD SIGNS
M3-1 thru M3-4
SERIES


WISCONSIN DEPT OF TRANSPORTATION

APPROVED

Matthew P. Rauch
for State Traffic Engineer

DATE 10/15/15

PLATE NO. M3-1.14

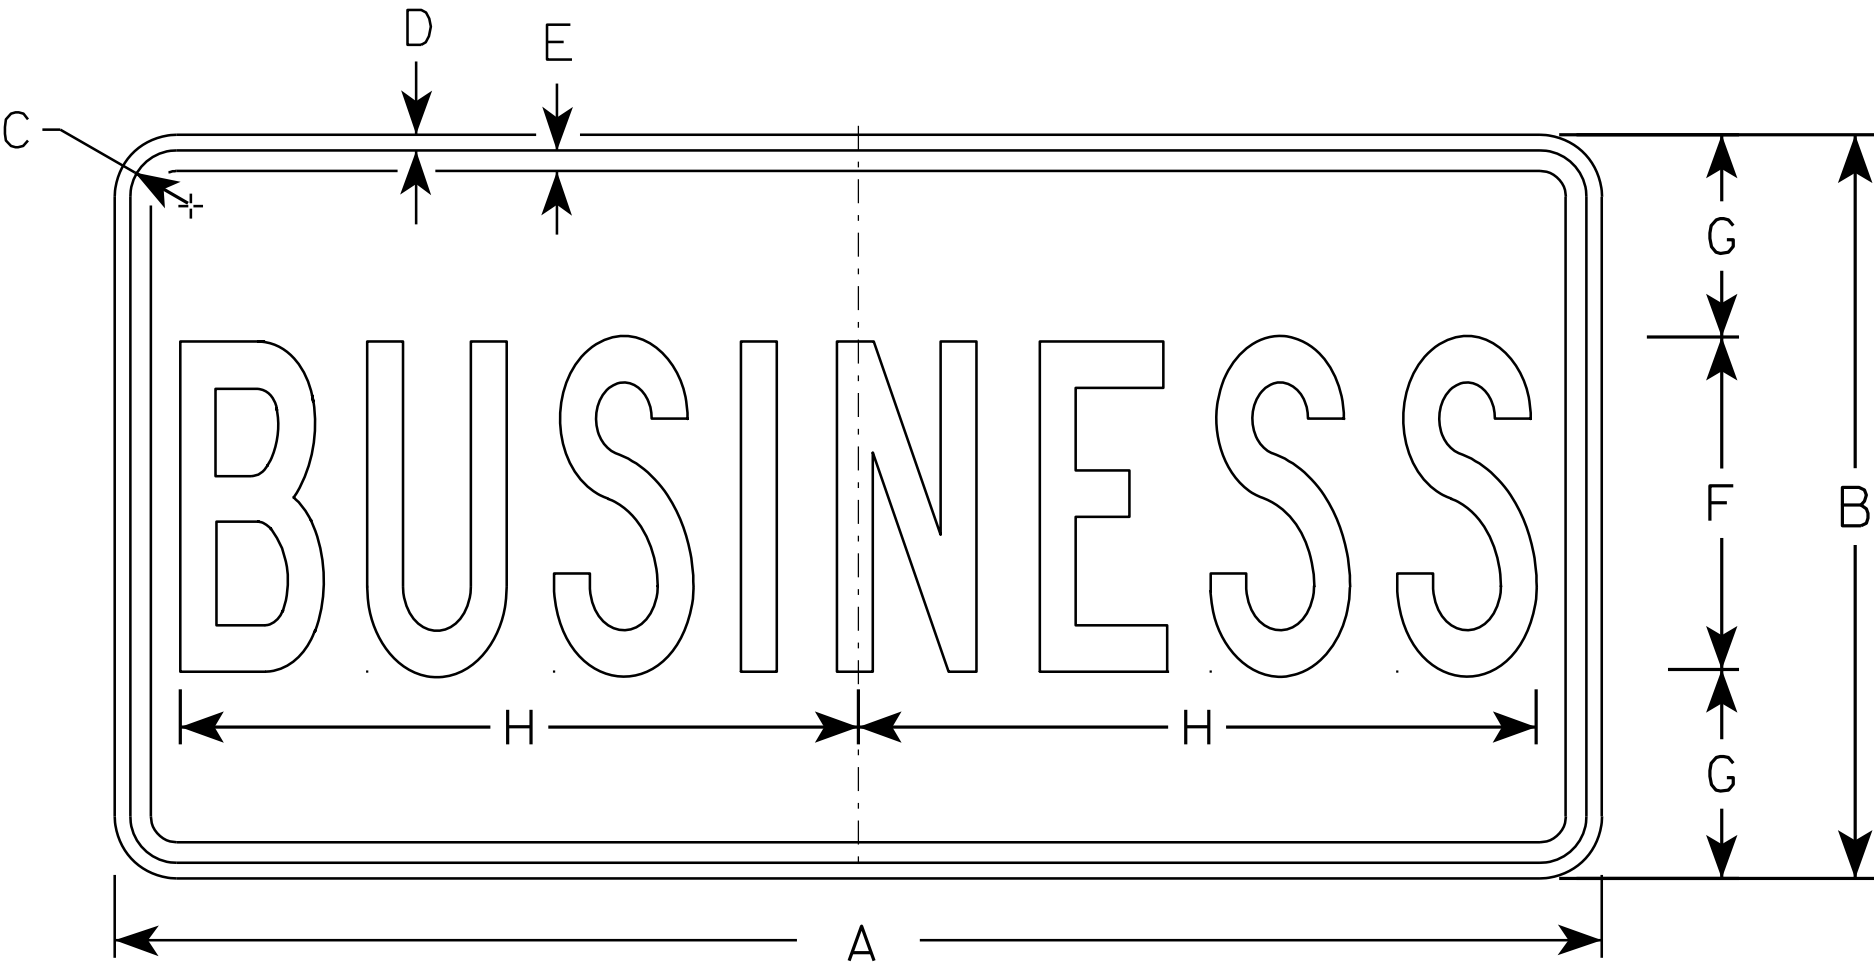

M4 - 3

NOTES

1. Sign is Type II - See Note 5 - reference
WIS DOT Standard Specification for HIGHWAY
and STRUCTURE CONSTRUCTION latest edition.
2. Color:
Background - White - See Note 5
Message - Black
3. Message Series - B
4. Corners may be square or rounded when base
material is plywood but borders shall be rounded
as shown. When base material is metal, the
corners and borders shall be rounded.
5. Permanent Signs
Background - Type H Reflective
Detour or other temporary Signs
Background - Reflective

SIZE	A	B	C	D	E	F	G	H	I	J	K	L	M	N	O	P	Q	R	S	T	U	V	W	X	Y	Z	Area sq. ft.
1																											
2	24	12	1 1/8	3/8	3/8	5	3 1/2	9 5/8																		2.0	
3	36	18	1 1/8	3/8	1/2	8	5	16 3/8																		4.5	
4																											
5																											

STANDARD SIGN


M4 - 3

WISCONSIN DEPT OF TRANSPORTATION


APPROVED *Matthew R. Rauch*
for State Traffic Engineer

DATE 11/10/10 PLATE NO. M4-3.5


PROJECT NO:	HWY:	COUNTY:	SHEET NO:	E
-------------	------	---------	-----------	---

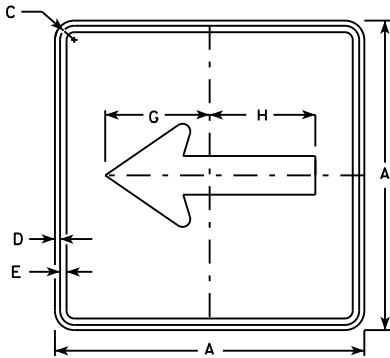


M6-1
MM6-1
MO6-1
MP6-1

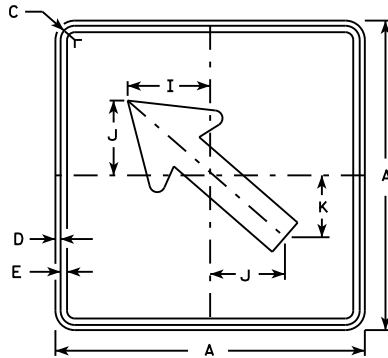


M6-2
MM6-2
MO6-2
MP6-2

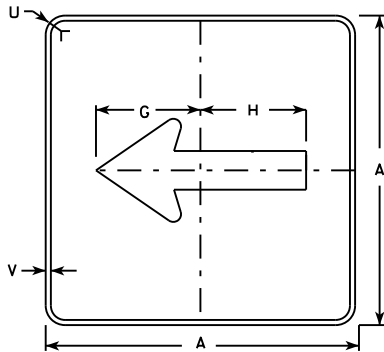

MB6-1
MK6-1
MN6-1
MR6-1

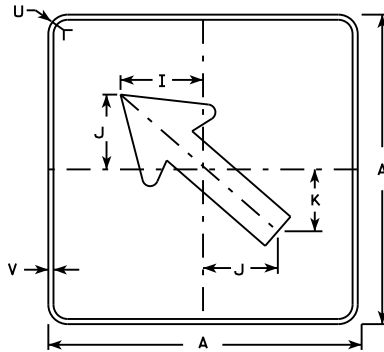

MB6-2
MK6-2
MN6-2
MR6-2

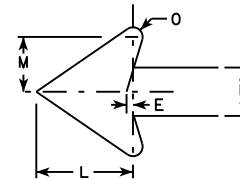

NOTES

- Signs are Type II - Type H except as Shown
- Color:
Background - See note 4
Message - See note 4
- Corners may be square or rounded when base material is plywood but borders shall be rounded as shown. When base material is metal, the corners and borders shall be rounded.
- M6-1 and M6-2 Background - White
Message - Black
MB6-1 and MB6-2 Background - Blue
Message - White
MK6-1 and MK6-2 Background - Green
Message - White
MM6-1 and MM6-2 Background - White
Message - Green
MN6-1 and MN6-2 Background - Brown
Message - White
MO6-1 and MO6-2 Background - Orange - Type F Reflective
Message - Black
MP6-1 and MP6-2 Background - White
Message - Blue
MR6-1 and MR6-2 Background - Brown
Message - Yellow

SIZE	A	B	C	D	E	F	G	H	I	J	K	L	M	N	O	P	Q	R	S	T	U	V	W	X	Y	Z	Area sq. ft.
1																											
2	21		1 1/8	3/8	3/8		7 1/2	7 1/8	5 5/8	5	4 1/4	5 1/4	3	2 5/8	1/2						1 1/2	1/2					3.06
3	30		1 3/8	1/2	5/8		10 3/4	10 1/4	8	7 1/4	6	7 1/2	4 1/4	3 3/4	3/4						1 3/8	1/2					6.25
4	30		1 3/8	1/2	5/8		10 3/4	10 1/4	8	7 1/4	6	7 1/2	4 1/4	3 3/4	3/4						1 3/8	1/2					6.25
5	30		1 3/8	1/2	5/8		10 3/4	10 1/4	8	7 1/4	6	7 1/2	4 1/4	3 3/4	3/4						1 3/8	1/2					6.25

PROJECT NO:

HWY:

COUNTY:

SHEET NO:


E

STANDARD SIGN
M6-1 & M6-2
SERIES


WISCONSIN DEPT OF TRANSPORTATION

APPROVED
Matthew R. Rauch
for State Traffic Engineer


DATE 10/15/15 PLATE NO. M6-1.15

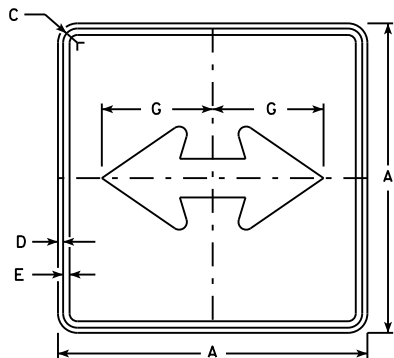


M6 - 4
MM6 - 4
M06 - 4
MP6 - 4

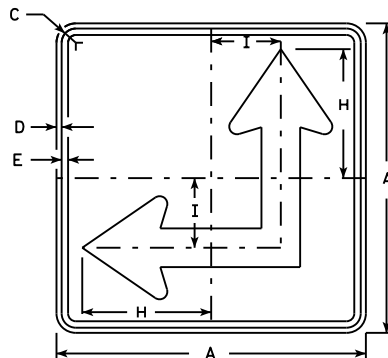

M6 - 6
MM6 - 6
M06 - 6
MP6 - 6

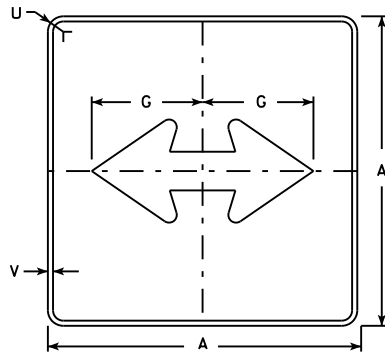


MB6 - 4
MK6 - 4
MN6 - 4
MR6 - 4

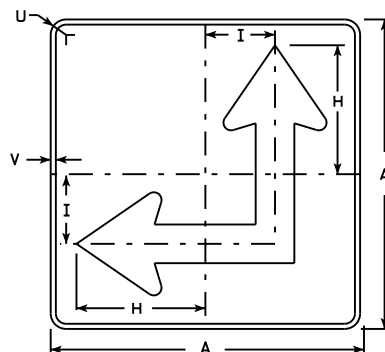



MB6 - 6
MK6 - 6
MN6 - 6
MR6 - 6

NOTES

- Signs are Type II - Type H except as Shown
- Color:
Background - See Note 4
Message - See Note 4
- Corners may be square or rounded when base material is plywood but borders shall be rounded as shown. When base material is metal, the corners and borders shall be rounded.
- M6-4 and M6-6 Background - White
Message - Black
MB6-4 and MB6-6 Background - Blue
Message - White
MK6-4 and MK6-6 Background - Green
Message - White
MM6-4 and MM6-6 Background - White
Message - Green
MN6-4 and MN6-6 Background - Brown
Message - White
M06-4 and M06-6 Background - Orange - Type F Reflective
Message - Black
MP6-4 and MP6-6 Background - White
Message - Blue
MR6-4 and MR6-6 Background - Brown
Message - Yellow
- M6-6R same as M6-6L except arrow points ahead and right.




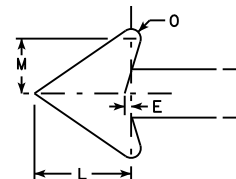


SIZE	A	B	C	D	E	F	G	H	I	J	K	L	M	N	O	P	Q	R	S	T	U	V	W	X	Y	Z	Area sq. ft.
1																											
2	21		1 1/8	3/8	3/8		7 1/2	8 3/4	4 1/4			5 1/4	3	2 5/8	1/2						1 1/2	1/2					3.06
3	30		1 3/8	1/2	5/8		10 3/4	12 1/2	6 3/4			7 1/2	4 1/4	3 3/4	3/4						1 3/8	1/2					6.25
4	30		1 3/8	1/2	5/8		10 3/4	12 1/2	6 3/4			7 1/2	4 1/4	3 3/4	3/4						1 3/8	1/2					6.25
5	30		1 3/8	1/2	5/8		10 3/4	12 1/2	6 3/4			7 1/2	4 1/4	3 3/4	3/4						1 3/8	1/2					6.25

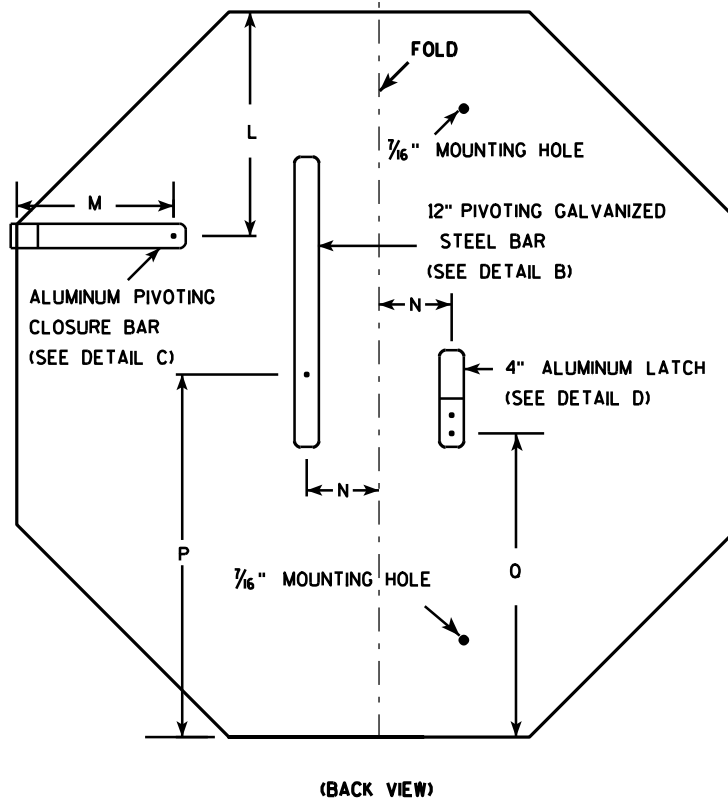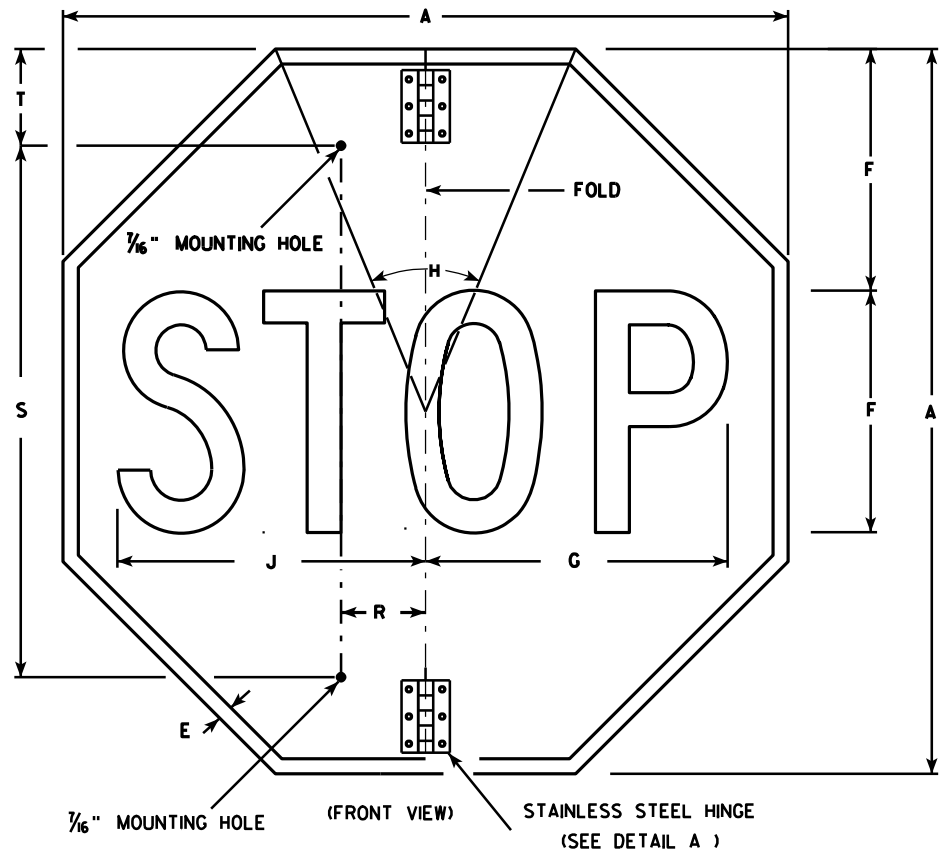

NOTES

- Sign is Type II - Type H Reflective - reference WIS DOT Standard Specification for HIGHWAY and STRUCTURE CONSTRUCTION latest edition.
- Color:
Background - Red
Message - White
- Message Series - C
- All hardware used on the folding STOP sign installation shall conform to 637.2.4 of the WIS DOT Standard Specification.

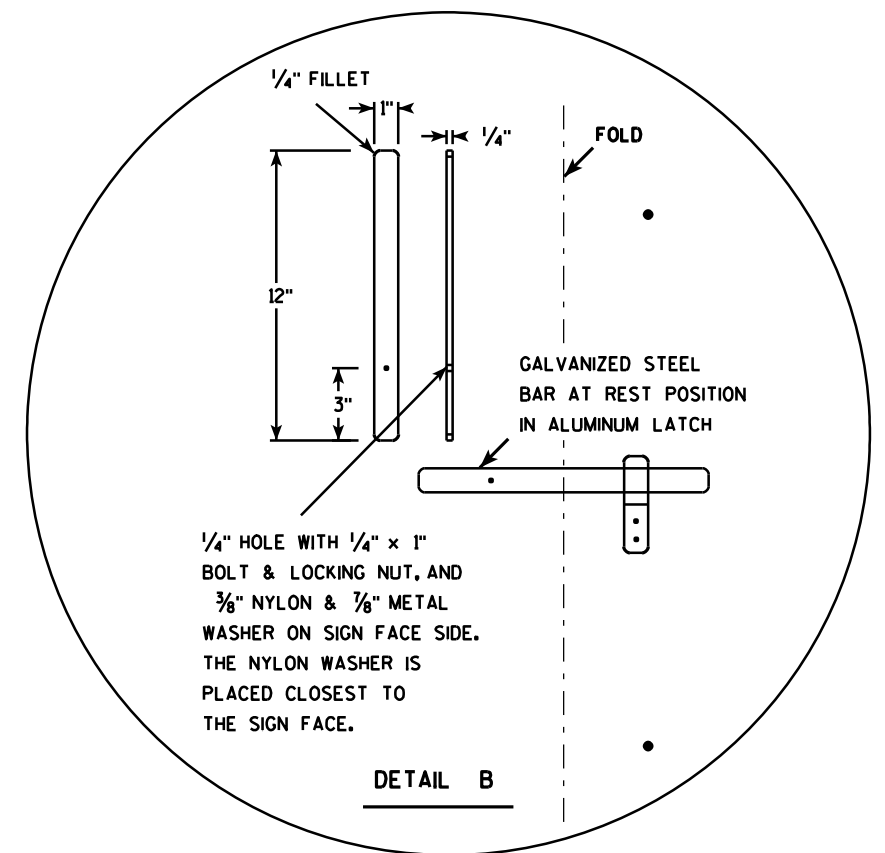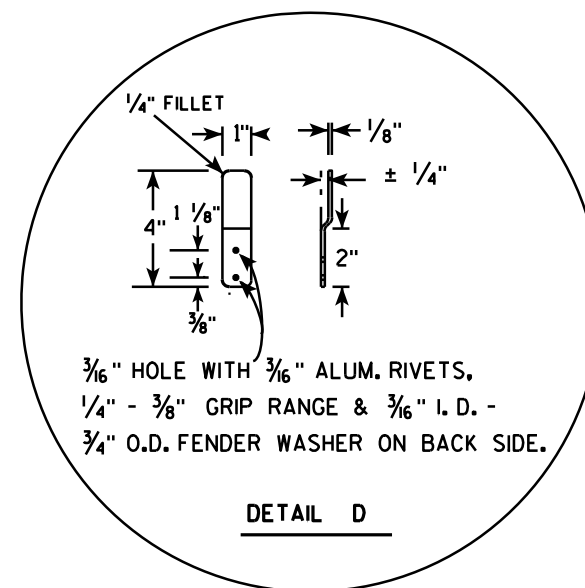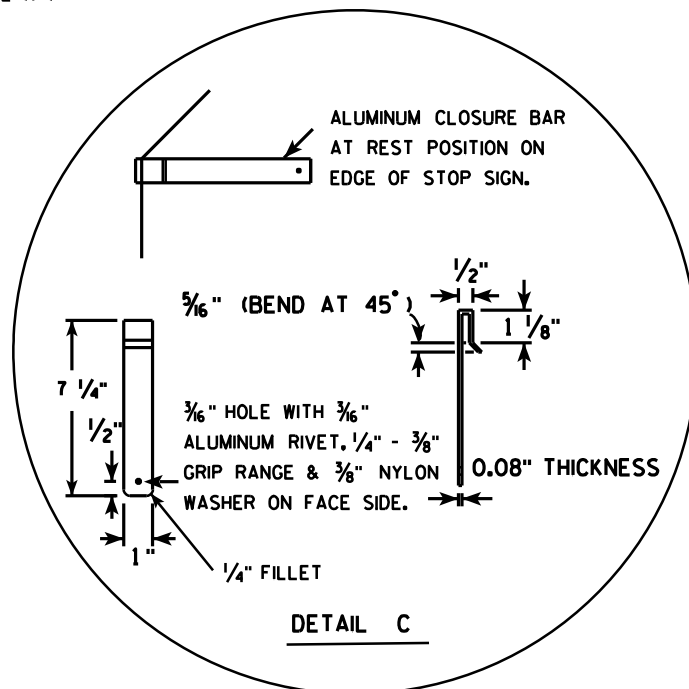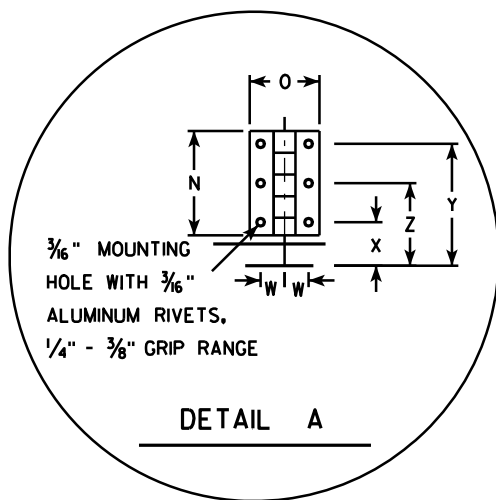

SIZE	A	B	C	D	E	F	G	H	I	J	K	L	M	N	O	P	Q	R	S	T	U	V	W	X	Y	Z	Area sq. ft.
1																											
2S	30				$\frac{5}{8}$	10	12 $\frac{1}{2}$	45		12 $\frac{3}{4}$		9 $\frac{1}{4}$	6 $\frac{1}{2}$	3	2	15	12 $\frac{3}{8}$	2 $\frac{1}{2}$	22	5			$\frac{11}{16}$	1 $\frac{1}{4}$	3 $\frac{1}{2}$	2 $\frac{3}{8}$	5.18
2M	36				$\frac{3}{4}$	12	15	45		15 $\frac{3}{8}$		11	6 $\frac{1}{2}$	3	2	18	15 $\frac{3}{8}$	2 $\frac{1}{2}$	26	5			$\frac{11}{16}$	1 $\frac{1}{4}$	3 $\frac{1}{2}$	2 $\frac{3}{8}$	7.46
3	36				$\frac{3}{4}$	12	15	45		15 $\frac{3}{8}$		11	6 $\frac{1}{2}$	3	2	18	15 $\frac{3}{8}$	2 $\frac{1}{2}$	26	5			$\frac{11}{16}$	1 $\frac{1}{4}$	3 $\frac{1}{2}$	2 $\frac{3}{8}$	7.46
4																											
5																											


PROJECT NO:	HWY:	COUNTY:	SHEET NO:	E
-------------	------	---------	-----------	---

STANDARD SIGN
R1-1F

WISCONSIN DEPT OF TRANSPORTATION

APPROVED *Matthew R. Rauch*
for State Traffic Engineer


DATE 12/03/10 PLATE NO. R1-1F.3

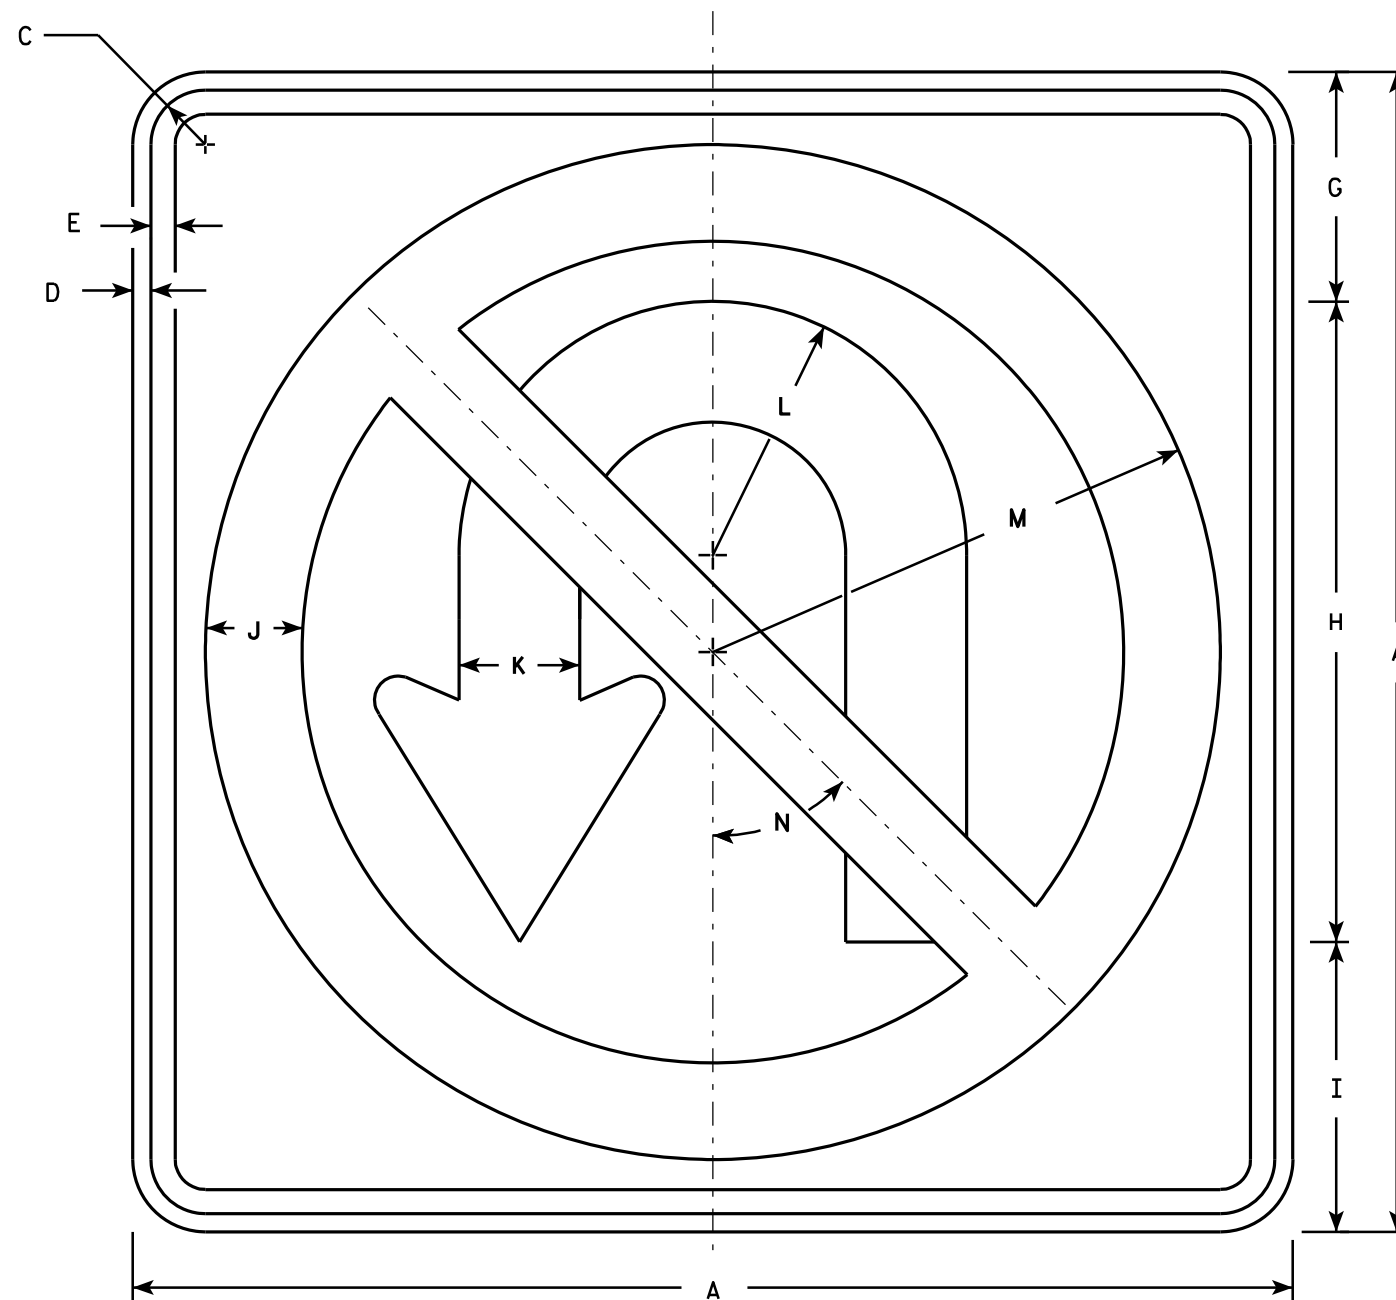

R3-4

NOTES

- Sign is Type II - Type H Reflective - reference WIS DOT Standard Specification for HIGHWAY and STRUCTURE CONSTRUCTION latest edition.
- Color:
Background - White
Message - See note 4
- Corners may be square or rounded when base material is plywood but borders shall be rounded as shown. When base material is metal, the corners and borders shall be rounded.
- Border & Arrow are non reflective black, the circle with diagonal bar is reflective red.

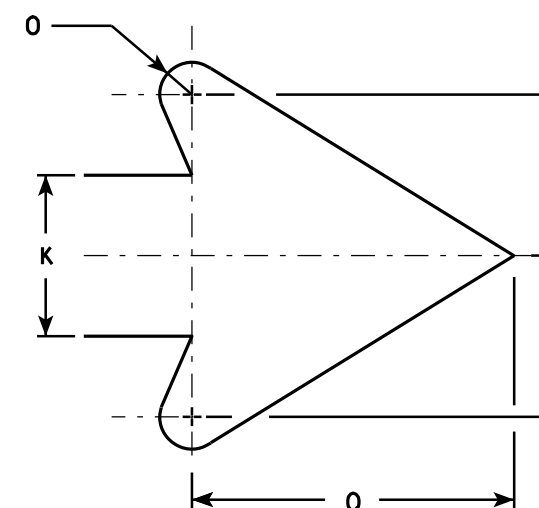


ARROW DETAIL


SIZE	A	B	C	D	E	F	G	H	I	J	K	L	M	N	O	P	Q	R	S	T	U	V	W	X	Y	Z	Area sq. ft.
1																											
2S	24		1 1/8	3/8	1/2		4 3/4	13 1/4	6	2	2 1/2	5 1/4	10 1/2	45°	1/2		5										4.0
2M	36		1 5/8	5/8	3/4		7 1/8	19 7/8	9	3	3 3/4	7 7/8	15 3/4	45°	3/4		7 5/8										9.0
3	36		1 5/8	5/8	3/4		7 1/8	19 7/8	9	3	3 3/4	7 7/8	15 3/4	45°	3/4		7 5/8										9.0
4	36		1 5/8	5/8	3/4		7 1/8	19 7/8	9	3	3 3/4	7 7/8	15 3/4	45°	3/4		7 5/8										9.0
5	36		1 5/8	5/8	3/4		7 1/8	19 7/8	9	3	3 3/4	7 7/8	15 3/4	45°	3/4		7 5/8										9.0

STANDARD SIGN	
R3-4	
WISCONSIN DEPT OF TRANSPORTATION	
APPROVED	<i>Matthew R. Rauch</i> for State Traffic Engineer
DATE 12/08/10	PLATE NO. R3-4.11

PROJECT NO:	HWY:	COUNTY:	SHEET NO:	E
-------------	------	---------	-----------	---

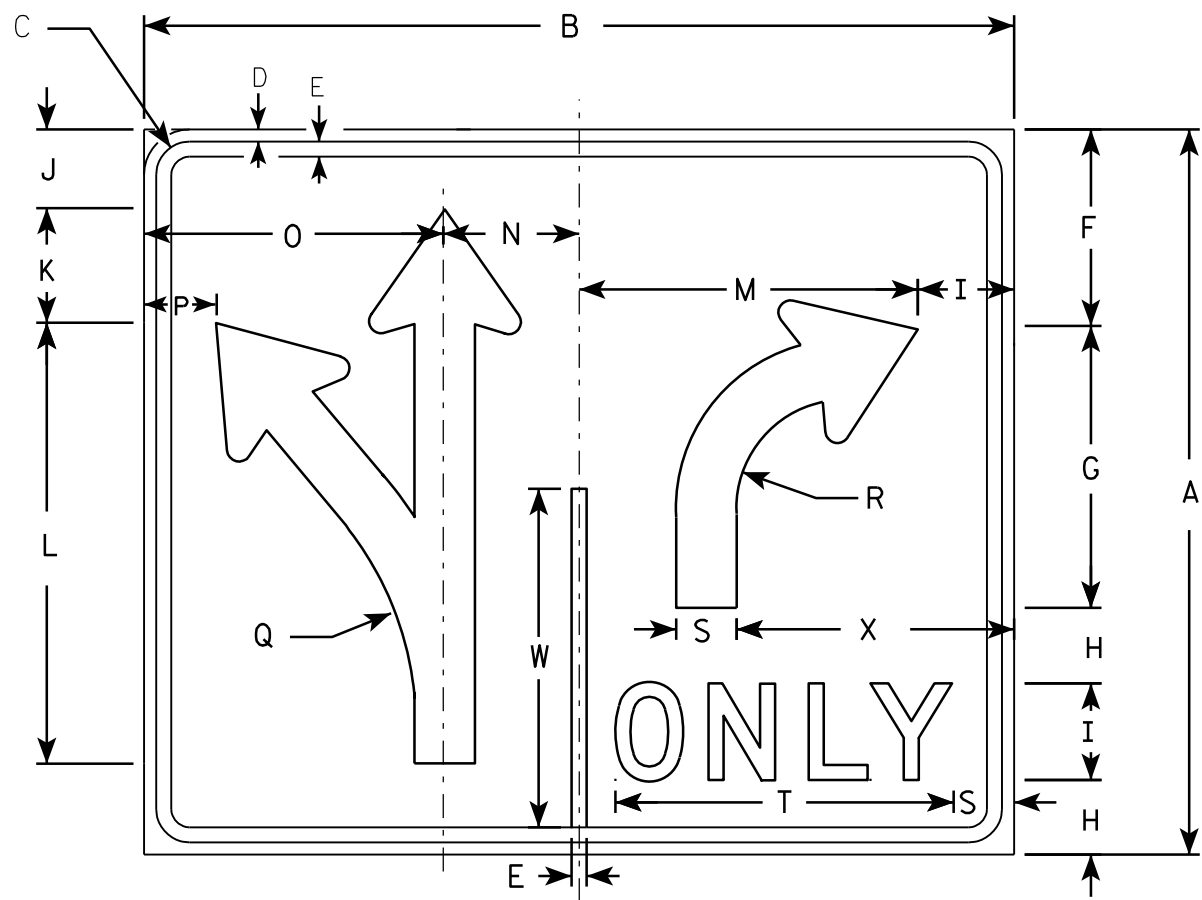


R3-8

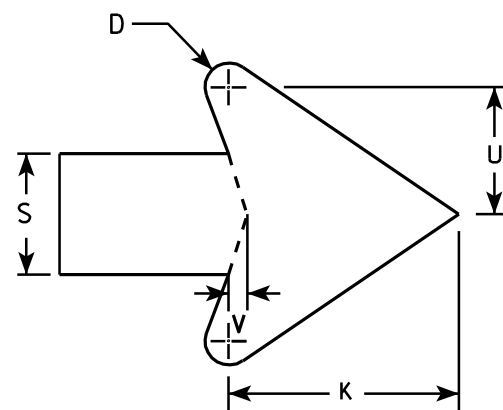

ARROW DETAIL

NOTES

1. Sign is Type II - Type H Reflective - reference WIS DOT Standard Specification for HIGHWAY and STRUCTURE CONSTRUCTION latest edition.
2. Color:
Background - WHITE
Message - BLACK
3. Message Series - D
4. Corners may be square or rounded when base material is plywood but borders shall be rounded as shown. When base material is metal, the corners and borders shall be rounded.

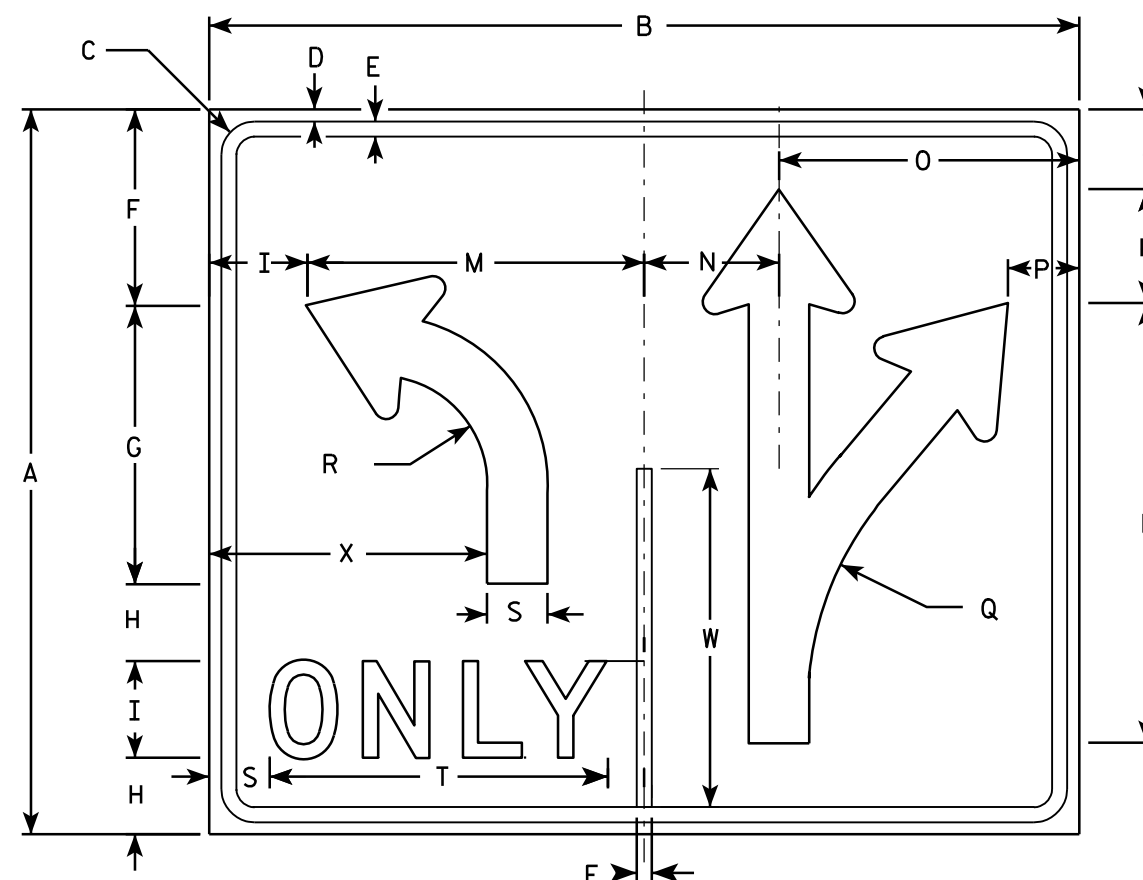

R3-8A

SIZE	A	B	C	D	E	F	G	H	I	J	K	L	M	N	O	P	Q	R	S	T	U	V	W	X	Y	Z	Area sq. ft.
1																											
2S	30	36	1 ³ / ₈	¹ / ₂	⁵ / ₈	8 ¹ / ₈	11 ⁵ / ₈	3 ¹ / ₈	4	3 ¹ / ₄	4 ³ / ₄	18 ¹ / ₄	14	5 ⁵ / ₈	12 ³ / ₈	3	13 ¹ / ₄	4 ¹ / ₂	2 ¹ / ₂	14	2 ⁵ / ₈	³ / ₈	14	11 ¹ / ₂			7.5
2M	30	36	1 ³ / ₈	¹ / ₂	⁵ / ₈	8 ¹ / ₈	11 ⁵ / ₈	3 ¹ / ₈	4	3 ¹ / ₄	4 ³ / ₄	18 ¹ / ₄	14	5 ⁵ / ₈	12 ³ / ₈	3	13 ¹ / ₄	4 ¹ / ₂	2 ¹ / ₂	14	2 ⁵ / ₈	³ / ₈	14	11 ¹ / ₂			7.5
3																											
4	48	54	2 ¹ / ₄	³ / ₄	1	13 ¹ / ₄	18 ¹ / ₂	5 ¹ / ₈	6	5 ¹ / ₄	7 ¹ / ₈	29 ¹ / ₈	21	8 ³ / ₈	18 ⁵ / ₈	4 ³ / ₈	21 ⁷ / ₈	7 ¹ / ₄	3 ³ / ₄	20 ⁵ / ₈	4	⁵ / ₈	22 ³ / ₈	17 ¹ / ₄			18.0
5	48	54	2 ¹ / ₄	³ / ₄	1	13 ¹ / ₄	18 ¹ / ₂	5 ¹ / ₈	6	5 ¹ / ₄	7 ¹ / ₈	29 ¹ / ₈	21	8 ³ / ₈	18 ⁵ / ₈	4 ³ / ₈	21 ⁷ / ₈	7 ¹ / ₄	3 ³ / ₄	20 ⁵ / ₈	4	⁵ / ₈	22 ³ / ₈	17 ¹ / ₄			18.0

STANDARD SIGN R3-8 & R3-8A

WISCONSIN DEPT OF TRANSPORTATION

APPROVED *Matthew R. Rauch*
for State Traffic Engineer

DATE 3/18/2011 PLATE NO. R3-8.5


PROJECT NO:

HWY:


COUNTY:

SHEET NO:

E

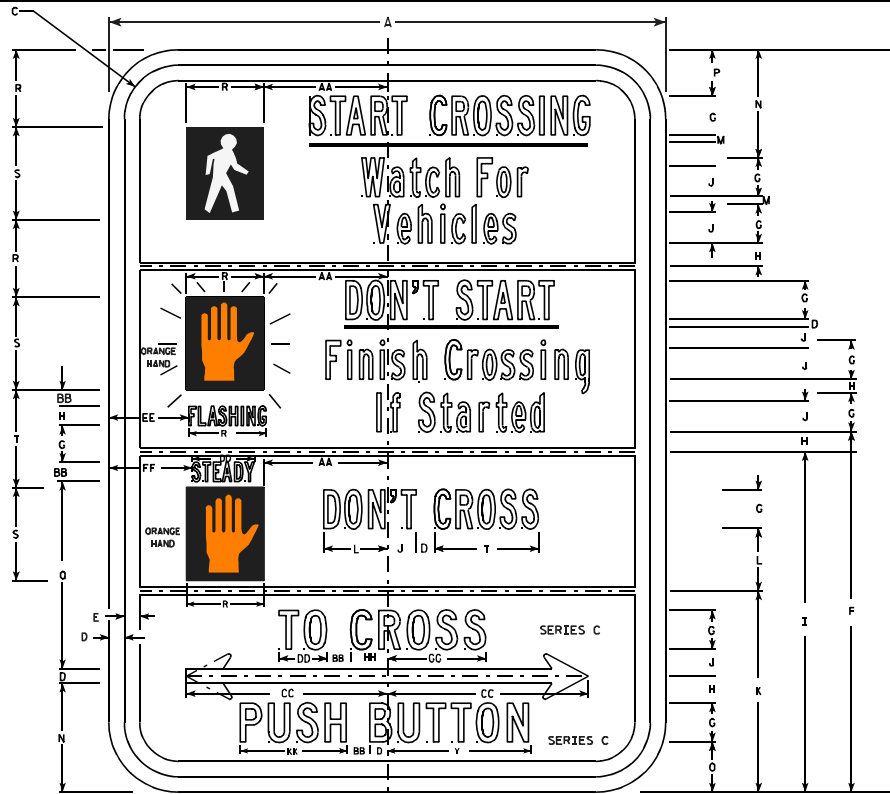

- NOTES**
1. All Signs Type II - Type H Reflective - reference WIS DOT Standard Specification for HIGHWAY and STRUCTURE CONSTRUCTION latest edition.
 2. Color:
Background - WHITE
Message - BLACK except Hand Symbol which is Orange with black background.
 3. Message Series - B or as noted on the sign.
 4. R10-3BR (right arrow)
R10-3BL (left arrow)
R10-3BD (double arrow)

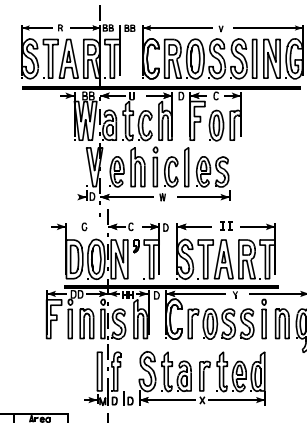

SIZE	A	B	C	D	E	F	G	H	I	J	K	L	M	N	O	P	Q	R	S	T	U	V	W	X	Y	Z	Area sq. ft.
1	6	9	1/2	1/8	1/8	4 1/4	1/2	1/8	4 1/8	3/8	2 3/8	3/8	1/8	1 3/8	5/8	5/8	2 1/4	3/8	1 1/8	1 1/4	3/4	1 3/4	1 5/8	1 3/8	1 1/2	5/8	0.38
2S	9	12	3/8	1/4	1/4	5 1/8	3/8	3/8	5 1/2	1/2	3 1/4	1	1/8	1 3/4	3/8	3/4	3	1 1/4	1 1/2	1 5/8	1 1/8	2 5/8	2 1/8	2	2 3/8	1 3/8	0.75
2M	9	12	3/8	1/4	1/4	5 7/8	5/8	3/8	5 1/2	1/2	3 1/4	1	1/8	1 3/4	3/8	3/4	3	1 1/4	1 1/2	1 5/8	1 1/8	2 5/8	2 1/8	2	2 3/8	1 3/8	0.75
3																											
4																											
5																											

SIZE	AA	BB	CC	DD	EE	FF	GG	HH	II	JJ	KK	LL	MM	NN	OO	PP	QQ	RR	SS	TT	UU	VV	WW	XX	YY	ZZ	Area sq. ft.
1	1 1/2	1/4	2 1/4	5/8	5/8	5/8	1 1/8	3/8	1	1/2	1 1/8																
2S	2	3/8	3 1/4	1	1 1/4	1 3/8	1 5/8	5/8	1 5/8	3/4	1 3/4																
2M	2	3/8	3 1/4	1	1 1/4	1 3/8	1 5/8	5/8	1 5/8	3/4	1 3/4																
3																											
4																											
5																											

PROJECT NO:

FILE NAME : C:\Users\PROJECTS\tr_std\late\R103B.DGN

PLOT DATE : 12-APR-2011 15:28

PLOT BY : mscj9h

STANDARD SIGN
R10-3B


WISCONSIN DEPT OF TRANSPORTATION

APPROVED *Matthew P. Rauch*
For State Traffic Engineer

DATE 4/12/11 PLATE NO. R10-3B.2


SHEET NO:

E

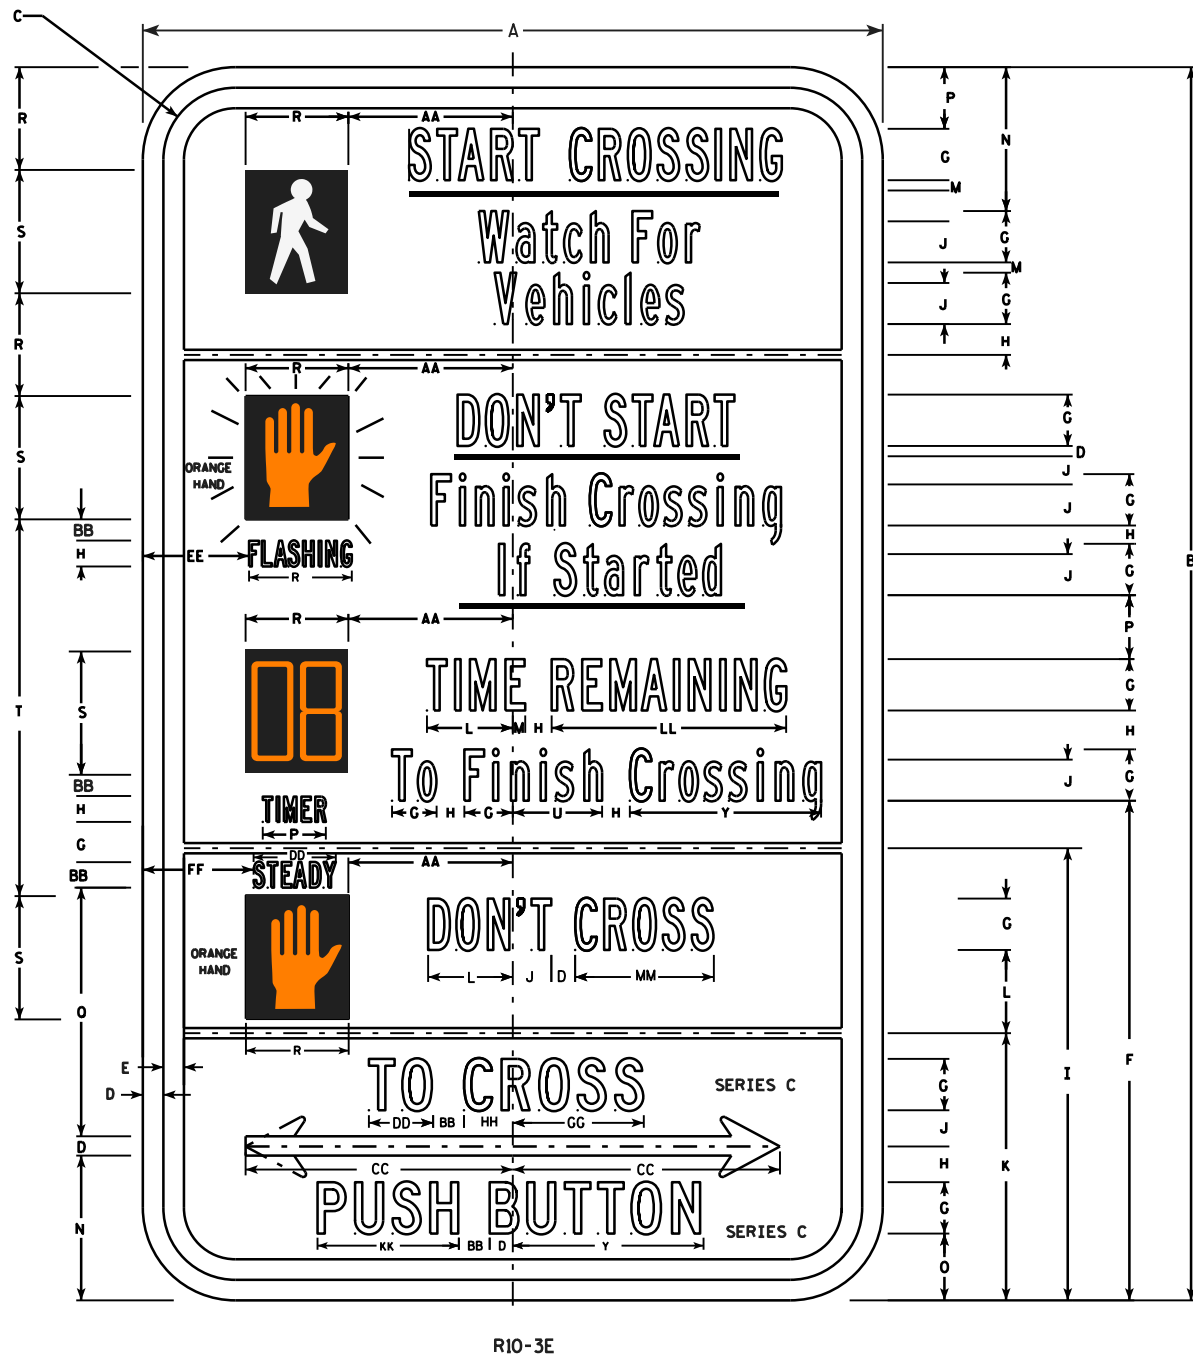

NOTES

1. All Signs Type II - Type H Reflective - reference WIS DOT Standard Specification for HIGHWAY and STRUCTURE CONSTRUCTION latest edition.
2. Color:
Background - WHITE
Message - BLACK except Hand Symbol which is Orange with black background.
3. Message Series - B or as noted on the sign.
4. R10-3ER (right arrow)
R10-3EL (left arrow)
R10-3ED (double arrow)

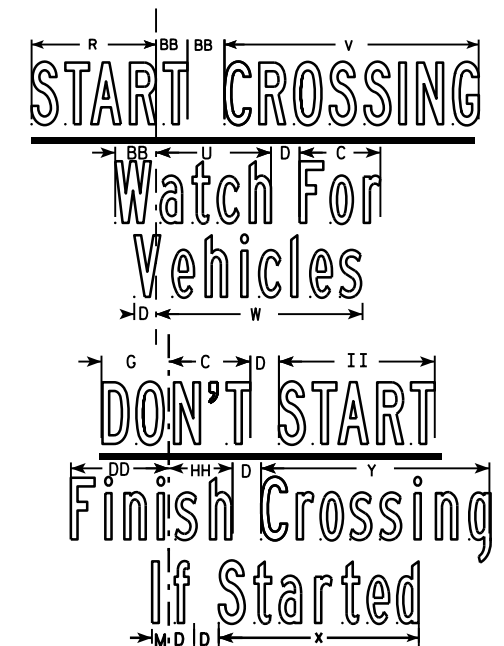

SIZE	A	B	C	D	E	F	G	H	I	J	K	L	M	N	O	P	Q	R	S	T	U	V	W	X	Y	Z	Area sq. ft.
1	6	10	1/2	1/8	1/8	4	3/8	1/4	4 1/8	1/4	2 1/8	3/4	1/8	1 1/8	1/2	1/2	2 1/4	7/8	1	3	3/4	1 3/4	1 5/8	1 3/8	1 1/2	5/8	0.42
2S	9	15	7/8	1/4	1/4	6 1/8	5/8	3/8	5 1/2	1/2	3 1/4	1	1/8	1 3/4	7/8	3/4	3	1 1/4	1 1/2	4 5/8	1 1/8	2 5/8	2 1/8	2	2 3/8	1 3/8	0.94
2M	9	15	7/8	1/4	1/4	6 1/8	5/8	3/8	5 1/2	1/2	3 1/4	1	1/8	1 3/4	7/8	3/4	3	1 1/4	1 1/2	4 5/8	1 1/8	2 5/8	2 1/8	2	2 3/8	1 3/8	0.94
3																											
4																											

SIZE	AA	BB	CC	DD	EE	FF	GG	HH	II	JJ	KK	LL	MM	NN	OO	PP	QO	RR	SS	TT	UU	VV	WW	XX	YY	ZZ	Area sq. ft.
1	1 3/8	1/4	2 1/4	1/2	7/8	7/8	1 1/8	3/8	1	1/2	1 1/8	1 7/8	1 1/8														
2S	2	3/8	3 1/4	1	1 1/4	1 3/8	1 5/8	5/8	1 5/8	3/4	1 3/4	2 7/8	1 5/8														
2M	2	3/8	3 1/4	1	1 1/4	1 3/8	1 5/8	5/8	1 5/8	3/4	1 3/4	2 7/8	1 5/8														
3																											
4																											

STANDARD SIGN

R10-3EL,R,D

WISCONSIN DEPT OF TRANSPORTATION

APPROVED

Matthew R. Rauch

for State Traffic Engineer


DATE 4/12/2011

PLATE NO. R10-3E.2


SHEET NO:

E

9



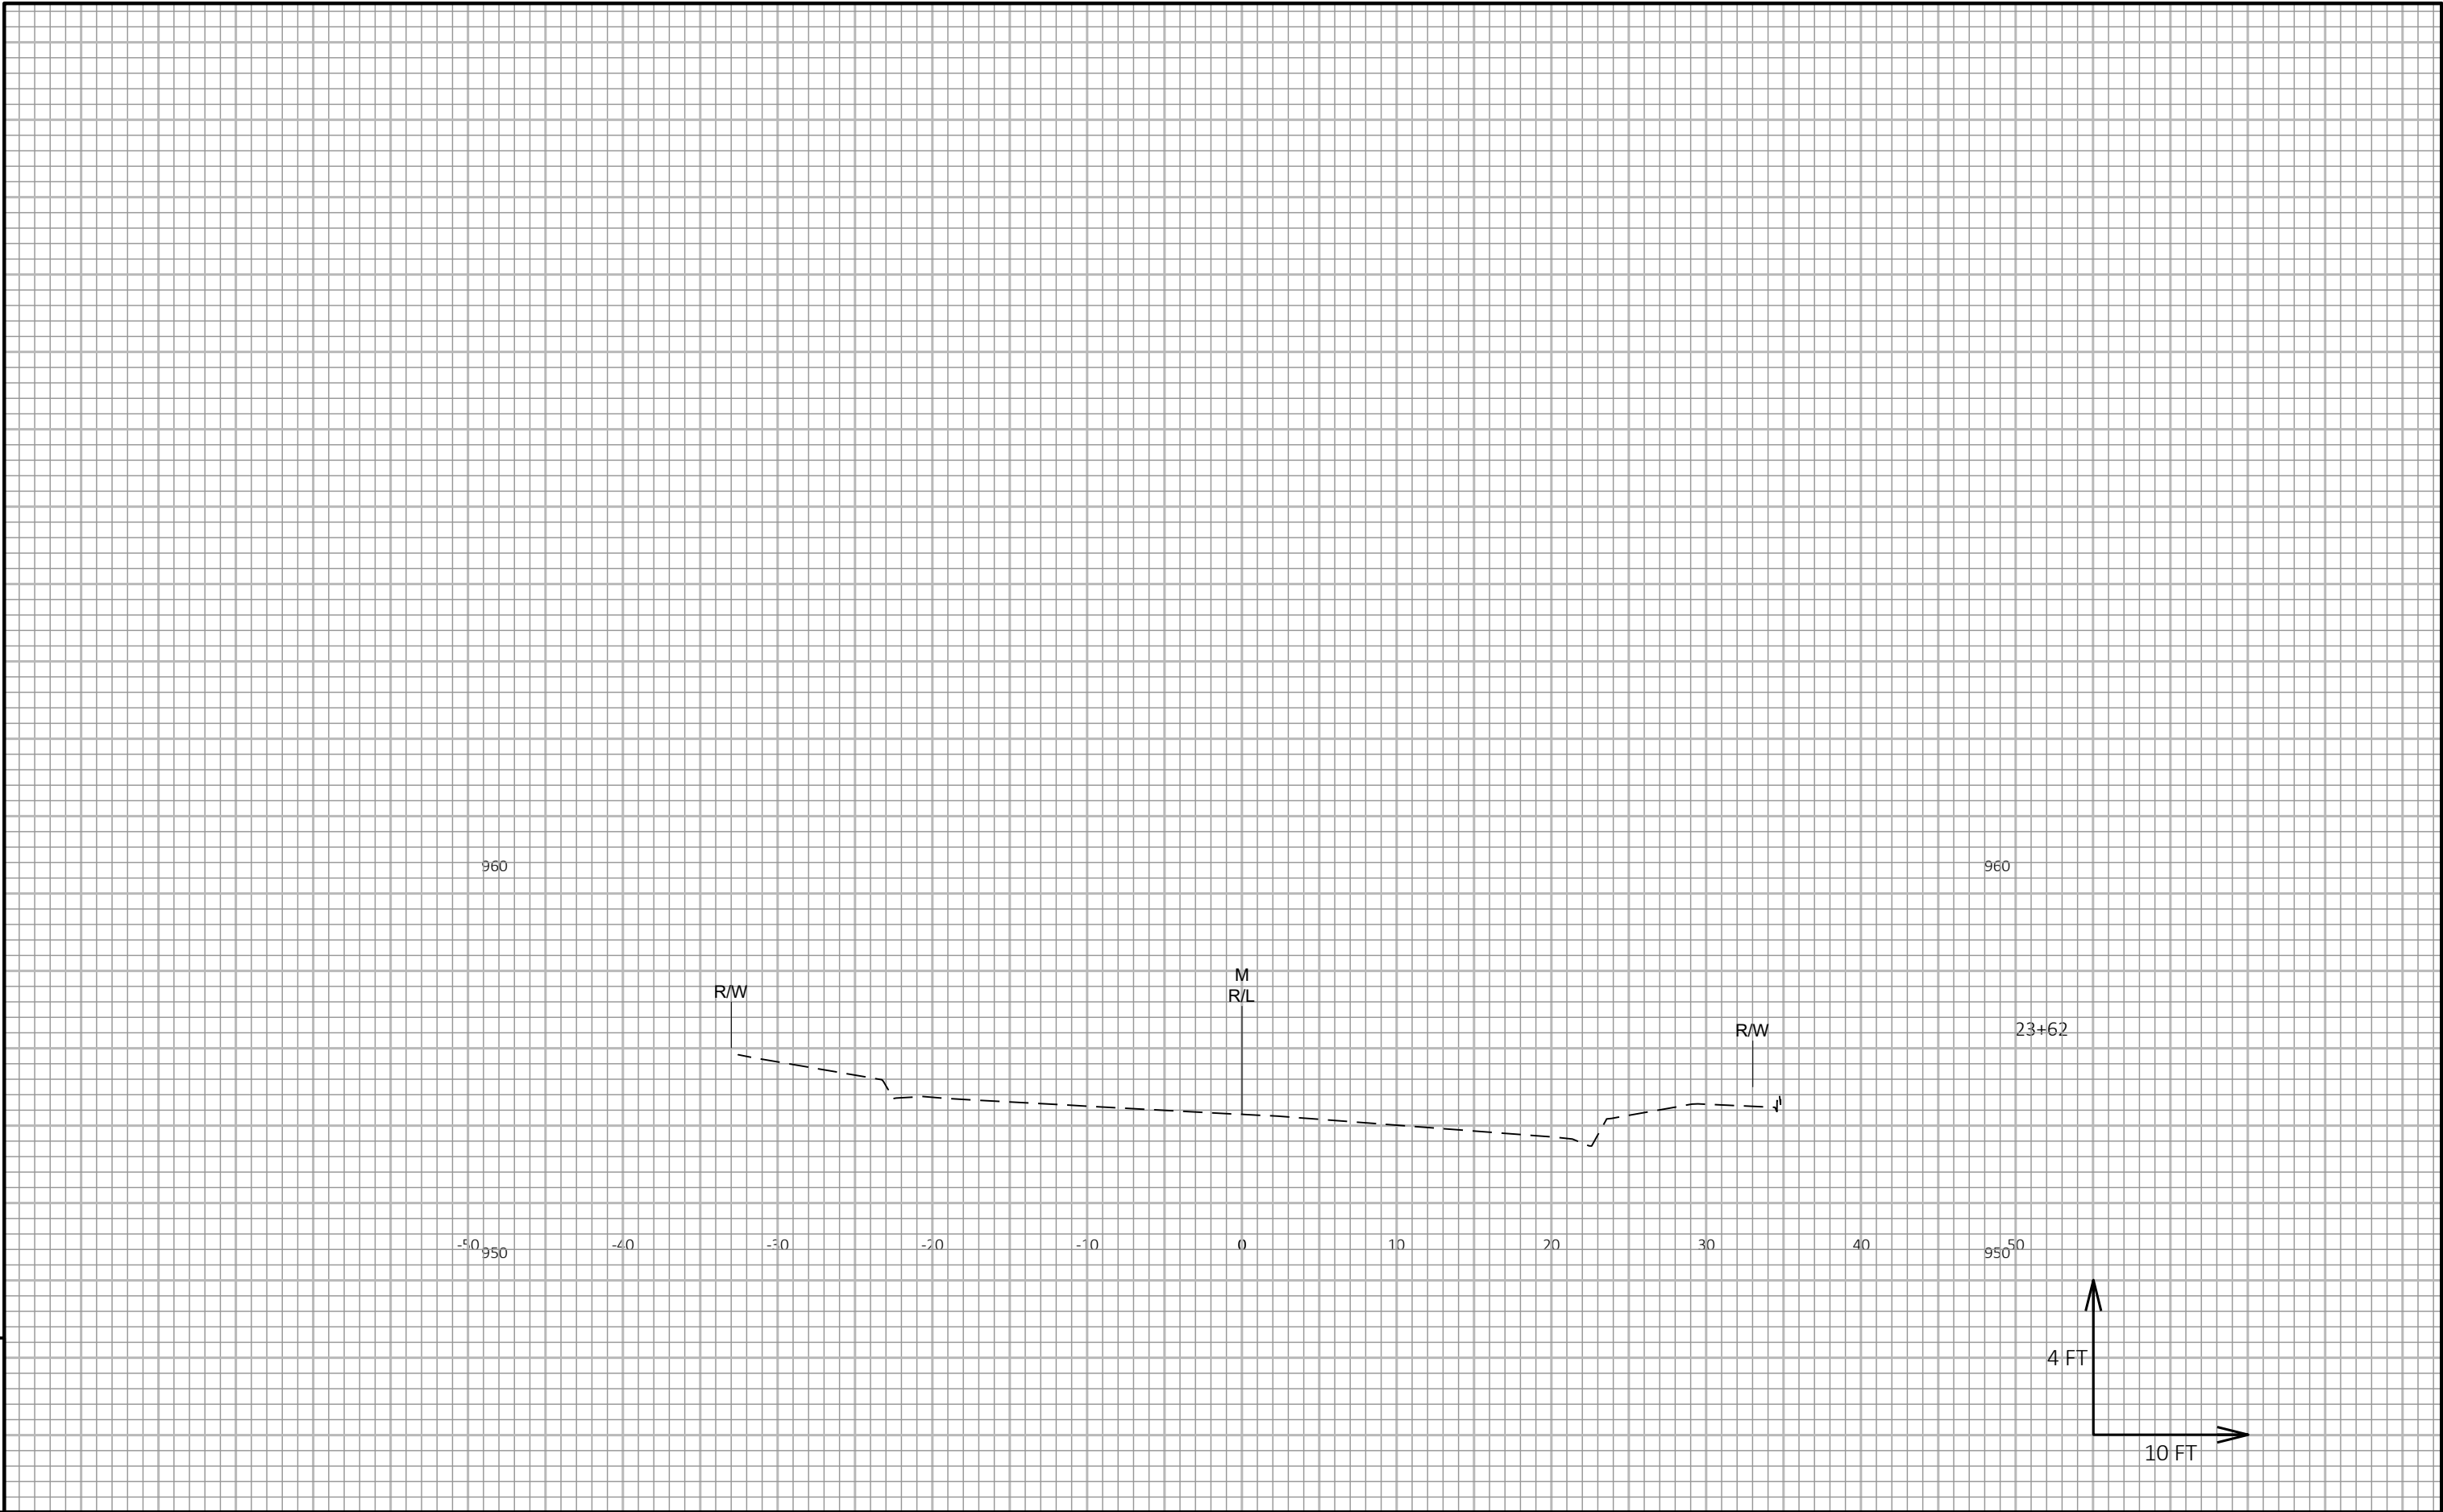


9

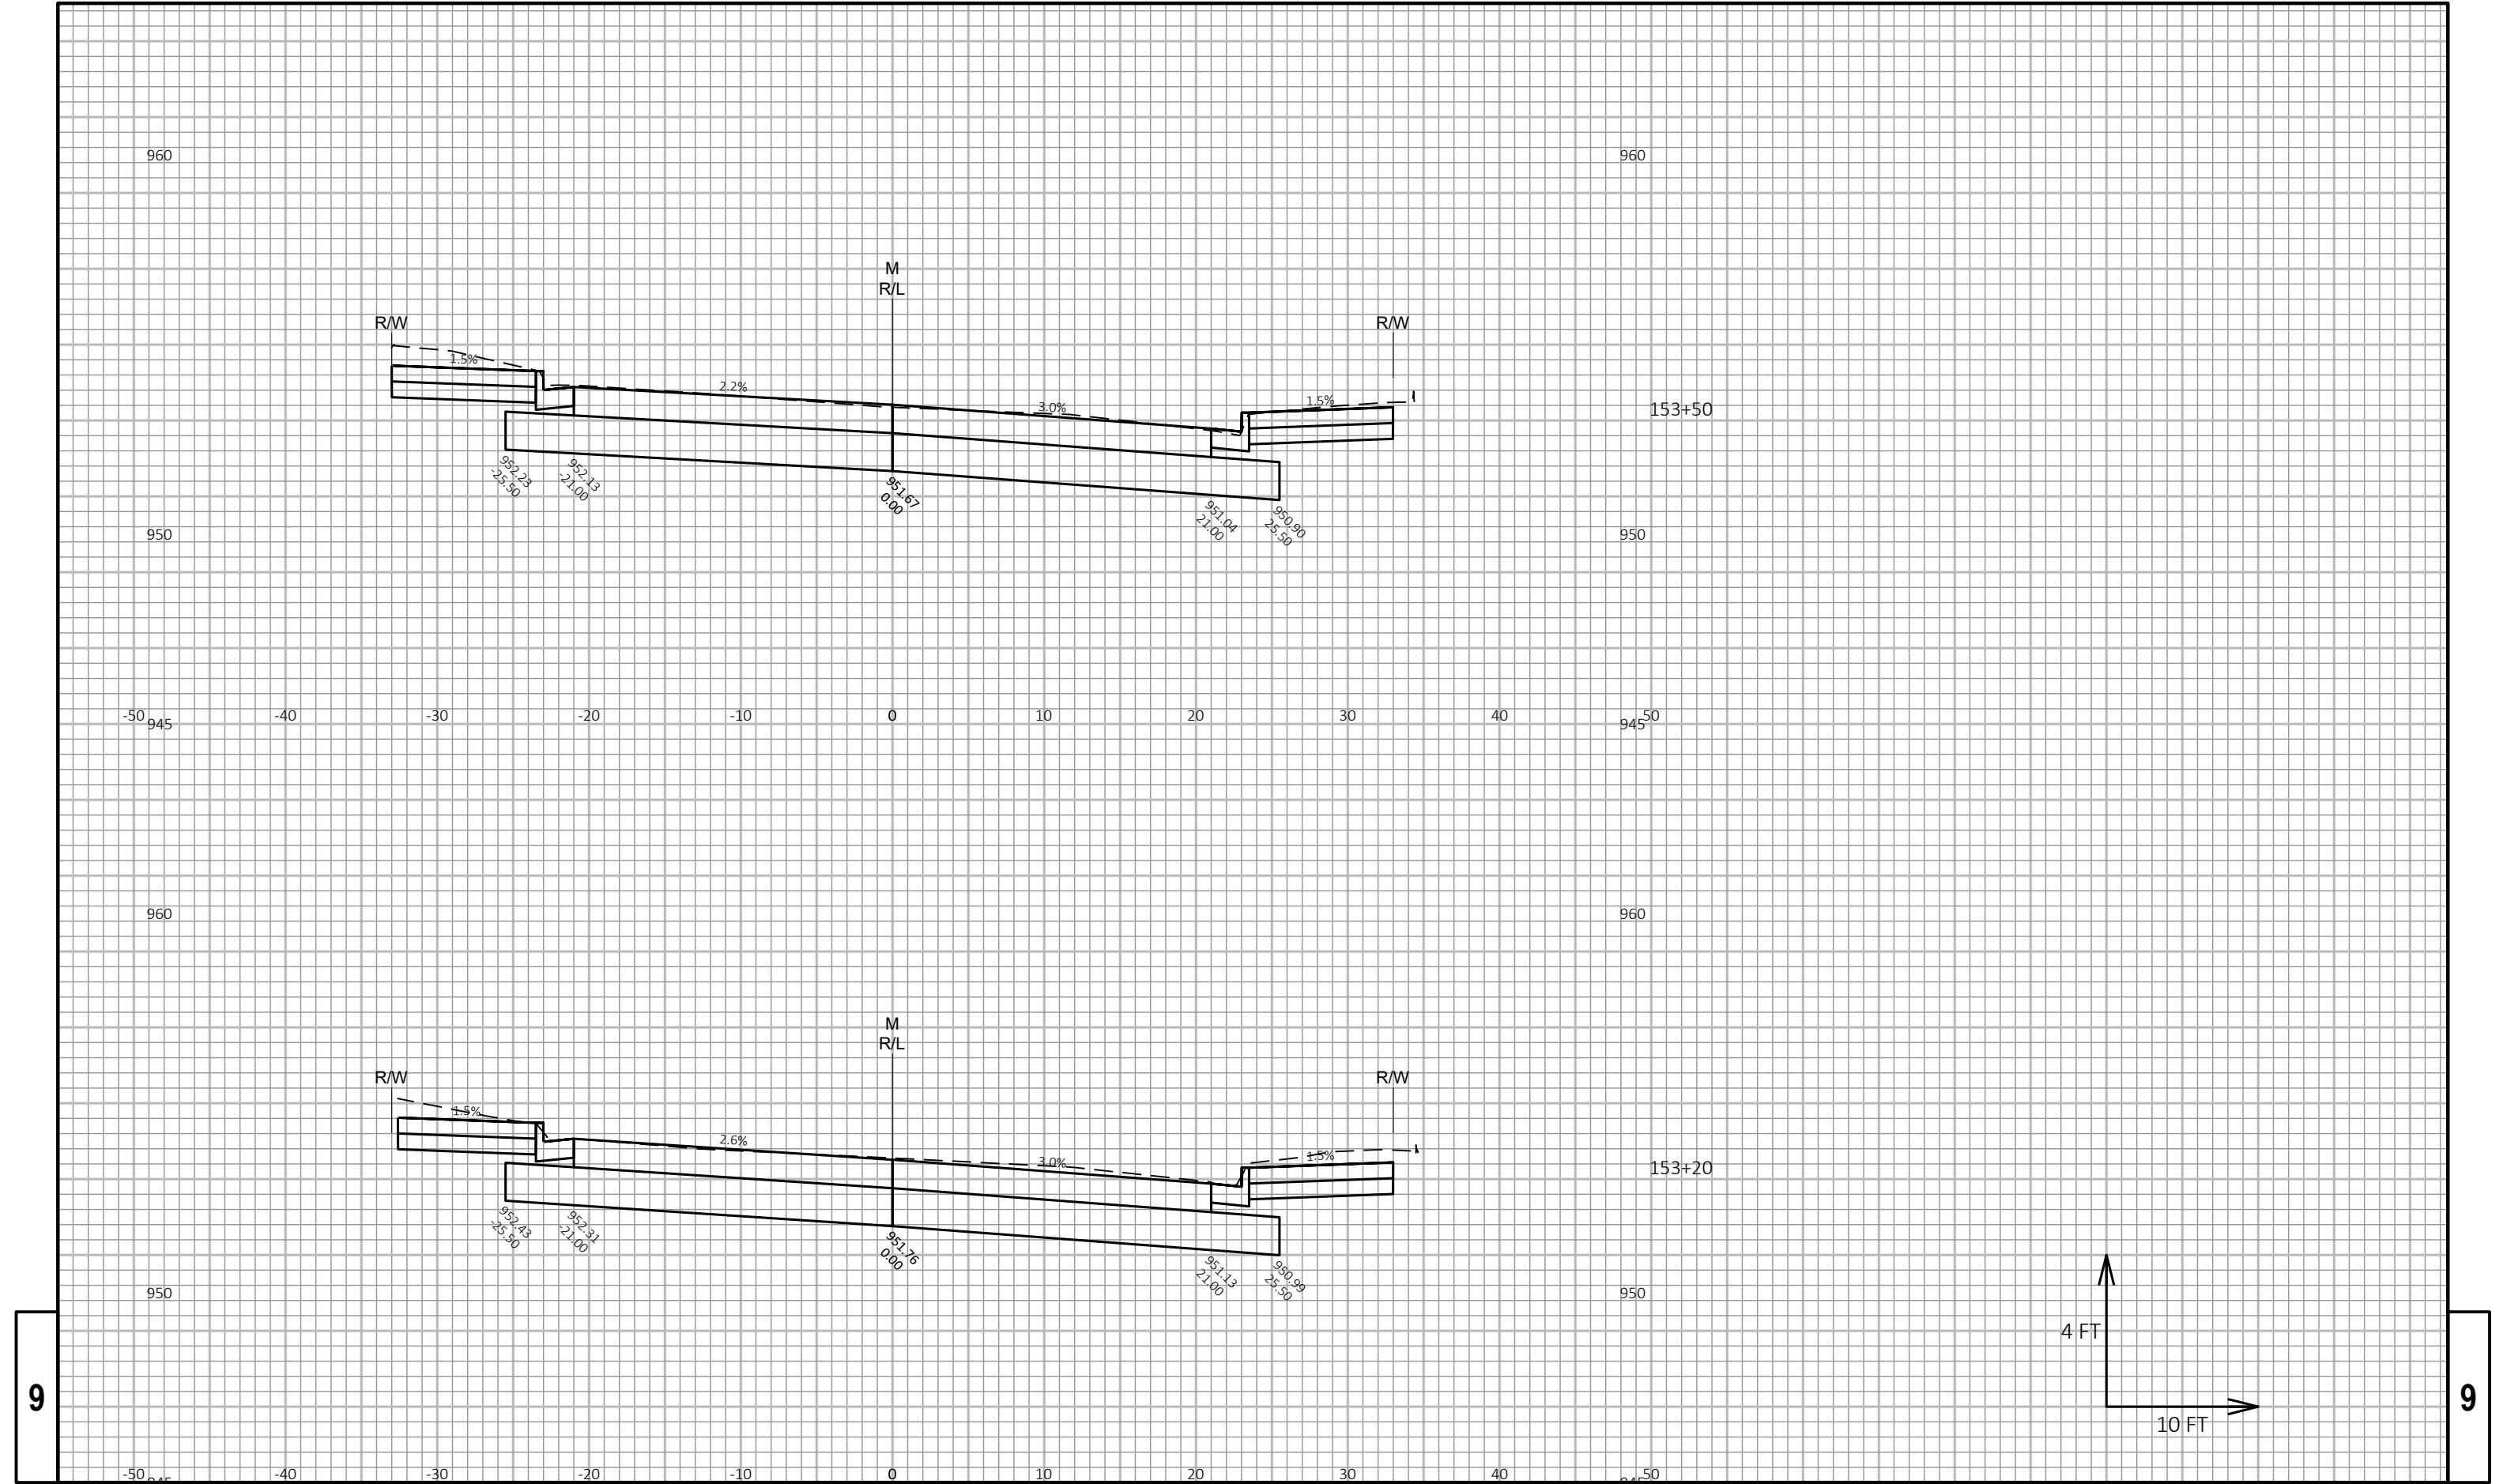

9



9

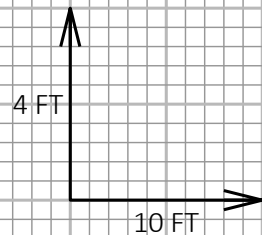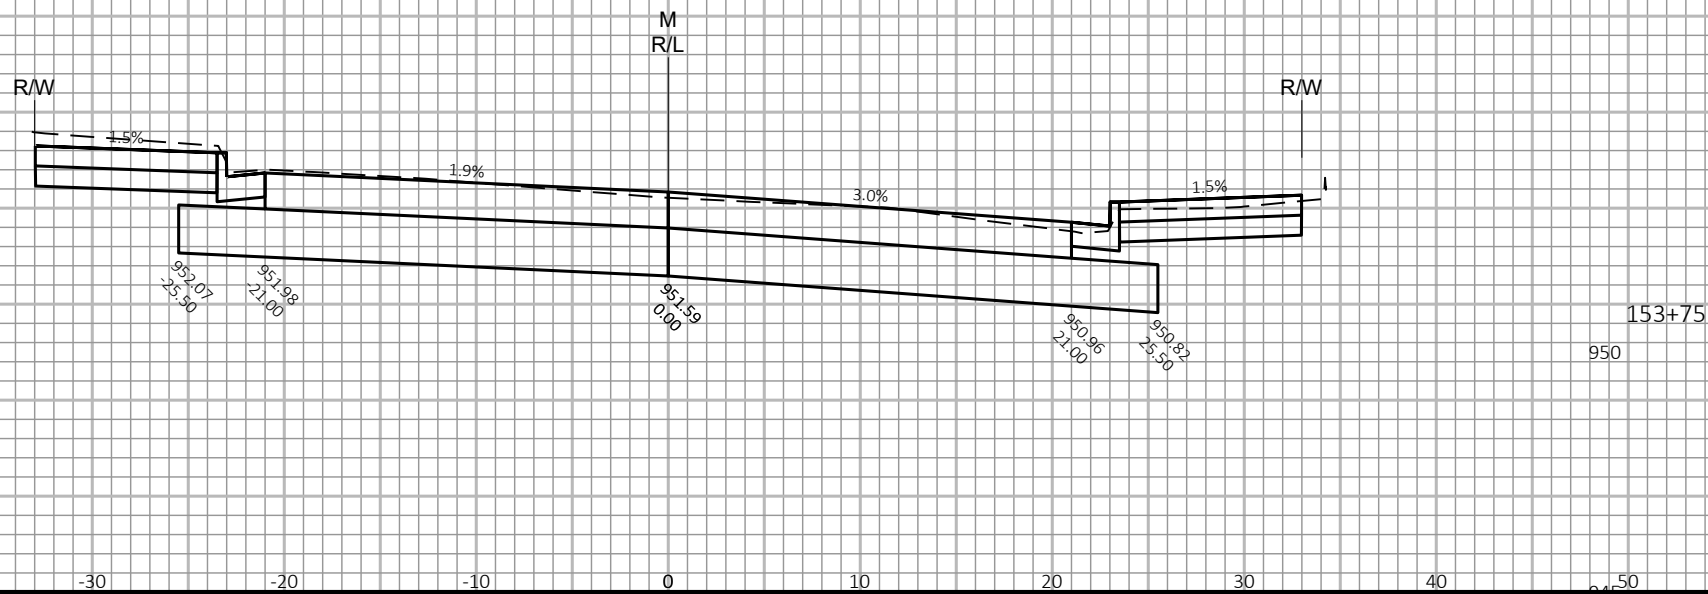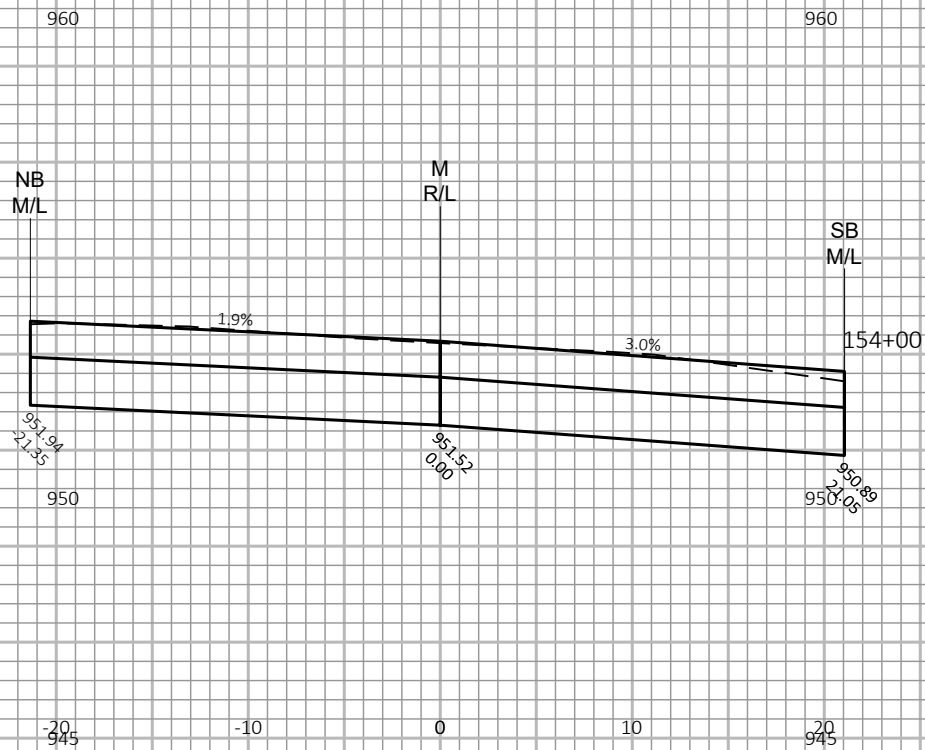


9

9

9

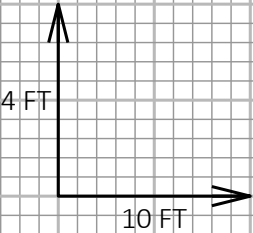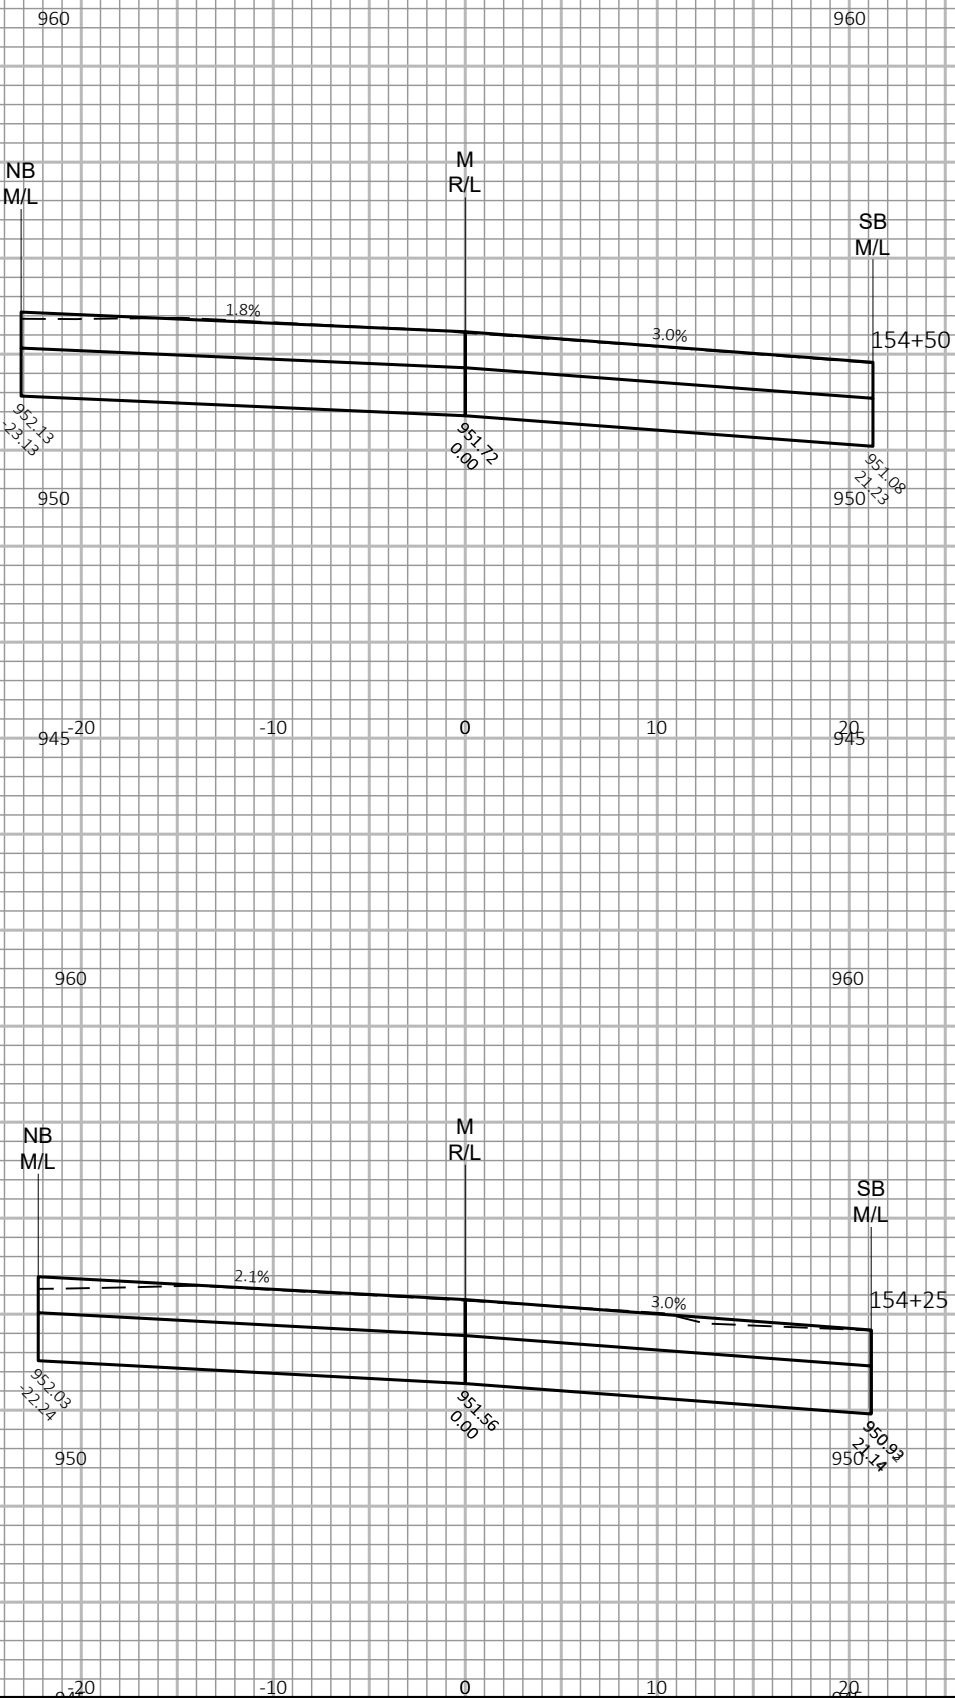


9

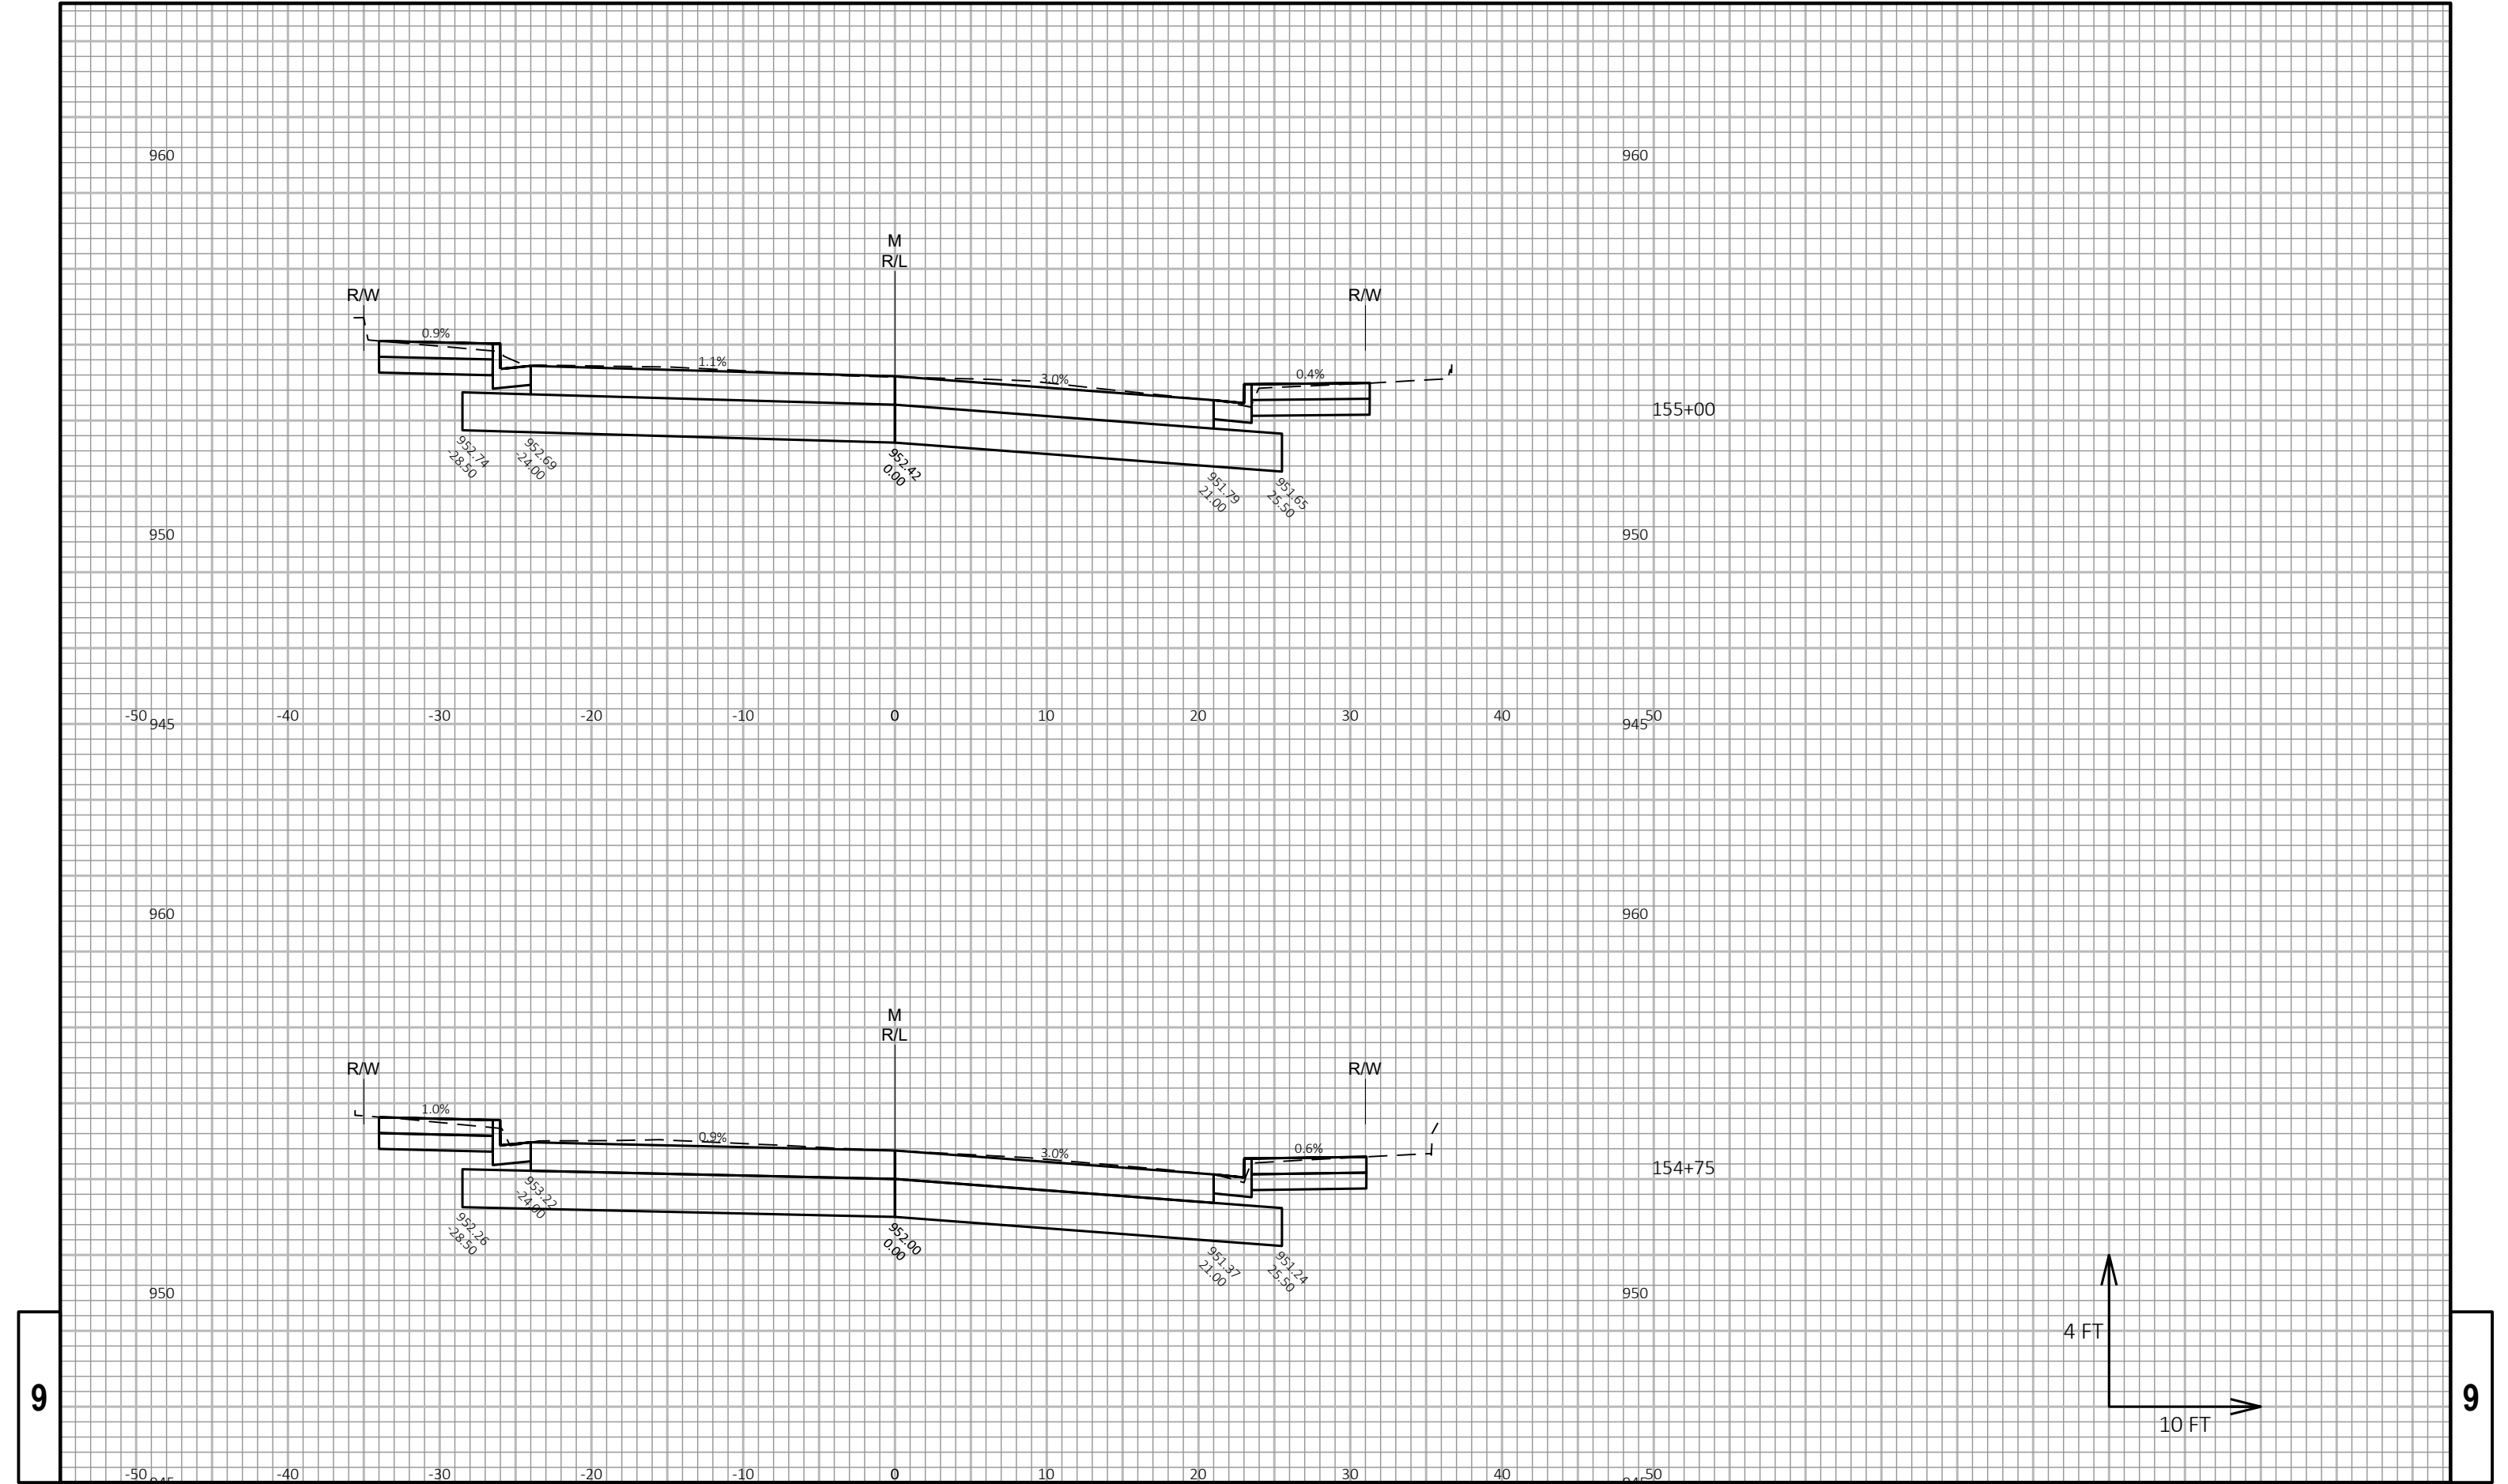


9

9

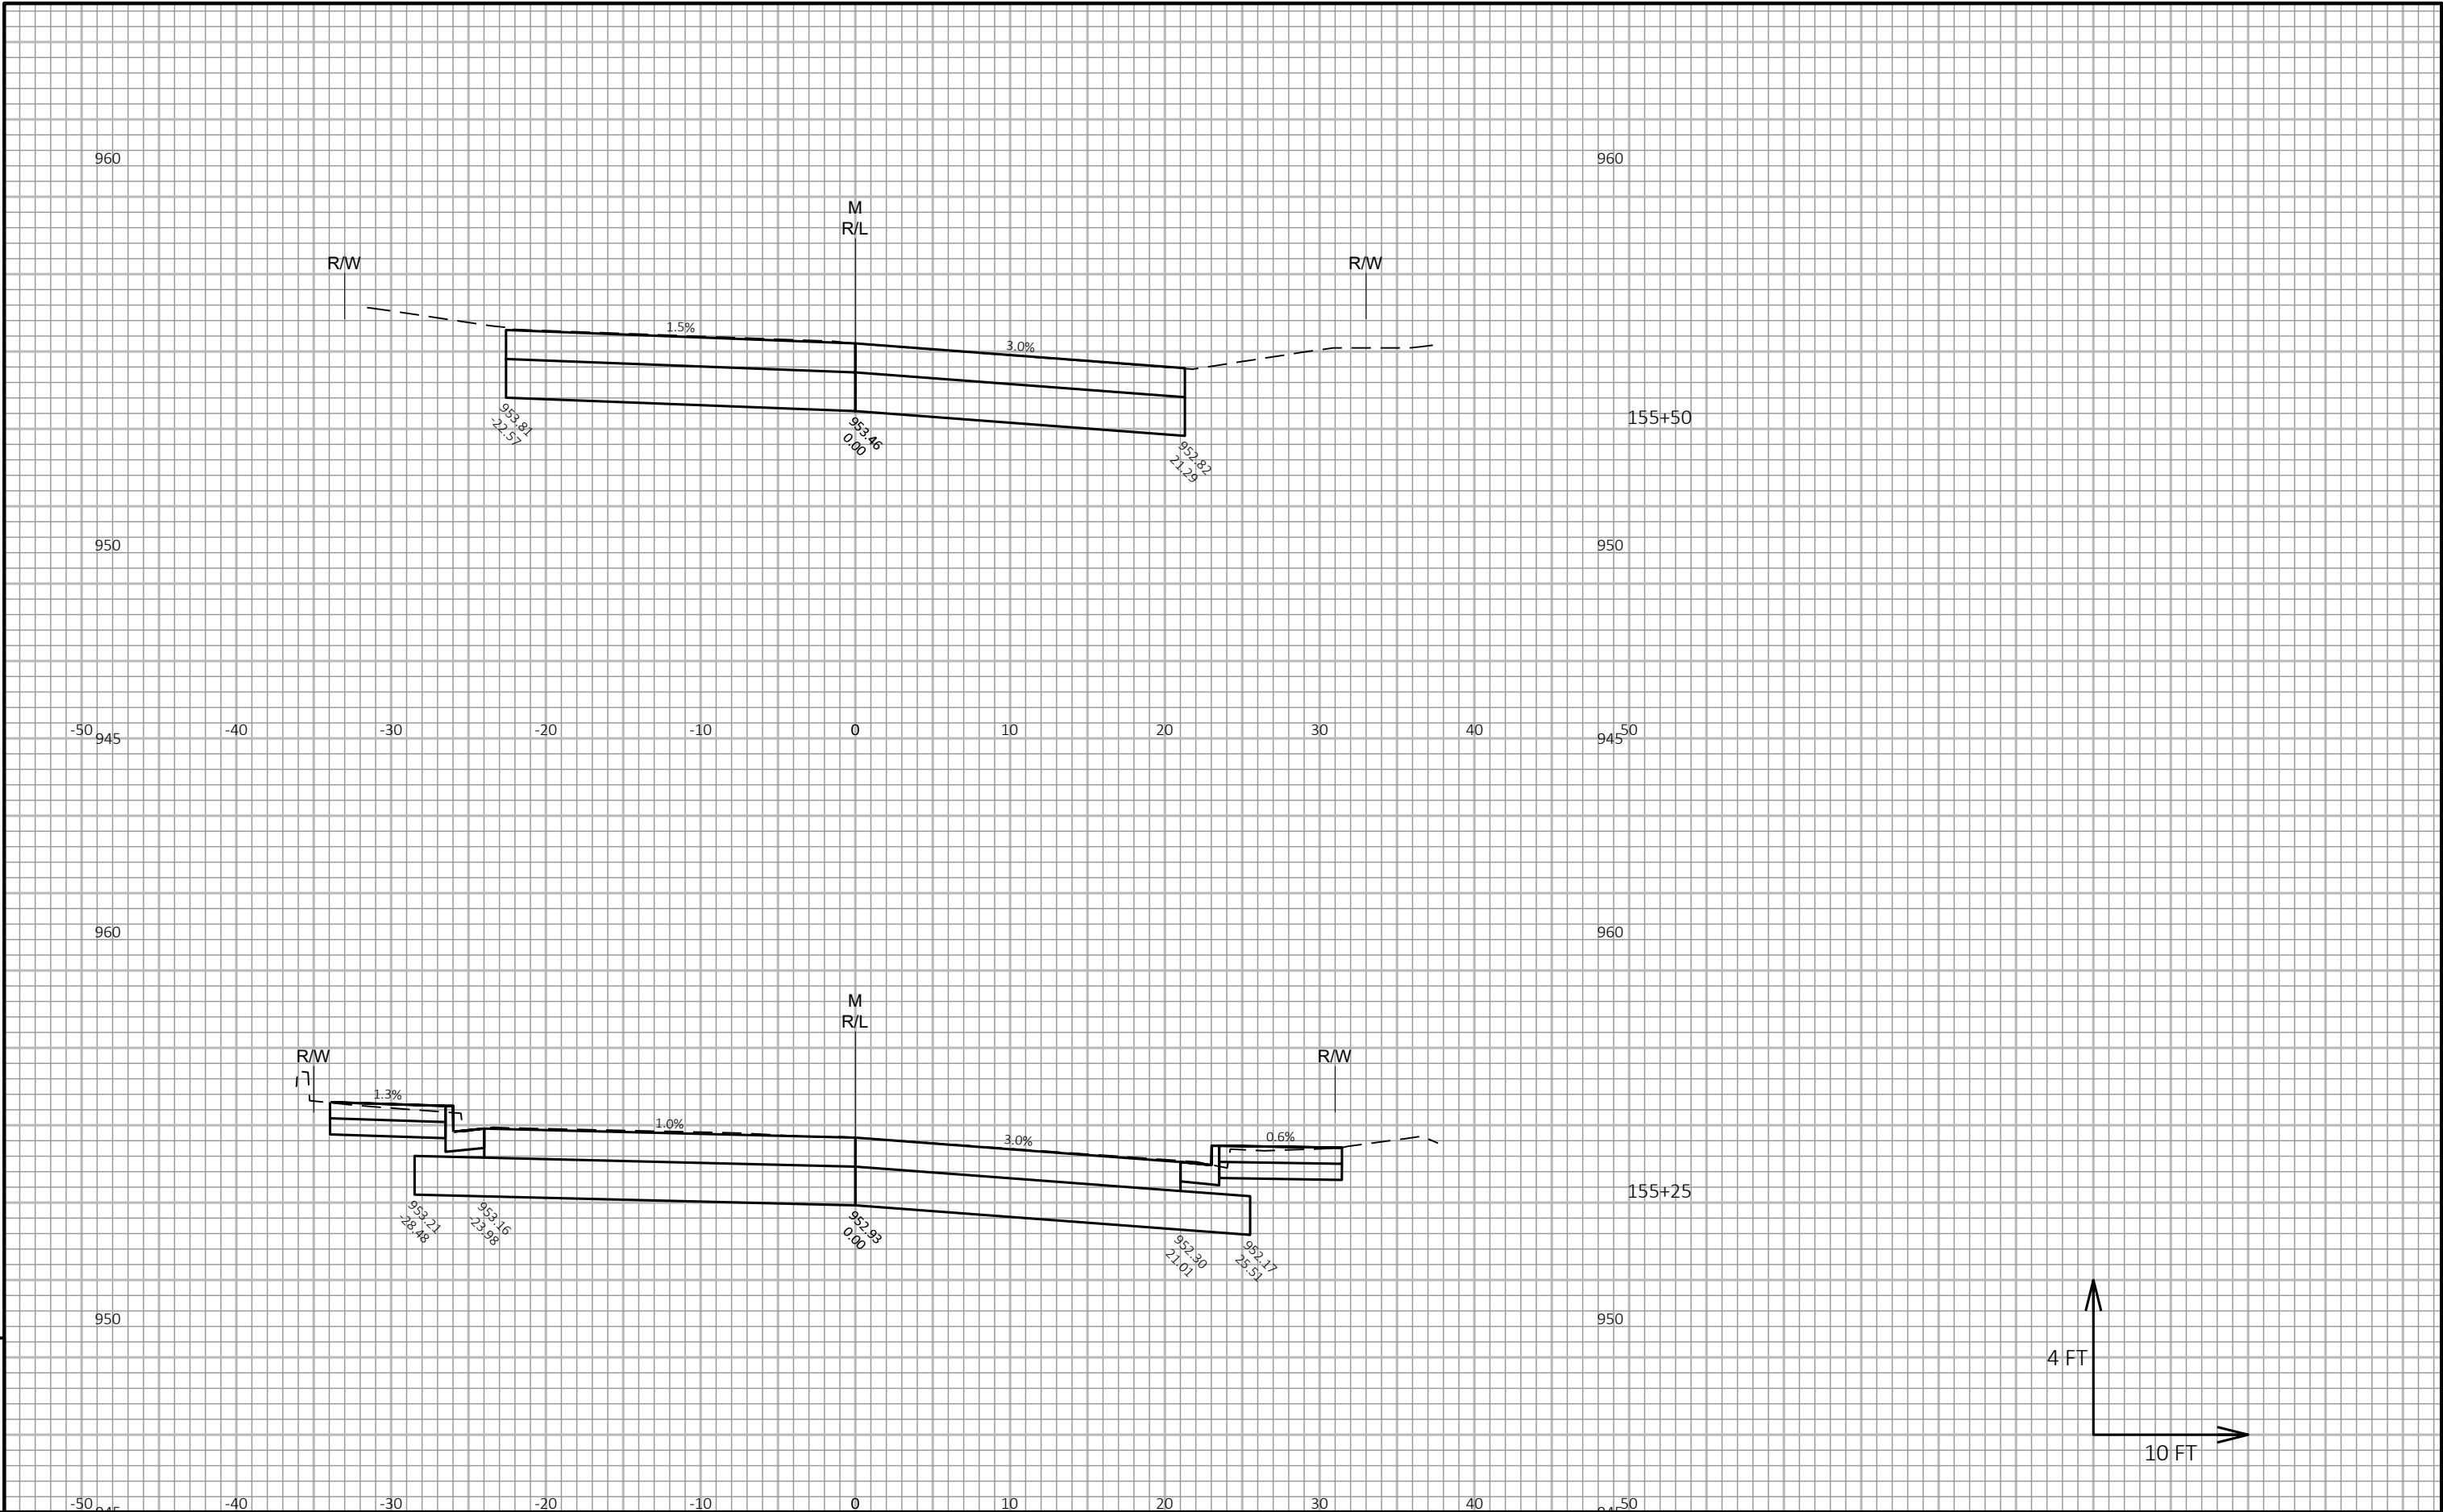


9


9

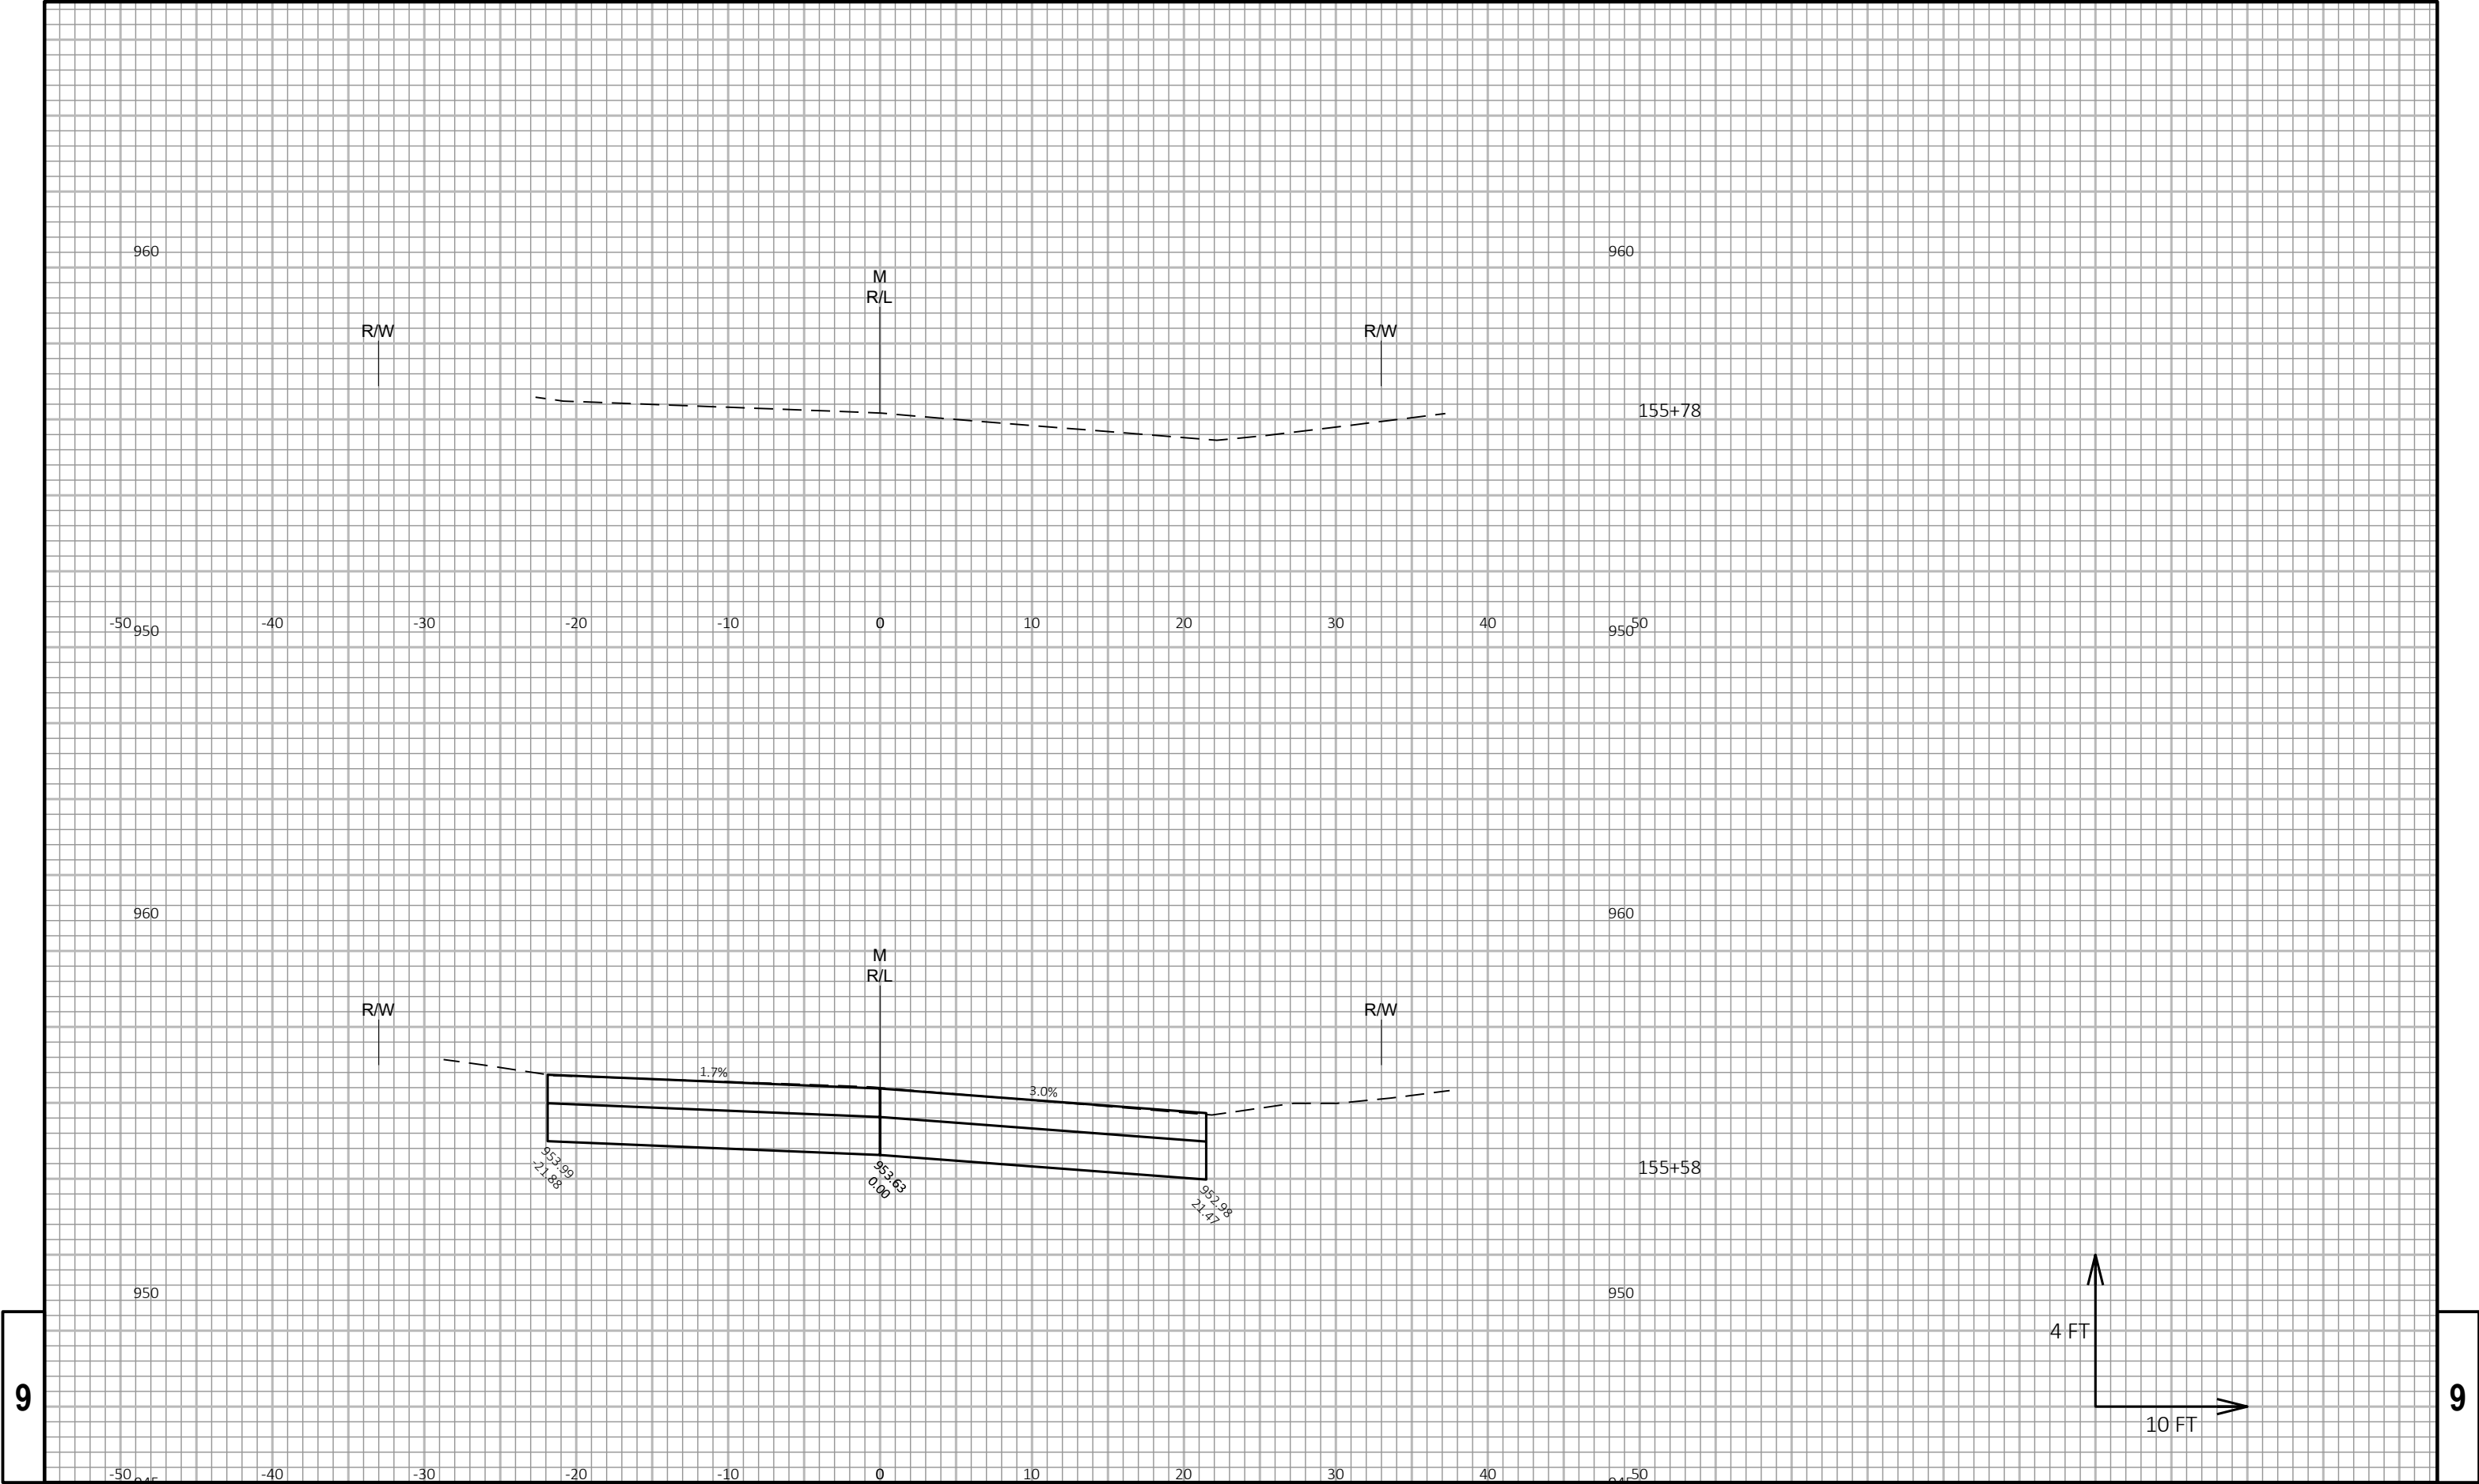

9

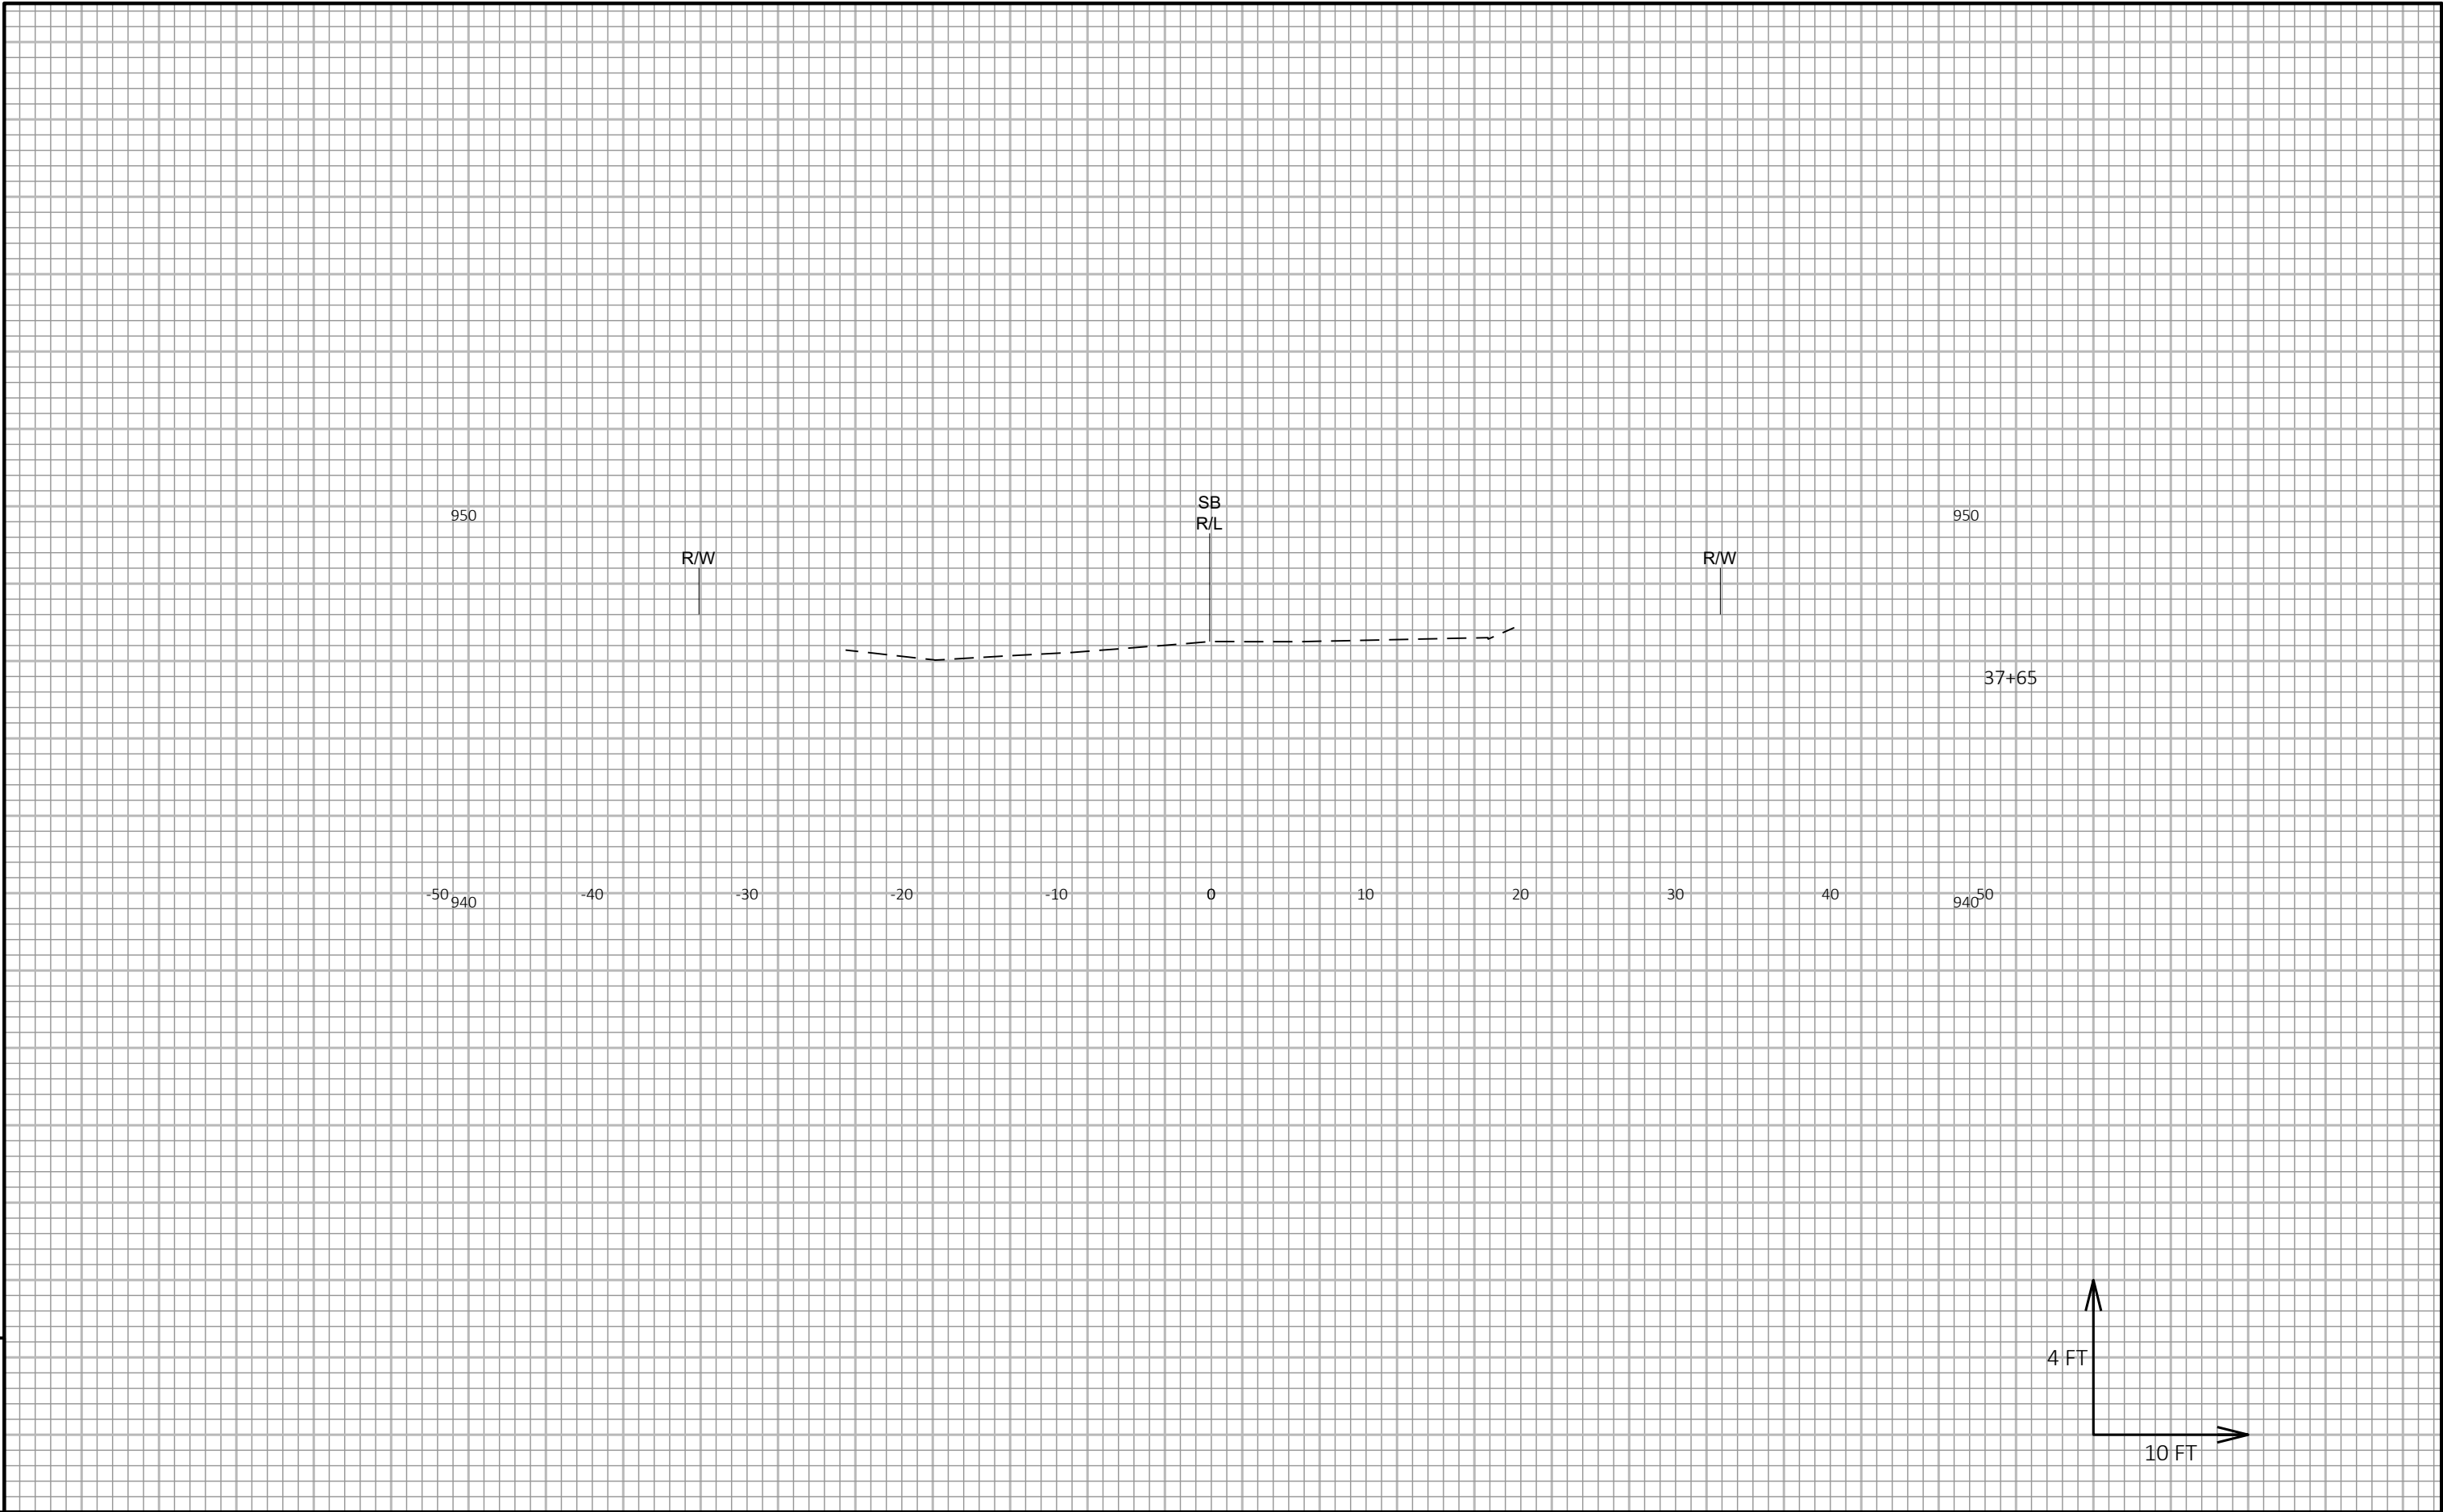


9

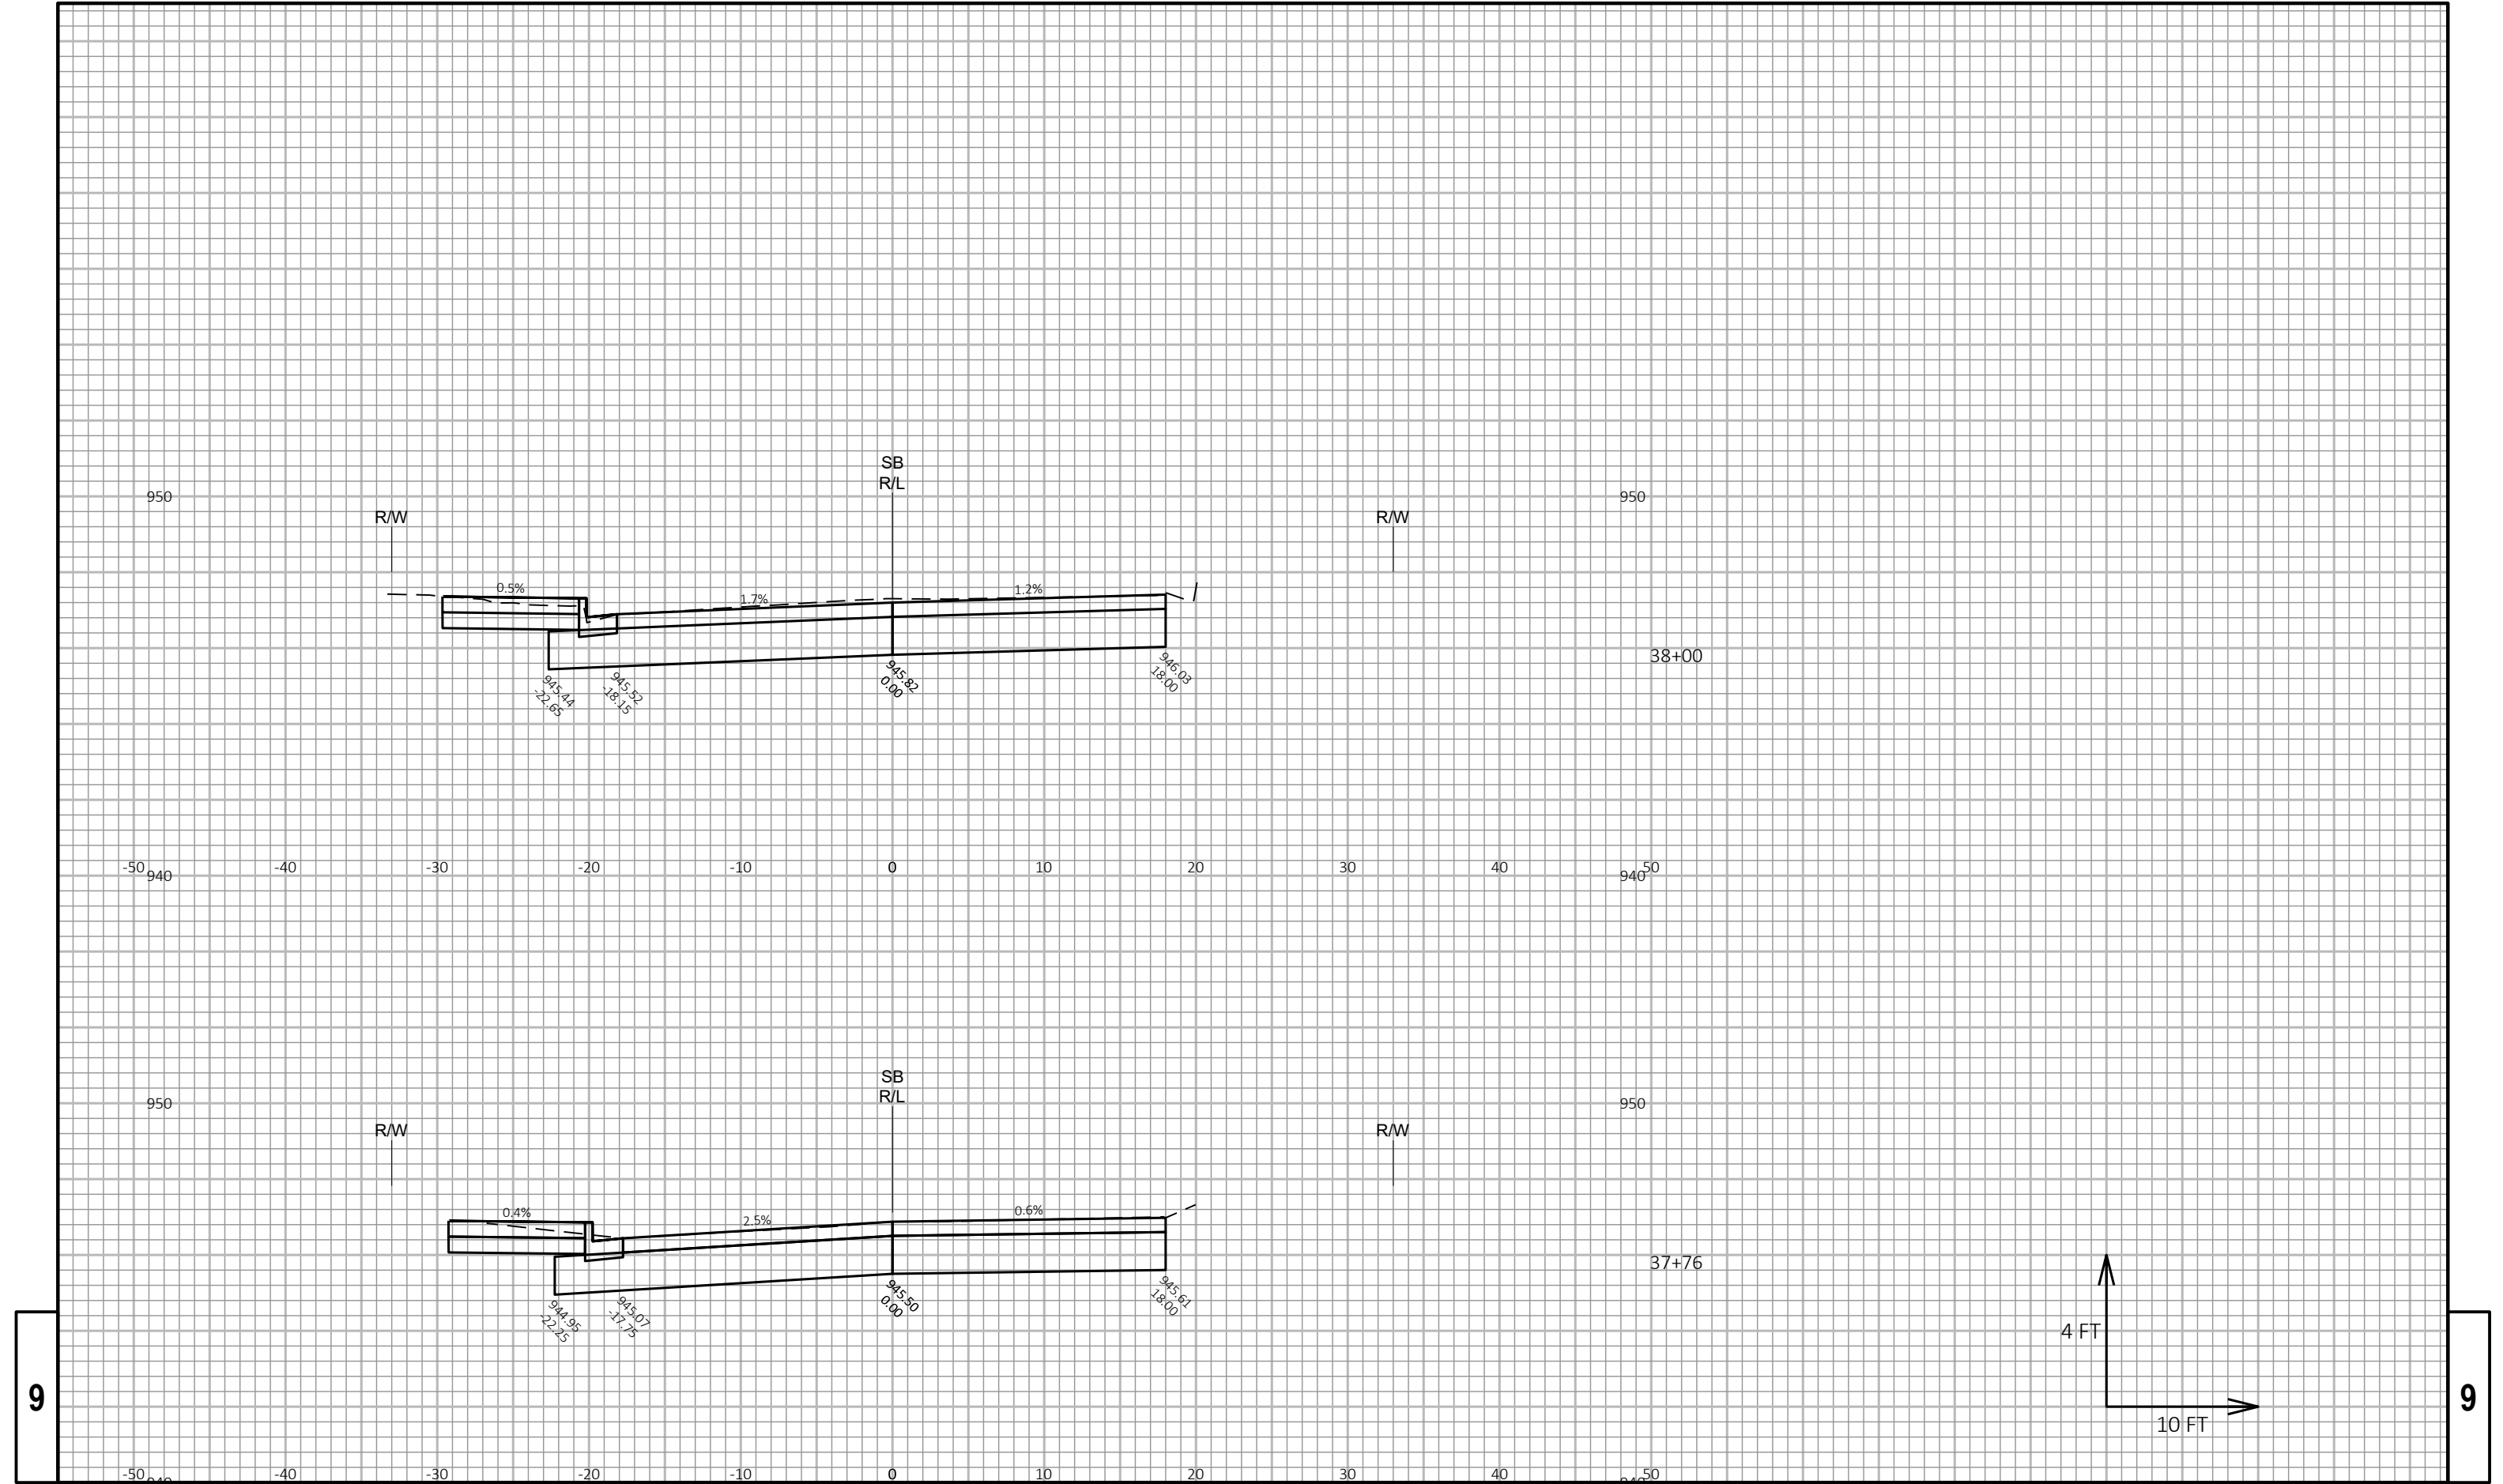


9

9

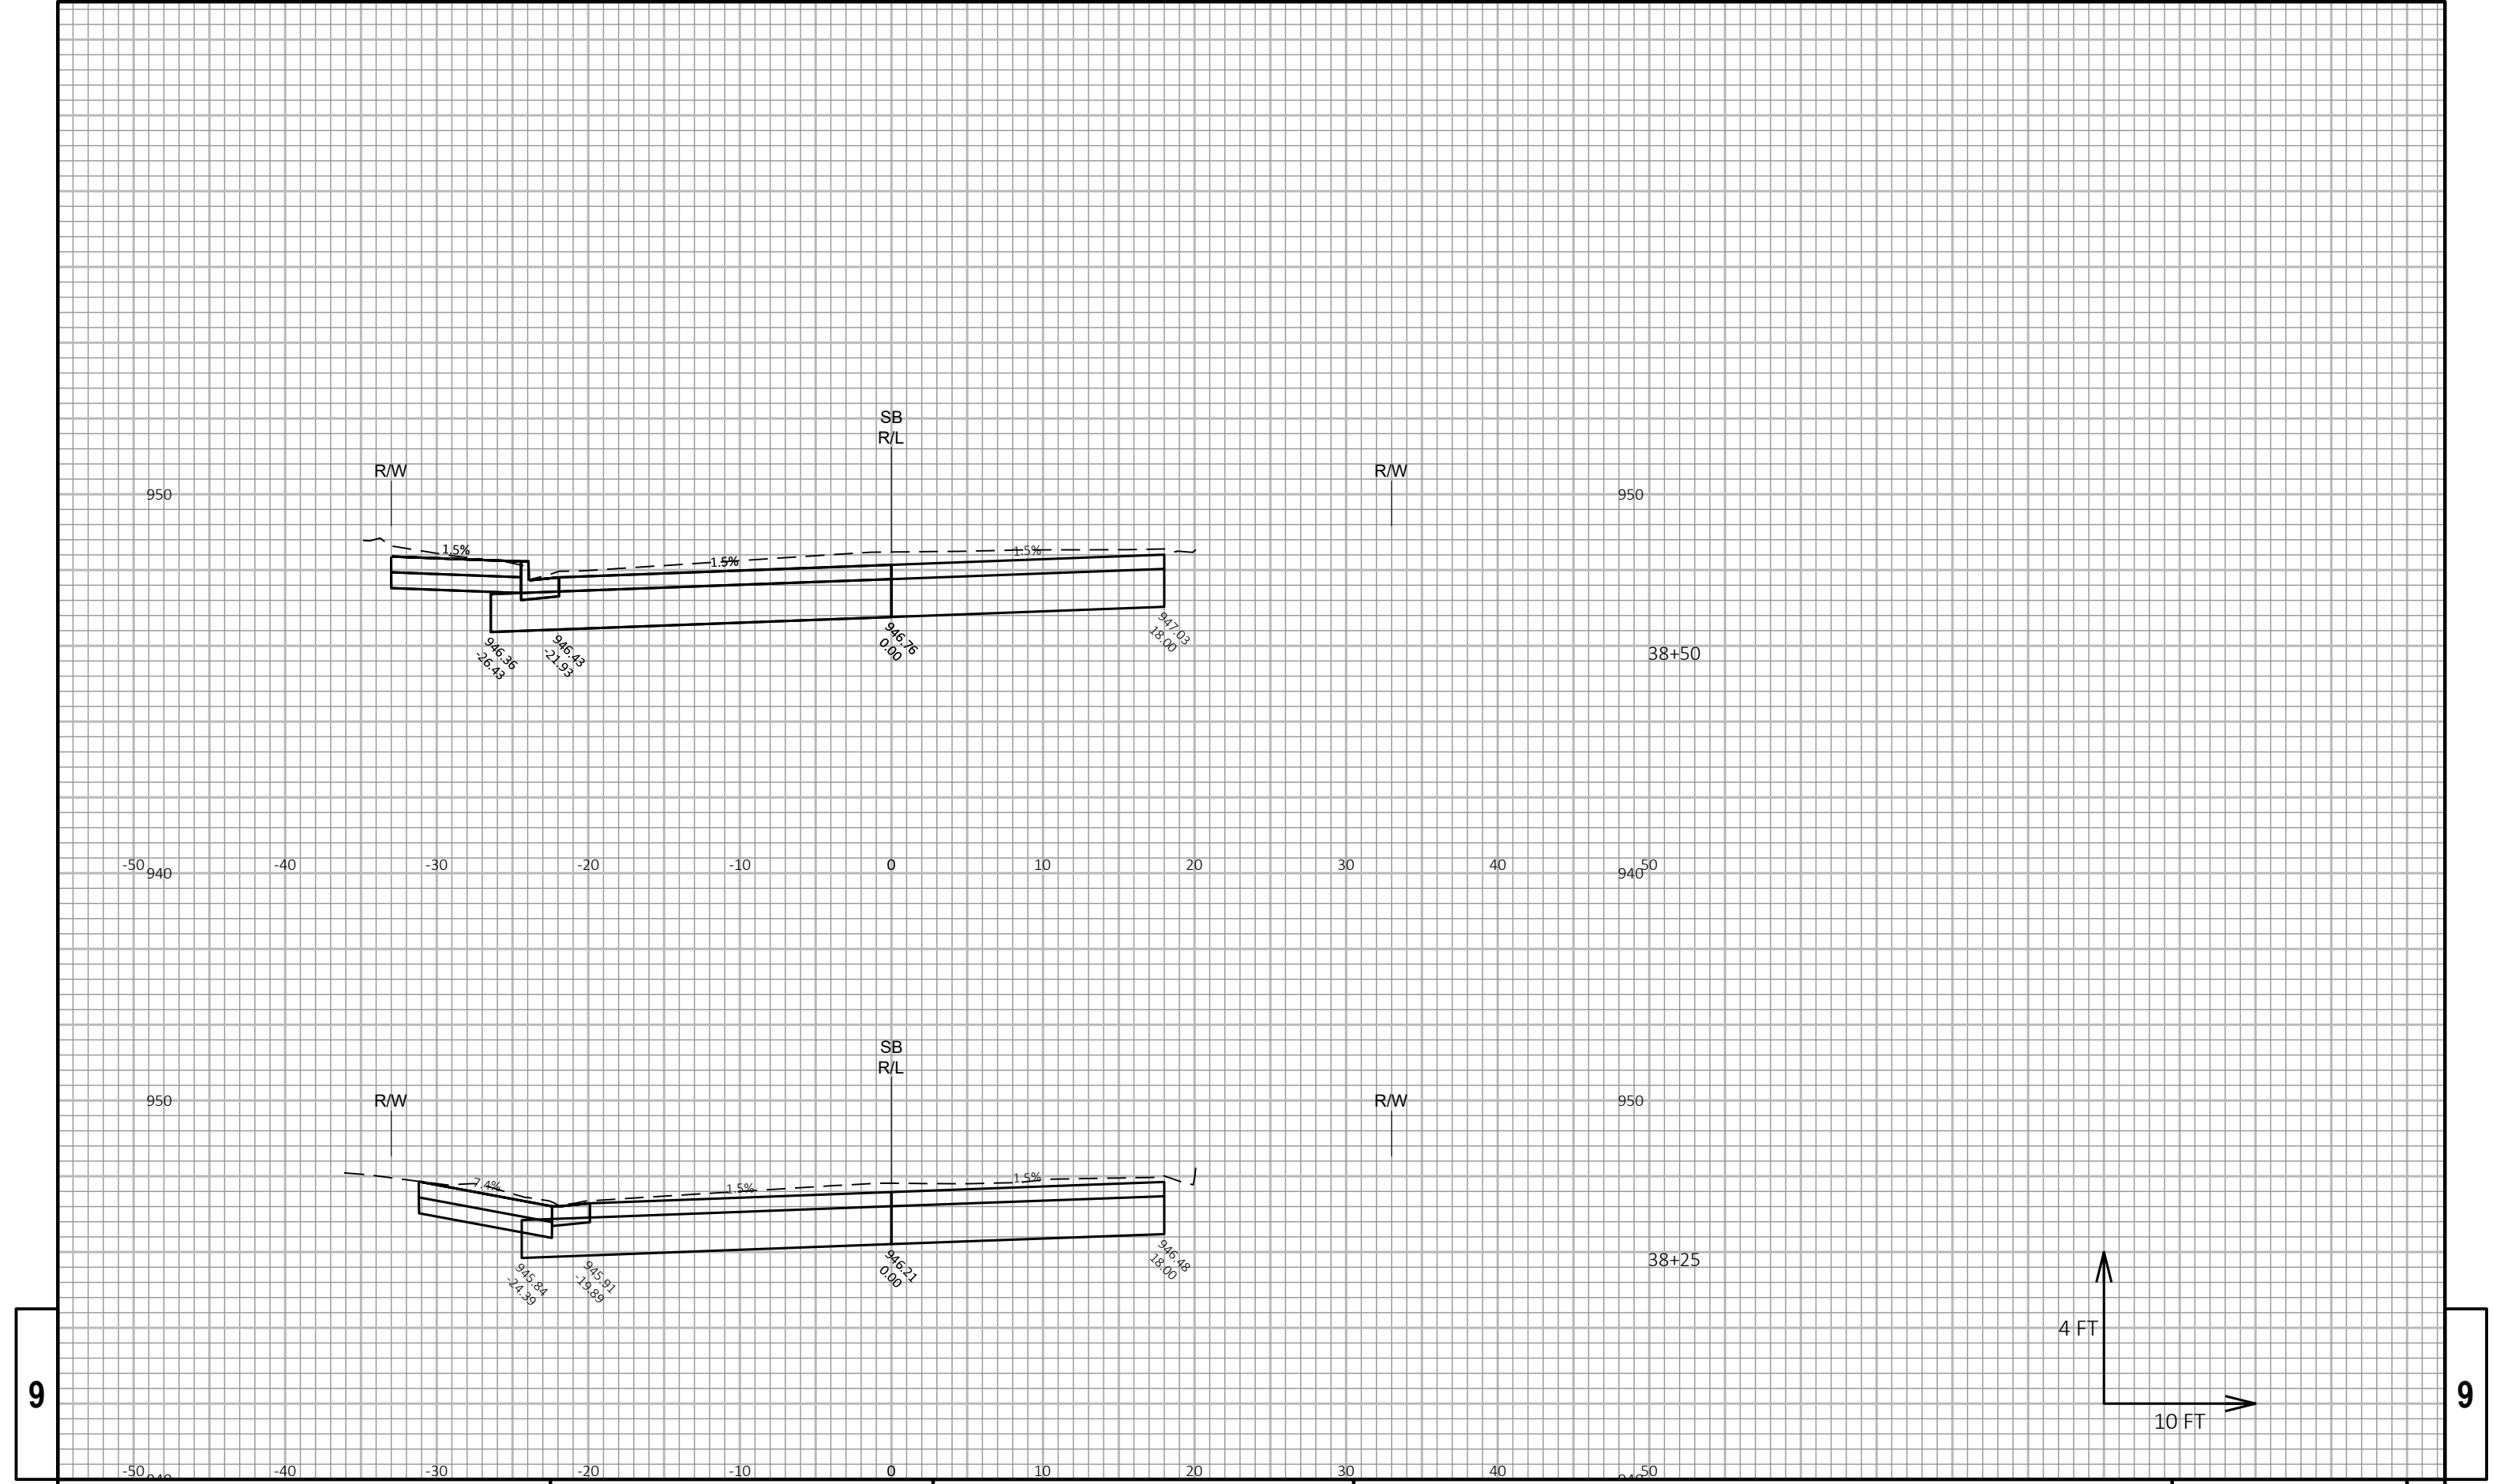


9

9

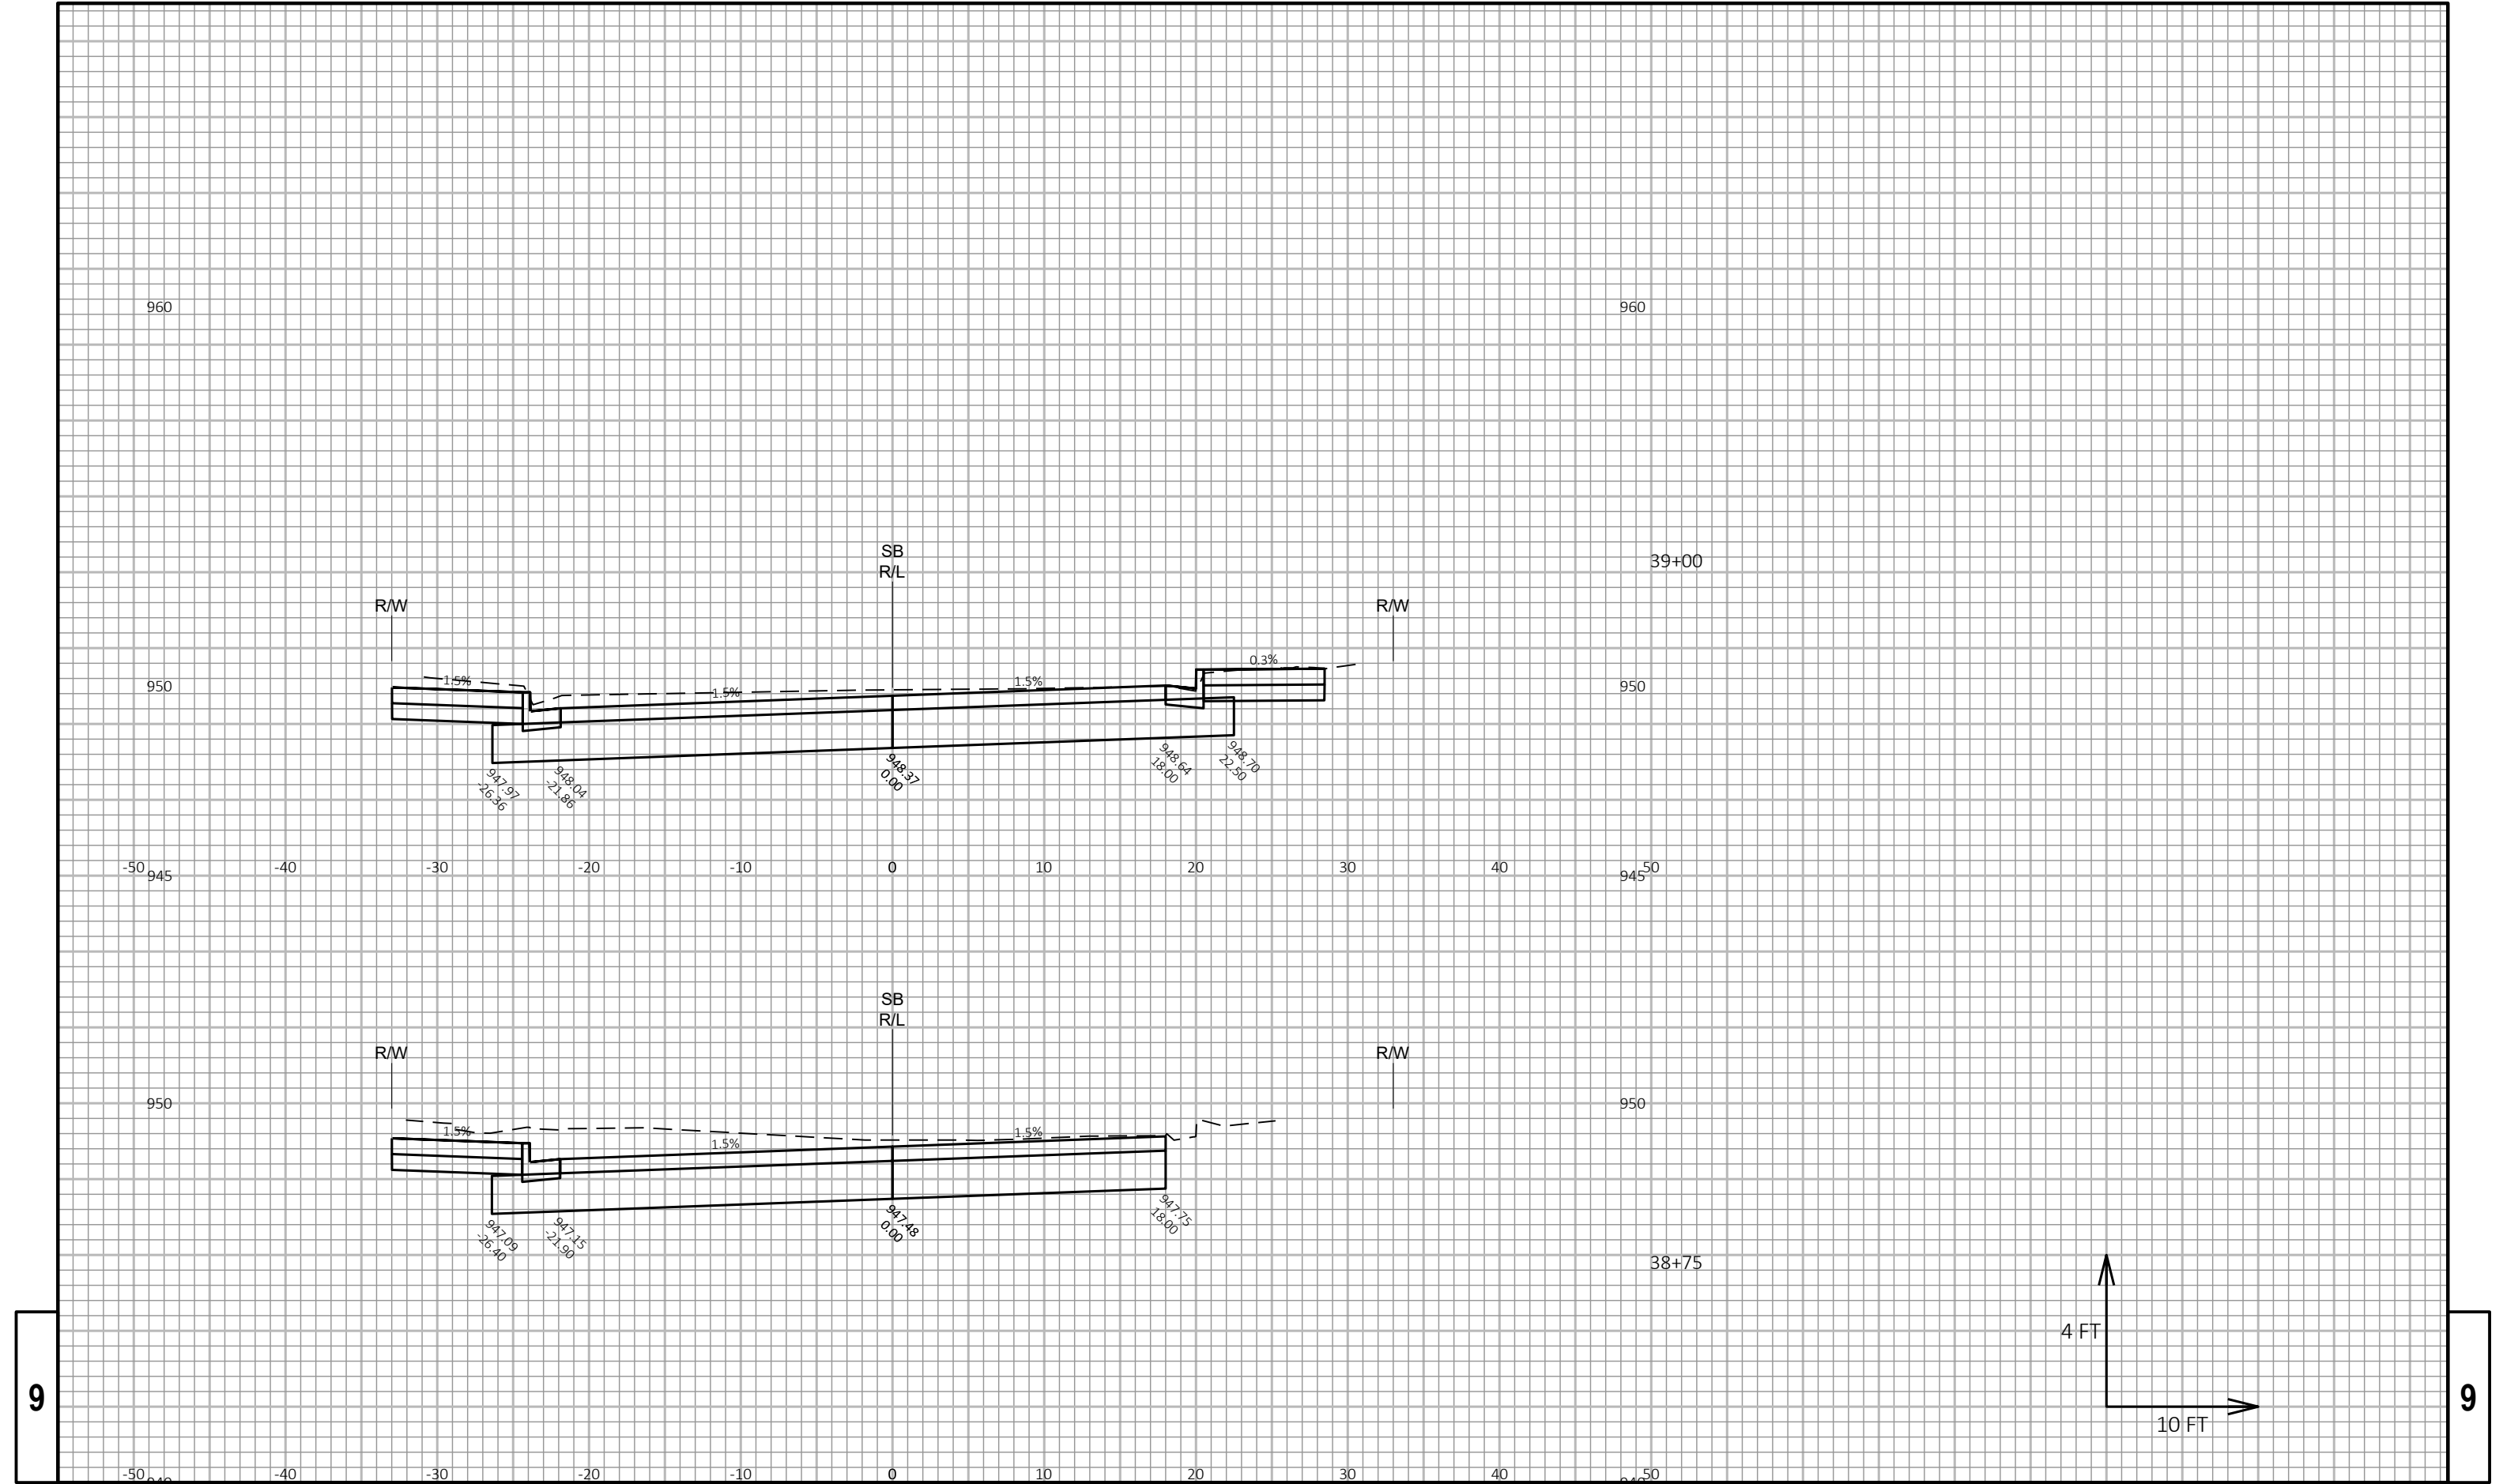


9


9

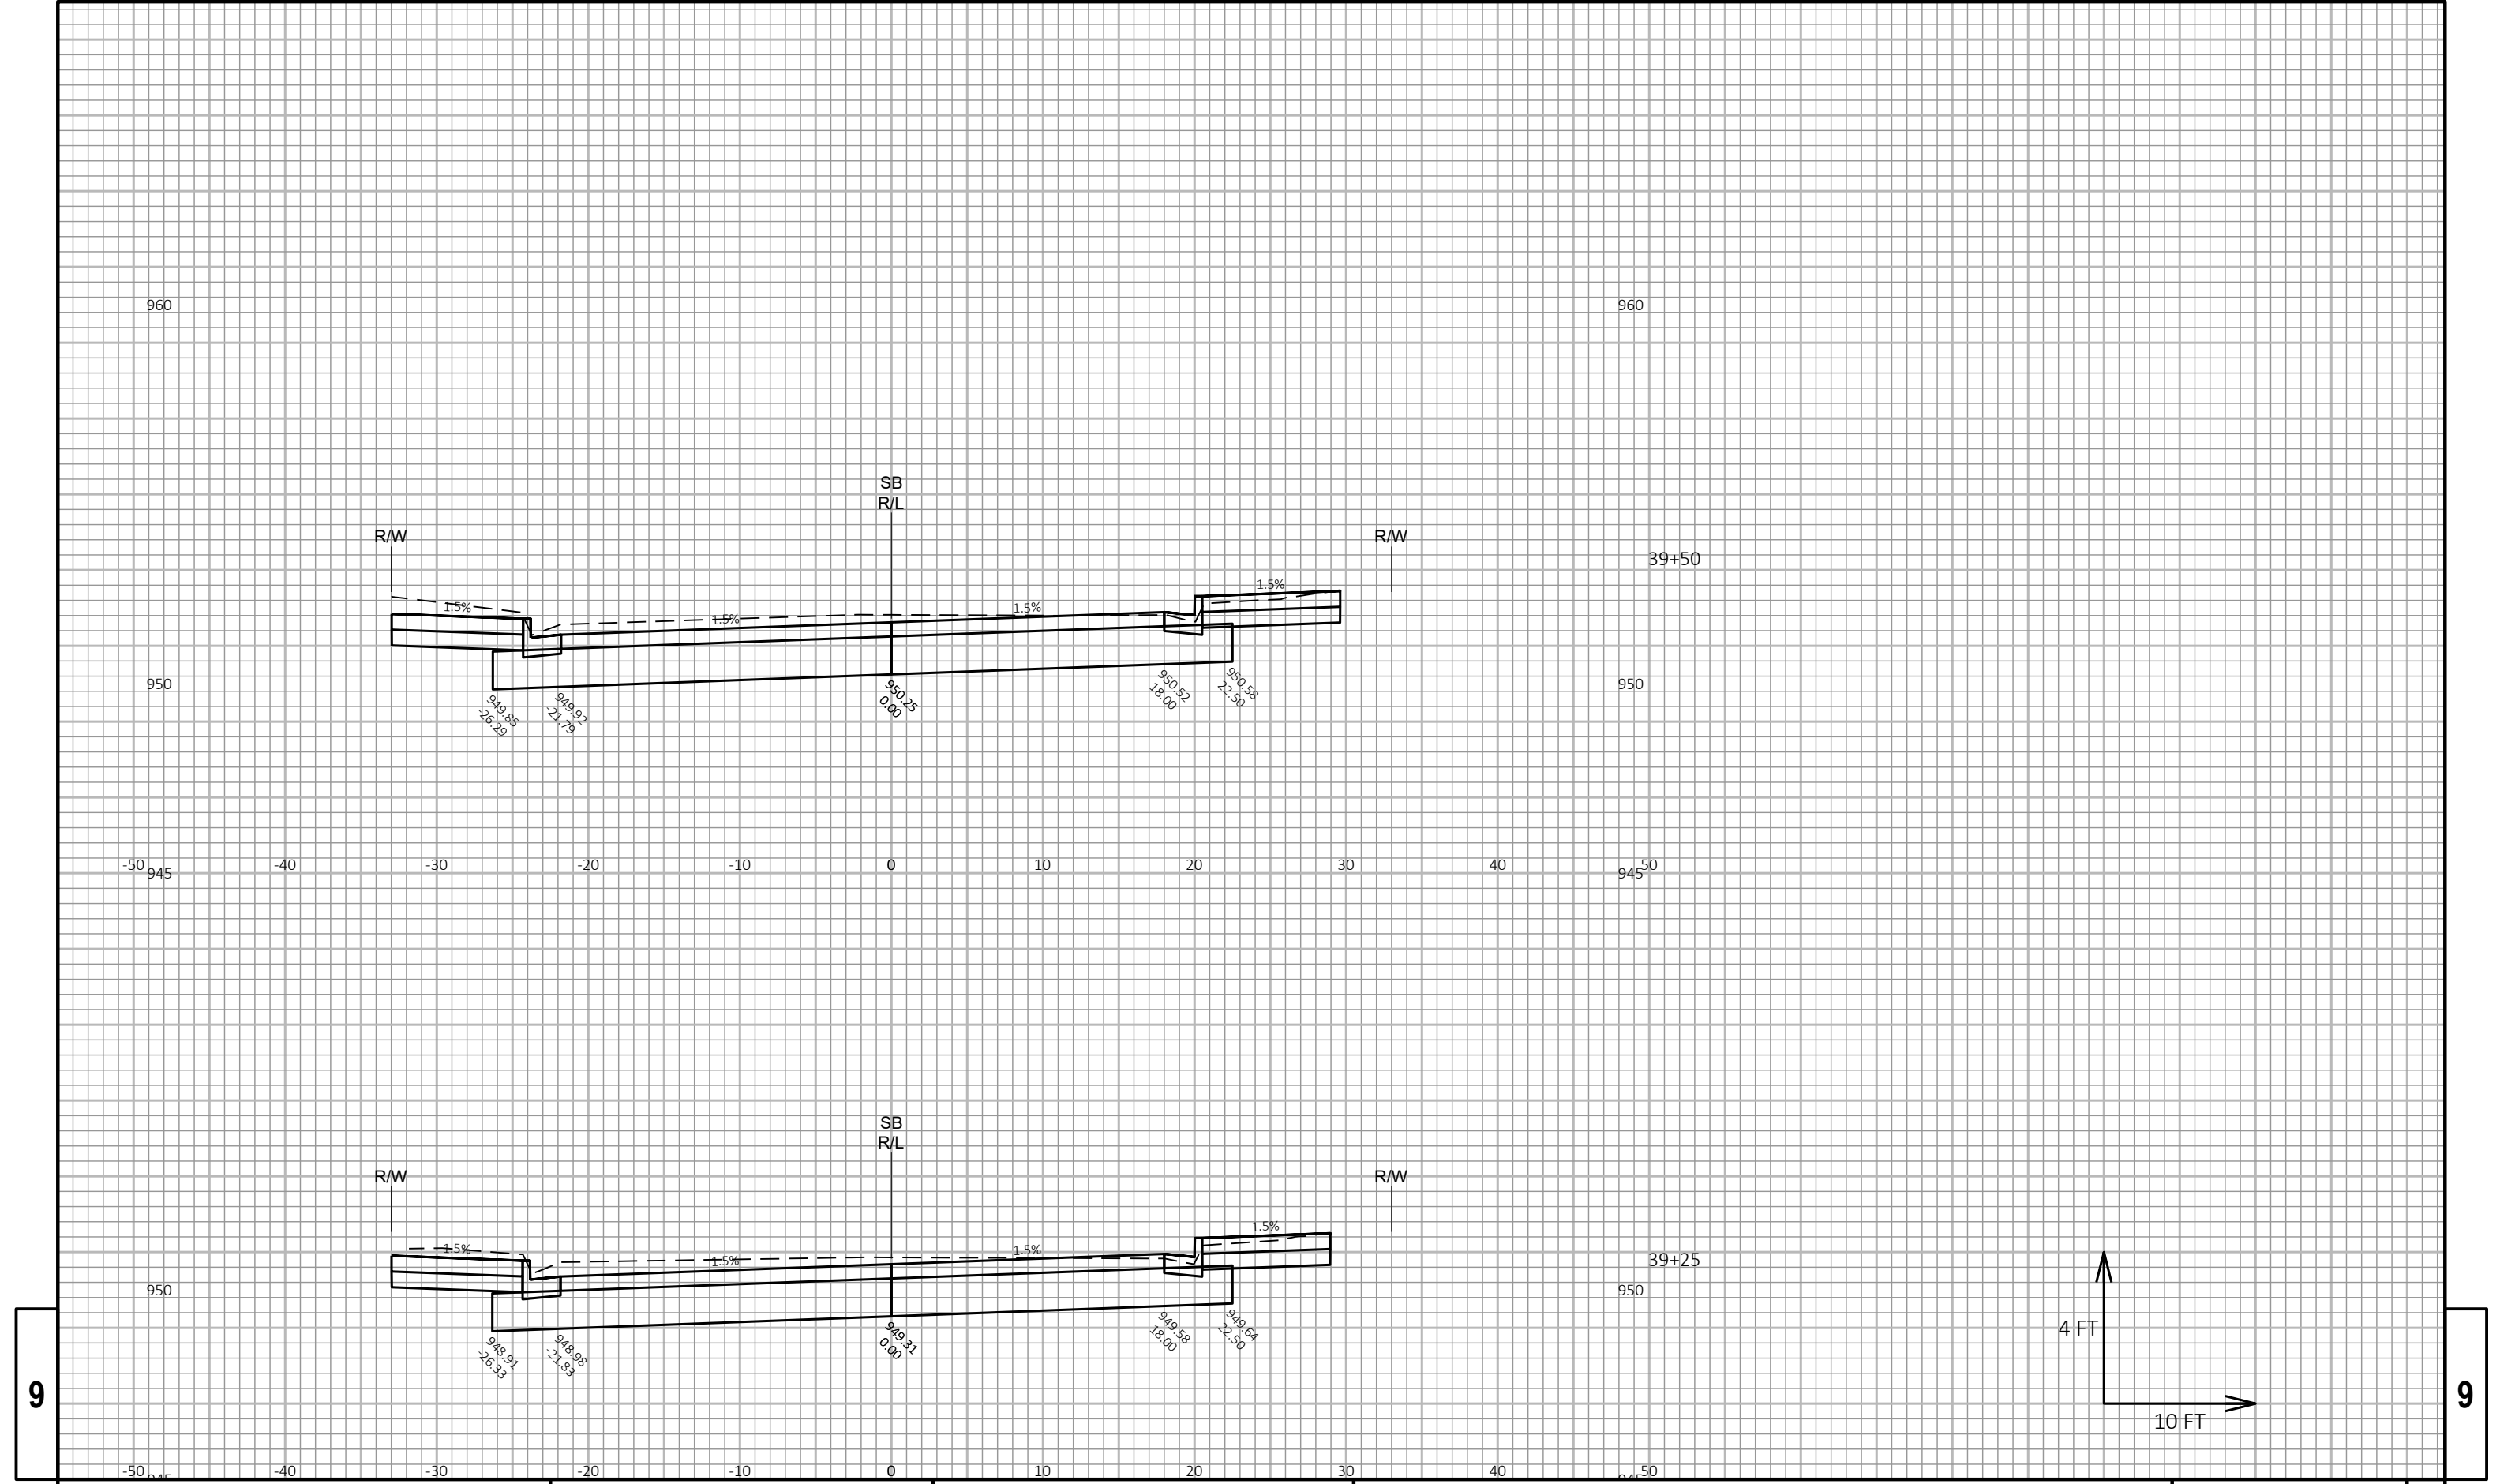





9



9

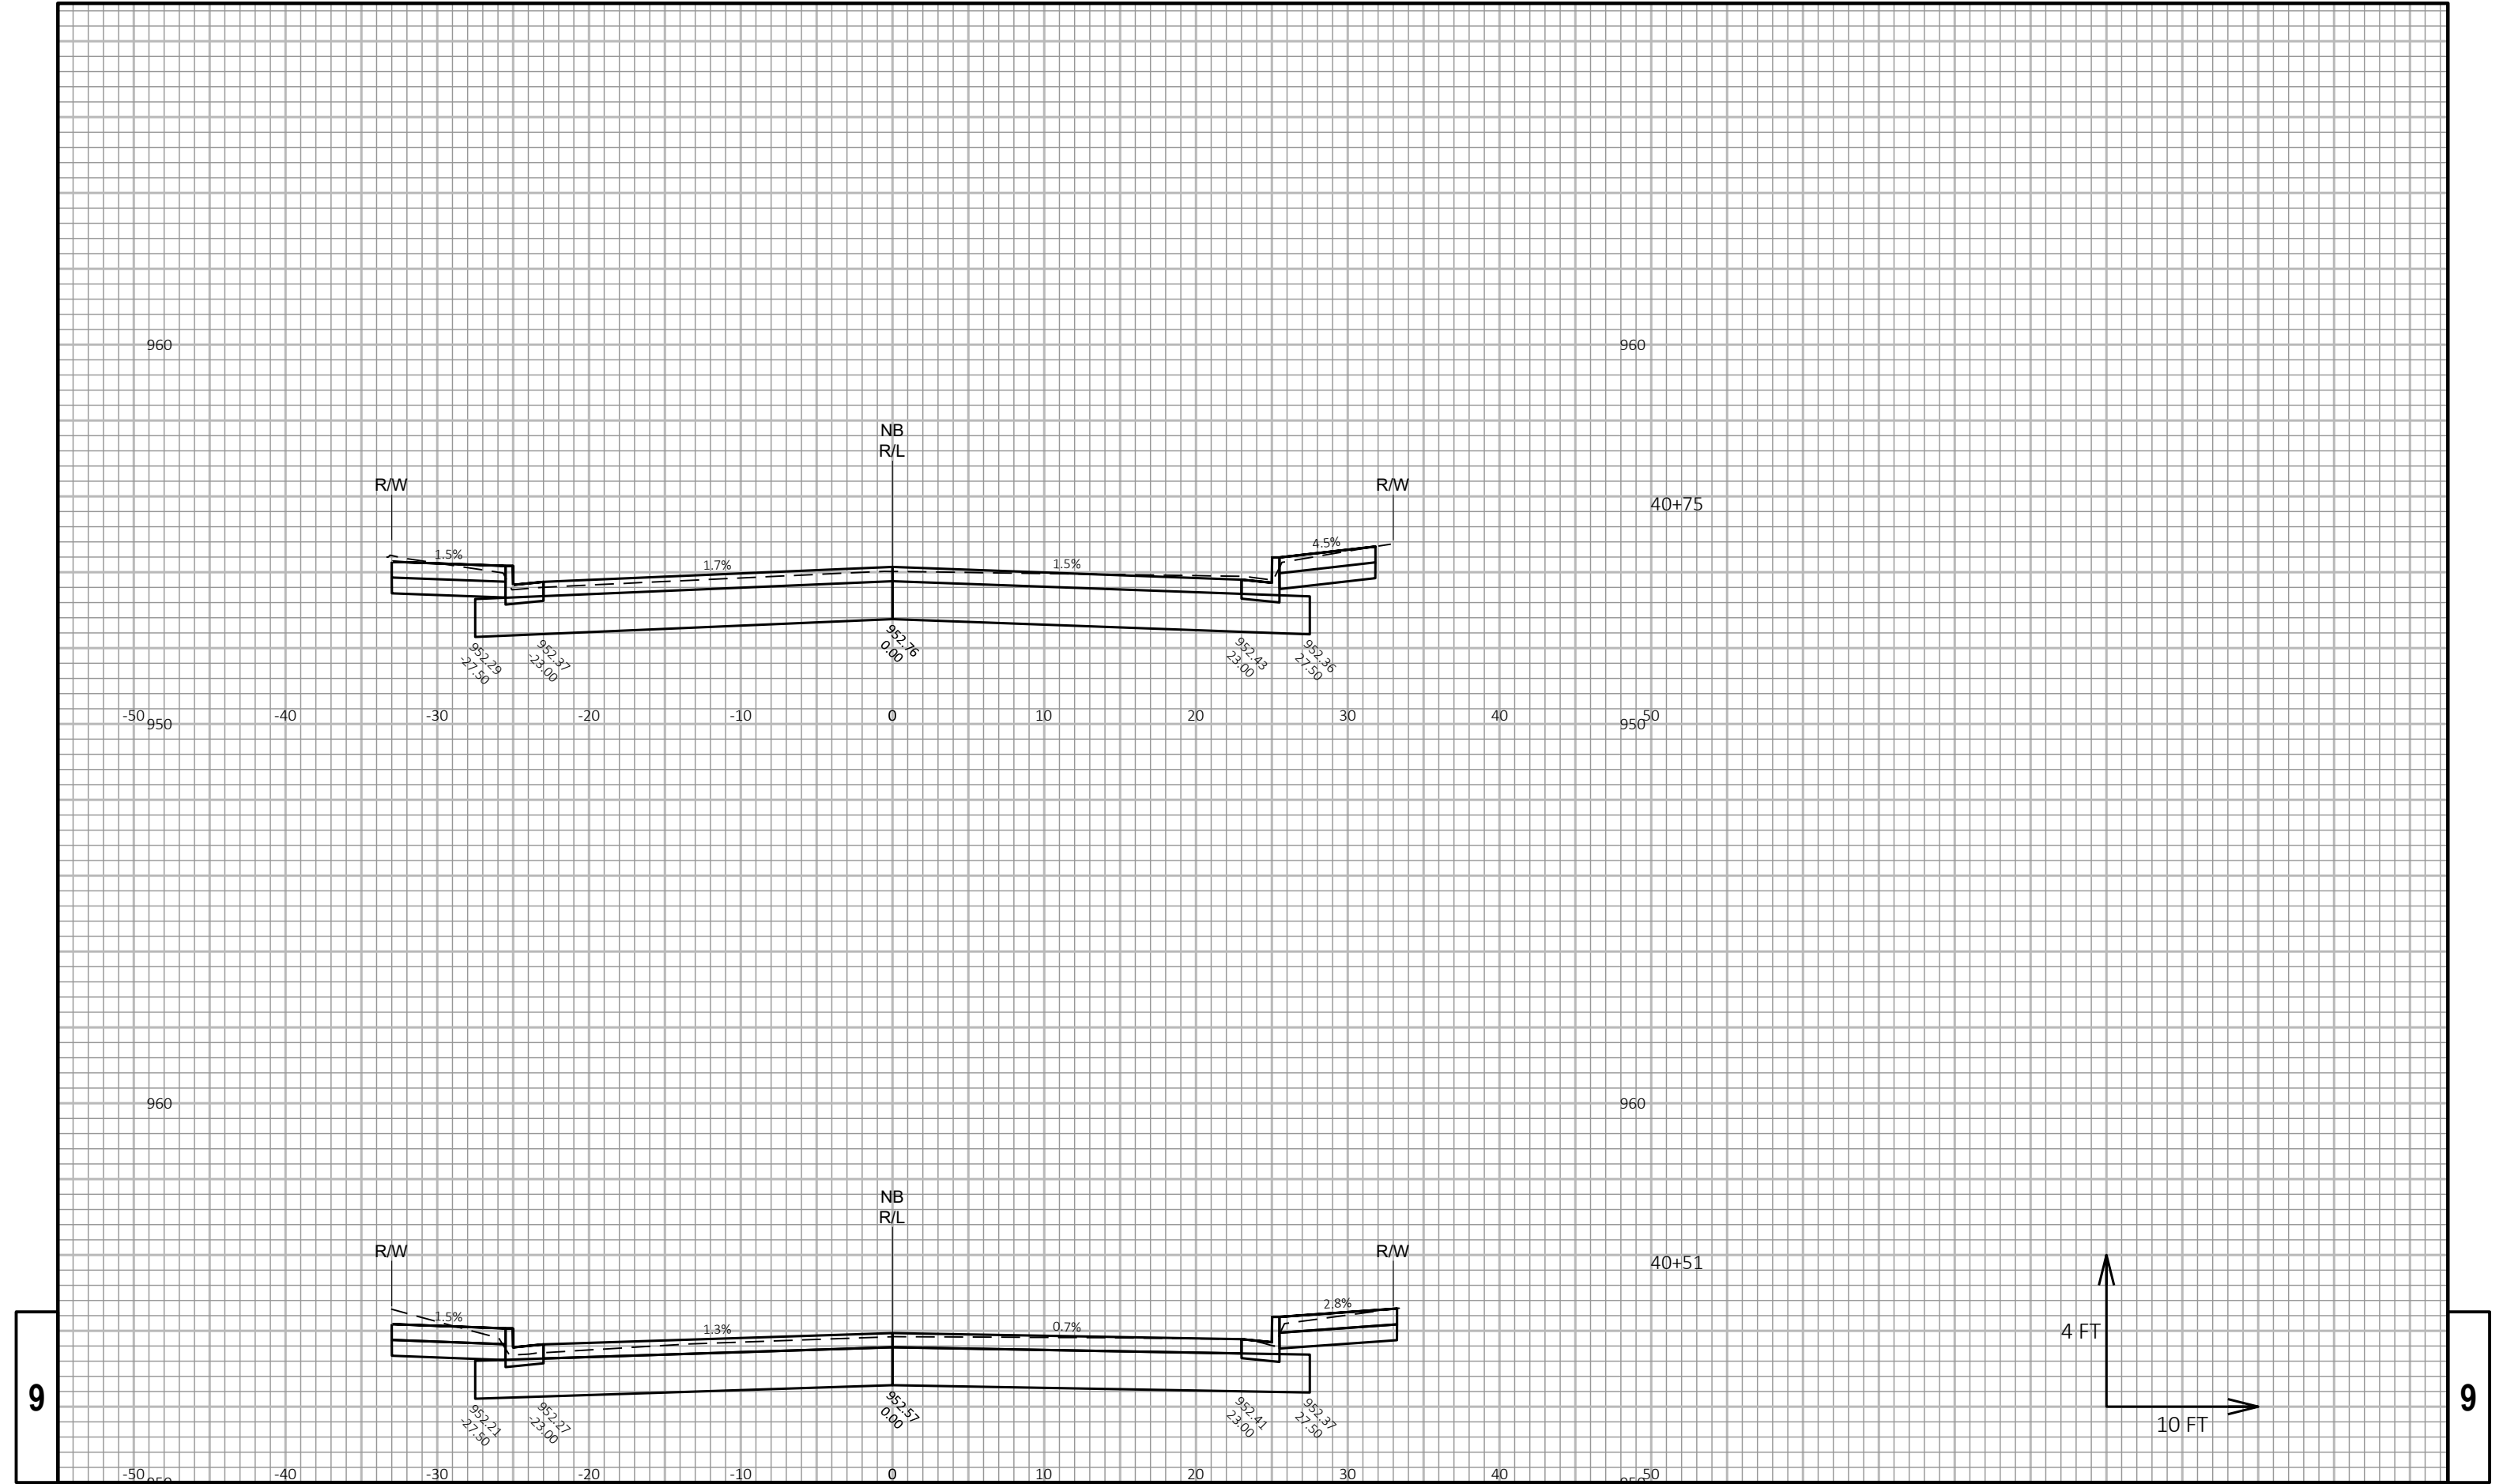

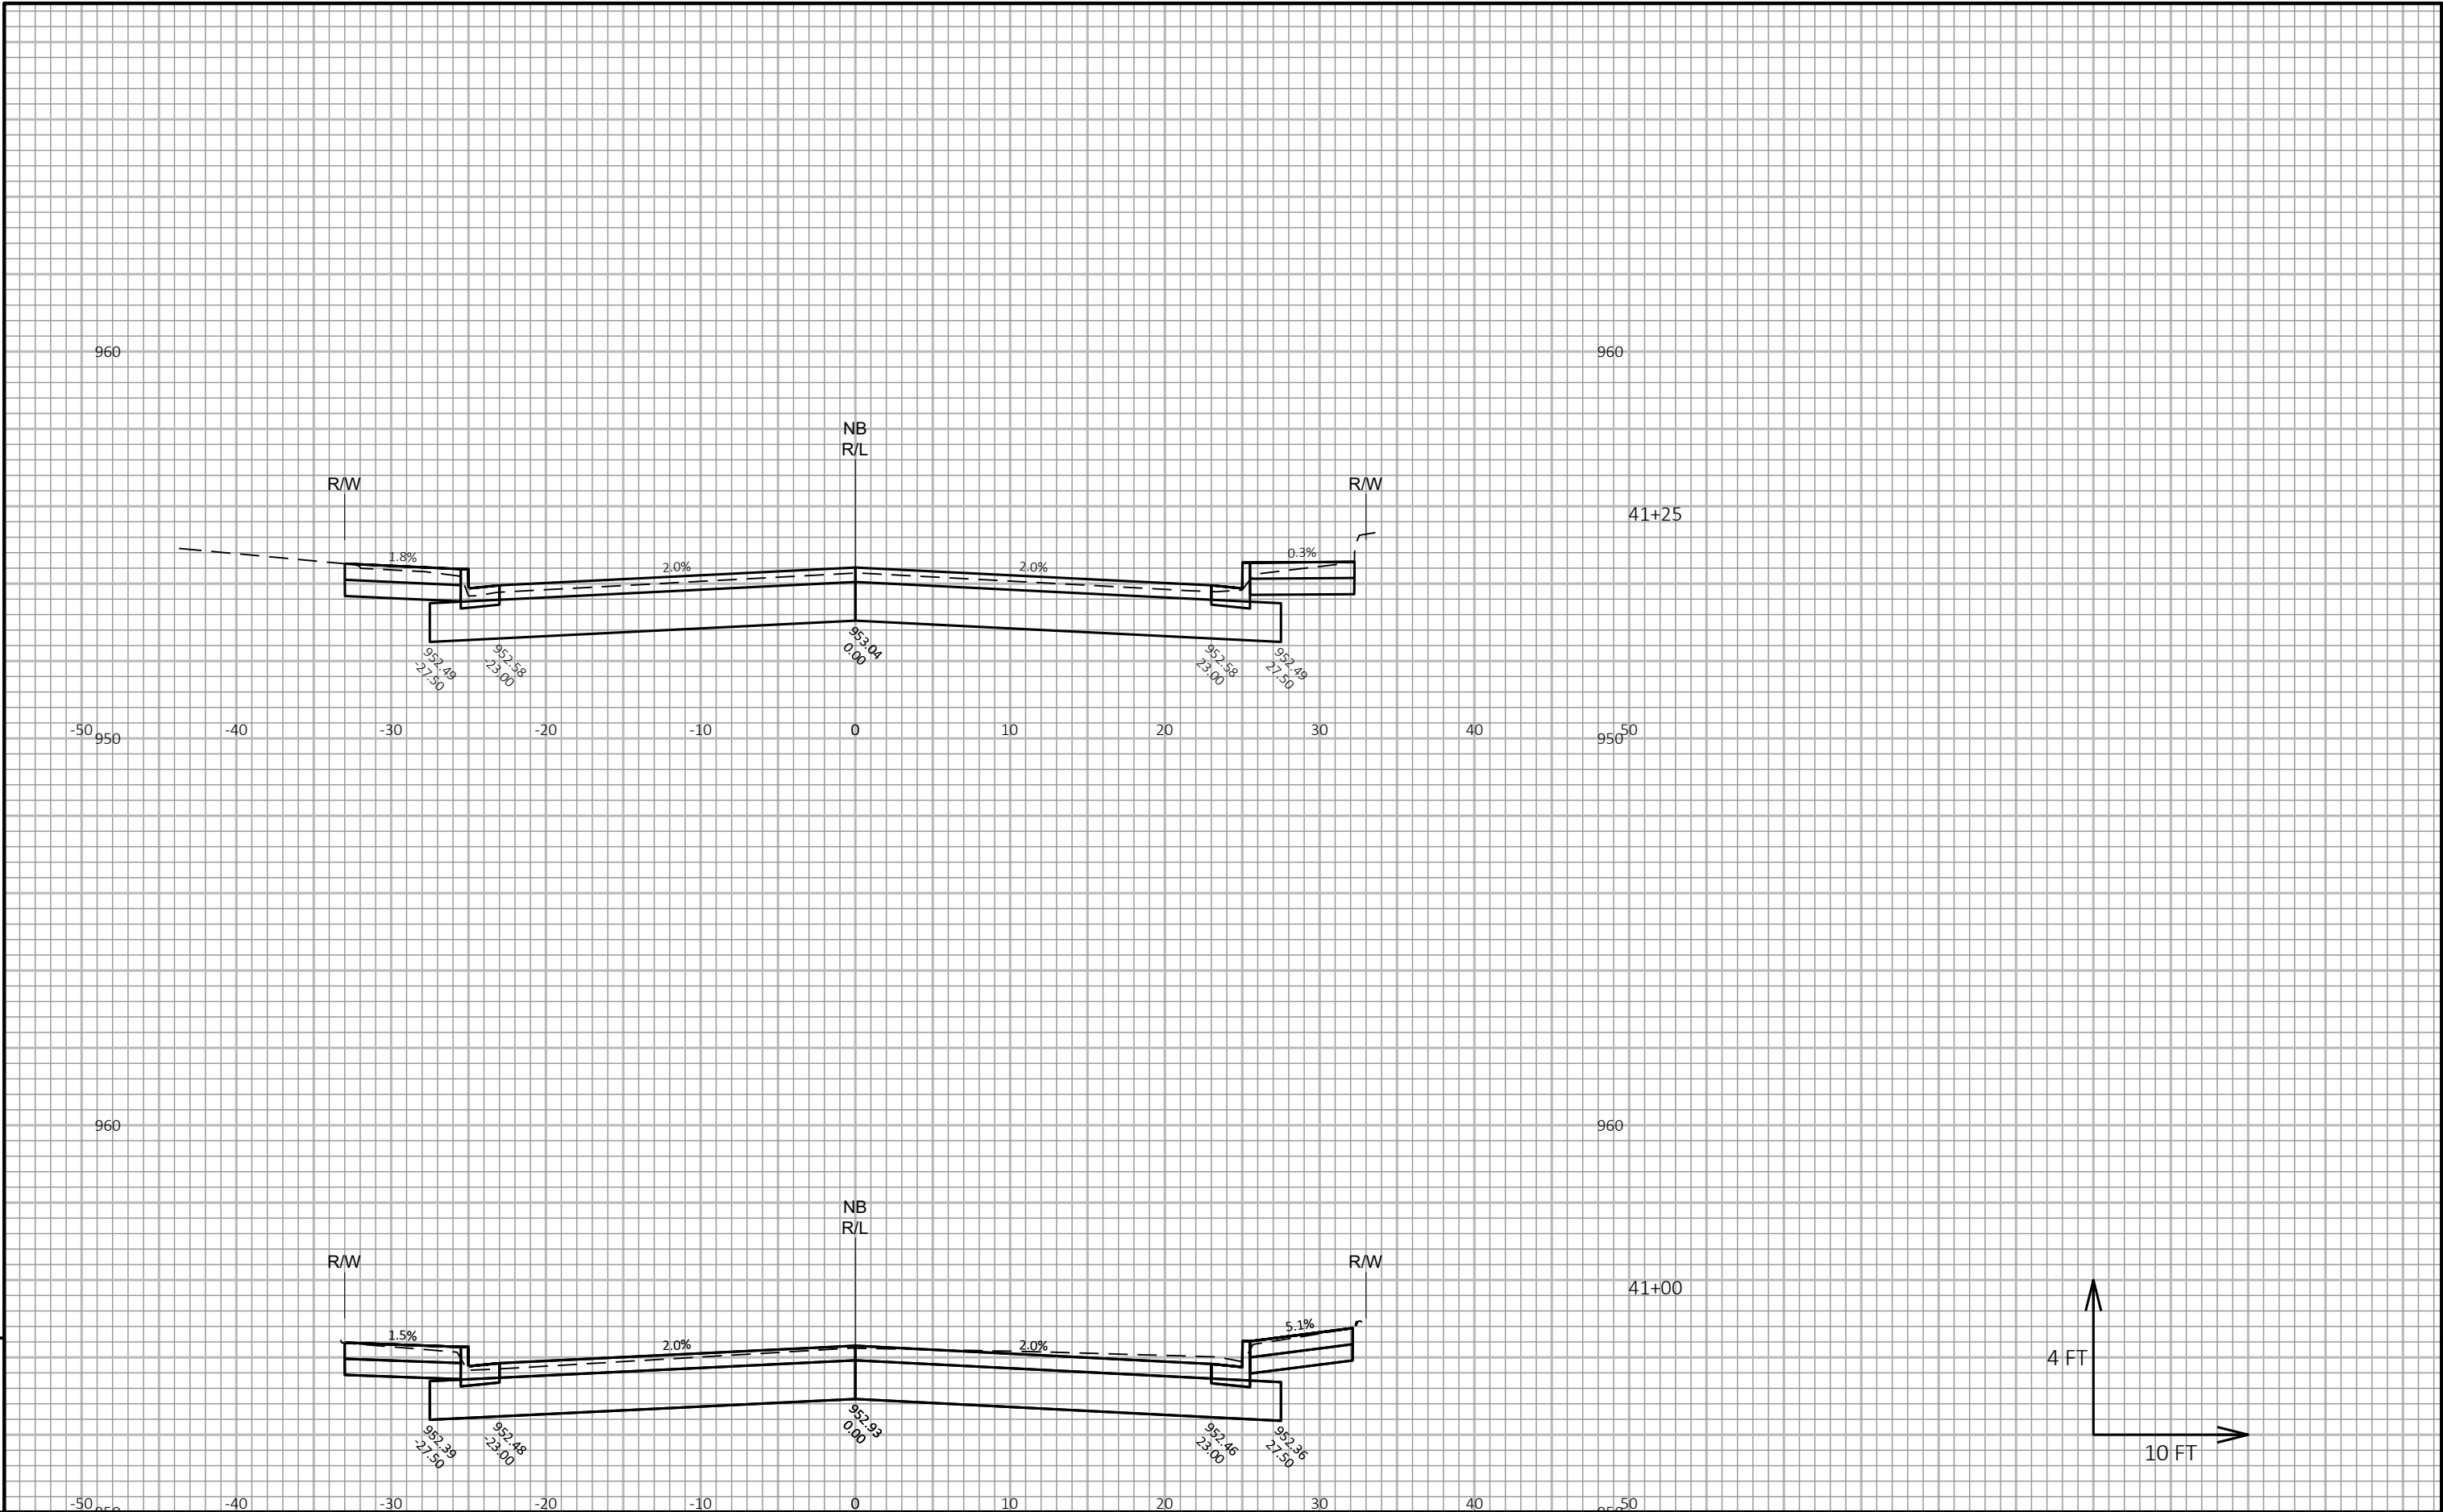

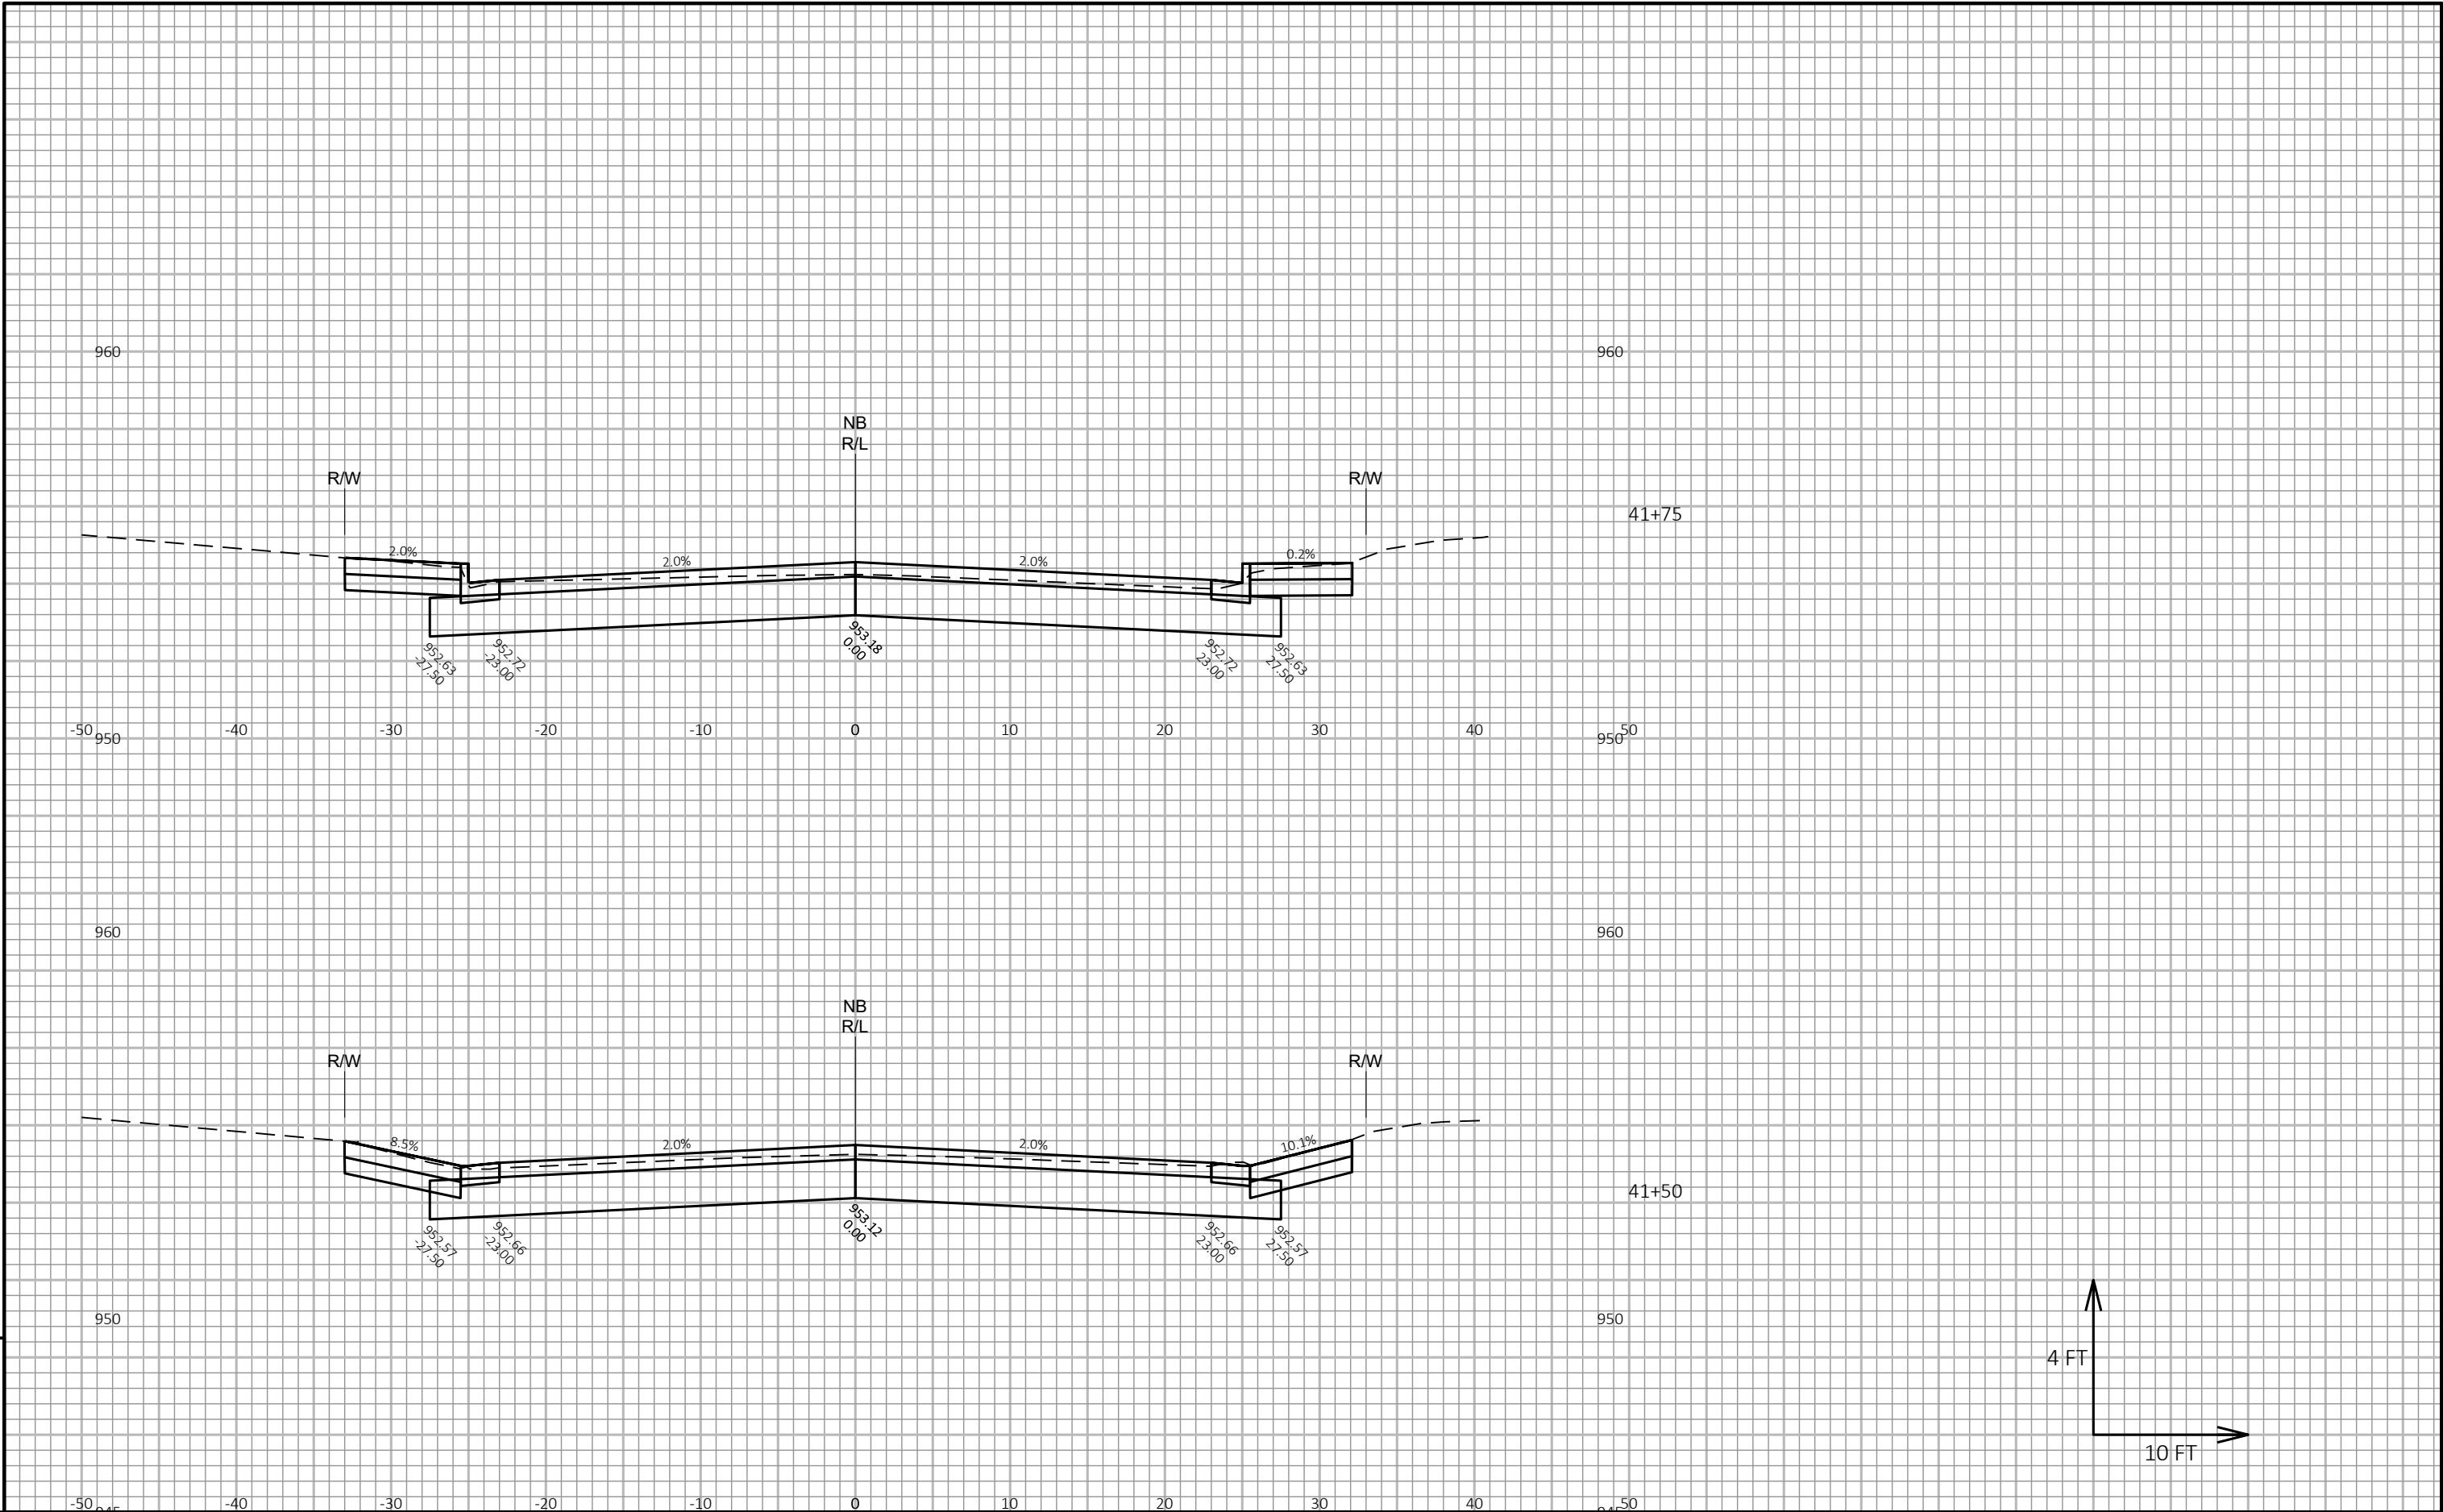

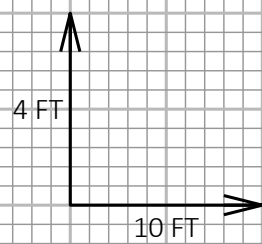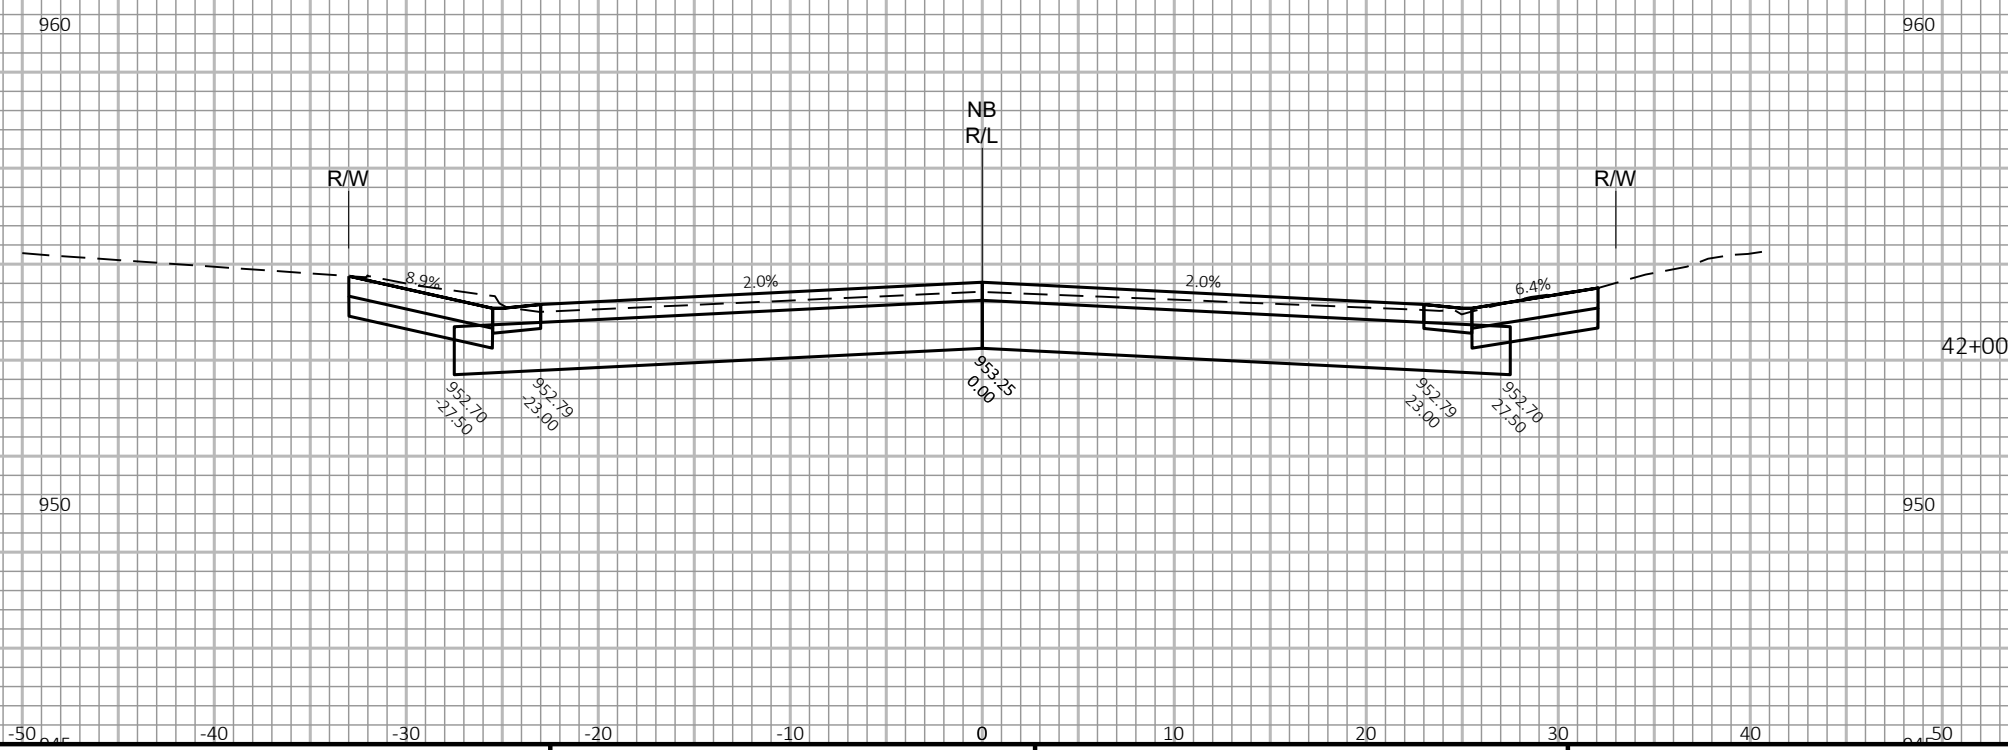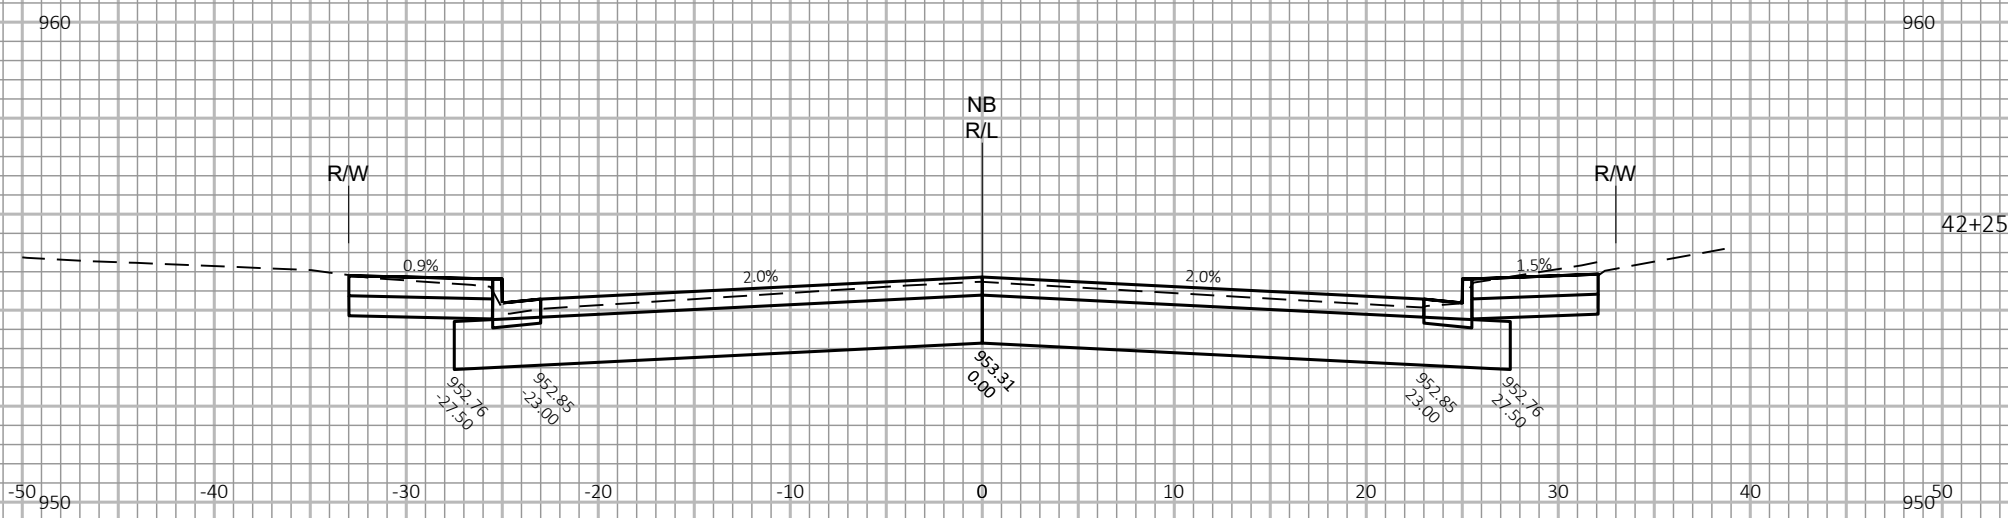

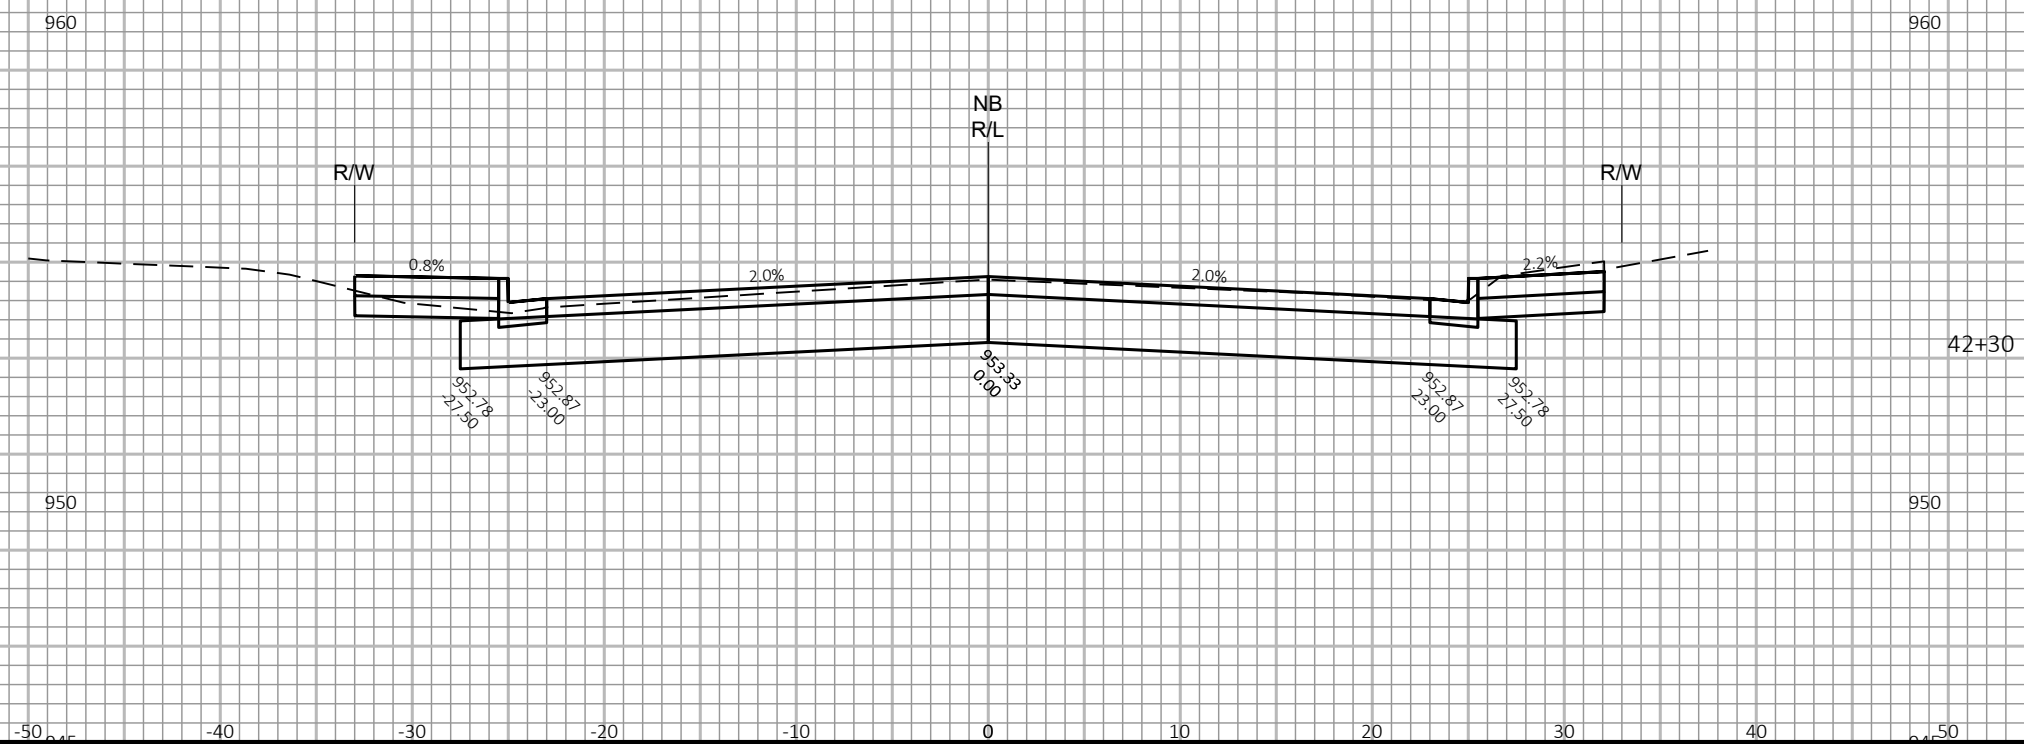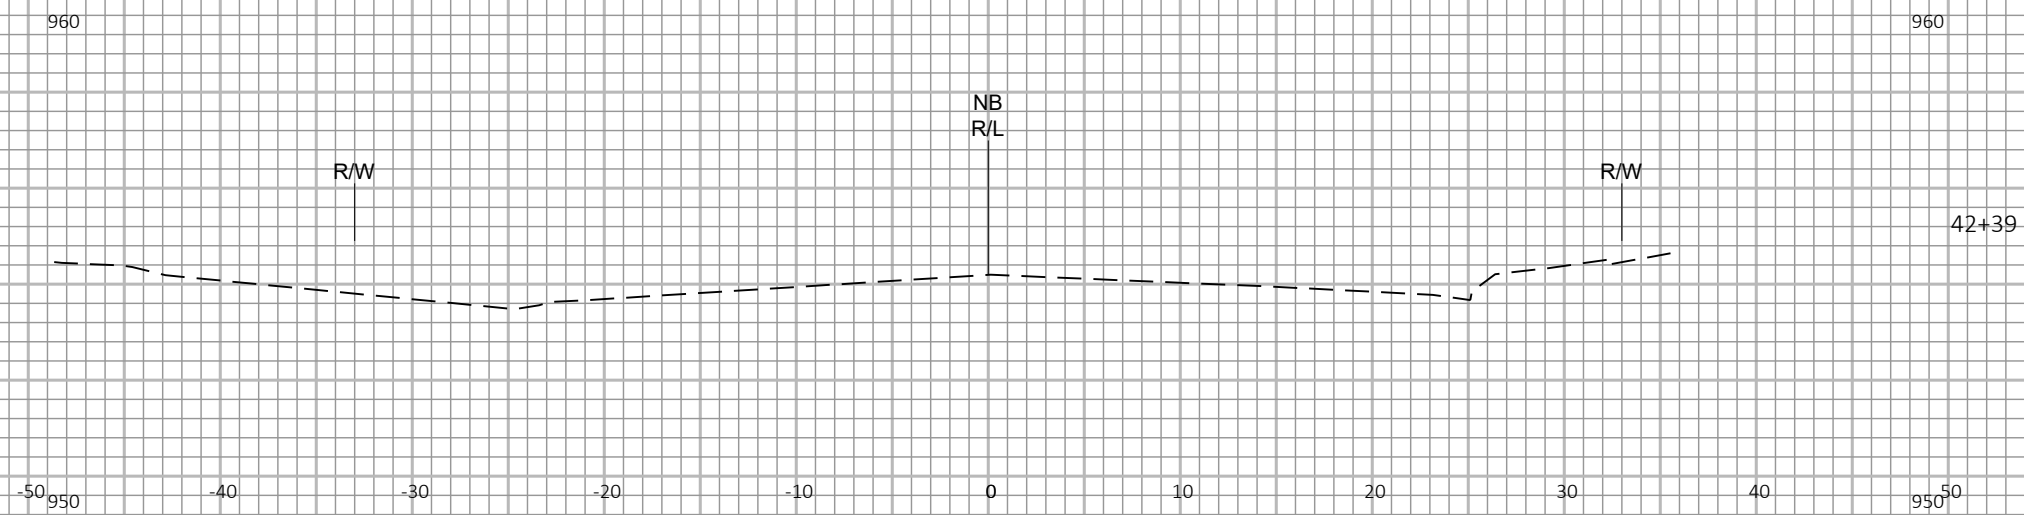

9

9

PROJECT NO:	3050-05-70
-------------	------------

HWY: STH 19

COUNTY: DANE

CROSS SECTIONS: NORTH BRISTOL STREET 'NB'

SHEET	Page 102 of 102
-------	-----------------

E

FILE NAME : N:\PDS\C3D\30500500\SHEETSPLAN\090201_XS.DWG
LAYOUT NAME - 090201_xs18

PLOT DATE : 8/23/2018 8:47 AM

PLOT BY : PORTER, STEVEN J

PLOT NAME :

PLOT SCALE : 1 IN:10 FT HORZ. / 1 IN:4 FT VERT.

WISDOT/CADDS SHEET 49